


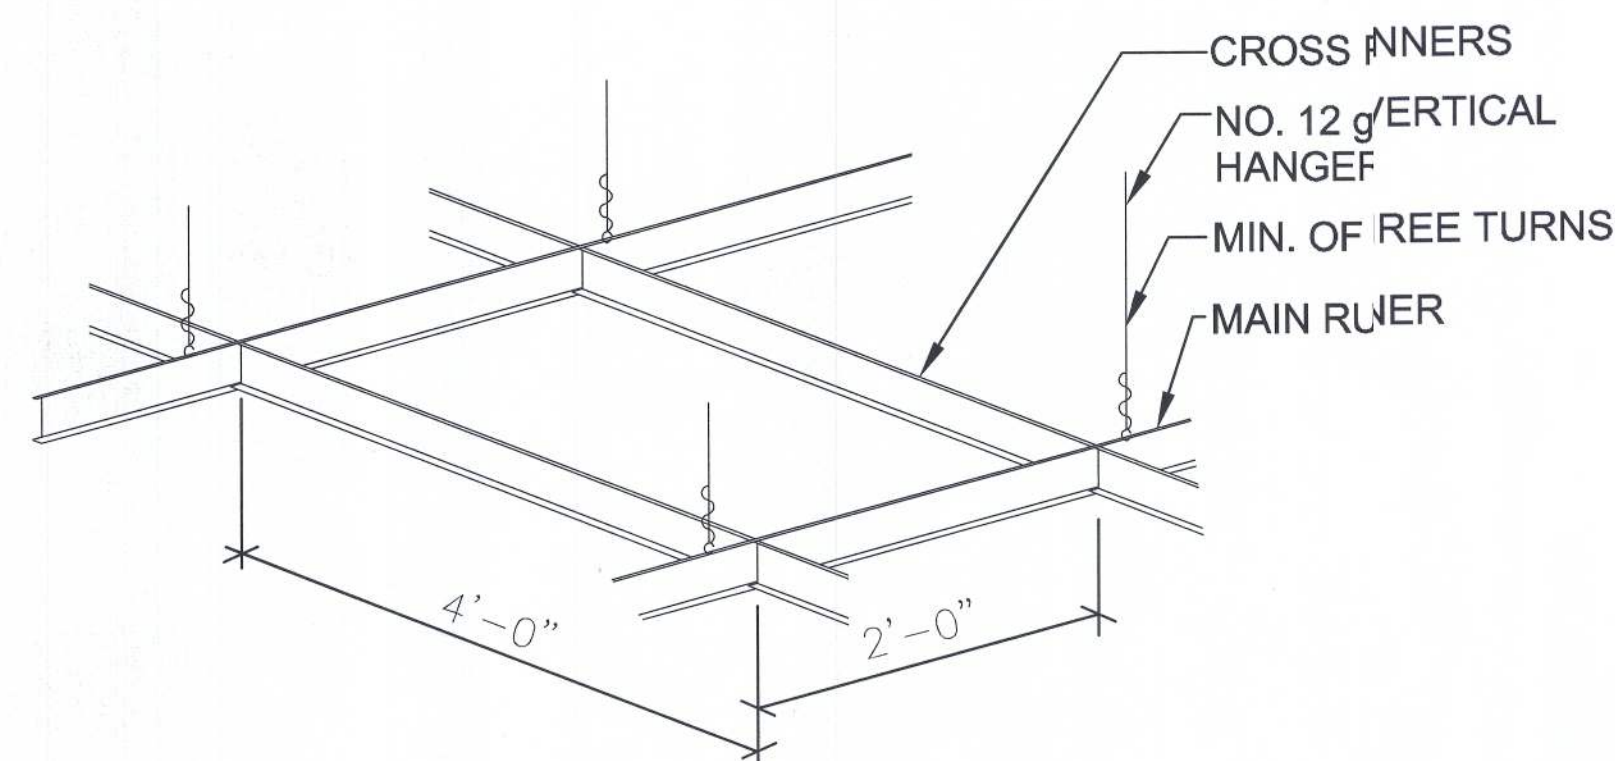

2 SUSPENDED GRID DETAIL
A9.C N.T.S. ADJUST PER LOCAL CODE

DISTANCE BETWEEN PERIMETER ROW OF LIGHTS TO BE NO MORE THAN 2'-0" AT ANY POINT FROM AN ADJACENT LIGHT FIXTURE.

DISTANCE BETWEEN PARALLEL ROWS OF LIGHTS TO BE NO MORE THAN 8'-0"

PERIMETER ROWS OF LIGHTS TO BE 4'-0" FROM THE ADJACENT SIDE WALLS.

RECEIVING AREA LIGHTS TO BE SPACED EVENLY BETWEEN FRONT AND REAR WALL OF THE RECEIVING AREA.

OPEN TO STRUCTURE ABOVE

ACT CEILING @ 8'-0" A.F.F.


ACT CEILING @ 8'-0" A.F.F.

1 REFLECTED CEILING PLAN
A9.C N.T.S.

ACT CEILING @ 10'-0" A.F.F.


PERIMETER ROWS OF LIGHTS TO BE 4'-0" FROM THE ADJACENT SIDE WALLS.

REFLECTED CEILING PLAN

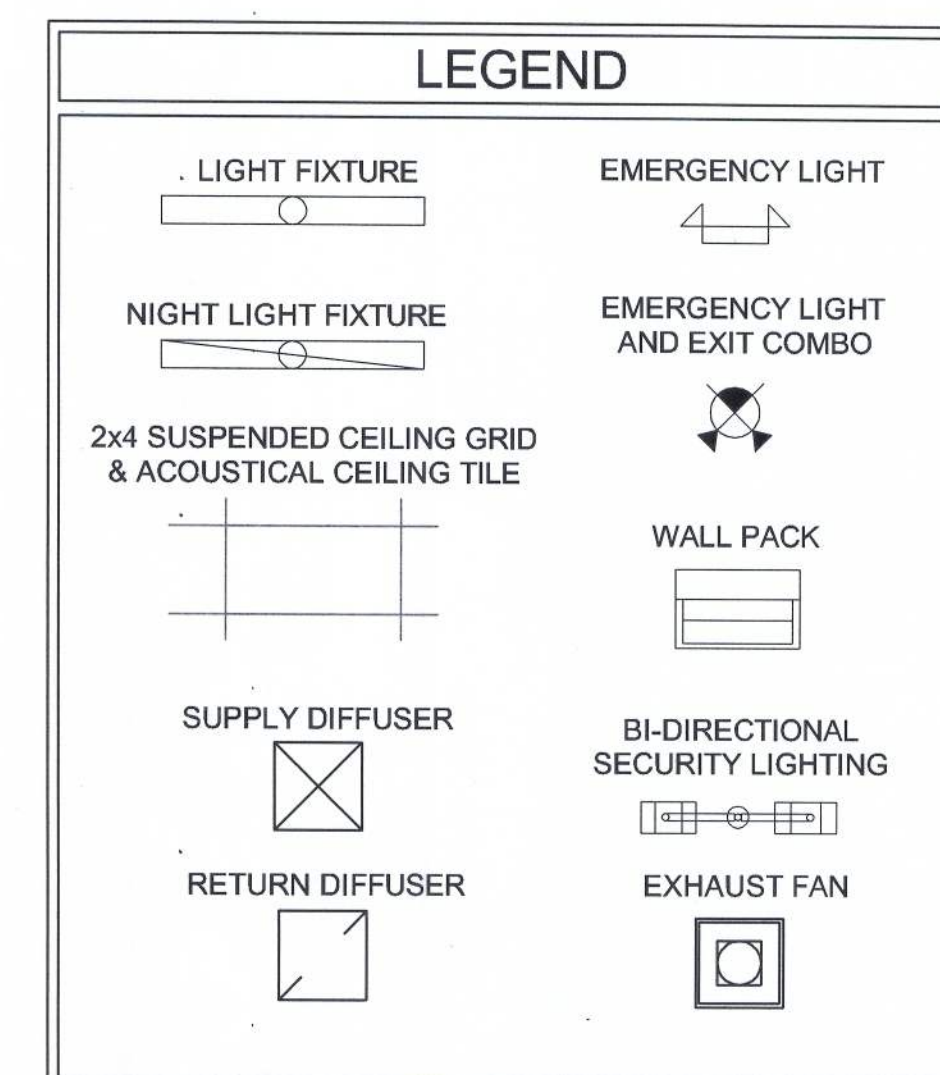

NICHOLAS GEISLER ARCHITECT
N.C.A.R.B. Certified
1758 NW Brown Road
Lake City, FL 32055
PHONE: 386-755-9021

CASCO
10877 WATSON ROAD
LAKE CITY, FL 32057
PHONE: 386-88-1100

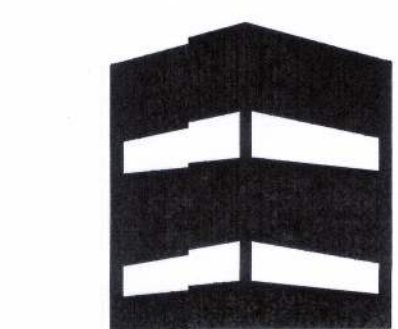

CONCEPT CONSTRUCTION

License# CGC1515491
ph: 386-75-8887
fx: 386-75-1919

295 NW Commons Loop
Suite 115323
Lake City, FL 32055
www.conceptconstruction.net

DOLLAR GENERAL

LAKE CITY, FLORIDA
COUNTY RD 247, LAKE CITY, FL

STORE # 12851
2010 PROTOTYPE - PLAN "C" 9,100

DATE 30 MAR 2010
Design JFB 06/10/10
Revisions JFB 10/20/10

SHEET NUMBER

A9.C