
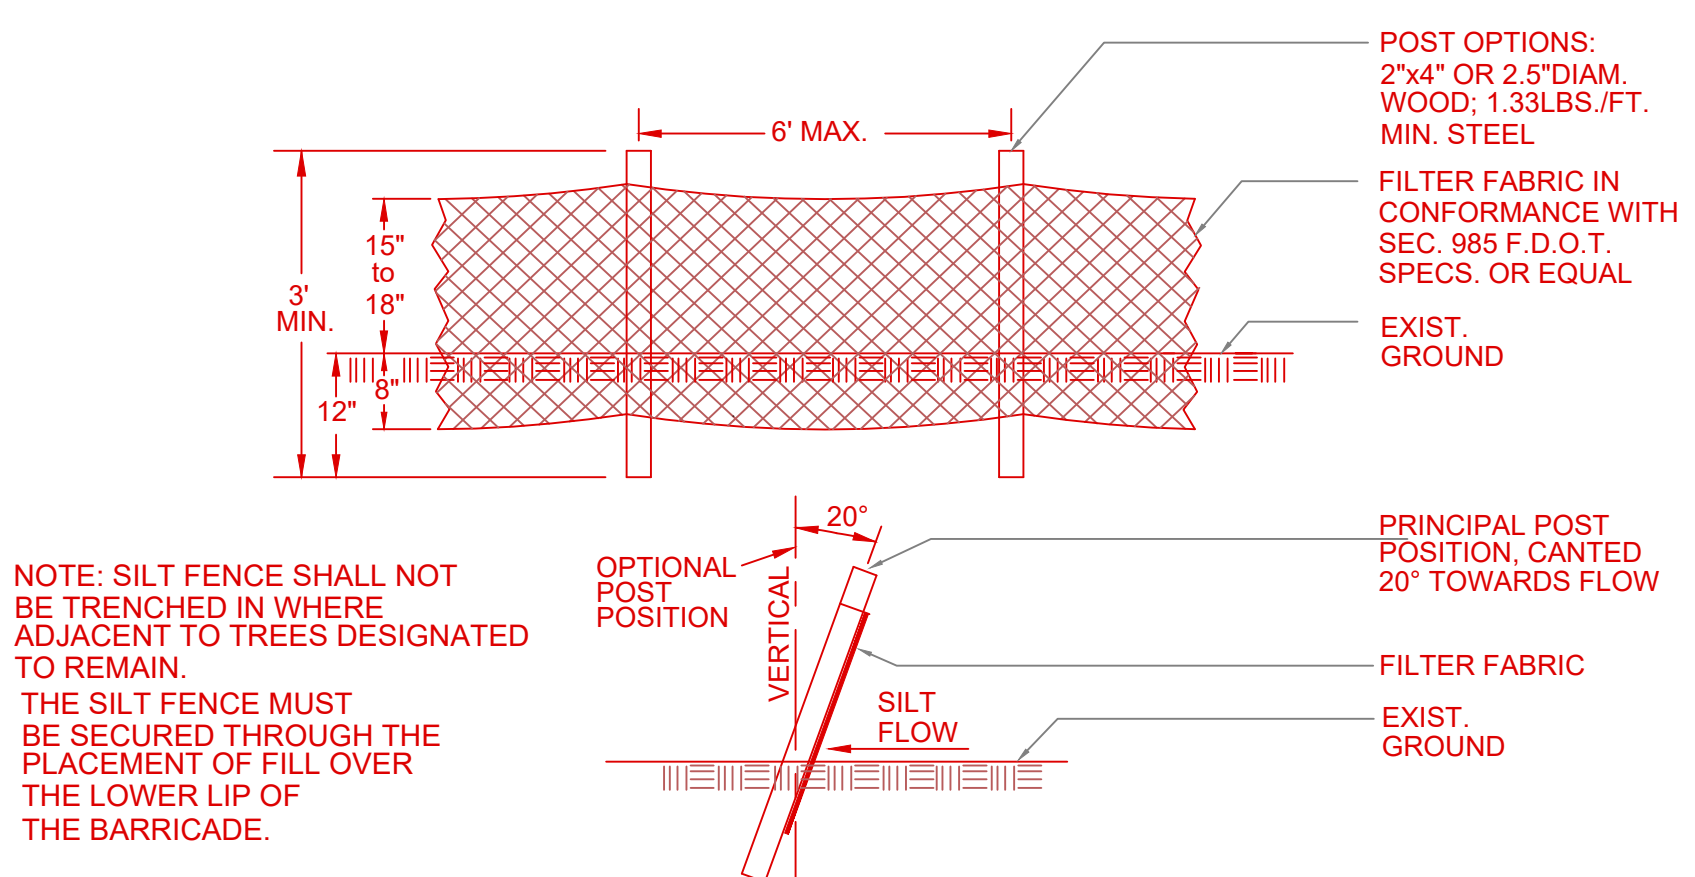


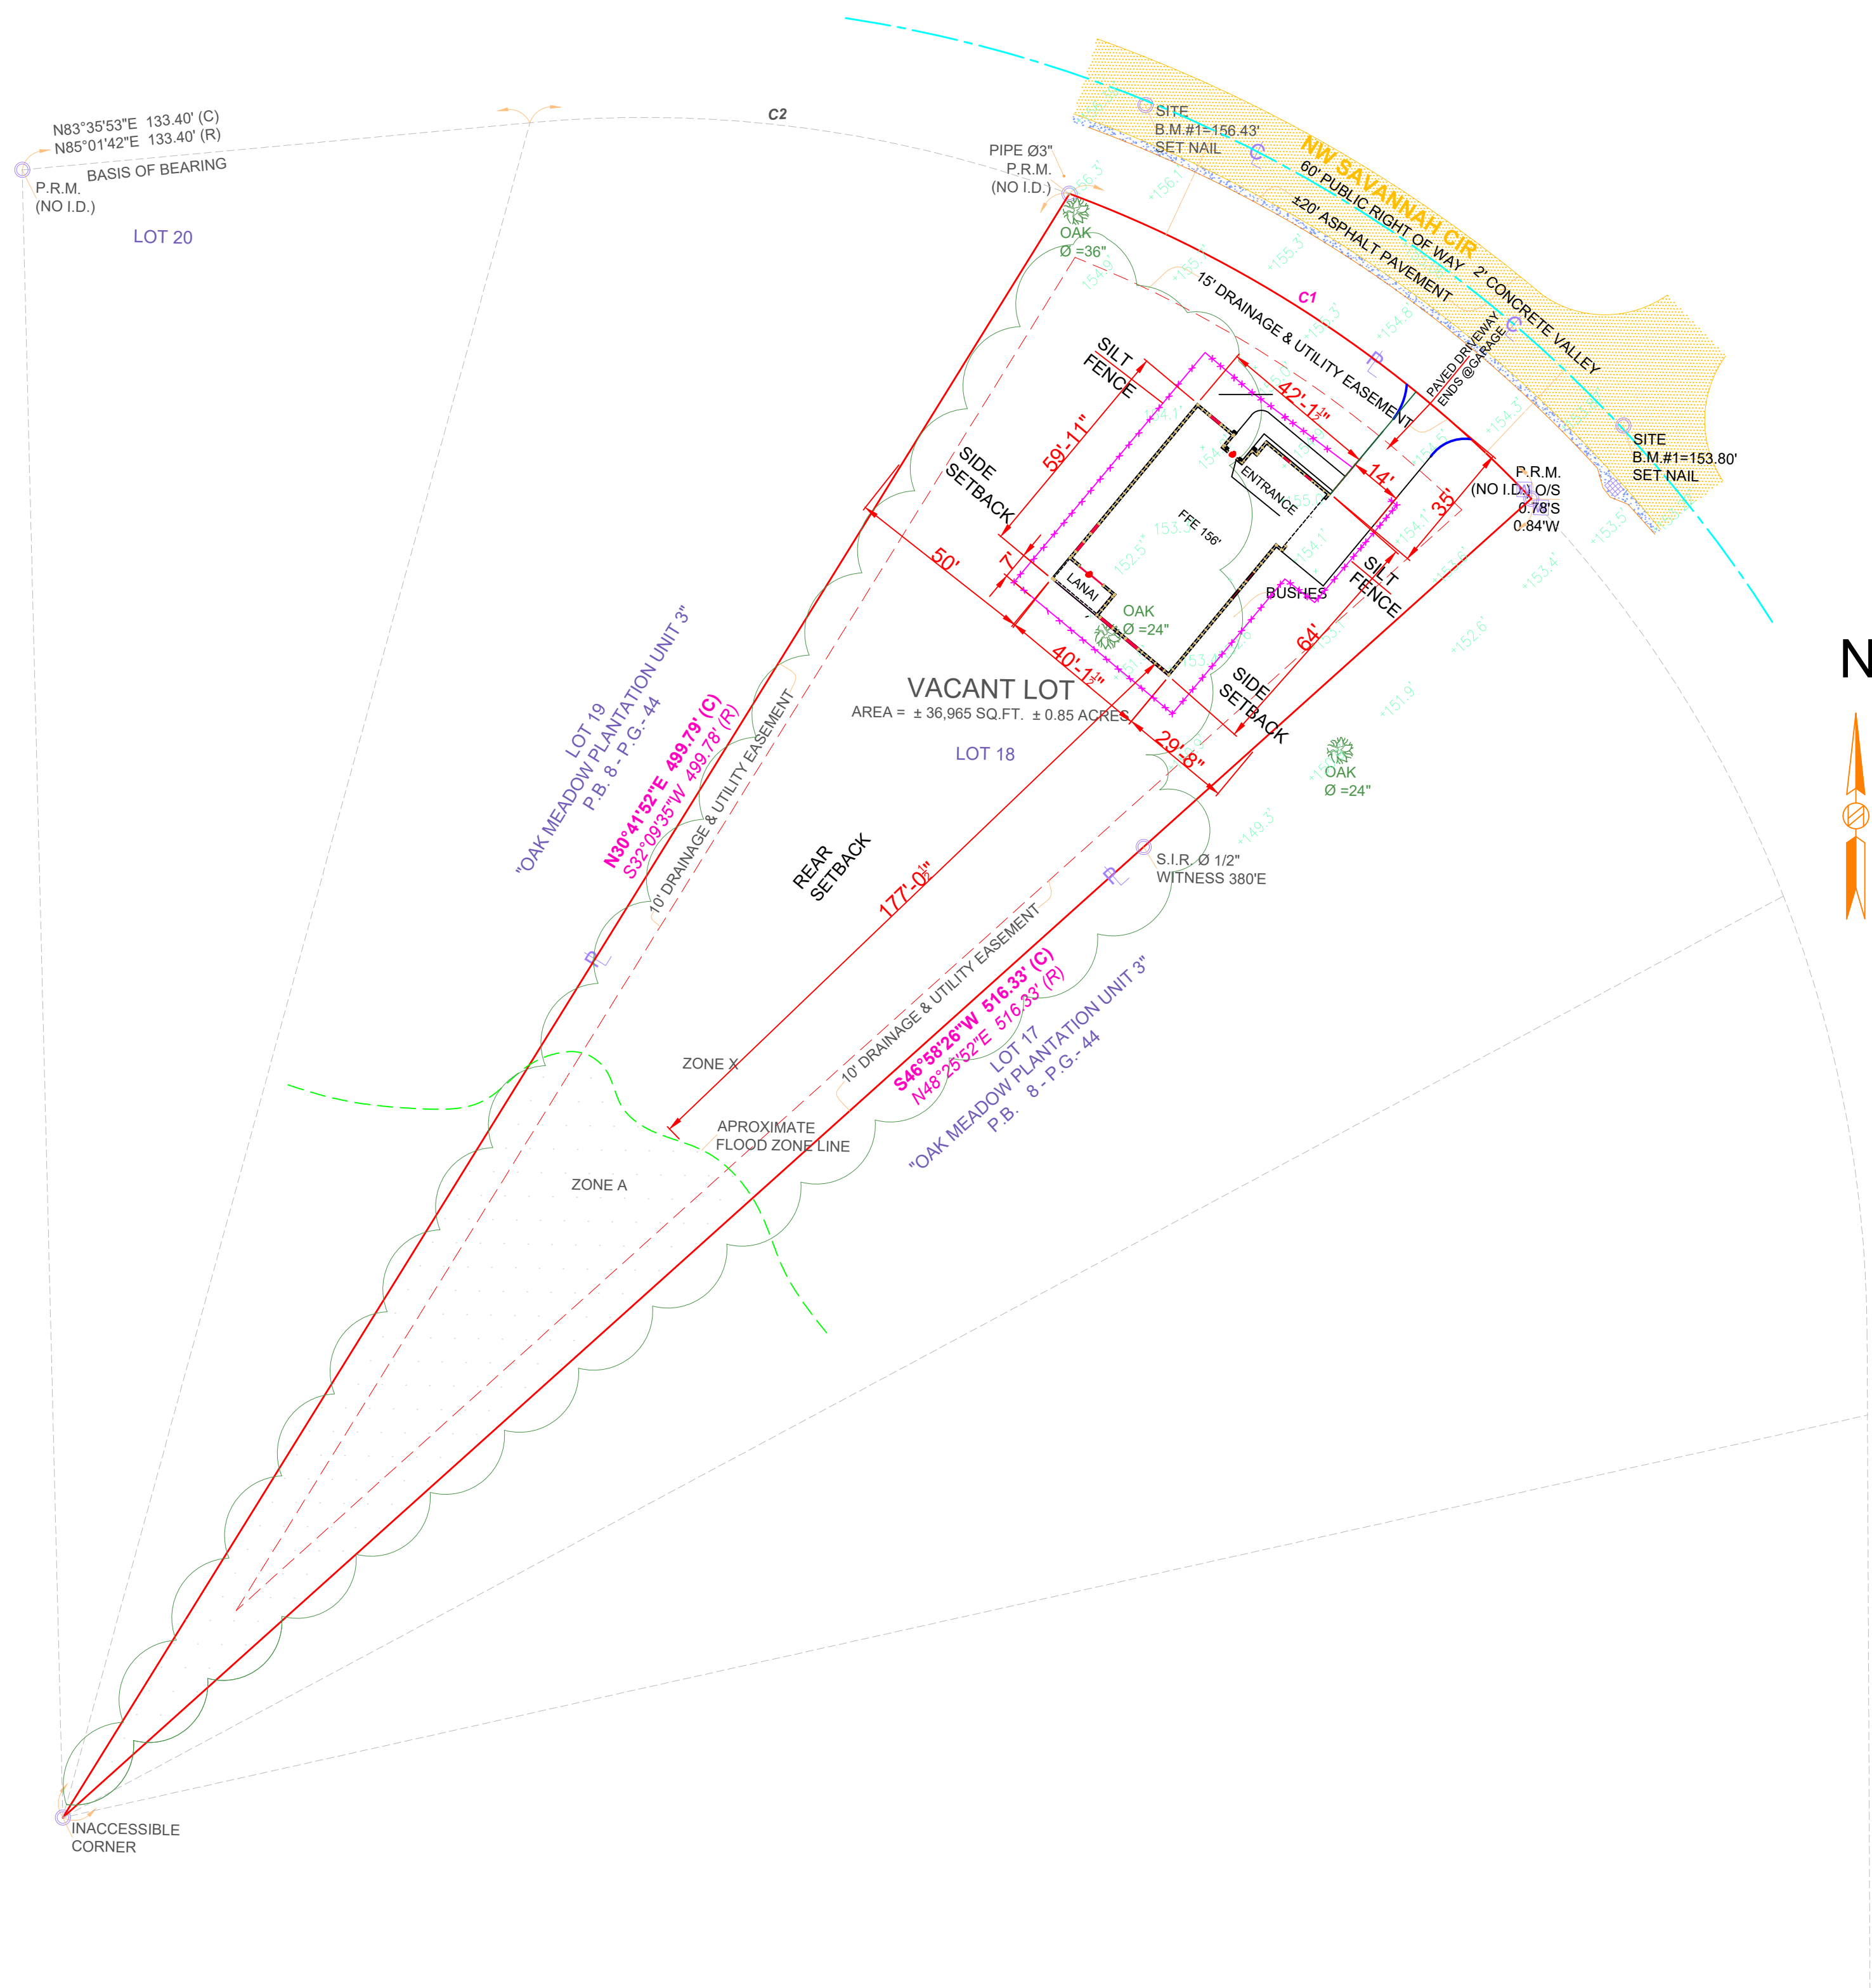

SILT BARRIER DETAIL

LEGEND

○ DENOTES 5/8" IRON ROD & CAP SET (LB7683)

● DENOTES IRON PIPE OR REBAR FOUND (5/8")

□ DENOTES 4"x4" CONCRETE MONUMENT SET (LB7683)

■ DENOTES 4"x4" CONCRETE MONUMENT FOUND

⊙ DENOTES NAIL & DISC FOUND

NO ID - NO IDENTIFICATION

FND - FOUND

CM - CONCRETE MONUMENT

± - MORE OR LESS

ORB - OFFICIAL RECORDS BOOK

PG - PAGE (S)

(P) - PLAT

(D) - DEED

(C) - CALCULATED

(M) - MEASURED

AC. - ACRE(S)

POB - POINT OF BEGINNING

POC - POINT OF COMMENCEMENT

EOP - EDGE OF PAVEMENT

EOG - EDGE OF GRADE

N - NORTH

E - EAST

S - SOUTH

W - WEST

PC - POINT OF CURVATURE

PI - POINT OF INTERSECTION

PT - POINT OF TANGENCY

IP - IRON PIPE

IPC - IRON PIPE and CAP

IR - IRON ROD

IRC - IRON ROD and CAP

R - RADIUS

T - TANGENT

L - ARC LENGTH

Δ - CENTRAL ANGLE

CH - CHORD BEARING & DISTANCE

R/W - RIGHT OF WAY

TWP - TOWNSHIP

RNG - RANGE

X—X DENOTES FENCE

E—E DENOTES OVERHEAD ELECTRIC

○—○ POWER POLE

CONCRETE

— TELEPHONE PEDESTAL

× × × SILT FENCE

— FLOW ARROW

- Notes:
1. This item has been electronically signed & sealed by Ram A. Goel using a Digital signature & date.
 2. Printed copies of this document are not considered signed & sealed. This signature must be verified on any electronic copies.

Ram Goel

Digitally signed by Ram Goel
DN:
c=US, o=Soney FM LLC,
ou=ENGINEERING,
li=Tampa, st=Florida, cn=US
Date: 2022.11.25
13:44:42-0500

RAM A. GOEL
LICENSE
No. 47431
STATE OF
FLORIDA
PROFESSIONAL ENGINEER

THIS DRAWING IS AN INSTRUMENT OF SERVICE AND SHALL REMAIN THE PROPERTY OF THE ENGINEER, AND SHALL NOT BE REPRODUCED, PUBLISHED OR USED IN ANY WAY WITHOUT THE WRITTEN CONSENT OF THE ENGINEER. COPYRIGHT 2016. NOT PUBLISHED. THIS IS TO CERTIFY THAT I HAVE REVIEWED THIS PLAN AND FOUND TO BE IN COMPLIANCE WITH CHAPTER 16 OF 2020 7TH EDITION FLORIDA BUILDING CODE AND APPLICABLE SUPPLEMENTS.

RAM A.GOEL, P.E. # 47431

COPIES OF THESE PLANS ARE NOT VALID UNLESS EMBOSSED WITH THE SIGNING ENGINEER'S SEAL

SONEY FM
ENGINEERS

Professional, Efficient & Technological

RAM A. GOEL, P.E. # 47431
PH-813-792-1600

SONEY FM LLC
CORY LAKE PROFESSIONAL CENTER
10329 CROSS CREEK BLVD., SUITE P
TAMPA, FL 33647
www.soneyfmllc.com

Job # SG2205

Drawn By: KD


Checked By: S.G.

Issue Date: 11-25-22		
Revisions:		
No.	Date	Description
Δ	//	
Δ	//	
Δ	//	
Δ	//	

SITE PLAN

LINCOLN MODEL III
791 NW SAVANNAH CIR.,
LAKE CITY, FL 32055


SP-1

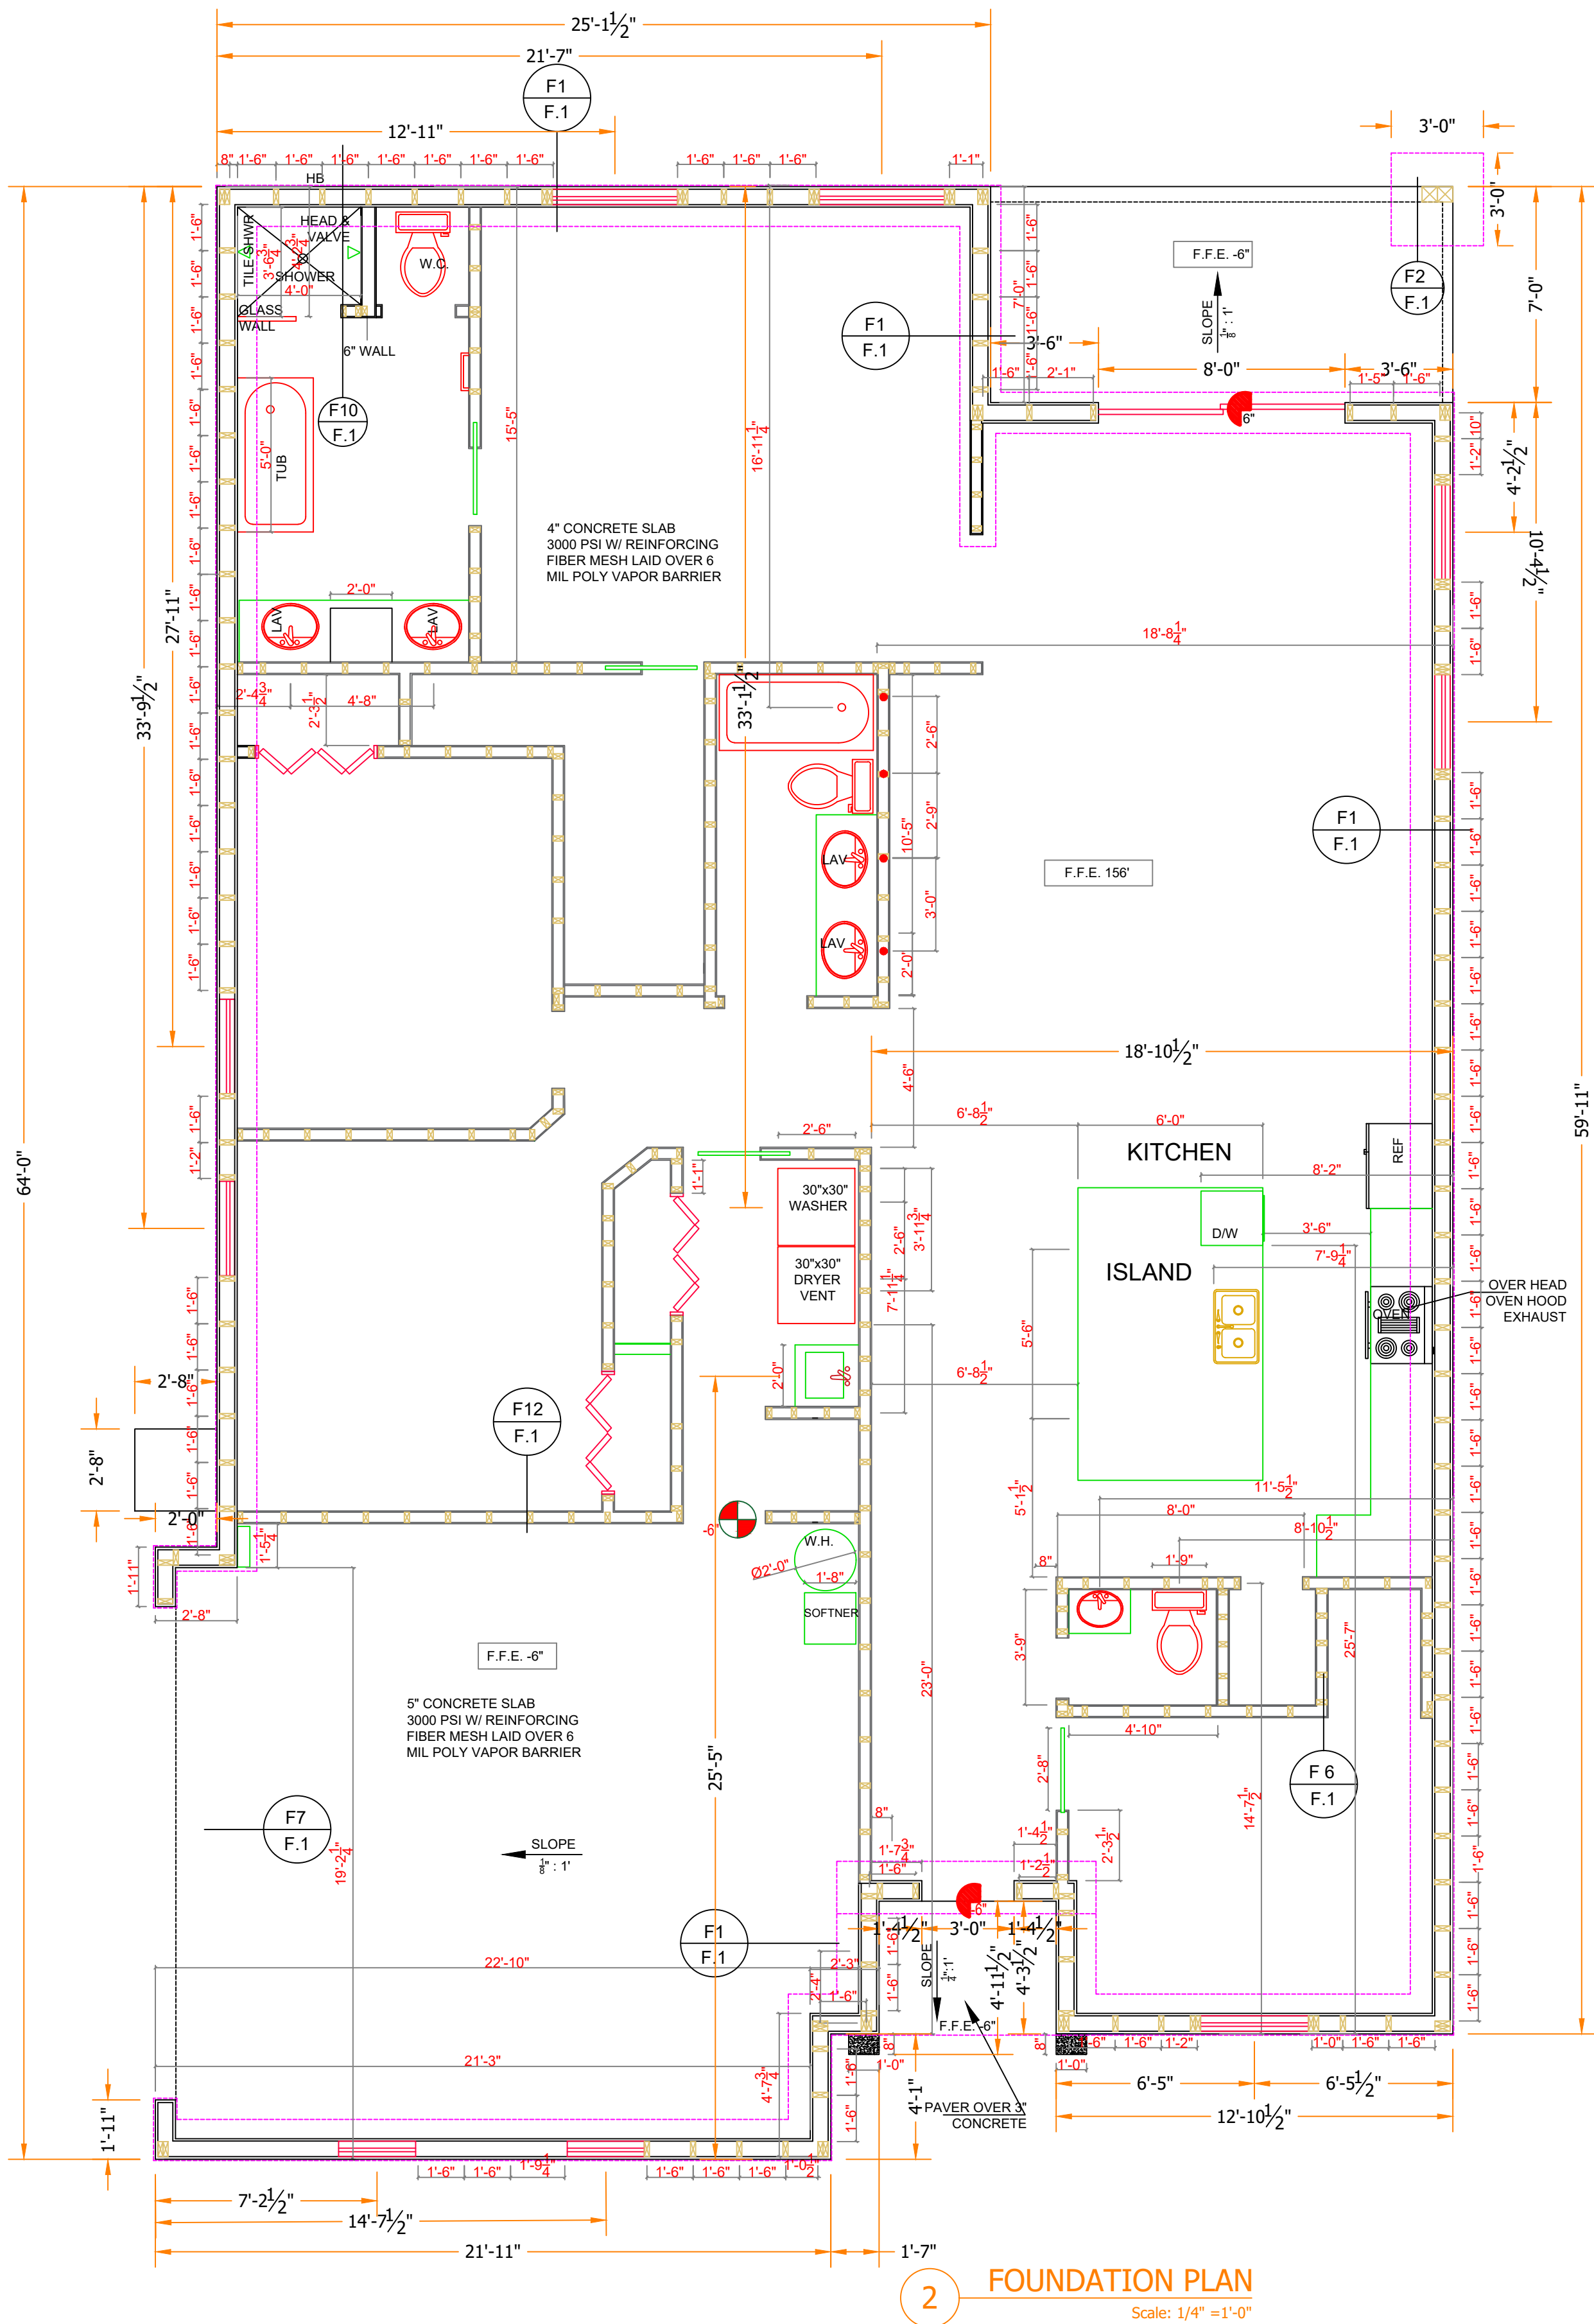

2 FOUNDATION PLAN
Scale: 1/4" = 1'-0"

NOTE:
IN VIEW OF CAST IN PLACE ANCHORS 1/2" MIN. X 6" EXPANSION
HEAD ANCHORS MAY BE USED. INSTALL EXPANSION ANCHORS
WITHIN 6" OF END WALL AND 24" O.C. BETWEEN ANCHORS.

LINTEL AND BEAM LEGEND		REMARKS
HEADER SCHEDULE	HEADER	
UP TO 24"	DOUBLE 2X6	
24" TO 30"	DOUBLE 2X8	
30" TO 36"	DOUBLE 2X10	
36" TO 42"	DOUBLE 2X12	
42" TO 48"	DOUBLE 2X12	
48" TO 54"	DOUBLE 2X12	
2142" TO 2148"	DOUBLE 2X12	

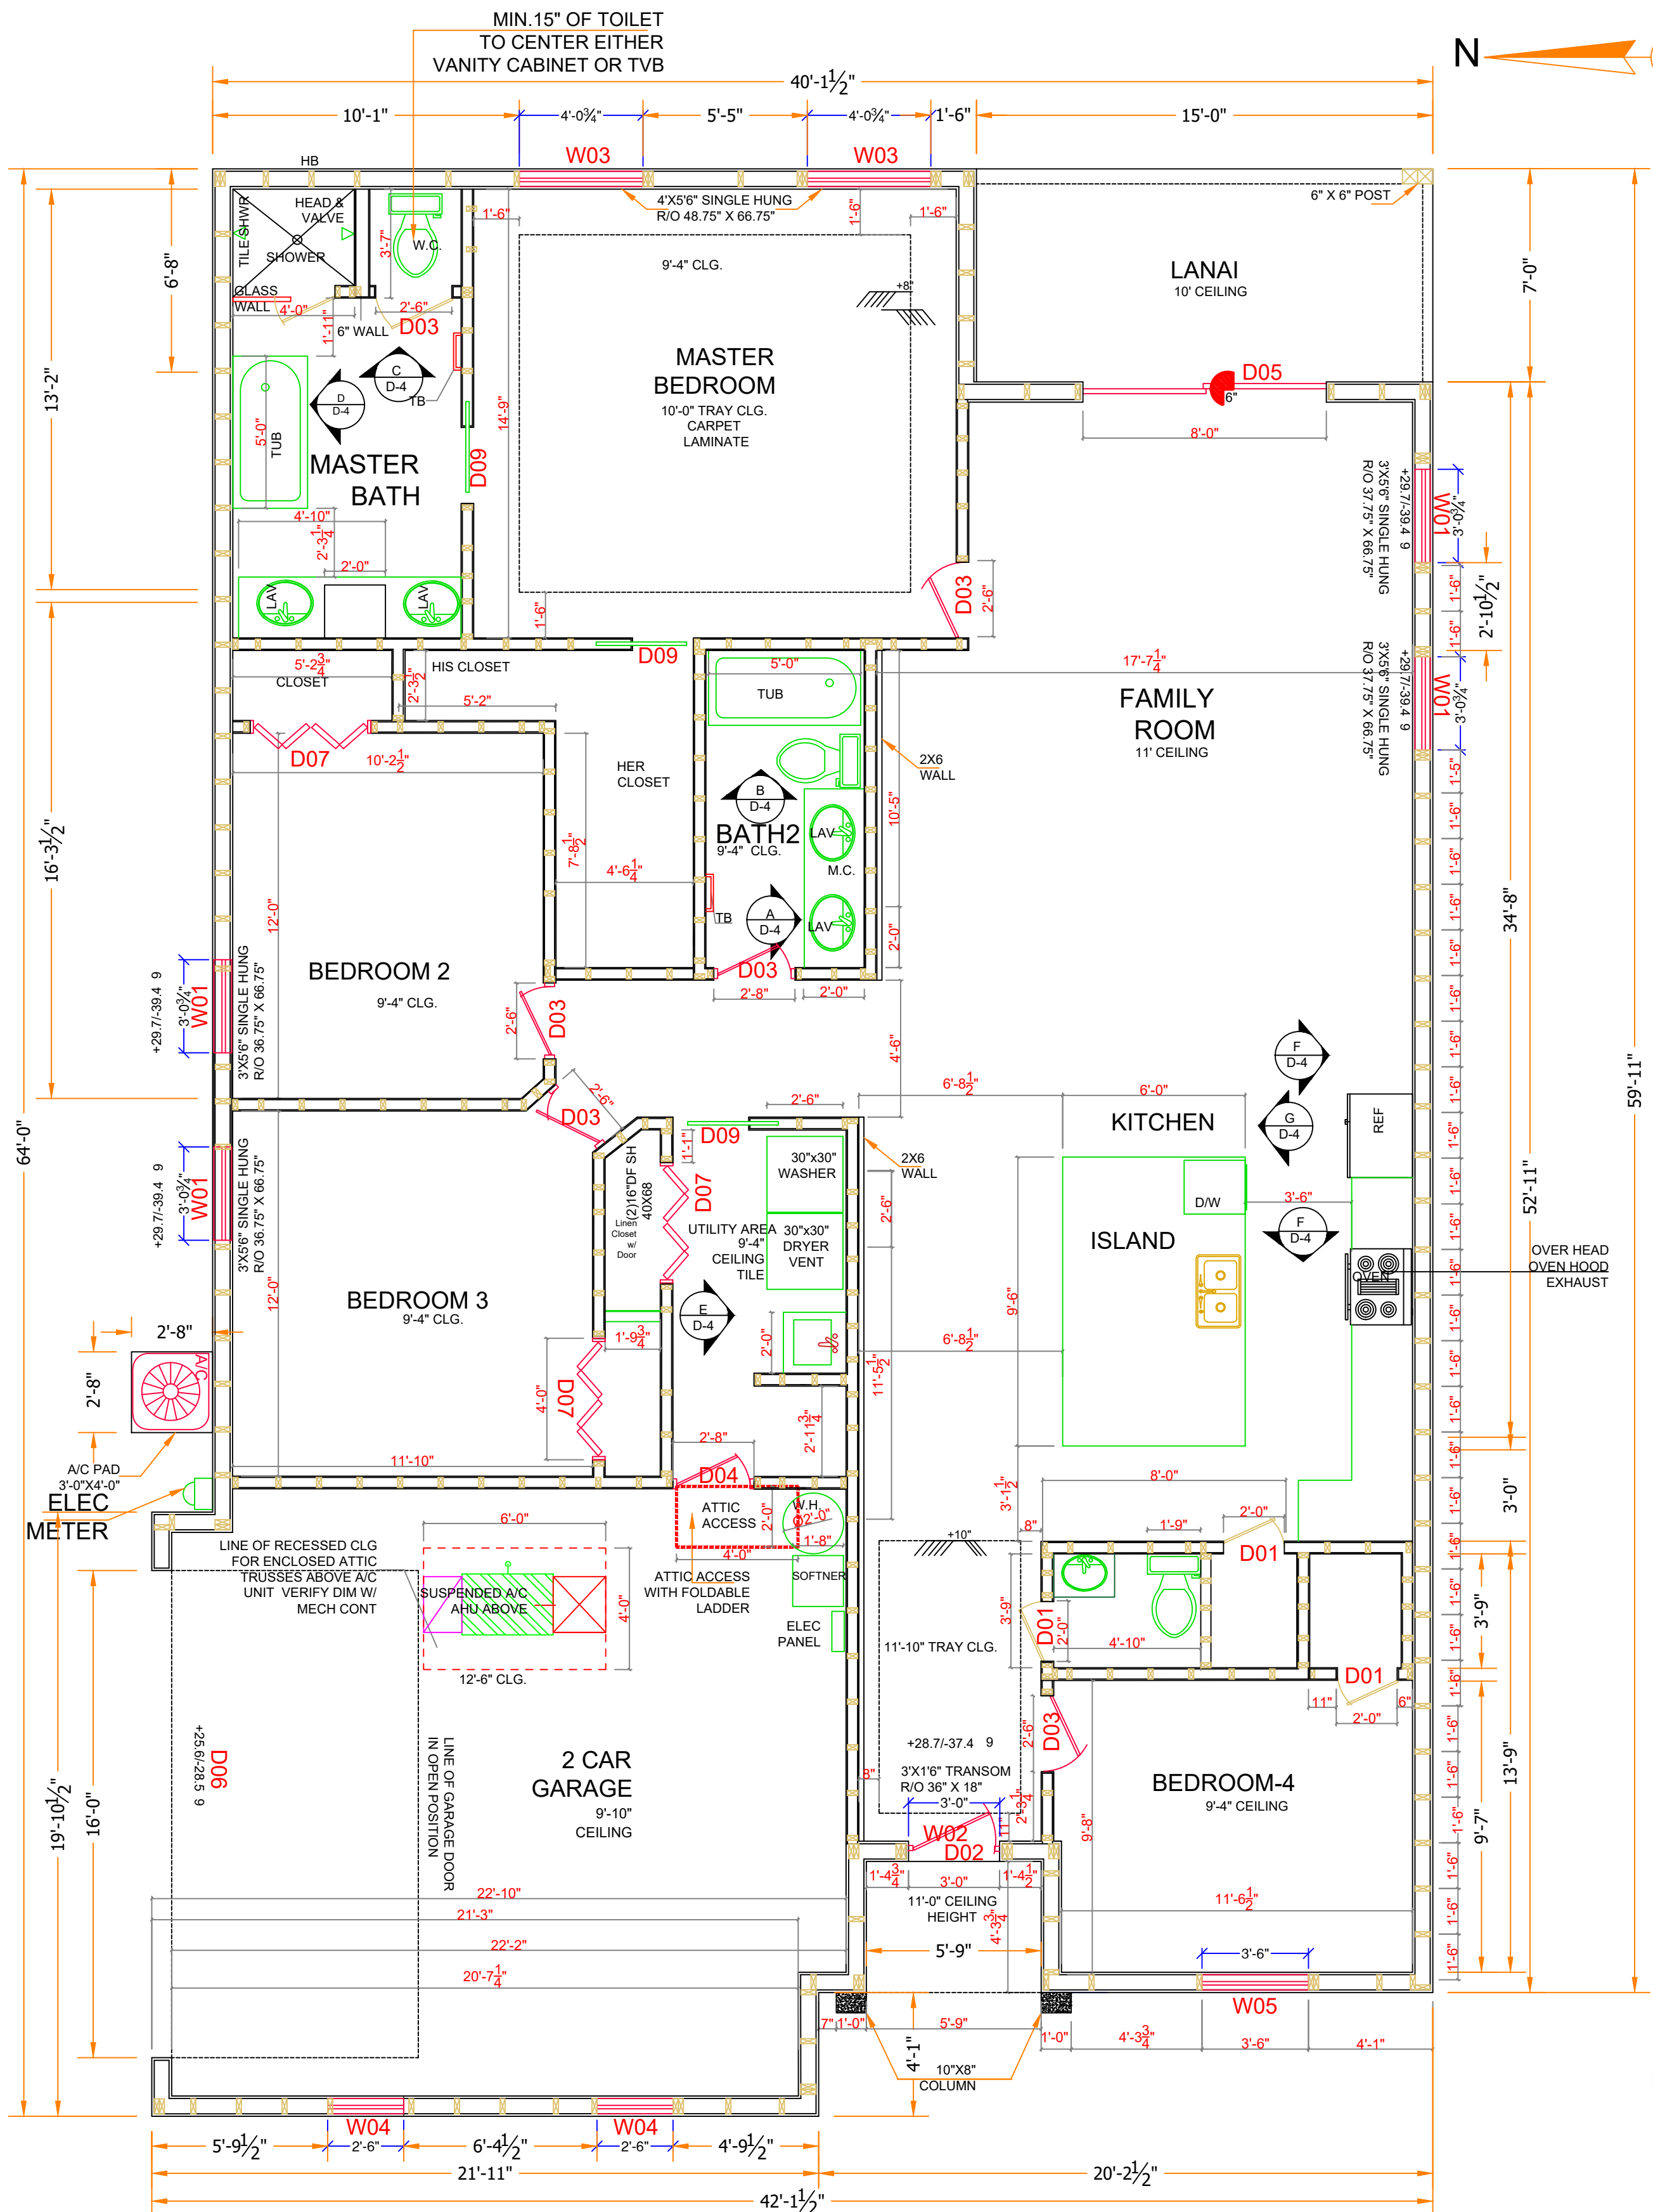

3 FLOOR PLAN

Scale: 1/4" = 1'-0"

AREA TABLE
GARAGE AREA : 396 S.F.
FRONT COVERED PORCH : 21 S.F.
HEATED AREA OF HOME : 1825 S.F.
BACK COVERED LANAI : 105 S.F.

PRODUCT APPROVAL SPECIFICATION SHEET				
CATEGORY/SUBCATEGORY	MANUFACTURER	PRODUCT DESCRIPTION	APPROVAL NUMBER(S)	Impact APPROVAL NUMBER(S)
1. EXTERIOR DOORS				
	FIXED	THERMA-TRU CORP	SWINGING DOORS	FL 15227.3 fl 15227.5
	FIXED	PGT	SLIDING DOORS	fl 251.10
2. WINDOWS				
	SINGLE/DOUBLE HUNG	pgt	SINGLE HUNG	FL 239.1
	HORIZONTAL SLIDER	pgt	HORIZONTAL SLIDER	FL 242.1
	FIXED	pgt	FIXED WINDOWS	FL 243.1
3. PANEL WALL				
	SOFFIT	plygem siding group	vinyl SOFFIT	FI 15847
4. ROOFING PRODUCTS				
	asphalt SHINGLES	owens corning	asphalt SHINGLES	fl 10674
	ROOFING TILES	MONIER/LIFESTYLE eagle	ROOF TILE	FL 601+5
5. STRUCT COMPONENTS				
	WOOD ANCHORS AND CONNECTORS	SIMPSON	WOOD CONNECTOR ANCHORS	fl 10456+2, fl 10852+11, fl 13872+1, fl 11473+2, fl 10667+1, fl 10866+2
LINTELS	cast-crete	PRECAST CONCRETE LINTELS	FL 158+5	
hurricane protection	global protection products, llc		20 gauge steel 24 gauge steel fabric shutter	fl 15076.1 fl 15076.2 fl 15088

DOOR SCHEDULE									
NUMBER	LABEL	QTY	FLOOR	CALL SIZE	WIDTH	HEIGHT	R/O	DESCRIPTION	HEADER
D01	2068	3	1	2480 IN	24"	80"	26 1/2"x82"	INTERIOR DOOR	2X4X38 1/2"
D02	3068	1	1	3680EX	36"	80"	38 1/2"x82"	FRONT DOOR EXTERIOR	2X4X50 1/2"
D03	2668	6	1	3080 IN	30"	80"	32 1/2"x82"	INTERIOR DOOR	2X4X44 1/2"
D04	2868	1	1	3280EX	32"	80"	34 1/2"x82"	SOLID CORE DOOR	2X4X46 1/2"
D05	8080	0	1	9696EX	96"	96"	96" X 96"	SLIDING GLAZED DOOR	2X4X110 1/2"
D06	1668	1	1	19280EX	192"	84"	194 1/2"x82"	GARAGE DOOR	2X4X206 1/2"
D07	4068	3	1	4880IN	48"	80"	50 1/2"x82"	BIFOLD DOOR	2X4X62 1/2"
D08	2668	0	1	3080 IN	30"	80"	32 1/2"x82"	BARN DOOR	2X4X44 1/2"
D09	2668	3	1	3080 IN	30"	80"	32 1/2"x82"	POCKET SLIDER	2X4X44 1/2"

WINDOW SCHEDULE									
NUMBER	LABEL	QTY	FLOOR	CALL SIZE	WIDTH	HEIGHT	R/O	TYPE	HEADER
W01	3056	4	1	3666	36"	66"	37.75"x66.75"	SINGLE HUNG	HEADER
W02	3016	1	1	3618	36"	18"	36" X 18"	TRANSOM	HEADER
W03	4856	2	1	4066	48"	66"	48.75" X 66.75"	SINGLE HUNG	HEADER
W04	2656	2	1	3066	30"	66"	30.75" X 66.75"	SINGLE HUNG	HEADER
W05	3656	1	1	4266	42"	66"	42.75" X 66.75"	SINGLE HUNG	HEADER

HEADER SCHEDULE			REMARKS
OPENING SIZE	HEADER		
UP TO 3'-4"	DOUBLE 2X6		
3'-5" TO 6'-0"	DOUBLE 2X8		
6'-1" TO 8'-6"	DOUBLE 2X10	(2)JACK STUDS EACH ENDS	
8'-7" TO 12'-6"	DOUBLE 2X12	(2)JACK STUDS EACH ENDS	

R311.2 EGRESS DOOR
AT LEAST ONE EGRESS DOOR SHALL BE PROVIDED FOR EACH DWELLING UNIT. THE EGRESS DOOR SHALL BE SIDE-HINGED, AND SHALL PROVIDE A MINIMUM CLEAR WIDTH OF 32 INCHES (813 mm) WHEN MEASURED BETWEEN THE FACE OF THE DOOR AND THE STOP, WITH THE DOOR OPEN 90 DEGREES (1.57 rad). THE MINIMUM CLEAR HEIGHT OF THE DOOR OPENING SHALL NOT BE LESS THAN 78 INCHES (1981 mm) IN HEIGHT MEASURED FROM THE TOP OF THE THRESHOLD TO THE BOTTOM OF THE STOP. OTHER DOORS SHALL NOT BE REQUIRED TO COMPLY WITH THESE MINIMUM DIMENSIONS. EGRESS DOORS SHALL BE READILY OPENABLE FROM INSIDE THE DWELLING WITHOUT THE USE OF A KEY OR SPECIAL KNOWLEDGE OR EFFORT.

TABLE R302.6 DWELLING / GARAGE SEPARATION


SEPARATION	MATERIAL
FROM THE RESIDENCE AND ATTICS	NOT LESS THAN 1/2 INCH GYPSUM BOARD OR EQUIVALENT APPLIED TO THE GARAGE SIDE
FROM ALL HABITABLE ROOMS ABOVE THE GARAGE	NOT LESS THAN 5/8 INCH TYPE "X" GYPSUM BOARD OR EQUIVALENT
STRUCTURE(S) SUPPORTING FLOOR/CEILING ASSEMBLIES USED FOR SEPARATION REQUIRED BY THIS SECTION	NOT LESS THAN 1/2 INCH GYPSUM BOARD OR EQUIVALENT
GARAGES LOCATED LESS THAN 3 FEET FROM A DWELLING UNIT ON THE SAME LOT	NOT LESS THAN 1/2 INCH GYPSUM BOARD OR EQUIVALENT APPLIED TO THE INTERIOR SIDE OF EXTERIOR WALLS THAT ARE WITHIN THIS AREA

FOR SI: 1 INCH = 25.4 mm, 1 FOOT = 304.8 mm

TABLE R301.2(4) GARAGE DOOR LOADS FOR A BUILDING WITH A MEAN HEIGHT OF 30 FEET LOCATED IN EXPOSURE B

Wind AS DETERMINED IN ACCORDANCE WITH SECTION R301.2.1.3 (MPH - 3 SECOND GUST)						
ROOF ANGLE <10 DEGREES	90	100	110	120	130	140
EFFECTIVE AREA:						
WIDTH (FT.)						
9	12.8-14.5	15.8-17.9	19.1-21.6	22.8-25.8	26.7-30.2	31.0-35.1
16	7	12.3-13.7	15.2-16.9	18.3-20.4	21.8-24.3	25.6-28.5

FOR SI: 1 FOOT = 304.8 mm, 1 SQUARE FOOT = 0.0929 m², 1 MILE PER HOUR = 1.609 km/h
1. FOR EFFECTIVE AREAS OR WIND SPEEDS BETWEEN THOSE GIVEN ABOVE THE LOAD MAY BE INTERPOLATED, OTHERWISE USE THE LOAD ASSOCIATED WITH THE LOWER EFFECTIVE AREA.
2. TABLE VALUES SHALL BE ADJUSTED FOR HEIGHT AND EXPOSURE BY MULTIPLYING THE ADJUSTMENT COEFFICIENT IN TABLE R301.2(3).
3. PLUS AND MINUS SIGNS SIGNIFY PRESSURES ACTING TOWARD AND AWAY FROM THE BUILDING SURFACES.
4. NEGATIVE PRESSURES ASSUME DOOR HAS 2 FEET WIDTH IN BUILDING END ZONE

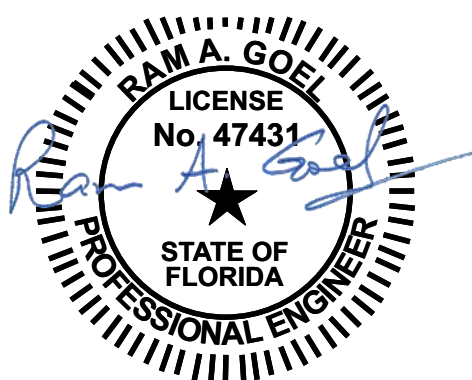

Digitally signed by Ram Goel
DN: E=Soneyfmllc@yahoo.com,
OU=ENGINEERING,
O=Soney FM LLC,
C=US
Date: 2022.11.25
13:44:01-0500

GENERAL PLUMBING NOTES

- ALL WORK AS PER GENERAL SPECIFICATIONS AND ALL FEDERAL, STATE AND LOCAL CODES.
- FOR HOT AND COLD WATER APPLICATIONS TYPE L COPPER SHALL BE USED OR PEX AS ALLOWED BELOW.
- CROSSLINKED POLYETHYLENE (PEX) PIPING MAY BE SUBSTITUTED FOR COPPER GIVEN THE FOLLOWING SPECIFICATIONS. USE ON COLD WATER AND HOT WATER APPLICATIONS NOT TO EXCEED 140 DEGREES F. ZURN OR EQUAL PIPE AND FITTINGS SHALL BE USED. THE FOLLOWING STANDARDS SHALL BE ADHERED TO: ASTM F876 FOR THE PIPE, ASTM F1807 BRASS FITTINGS MUST BE USED. DO NOT HYPERCLORATE THE SYSTEM IN EXCESS OF 5 PPM OR AS ALLOWED BY MANUFACTURER. DO NOT STORE PEX IN DIRECT SUNLIGHT. DO NOT BUY PEX FROM ANY WAREHOUSE KEEPING PEX STORED OUTSIDE. DO NOT INSTALL ANY PEX PIPING THAT HAS BEEN EXPOSED TO SUNLIGHT LONG ENOUGH FOR THE LABELING TO FADE. PEX THAT IS TO BE EXPOSED IN OPEN SLAB APPLICATIONS FOR LONGER THAN ONE WEEK SHALL BE WRAPPED IN ALUMINIZED TAPE TO PROTECT AGAINST UV DEGRADATION.
- ALL FIXTURES USED SHALL BE AS PER SCHEDULE OR EQUAL.
- ALL FIXTURES SHALL HAVE STOP VALVES AT WALL.
- ALL VENTS SHALL BE CARRIED THROUGH ROOF, COMPLETE WITH ROOF SYSTEM COMPATIBLE ROOF JACKS.
- ALL TOILET SEATS SHALL BE FOR ELONGATED BOWLS WITH OPEN FRONTS.
- TO FACILITATE THE CLARITY OF THE DRAWINGS, SEWER, WATER, AND GAS LINES ARE NOT ALWAYS SHOWN IN THEIR EXACT LOCATIONS.
- CONTRACTOR SHALL VISIT JOB SITE PRIOR TO BID AND VERIFY EXISTING CONDITIONS. NOTIFY ENGINEER IF EXISTING CONDITIONS DO NOT MATCH CONTRACT DOCUMENTS.
- PROVIDE WETTED TRAPS TO ALL FLOOR DRAINS.
- ROUTE TEMPERATURE AND PRESSURE RELIEF FROM WATER HEATER TO SEWER OR TO THE OUTSIDE OF BUILDING.

NOTE: MAIN WATER LINE TO HOME TO SOFTNER THEN WATER HEATER



RAM A. GOEL, P.E. # 47431
PH-813-792-1600

SONEY FM LLC
CORY LAKE PROFESSIONAL CENTER
10329 CROSS CREEK BLVD., SUITE P
TAMPA, FL 33647
www.soneyfmllc.com

Job # SG2205

Drawn By: KD

Checked By: S.G.

Issue Date: 11-25-22

Revisions:		
No.	Date	Description
1		
2		
3		
4		

FLOOR PLAN

LINCOLN MODEL III
791 NW SAVANNAH CIR.,
LAKE CITY, FL 32055

A-1

RAM A. GOEL, P.E. # 47431
PH: 813-792-1600
SONEY FM LLC
CORY LAKE PROFESSIONAL CENTER
10329 CROSS CREEK BLVD., SUITE P
TAMPA, FL 33647
www.soneyfmllc.com


Job # SG2205
Drawn By: KD
Checked By: S.G.

Issue Date: 11-25-22		
Revisions:		
No.	Date	Description
Δ	11	
Δ	11	
Δ	11	
Δ	11	


ROOF LAYOUT

LINCOLN MODEL III
791 NW SAVANNAH CIR.,
LAKE CITY, FL 32055

A-3

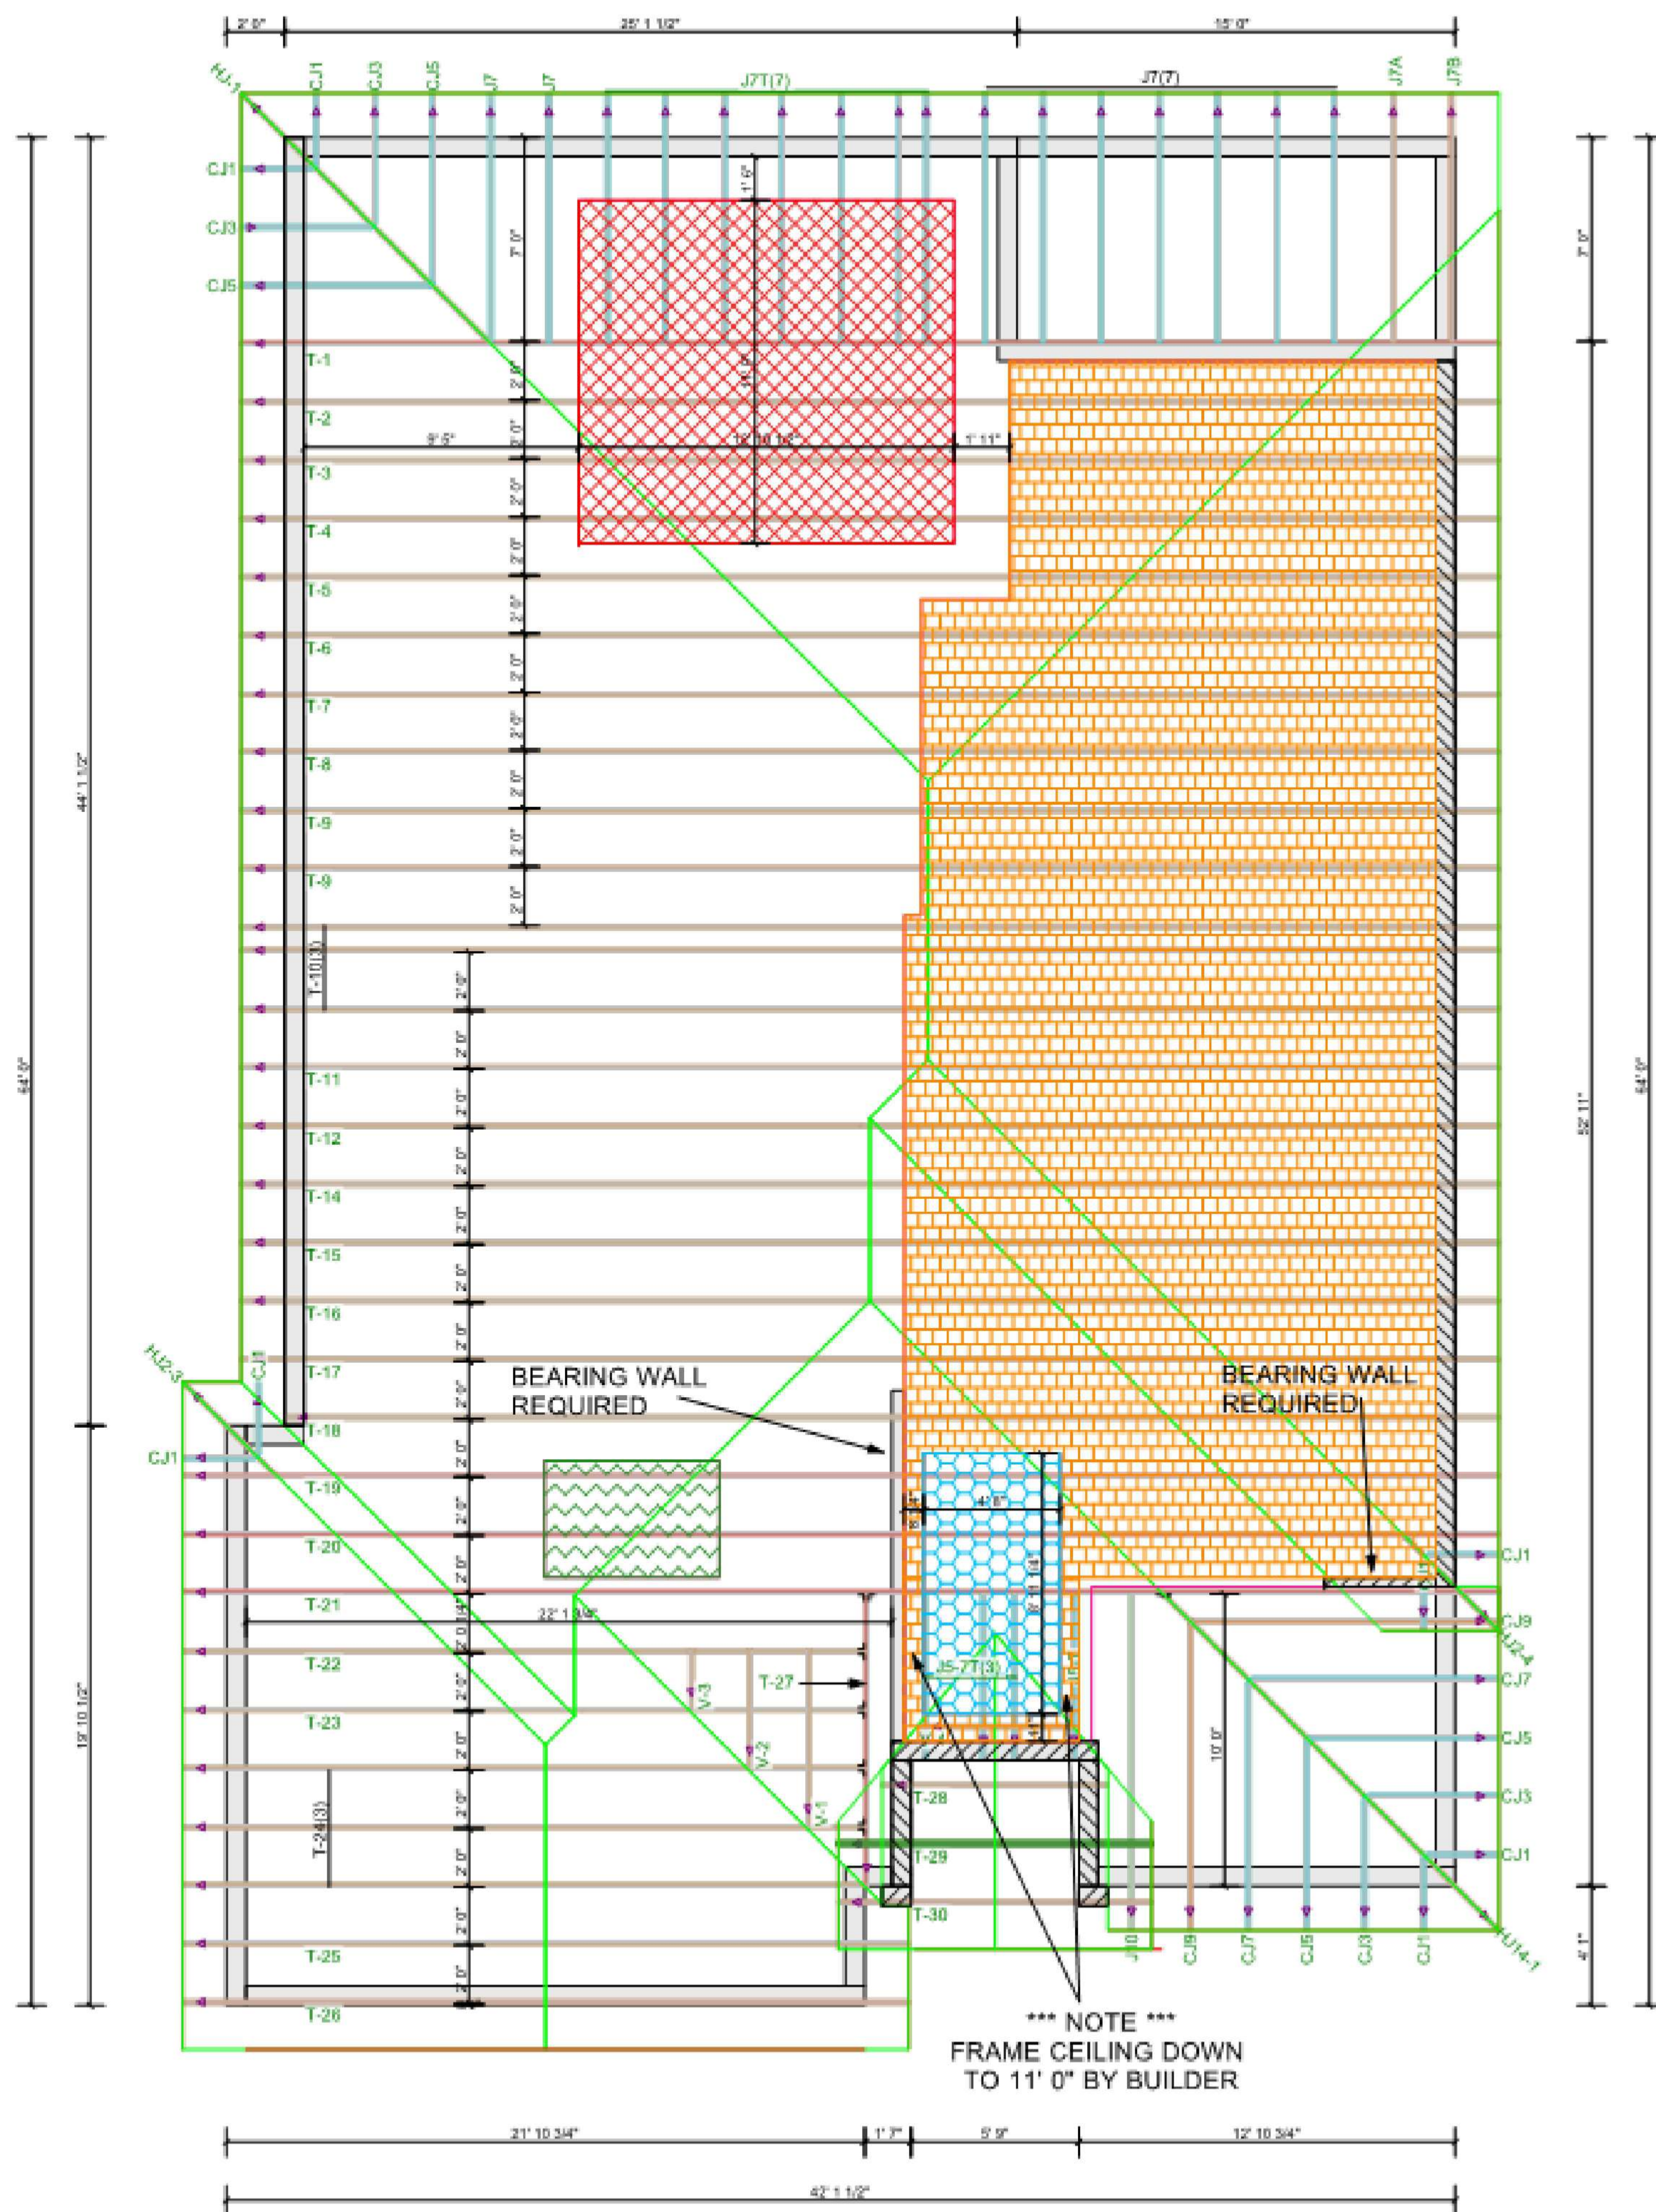

Hatch Legend	
	9' 4" BEARING HEIGHT
	11' 0" BEARING HEIGHT
	8" STEP TRAY CEILING TOP AT 10' 0"
	11' 0" FLAT CEILING AREA
	10' STEP TRAY CEILING TOP AT 11' 10"
	30" MECHANICAL RECESS

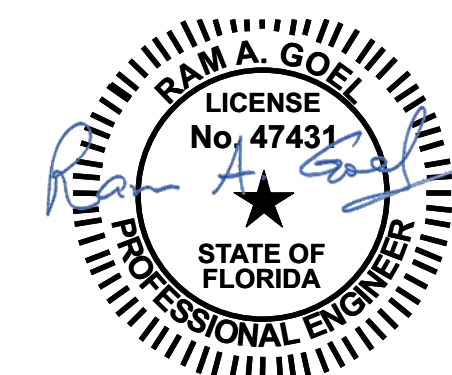


Ram Goel
Digitally signed by Ram Goel
DN:
E=Soneyfmllc@yahoo.com,
CN=Ram Goel,
OU=ENGINEERING,
O=Soney FM LLC,
L=Tampa, S-Florida, C=US
Date: 2022.11.25
13:42:28-05'00'

- Notes:
1. This item has been electronically signed & sealed by Ram A. Goel using a Digital signature & date.
 2. Printed copies of this document are not considered signed & sealed. This signature must be verified on any electronic copies.

THIS DRAWING IS AN INSTRUMENT OF SERVICE AND SHALL REMAIN THE PROPERTY OF THE ENGINEER, AND SHALL NOT BE REPRODUCED, PUBLISHED OR USED IN ANY WAY WITHOUT THE WRITTEN CONSENT OF THE ENGINEER. COPYRIGHT 2016. NOT PUBLISHED. THIS IS TO CERTIFY THAT I HAVE REVIEWED THIS PLAN AND FOUND TO BE IN COMPLIANCE WITH CHAPTER 16 OF 2020 7TH EDITION FLORIDA BUILDING CODE AND APPLICABLE SUPPLEMENTS.


RAM A. GOEL, P.E. # 47431
COPIES OF THESE PLANS ARE NOT VALID UNLESS EMBOSSED WITH THE SIGNING ENGINEER'S SEAL

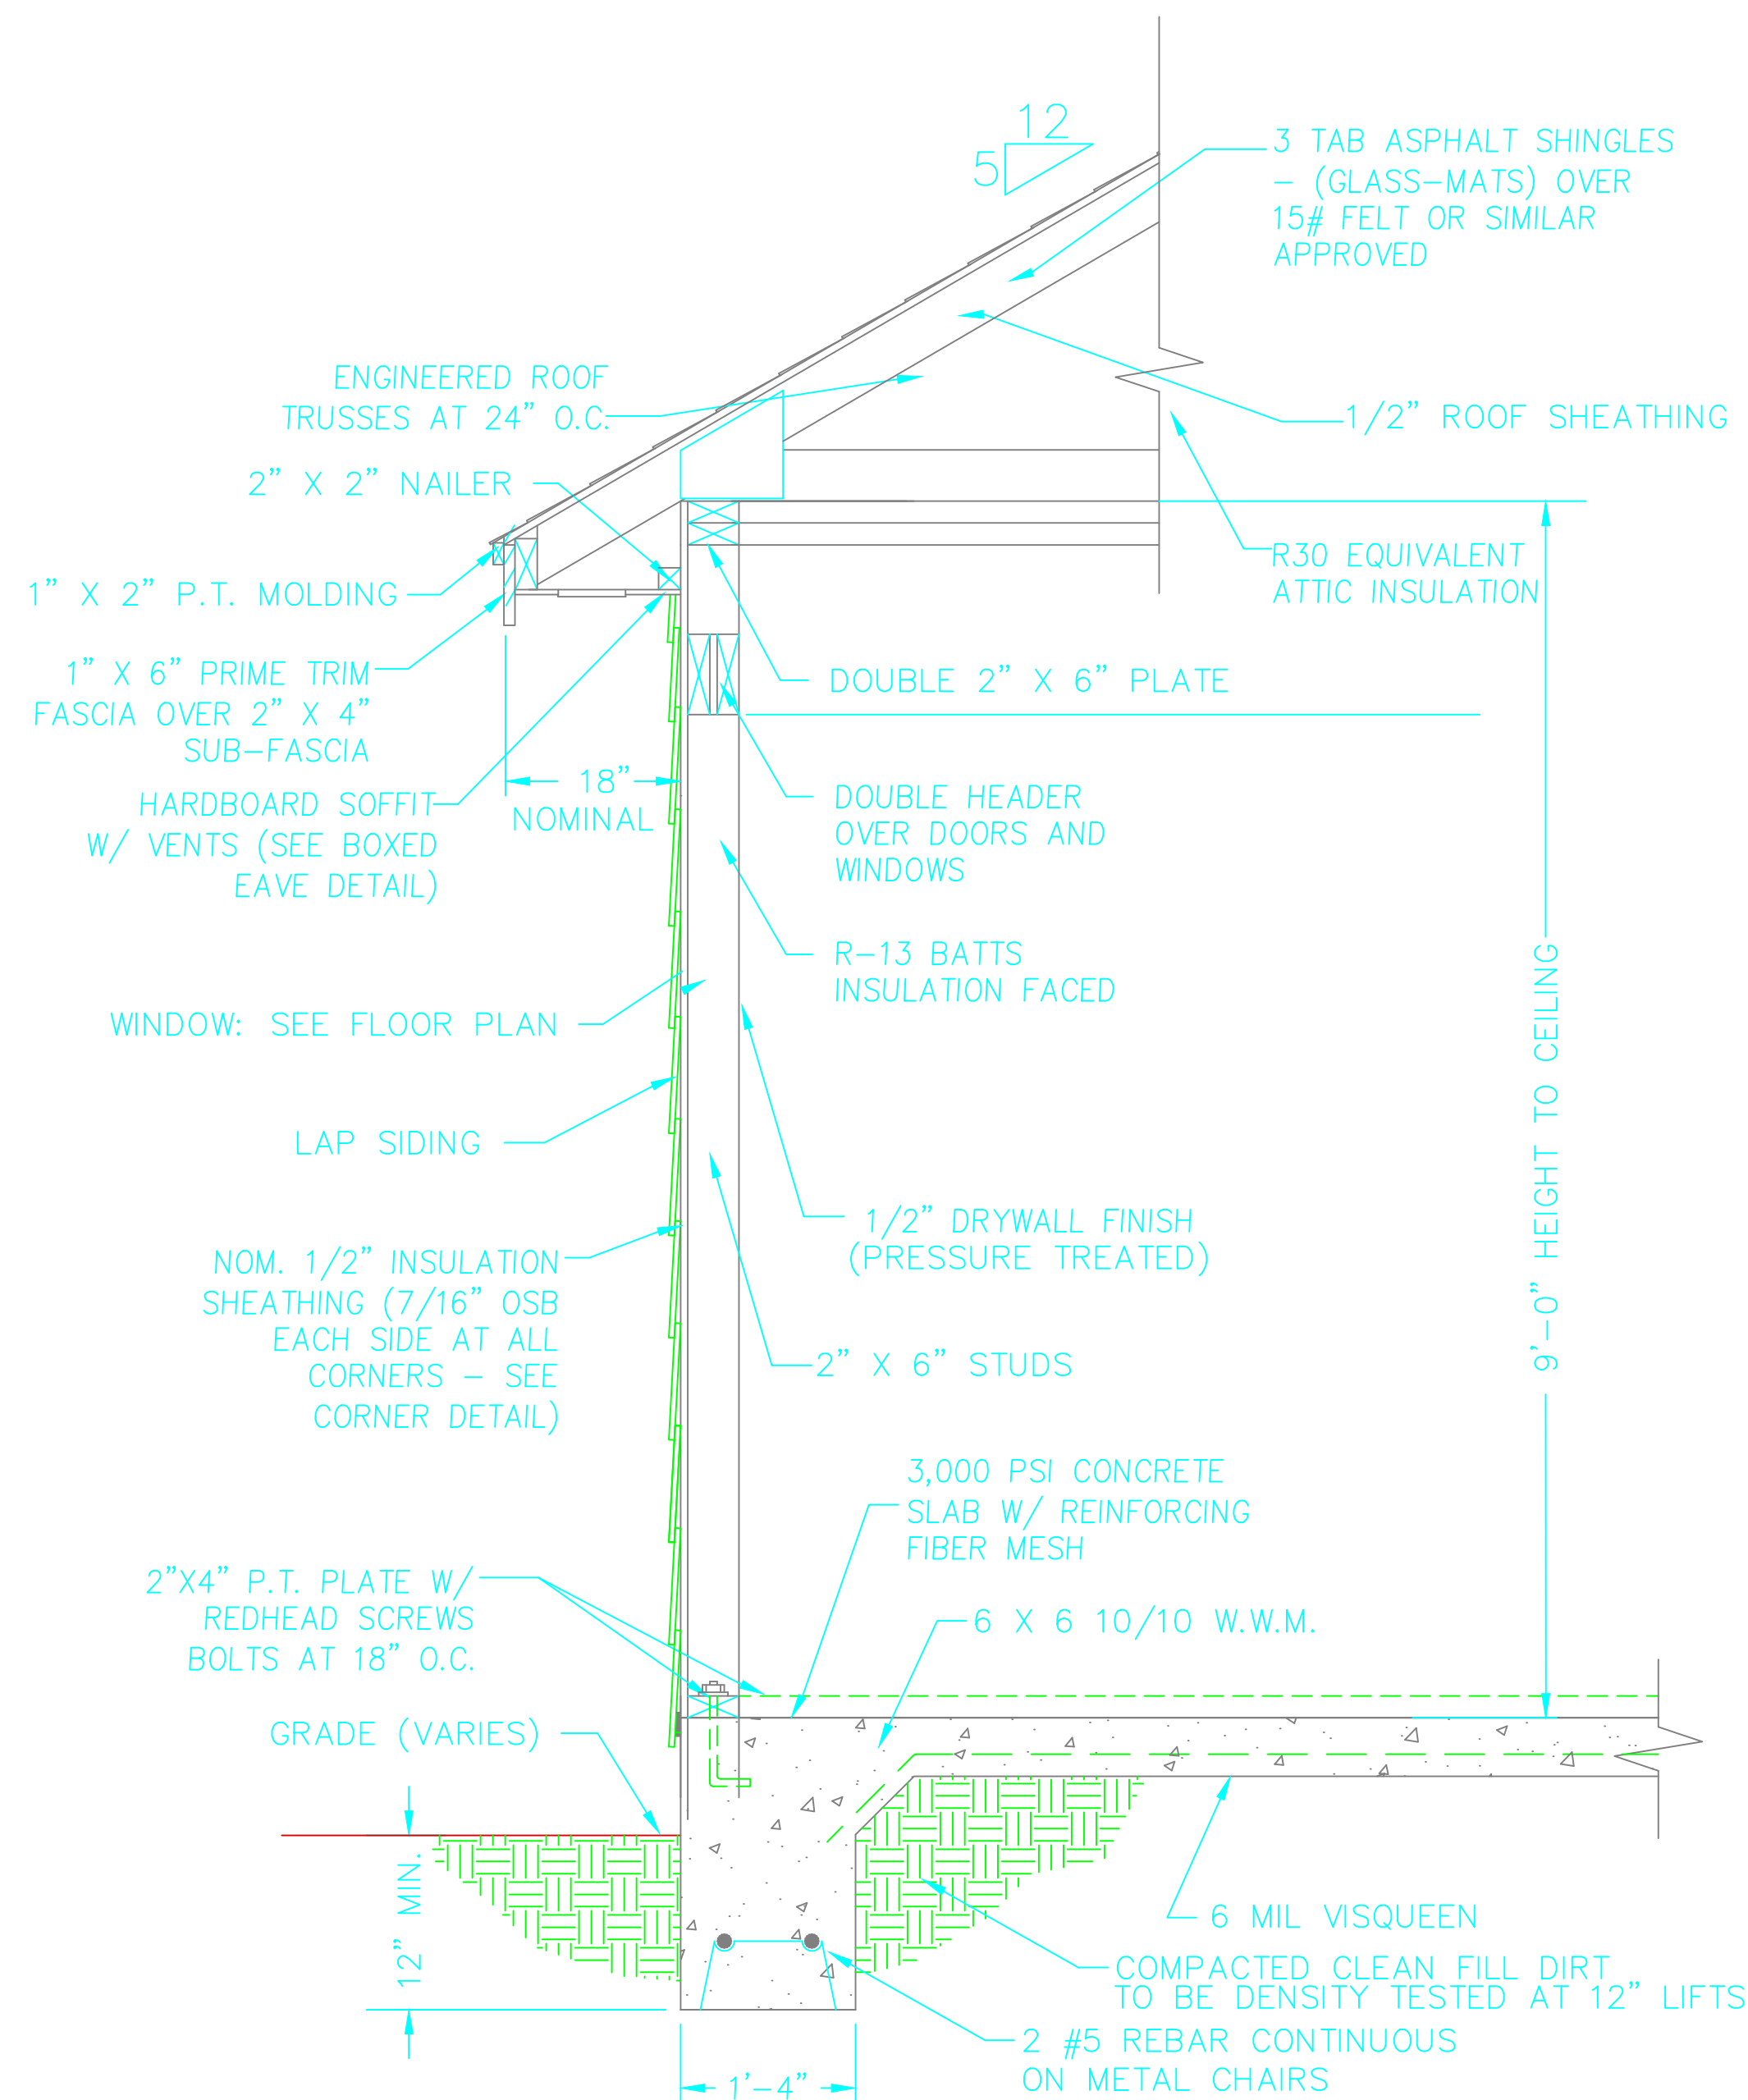

WALL SECTION


NOTES: 1) MITERED CUTS TO BE
MADE AT ALL JOINTS OF FASCIA.

SCALE: 3/4" = 1'-0"

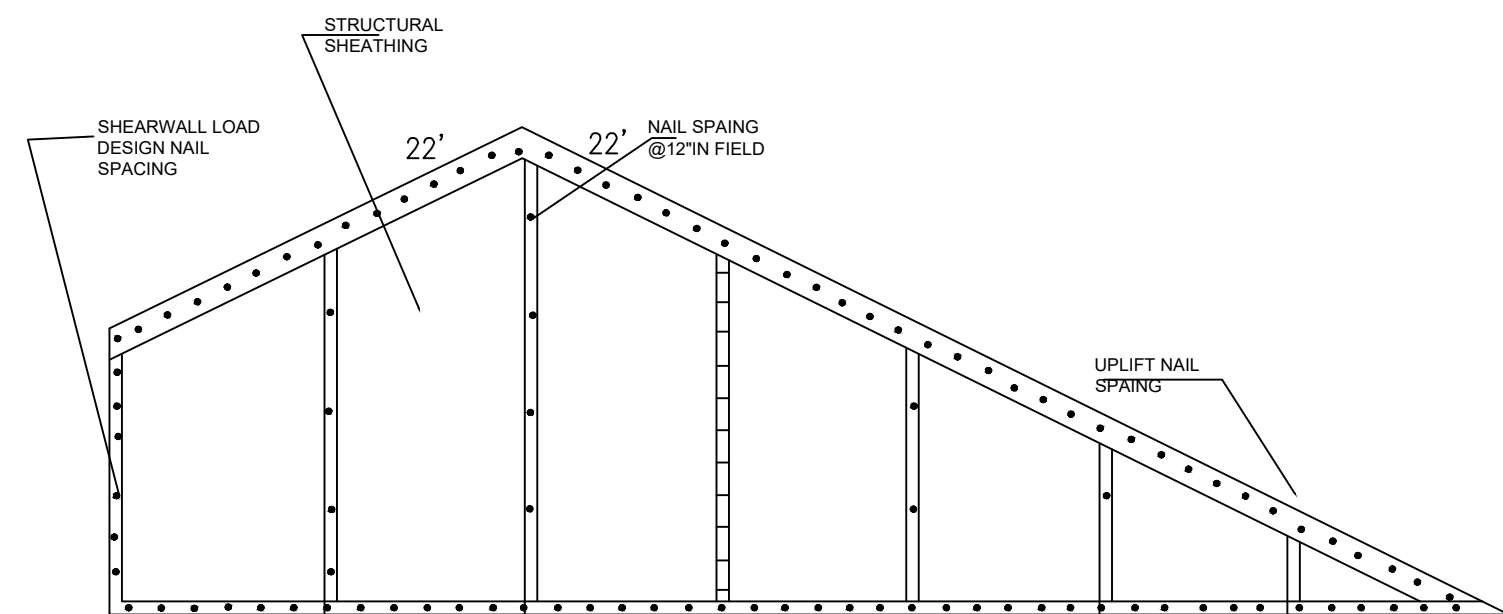

W02 GABLE END AND SHEATHING DETAIL Scale: N.T.S.

Scale: N.T.S

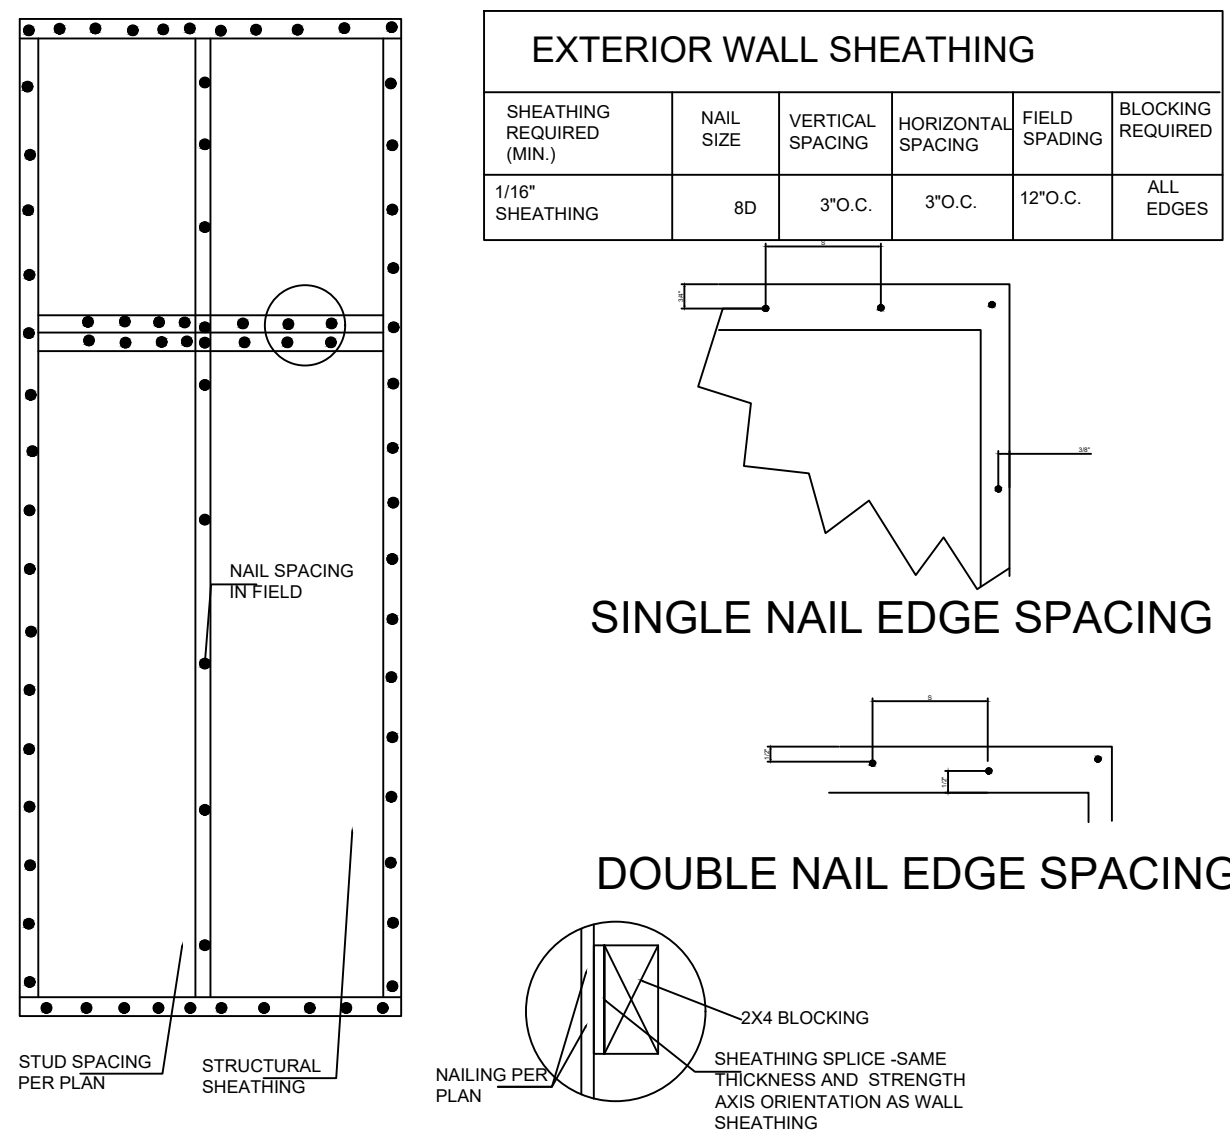

W01 TYPICAL SHEATHING DETAIL

Scale: N.T.S.



NOTE: ALL PRE-ENGINEERED WOOD PRODUCTS SHALL BE VERIFIED BY TRUSS MANUFACTURER. TRUSS MANUFACTURER SHALL HAVE THE AUTHORITY TO MAKE SUBSTITUTIONS FOR PRODUCTS SPECIFIED ON THE PLANS DUE TO AVAILABILITY OR ECONOMICS. CHANGES SPECIFIED BY THE TRUSS MANUFACTURER SHALL CONTROL. CHANGES MADE AFTER TRUSS ENGINEERING HAS BEEN PROVIDED TO ENGINEER OF RECORD, MUST BE APPROVED BY THE ENGINEER OF RECORD.

2. FRAMING PLAN IS DIAGRAMMATIC IN NATURE AND IS PROVIDED FOR ILLUSTRATION PURPOSES ONLY. TRUSS MANUFACTURER TO PROVIDE SEPARATE LAYOUT AND TRUSS COMPONENT DESIGN SIGNED AND SEALED BY A FLORIDA REGISTERED PROFESSIONAL ENGINEER.

[illegible]


1. 2"x10" RAFTER W/ 2"x8" C.R.T.S. S.P. 16" @ COMMON RAFTER FRAMING.
2. ATTACHMENT AT TOP OF NEW C/M.S. WALL TO BE SIMPSON HETA 20 STRAPS.
3. VAL FRAMING 2"x6" SLEEPER W/ (2) 4" TYP. 16" @ COMMON RAFTER FRAMING.
4. 2"x6" SLEEPER W/ 2"x8" C.R.T.S. S.P. 16" @ COMMON RAFTER FRAMING.
5. OF RAFTER, COLLAR TIES GLUED AND NAILED 12" DOWN FROM RIDGE AT 24" O.C.
6. GABLE FRAMING TO CONSIST OF 2X4 S.Y.P. DROP GABLE DESIGN. S.P.1 AT BOTTOM PLATE STUD CONNECTION. S.P. 2 AT TOP PLATE STUD CONNECTION.
7. 10 D @ EACH OUTCLOUTER 24" O.C. AT FRAMING WALL CONNECTION. ALL OUTLOOKERS TO BE 2K4 S.Y.P.
8. CEILING FRAMING TO BE 2X6 S.Y.P. AT EACH RAFTER.
9. ALL ROOF SHEATHING WILL BE 19/32 CDX 4 PLY WITH CLIPS AND NAILED PER F.B.C.
10. GABLE PLYWOOD TO BE 15/32.
11. MICROSLA AND SUB-FASCIA AND SOFFIT TO MATCH EXISTING AS CLOSE AS POSSIBLE.
12. GUTTERS ON EACH SIDE OF NEW ROOF TO BE COORDINATE WITH EXISTING.
13. FASCIA BEAM WITH H10 CONNECTORS EACH END.

1. LONG SIDE OF SHEATHING TO BE TRUSSES OR RAFTERS-TYPICAL.
2. EDGE SPACING ALSO APPLIES OVER GABLE END WALLS OR TRUSSES.
3. FASTENING ZONE 2 AND 3 ARE EQUAL TO 10% OF TOTAL HOUSE WIDTH, DIMENSION "X" FROM ROOF EDGE
30' WIDE HOUSE = 3' ZONE, 50' WIDE HOUSE = 5' ZONE 60' WIDE HOUSE = 6' ZONE

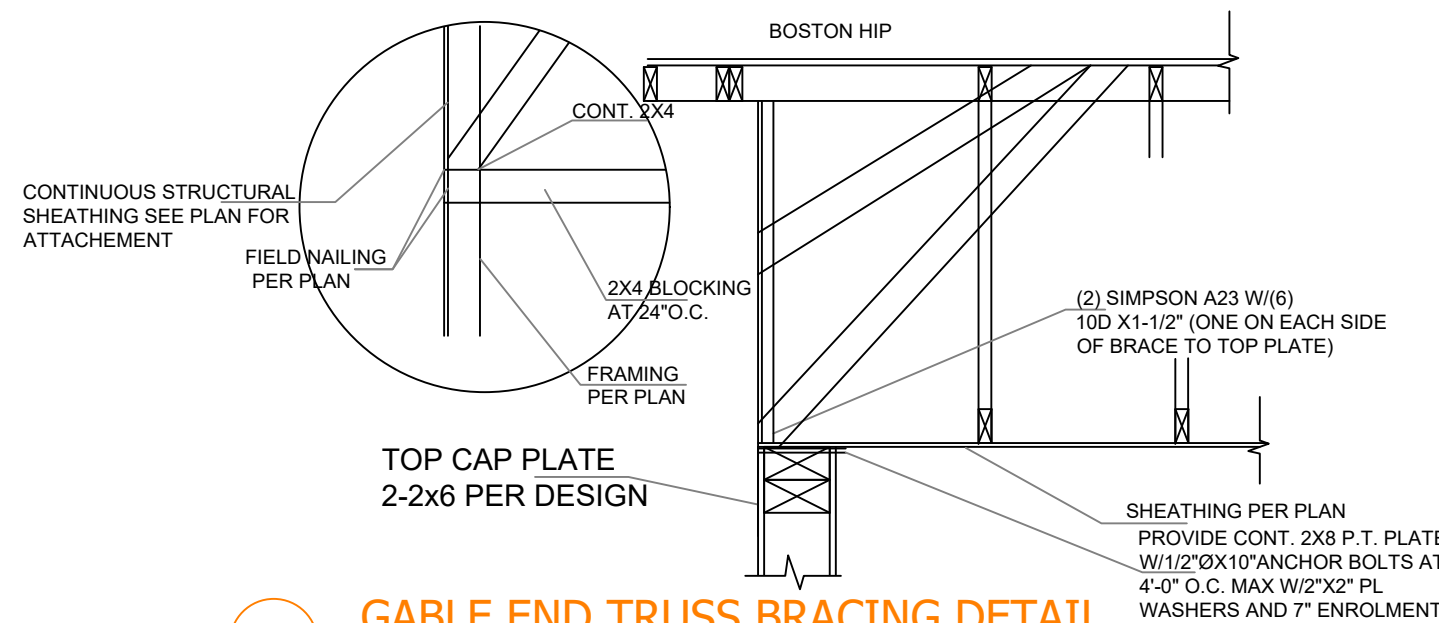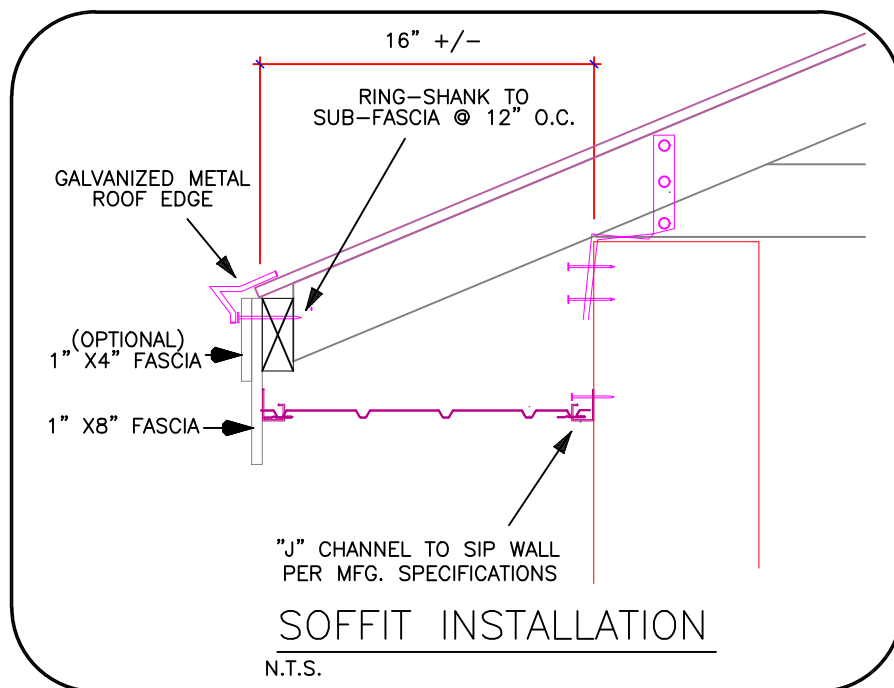

536 GABLE END TRUSS BRACING DETAIL

Scale: N.T.S

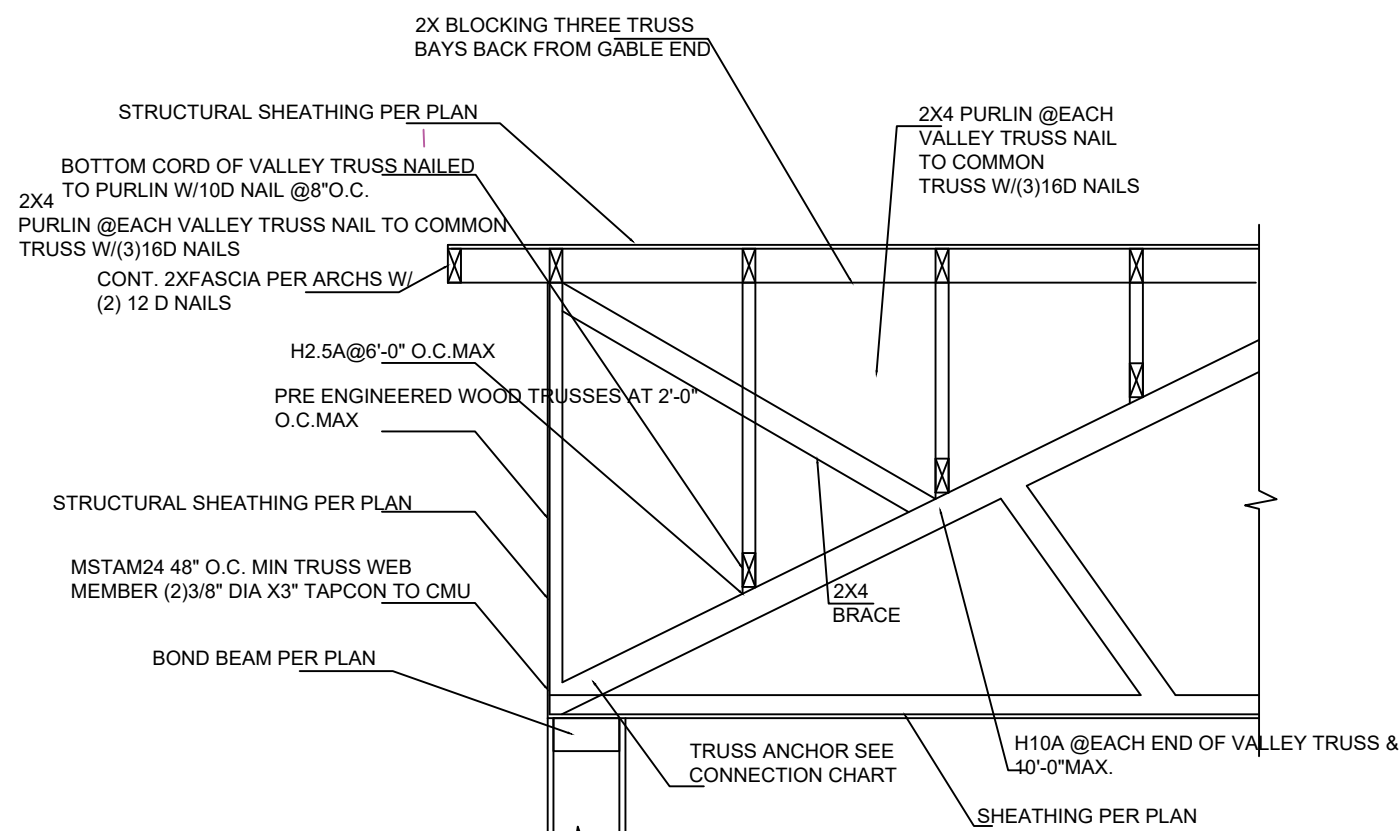

522 TYPICAL GABLE END DETAIL

Scale: N.T.S.

EXTERIOR GABLE END SHEATHING

SHEATHING REQUIRED (MIN.)	NAIL SIZE	VERTICAL SPACING	HORIZONTAL SPACING	FIELD SPACING	BLOCKING REQUIRED
1/16" SHEATHING	8D	3"O.C.	3"O.C.	12"O.C.	ALL EDGES

FLASHING NOTES:

- [illegible]

CONNECTION SCHEDULE			
Manufacturer Name	Model No.	Fl. Product Approval	Location / Use
	"HETA-20"	# 11473-R2	AT ALL TRUSS/WALL CONNECTIONS
SIMPSON	"M1S-12"	# 10456-R2	AT ALL RAFTER/WALL CONNECTIONS
SIMPSON	"LSTA-36"	# 10852-R2	EMBEDDED IN BLOCK CELL MORTARO STRAP DOWN P.T. WOOD BEAMS ON TOP OF CONC. BLOCK COLUMNS
SIMPSON	"H10"	# 10456-R2	AT ALL WALL PLATES/RAFTERS
SIMPSON	"EC066"	# 10860-R2	ANCHOR P.T. WOOD POSTS ON TOP PLYWOOD FLOOR
SIMPSON	"EC0LR"	# 13904-R2	CAP LUMBER BEAM CORNERS ON P.T. POST
SIMPSON	"A33" Angle	# 10446-R2	CAP LUMBER BEAM CORNERS ON P.T. POST
SIMPSON	"SP2"	# 10456-R2	● TOP PLATE
SIMPSON	"SP1"	# 10456-R2	● BOTTOM PLATE
SIMPSON	"ABA66"	# 10849-R3	ANCHOR P.T. POSTS ON TOP OF NEW CONCRETE FOOTER SLAB
SIMPSON	"HH4"	# 10446-R2	USE 16d Nails W/ "HH4" TO ATTACH FLOOR BEAM TO P.T. WOOD POST
SIMPSON	"H0US48"	# 11468-R2	USE 16d Nails W/ "H0US48" TO ATTACH FLOOR BEAM TO FRAME WALL BASE BOARD
USP	"HUS28"	# 10655-R2	HEAVY DUTY JOIST HANGER-AT ALL PERPENDICULAR CONTACTS TO SECURE P.T. ROOF RAFTERS TO WALL LEDGER BOARD
USP	"NFM3.5x10"	# 578-R3	AT BEAM/BLOCKWALL CONNECTIONS

Note

1. Any products that are substituted, must meet or exceed products specified. Contractor "must" provide data to building inspector at time of inspection.

BEAM SCHEDULE	
BEAM HEADER	
	(3)X12 RAFTER WITH (2) 1/2"PLYWOOD FLITCH USE 2 ROWS SIMPSON 1/4"X2-1/2" SCS SCREWS @12"O.C. PLUS CTS BEAD OF PL50 CONSTRUCTION ADHESIVE
	(2)X6 RAFTER WITH 1/2"PLYWOOD FLITCH USE 2 ROWS SIMPSON 1/4"X2-1/2" SCS SCREWS @12"O.C. PLUS CTS BEAD OF PL50 CONSTRUCTION ADHESIVE
	(3)X8 RAFTER WITH 1/2"PLYWOOD FLITCH USE 2 ROWS SIMPSON 1/4"X2-1/2" SCS SCREWS @12"O.C. PLUS CTS BEAD OF PL50 CONSTRUCTION ADHESIVE
	(3)X10 RAFTER WITH 1/2"PLYWOOD FLITCH USE 2 ROWS SIMPSON 1/4"X2-1/2" SCS SCREWS @12"O.C. PLUS CTS BEAD OF PL50 CONSTRUCTION ADHESIVE

NAILING SCHEDULE		
CONNECTION	COMMON NAIL	# OF SPACING
SOLE PLATE TO TRUSS OR BLOCKING	16d	16" O.C.
STUD TO SOLE PLATE, TOE NAIL	8d	4
DOUBLE STUDS, FACE NAIL	10d	24" O.C.
DOUBLE TOP PLATES, FACE NAIL	10d	16" O.C.
TOP PLATES, LAPS AND INTERSECTIONS	10d	3
TRUSSES, LAPS OVER WALLS, FACE NAIL	16d	4
BUILT-UP CORNER STUDS	16d	24" O.C.
STUDS TO SOLE PLATE, END NAIL	16d	2

FLORIDA PRODUCT APPROVALS				
CATEGORY	SUB-CATEGORY	MANUFACTURER	APPROVAL CODE (FL)	APPROVAL DATE
PANEL WALLS	SIDING	JAMES HARDIE	13223.2	10/10/2017
WINDOWS	SINGLE-HUNG	JELD-WEN	14095.4	7/28/2017
WINDOWS	FIXED	JELD-WEN	14088.3	8/16/2017
EXTERIOR DOORS	SWINGING EXTERIOR DOOR ASSEMBLY	TERMATRU	10537.4	12/12/2017
EXTERIOR DOORS	GARAGE DOOR	CLOPAY	5684.1	10/10/2017
EXTERIOR DOORS	GARAGE DOOR	CLOPAY	5684.18	10/10/2017
EXTERIOR DOORS	SWINGING EXTERIOR DOOR ASSEMBLY	TERMATRU	7640.1	12/12/2017
EXTERIOR DOORS	SLIDING EXTERIOR DOOR ASSEMBLES	JELD-WEN	21705.1	6/24/2020
PANEL WALLS	SOFFITS	JAMES HARDIE	13765.1	6/7/2020
ROOFING	ASPHALT SHINGLES	GAF	10124.1	6/7/2020
ROOFING	UNDERLAYMENTS	OWENS CORNING	14259.1	6/18/2019

ATTIC TABULATION & VENTILATION		
GROSS AREA OF ROOF	3898	SQUARE FEET
GROSS AREA OF VENTED SOFFIT	182	SQUARE FEET
NET AREA OF VENTED SOFFIT	127	SQUARE FEET (70%)
1/150 OF GROSS ROOF AREA	26	SQUARE FEET
1/300 OF GROSS ROOF AREA	13	SQUARE FEET
REQUIRED RIDGE & OFF RIDGE VENTS (TOTAL AREA)	3	SQUARE FEET TOTAL

ATTIC VENTILATION PER FLORIDA BUILDING CODE 2017 6TH EDITION, RESIDENTIAL
FOR GABLED AND HIPPED ROOFS, VENTILATION SHALL BE PROVIDED TO
FURNISH CROSS VENTILATION OF EACH SEPARATE ATTIC SPACE WITH
WEATHER PROTECTED VENTILATION.
PROTECT THE INTERIOR FROM INTRUSION OF BIRDS. THE RATIO OF
TOTAL NET FREE VENTILATING AREA TO THE AREA OF THE CEILING SHALL
BE NOT LESS THAN 1/30. THIS AREA MAY BE EXCEEDED TO THE FOLLOWING:
1. A VAPOR RETARDER HAVING A PERMEANCE NOT EXCEEDING ONE
PERM IS INSTALLED ON THE INSIDE OF THE ROOF.
2. AT LEAST 50% OF THE REQUIRED VENTILATING AREA IS PROVIDED BY
VENTILATORS LOCATED IN THE UPPER PORTION OF THE SPACE TO BE VENTILATED
(AT LEAST 3 FEET ABOVE EAVE OR CORNICE VENTS.)

ROOF SHEATHING:
UNLESS OTHERWISE NOTED, ALL ROOF SHEATHING SHALL BE 19/32" CDX PLYWOOD, NAILED
WITH 10d COMMON NAILS AT 6" O/C BOUNDARY, 6" O/C ALL OTHER EDGES AND 6" O/C FIELD.

Notes:

1. This item has been electronically signed & sealed by Ram A. Goel using a Digital signature & date.
2. Printed copies of this document are not considered signed & sealed. This signature must be verified on any electronic copies.

RAM A. GOFEL P.F. # 474.31

COPIES OF THESE PLANS ARE NOT VALID UNLESS
EMBOSSSED WITH THE SIGNING ENGINEER'S SEAL


Digitally signed by Ram Goel
DN:
E=Soneyfmllc@yahoo.com
CN=Ram Goel,
OU=ENGINEERING,
O=Soney FM LLC,

Digitally signed by Ram Goel
DN:
E=Soneyfmllc@yahoo.com,
CN=Ram Goel,
OU=ENGINEERING,
O=Soney FM LLC,
L=Tampa, S=Florida, C=US
Date: 2022.11.25
13:42:13-0500

FRAMING DETAILS

LINCOLN MODEL III
791 NW SAVANNAH CIR.,
LAKE CITY, FL 32055



D-1

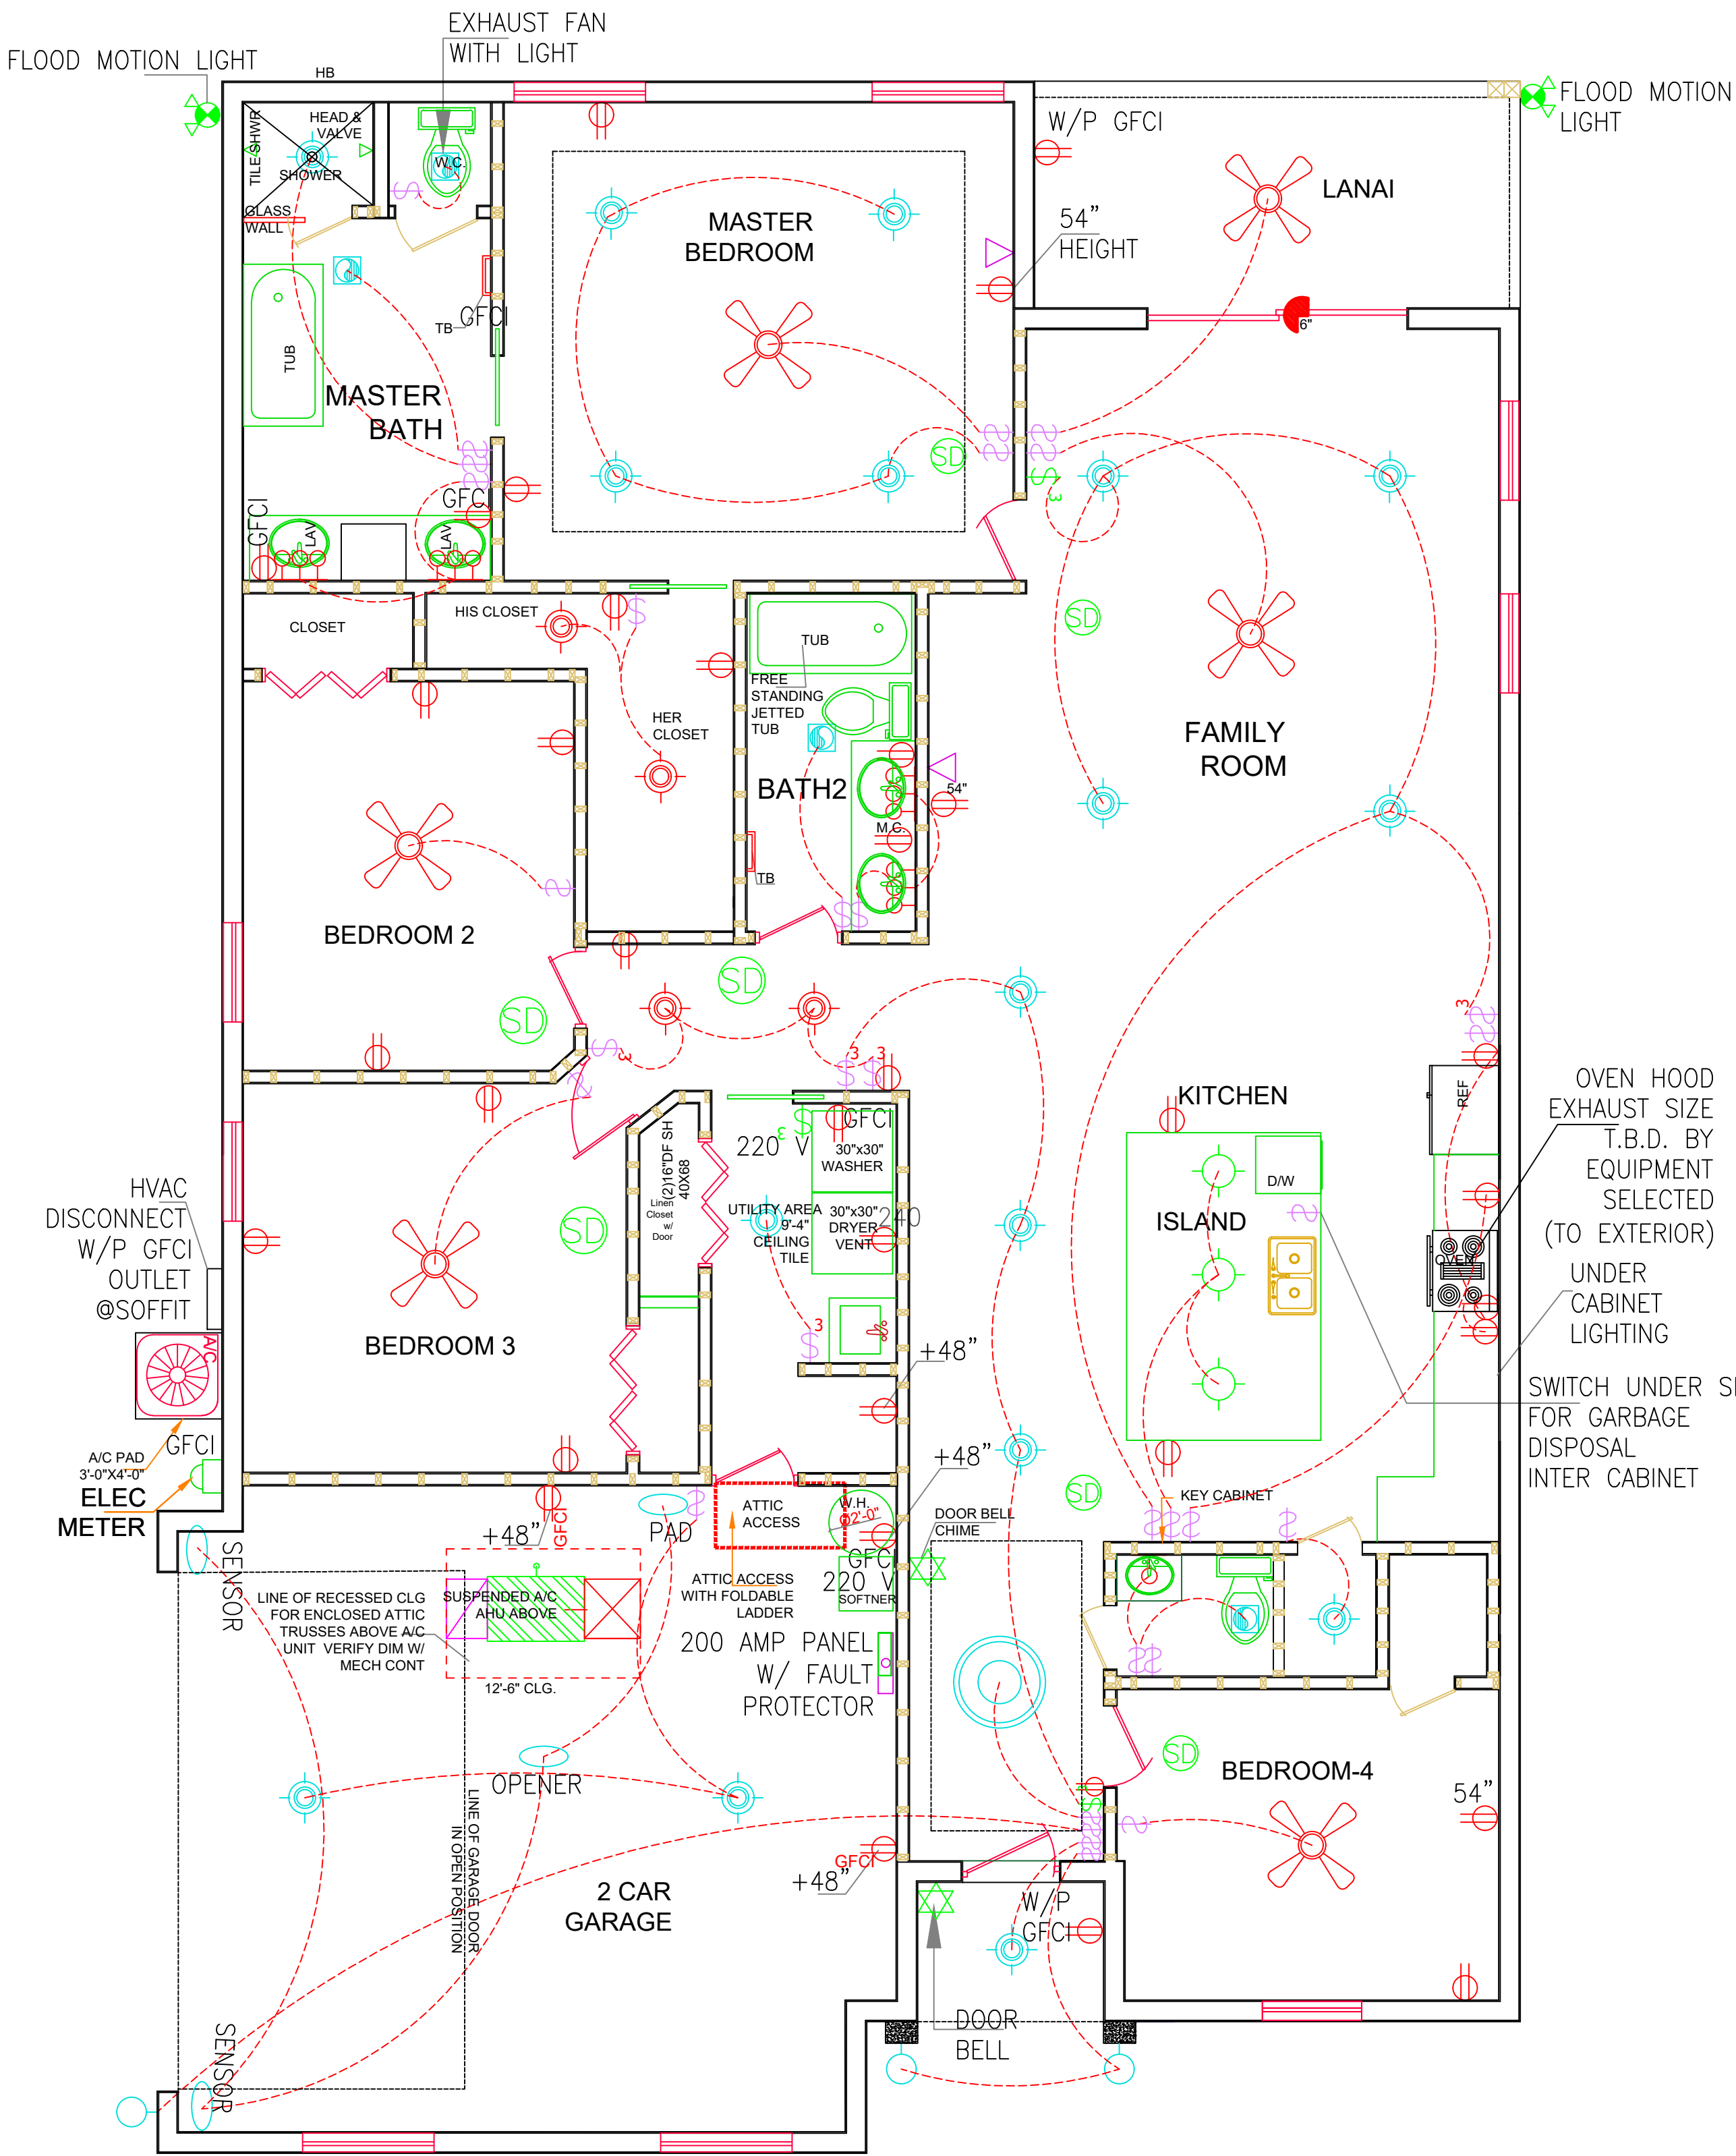



ELECTRICAL SYMBOLS	
CEILING FAN	
SURFACE MOUNTED CEILING FIXTURE	
QUADRUPLEX RECEPTACLE ARC FAULT CIRCUIT INTRUPPTER DUPLEX OUTLET	
ELECTRICAL WIRING	
SMOKE DETECTOR WITH CARBON	
WALL SWITCH	
3-WAY SWITCH (20 AMP RATED) AT 48" A.F.F.	
SWITCH (20 AMP RATED) AT 48" A.F.F.	
EXHAUST FAN (FOR SIZES SEE HVAC PLAN)	
PHONE - I/T (DATACOM)	
WALLPACK SECURITY LIGHTS	
VANITY LIGHT	
EXIT LIGHT	
WALL MOUNTED EMERGENCY FIXTURE	
6" RECESSED CAN LIGHT	
EXHAUST FAN	
DOORBELL CHIME	
DOORBELL	
CEILLING OUTLET	
SCONCE LIGHT	
TV INTERNET	
DUPLEX RECEP.	
GROUND FAULT RECEP	
ELECTRIC METER	

GENERAL ELECTRICAL NOTES

1. FIXTURES AS PER SCHEDULE OR APPROVED EQUAL.
2. FIXTURES SHALL BE COMPLETE WITH LAMPS.
3. THE ELECTRICAL CONTRACTOR SHALL PROVIDE ALL LABOR AND MATERIALS REQUIRED TO CONNECT ELECTRICAL POWER TO ALL MECHANICAL EQUIPMENT.
4. ALL WIRING, CONDUIT, LABOR AND MATERIALS NOT SHOWN ON PLAN, BUT NECESSARY FOR COMPLETE AND PROPER OPERATIONS OF THE ELECTRICAL SYSTEM SHALL BE CONSIDERED AS PART OF THE ELECTRICAL CONTRACTOR'S RESPONSIBILITY.
5. THE ELECTRICAL CONTRACTOR SHALL COORDINATE AND INSTALL ALL CONDUIT REQUIRED FOR THE TELEPHONES.
6. ALL WORK AS PER GENERAL SPECIFICATIONS AND ALL FEDERAL, STATE AND LOCAL CODES.
7. THE ELECTRICAL CONTRACTOR SHALL VISIT THE JOB SITE PRIOR TO SUBMITTING A BID.
8. THE ELECTRICAL CONTRACTOR SHALL PERSONALLY CONTACT THE POWER COMPANY IN ORDER TO VERIFY AND COORDINATE THE INSTALLATION OF THE MAIN ELECTRICAL SERVICE AND TRANSFORMER PLACEMENT TO THE BUILDING.
9. THE ELECTRICAL CONTRACTOR SHALL SUPPLY AND INSTALL ALL FIRE ALARM DEVICES REQUIRED TO SATISFY ALL APPLICABLE CODES & PROVIDE A WORKING SYSTEM. DEVICES SHOWN ON PLANS ARE FOR GUIDELINES ONLY.
10. THE ELECTRICAL CONTRACTOR SHALL PROVIDE A 200 AMP SINGLE PHASE TEMPORARY ELECTRICAL SERVICE AND WEATHER PROOF OUTLETS. COORDINATE LOCATION WITH POWER COMPANY. INCLUDE ALL FEES FOR TEMPORARY SERVICE IN THE BASE BID. REMOVE TEMP SERVICE AFTER MAIN SERVICE BECOMES USABLE.
11. THE ELECTRICAL CONTRACTOR SHALL SUPPLY AND INSTALL TEMPORARY CONSTRUCTION LIGHTING PER O.S.H.A. AND CITY MINIMUM LIGHTING LEVELS IN THE BASE CONTRACT.

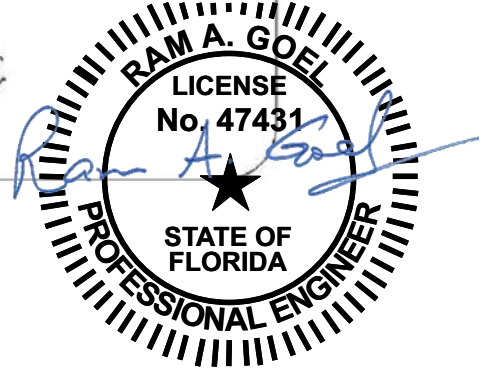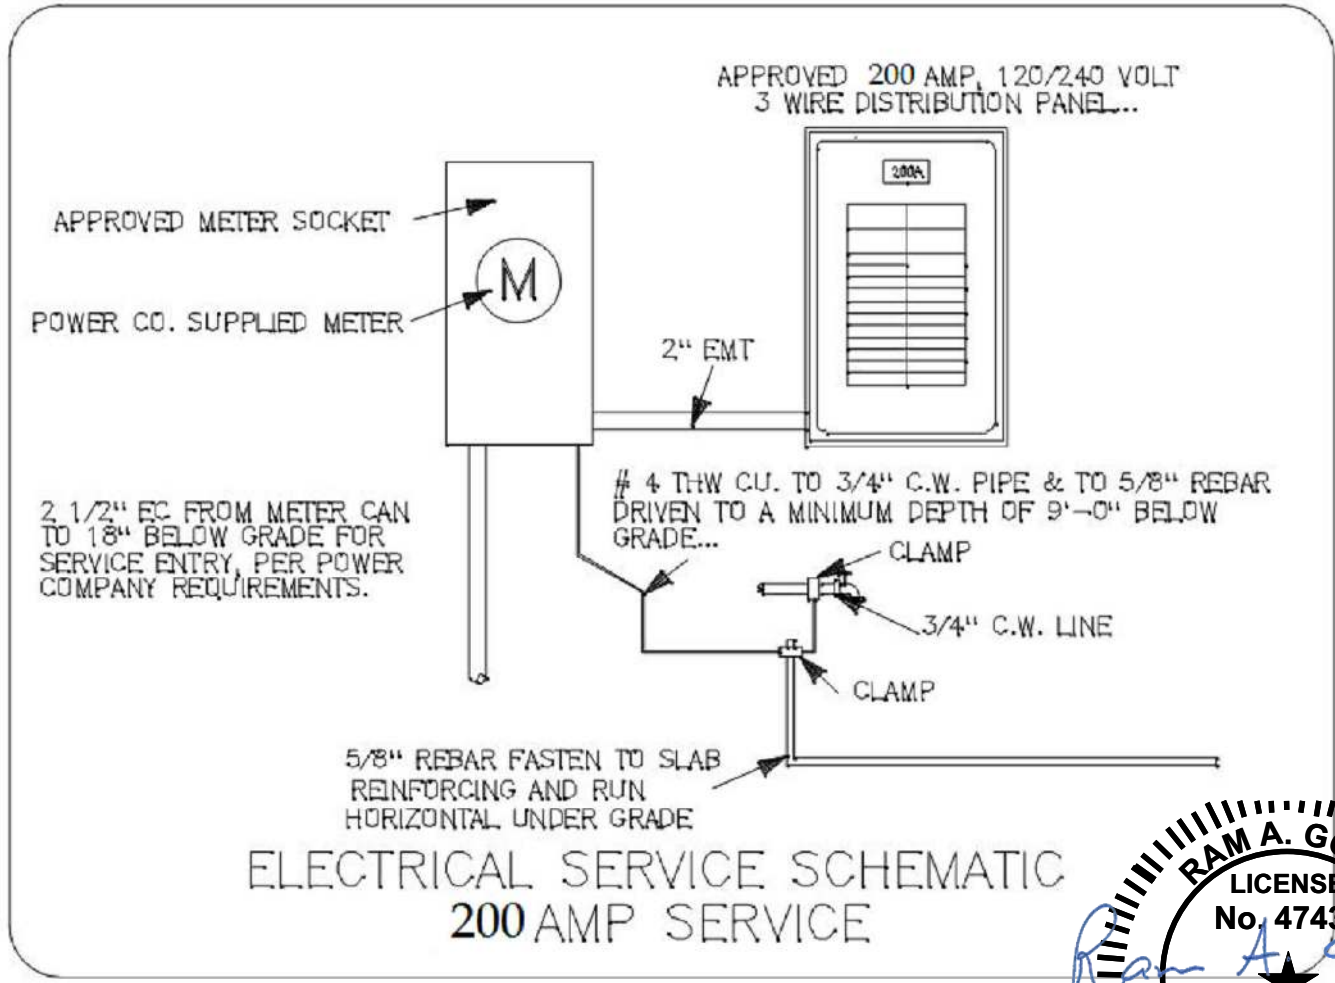


- Notes:
1. This item has been electronically signed & sealed by Ram A. Goel using a Digital signature & date.
 2. Printed copies of this document are not considered signed & sealed. This signature must be verified on any electronic copies.

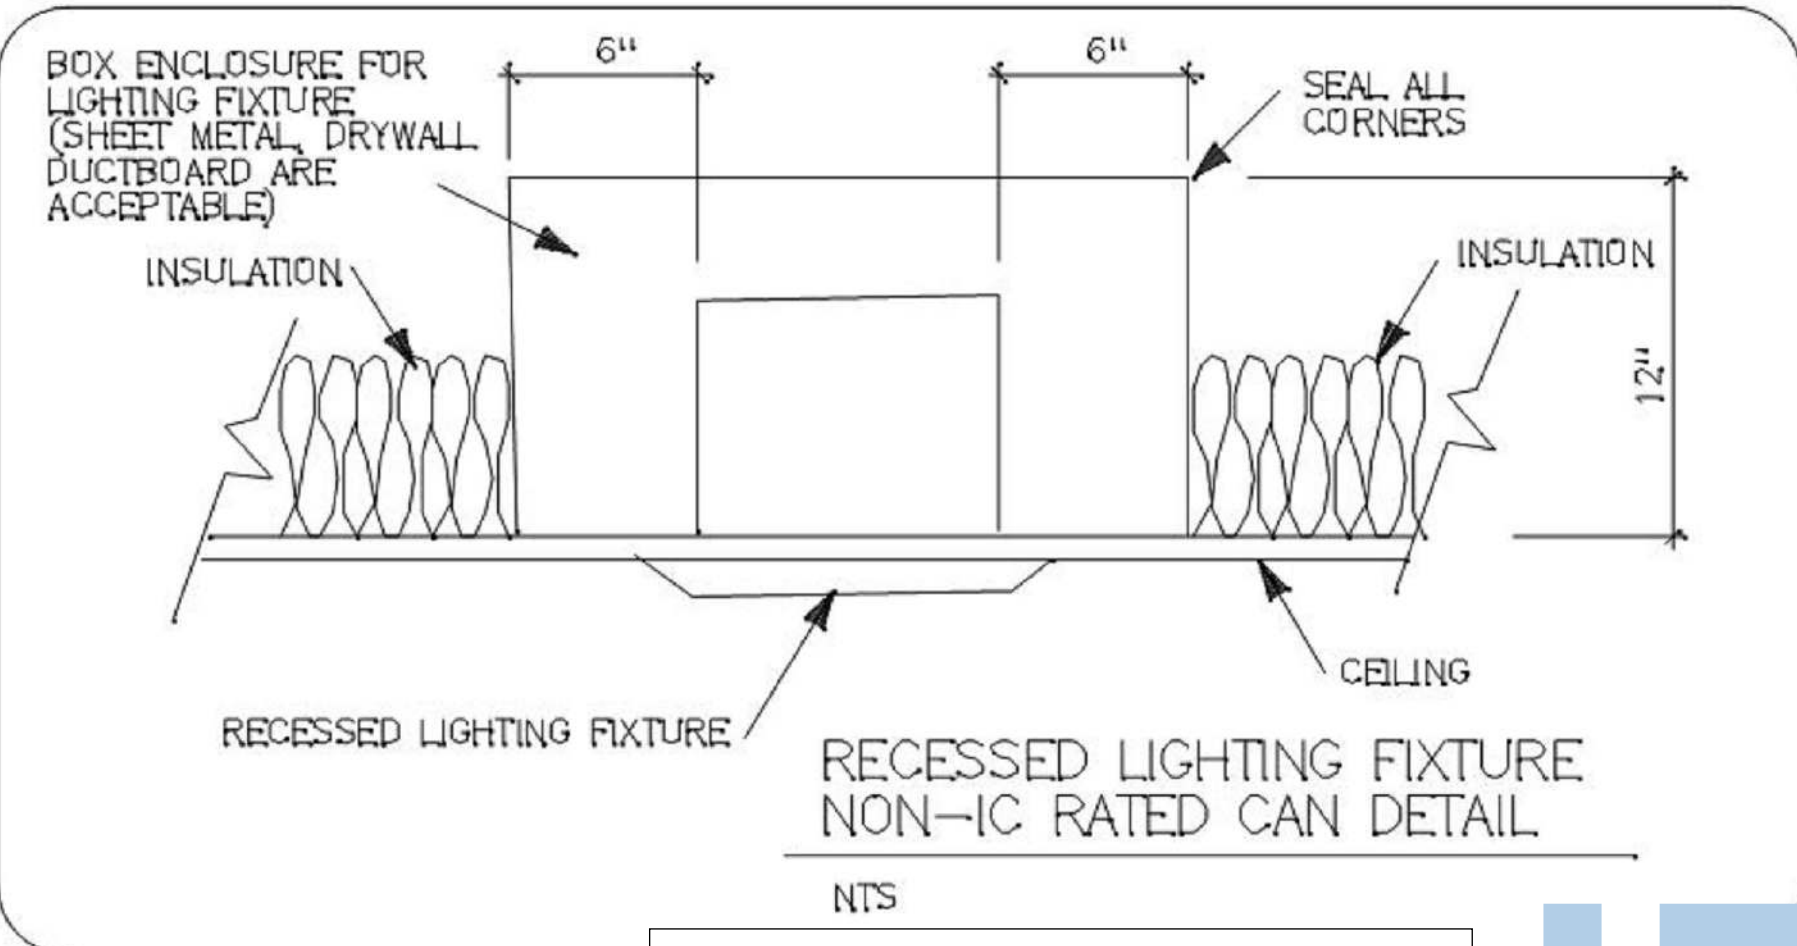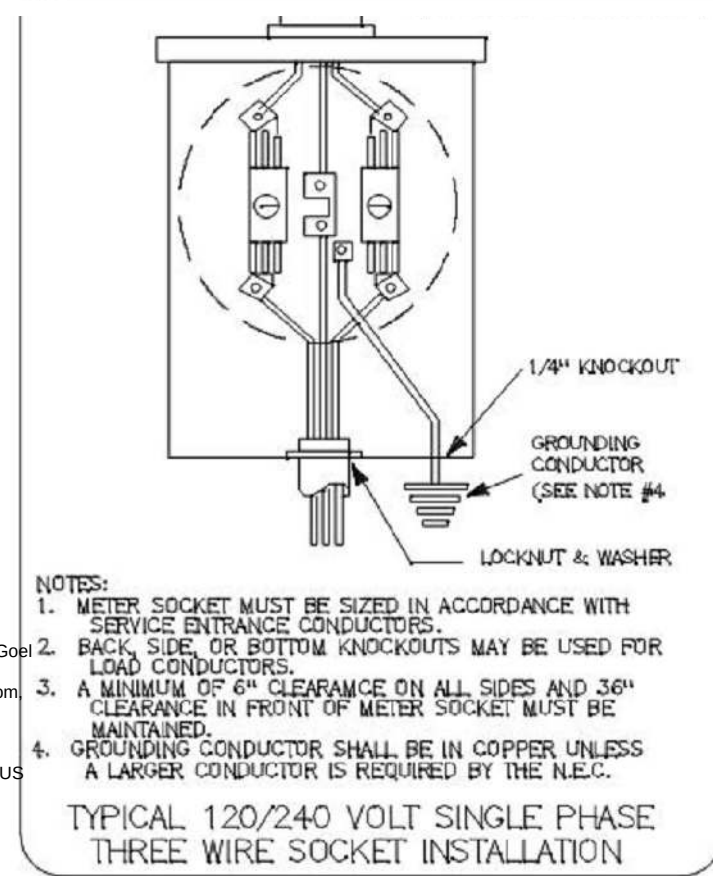

SCHEMATIC ONLY
CONTRACTOR WILL SEEK
SEPARATE PERMIT

Ram Goel
Digitally signed by Ram Goel
DN: cn=Ram Goel, o=SONEY FM LLC, ou=SONEY FM LLC, email=ramgoel@sonyfm.com, c=US
Date: 2022.11.25 13:41:58-0500

10 ELECTRICAL LAYOUT PLAN
Scale: 1/4" = 1'-0"

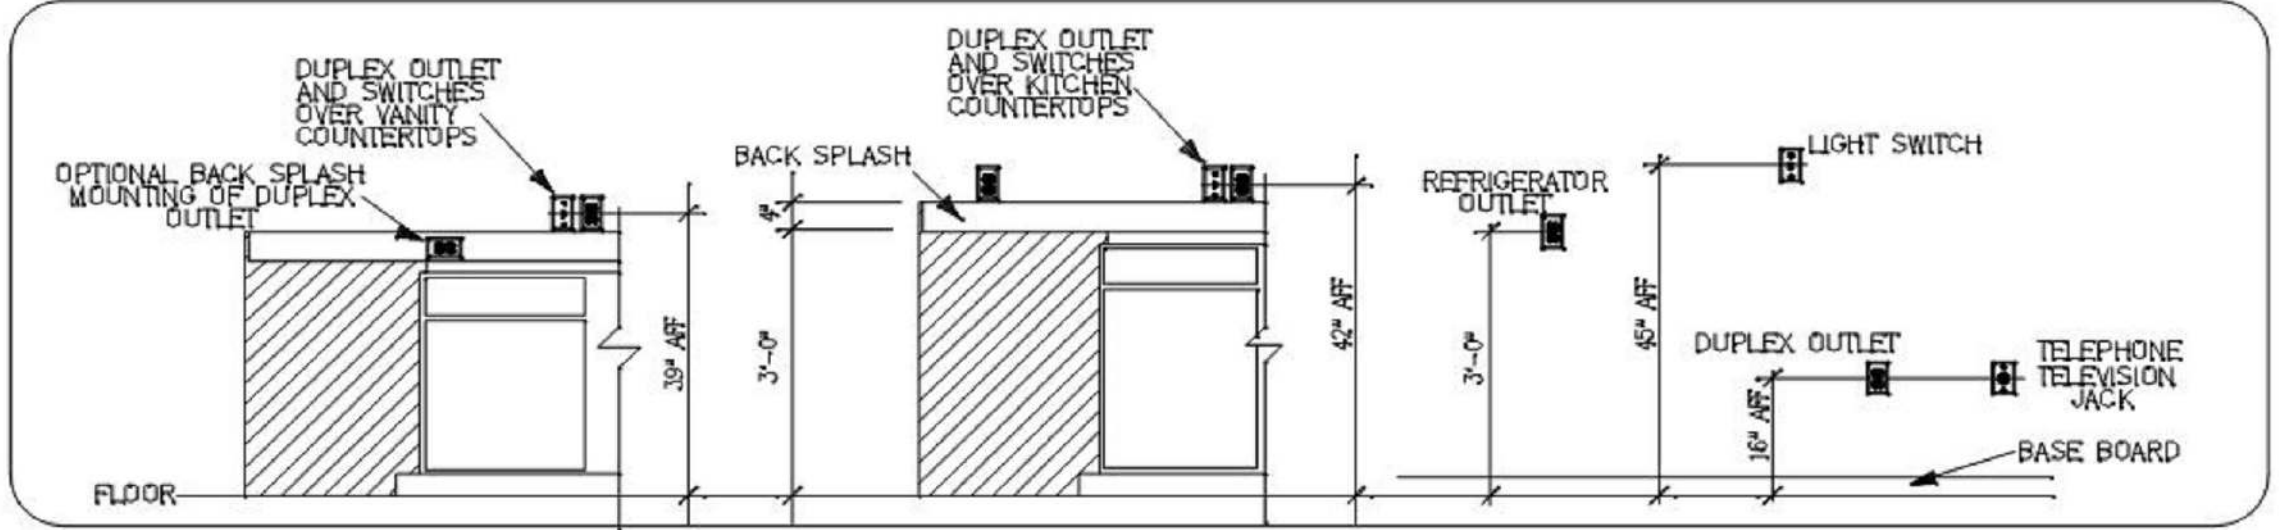

RAM A. GOEL, P.E. # 47431
PH-813-792-1600
SONEY FM LLC
CORY LAKE PROFESSIONAL CENTER
10329 CROSS CREEK BLVD., SUITE P
TAMPA, FL 33647
www.soneyfmllc.com

Job # SG2205
Drawn By: KD
Checked By: S.G.

Issue Date: 11-25-22		
Revisions:		
No.	Date	Description
1	11/25/22	Initial Issue
2		
3		
4		

ELECTRICAL FLOOR PLAN
LINCOLN MODEL III
791 NW SAVANNAH CIR.,
LAKE CITY, FL 32055


E-1

THIS DRAWING IS AN INSTRUMENT OF SERVICE AND SHALL REMAIN THE PROPERTY OF THE ENGINEER, AND SHALL NOT BE REPRODUCED, PUBLISHED OR USED IN ANY WAY WITHOUT THE WRITTEN CONSENT OF THE ENGINEER. COPYRIGHT 2018. NOT PUBLISHED. THIS IS TO CERTIFY THAT I HAVE REVIEWED THIS PLAN AND FOUND IT TO BE IN COMPLIANCE WITH CHAPTER 16 OF 2017 6TH EDITION FLORIDA BUILDING CODE AND APPLICABLE SUPPLEMENTS.

RAM A. GOEL, P.E. # 47431
COPIES OF THESE PLANS ARE NOT VALID UNLESS EMBOSSED WITH THE SIGNING ENGINEER'S SEAL

TO SEPTIC

HOSE BIB
W/SOV & VB.

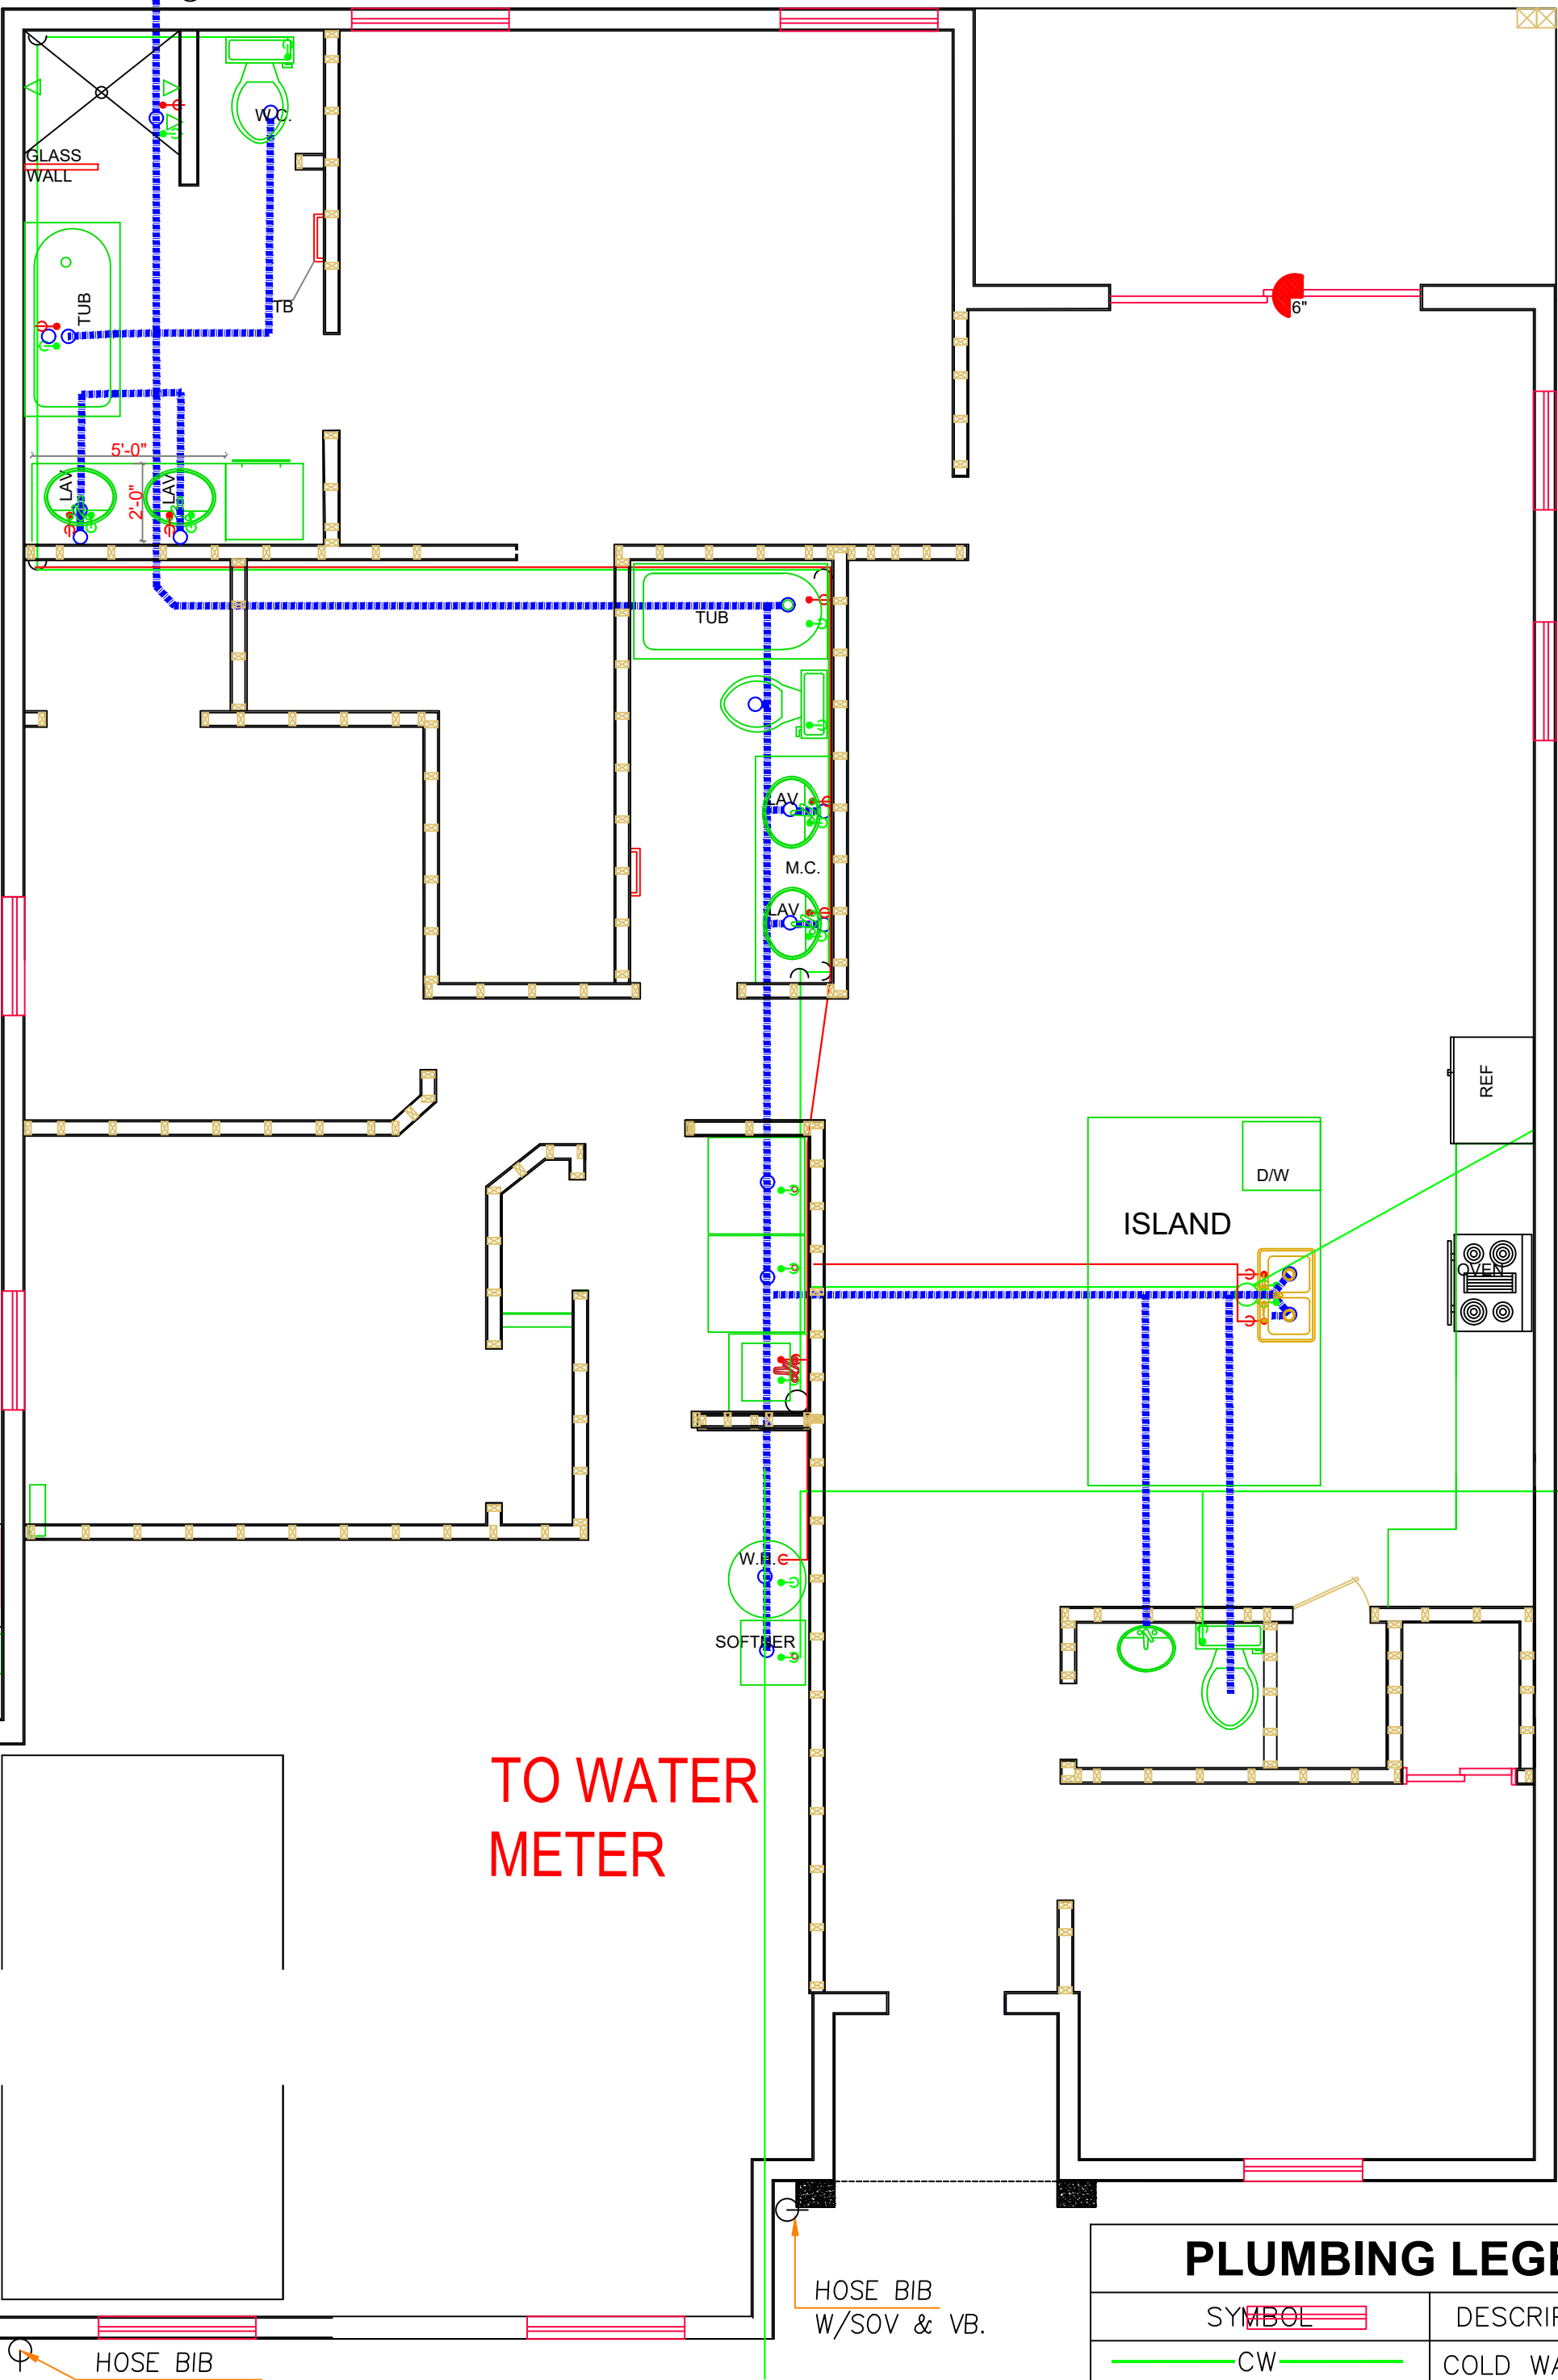

TO WATER
METER

7

PLUMBING PLAN

Scale: 1/4" = 1'-0"

PLUMBING LEGEND

SYMBOL	DESCRIPTION
CW	COLD WATER 1/2"
HW	HOT WATER 1/2"
SS	SANITARY SEWER 2"
HOSE BIB W/SOV & VB.	

PLUMBING FIXTURE SCHEDULE

MARK	QUANTITY	DESCRIPTION	CONNECTION SIZES				MFG. & MODEL NO.
			WASTE	VENT	C.W.	H.W.	
WC	2	TANK TOILET	2"	2"	1/2"		TBD
LAV	4	LAVATORY	2"	-	-	-	TBD
			2"	-	-	-	



COORDINATE FIXTURES WITH OWNER.

TO SEPTIC

TYP. SHOP SANITARY ISOMETRIC


GENERAL PLUMBING NOTES

1. ALL WORK AS PER GENERAL SPECIFICATIONS AND ALL FEDERAL, STATE AND LOCAL CODES, FPC 2017, 6TH EDITION.
2. FOR HOT AND COLD WATER APPLICATIONS TYPE L COPPER SHALL BE USED OR PEX AS ALLOWED BELOW.
3. CROSSLINKED POLYETHYLENE (PEX) PIPING MAY BE SUBSTITUTED FOR COPPER GIVEN THE FOLLOWING SPECIFICATIONS. USE ON COLD WATER AND HOT WATER APPLICATIONS NOT TO EXCEED 140 DEGREES F. ZURN OR EQUAL PIPE AND FITTINGS SHALL BE USED. THE FOLLOWING STANDARDS SHALL BE ADHERED TO: ASTM F876 FOR THE PIPE, ASTM F1807 BRASS FITTINGS MUST BE USED. DO NOT HYPERCLORATE THE SYSTEM IN EXCESS OF 5 PPM OR AS ALLOWED BY MANUFACTURER. DO NOT STORE PEX IN DIRECT SUNLIGHT. DO NOT BUY PEX FROM ANY WAREHOUSE KEEPING PEX STORED OUTSIDE. DO NOT INSTALL ANY PEX PIPING THAT HAS BEEN EXPOSED TO SUNLIGHT LONG ENOUGH FOR THE LABELING TO FADE. PEX THAT IS TO BE EXPOSED IN OPEN SLAB APPLICATIONS FOR LONGER THAN ONE WEEK SHALL BE WRAPPED IN ALUMINIZED TAPE TO PROTECT AGAINST UV DEGRADATION.
4. ALL FIXTURES USED SHALL BE AS PER SCHEDULE OR EQUAL.
5. ALL FIXTURES SHALL HAVE STOP VALVES AT WALL.
6. ALL VENTS SHALL BE CARRIED THROUGH ROOF, COMPLETE WITH ROOF SYSTEM COMPATIBLE ROOF JACKS.
7. ALL TOILET SEATS SHALL BE FOR ELONGATED BOWLS WITH OPEN FRONTS.
8. TO FACILITATE THE CLARITY OF THE DRAWINGS, SEWER, WATER, AND GAS LINES ARE NOT ALWAYS SHOWN IN THEIR EXACT LOCATIONS.
9. CONTRACTOR SHALL VISIT JOB SITE PRIOR TO BID AND VERIFY NEWCONDITIONS. NOTIFY ENGINEER IF NEWCONDITIONS DO NOT MATCH CONTRACT DOCUMENTS.
10. PROVIDE WETTED TRAPS TO ALL FLOOR DRAINS.
11. ROUTE TEMPERATURE AND PRESSURE RELIEF FROM WATER HEATER TO SEWER OR TO THE OUTSIDE OF BUILDING.

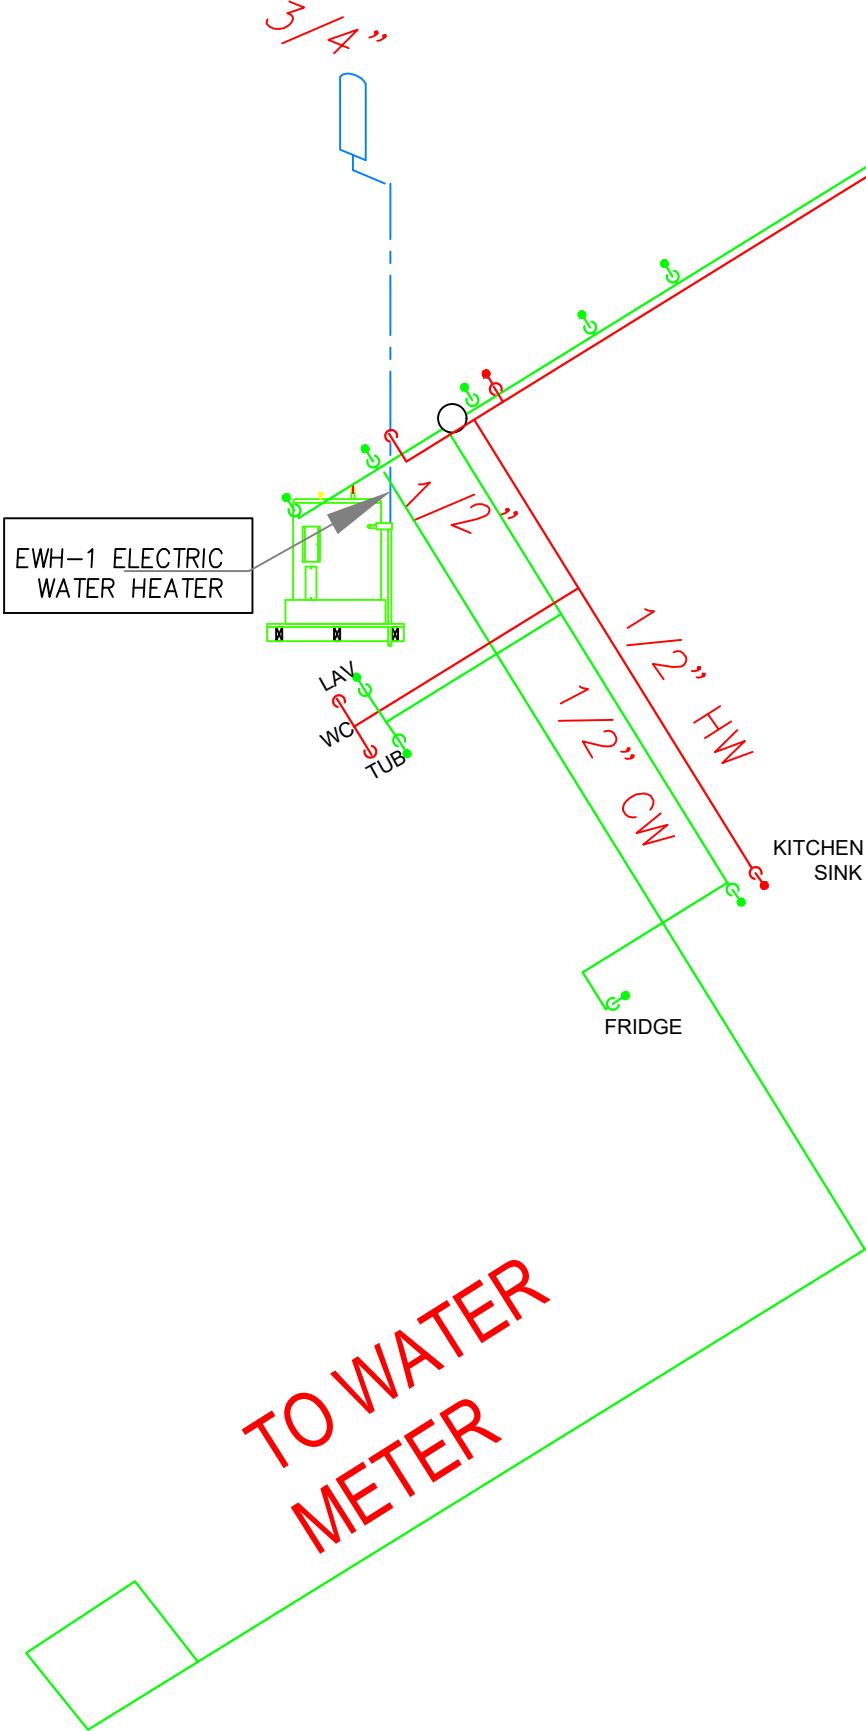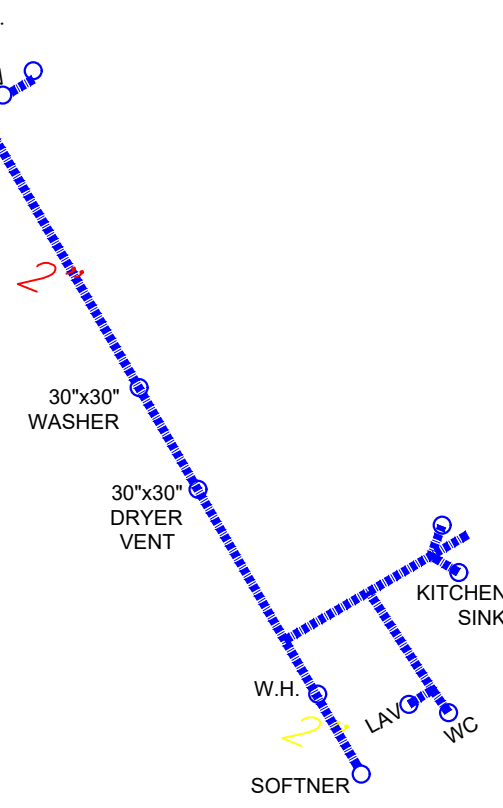

TYP. SHOP WATER ISOMETRIC

DRAWING SCALE: NTS

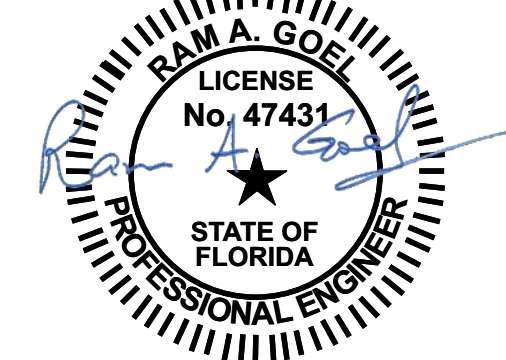

Notes:

1. This item has been electronically signed & sealed by Ram A. Goel using a Digital signature & date.
2. Printed copies of this document are not considered signed & sealed. This signature must be verified on any electronic copies.

SCHEMATIC ONLY
CONTRACTOR WILL SEEK
SEPARATE PERMIT



RAM A. GOEL, P.E. # 47431
PH-813-792-1600
SONEY FM LLC
CORY LAKE PROFESSIONAL CENTER
10329 CROSS CREEK BLVD., SUITE P
TAMPA, FL 33647
www.soneyfmllc.com

Job # SG2205
Drawn By: KD
Checked By: S.G.

Issue Date: 11-25-22		
Revisions:		
No.	Date	Description
1	11/25/22	Initial
2	11/25/22	Initial
3	11/25/22	Initial


PLUMBING LAYOUT PLAN

LINCOLN MODEL III
791 NW SAVANNAH CIR.,
LAKE CITY, FL 32055

P-1

THIS DRAWING IS AN INSTRUMENT OF SERVICE AND SHALL REMAIN THE PROPERTY OF THE ENGINEER, AND SHALL NOT BE REPRODUCED, PUBLISHED OR USED IN ANY WAY WITHOUT THE WRITTEN CONSENT OF THE ENGINEER. COPYRIGHT 2018. NOT PUBLISHED THIS IS TO CERTIFY THAT I HAVE REVIEWED THIS PLAN AND FOUND TO BE IN COMPLIANCE WITH CHAPTER 16 OF 2020 7TH EDITION FLORIDA BUILDING CODE AND APPLICABLE SUPPLEMENTS.

RAM A. GOEL, P.E. # 47431
COPIES OF THESE PLANS ARE NOT VALID UNLESS EMBOSSED WITH THE SIGNING ENGINEER'S SEAL

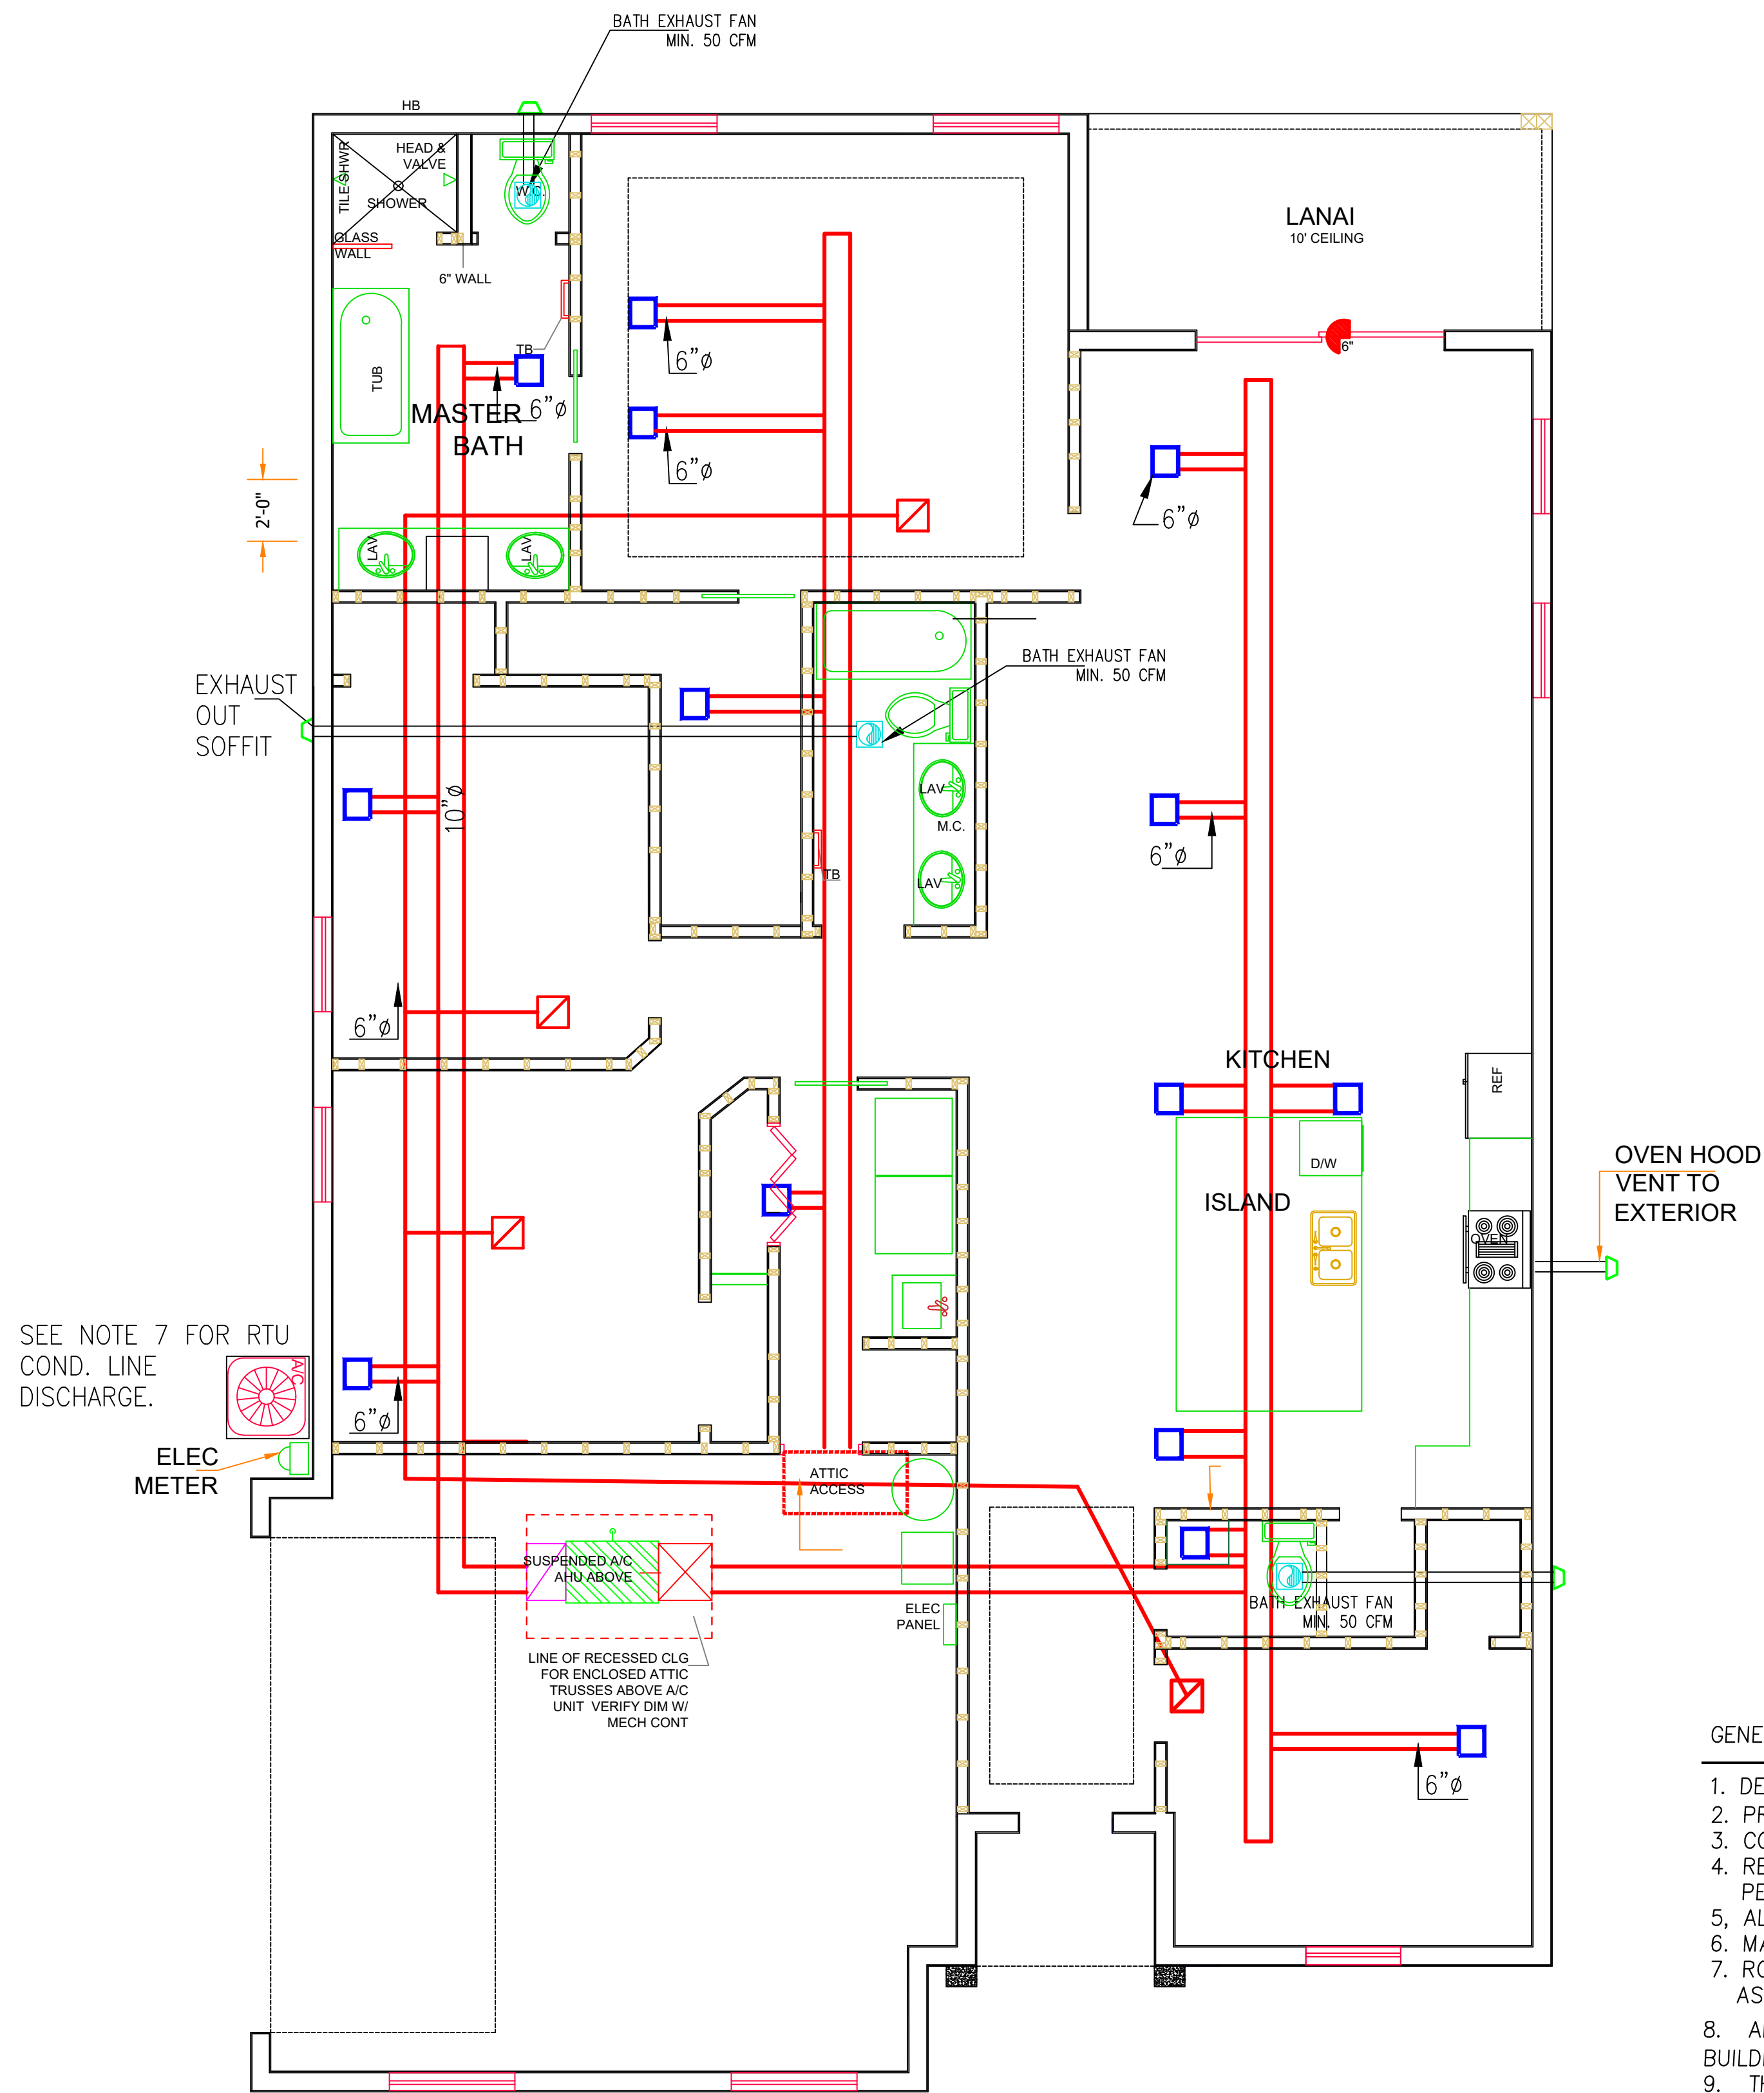


NOTE; ALL EXHAUST FANS EXIT TO ROOF

15

HVAC LAYOUT PLAN ISO

Scale: 1/4" =1'-0"

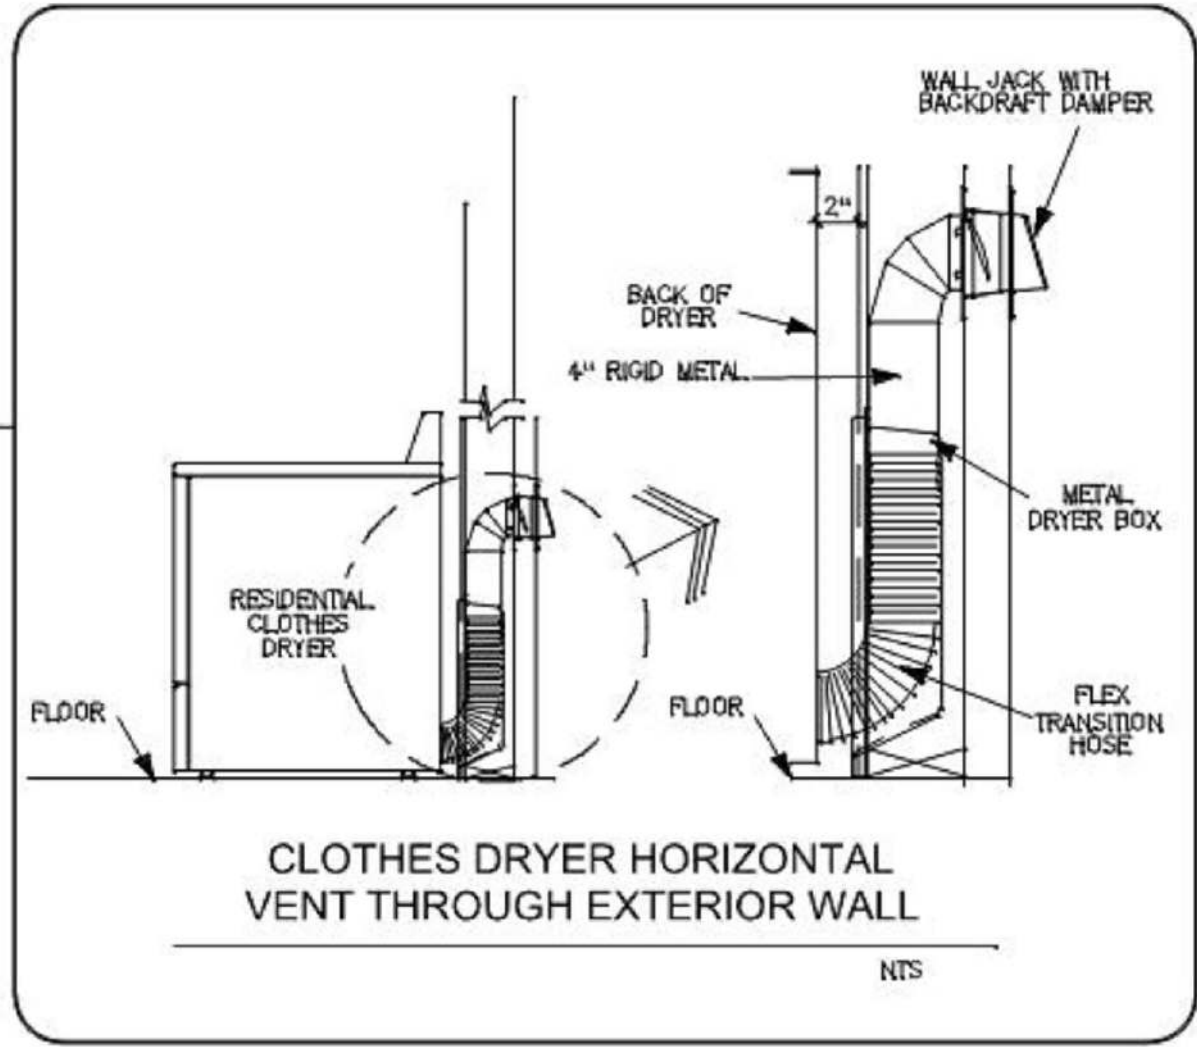

ALL PENETRATIONS (DUCT/PIPES/LIGHT FIXTURES/HVAC DIFFUSERS) SHALL BE PROTECTED AT ALL FIRE RATED WALLS AND FLOOR CEILING ASSEMBLIES.

EXHAUST FAN SCHEDULE									
MARK	TYPE	CFM	ESP	FAN WATTS	DUCT	SONES	VOLT/PH	AMPS	LOCATION
EF-1	EXHAUST	65	0.25"	26.1	4"	2.0	120/1	0.3	TOILET/RR
EF-2	EXHAUST	50	0.25"	17.5	4"	1.5	120/1	0.2	TOILET/RR
EF	EXHAUST	50	0.25"	17.5	4"	1.5	120/1	0.2	TOILET/RR

1. SCHEMATIC ONLY
2. MECHANICAL CONTRACTOR TO GET THEIR OWN SHOP DRAWINGS & PERMIT

MECHANICAL LEGEND


- SUPPLY AIR DIFFUSER
- RETURN AIR DIFFUSER

GENERAL NOTES:

1. DESIGN TO MEET FLORIDA BUILDING MECHANICAL CODE 2017 ASHRAE, ASME, ANSI CODES.
2. PROVIDE 1" UNDERCUT ON ALL INTERIOR DOORS.
3. COORDINATE EXACT LOCATION OF DIFFUSERS WITH ARCHITECTURAL & REFLECTIVE CEILING PLANS.
4. REST ROOMS EXHAUST WALL CAP TO BE PROVIDED WITH A CORROSION RESISTANT SCREEN AS PER FBCM.
5. ALL ROOF MOUNTED EQUIPMENT SHALL BE INSTALLED TO WITHSTAND HURRICANE FORCE WINDS.
6. MAINTAIN A MINIMUM OF 10 FT SEPARATION BETWEEN ANY AIR INTAKE AND EXHAUST DISCHARGE.
7. ROUTE CONDENSATE DRAIN, FULL SIZE TO NEAREST ROOF DRAIN. PROVIDE PIPING SUPPORT AS REQUIRED BY THE CODE. PROVIDE SECONDARY AUTOMATIC OVERFLOW FLOAT SWITCH.
8. ALL CONSTRUCTION/MATERIALS BY THE CONTRACTOR SHALL CONFORM TO THE 2017 FLORIDA BUILDING/ MECHANICAL CODE.
9. THE CONTRACTOR SHALL BALANCE THE SYSTEM TO WITHIN PLUS 10% OR MINUS 5% OF LISTED CFM VALUES. PROVIDE STANDARD FORMS TO DOCUMENT AIR PERFORMANCE., STATIC PRESSURE, ETC.

SCHEMATIC ONLY
CONTRACTOR WILL SEEK
SEPARATE PERMIT

Ram Goel

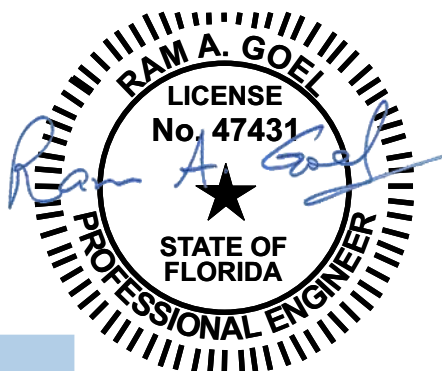

M1305.1.3 Appliances in attics. Attics containing appliances requiring access shall be provided with an opening and unobstructed passageway large enough to allow removal of the largest appliance. The passageway shall not be less than 30 inches (762 mm) high and 22 inches (559 mm) wide and not more than 6 feet (1829 mm) in length measured along the centerline of the passageway from the attic access opening to the appliance's service panel. The passageway shall have continuous solid flooring not less than 24 inches (610 mm) wide. A level service space not less than 30 inches (762 mm) deep and 30 inches (762 mm) wide shall be present at the front or service side of the appliance. The clear access opening dimensions shall be a minimum of 20 inches by 30 inches (508 mm by 762 mm), where such dimensions are large enough to allow removal of the largest appliance.

Exception: The passageway and level service space are not required where the appliance is capable of being serviced and removed through the required opening. M1305.1.3.1 Electrical requirements. A luminaire controlled by a switch located at the required passageway opening and a receptacle outlet shall be installed at or near the appliance location in accordance with Chapter 33.

M1305.1.3.2 Air-handling units. Air-handling units shall be allowed in attics if the following conditions are met: 1. The service panel of the equipment is located within 6 feet (1829 mm) of an attic access. 2. A device is installed to alert the owner or shut the unit down when the condensation drain is not working properly.

3. The attic access opening is of sufficient size to replace the air handler. 4. A notice is posted on the electric service panel indicating to the homeowner that the air handler is located in the attic. Said notice shall be in all capitals, in 16 point type, with the title and first paragraph in bold: NOTICE TO OWNER

A PART OF YOUR AIR CONDITIONING SYSTEM, THE AIR HANDLER, IS LOCATED IN THE ROOF.

FOR PROPER, EFFICIENT, AND ECONOMIC OPERATION OF THE AIR CONDITIONING SYSTEM, YOU MUST ENSURE THAT REGULAR MAINTENANCE IS PERFORMED. YOUR AIR CONDITIONING SYSTEM IS EQUIPPED WITH ONE OR BOTH OF THE FOLLOWING:

- 1) A DEVICE THAT WILL ALERT YOU WHEN THE CONDENSATION DRAIN IS NOT WORKING PROPERLY OR
- 2) A DEVICE THAT WILL SHUT THE SYSTEM DOWN WHEN THE CONDENSATION DRAIN IS NOT WORKING. TO LIMIT POTENTIAL DAMAGE TO YOUR HOME, AND TO AVOID DISRUPTION OF SERVICE, IT IS RECOMMENDED THAT YOU ENSURE PROPER WORKING ORDER OF THESE DEVICES BEFORE EACH SEASON OF PEAK OPERATION.

Notes:

1. This item has been electronically signed & sealed by RAM A. GOEL using a Digital signature & date.
2. Printed copies of this document are not considered signed & sealed. This signature must be verified on any electronic copies.

THIS DRAWING IS AN INSTRUMENT OF SERVICE AND SHALL REMAIN THE PROPERTY OF THE ENGINEER, AND SHALL NOT BE REPRODUCED, PUBLISHED OR USED IN ANY WAY WITHOUT THE WRITTEN CONSENT OF THE ENGINEER. COPYRIGHT 2016. NOT PUBLISHED. THIS IS TO CERTIFY THAT I HAVE REVIEWED THIS PLAN AND FOUND IT TO BE IN COMPLIANCE WITH CHAPTER 16 OF 2020 7TH EDITION FLORIDA BUILDING CODE AND APPLICABLE SUPPLEMENTS.

RAM A. GOEL, P.E. # 47431

COPIES OF THESE PLANS ARE NOT VALID UNLESS EMBOSSED WITH THE SIGNING ENGINEER'S SEAL

RAM A. GOEL, P.E. # 47431

PH: 813-792-1600

SONEY FM LLC
CORY LAKE PROFESSIONAL CENTER
10329 CROSS CREEK BLVD., SUITE P
TAMPA, FL 33647
www.soneyfmllc.com

Job # SG2205

Drawn By: K.D.

Checked By: S.G.

Issue Date: 11-25-22

Revisions:

No.	Date	Description
Δ	//	
Δ	//	
Δ	//	
Δ	//	

HVAC LAYOUT

LINCOLN MODEL III
791 NW SAVANNAH CIR.,
LAKE CITY, FL 32055

H-1