

GENERAL NOTES:

IT IS SOLELY THE CONTRACTOR'S RESPONSIBILITY TO FOLLOW ALL APPLICABLE SAFETY CODES AND REGULATIONS DURING ALL PHASES OF CONSTRUCTION.

SHOULD ANY OF THE DETAILED INSTRUCTIONS SHOWN ON THE PLANS CONFLICT WITH THE GENERAL STRUCTURAL NOTES, THE SPECIFICATION OR WITH EACH OTHER, THE STRICTEST PROVISION SHALL GOVERN.

THE GENERAL CONTRACTOR SHALL BE RESPONSIBLE FOR VERIFYING ALL DIMENSIONS AND ELEVATIONS SHOWN ON THE PLANS AND FOR COORDINATING ALL DIMENSIONS AND ELEVATIONS SHOWN ON THE FOUNDATION PLAN WITH THOSE SHOWN ON THE METAL BUILDING PLANS OR OTHER PLANS.

IF DISCREPANCIES OCCUR, IT SHALL BE THE CONTRACTOR'S RESPONSIBILITY TO BRING THE DISCREPANCY TO THE ATTENTION OF THE FOUNDATION ENGINEER BEFORE PROCEEDING WITH THE WORK.

MATERIAL SPECIFICATIONS:

MINIMUM 28-DAY CONCRETE STRENGTHS: SUBMIT MIX DESIGN
FOOTING: 3000 PSI
SLAB ON GRADE: 3500 PSI
(DURABILITY REQUIREMENTS MAY CONTROL MIX DESIGN: MAX SLUMP = 3" TO 4")
ALL REINFORCING STEEL SHALL BE ASTM A615 GRADE 60.
ALL ANCHOR BOLT SHALL BE F1554-36 K31 HEX HEAD.

CONCRETE NOTES:

ALL CONCRETE WORK SHALL CONFORM TO THE BUILDING CODE REQUIREMENTS FOR REINFORCED CONCRETE (ACI 318) AND SPECIFICATIONS FOR STRUCTURAL CONCRETE FOR BUILDINGS (ACI 301) OF THE AMERICAN CONCRETE INSTITUTE.

PROVIDE AT LEAST ONE COPY OF THE ACI FIELD REFERENCE MANUAL, SP-15, IN THE FIELD OFFICE AT ALL TIMES.

ALL REINFORCING STEEL SHALL BE ASTM A615 GRADE 60.

COORDINATE CONCRETE WORK WITH ARCHITECTURAL DRAWINGS AND SPECIFICATIONS FOR ARCHITECTURE, FINISHED CONCRETE, RECESSED AREAS, EMBEDDED ITEMS, AND SPECIAL CONTROL JOINTS.

PROVIDE THE FOLLOWING MINIMUM CLEAR COVER FOR REINFORCING STEEL FROM SURFACE OF CONCRETE:

-FOR CONCRETE CAST AGAINST AND PERMANENTLY EXPOSED TO EARTH: 3" IN GENERAL

-FOR CONCRETE SURFACE EXPOSED TO THE WEATHER OR AGAINST WHICH BACKFILL WILL BE PLACED: 2" FOR #5 BARS AND LARGER

-FOR SURFACES OTHER THAN ABOVE: 1-1/2" FOR COLUMN SPIRALS OR TIES, OR STRUPTUPS

3/4" FOR SLABS AND FOR STRUPTUPS IN PLAN JOINTS

TOLERANCES FOR BAR COVER ARE +/- 3/8 INCH FOR CONCRETE HAVING A THICKNESS OF 8 INCHES OR LESS AND +/- 1/2 INCH FOR CONCRETE HAVING A THICKNESS GREATER THAN 8 INCHES. TOLERANCE FOR LONGITUDINAL LOCATION OF BONDS AND ENDS OF REINFORCEMENT SHALL BE +/- 2 INCHES EXCEPT AT DISCONTINUOUS ENDS OF MEMBERS WHERE THE TOLERANCE SHALL BE +/- INCH. TOLERANCE FOR BAR SPACING IS +/- 2 INCHES. TOLERANCE FOR LENGTH OF LAP SPACE IS +/- 1 INCH, AND TOLERANCE FOR EMBEDDED LENGTH IS +/- 1 INCH.

SOIL NOTES:

ALL ORGANICS (99%) SHALL BE REMOVED FROM THE BUILDING PAD AREA. THE SITE SHALL BE CLEARED AND GRUBBED. IF STRUCTURAL FILL IS REQUIRED FOR THE SITE, IT SHALL BE PLACED IN LIFTS NO GREATER THAN 6" BEFORE COMPACTION TAKES PLACE. SOIL DENSITIES BENEATH ALL FOOTINGS AND SLABS MUST ACHIEVE (90%) STANDARD PROCTOR UNLESS DIRECTED OTHERWISE BY THE GEOTECHNICAL ENGINEER. SOIL BEARING CAPACITIES CAN BE VERIFIED USING A DYNAMIC CONE PENETROMETER OR SIMILAR MEANS. A UNIFORM AND WELL COMPACTED BASE & SUBGRADE IS ESSENTIAL FOR PROPER SLAB PERFORMANCE.

PROOF ROLLING WITH A LOADED TANDUM AXLE DUMP TRUCK OR CONCRETE MIX TRUCK IN A GRID PATTERN SHOULD BE PERFORMED IN THE BUILDING PAD AREA. PROOF ROLLING SHOULD BE PERFORMED AS LIFTS ARE BEING MADE. IF PUMPING OR LIFTING IS OBSERVED, REPAIRS MUST BE MADE. ANY DEPRESSIONS GREATER THAN 1/2 INCH REQUIRE REPAIR.

A 4"-6" COMPACTED GRANULAR FILL SHALL BE PLACED BENEATH THE SLAB WITH A MIN 8 MIL VAPOR BARRIER PLACED DIRECTLY BENEATH THE SLAB UNLESS DIRECTED OTHERWISE BY THE GEOTECHNICAL ENGINEER.


THE NET ALLOWABLE BEARING CAPACITY OF THE SOIL USED IN DESIGN OF THE FOUNDATION IS 2000 PSF. THE CONTRACTOR IS RESPONSIBLE FOR ENSURING THAT THE SOILS COMPLY WITH THESE ASSUMPTIONS BEFORE ANY CONCRETE IS POURED. NO GEOTECHNICAL REPORT WAS AVAILABLE WHEN THIS FOUNDATION PLAN WAS PREPARED.

COORDINATE ALL SAW JOINTS WITH ARCHITECTURAL, MECHANICAL, AND PLUMBING PLANS. SAW JOINT LOCATIONS ARE SUGGESTED. SAW JOINTS SHOULD BE APPROXIMATELY SQUARE, IF POSSIBLE. IF NOT, TRY TO LIMIT THE LONGEST SIDE TO 1.5 TIMES THE SHORTEST SIDE. THE FOUNDATION ENGINEER DOES NOT HAVE SPECIFIC KNOWLEDGE OF ANY SPECIFIC SLAB LOADINGS. IT IS ASSUMED THAT SLAB LOADINGS WILL BE LIGHT IN NATURE SUCH AS FOR LIGHT COMMERCIAL/RESIDENTIAL FACILITIES. SEE JOINT DETAIL SHEET 0.2.

Wayne Brad Baker PE 235 Sanders Road Marietta, GA 30067

Wayne Brad Baker State of Florida, Professional Engineer, License No. 18822. This form has been digitally signed and sealed by Wayne Brad Baker, PE on the date shown here using a Digital Signature. Printed copies of this document are not considered signed and sealed and the S&B authentication code must be verified on any electronic copies.

Digitally signed
by Wayne B Baker
Date: 2023.04.25
14:03:25 -04'00'

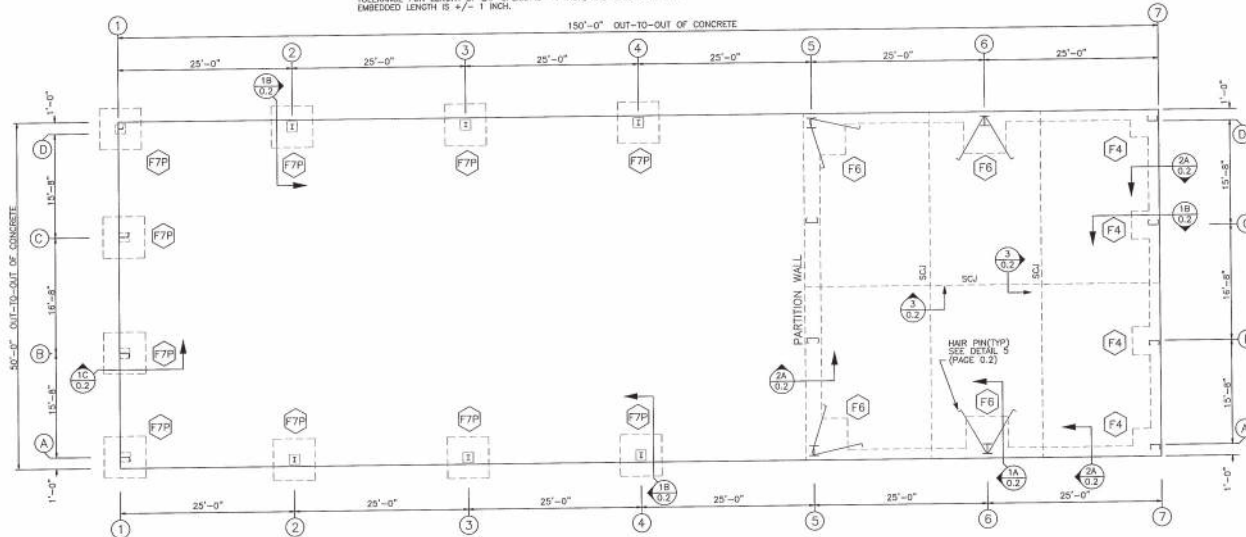

FOUNDATION PLAN LAYOUT
NOTE: All Base Plates @ 100'-0" (Unless Noted)

REFERENCE ELEVATION IS ASSUMED TO BE 100.0 FT AT THE TOP CORNERS OF THE SLAB. EXACT FINISHED FLOOR ELEVATION (XX.XX) SHALL BE DETERMINED BY CIVIL (SITE) ENGINEER.

FOOTING SCHEDULE

MARK #	SIZE (L x W x T)	TOP REINF.	BOTTOM REINF.	T.O.F. ELEV.
F4	4'-0"x4'-0"x2'-0"	(5) #6's E.W.	(5) #6's E.W.	PER CIVIL
F6	6'-0"x6'-0"x2'-0"	(7) #6's E.W. (1) #8's E.W.	(7) #6's E.W. (1) #8's E.W.	PER CIVIL




FOOTING SCHEDULE

MARK #	SIZE (L x W x T)	PIER (L x W x H)	TOP REINF.	BOTTOM REINF.	T.O.F. ELEV.
F7P	7'-0"x7'-0"x2'-0"	1'-6"x1'-6"x2'-0"	(8) #6's E.W.	(8) #6's E.W.	PER CIVIL



COORDINATE THE FOUNDATION PLAN WITH THE SPECIFIC ANCHOR BOLT LAYOUT PLAN PROVIDED BY THE MBM.

ALL SLABS = 8" CONCRETE SLAB PER CUSTOMER WITH 60-MIL VAPOR BARRIER PER GEOTECHNICAL ENGINEER AND CHAIRS AT 3'-0" O.C. MAXIMUM IN ALL DIRECTIONS. VAPOR BARRIER PER GEOTECHNICAL ENGINEER. RECOMMENDATIONS REFER TO THE GEOTECHNICAL REPORT FOR COMPACTION REQUIREMENTS AND SHEET 0.2. ALL UTILITIES, SLOPED SLABS, STEPPED FOOTINGS, RECESSED AREAS, BURRED ITEMS, AND THE COORDINATION OF SUCH ITEMS IN CONNECTION WITH THIS SLAB PLAN ARE THE RESPONSIBILITY OF THE CONTRACTOR.




ISSUE	DET	CHK	DATE
BUILDINGS AND MORE			
CONTRACTOR: F TRAFFIC OPS BUILDINGS			
JOB NO:	7966	DATE:	4/11/23
LOCATION:	LAKE CITY, FL 32055		
DRAWN BY:	FOUNDATION PLAN LAYOUT		
ISSUED BY:	PAGE 0.1	SCALE:	WITH
CHECKED BY:	WBB	DATE:	NONE

   

ISSUE	BCT	CHK	DATE
BUILDINGS AND MORE			
LOCATION:			
F TRAFFIC OPS BUILDINGS			DATE
JOB NO. 7966			4/11/23
LOCATION:			
LAKE CITY, FL 32055			
DRAWING NAME			
FOUNDATION PLAN LAYOUT			
DRAWING NO.	QUANTITY	CHECKED BY	SCALE
FOUNDATION 0.2	1 EACH	MANUEL	1/8"=1'-0"

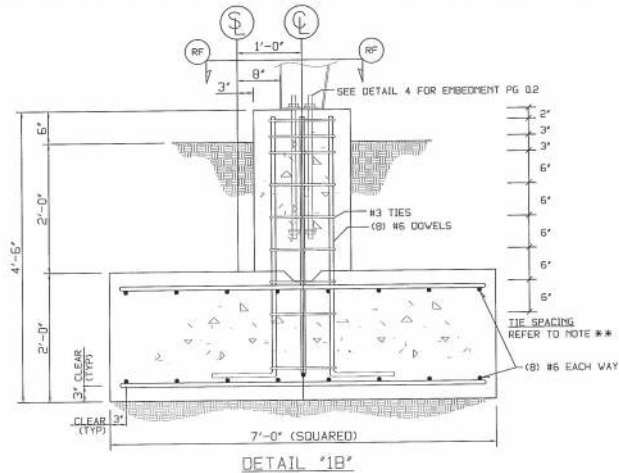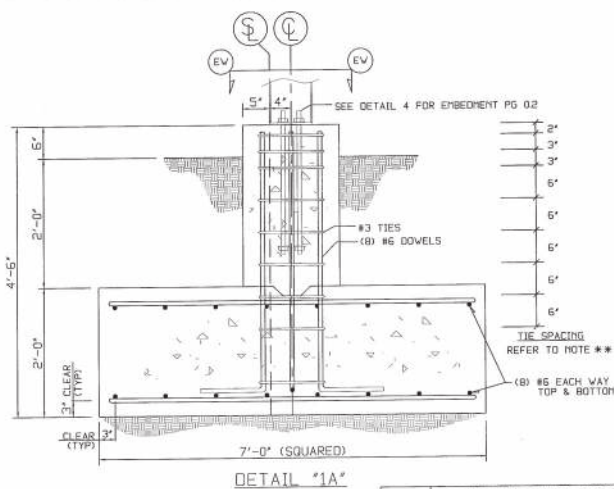

** AT EACH TIE LEVEL THERE ARE 2 TIES, AS SHOWN BELOW (ONE ORIENTED DIAGONALLY, AND ONE ORIENTED NORMAL).

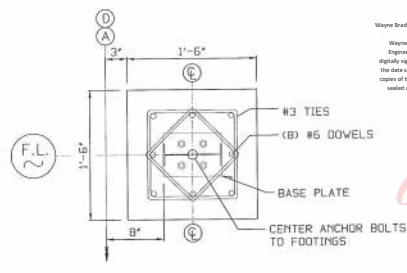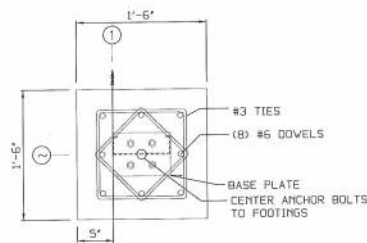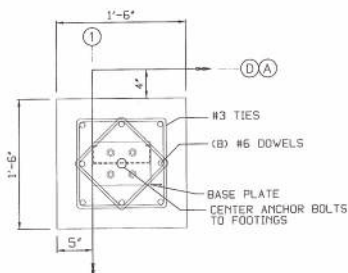

Wayne Brad Baker PE 235 Sanders Road Hudson, GA 31802
Wayne Brad Baker State of Florida, Professional Engineer, License No. 18832. This stamp has been digitally signed and sealed by Wayne Brad Baker, PE on the date shown here using a Digital Signature. Printed copies of this document are not considered signed and sealed and the PE's authentication code must be verified on any electronic copies.

Digitally signed by
Wayne B Baker
Date: 2023.04.25 14:04:08 -04'00'

ISSUE	DET	CHK	DATE
BUILDINGS AND MORE			
CUSTOMER			
F TRAFFIC OPS BUILDINGS			
JOB NO.			DATE
7966			4/11/23
LOCATION			
LAKE CITY, FL 32055			
DRAWING TITLE			
FOUNDATION PLAN LAYOUT			
DRAWING NO.	SCALE	DRAWN BY	CHECKED BY
03	0.3	WBB	WBB
		SCALE	NONE