

Office copy

Daniel Shaheen
Daniel Shaheen

10-15-02
CONSTRUCTION
DOCUMENTS BY:
Daniel Shaheen
P.O. Box 213
Lake City FL 32056
(904) 754-0181


A CUSTOM HOUSE BY DON REED CONSTRUCTION
DAUGHERTY RESIDENCE

ELECTRICAL PLAN
ROOF PLAN

SHEET NUMBER
3 of 3
All work shall comply with the standard building code, and all applicable local codes and ordinances.
Contractor shall verify all dimensions prior to commencing construction.
PROJECT NUMBER
010222

Office copy

- ROOF PLAN NOTES
- R-1 ALL ROOF PITCH 6/12 UNLESS OTHERWISE NOTED
 - R-2 ALL OVERHANG 18" AND 12" AT GABLES UNLESS OTHERWISE NOTED
 - R-3 PROVIDE ATTIC VENTILATION IN ACCORDANCE WITH CODE REQUIREMENTS
 - R-4 SEE EXTERIOR ELEVATIONS AND FLOOR PLANS TO VERIFY PLATE AND HILL HEIGHTS
 - R-5 MOVE ALL VENTS AND OTHER ROOF PENETRATIONS TO REAR

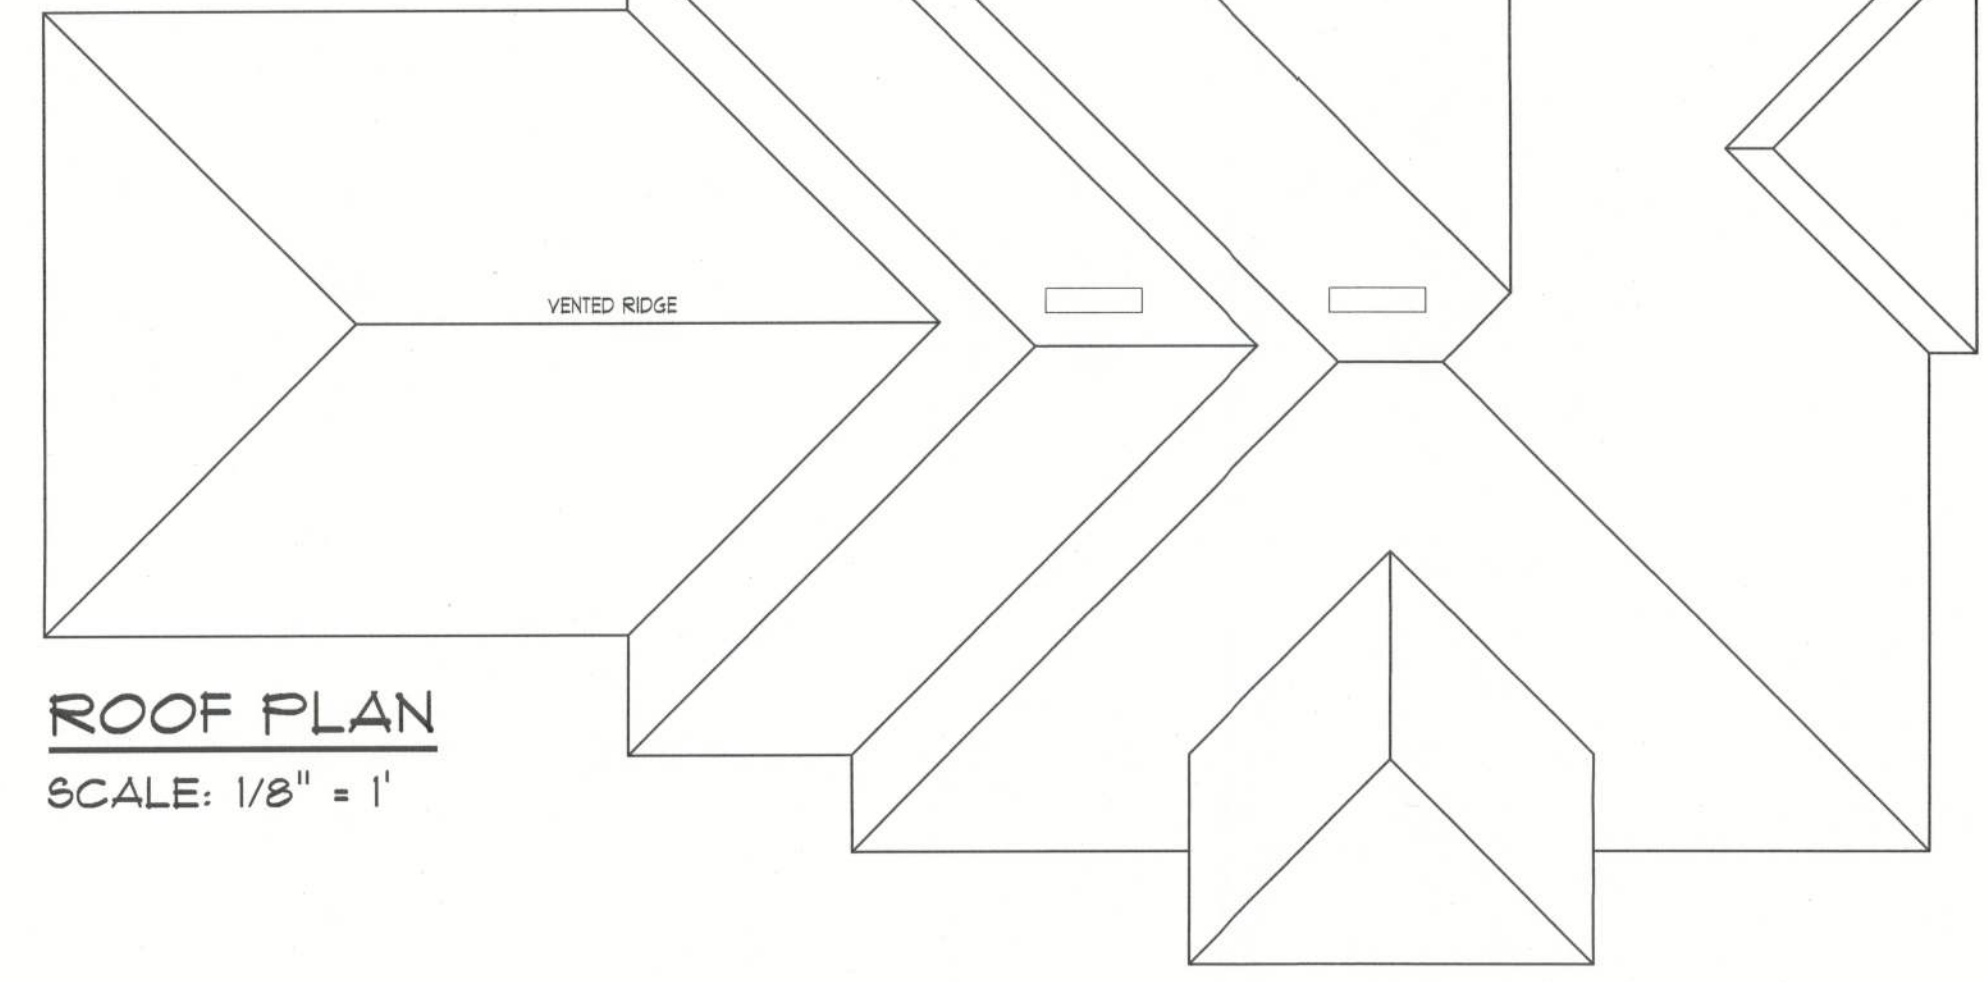

ROOF PLAN
SCALE: 1/8" = 1'


ELECTRICAL PLAN NOTES

- E-1 ALL WORK SHALL COMPLY WITH THE NATIONAL ELECTRICAL CODE, LATEST EDITION, AND ALL OTHER APPLICABLE LOCAL CODES AND ORDINANCES.
- E-2 NOTE: ALL SMOKE DETECTORS TO BE WIRED TOGETHER TO ACTIVATE ALL ALARMS IF ANY ONE UNIT IS ACTUATED.
- E-3 PHONE AND TELEVISION OUTLET LOCATIONS TO BE DETERMINED DURING CONSTRUCTION, EXCEPT WHERE SHOWN ON ELECTRICAL PLAN
- E-4 PROVIDE WIRING AS REQUIRED FOR APPLIANCES, AIR CONDITIONING, HEATING AND WATER HEATING EQUIPMENT.

NOTE: PROVIDE OUTLETS PER CODE REQUIREMENTS

NOTE: PROVIDE SMOKE DETECTORS PER CODE REQUIREMENTS

NOTE:
THIS ELECTRICAL PLAN IS A SCHEMATIC WITH SUGGESTED SWITCH, RECEPTACLE, AND LIGHT FIXTURE LOCATIONS. DUE TO VARYING LOCAL AND STATE CODES, REGULATIONS, AND STATUTES, IT IS THE RESPONSIBILITY OF THE OWNER AND/OR CONTRACTOR TO COMPLY WITH ALL LOCAL AND STATE CODES, REGULATIONS AND STATUTES.

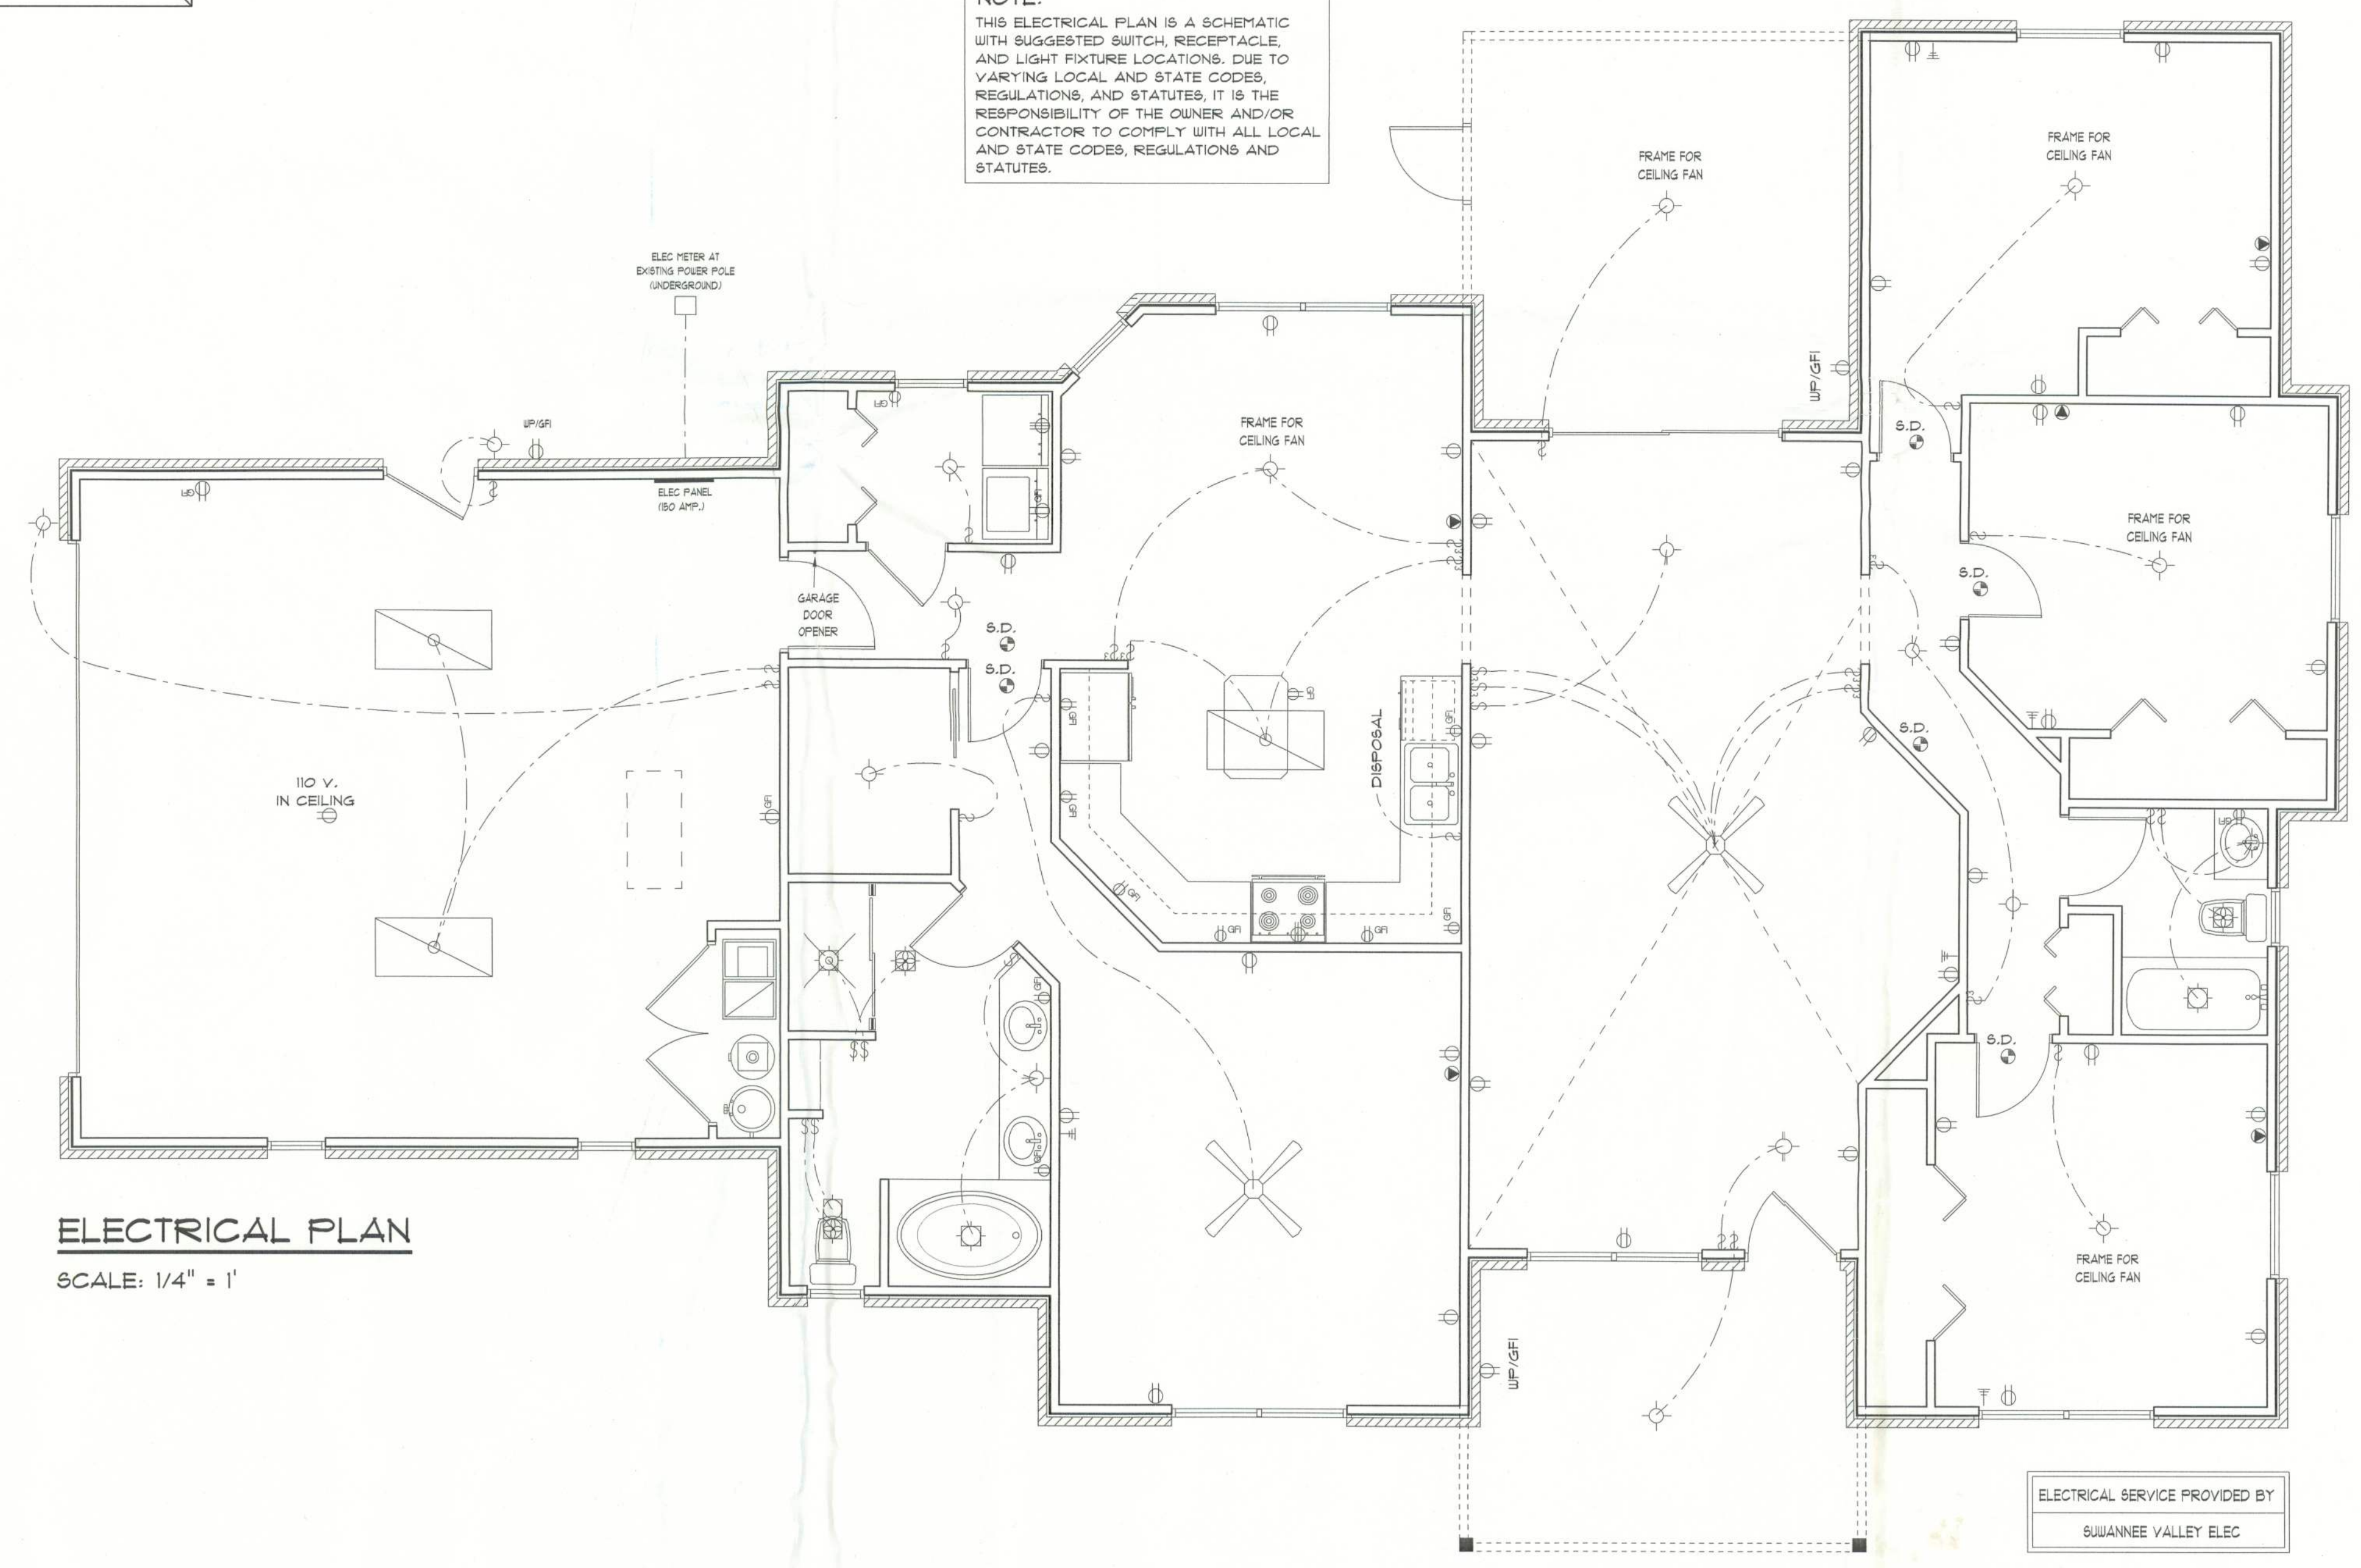

ELECTRICAL PLAN
SCALE: 1/4" = 1'