



NOTES

- 1. ELEVATIONS BASED ON AN NAVD 88 DATUM
- 2. CONTRACTOR TO LOCATE AND VERIFY ALL UTILITIES
- 3. EXISTING UTILITIES AS PROVIDED BY THE CITY OF LAKE CITY
CONTRACTOR TO LOCATE AND VERIFY ALL UTILITIES

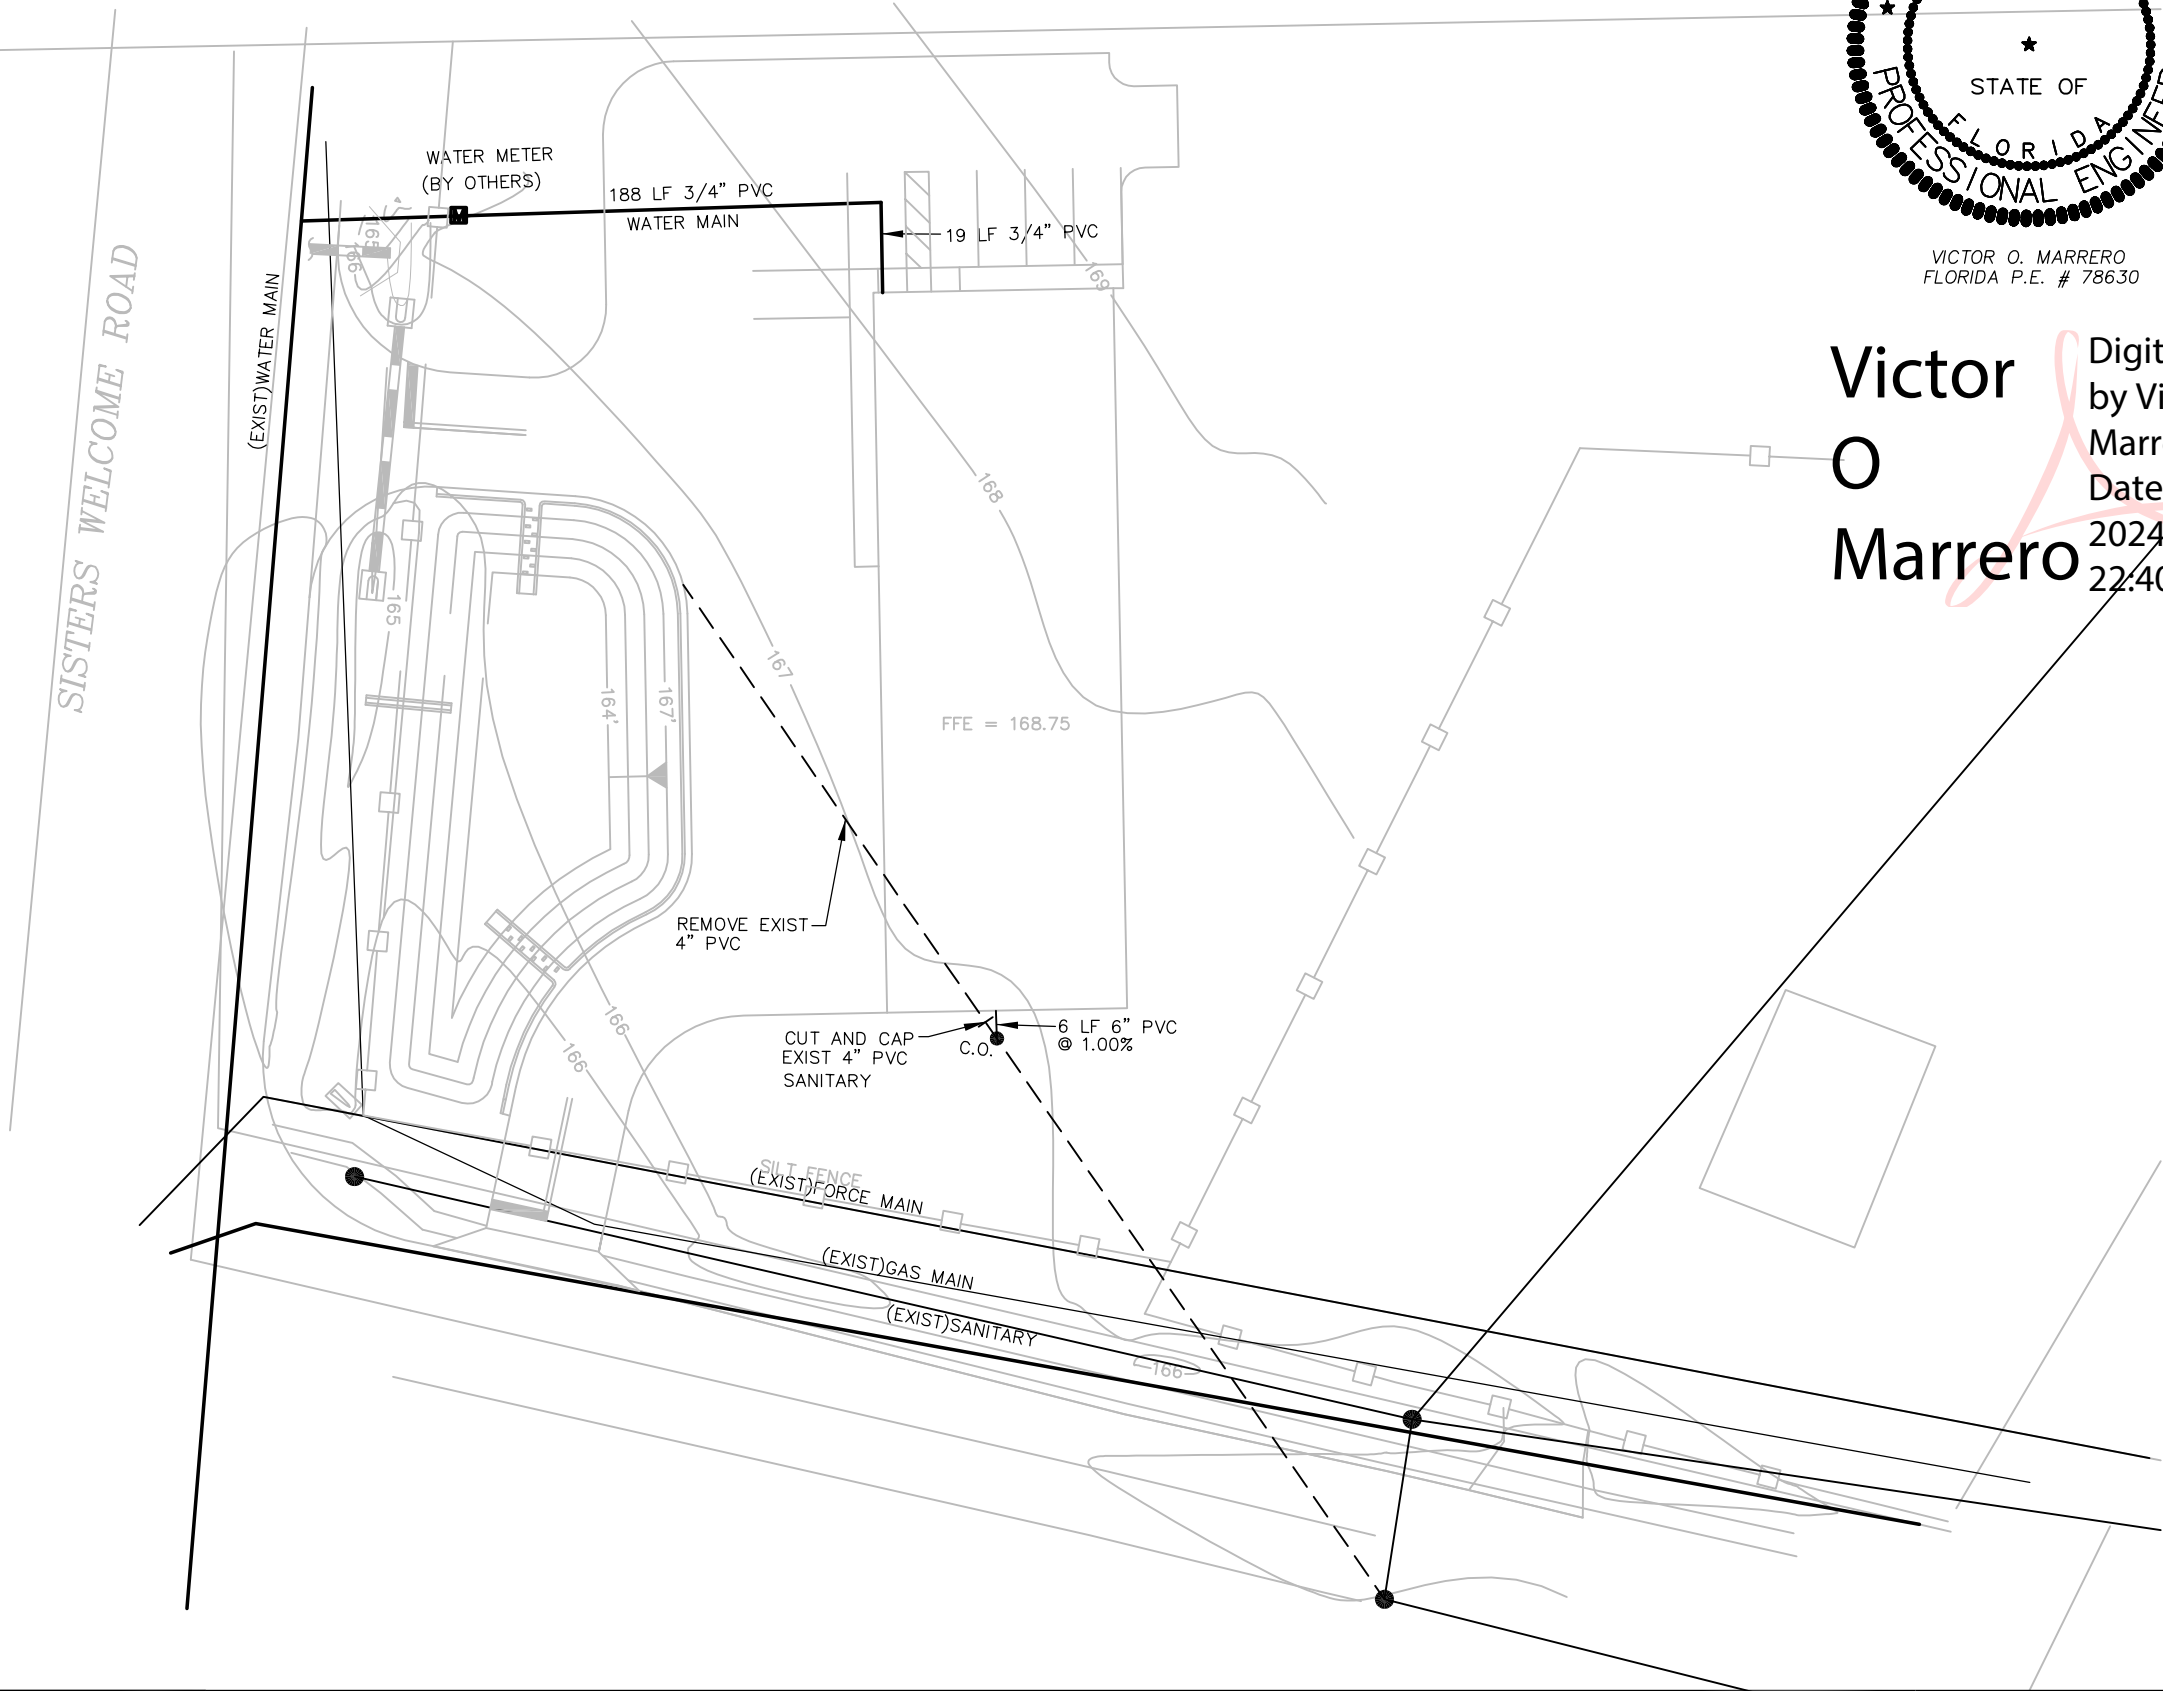

AFFINE ENGINEERING
AND SURVEYING, INC.
CERTIFICATE OF
AUTHORIZATION No. 29140

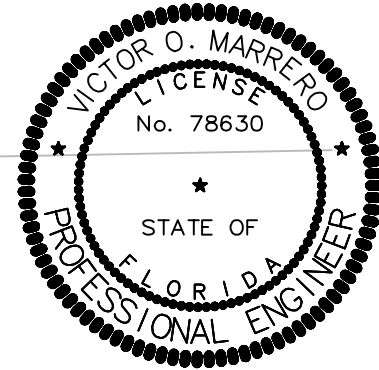

VICTOR O. MARRERO
FLORIDA P.E. # 78630

Victor
O
Marrero

Digitally signed
by Victor O
Marrero
Date:
2024.05.12
22:40:02 -04'00'

REVISIONS	
BY	#

DRAWN BY: VM
CHECKED BY: NB
DATE: 2/21/24
SCALE: 1"=40'
JOB #: 23010

AFFINE ENGINEERING AND SURVEYING, INC
AFFINE CIVIL ENGINEERS
TELEPHONE NUMBER 407-421-5534
128 NW GREEN LN, LAKE CITY, FLORIDA 32055
CERTIFICATE OF AUTHORIZATION No. 29140

PREPARED FOR:
C.A BOONE CONSTRUCTION
UTILITY PLAN

DRAWING
23010-01
SHEET
4