


The Final Plan Inc. reserves its common law copyrights. These plans and designs are not to be reproduced for a purpose other than the completion of this project without written consent from The Final Plan, Inc.

ELECTRICAL LEGEND


	Ceiling Mounted Light		Water Proof Receptacle		Cable Jack		Ceiling Fan		Thermostat
	Pull Chain Light		Floor Receptacle		Pre-Wire Garage Door Opener		Wall Sconce		Speaker
	Recessed Light		Outlet in Ceiling		Fluorescent Light		Chandelier		Junction Box
	Ceiling Mounted LED		Ground Fault Interrupt		Electrical Panel		Intercom		Track Lighting
	Wall Mounted Light		Wall Switch		Chime		Spot Light		Theatrical Strip
	Wall Wash Recessed		3-Way Switch		Door Bell/Garage Door Switch		Led Strip		
	Duplex Receptacle		Dimmer Switch		Disconnect Switch		Fan/Light Combination		
	220 V Receptacle		Telephone Jack		Electrical Meter		Garbage Disposal Motor		
	1/2 hot, 1/2 switched		Ethernet		Smoke Detector				

NOTES:

1. ALL SMOKE DETECTORS ARE TO BE HARD WIRED AND INTERCONNECTED.
2. PROVIDE ARC FAULT PROTECTION IN ALL LIVING SPACES, EXCEPT IN BATHROOMS, KITCHEN, LAUNDRY, AND GARAGES.
3. USE COMBINATION SMOKE AND CARBON MONOXIDE ALARMS, OR PROVIDE A CARBON MONOXIDE ALARM (IN ADDITION TO SMOKE) WITHIN 10' OF EACH ROOM USED FOR SLEEPING PURPOSES (SEE FBCR 2010, SEC. R315).
4. EXACT LOCATIONS OF FIXTURES AND/OR OUTLETS ARE SUGGESTED AND MEET MOST LOCAL CODE REQUIREMENTS. ADDITIONS OR ADJUSTMENTS MAY BE MADE BETWEEN OWNER AND BUILDER IN THE FIELD.

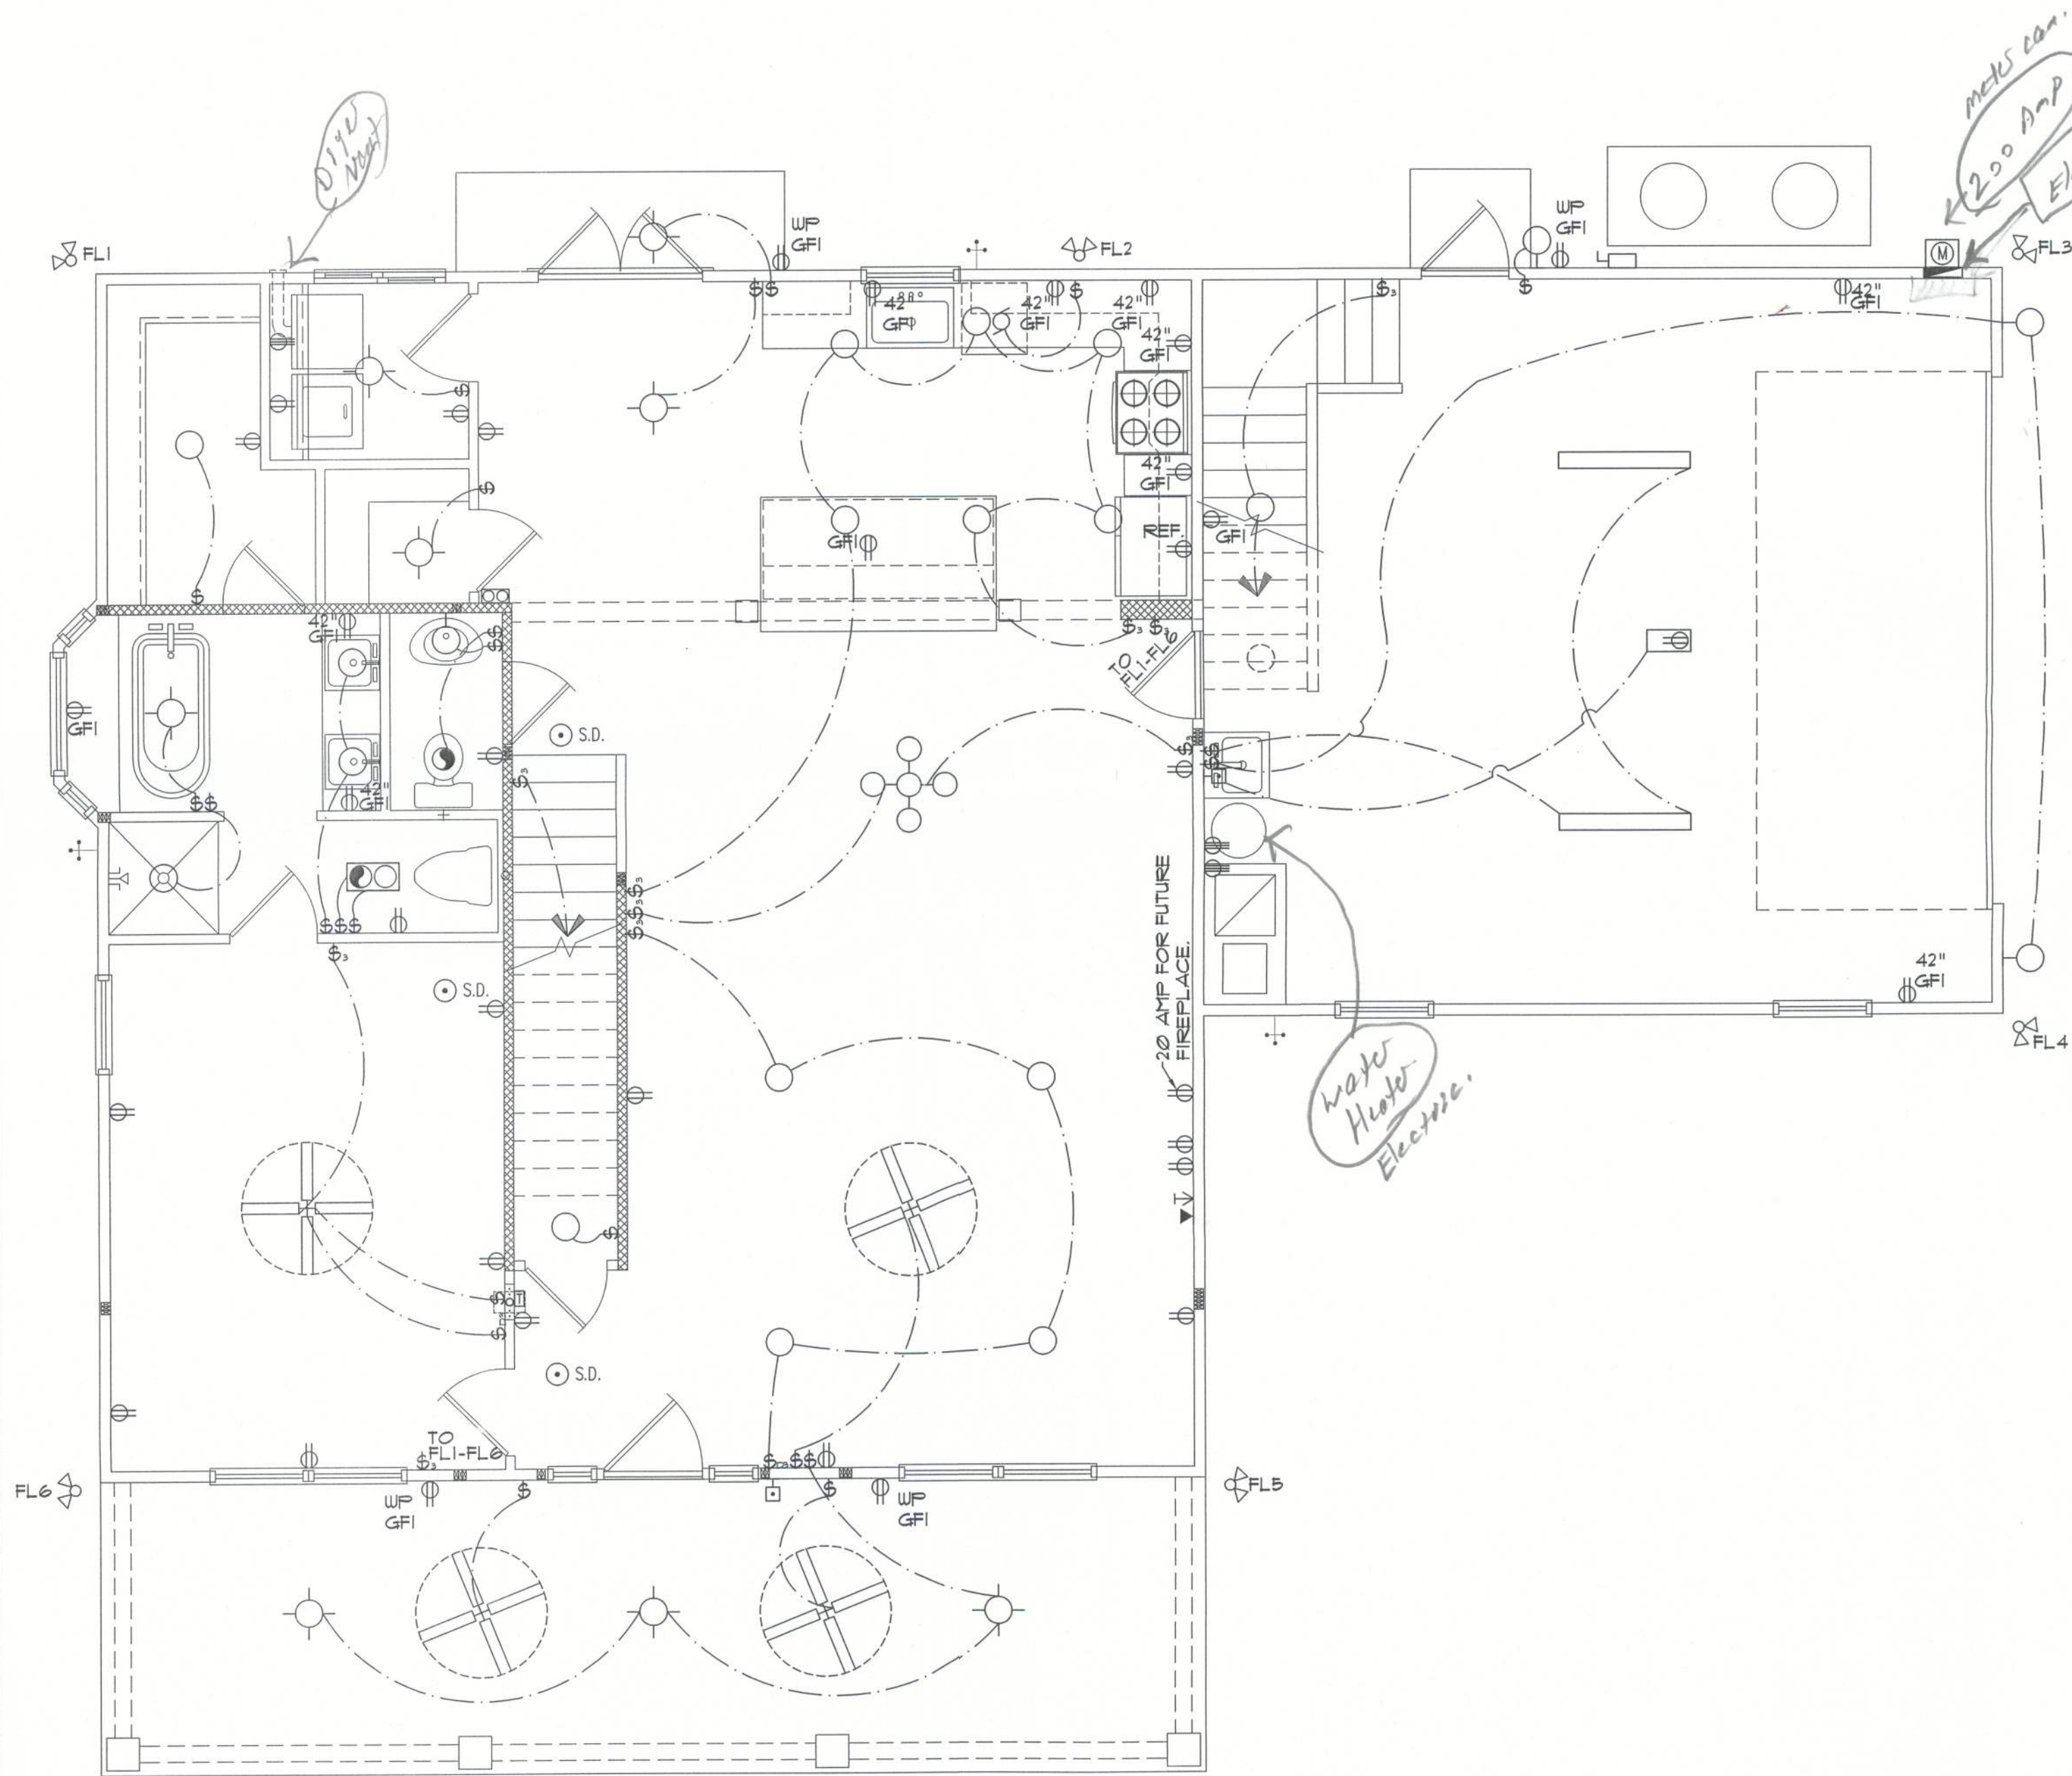

A Electrical Fixture Layout
SCALE: 1/4" = 1'-0"
FIRST LEVEL

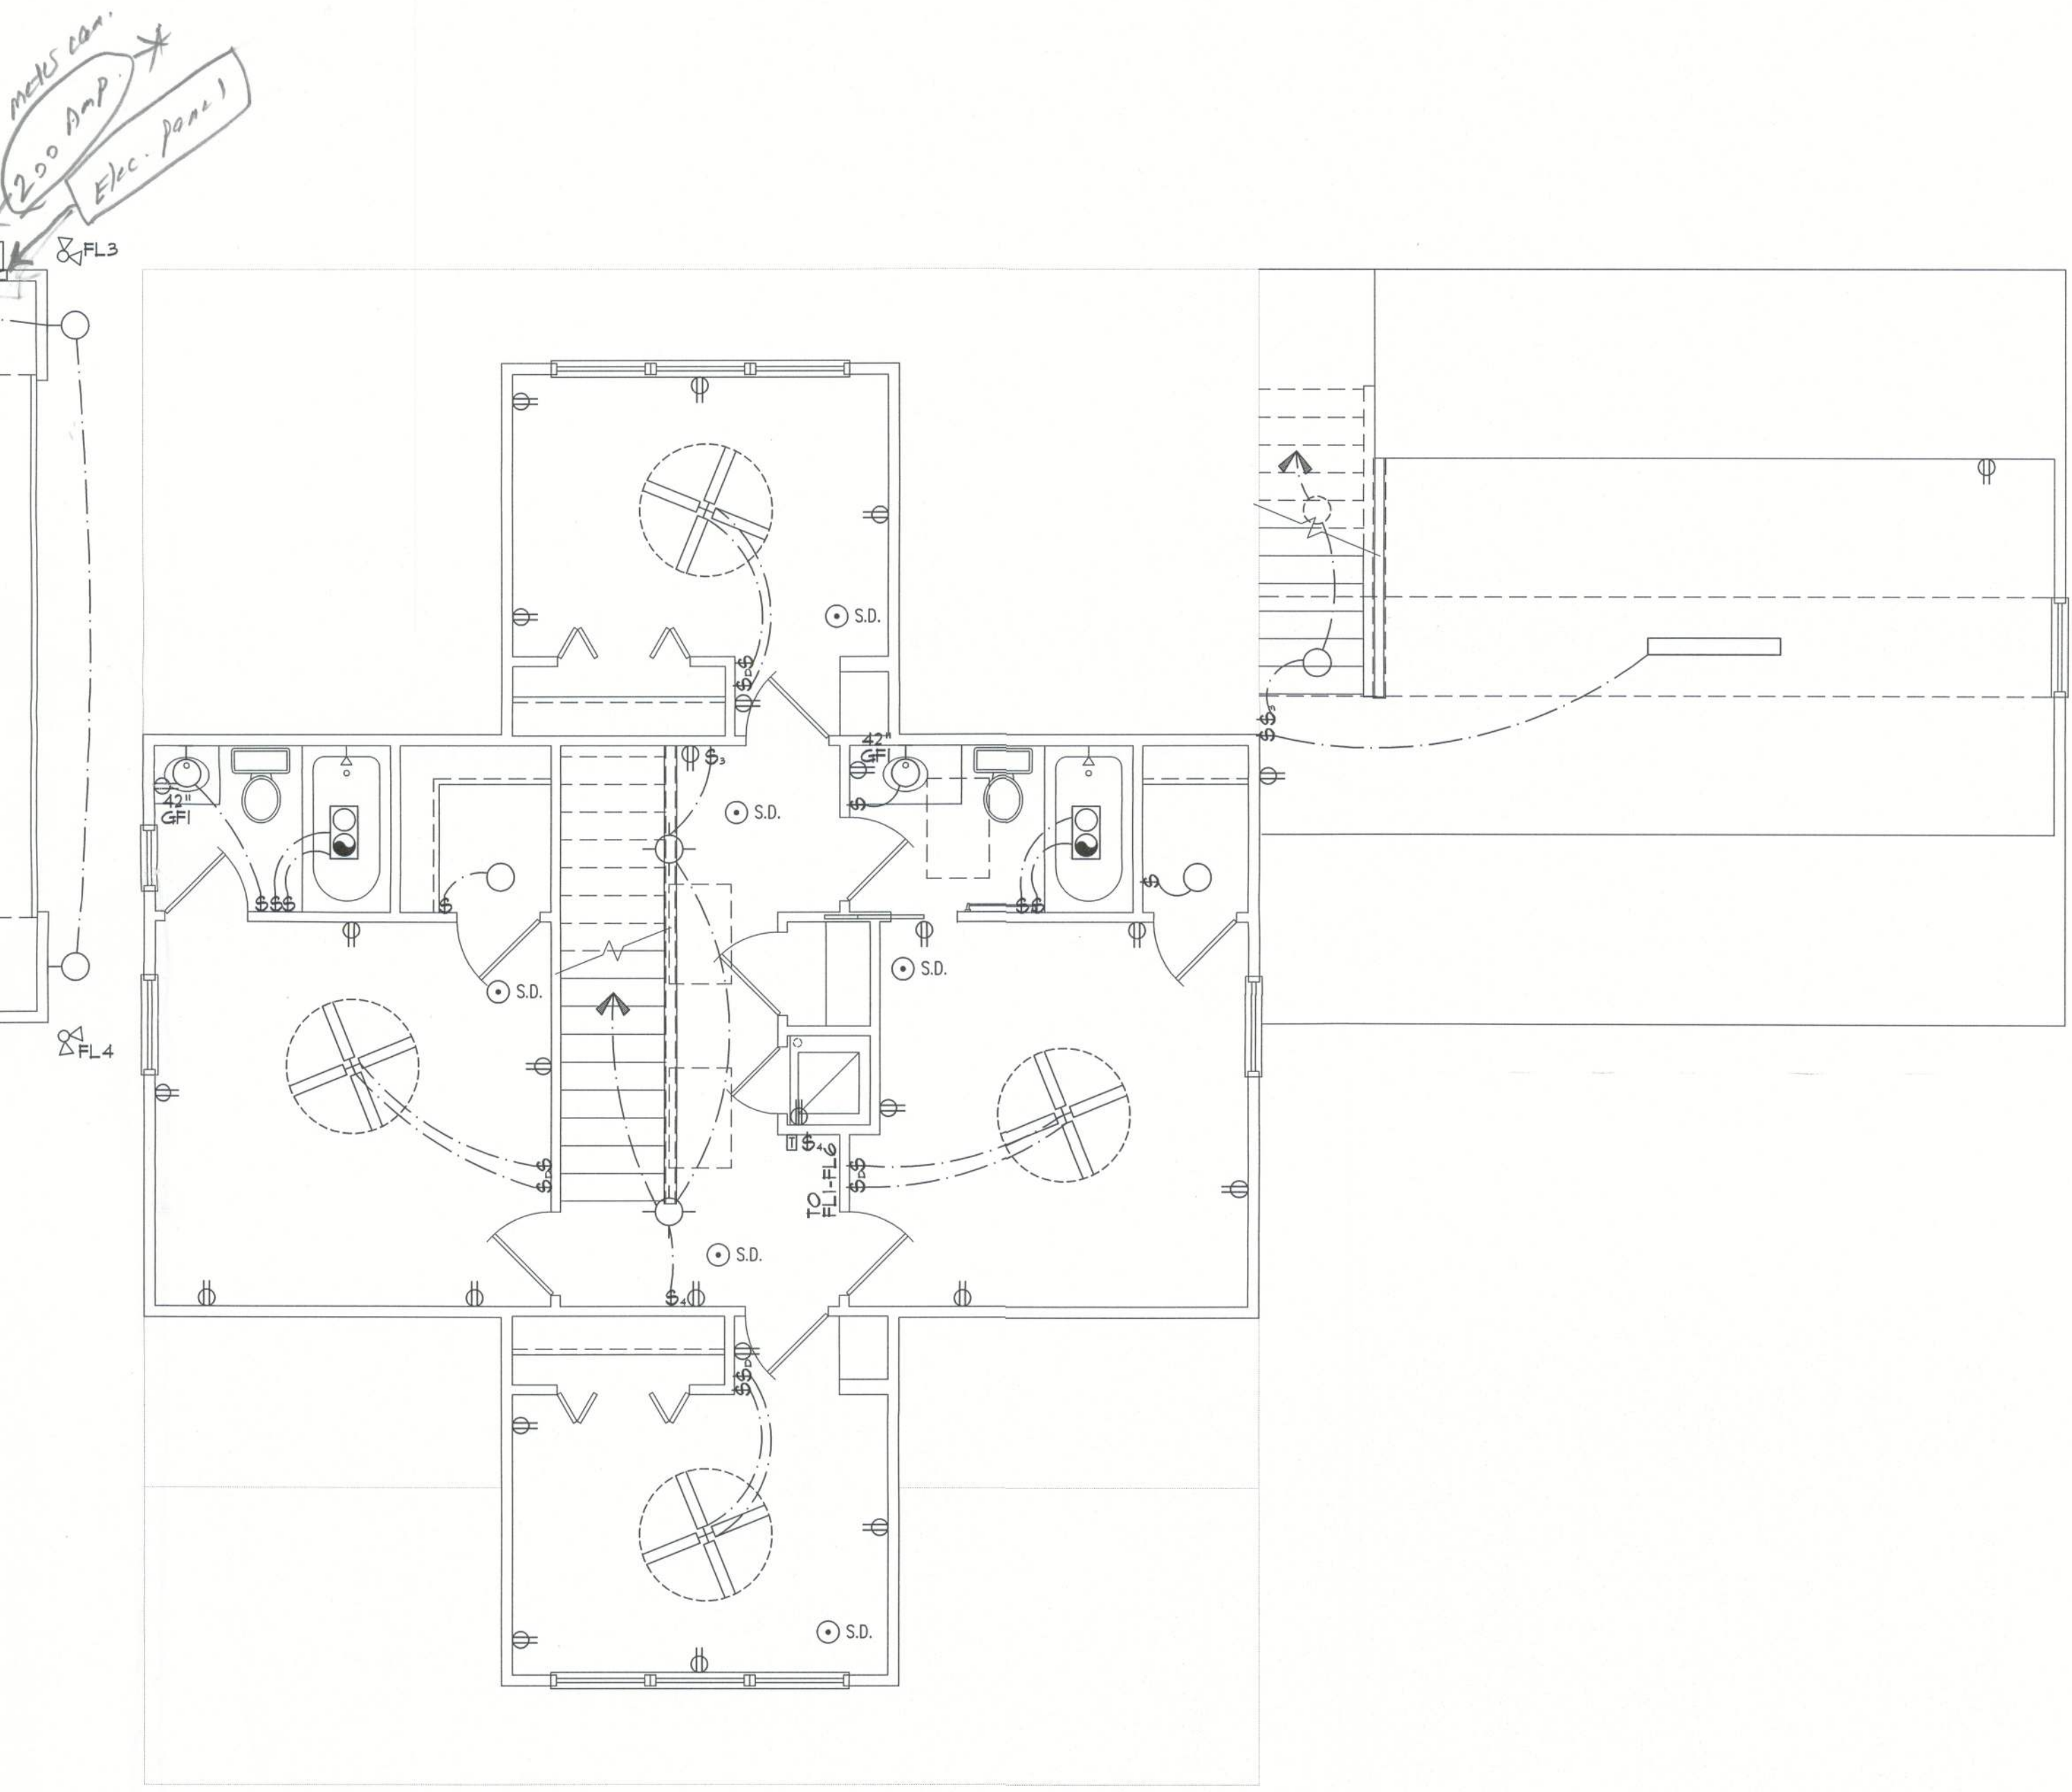

B Electrical Fixture Layout
SCALE: 1/4" = 1'-0"
SECOND LEVEL

THE FINAL PLAN, INC.

WWW.THEFINALPLAN.COM

TEL. 352.410.2539

CUSTOM DESIGNS, SPACE PLANNING
TENANT BUILD OUTS, ADDITIONS, REMODELS

revisions	by

OWENS RESIDENCE

PARCEL ID: 03-69-16-03161-325

FORT WHITE, FLORIDA

job no	OWENS 1123
drawn by	DA
checked	
date	05/14/24
scale	AS NOTED

111