

HOME PLANS FOR KRUSE RESIDENCE COLUMBIA COUNTY, FL

Plan Sheet Index:

Sheet No.	Description
1	title/index sheet
2	floor plan
3	front and right elevations
4	rear and left elevations
5	wall typical
6	roof plan
7	foundation & plumbing plan
8	electrical plan

PLANS PREPARED BY:
CHRISTOPHER Q. DICKS
4035 SE CR 252, LAKE CITY, FL 32025


KRUSE RESIDENCE
COLUMBIA COUNTY, FLORIDA




SHEET
1
OF
8

SQUARE FOOTAGE	
HEATED AREA	3249 SF
PORCH	566 SF
GARAGE	683 SF
TOTAL	4498 SF

1. ALL EXTERIOR WALLS ARE 2x6.
2. INTERIOR WALLS ARE 2x4 UNLESS OTHERWISE INDICATED.

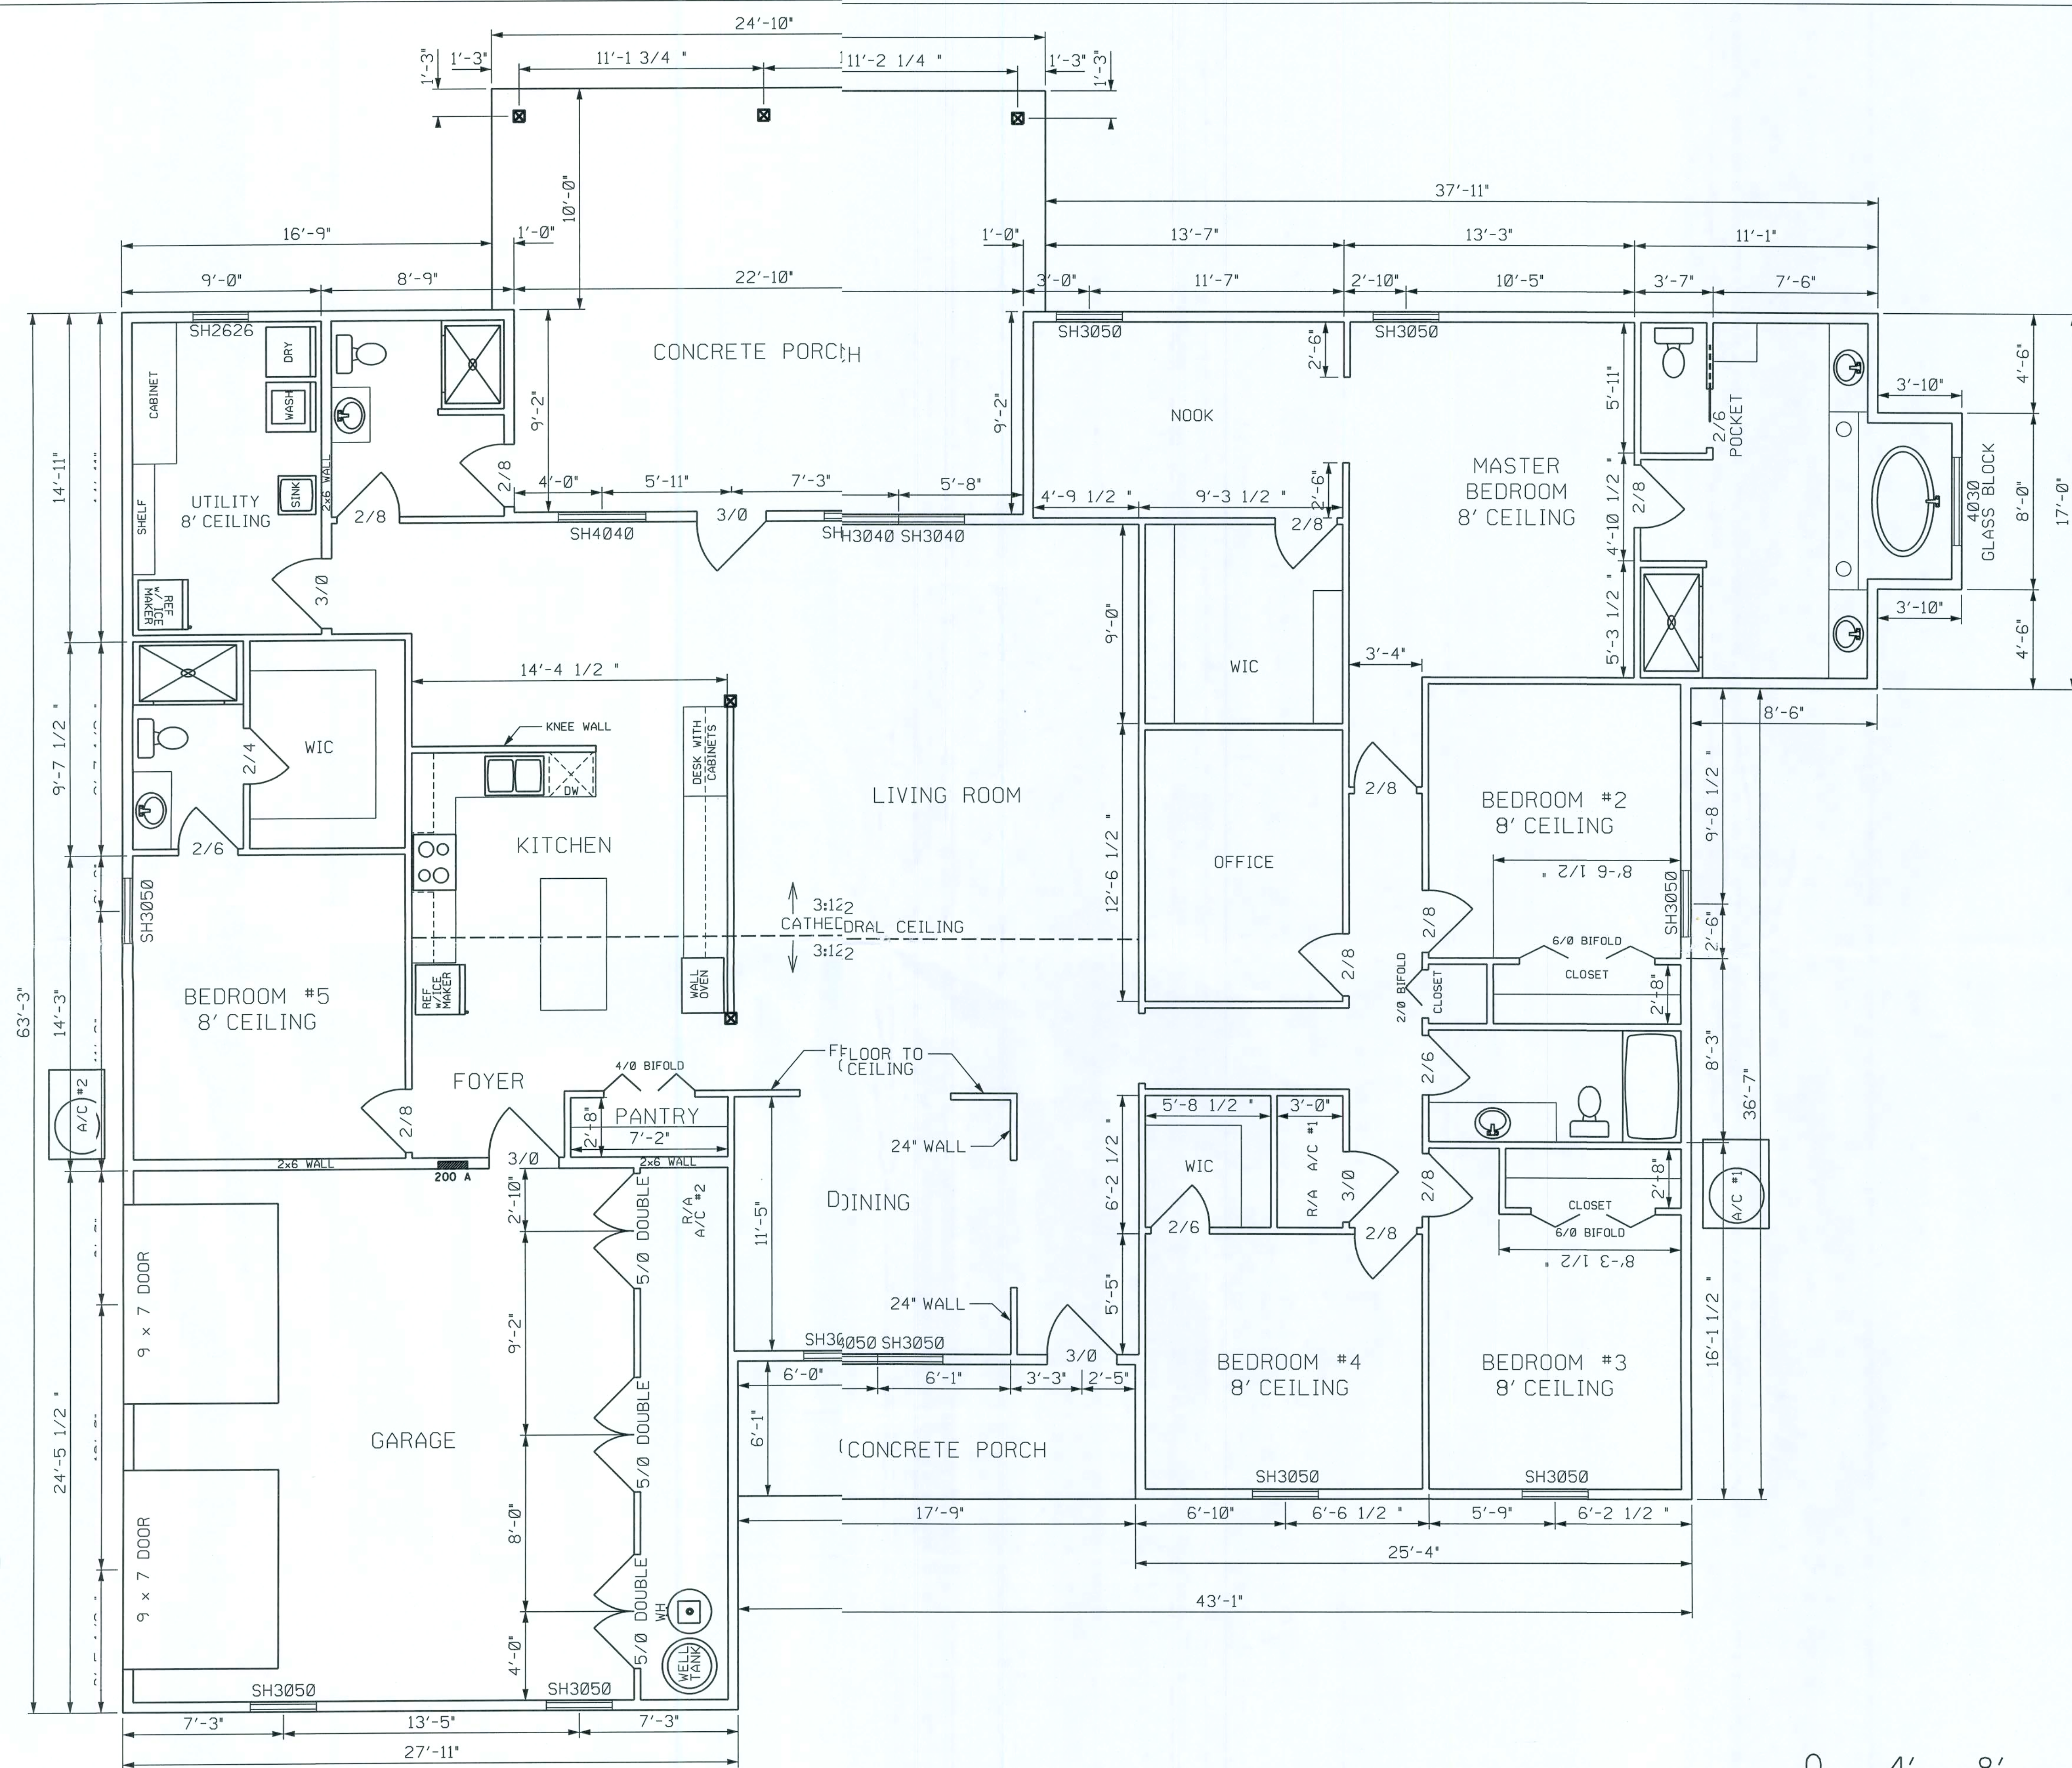


FLOOR PLAN

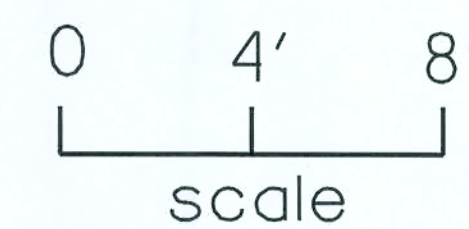


PLANS PREPARED BY:
CHRISTOPHER Q. DICKS
4035 SE CR 252, LAKE CITY, FL 32025

KRUSE RESIDENCE
COLUMBIA COUNTY, FLORIDA


SHEET
2
OF
8

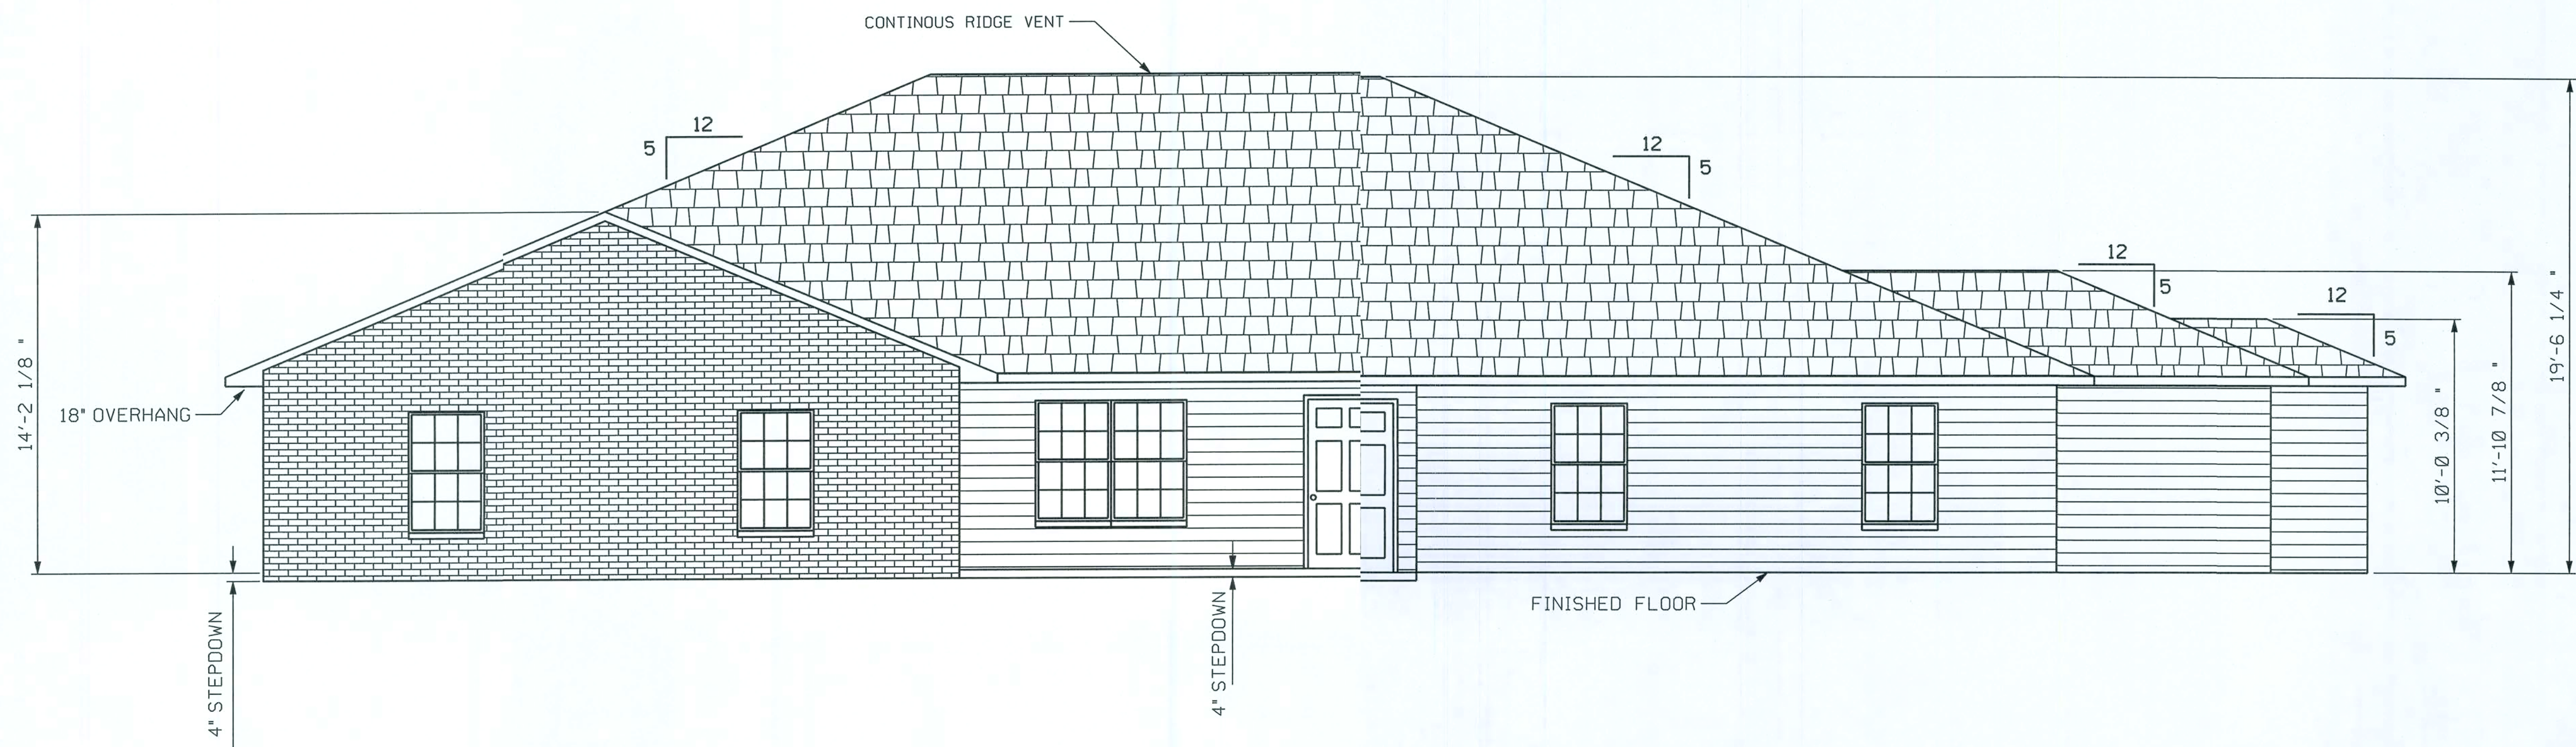

FRONT ELEVATION

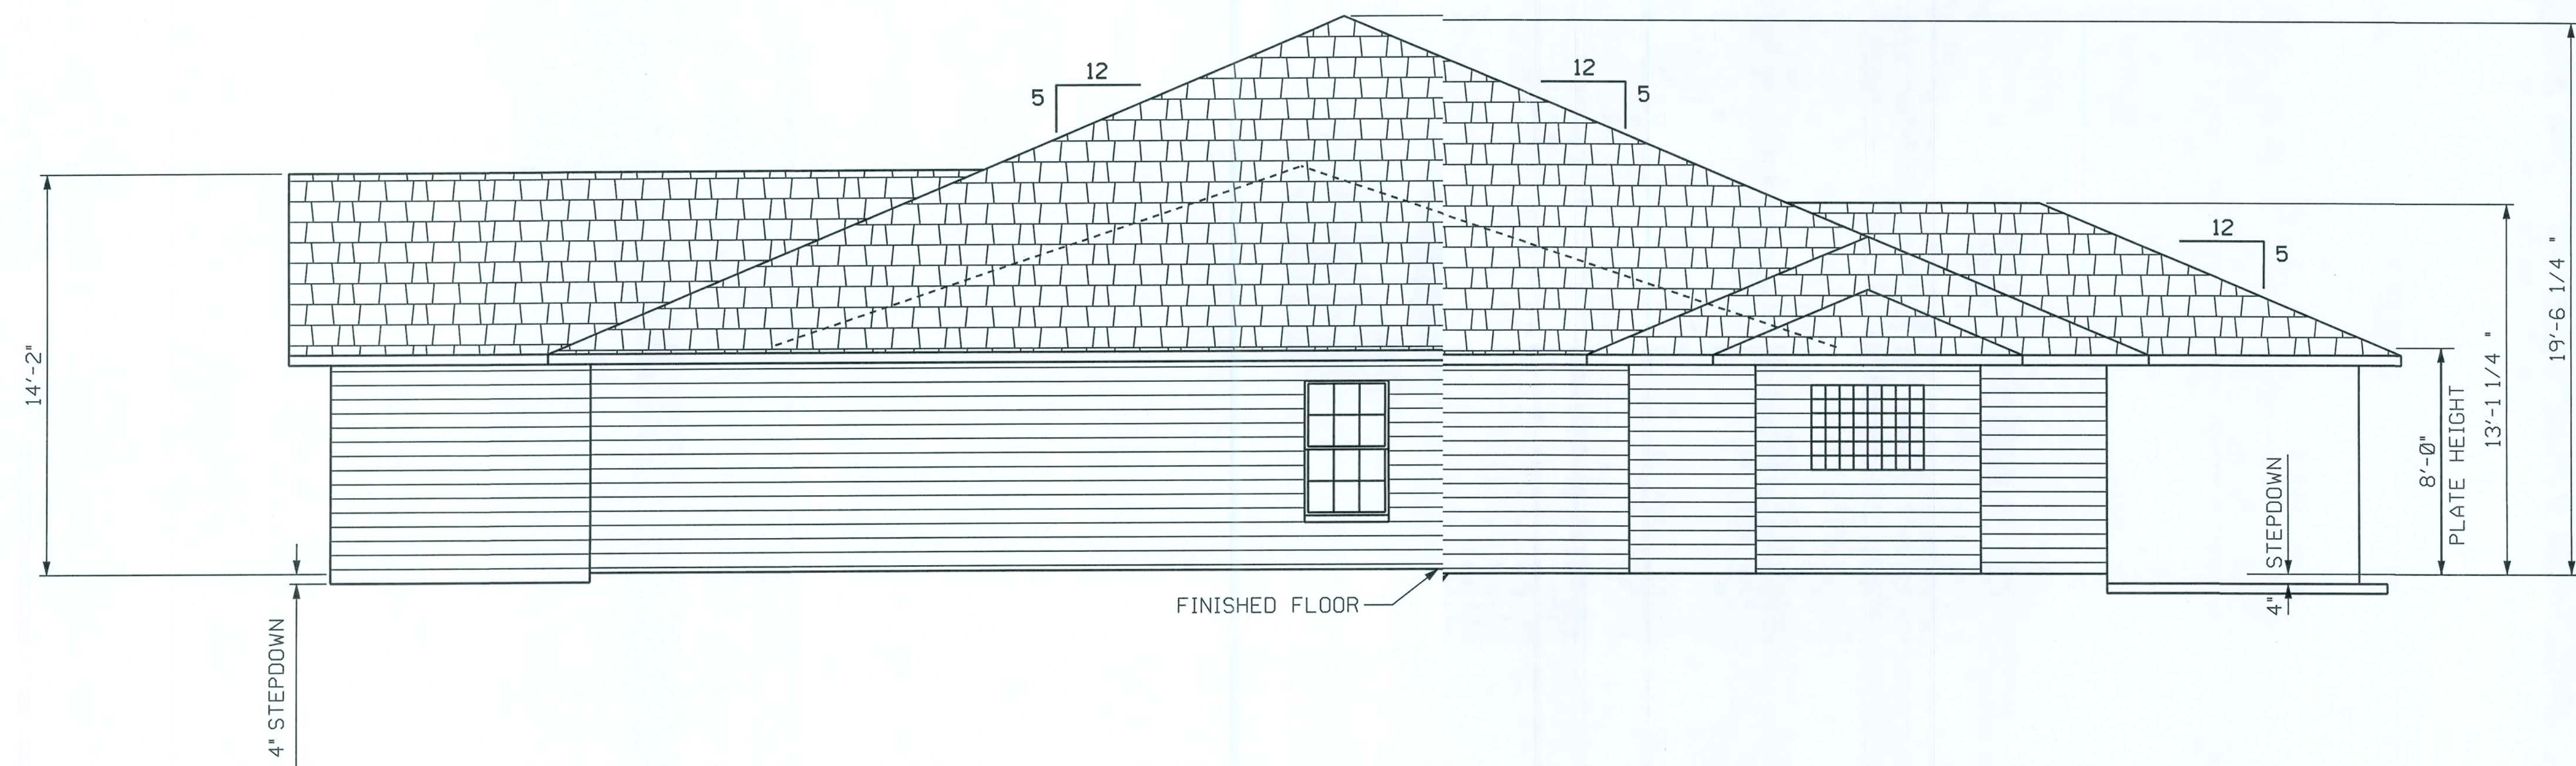


RIGHT ELEVATION

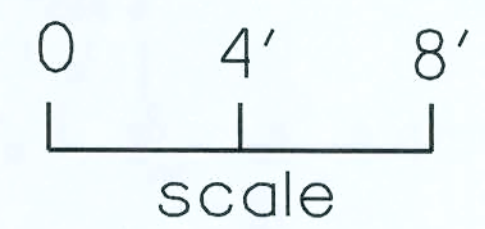


PLANS PREPARED BY:
CHRISTOPHER Q. DICKS
4035 SE CR 252, LAKE CITY, FL 32025

KRUSE RESIDENCE
COLUMBIA COUNTY, FLORIDA

SHEET
3
OF
8

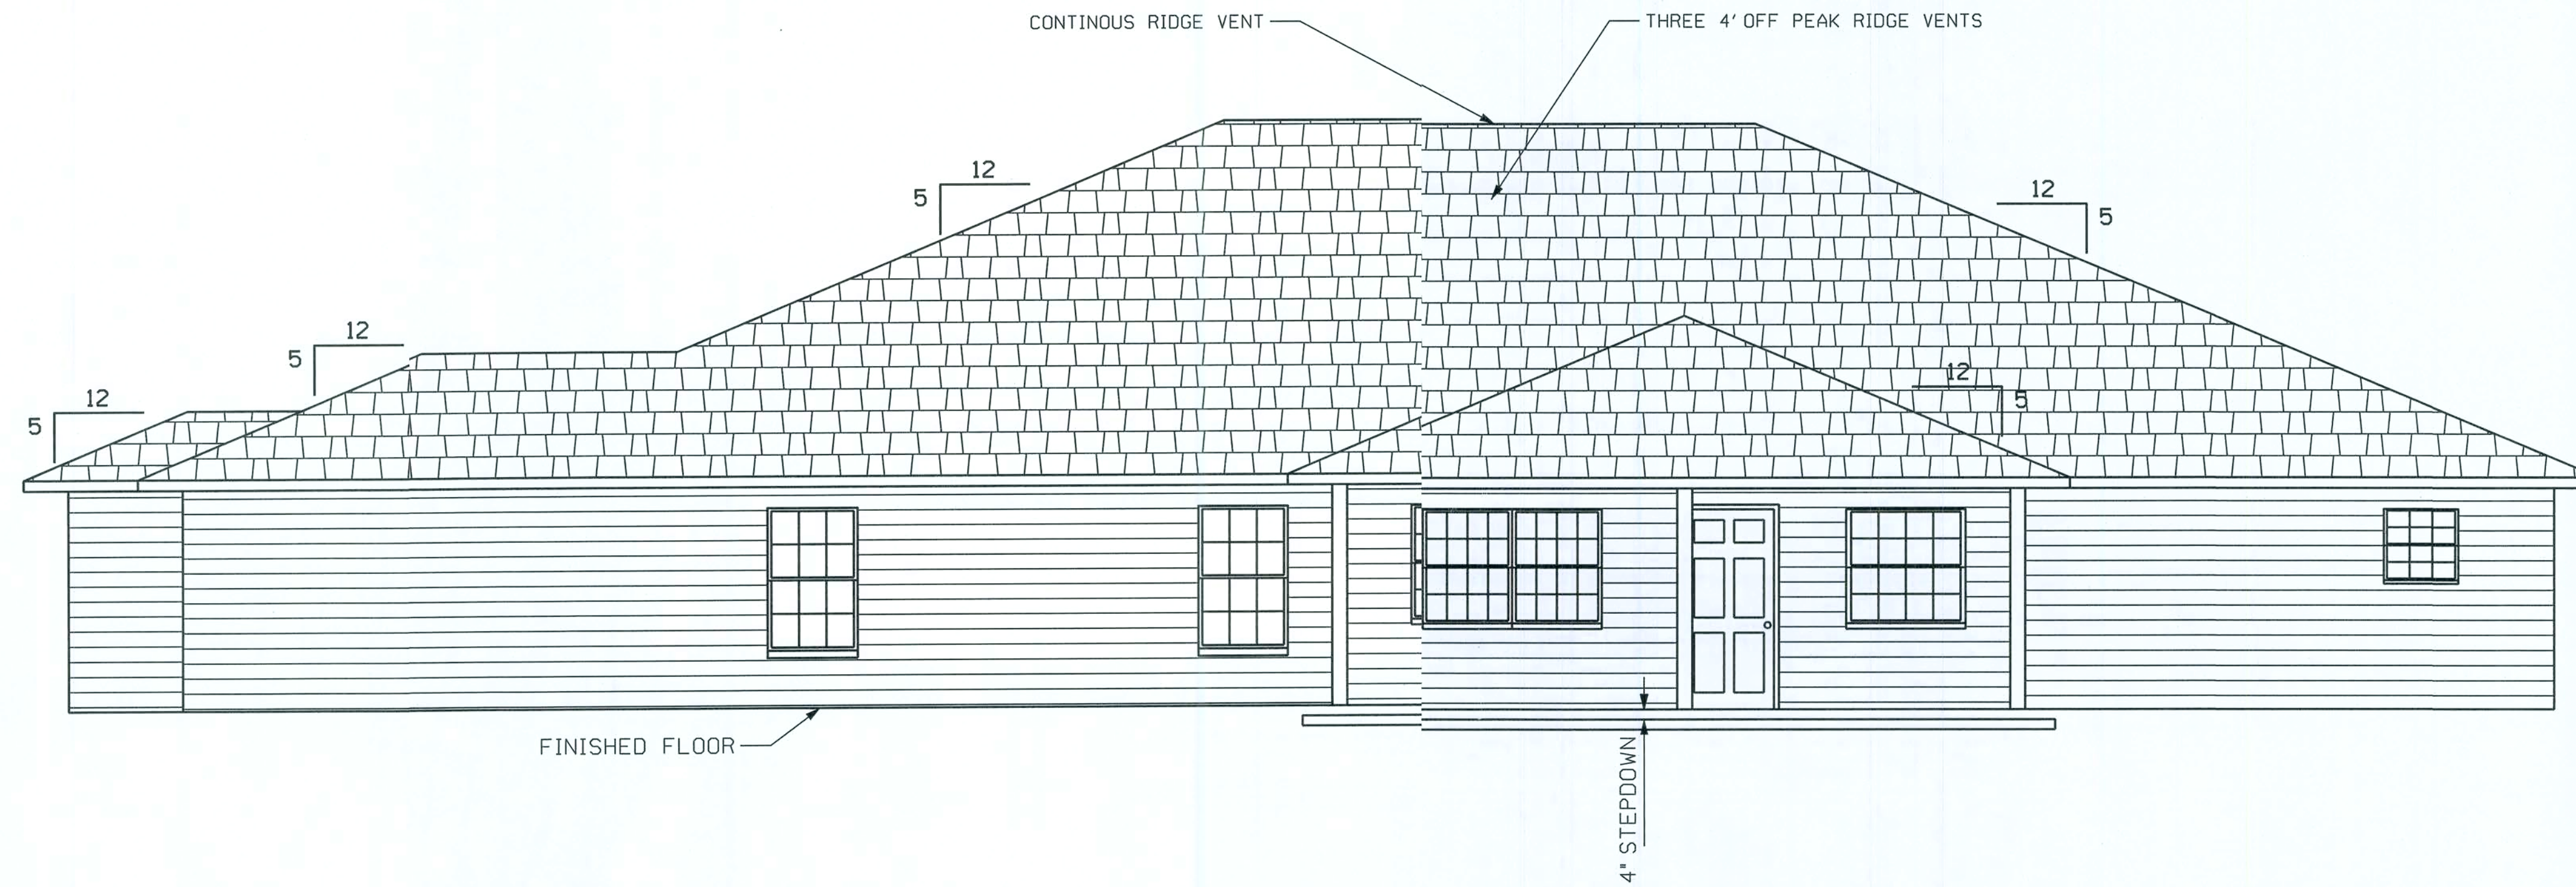

REAR ELEVATION

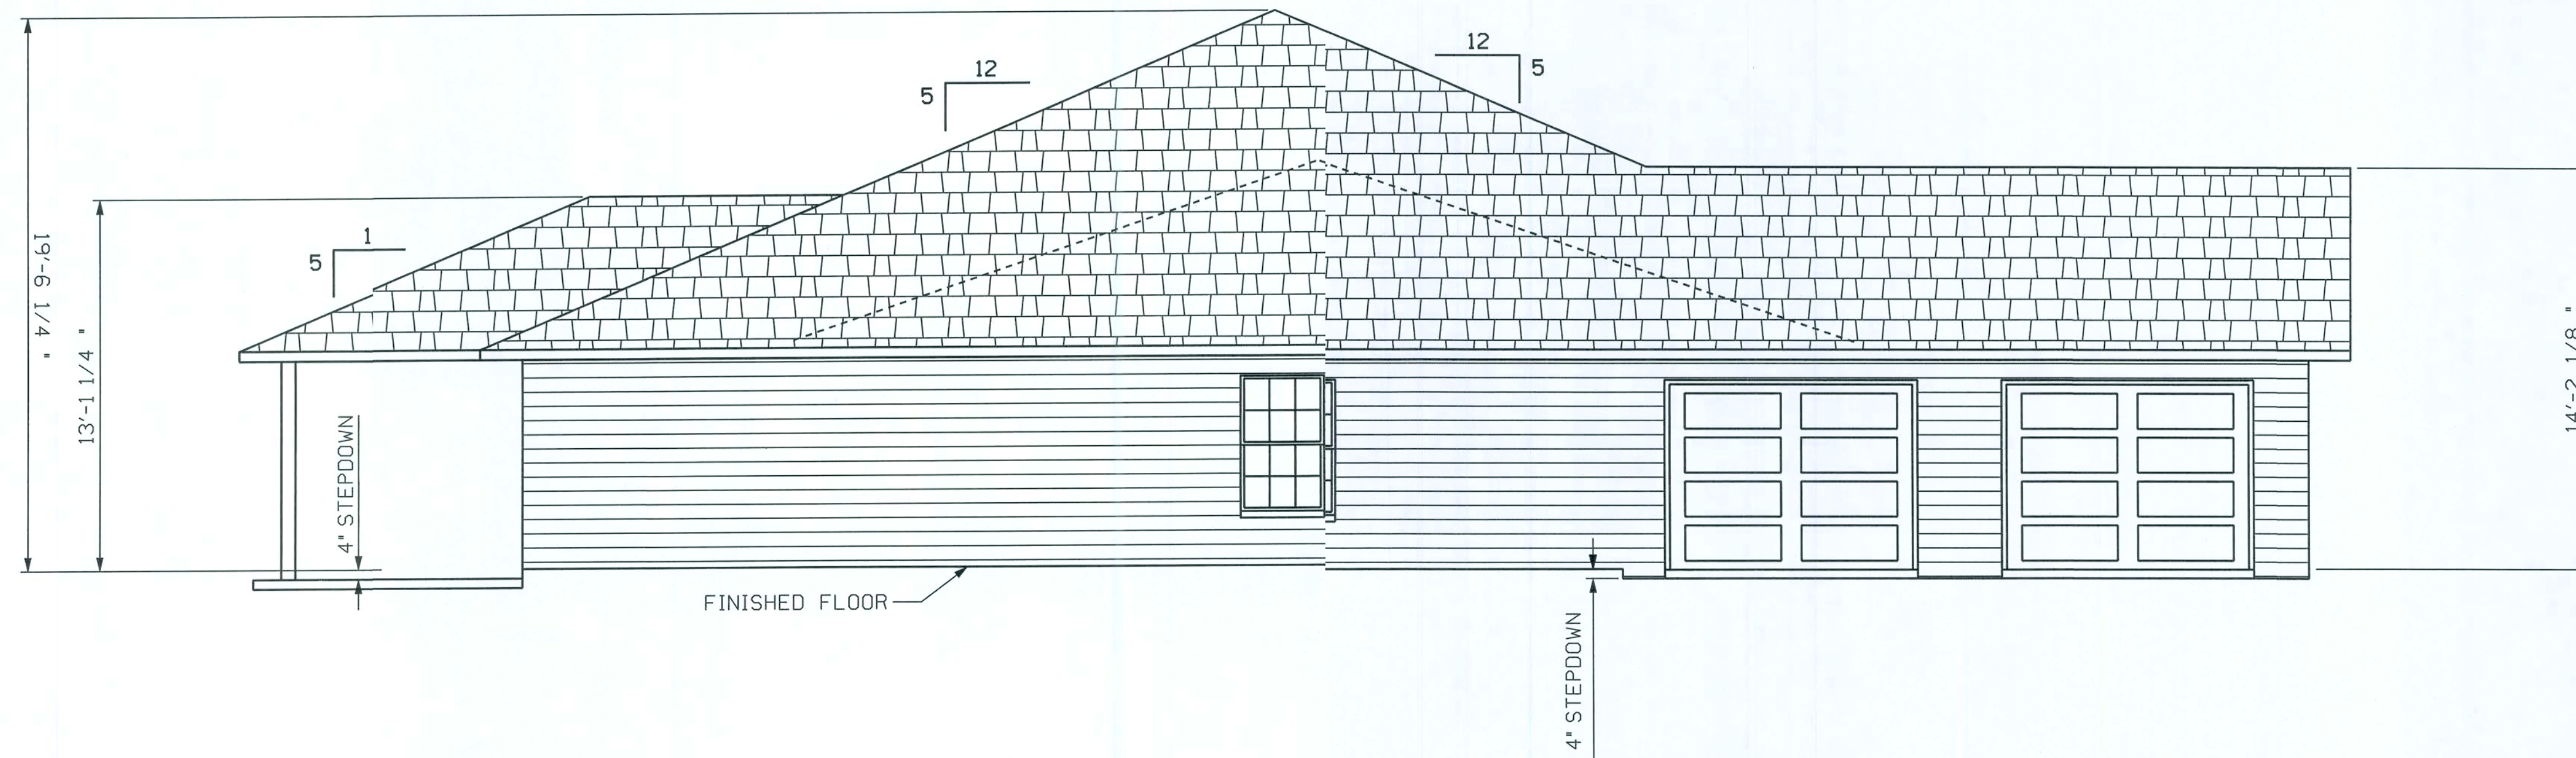


LEFT ELEVATION

0 4' 8'
scale

PLANS PREPARED BY:
CHRISTOPHER Q. DICKS
4035 SE CR 252, LAKE CITY, FL 32025

KRUSE RESIDENCE
COLUMBIA COUNTY, FLORIDA

SHEET
4
OF
8

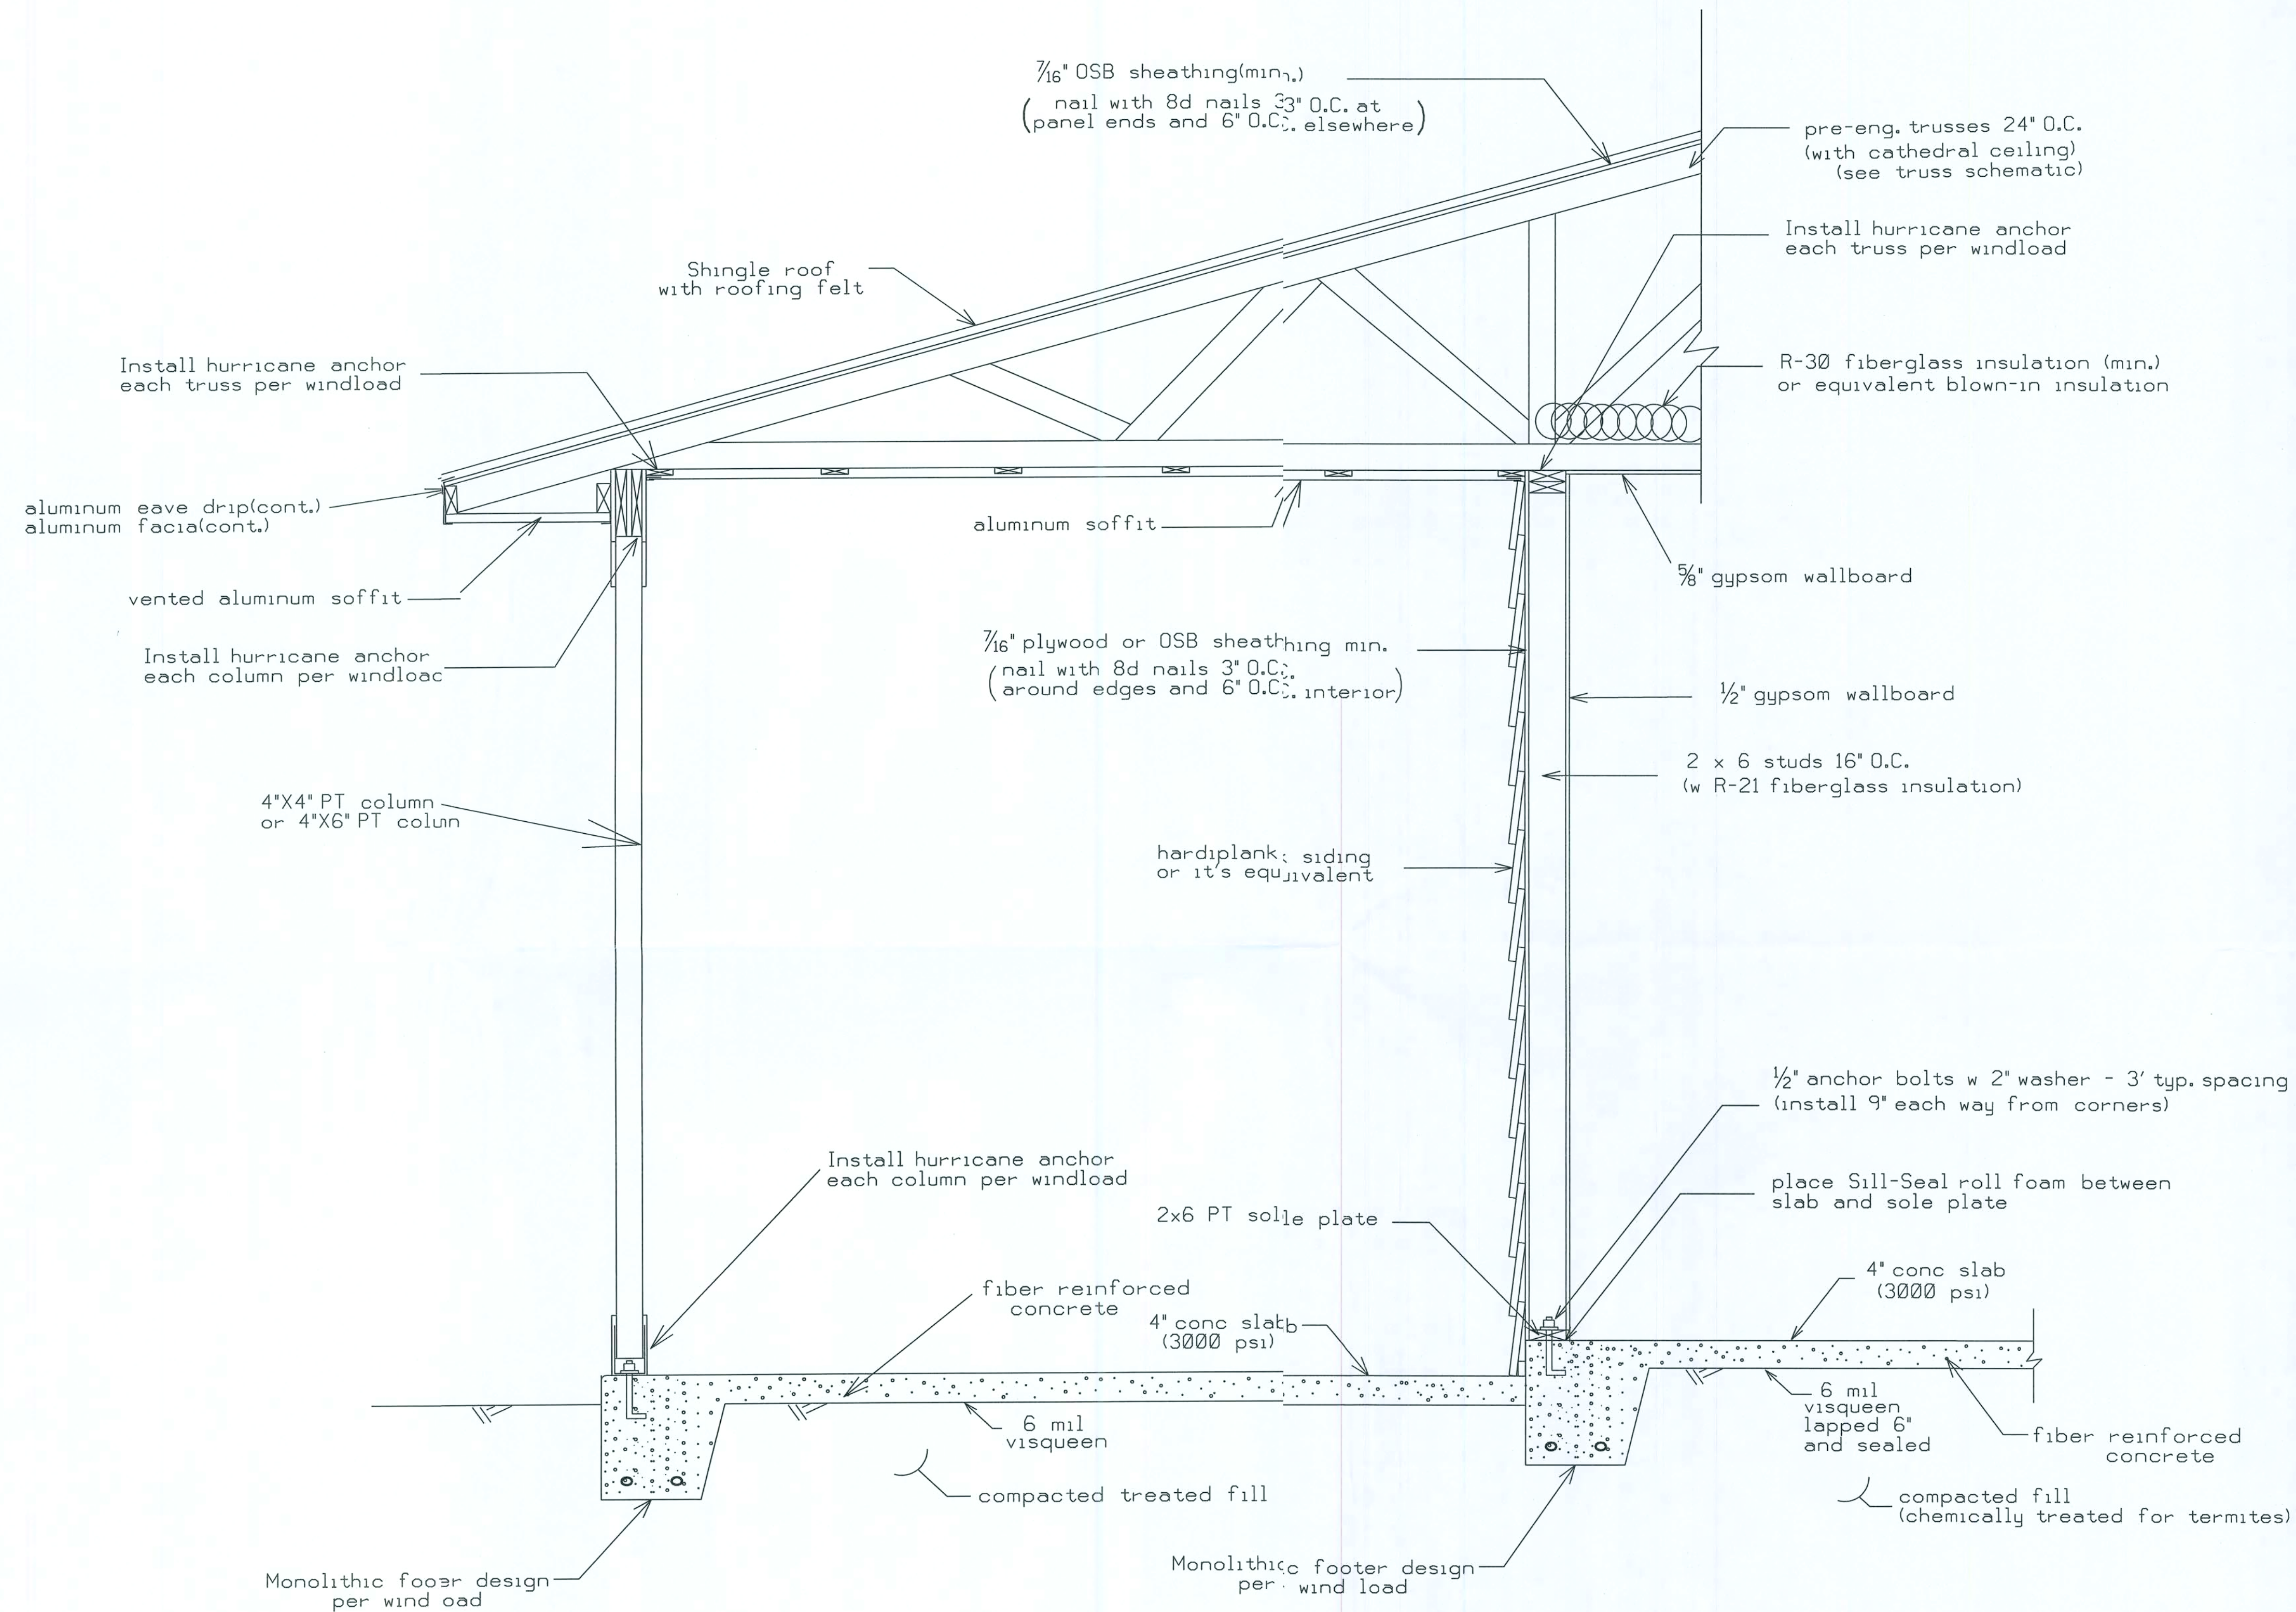


Note: The size of the headers for windows and doors as well as the porch beam sizes shall be in accordance with the wind load.

TYPICAL WALL SECTION N.T.S.

PLANS PREPARED BY:
CHRISTOPHER Q. DICKS
4035 SE CR 252, LAKE CITY, FL 32025

KRUSE RESIDENCE
COLUMBIA COUNTY, FLORIDA

SHEET
5
OF
8

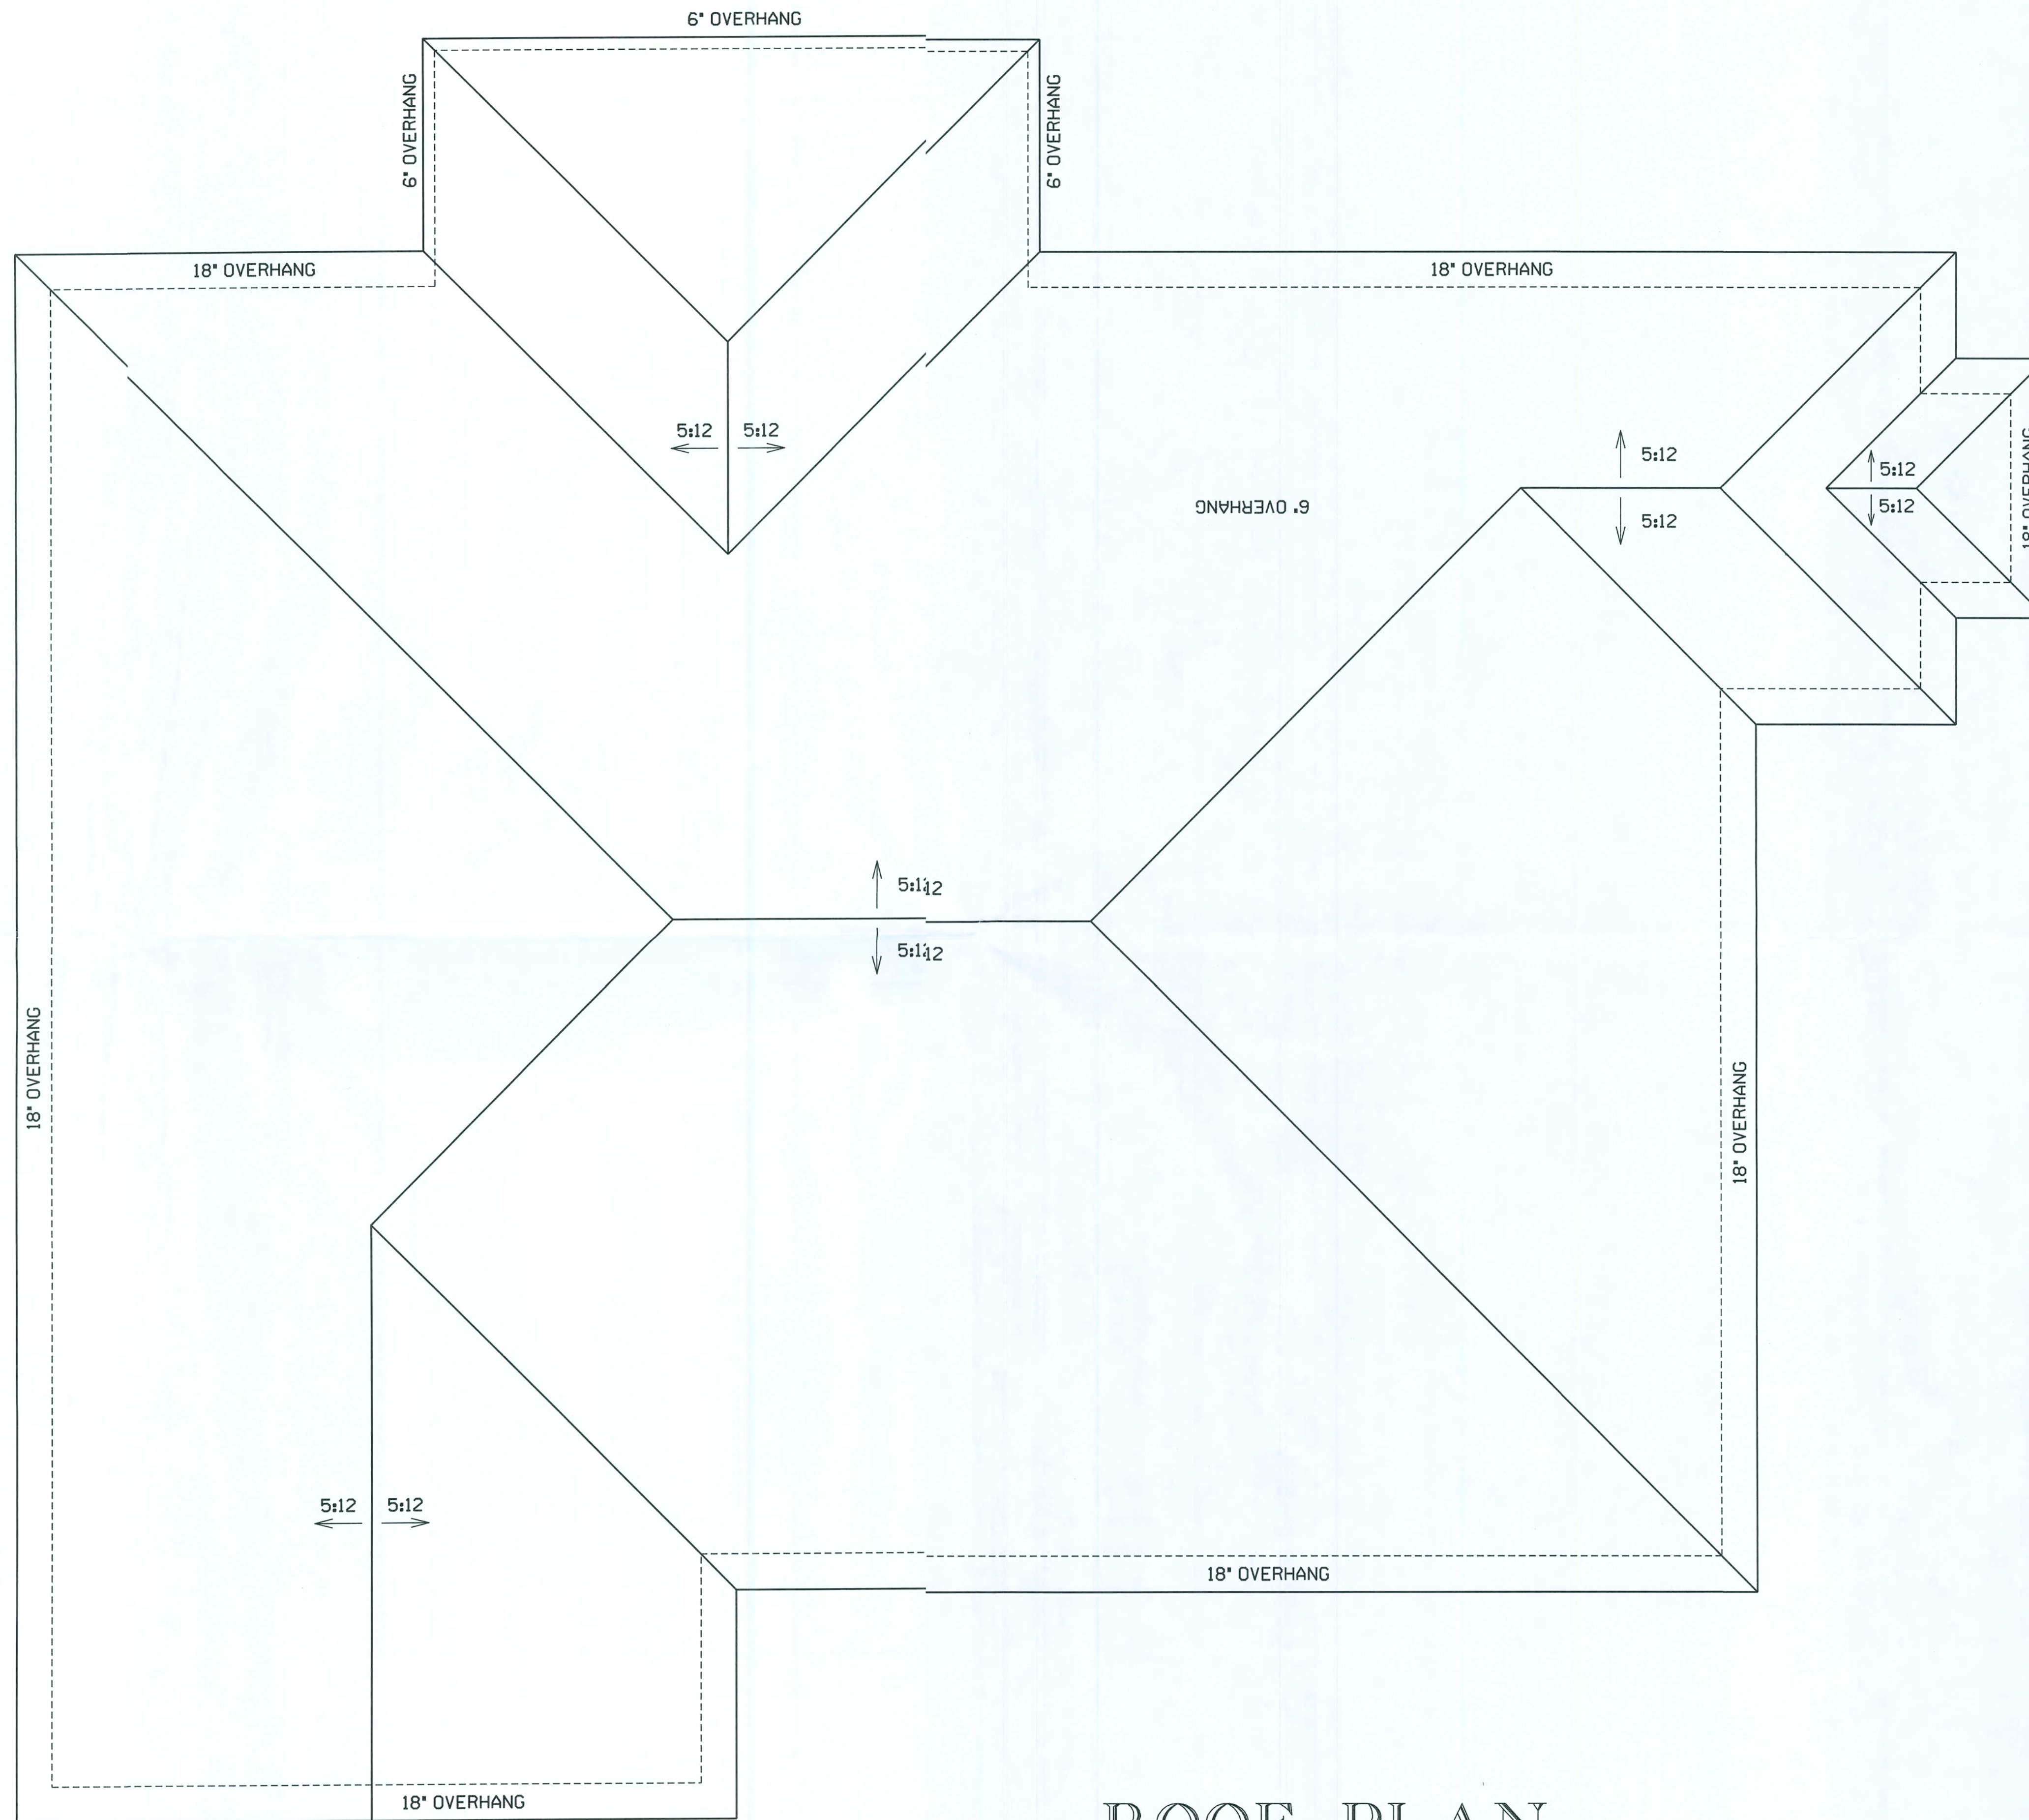


ROOF PLAN

KRUSE RESIDENCE
COLUMBIA COUNTY, FLORIDA

PLANS PREPARED BY:
CHRISTOPHER Q. DICKS
4035 SE CR 252, LAKE CITY, FL 32025

ELECTRICAL LEGEND

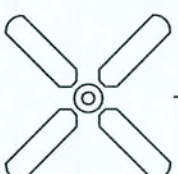-  - CEILING FAN w LIGHTS
-  - LIGHT FIXTURE
-  - SINGLE POLE SWITCH
-  - THREE-WAY SWITCH
-  - RECEPT.
-  - RECEPT OR PART OF A GFI CIRCUIT
-  - FLOOR RECEPT.
-  - SECURITY LIGHT
-  - EXHAUST WITH LIGHT
-  - 220 V.
-  - SMOKE DETECTOR (AC/DC and interconnected)
-  - TELEPHONE AND RG6 COAX
-  - ELECTRICAL SERVICE METER CAN

60 AMP DISCONNECT

A/C #2

ELECTRICAL PLAN

0 4' 8'
scale

- NOTES:
- 1.) ALL EXTERIOR RECEPTACLES SHALL BE WEATHERPROOF.
 - 2.) ALL BEDROOM RECPTS SHALL BE PART OF AN AFCI CIRCUIT. EACH BEDROOM SHALL BE ON AN INDIVIDUAL AFC CIRCUIT.

PLANS PREPARED BY:
CHRISTOPHER Q. DICKS
4035 SE CR 252, LAKE CITY, FL 32025

KRUSE RESIDENCE
COLUMBIA COUNTY, FLORIDA

SHEET
8
OF
8