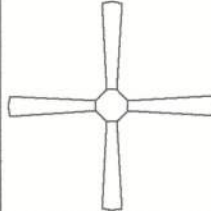


| ELECTRICAL LEGEND                                                                   |                                                   |
|-------------------------------------------------------------------------------------|---------------------------------------------------|
|    | CEILING FAN<br>(PRE-WIRE FOR LIGHT KIT)           |
|    | DOUBLE SECURITY LIGHT                             |
|    | RECESSED CAN LIGHT                                |
|    | BATH EXHAUST FAN                                  |
|    | LIGHT FIXTURE                                     |
|    | DUPLEX OUTLET (AFCI & TAMPER RESISTANT)           |
|    | 220v OUTLET                                       |
|    | GFI DUPLEX OUTLET (PER NEC 406.8)                 |
|    | TELEVISION JACK                                   |
|    | CIRCUIT FOR MINI-SPLIT A/C UNIT                   |
|    | SMOKE / CARBON MONOXIDE DETECTOR (see note below) |
|  | WALL SWITCH                                       |
|  | 3 WAY WALL SWITCH                                 |
|  | WATER PROOF GFI OUTLET                            |
| 48" FLOOR:                                                                          | 2 OR 4 TUB FLOURESCENT FIXTURE                    |


NOTE:  
ALL INTERIOR RECEPTACLES SHALL BE AFCI  
(ARC FAULT CIRCUIT INTERRUPT) PER NEC 210.12 & TAMPER RESISTANT PER  
NEC 406.11

ALL INTERIOR & EXTERIOR LIGHTING SHALL MEET OR EXCEED THE MIN. 75% HIGH-EFFICIENCY  
LIGHTING PER FBC-ENERGY CONSERVATION R404.

ALL SMOKE DETECTORS BE A COMBO SMOKE & CARBON MONOXIDE DETECTOR  
AND SHALL HAVE BATTERY BACKUP POWER  
AND ALL WIRED TOGETHER SO IF ANY ONE UNIT IS ACTUATED THEY  
ALL ACTIVATE.

THE ELECTRICAL SERVICE OVERCURRENT PROTECTION DEVICE SHALL BE  
INSTALLED ON THE EXTERIOR OF STRUCTURES TO SERVE AS A DISCONNECT MEANS.  
CONDUCTORS USED FROM THE EXTERIOR DISCONNECTING MEANS TO A PANEL OR SUB  
PANEL SHALL HAVE FOUR-WIRE CONDUCTORS, OF WHICH ONE CONDUCTOR  
SHALL BE USED AS AN EQUIPMENT GROUND.

IT IS THE LICENSED ELECTRICAL CONTRACTORS RESPONSIBILITY TO INSURE THAT ALL  
WORK PERFORMED AND EQUIPMENT INSTALLED MEETS OR EXCEEDS THE 2017 (NFPA-70) NATIONAL  
ELECTRIC CODE AND ALL OTHER LOCAL CODES AND ORDINANCES.

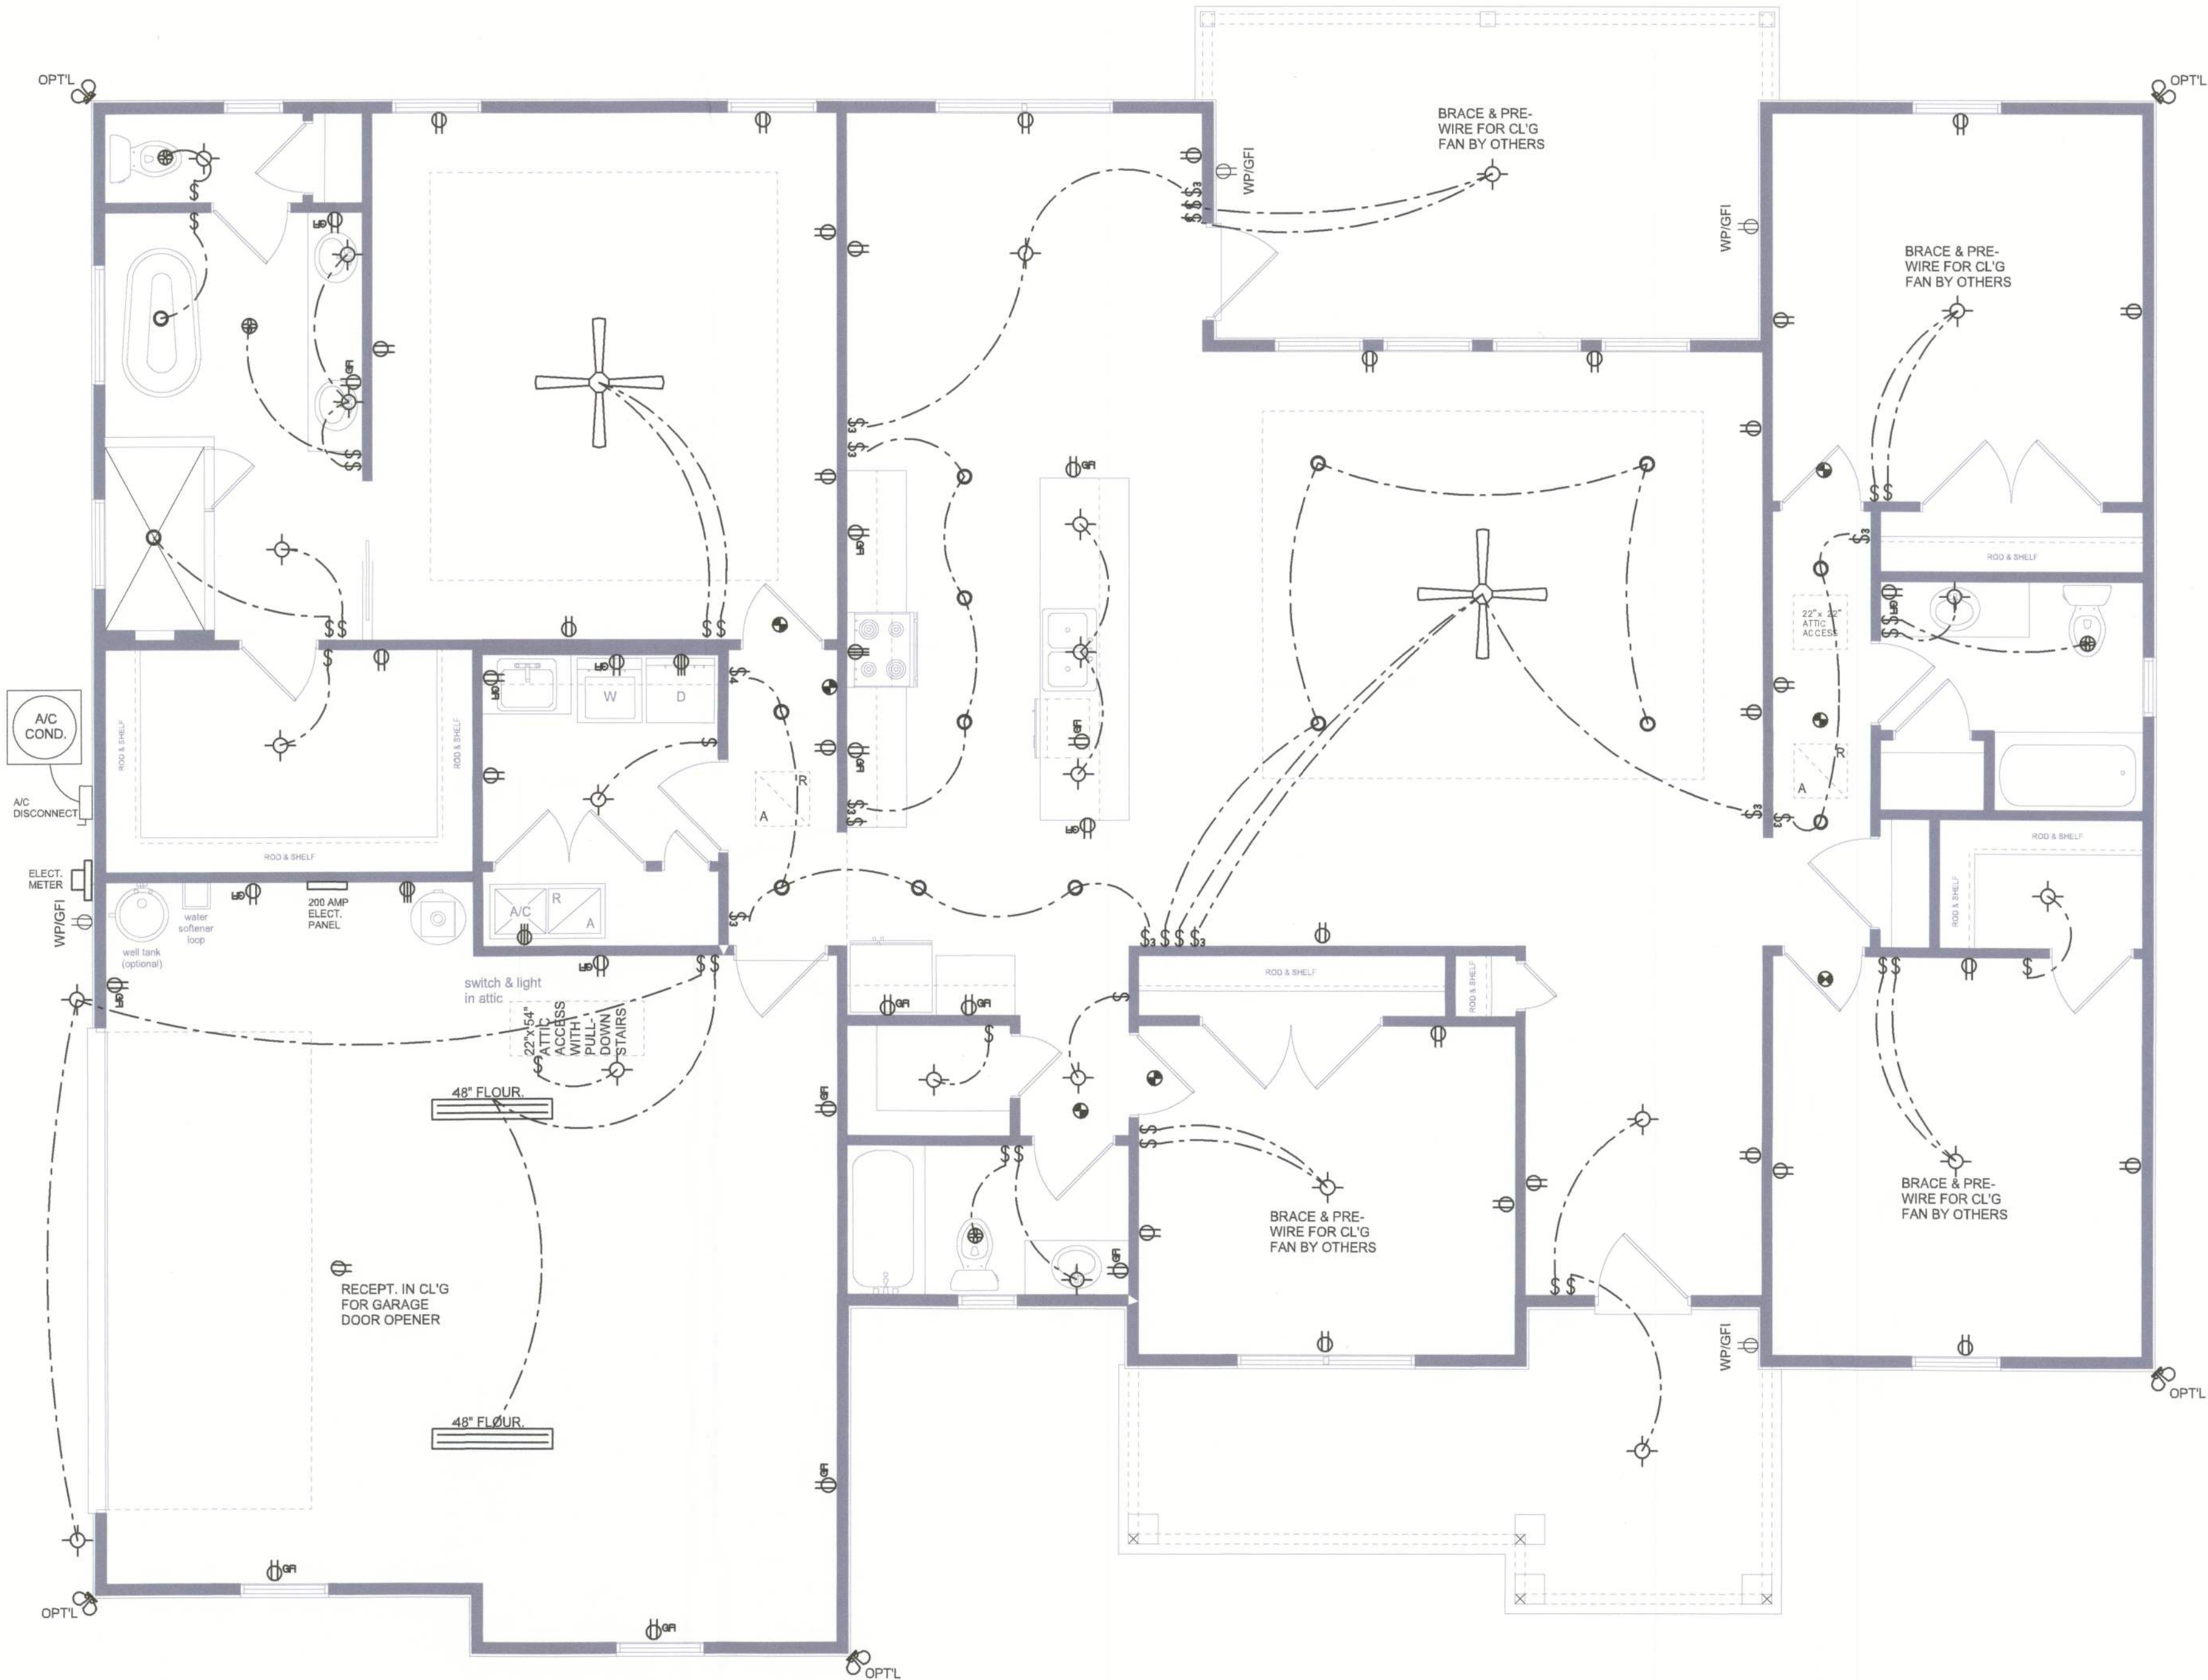

ELECTRICAL PLAN  
SCALE: 1/4" = 1'-0"

NOTE: ALL DRAWINGS NOT TO BE SCALED, WRITTEN DIMENSIONS TAKE PRECEDENCE OVER SCALED DIMENSIONS

| REVISIONS     |  |
|---------------|--|
| June 13, 2023 |  |
|               |  |
|               |  |
|               |  |

ELECTRICAL PLAN

SCALE: 1/4" = 1'-0"

THE WESTERN MODEL CUSTOM FOR:

**Charles & Nastoshia Miller**

PROJECT ADDRESS: 452 SW Mossy Oak Way Lake City, FL 32024

**GIBALTAR CONTRACTING, LLC.**

LIC# 1259633 HIGH SPRINGS, FLORIDA

© WM DESIGN & ASSOCIATES, INC.

426 SW COMMERCE DR. STE 130

LAKE CITY, FL 32025

(386) 758-8406

wm@wmymyers.net



JOB NUMBER

20230510

SHEET NUMBER

A.3

*Wm C. Myers*