


A CUSTOM CABIN FOR:

JOHN HADLEY

PROJECT ADDRESS:
826 NW ASH RD
COLUMBIA COUNTY, FLORIDA 32055

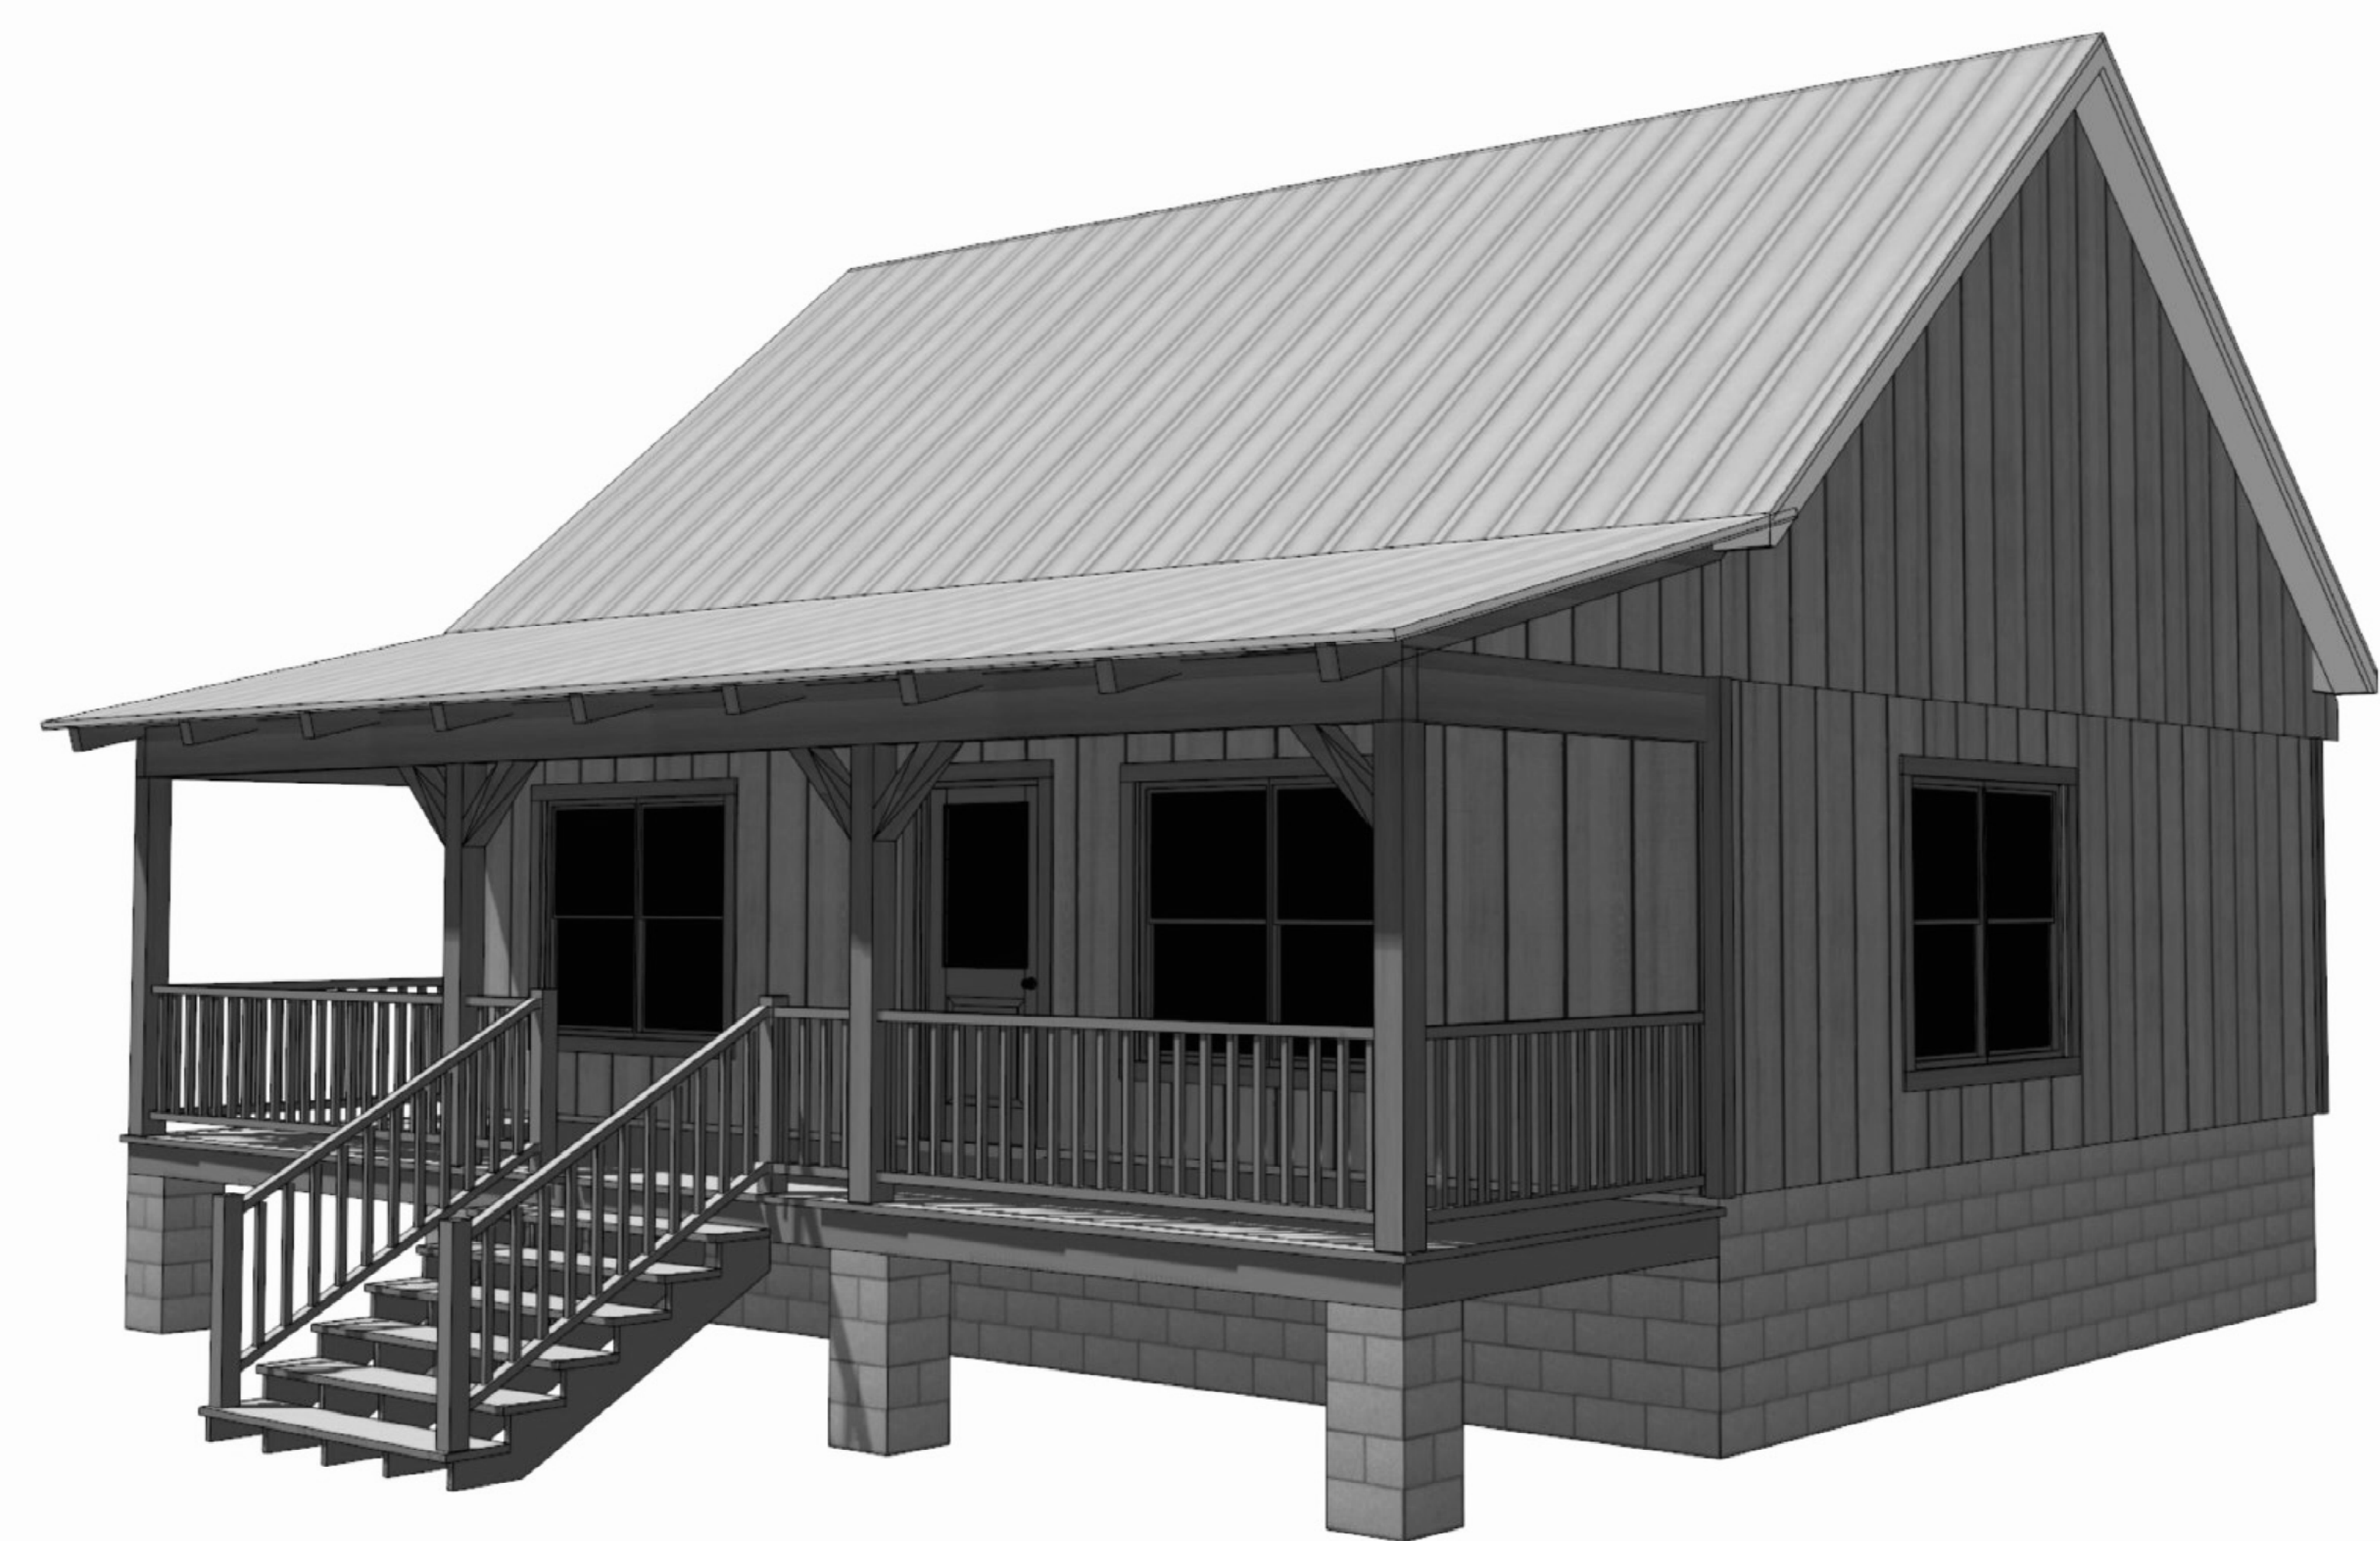

SHEET INDEX

- A1 EXTERIOR ELEVATIONS
- A2 DIMENSIONED FLOOR & ELECTRICAL PLANS
- S1 FOUNDATION PLAN, DETAILS & NOTES
- S2 ROOF PLAN, DETAILS & NOTES
- S3 WINDLOAD INFO, NOTES & DETAILS
- S4 FRAMING DETAILS & NOTES
- S5 FULL BUILDING SECTION 'A'

AREA SUMMARY		
LIVING AREA	768	S.F.
ENTRY PORCH AREA	160	S.F.
TOTAL AREA	928	S.F.

NOTE: ALL DRAWINGS NOT TO BE SCALED, WRITTEN DIMENSIONS TAKE PRECEDENCE OVER SCALED DIMENSIONS

REVISIONS

April 20, 2021

SOFTPLAN

ARCHITECTURAL DESIGN SOFTWARE

COVER PAGE

A CUSTOM HOME DESIGN FOR:

JOHN HADLEY

PROJECT ADDRESS: 826 NW ASH RD, COLUMBIA COUNTY, FLORIDA 32055

PARCEL # 21-3S-16-02215-014

© WM DESIGN & ASSOCIATES, INC.

426 SW COMMERCE DR. STE. 130

LAKE CITY, FL 32025

(386) 758-8406

will@willmymers.net

JOB NUMBER

20201230

SHEET NUMBER

COVER

Wm C. Myers

REVISIONS	
April 20, 2021	



EXTERIOR ELEVATIONS
SCALE: 1/4" = 1'-0"


A CUSTOM HOME DESIGN FOR:
JOHN HADLEY
PROJECT ADDRESS: 826 NW ASH RD, COLUMBIA COUNTY, FLORIDA 32055
PARCEL # 21-3S-16-02215-014

© WM DESIGN & ASSOCIATES, INC.
426 SW COMMERCE DR. STE 130
LAKE CITY, FL 32025
(386) 758-8406
will@willmyers.net




JOB NUMBER
20201230

SHEET NUMBER
A.1

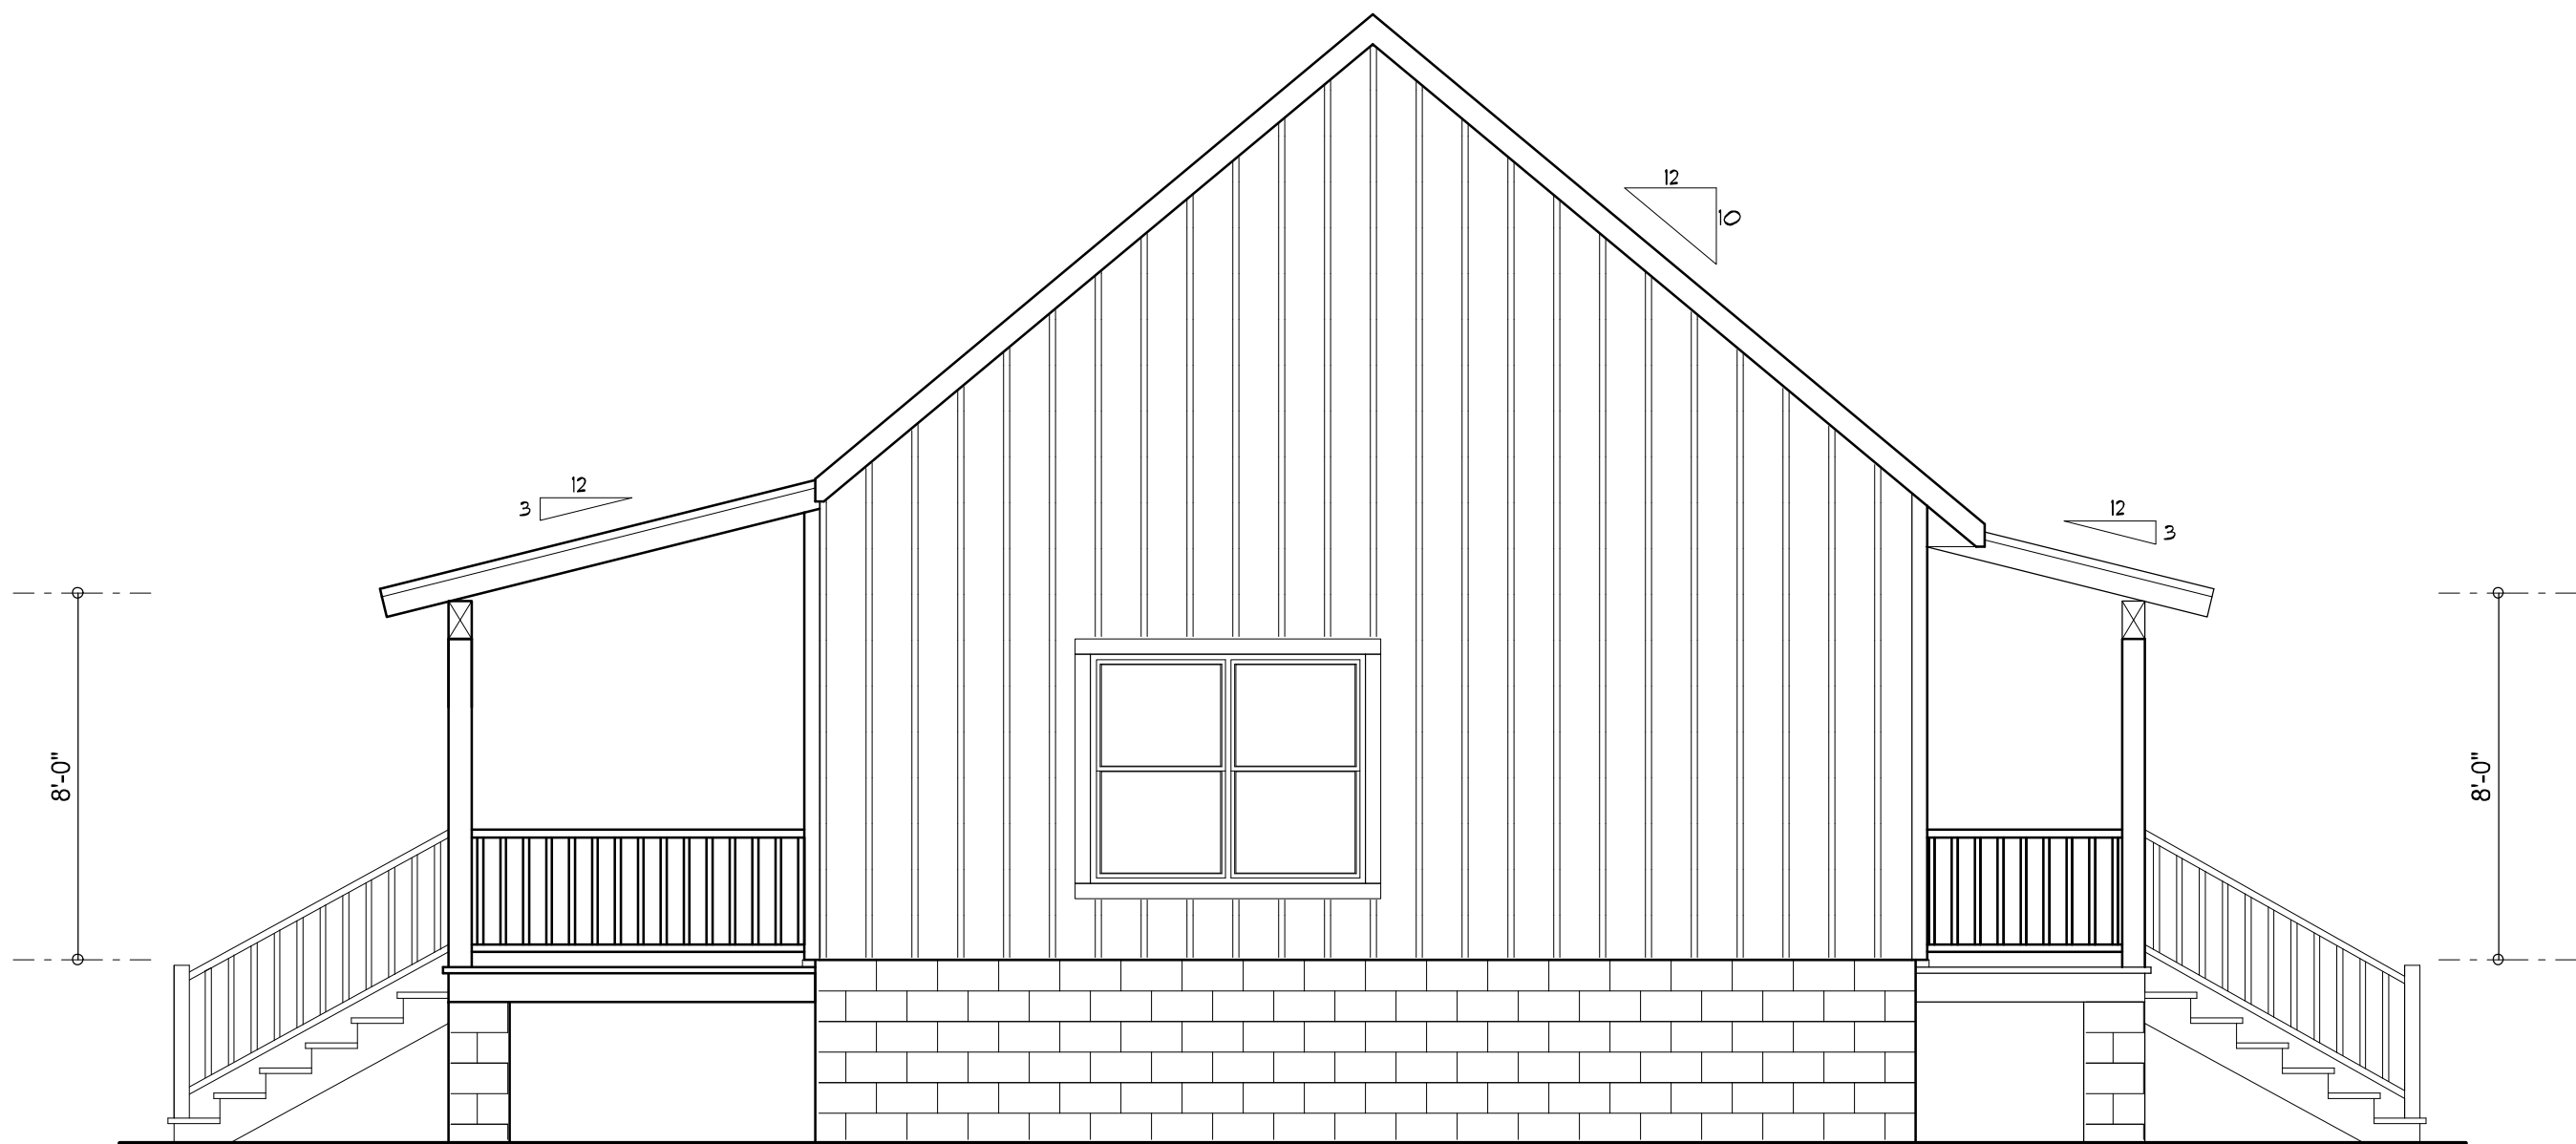

RIGHT ELEVATION
SCALE: 1/4" = 1'-0"

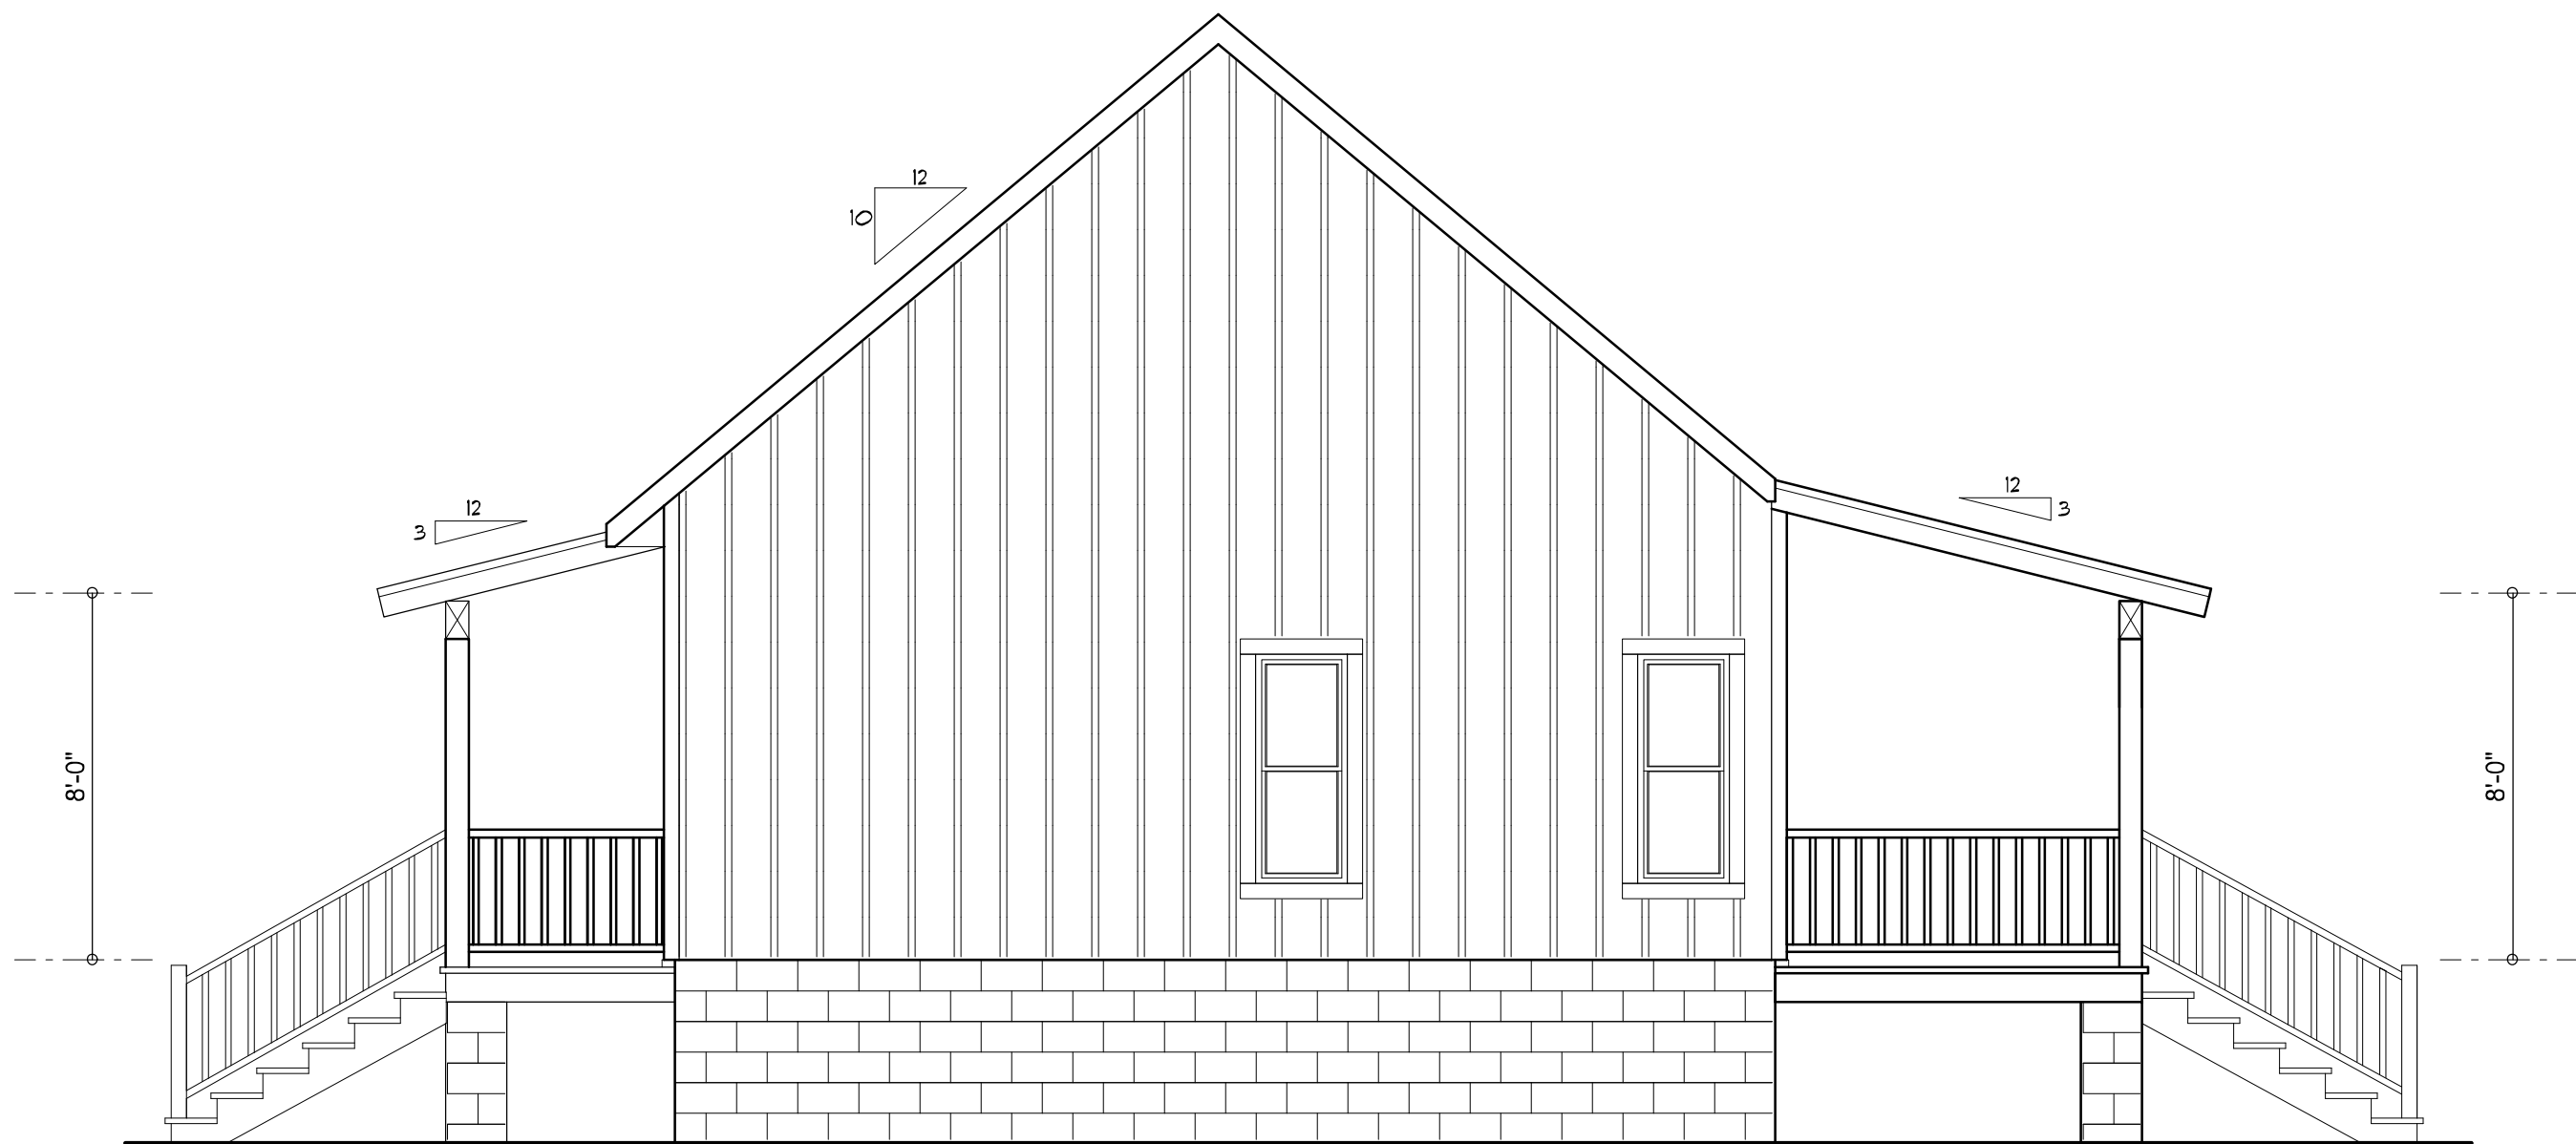

LEFT ELEVATION
SCALE: 1/4" = 1'-0"




REAR ELEVATION
SCALE: 1/4" = 1'-0"



FRONT ELEVATION
SCALE: 1/4" = 1'-0"

NOTE: ALL DRAWINGS NOT TO BE SCALED, WRITTEN DIMENSIONS TAKE PRECEDENCE OVER SCALED DIMENSIONS

Will C. Myers

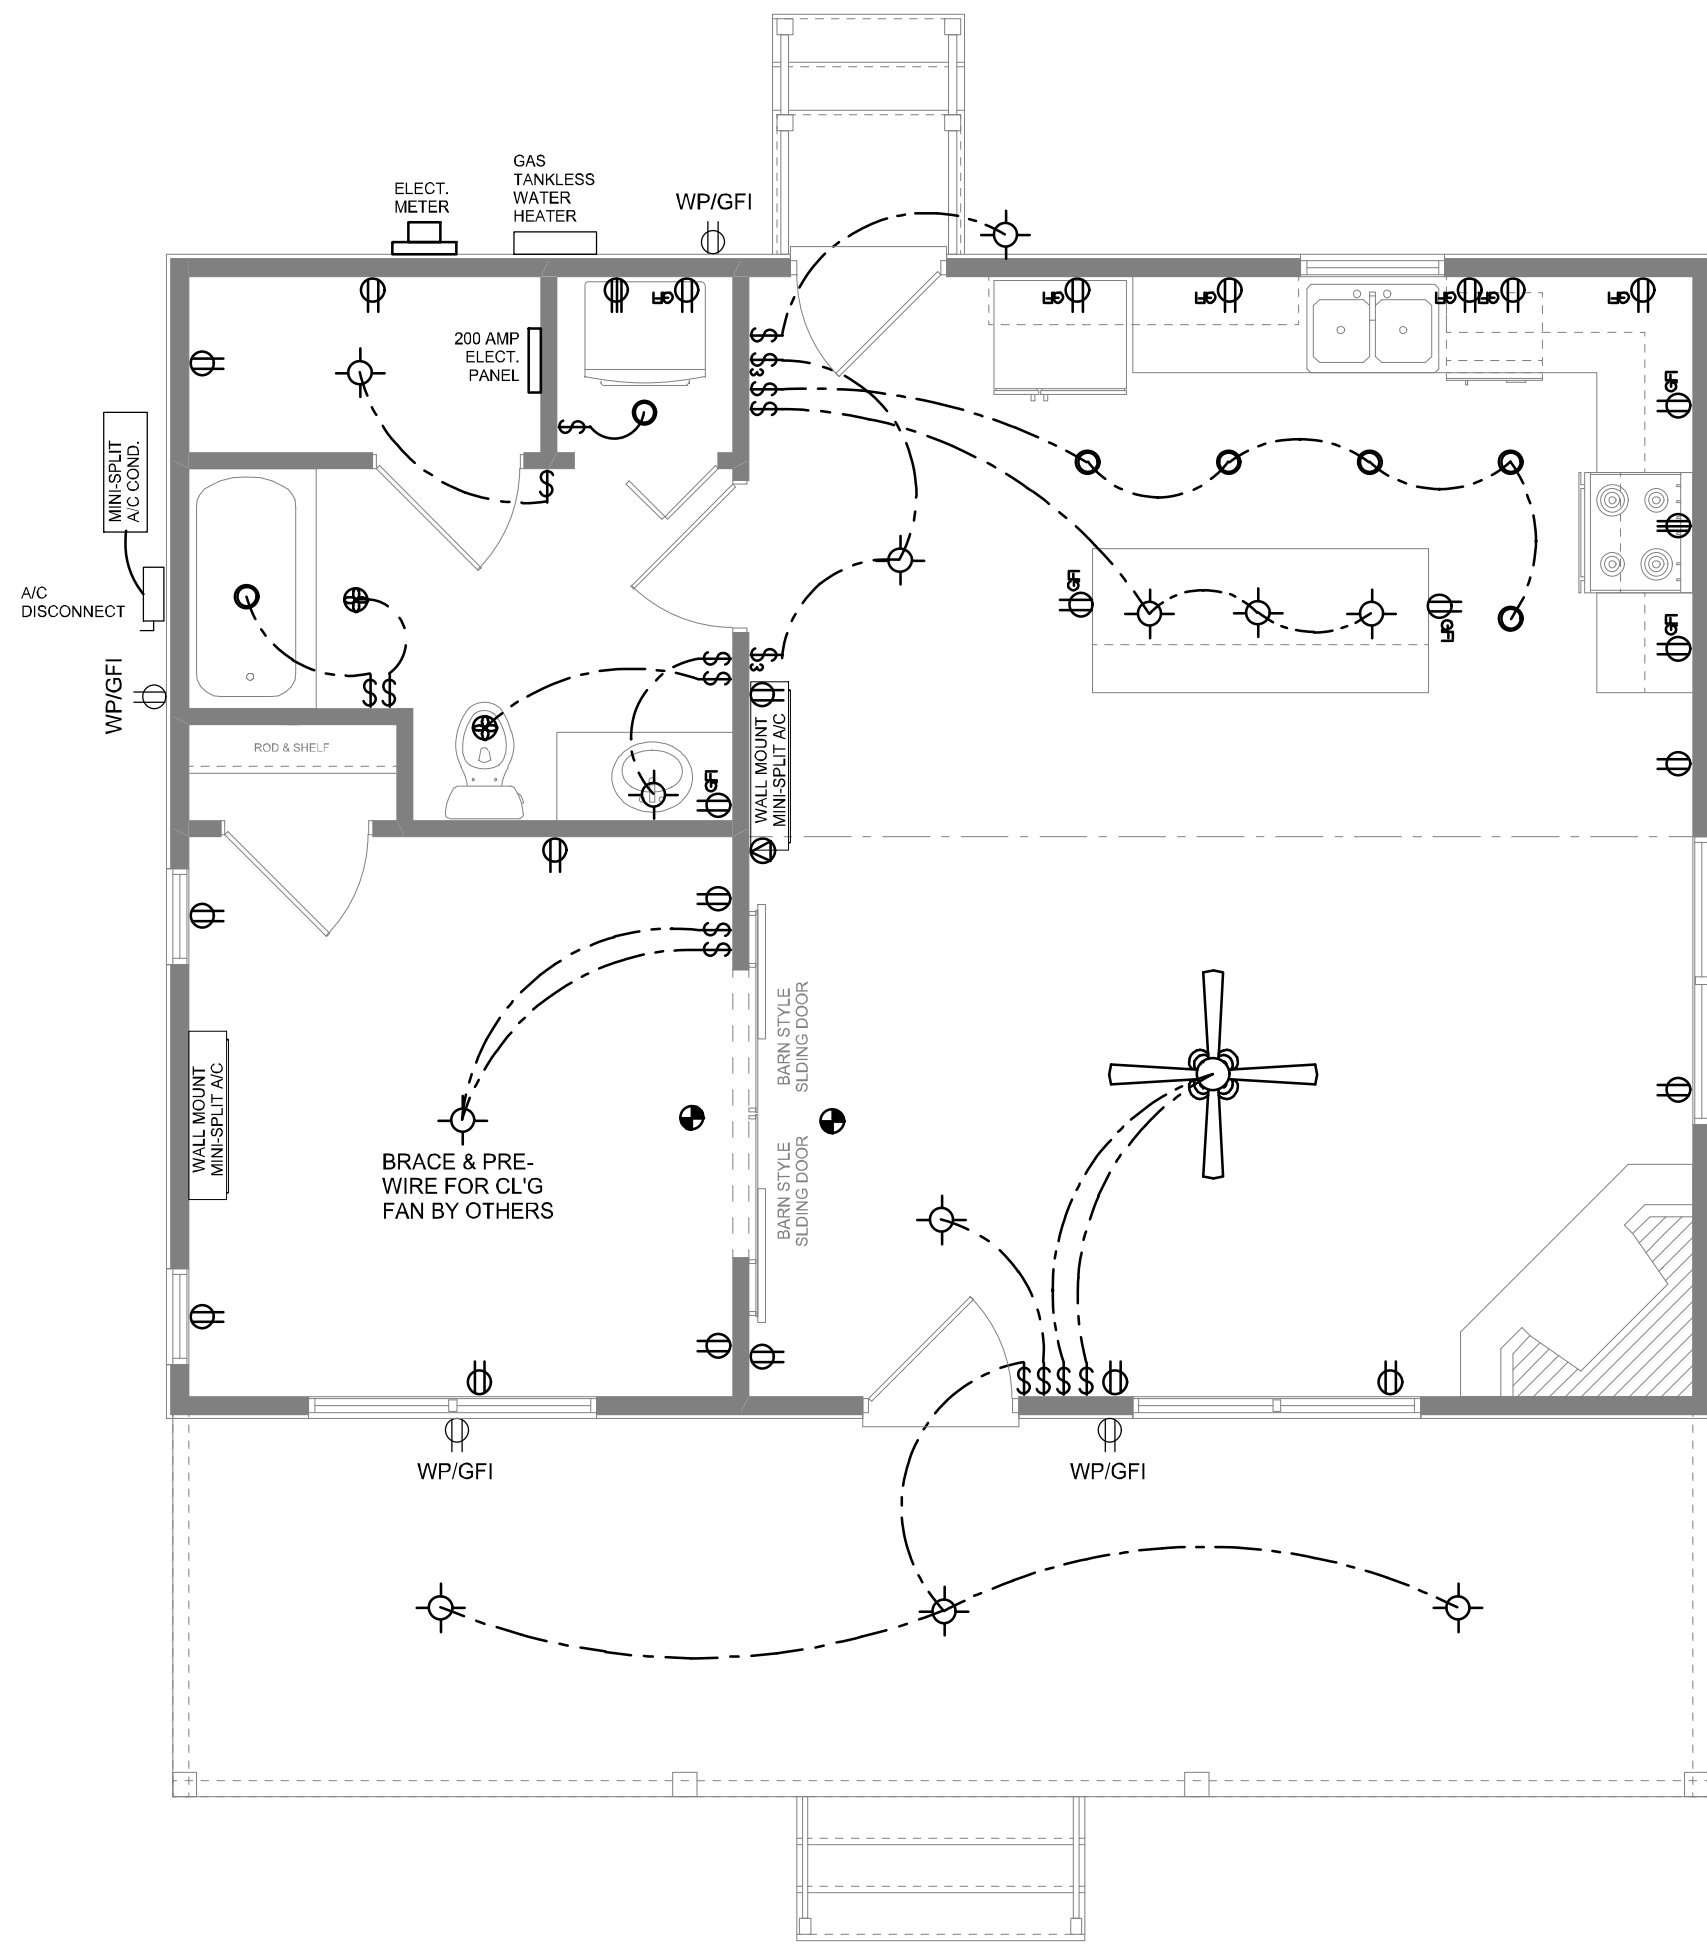

ELECTRICAL PLAN
SCALE: 1/4" = 1'-0"

ELECTRICAL LEGEND	
	CEILING FAN (PRE-WIRE FOR LIGHT KIT)
	DOUBLE SECURITY LIGHT
	RECESSED CAN LIGHT
	BATH EXHAUST FAN
	LIGHT FIXTURE
	DUPLEX OUTLET (AFCI & TAMPER RESISTANT)
	220v OUTLET
	GFI DUPLEX OUTLET (PER NEC 406.8)
	TELEVISION JACK
	CIRCUIT FOR MINI-SPLIT A/C UNIT
	SMOKE / CARBON MONOXIDE DETECTOR (see note below)
	WALL SWITCH
	3 WAY WALL SWITCH
	WATER PROOF GFI OUTLET
	2 OR 4 TUB FLUORESCENT FIXTURE


NOTE:
ALL INTERIOR RECEPTACLES SHALL BE AFCI
(ARC FAULT CIRCUIT INTERRUPT) PER NEC 210.12 & TAMPER RESISTANT PER
NEC 406.11

ALL INTERIOR & EXTERIOR LIGHTING SHALL MEET OR EXCEED THE MIN. 75% HIGH-EFFICIENCY
LIGHTING PER FBC-ENERGY CONSERVATION R404.

ALL SMOKE DETECTORS BE A COMBO SMOKE & CARBON MONOXIDE DETECTOR
AND SHALL HAVE BATTERY BACKUP POWER
AND ALL WIRED TOGETHER SO IF ANY ONE UNIT IS ACTUATED THEY
ALL ACTIVATE.

THE ELECTRICAL SERVICE OVERCURRENT PROTECTION DEVICE SHALL BE
INSTALLED ON THE EXTERIOR OF STRUCTURES TO SERVE AS A DISCONNECT MEANS.
CONDUCTORS USED FROM THE EXTERIOR DISCONNECTING MEANS TO A PANEL OR SUB
PANEL SHALL HAVE FOUR-WIRE CONDUCTORS, OF WHICH ONE CONDUCTOR
SHALL BE USED AS AN EQUIPMENT GROUND.

IT IS THE LICENSED ELECTRICAL CONTRACTORS RESPONSIBILITY TO INSURE THAT ALL
WORK PERFORMED AND EQUIPMENT INSTALLED MEETS OR EXCEEDS THE NFPA70 2014 NATIONAL
ELECTRIC CODE AND ALL OTHER LOCAL CODES AND ORDINANCES.

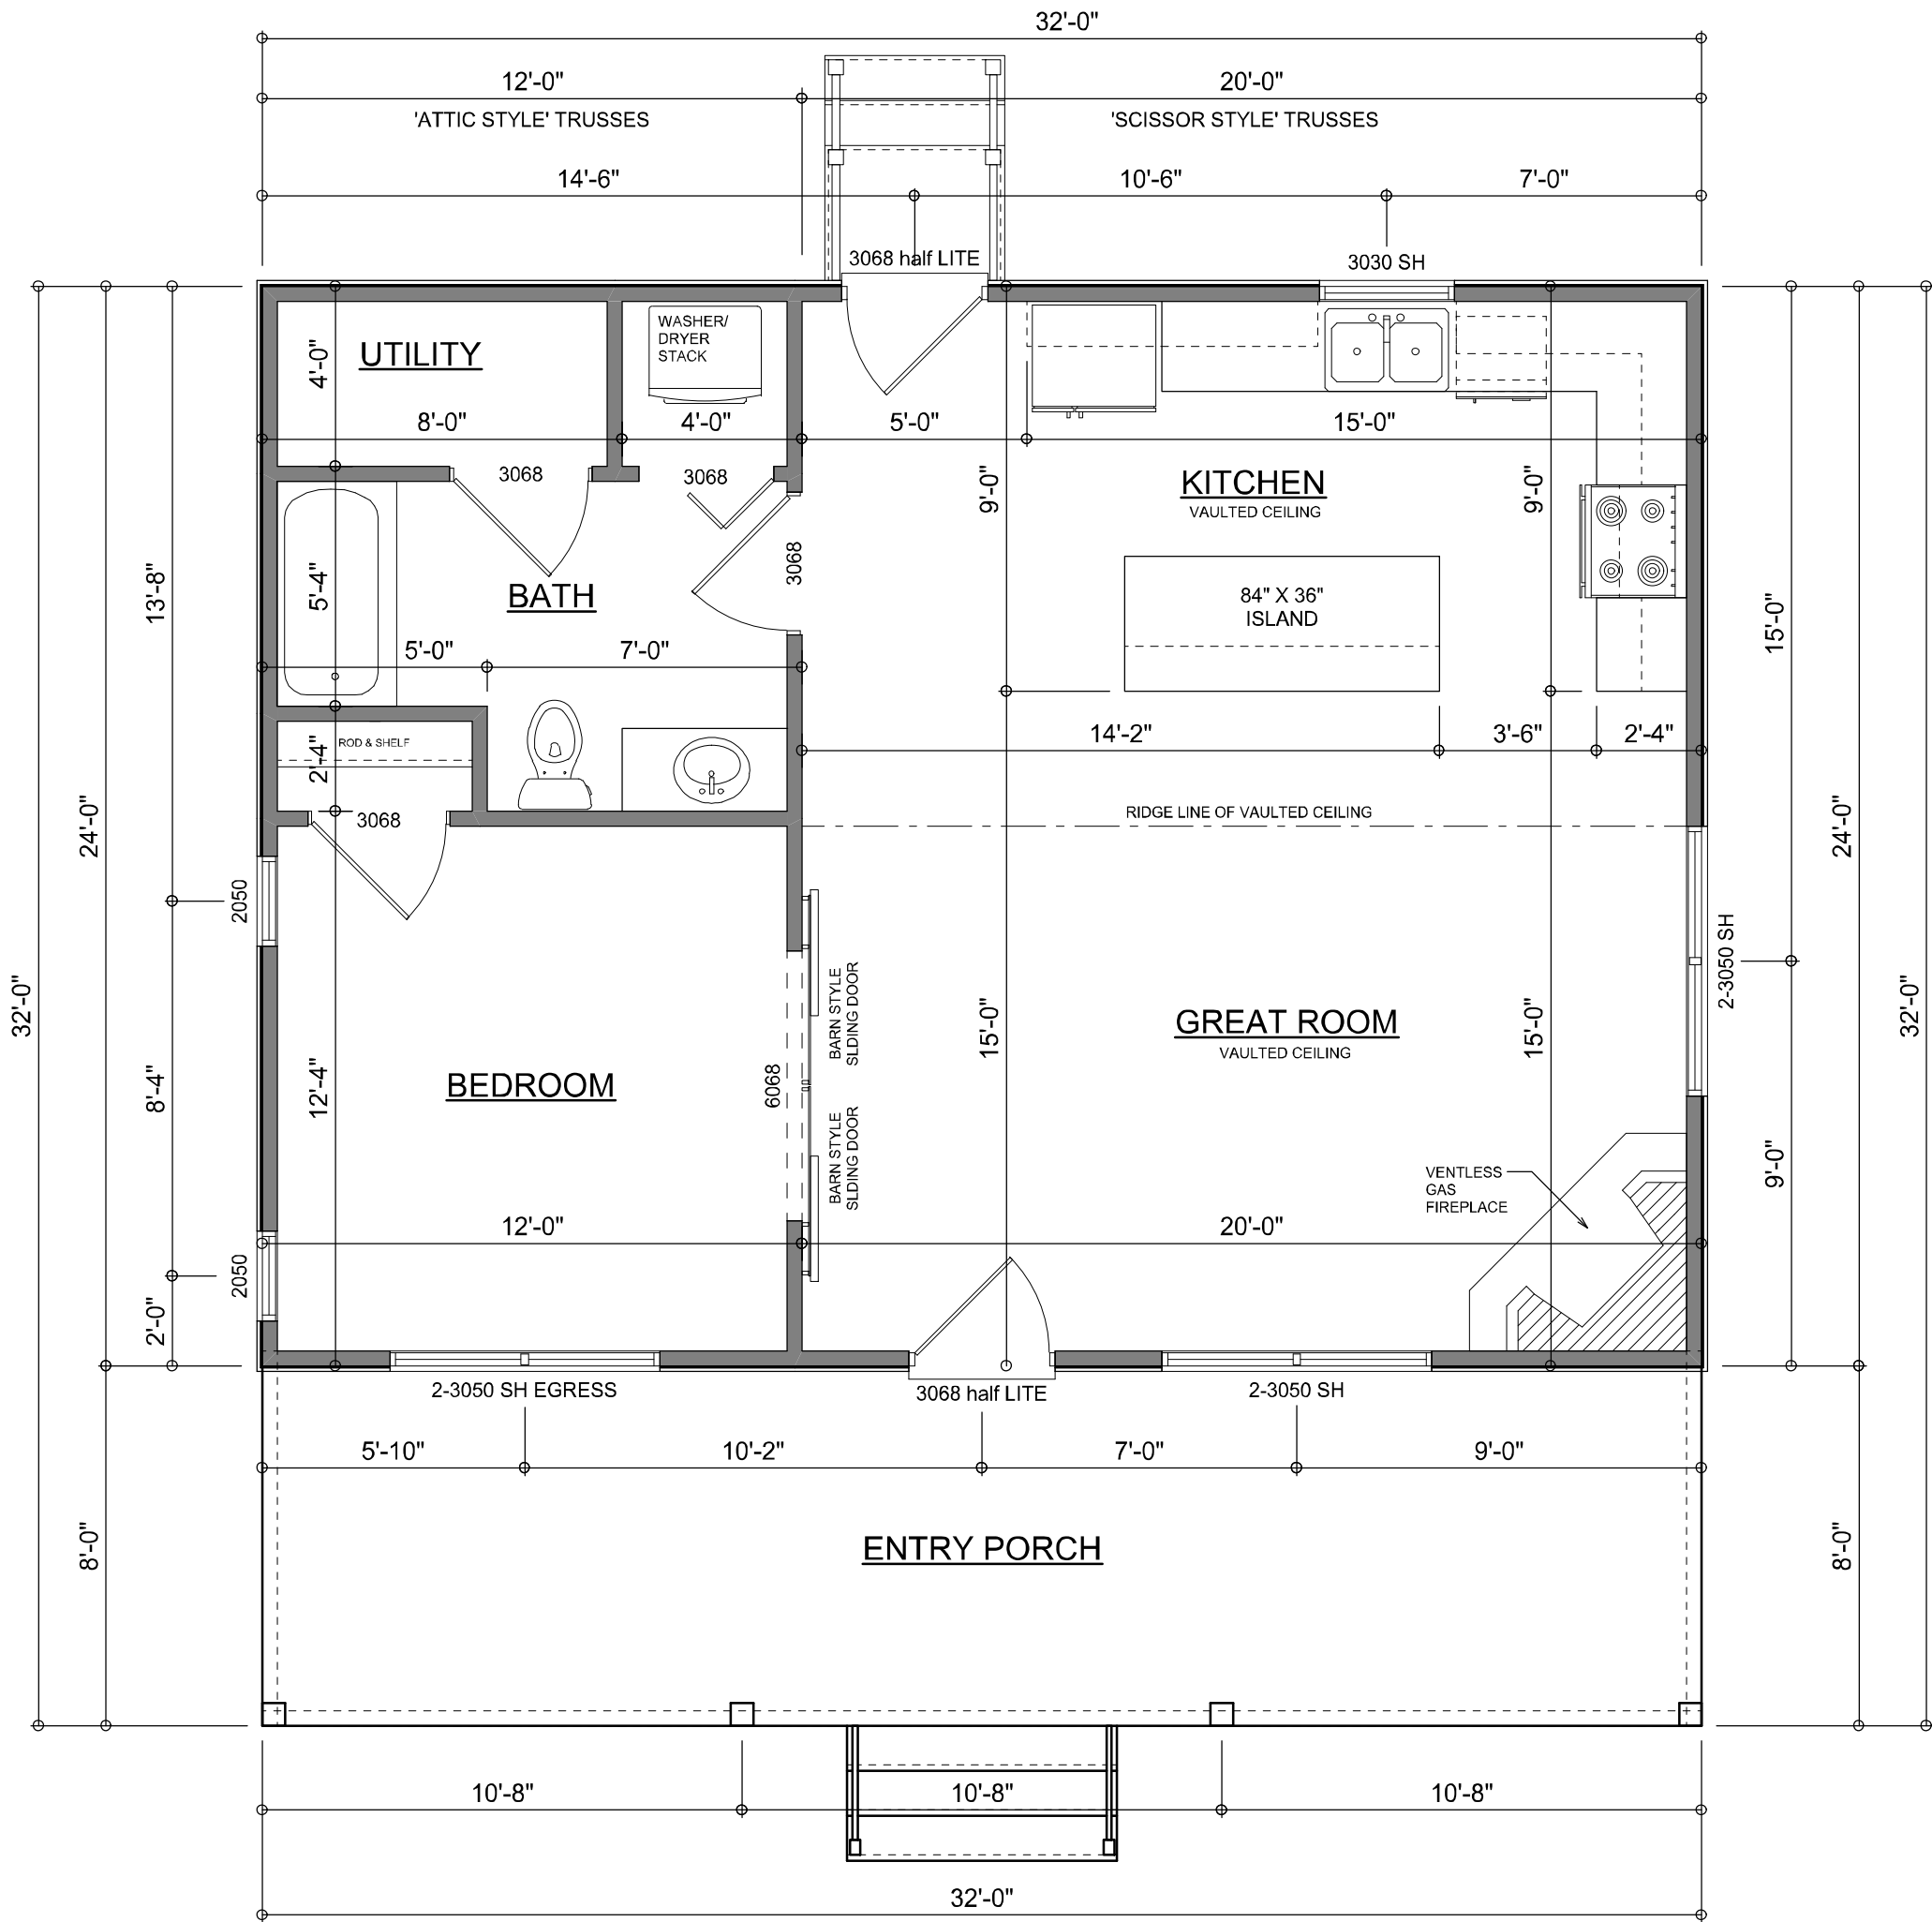

FLOOR PLAN
SCALE: 1/4" = 1'-0"

NOTE: ALL WALLS SHALL BE 8'-0" UNLESS OTHERWISE NOTED.

AREA SUMMARY

LIVING AREA	768	S.F.
ENTRY PORCH AREA	160	S.F.
TOTAL AREA	928	S.F.

REVISIONS
January 11, 2021

SOFTPLAN
ARCHITECTURAL DESIGN SOFTWARE

DIMENSIONED FLOOR PLAN
SCALE: 1/4" = 1'-0"

ELECTRICAL PLAN
SCALE: 1/4" = 1'-0"

A CUSTOM HOME DESIGN FOR:
JOHN HADLEY

PROJECT ADDRESS: NW ASH DRIVE, COLUMBIA COUNTY, FLORIDA
PARCEL # 21-3S-16-02215-014

© WM DESIGN &
ASSOCIATES, INC.

428 SW COMMERCE DR. STE 130
LAKE CITY, FL 32025

(386) 758-8406
will@willmayers.net



JOB NUMBER

20201230

SHEET NUMBER

A.2

NOTE: ALL DRAWINGS NOT TO BE SCALED, WRITTEN DIMENSIONS TAKE PRECEDENCE OVER SCALED DIMENSIONS

Will C. May