



RESIDENCE
FOR

KIM McCONNELL
AND
DANIEL McCONNELL

18818 SOUTH US HIGHWAY 441
HIGH SPRINGS, FL 32643

DATE	DESCRIPTION

CONSTRUCTION DOCUMENTS


PROJECT NO. 2405

DATE: 11 OCTOBER 2024

SHEET:

A-01

OF: ELEVEN

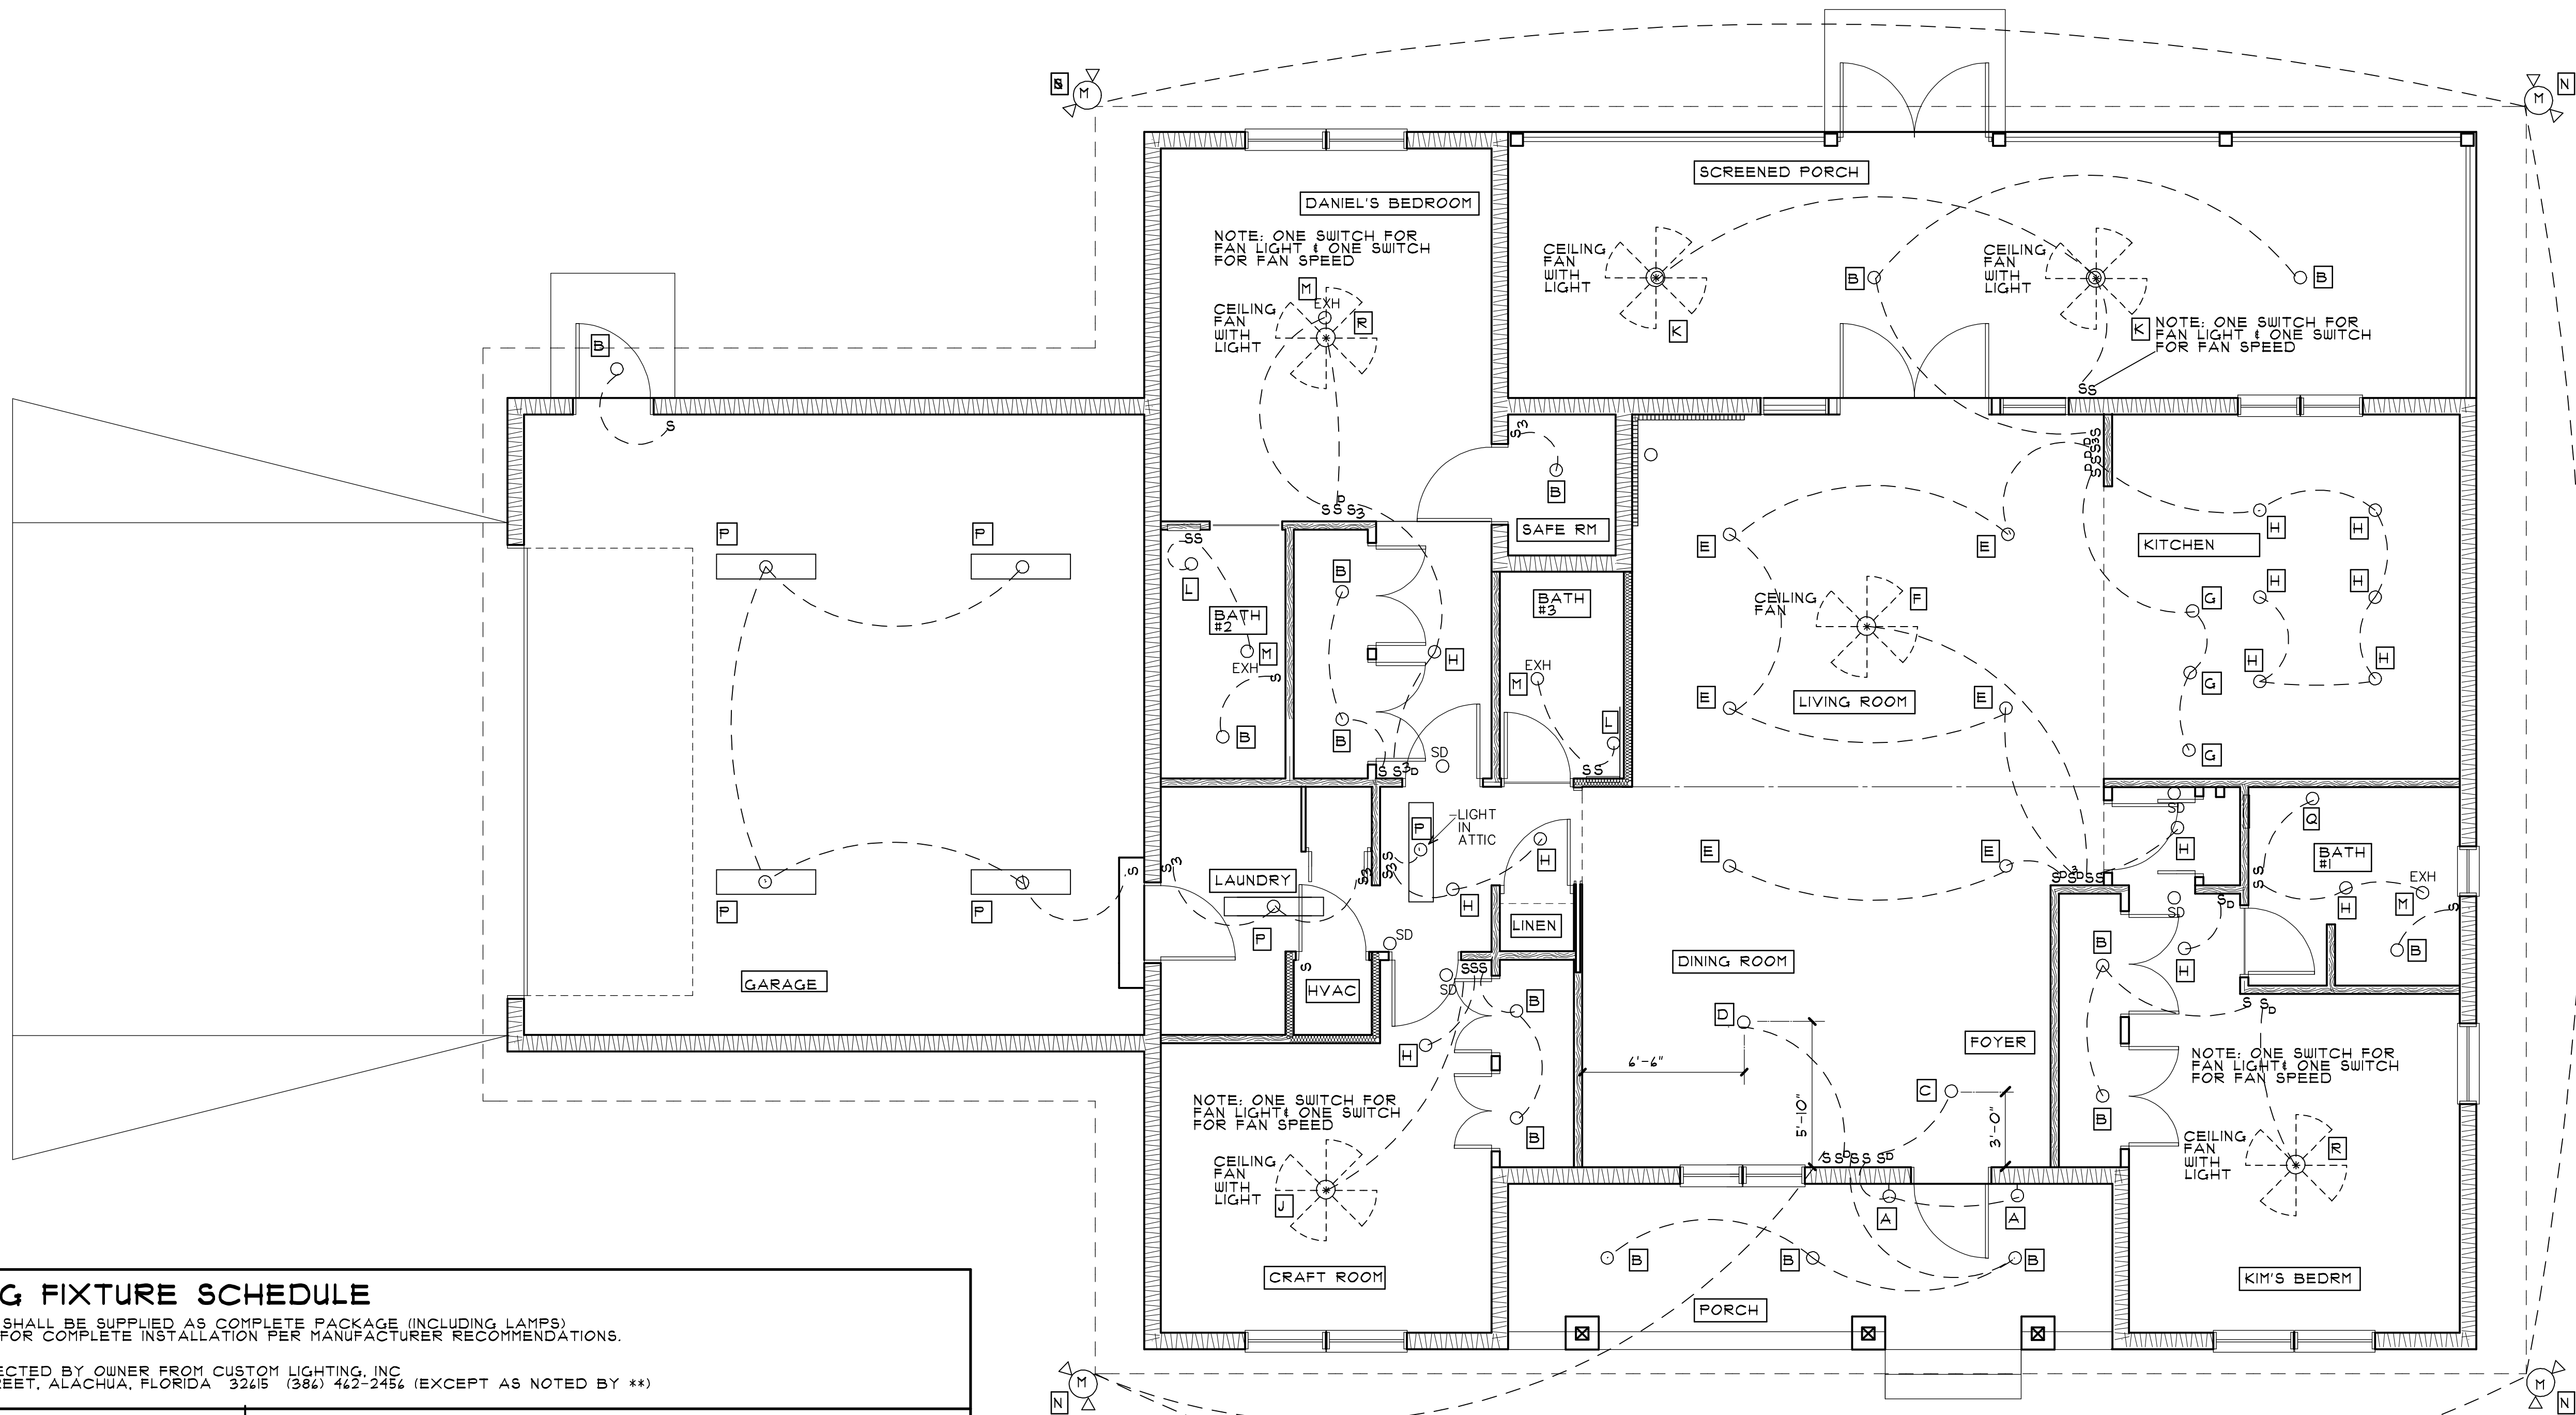

LIGHTING FIXTURE SCHEDULE

ALL FIXTURES SHALL BE SUPPLIED AS COMPLETE PACKAGE (INCLUDING LAMPS)
AS REQUIRED FOR COMPLETE INSTALLATION PER MANUFACTURER RECOMMENDATIONS.

FIXTURES SELECTED BY OWNER FROM CUSTOM LIGHTING, INC
14545 MAIN STREET, ALACHUA, FLORIDA 32415 (386) 462-2456 (EXCEPT AS NOTED BY **)

MARK	FIXTURE	DESCRIPTION
A	WALL MOUNTED FIXTURE/EXTERIOR	2150 OZ
B	RECESSED FIXTURE/INT. EXT	HALO QUICKLINK/LT4-DM TRIAC LOW VOLTAGE KIT WITH DRIVER**
C	CLG HUNG CHANDLIER ON ROD	538131 WG
D	CLG HUNG CHANDLIER ON ROD	4384 MG
E	RECESSED FIXTURES/SLOPED CLG	HALO HL4 SERIES/ALLSLOPE LED RECESSED **
F	CLG FAN ON ROD	78605-86 CHATEAUZ 40" OILED BRONZE WITH WALNUT/OILED BRONZE BLADES
G	KITCHEN PENDANTS	206-AB-G18 FROSTED
H	RECESSED FIXTURES/FLAT CLG	HALO QUICKLINK/LT4-DM TRIAC LOW VOLTAGE LIGHTING KIT **
J	CLG FAN WITH LIGHT ON ROD	F695-WH
K	W/ CLG FAN WITH LIGHT ON ROD	F589-MW
L	CLG MOUNT FIXTURE OVER LAV	205-AB-G18 FROSTED
M	EXHAUST FAN	SEE SCHEDULE/SHEET A-04
N	MOTION SENSOR EAVE MOUNTED	DEFIANT, 1400 LUMEN, TWIN HEAD WHITE MOTION SENSOR, 180 DEGREE LED SECURITY FLOOD LIGHT **
O	NOT USED	NOT USED
P	CLG MOUNT IX4 LED	COMMERCIAL ELECTRIC, LED IX4 FRAMELESS PANEL WITH DIMMER **
Q	CLG MOUNT FIXTURE OVER LAV	215-AB-G18 FROSTED
R	CLG FAN WITH LIGHT ON ROD	F696-WH


LAMPS AND ACCESSORIES FOR FIXTURES

LAMPS FOR FIXTURES:
A,C,D,F,G,J,K,L,M,O,R
WILL BE PROVIDED BY CUSTOM LIGHTING, INC
IN PACKAGE AS SELECTED BY OWNER.

LAMPS FOR FIXTURES "B, E, H"
RECEIVER ONLY FOR LIGHT KIT K9115L WARM COLOR RANGE
L001047010

LAMPS FOR FIXTURE "P"
COOL COLOR RANGE

LIGHTING PLAN

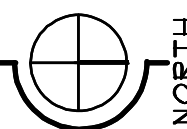

SCALE 1/4"=1'-0"