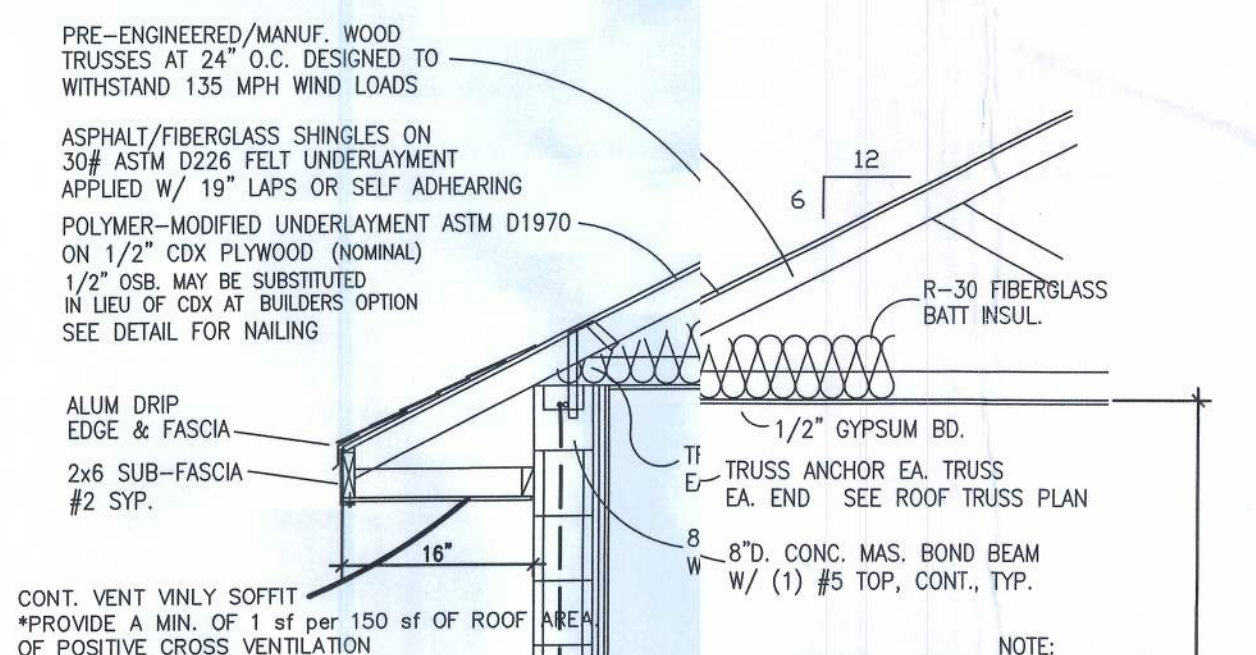


NOTE: ALL ELEVATION HGT.'S ARE REFERENCED FROM THE NORM.F. ELEV. OF +0'0"

SOPFIT TABLE VENT SPECS

Double 5" perforated soffits have a 6.20 sq. inches/sq. foot rating

Triple 4" center vent soffit has a 1.95G sq. inches/sq. foot rating

Triple 4" full vent soffit has a 5.067 sq. inches/sq. foot rating

Triple 4" basketweave full vent has a 1.34 sq. inches/sq. foot rating

Triple 4" center vent has a 4.78 sq. inches/sq. foot rating

Double 4" full vent soffit has 2.6G sq. inches/sq. foot rating

Beaded hidden vent soffit has a 9.19 sq. inches/sq. foot rating

NOTE
7/16" O.S.B. NAILED WITH 8D @
O.C. IN FIELD & 4" O.C. ON EDGES.

Simpson Strong-Tie Co. Strong-Drive SDWC TRUSS Screws may be used for uplift connection in lieu of straps. Strong-Drive SDWC TRUSS Screws to be installed per manufacturer's specifications.

Simpson Strong-Tie Co. Titen HD Heavy-Duty Screw Anchors 5/8" x 8", maximum spacing of 42" o.c., may be used in lieu of 5/8"x10" anchor bolts with 3"x3"x1/8" washer. Titen HD Heavy-Duty Screw Anchors shall be installed per manufacturer's specifications.

- 4" O.C. GABLE END
- 6" O.C. EDGES (ALL ZONES)
- 6" O.C. INTERMEDIATE FRAMING (ZONE 3)
- 12" O.C. INTERMEDIATE FRAMING (ZONES 1 & 2)

OVERLAP ROOFING UNDERLAYMENT 4"(MIN) OVER HIPS AND RIDGES

BUTTON CAP NAILS ARE USED TO FASTEN UNDERLAYMENT TO ROOF DECK WHEN SHINGLES NOT INSTALLED SAME DAY

DRIP EDGE INSTALLED OVER THE UNDERLAYMENT AT RAKES AND UNDER THE UNDERLAYMENT AT EAVES

ALL ROOF PENETRATIONS ARE PROPERLY FLASHED W/ FLASHING OF THE
CORRECT SIZE FOR THE PENETRATION


METAL ROOFING ATTACHED W/ CORRECT FASTENERS PER CODE AND MANUFACTURERS SPECS

1" SPACE IS MAINTAINED BETWEEN THE END OF THE GUTTER AND THE WALL CLADDING

Digitally signed
by Carol
Chadwick
DN: c=US,
o=Florida,
dnQualifier=A01
10D0000017EBE
924CE0005954C
cn=Carol
Chadwick
Date: 2022.07.1
18:21:38 -0400

Printed copies of this document are not considered signed and sealed and the signature must be verified on any electronic copy.

PROJECT	DATE	REVISION	SHEET
	JUL		

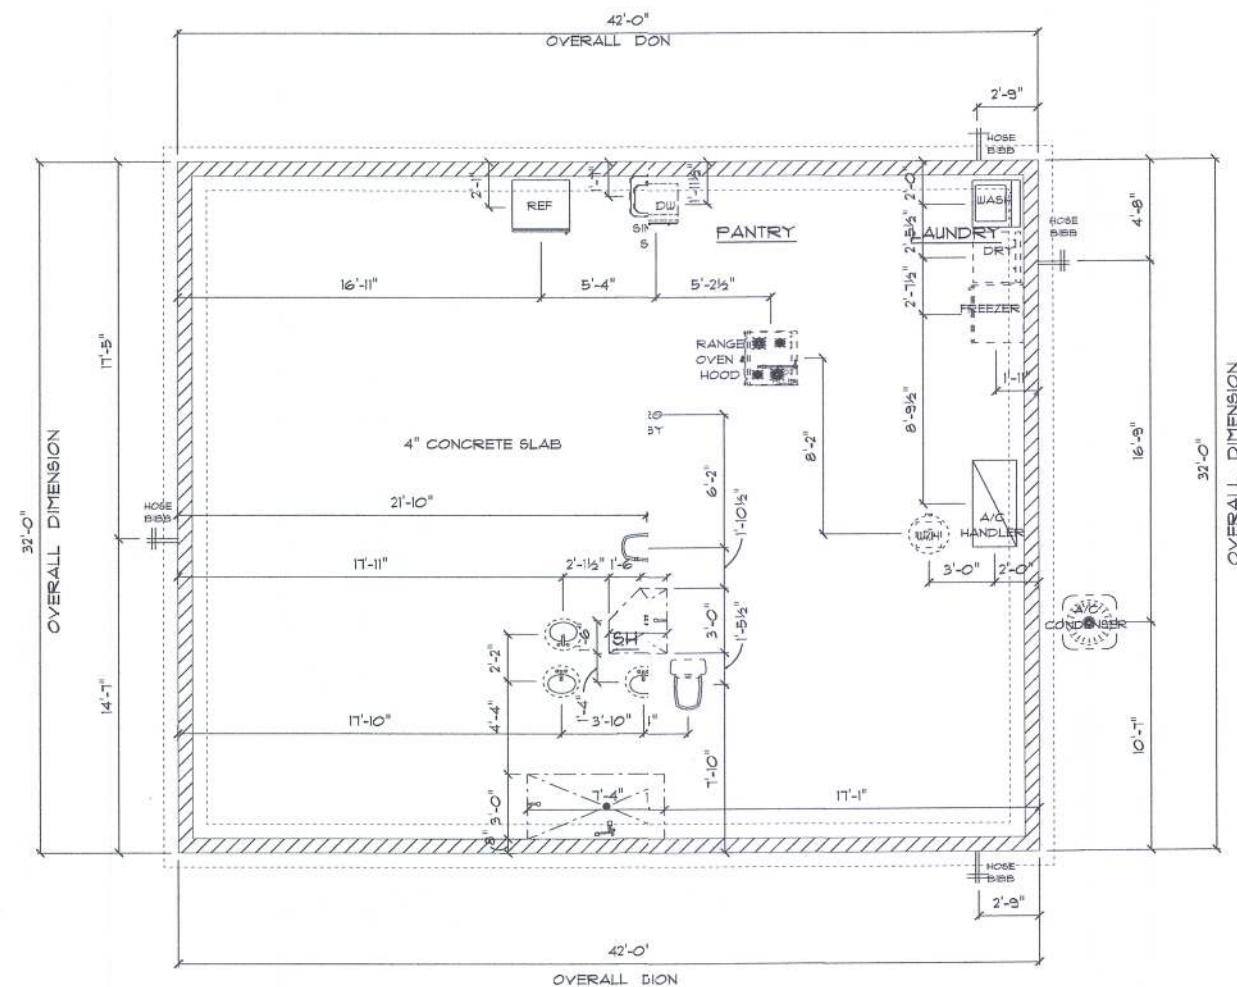

* FOUNDATION / PLUMBING PLAN *

SCALE : = 1'-0"

IMPORTANT NOTES:
 1. IT IS THE BUILDER'S RESPONSIBILITY TO VERIFY ALL GEOMETRY AND DIMENSIONS BEFORE ORDERING ANY MATERIAL BEGINNING CONSTRUCTION.
 2. THESE PLANS ARE FOR LAYOUT DESIGN PURPOSES ONLY. ALL STRUCTURAL NOTES AND DETAILS TO BE PROVIDED BY AN ENGINEER.

RESIDENCE
 For
 CHRIS & WEIDUS
 SHOUSE
 OAK HAMMOCK
 LOT #4
 LAKE CITY, FLORIDA

Teresa M. Ruffo
 2925 SW 6R 41
 Lake City Florida, 33025
 Cell: (386) 661-1181
 Email: teranuffo@gmail.com

PRINTED DATE:
 Wednesday, June 22, 2022

DRAWN BY: Teresa M. Ruffo CHECKED BY:

BUILDING CONTRACTOR: GLENWOOD KING


FINALS DATE:

JOB NUMBER:

DRAWING NUMBER:

A-2

OF 6 SHEETS


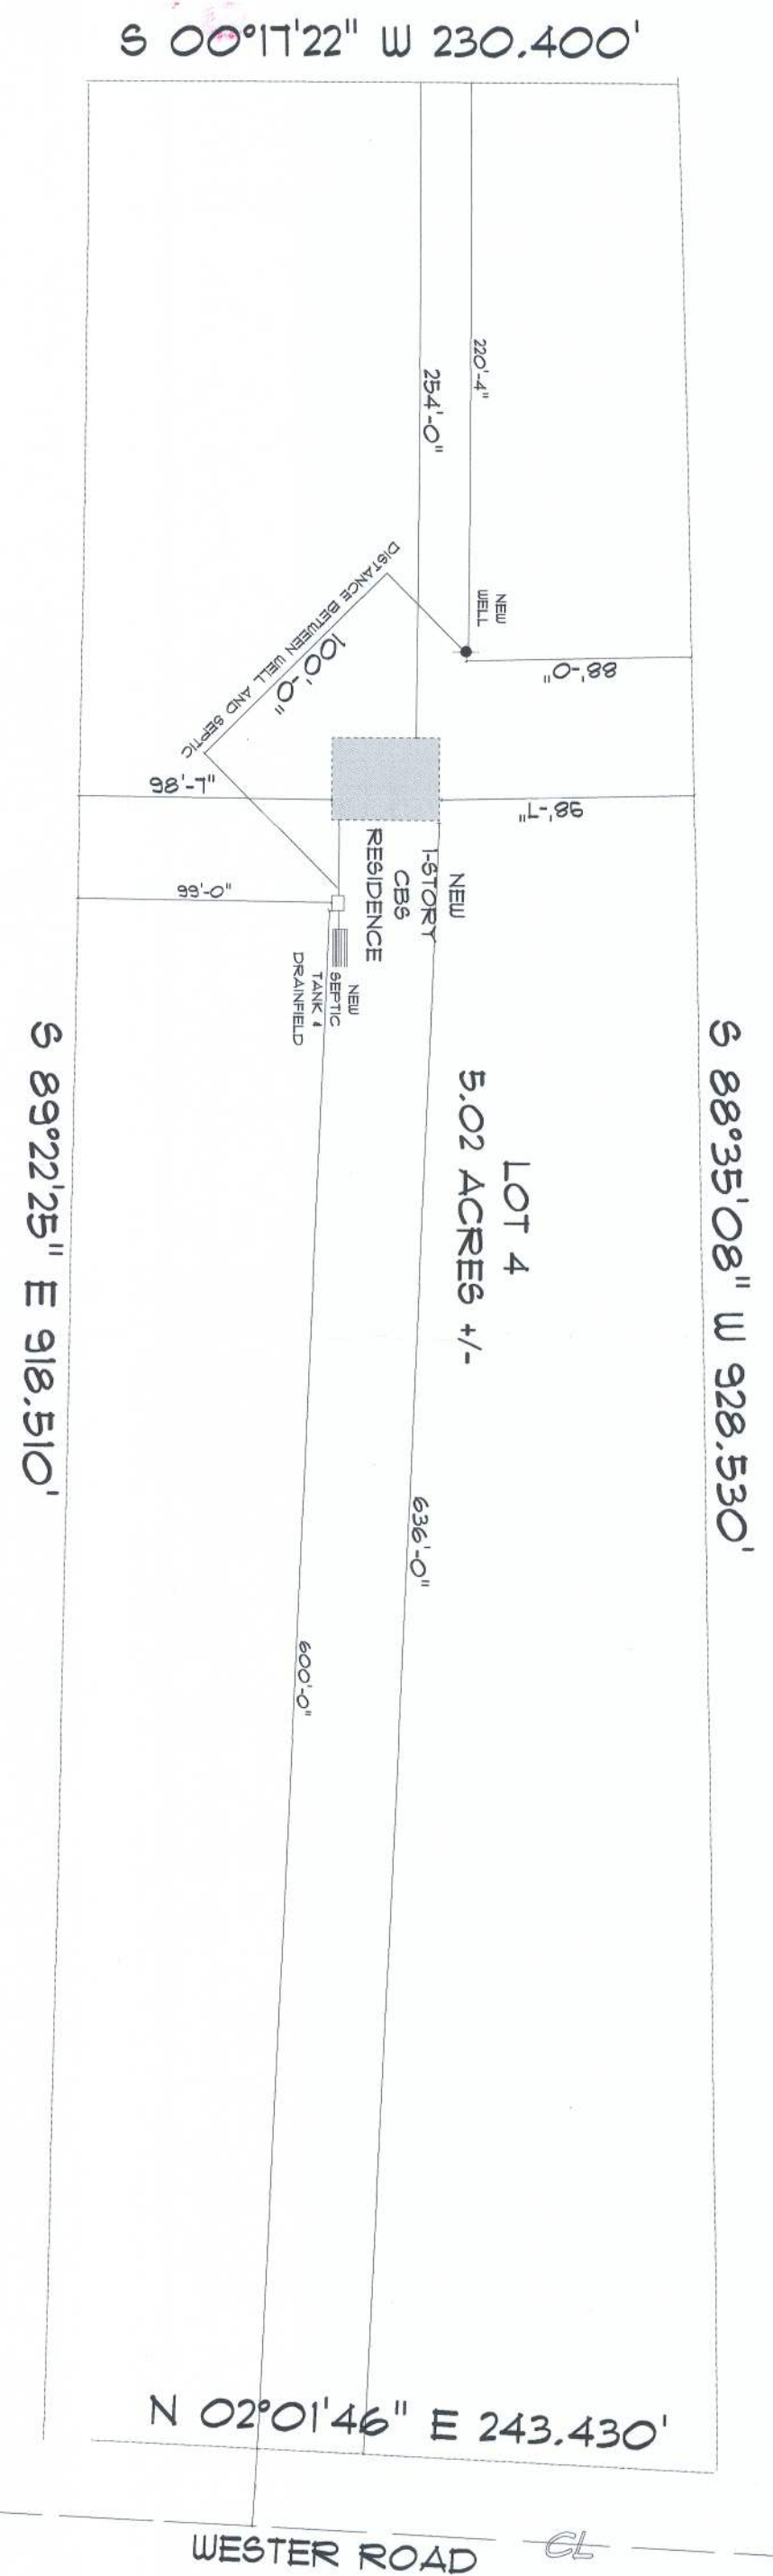


* S-T-E-V-E N * ---

SCALE: 1" = 30'-0"




RESIDENCE For CHRIS & JUDITH SQUASH C&J HAYSTACK LOT #4 LAKE CITY, FLORIDA	Tract 14, Rwy 10 Lot 4, 2000 SW 4th St Lot 4, 2000 SW 4th St, 32025 Call: (904) 843-3322 Email: sewer@sewer.com
JOBS NUMBER FINALS DATE RELIABLE CONSTRUCTION 6 ELINORC KING	CREATED DATE: Wednesday, June 22, 2005 CREATED BY: DORISCH BY DETAILS BY: JIMMY
CR & BUILTS A-1 DRAWING NUMBER	

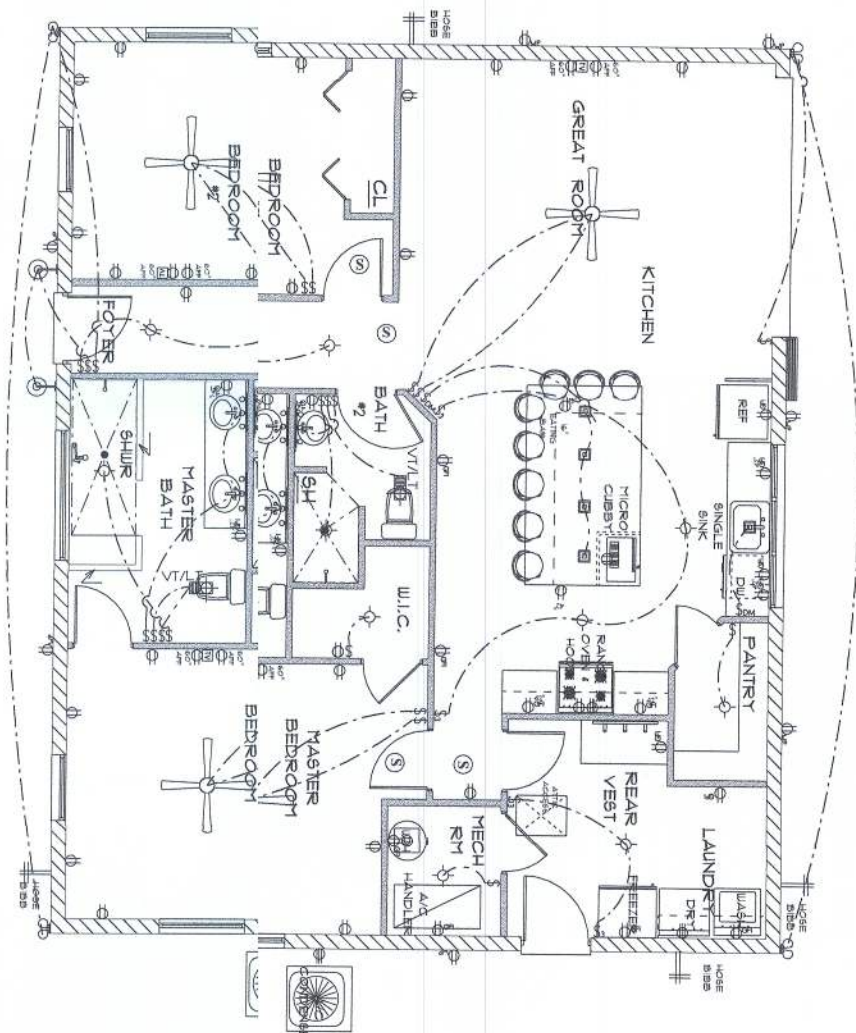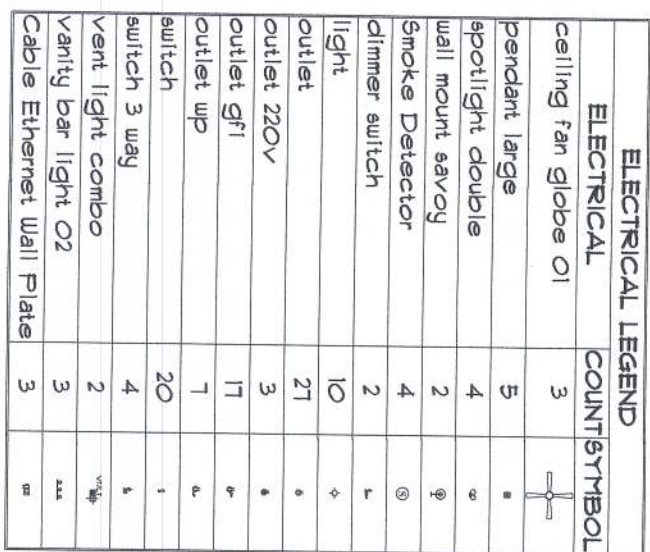


*
M
L
M
C
T
P
—
C
P
L
A
N
*

SCALE : 1/4" = 1'-0"

RESIDENCE for CHRIS & JENNIFER SHOUSE OAK HATPOCK LOT #4 LAKE CITY, FLORIDA	THOMAS M. KELTO 2020 SW 66th AV LAKE CITY, FL 33509 Cell: (404) 860-3368 Email: tomketo@earthlink.net	PRINTED DATE: Wednesday, June 22, 2005 CRAIG M. KELTO DISPATCH BY: THOMAS M. KELTO GLENWOOD KING FATALS DATE: JOB NUMBER: DRAWING NUMBER A-6 21 x 8 SHEETS
---	---	--

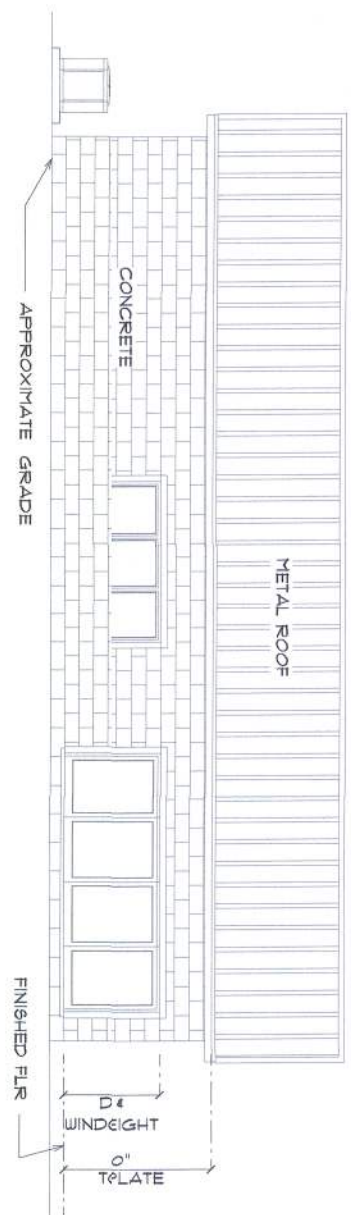

SCALE : 1/4" = 1'-0"

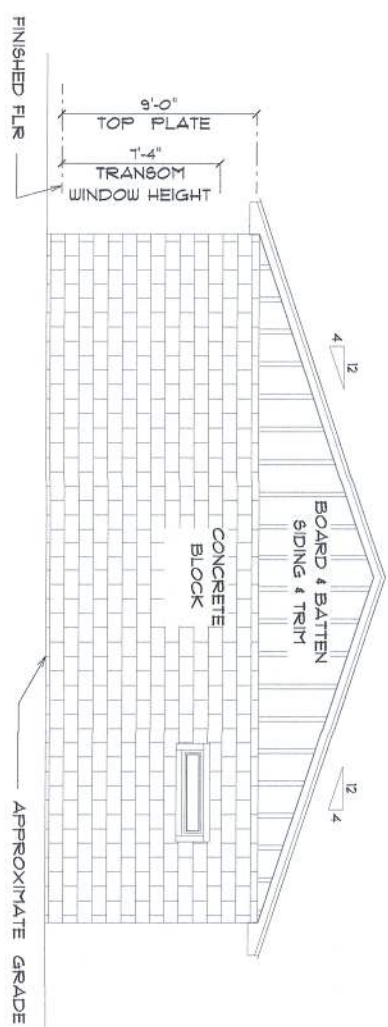

SCALE : 1/4" = 1'-0"

REBID/INVOICE
for
CHRS. & WENDIS
SHOUSE
OAK HAVENPOE
LOT #4
LAKE CITY, FLORIDA

Teresa M. Ruff
Lula City, Shouse
Call: (813) 861-1181
Email: lusera@angel.com

PROPOSED DATE:
Wednesday, June 22, 2012

DRAWN BY:	CHECKED BY:
TRC	TRC

REVISION COMMENTS:
GLENNWOOD KING

DATE DATE:
208 NUMBER

DRAWING NUMBER
A-5

OF 6 SHEETS