

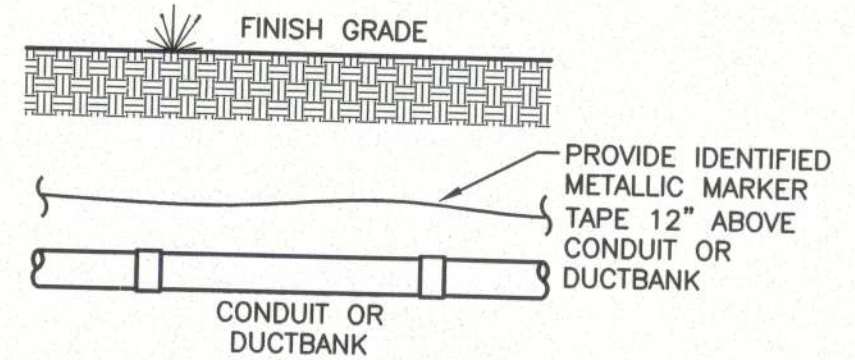


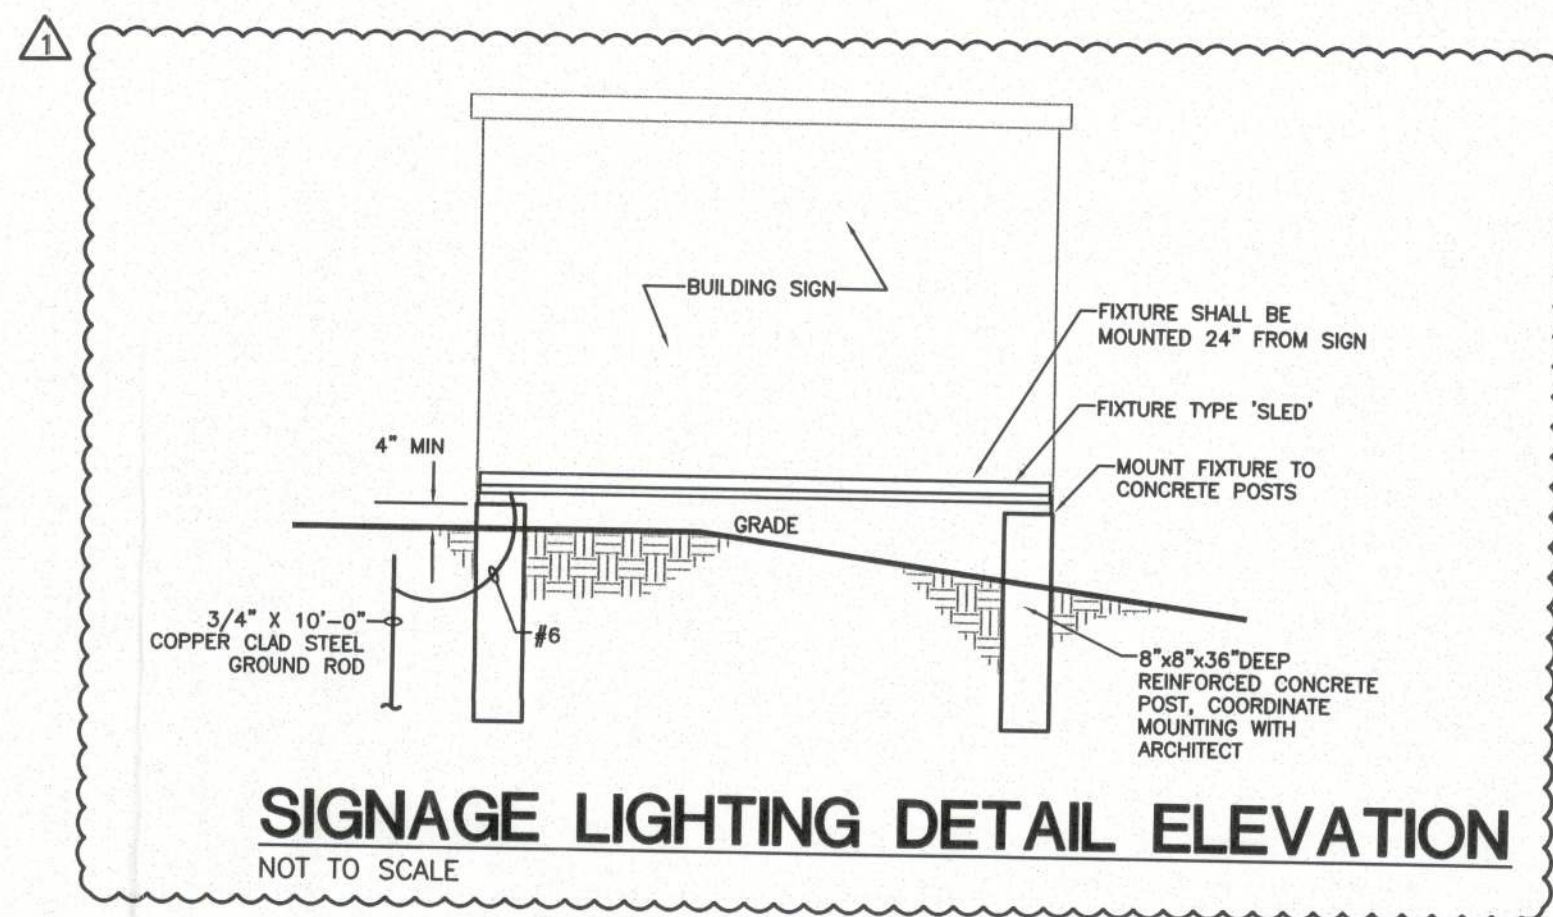

BURIED CONDUIT MARKER DETAIL

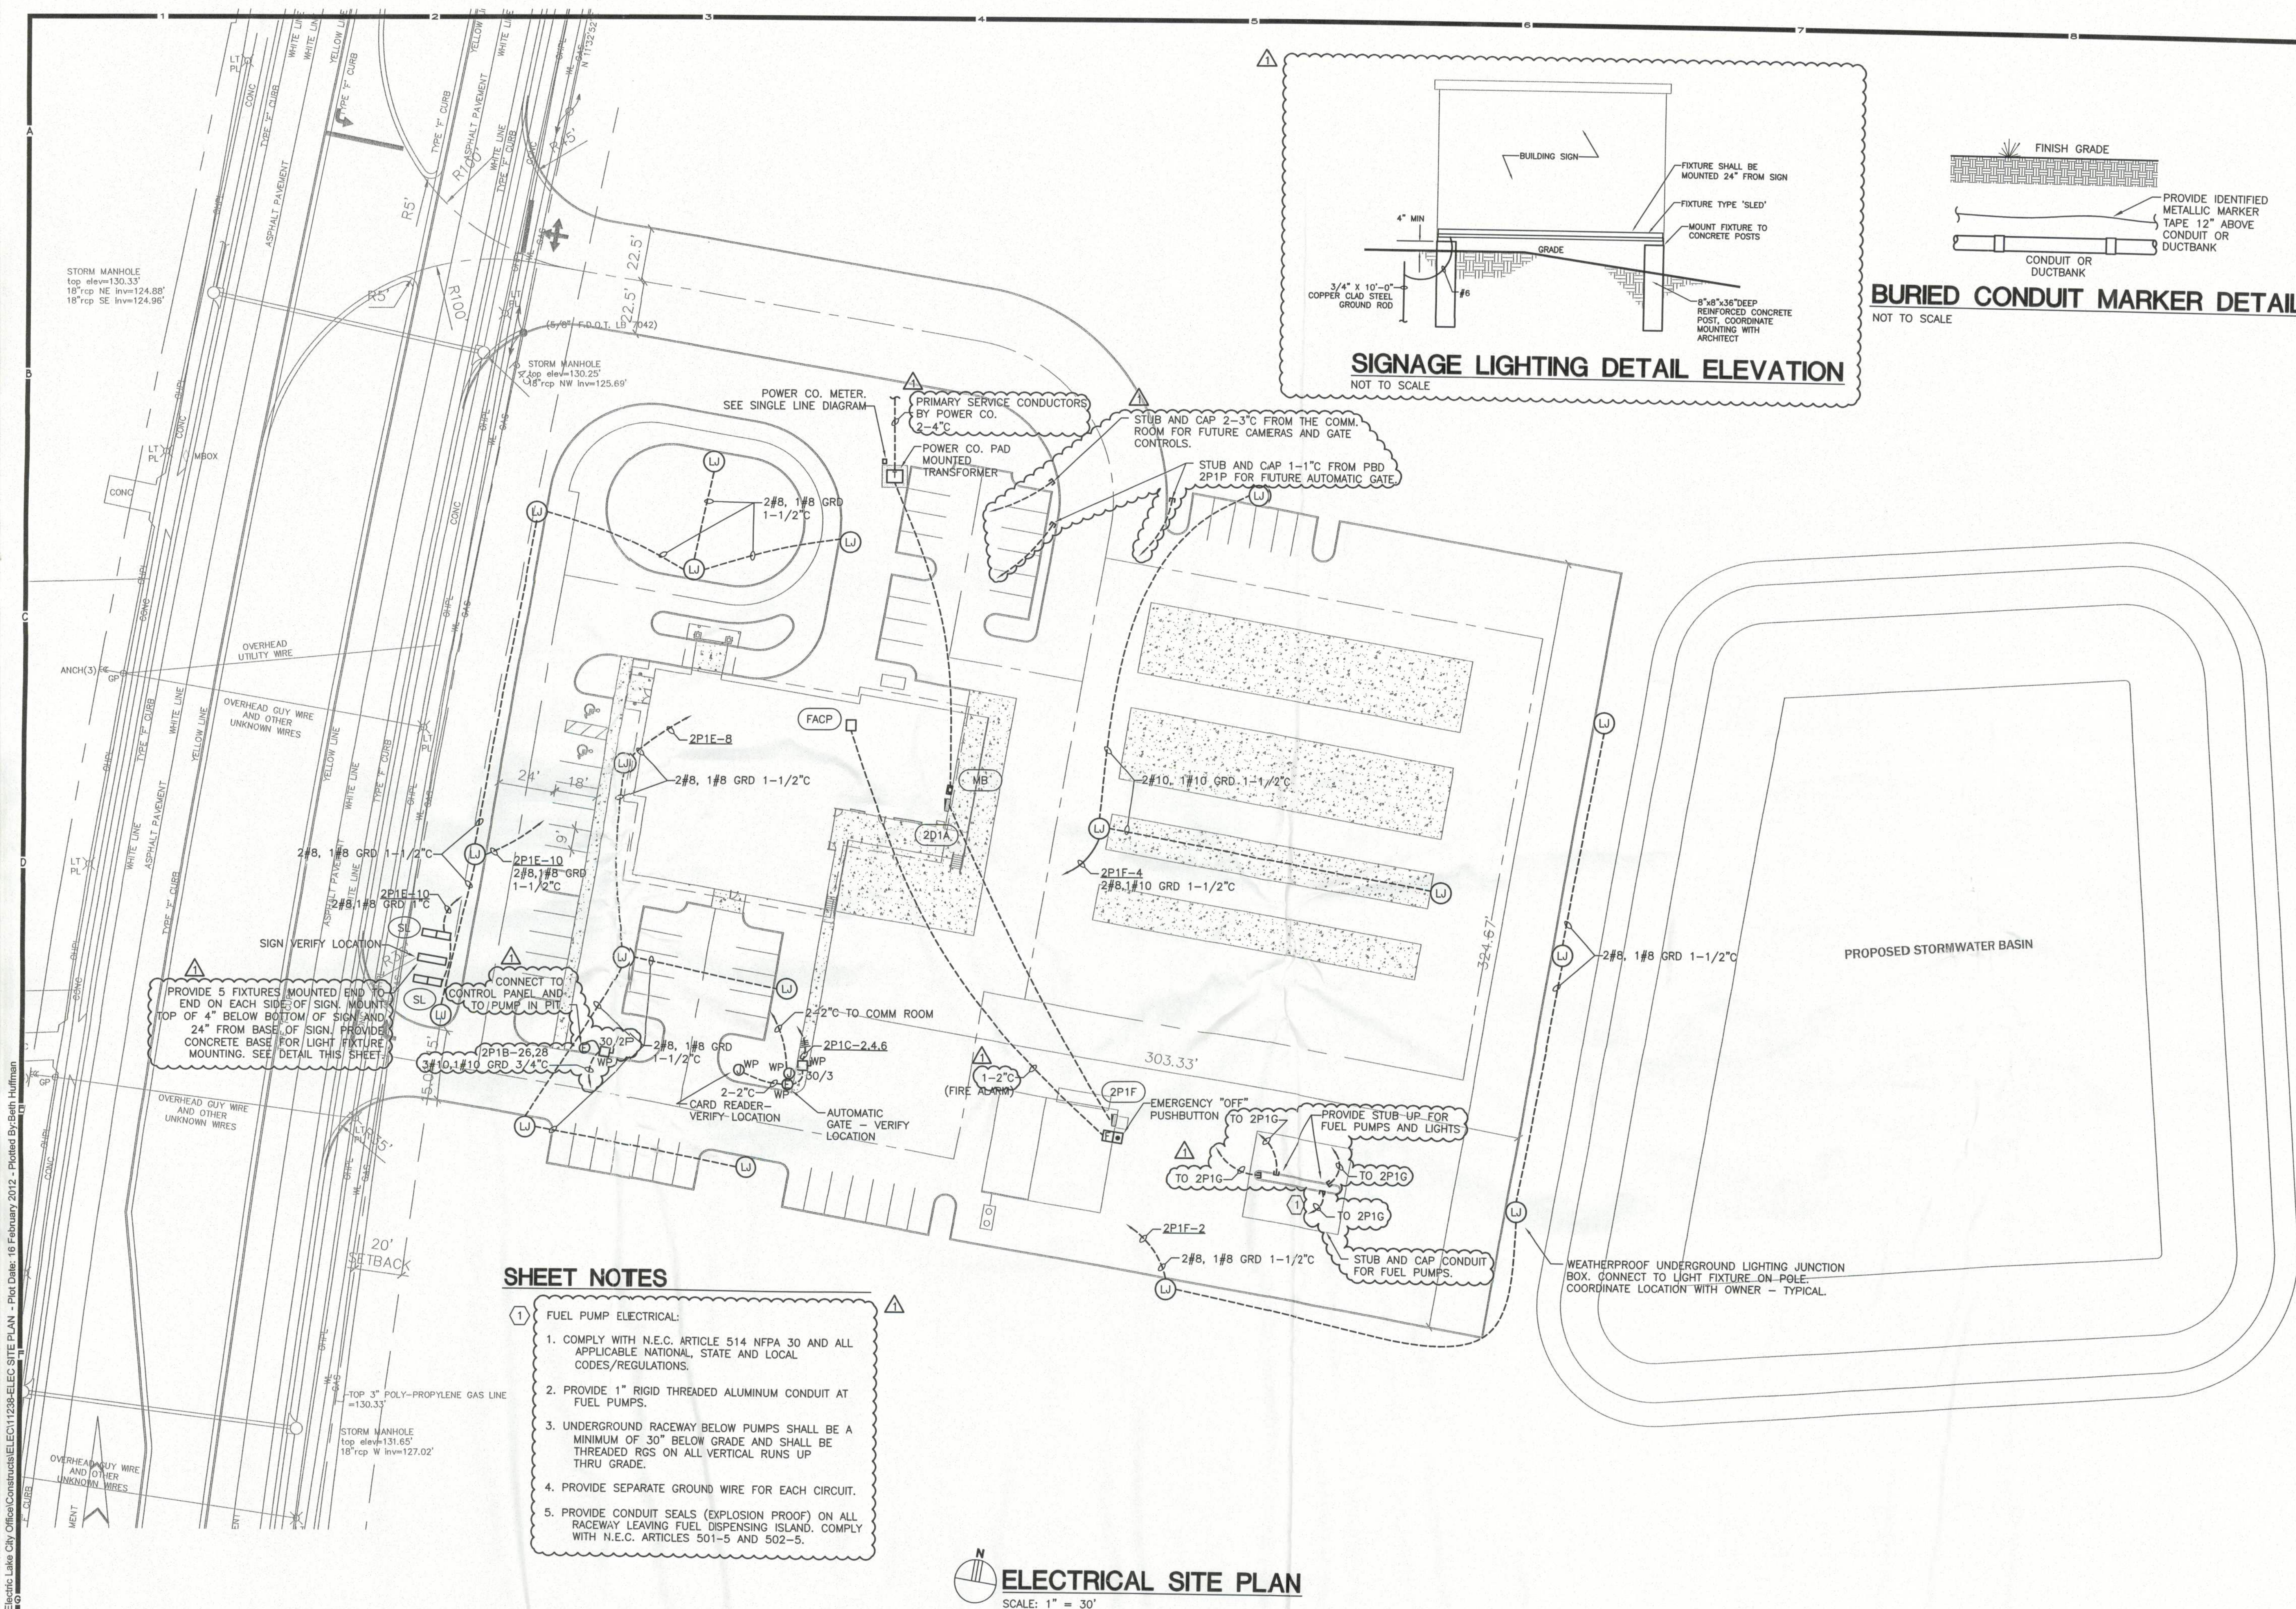

ELECTRICAL SITE PLAN

SCALE: 1" = 30'

SHEET NOTES

- 1 FUEL PUMP ELECTRICAL:
1. COMPLY WITH N.E.C. ARTICLE 514 NFPA 30 AND ALL APPLICABLE NATIONAL, STATE AND LOCAL CODES/REGULATIONS.
 2. PROVIDE 1" RIGID THREADED ALUMINUM CONDUIT AT FUEL PUMPS.
 3. UNDERGROUND RACEWAY BELOW PUMPS SHALL BE A MINIMUM OF 30" BELOW GRADE AND SHALL BE THREADED RGS ON ALL VERTICAL RUNS UP THRU GRADE.
 4. PROVIDE SEPARATE GROUND WIRE FOR EACH CIRCUIT.
 5. PROVIDE CONDUIT SEALS (EXPLOSION PROOF) ON ALL RACEWAY LEAVING FUEL DISPENSING ISLAND. COMPLY WITH N.E.C. ARTICLES 501-5 AND 502-5.