
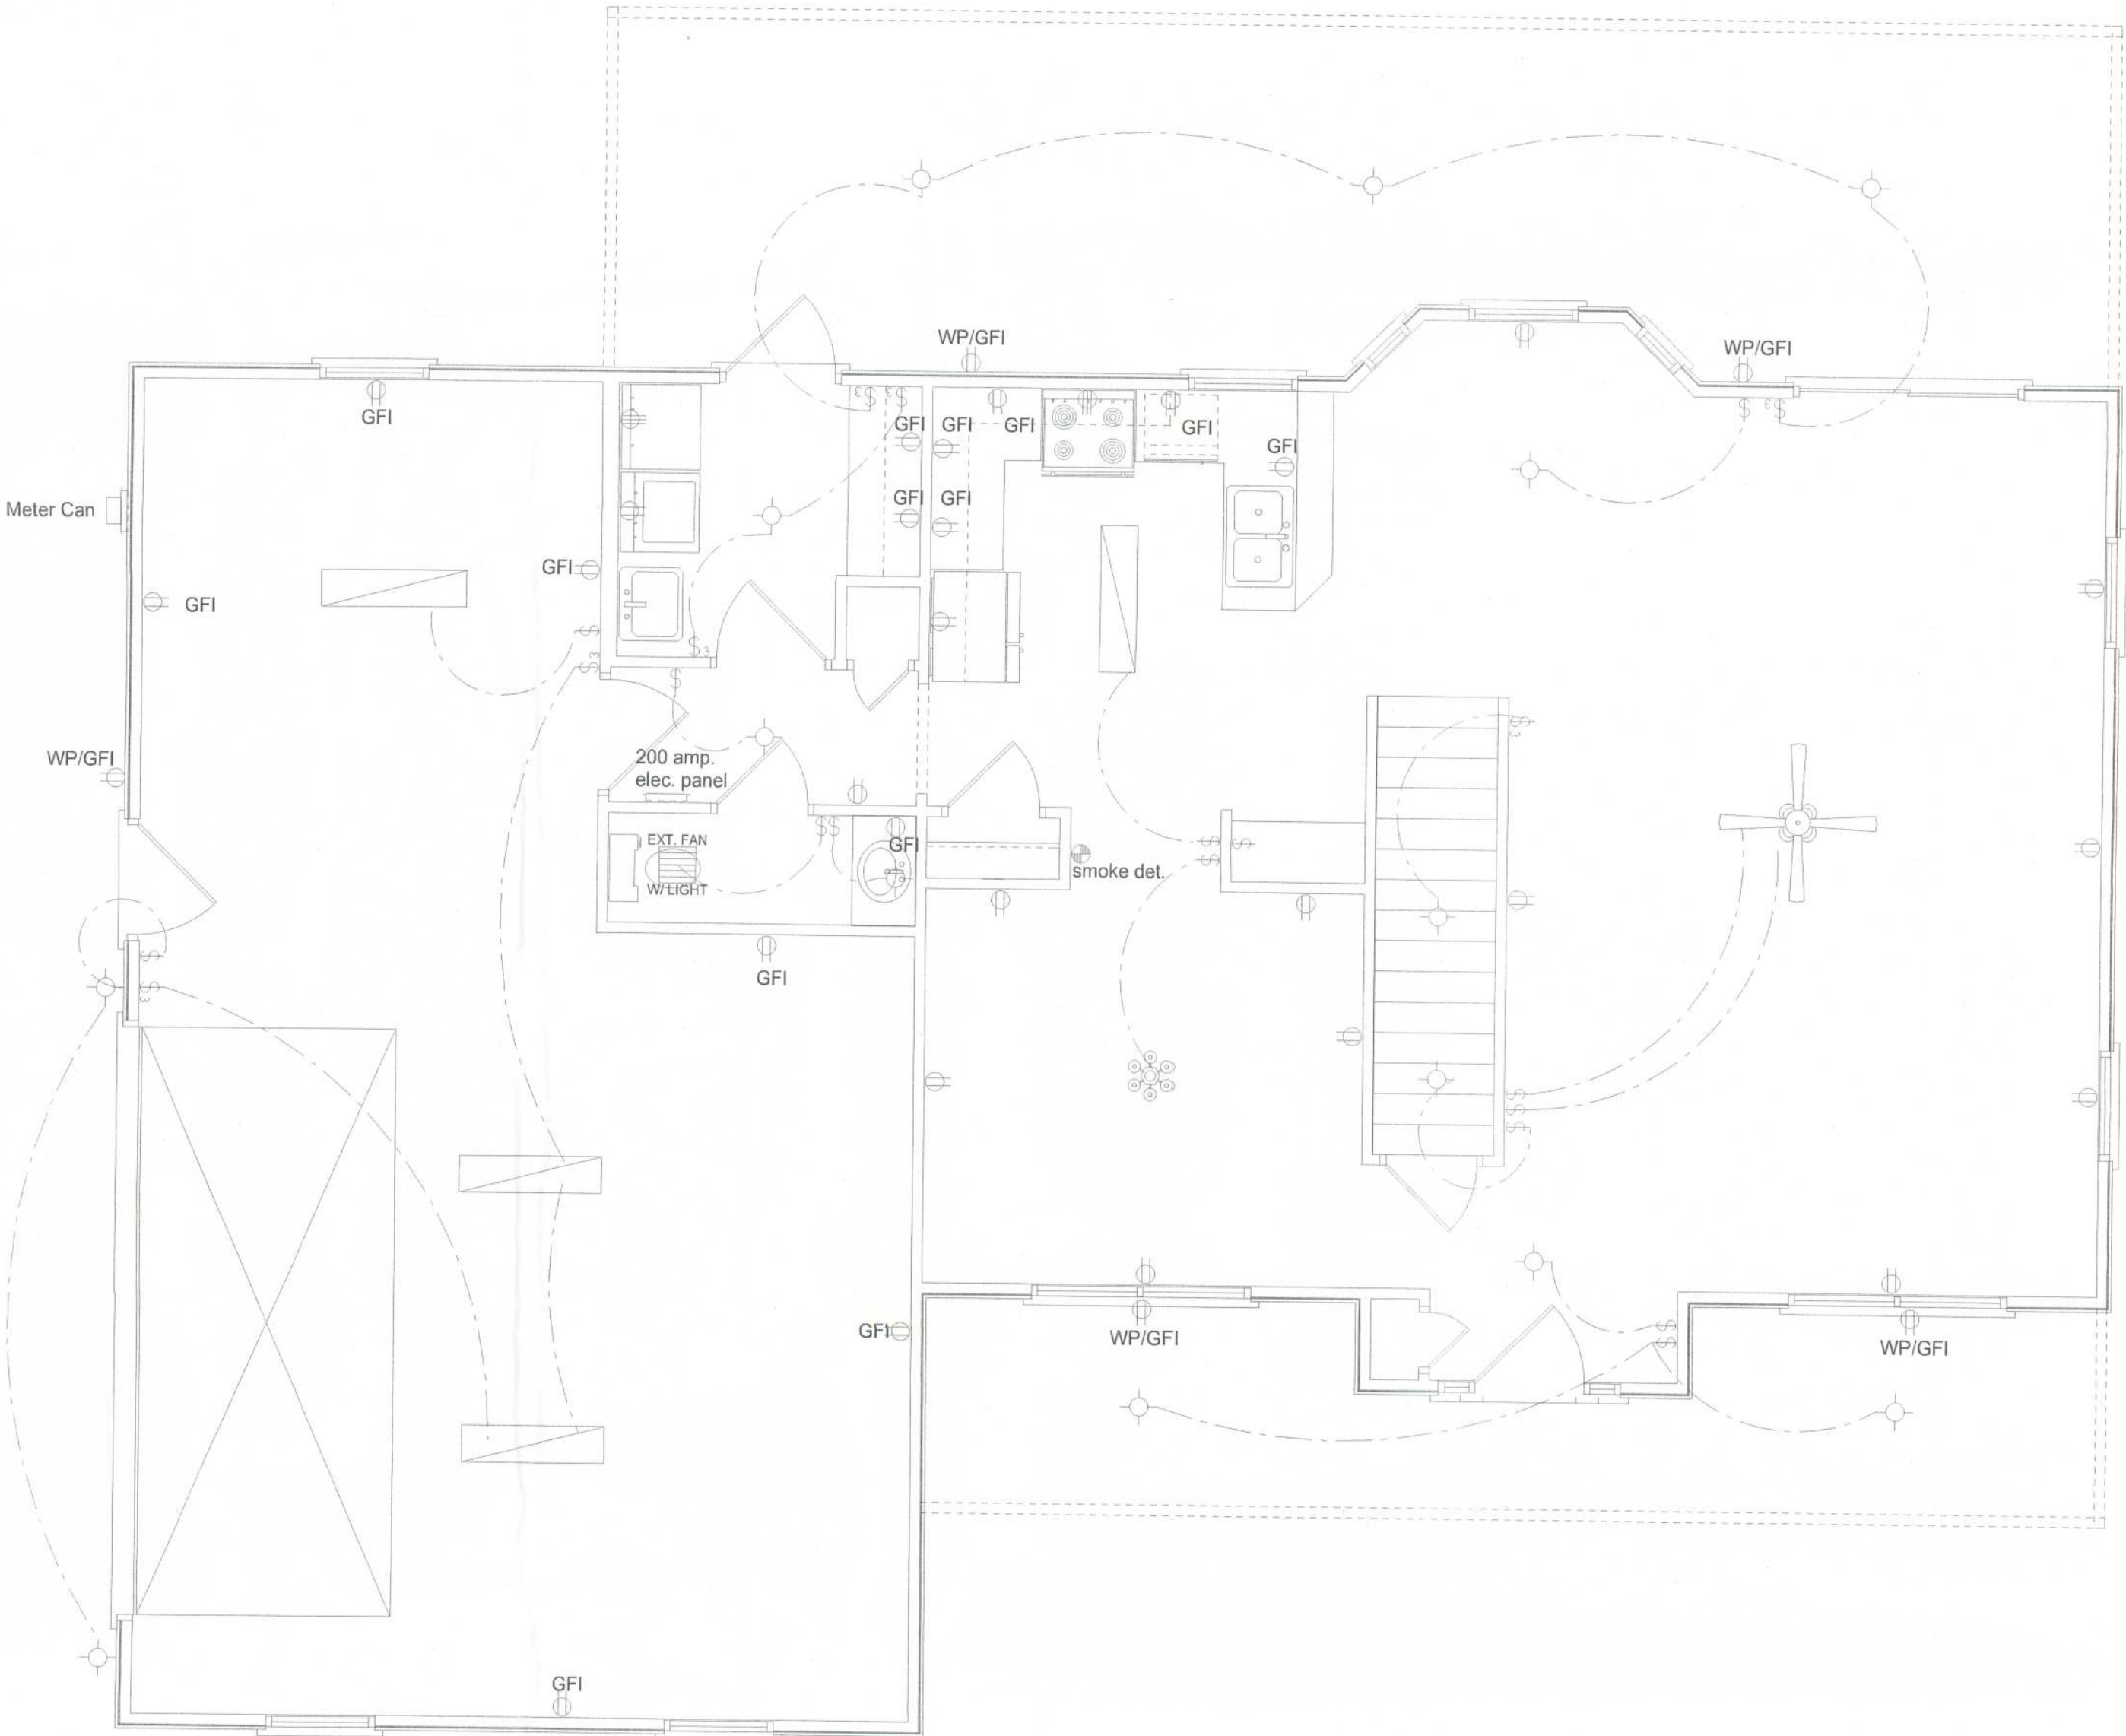


ELECTRICAL	COUNT	SYMBOL
ELECTRICAL PANEL	1	
METER	1	
220V OUTLET	2	
120V OUTLET	26	
SWITCH	25	
3- WAY SWITCH	6	
LIGHT	13	
CHANDALIER	1	
CAN LIGHT	2	
EXT. FAN	3	
FLOUR FIXTURE	3	
DBL. SPOTLIGHT	3	
GFI OUTLET	19	
SMOKE DETECTOR	5	
CEILING FAN	4	

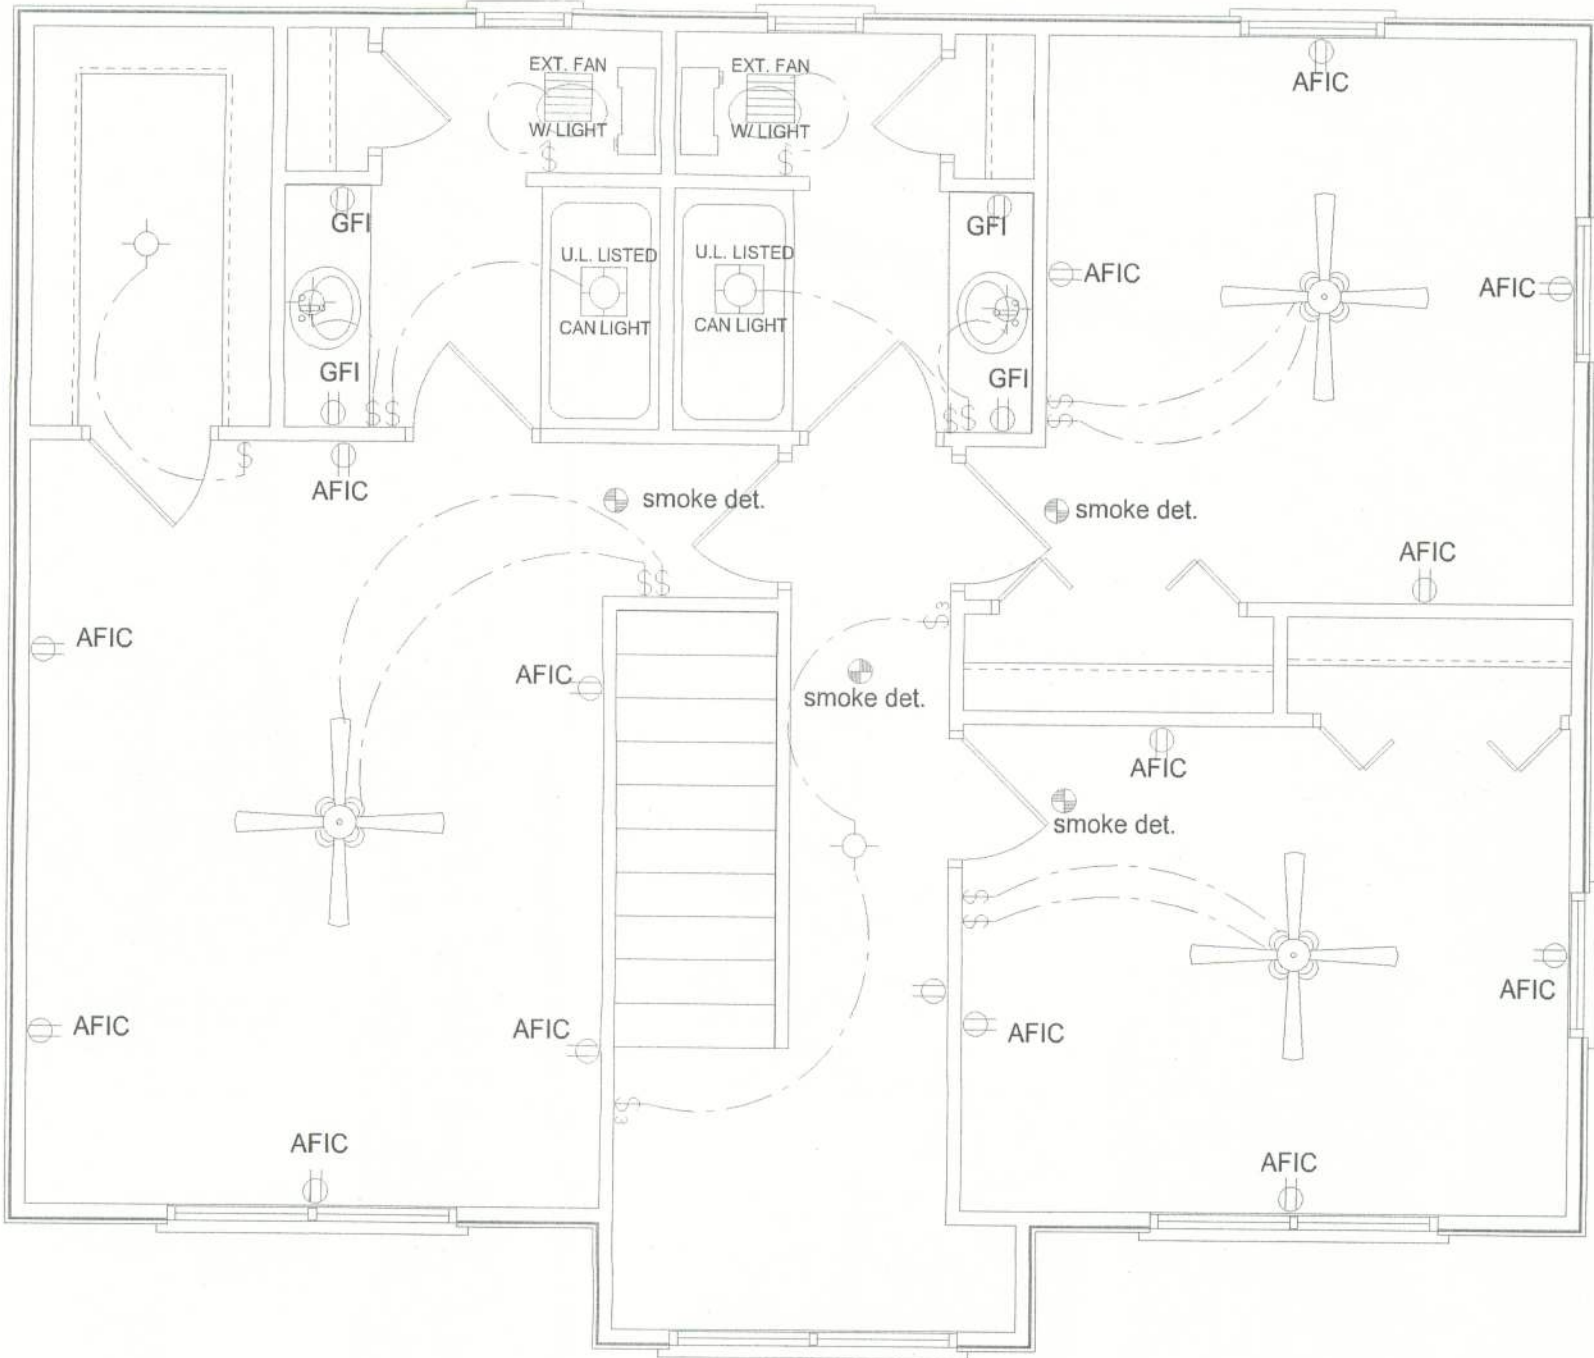

ELECTRICAL PLAN NOTES

ALL RECEPTICALS IN ALL BEDROOMS
SHALL BE AFIC CIRCUITS

WIRE ALL APPLIANCES, HVAC UNITS AND OTHER EQUIPMENT
PER MANUFACTOR SPECIFICATIONS

INSTALLATION SHALL BE PER NATIONAL ELECTRIC CODE.

ALL SMOKE DETECTORS SHALL BE 120V W/ BATTERY
BACKUP OF THE PHOTOELECTRIC TYPE AND SHALL BE
INTERLOCKED TOGETHER. INSTALL INSIDE AND NEAR ALL
BEDROOMS.

TELEPHONE, TELEVISION AND OTHER LOW VOLTAGE
DEVICES OR OUTLETS SHALL BE AS PER THE OWNERS
DIRECTIONS & IN ACCORDANCE W/ APPLICABLE
SECTIONS OF NEC-LATEST EDITIONS.

ELECTRICAL CONTRACTOR SHALL PREPAIR * AS-BUILT * SHOP DRAWINGS
INTDICATING ALL ELECTRICAL WORK INCLUDING ANY CHANGES TO ELEC. PLAN,
ADDITIONS TO THE ELEC. PLAN, RISER DIAGRAM, AS-BUILT PANEL SCHEDULE
W/ ALL CKTS IDENTIFIED W/ CKT Nr., DESCRIPTION AND BRKR, SERVICE ENT.
& ALL UNDERGROUND WIRE LOCATIONS/ROUTING/DEPTH.
RISER DIA. SHALL INCLUDE WIRE SIZES/TYPER & EQUIPMENT
TYPE W/ RATINGS & LOADS.
CONTRACTOR SHALL PROVIDE 1 COPY OF AS-BUILT DWGS.
TO OWNER & 1-COPY TO THE PERMIT ISSUING AUTHORITY.

NOTES:

ALL WORK SHALL COMPLY WITH
THE STANDARD BUILDING CODE
AND ALL APPLICABLE
LOCAL CODES AND ORDINANCES

AREA SUMMARY
Main Living Area 1007 SF
2nd Floor Living Area 857 SF
Garage 685 SF
Porches 564 SF
TOTAL AREA 3113 SF

Adam & Kim Service Residence
Stephen Crawford Construction, Inc. Lake Butler, Florida.
PLANS BY: Stephen Crawford

MAIN ELEC. PLAN &
2ND ELEC. PLAN
SCALE 1/4" = 1'-0"

@ DATE
@ TIME
SHEET #