



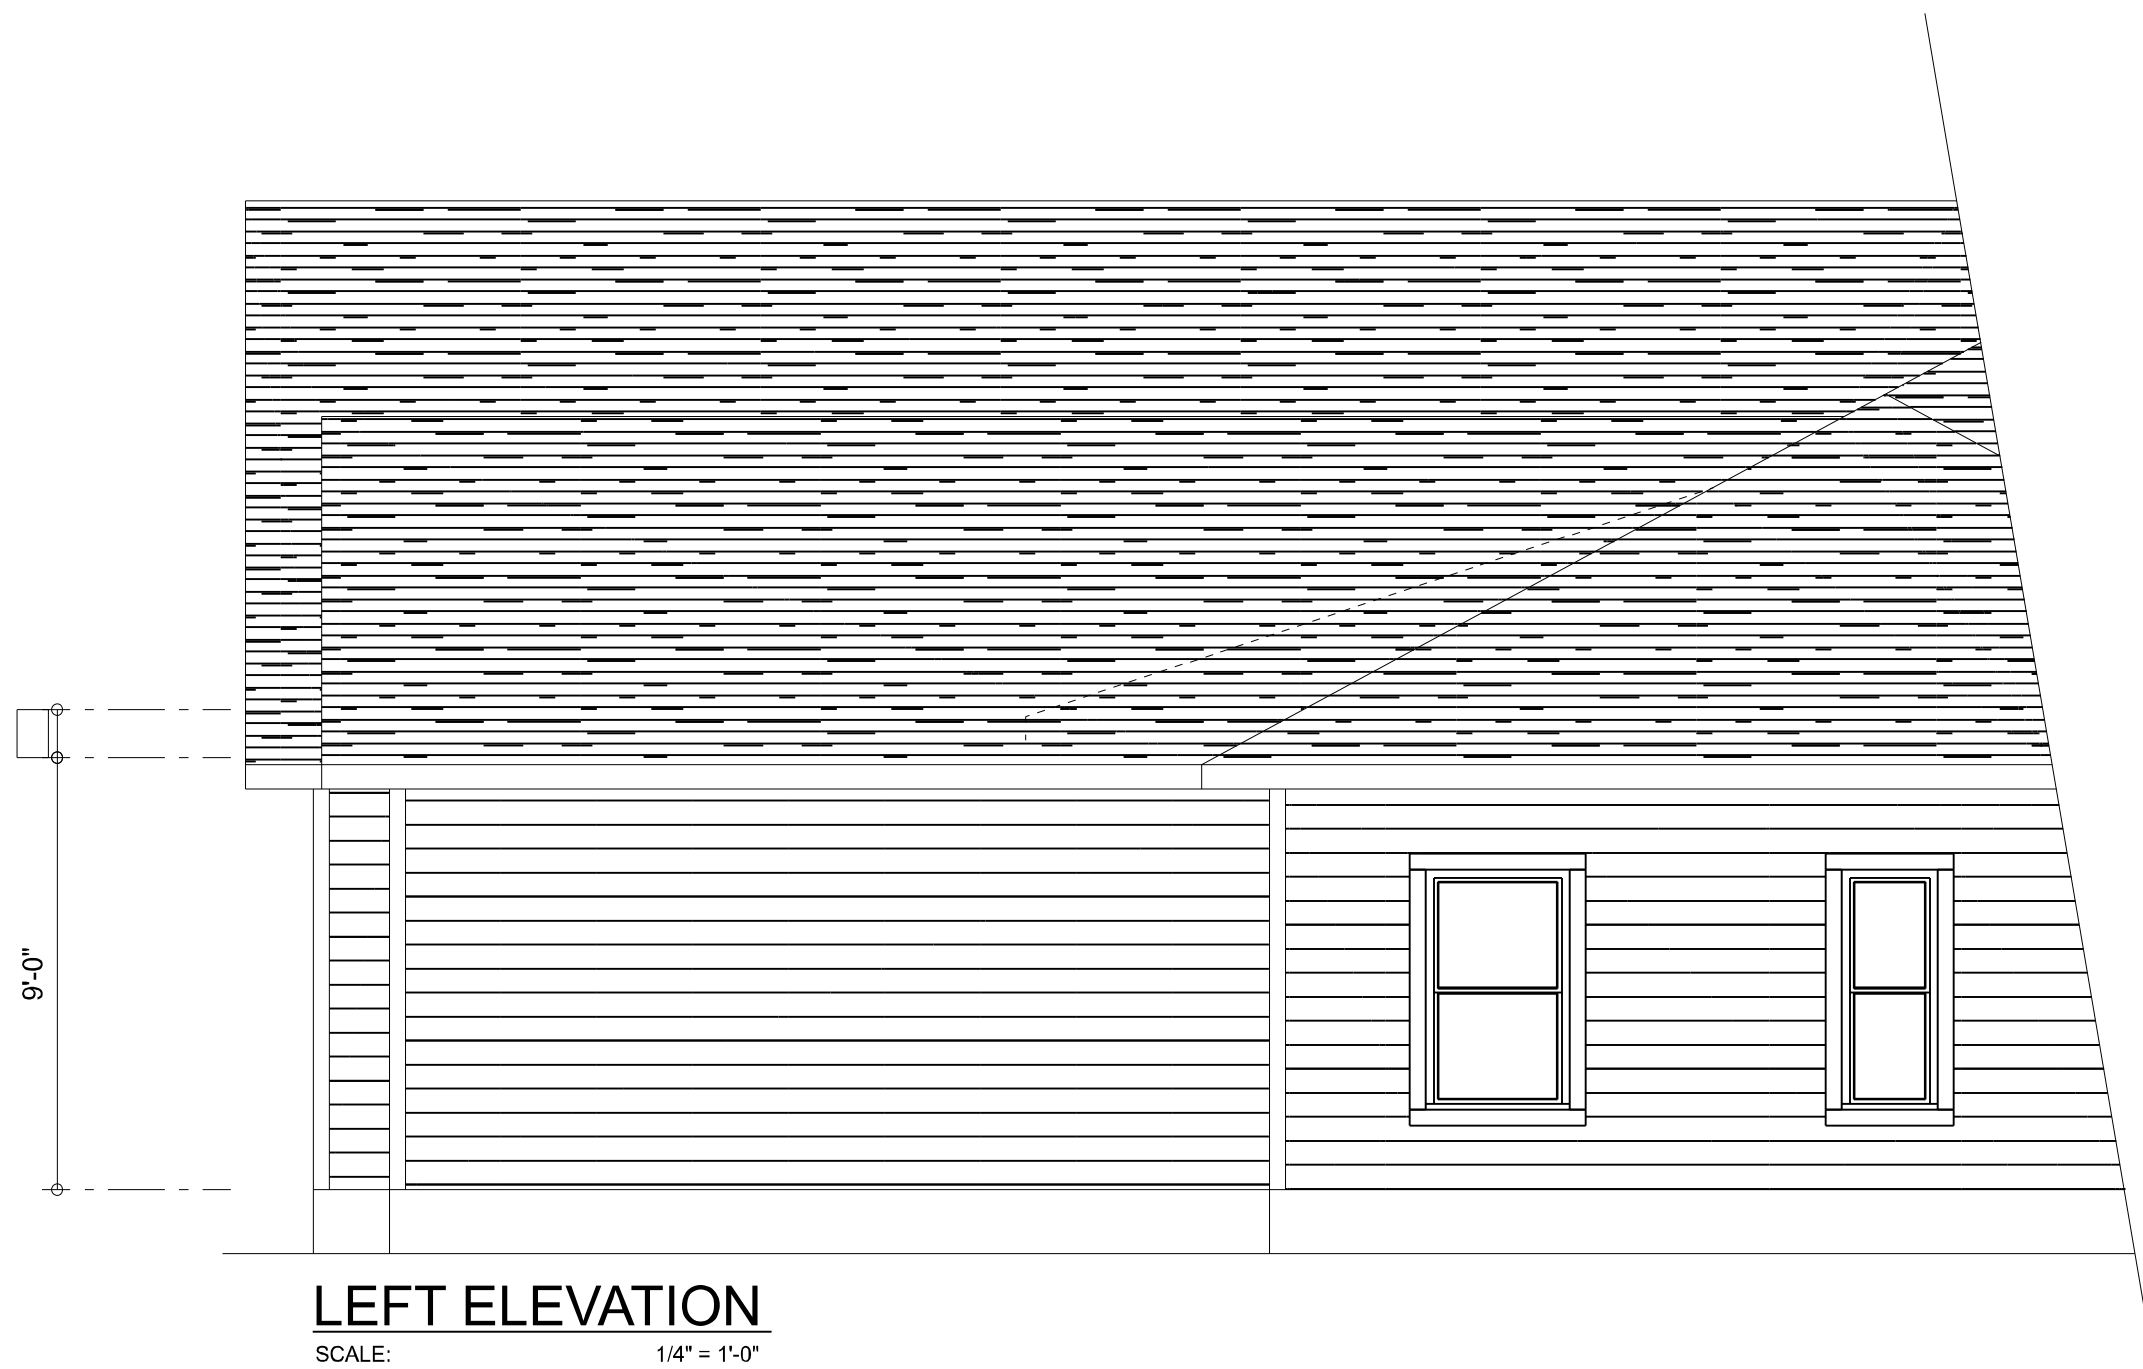

LEFT ELEVATION
SCALE: 1/4" = 1'-0"




REAR ELEVATION
SCALE: 1/4" = 1'-0"

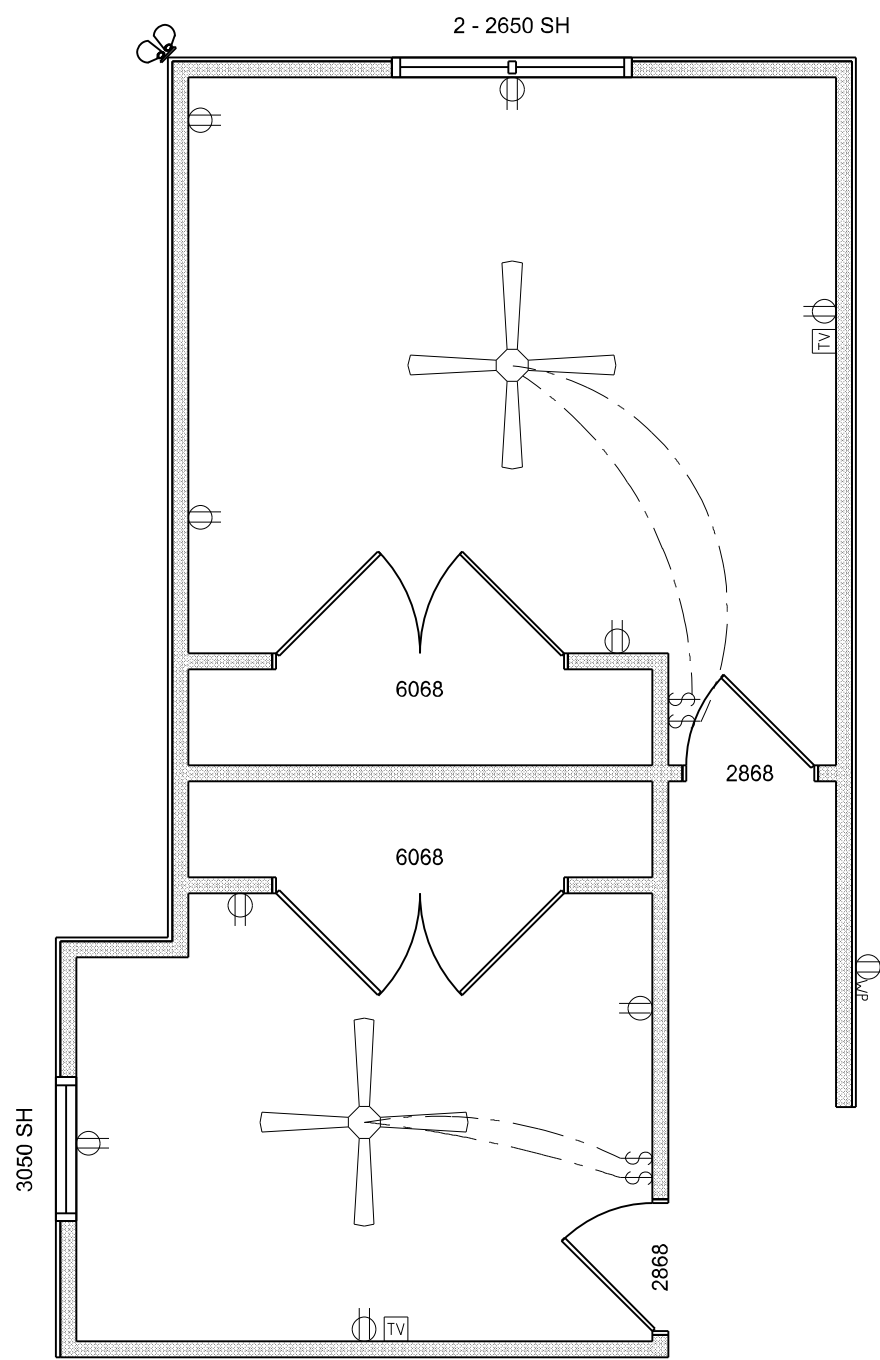

ELECTRICAL PLAN
SCALE: 1/4" = 1'-0"

ELECTRICAL LEGEND		
ELECTRICAL	COUNT	SYMBOL
CEILING FAN	2	
MOTION SECURITY LIGHT	1	
COAX OUTLET	2	
OUTLET	9	
OUTLET WP	1	
SWITCH	4	

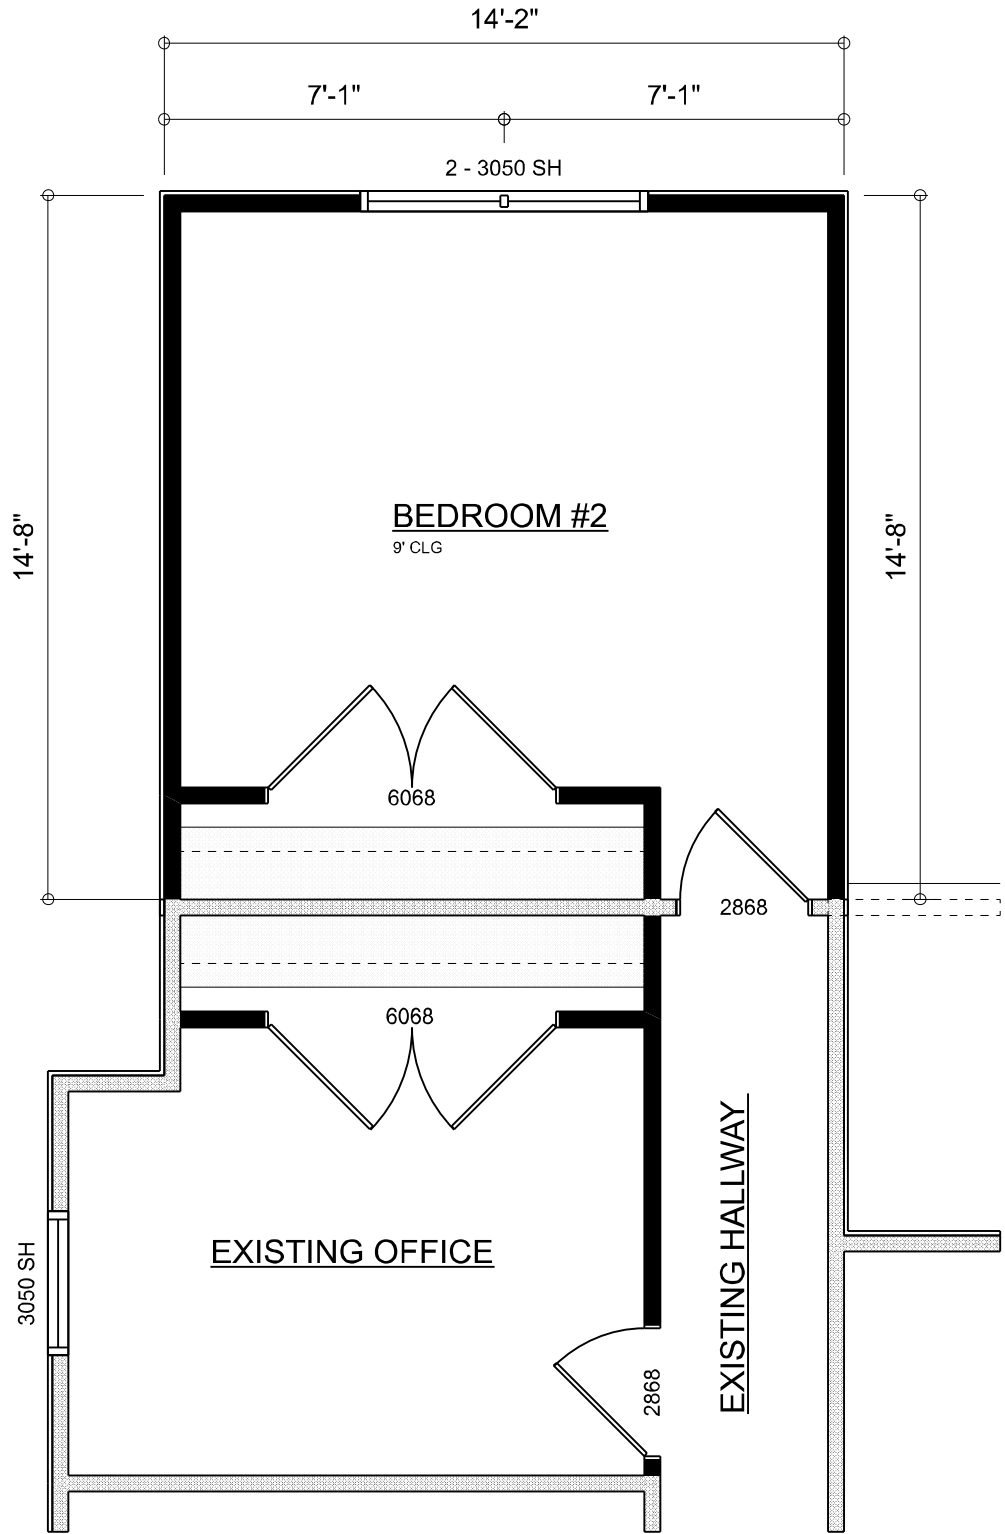

DIMENSIONED FLOOR PLAN
SCALE: 1/4" = 1'-0"

AREA SUMMARY		
HEATED & COOLED ADDITION	210	S.F.
GRAND TOTAL	210	S.F.