





FRONT ELEVATION

SCALE: 1/4"=1'-0"

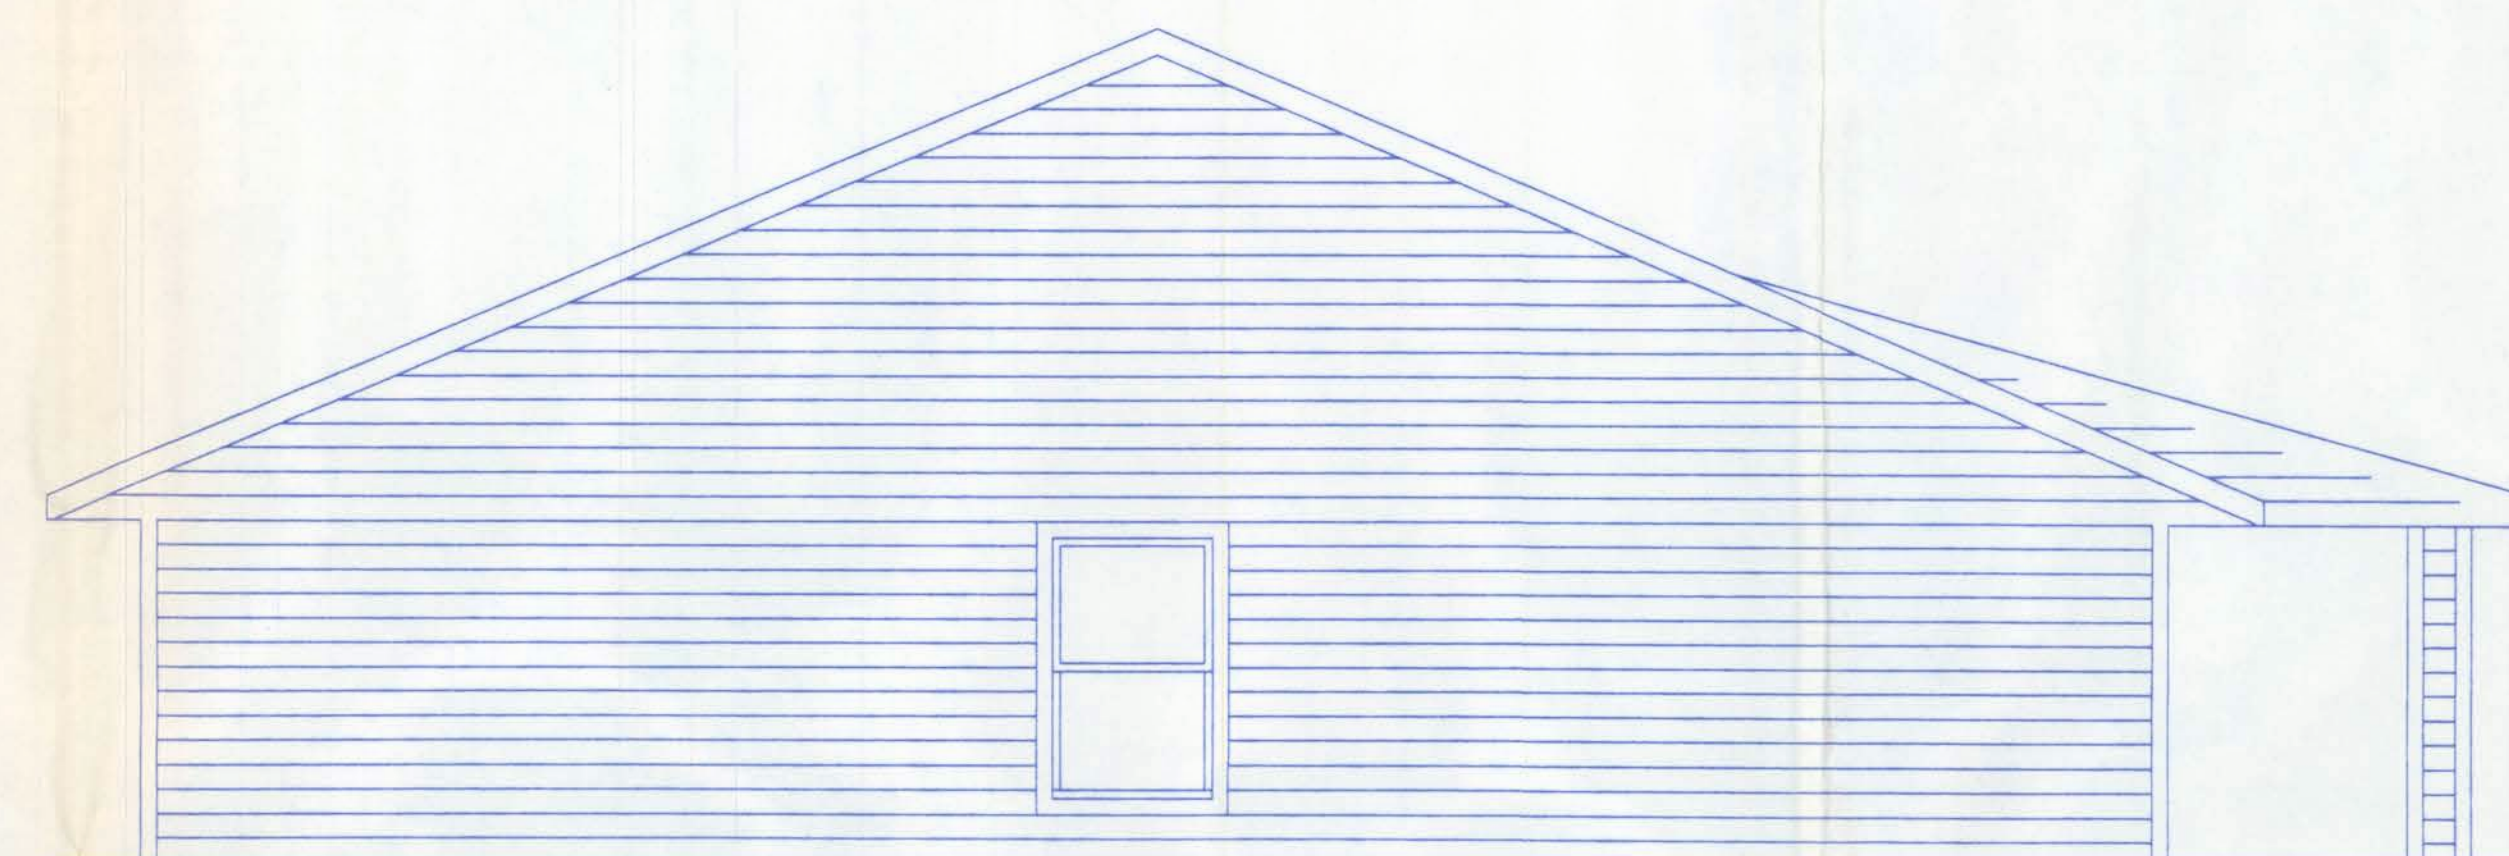


LEFT ELEVATION

SCALE: 1/4"=1'-0"

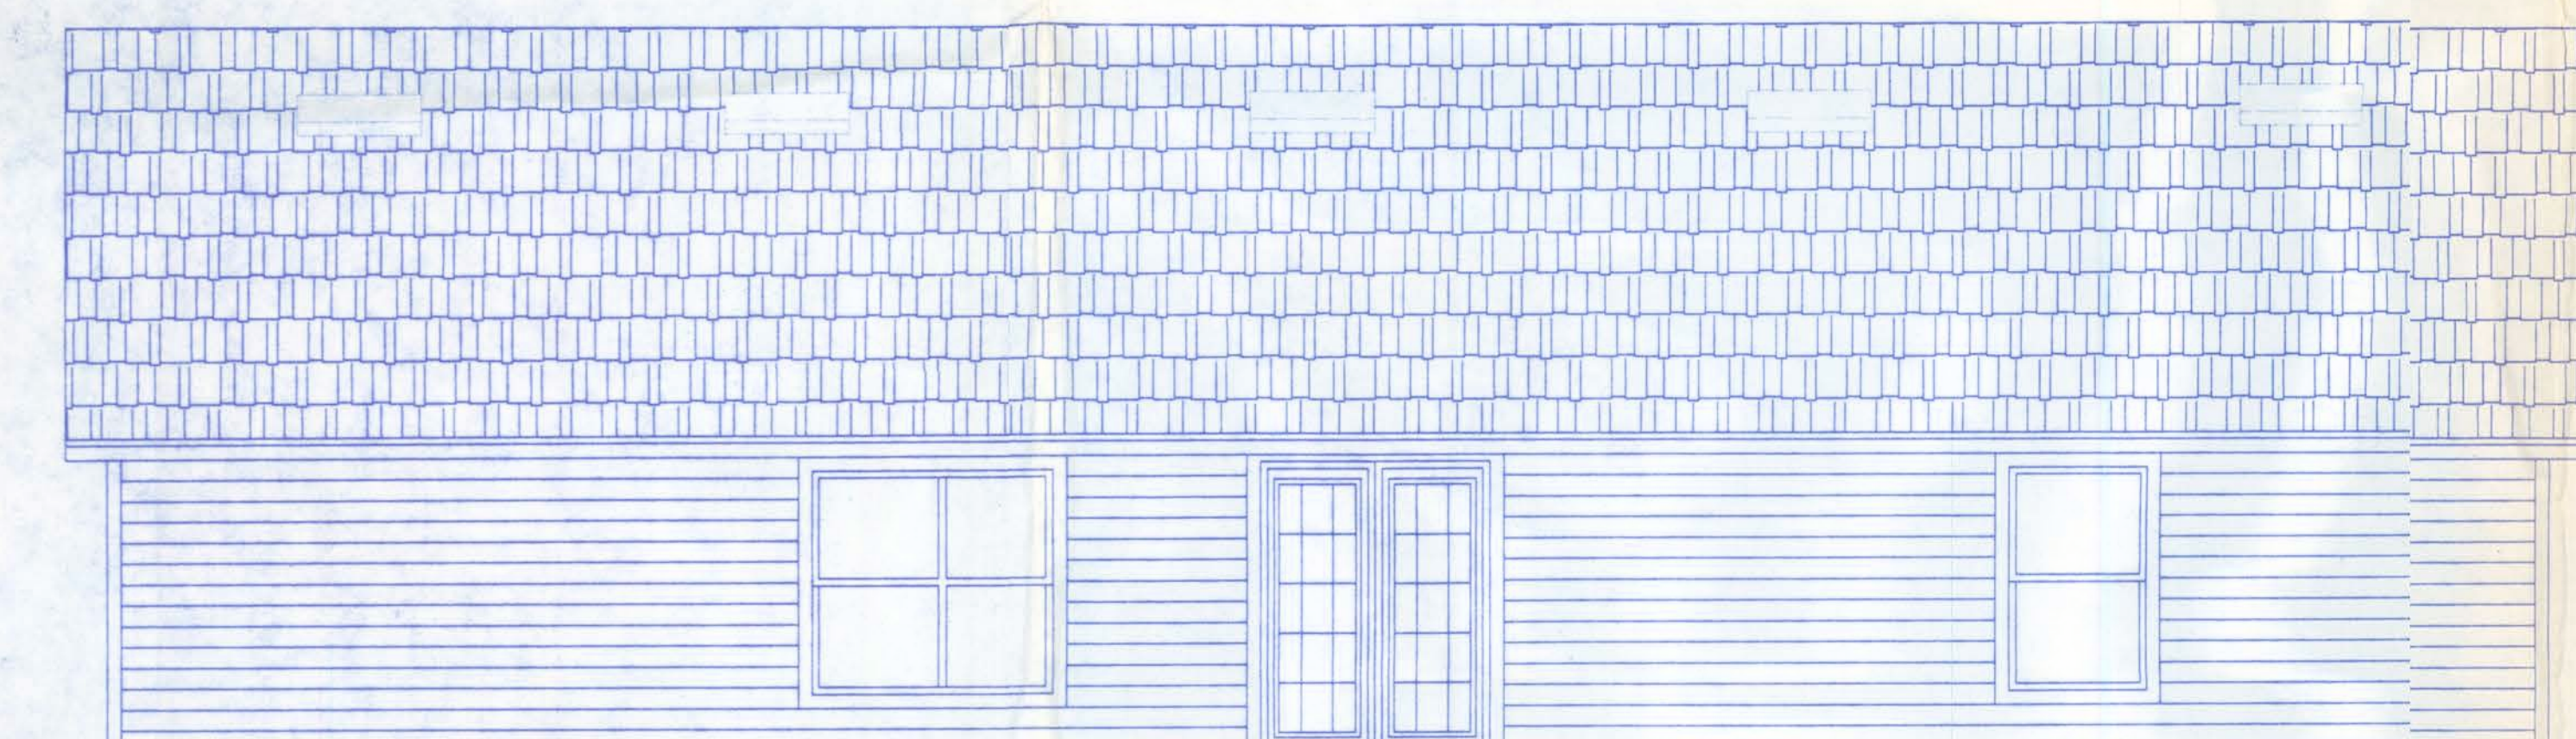

BACK ELEVATION

SCALE: 1/4"=1'-0"

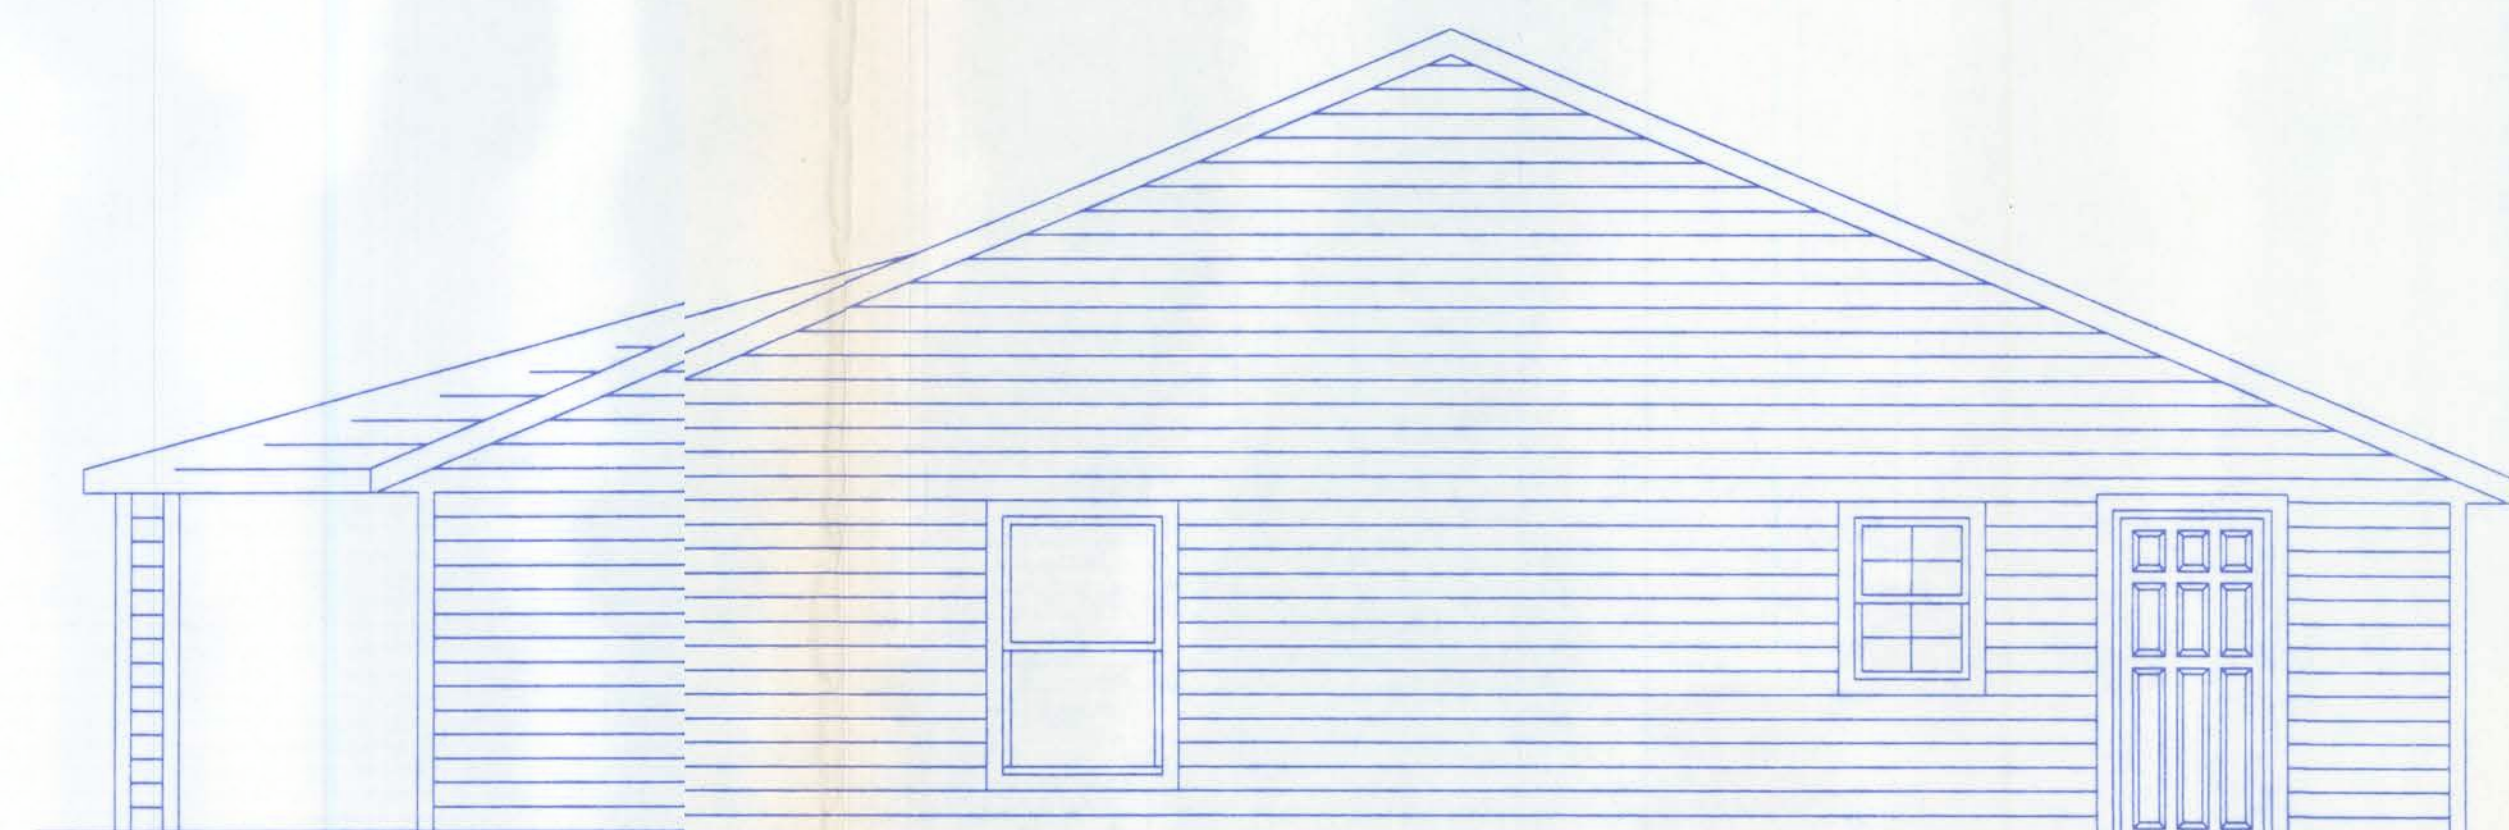

RIGHT ELEVATION

SCALE: 1/4"=1'-0"

ROOF VENT SCHEDULE

2,637 SQ. FT./300 = 8.79 SQ. FT. VENT REQUIRED
 214 L. FT. x2/35 = 12.23 SQ. FT. VENT PROVIDED
 5 STANDARD ROOF VENTS x 0.72 = 4.24 SQ. FT. PROVIDED
 8.48 REQUIRED = 16.47 PROVIDED



HOUSE CRAFT HOMES, L.L.C.
 12523 NW U.S. Hwy. 441 - Alachua, FL 32615
 Phone: (386) 462-5323/FAX: (386) 462-1509

Job name: **TRYE**
 Model: CUSTOM Type: ELEVATIONS
 Location: LAKE CITY Drawn By: J.D.H.
 Checked By: J.D.H. Revision Date: 9/10/08
 Scale: 1/4"=1' Date: 9/10/08 Sheet: 3 of 3



HOMES BY HOUSE CRAFT, L.L.C.

12523 U.S. Highway 441 - Alachua, FL 32615 Phone: (904) 462-5323/FAX: (904)462-1509

Client Name: _____ Model: CUSTOM

BANK: _____ LOAN TYPE: () Cash
() Conventional
() F.H.A.
() V.A.

CABINET COLOR SELECTIONS:

Kitchen: _____ Toilets: color
Countertop: _____ Master: _____
Cabinet Base: _____ Hall: _____
Master Bath: _____ Other: _____
Countertop: _____ NOTES: _____
Cabinet Base: _____
Hall Bath: _____
Countertop: _____
Cabinet Base: _____

BATHROOM TILE SELECTION:

Master Bath: _____ Color: _____ Tub Choices: _____
Shower: _____ Master: _____ Style: _____ Lmp: _____
Shower Floor: _____ Hall: _____
Grout: _____ Bath 3: _____
Hall Bath: _____ Tub Surround: _____
Tub Surround: _____ Tile Selection: _____
Tile Selection: _____
Grout: _____ Tile Selection: _____

VAULTS:

CARPET

VINYL/FLOOR TILE

PAINT SELECTIONS:

Interior Wall Color: TD
Interior Trim: TD
Window Sills: () Wood
() Flatcut Marble
() Hardiplank Siding/Wood Sill

RANGE SELECTIONS:

Range/Color: HOMESOWNER SUPPLYING APPLIANCES
Hood/Color: TD TO COST \$850
OPTIONAL APPLIANCES: _____

EXTERIOR FEATURE SELECTIONS:

Acrocrete/Main House: _____
Trim Package: _____
Trim Color: _____
Exterior Door Colors: _____
Siding: _____
Soffit: _____
Shingles: _____
Style/Color: _____
Window Color: _____
Trim Type Colonial w/Classique Doors Std.
Colonial Grills Front Windows Standard

BATH WINDOWS:

Master (x) Obscure () Clear Glass
Hall (x) Obscure () Clear Glass

SUPER Energy Pac: Yes () No (x) Well Allowance Yes () No (x)
Septic Allowance Yes (x) No ()

Extras: _____

Power Company: _____ () Overhead () Underground

Fireplace: N/A Screenroom Color: _____


We have reviewed this plan and all notes on it. All items we have discussed with House Craft and its representatives are indicated on this "Master Copy". We understand that any additional items that are not on this print can be done for a \$250.00 plan change fee plus the cost of the change.

Purchaser: _____ Date: _____

REV.

DESCRIPTION

DATE

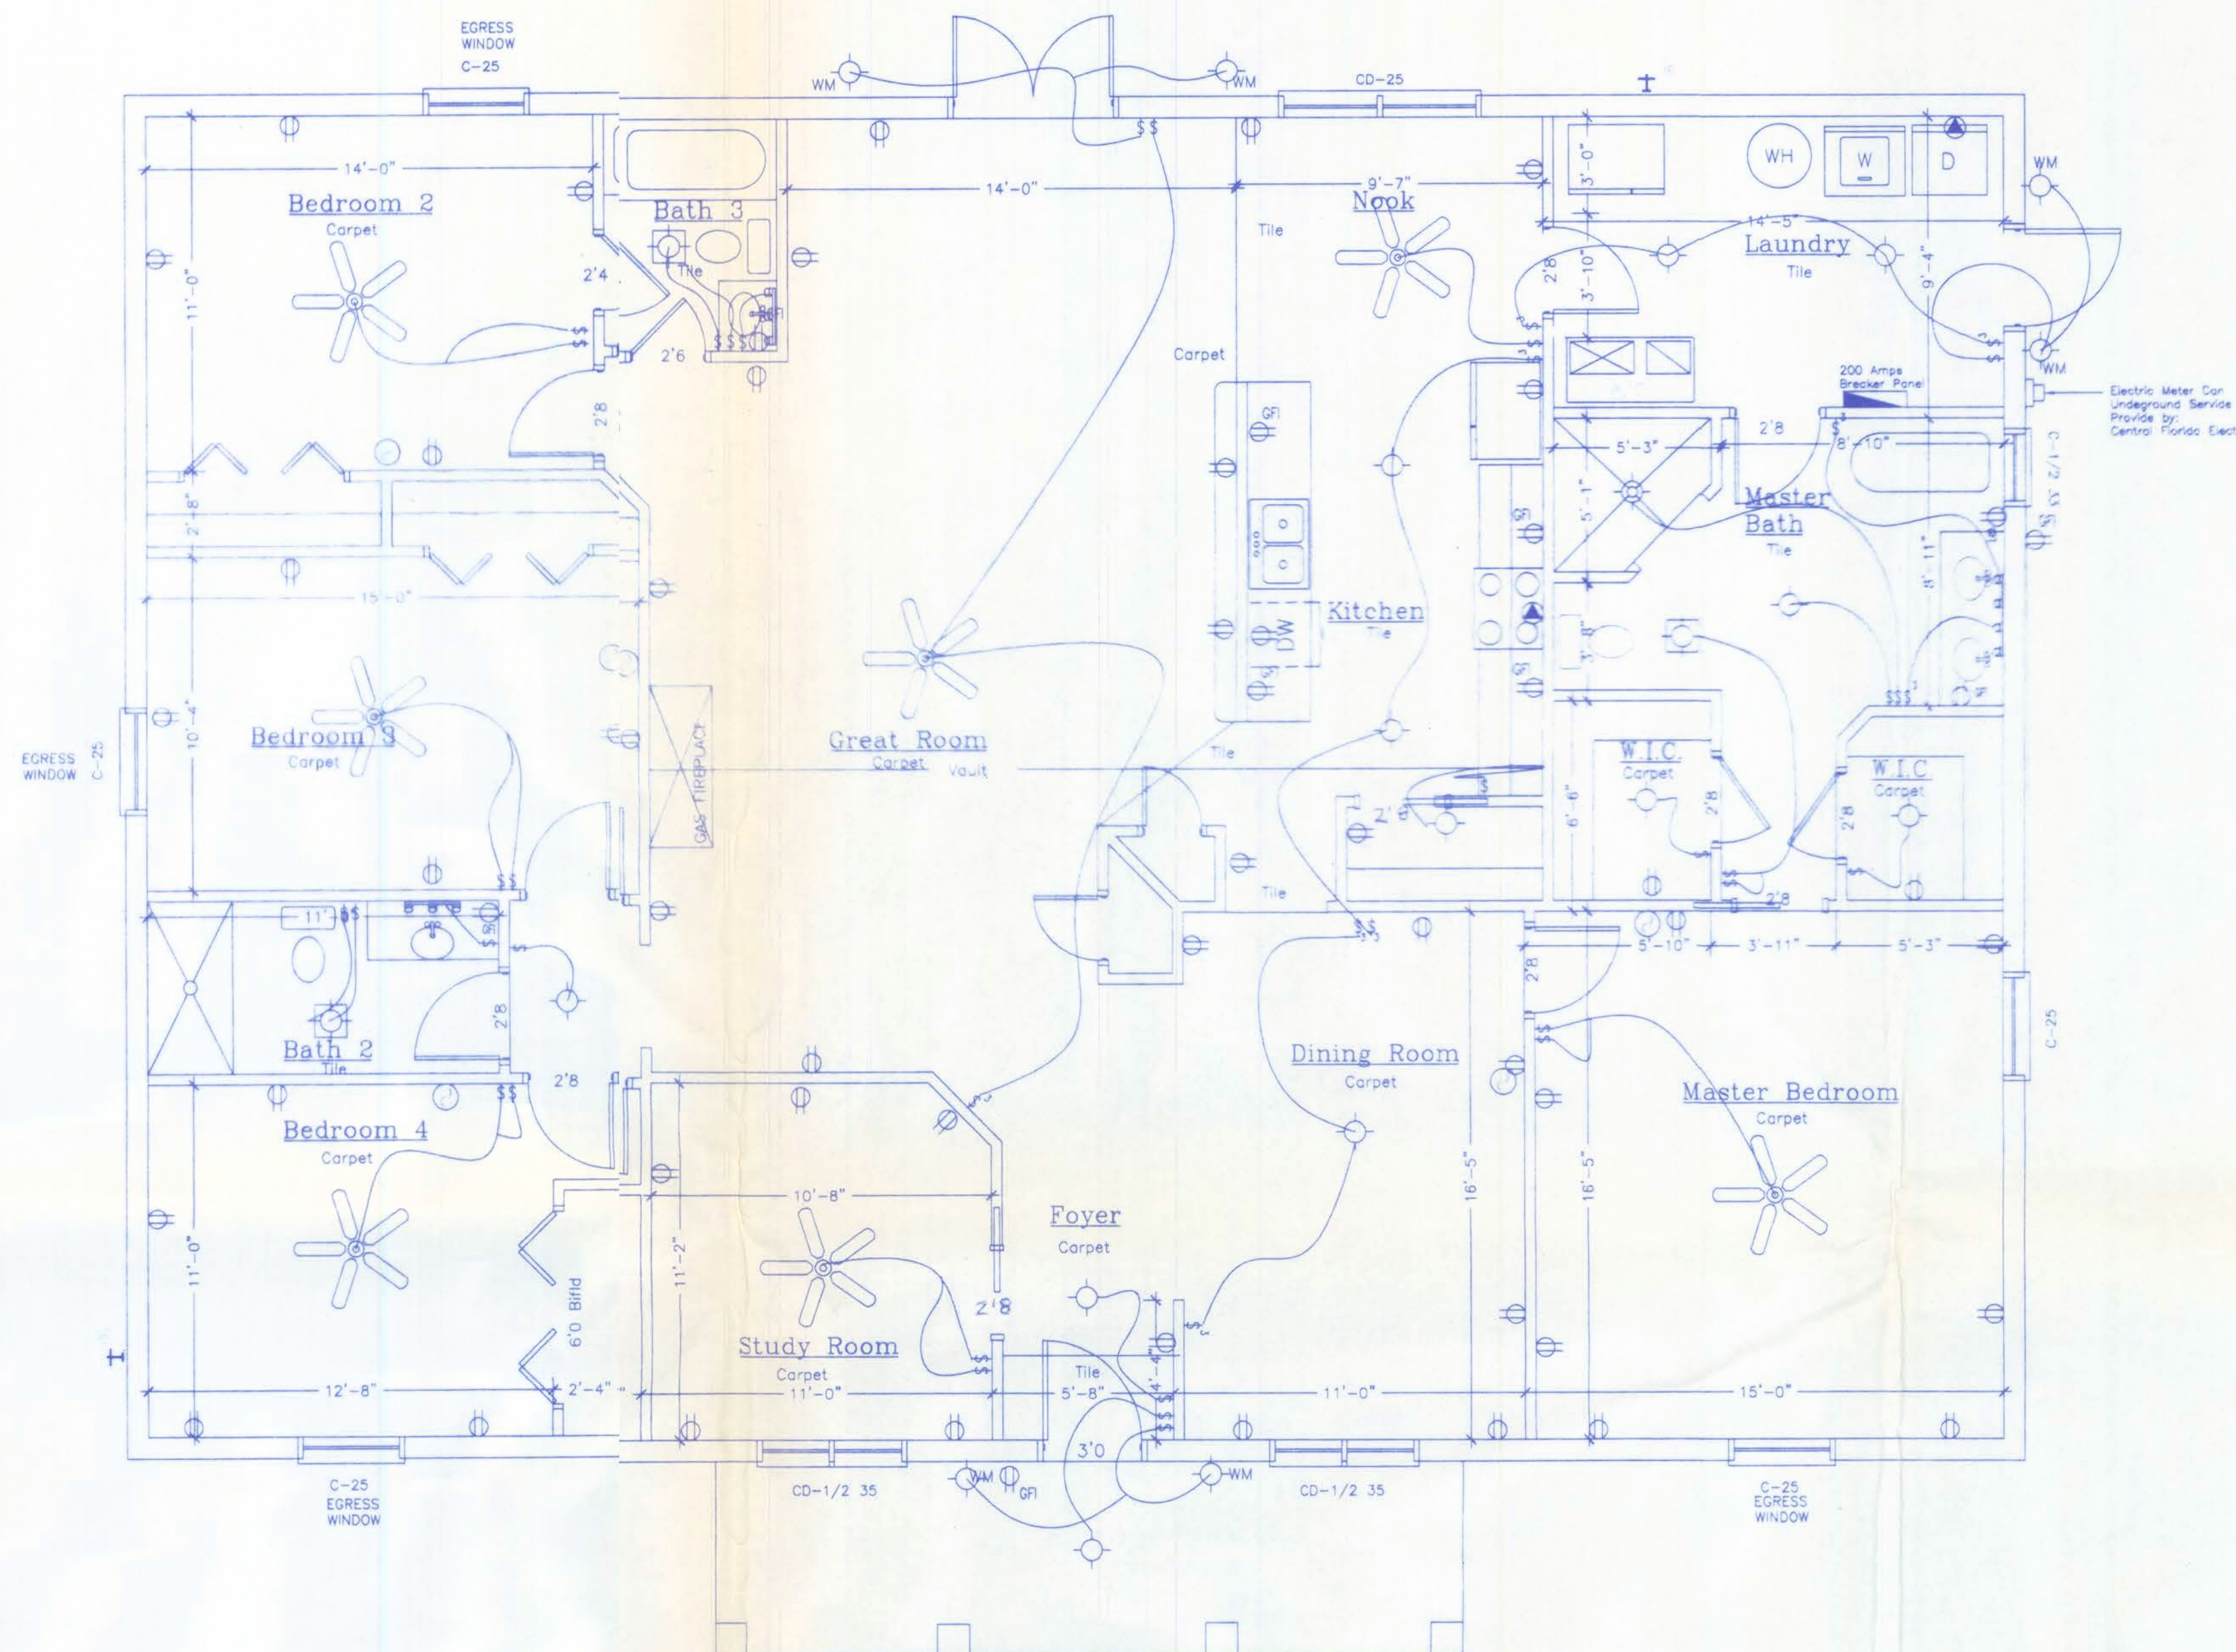

ELECTRICAL LEGEND

- 44" DUPLEX CONVENIENCE RECEPTACLE WITH GROUND (44" DENOTES HEIGHT A.F.F., IF OTHER THAN STD.) (GFI/GFCI DENOTES GROUND FAULT CIRCUIT INTERRUPTER (W.P. DENOTES WEATHER PROOF))
- SPECIAL RECEPTACLE WITH GROUND, SEE SPECIFICATIONS
- SINGLE POLE SWITCH AT STANDARD HEIGHT
- THREE WAY SWITCH AT STANDARD HEIGHT
- TELEPHONE OUTLET
- CEILING MOUNTED EXHAUST FAN VENTED TO EXTERIOR
- CABLE TV OUTLET
- ELECTRICAL DISTRIBUTION PANEL
- SMOKE DETECTOR
- THERMOSTAT

FLOOR PLAN

SCALE: 1/4" = 1'-0"

LIGHTING FIXTURE SCHEDULE

FIXTURE	DESCRIPTION
	SURFACE MOUNTED INCANDESCENT FIXTURE
	PRE-WIRED CEILING FAN
	DOUBLE FLOOD LIGHT FIXTURE
	FAN LIGHT VENTED TO EXTERIOR
	SURFACE MOUNTED INCANDESCENT FIXTURE

TYPICAL SPECIAL CIRCUIT ELECTRIC SCHEDULE

TWO GFI'S IN KITCHEN
ONE OR TWO GFI'S IN BATHS LOOPED TOGETHER
GFI IN GARAGE, FRONT ENTRY, AND REAR PORCH LOOPED TOGETHER
ONE GFI FOR JETTED TUB (OPTIONAL)
TWO AFI CIRCUITS PROVIDED FOR BEDROOMS

CODE COMPLIANCE - This building is designed in compliance with the requirements of the Florida Building Code, 2004. Structural members, cladding, fasteners and systems providing for the structural integrity of the building are designed to resist gravity loads prescribed Chapter 16 and wind loads prescribed in Section 16 and wind loads prescribed in Section 1609.6 Simplified Provisions for Low Rise Building

DESIGN LOADS			
a. Uniformly Distributed Live Loads (Section 1604.1)			
Floor Live Load	no	psf	
b. Roof Live Loads (Section 1604.6)			
6:12 Pitch	16	psf	
c. Wind Loads (Section 1606.2)			
1.) Enclosure Classification			
2.) Basic Wind Speed (3 second gust)			
3.) Wind Importance Factor, Iw			
4.) Exposure Category			
5.) Internal Pressure Coefficients:			
6.) Design Wind Pressures for Doors and Windows			
Opening Area (sf)	Inward Pressure (psf)	Outward Pressure (psf)	
0-10	21.8	-29.1	
11-20	20.8	-27.2	
21-50	19.5	-24.6	
51-100	18.5	-22.6	

Square Footage

Living... 2,497
Garage... 000
Entry... 140
Porch...
Total... 2,637



HOUSE CRAFT HOMES, L.L.C.

12523 NW U.S. Hwy. 441 - Alachua, FL 32615
Phone: (386) 462-5323/FAX: (386) 462-1509

Job name: TYRE

Model: CUSTOM Type: PLAN

Location: LAKE CITY Drawn By: J.D.H.

Checked By: J.D.H. Revision Date: 9/10/08
Scale: 1/4" = 1' Date: 9/10/08 Sheet: 2 of 3

Job name:		TYRE	
Model:	FOUNDATION	Type:	FOUNDATION
Location:	LAKE CITY	Drawn By:	J.D.H.
Checked By:	J.D.H.	Revision Date:	9/10/08
Scale:	1/4"=1'	Date:	9/10/08
		Sheet:	1 of 3

