



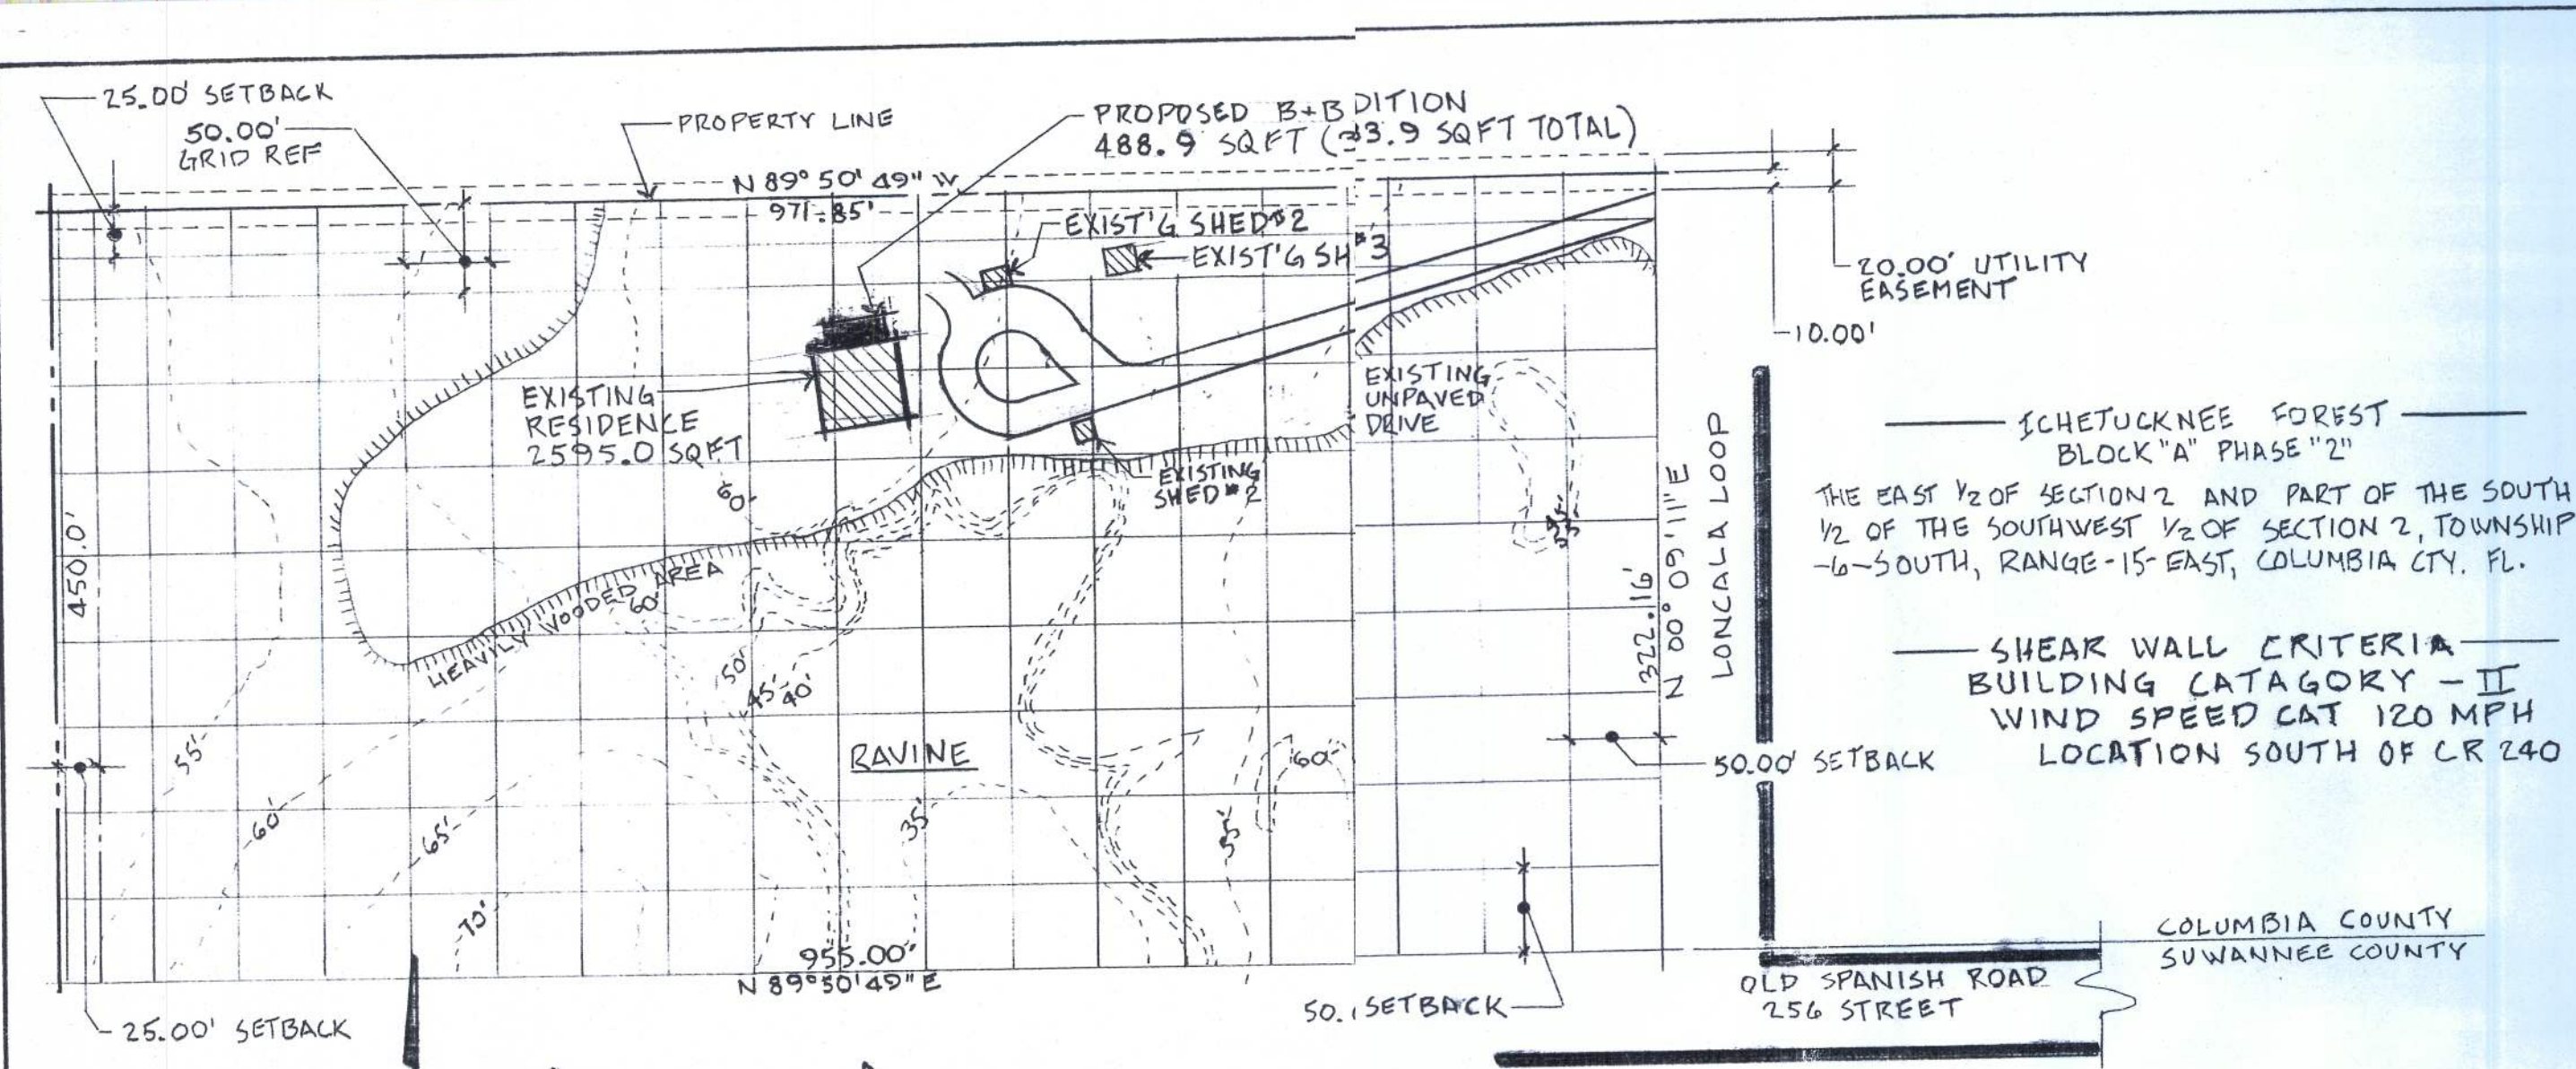

PLOT PLAN
SCALE = 1" = 100.0'

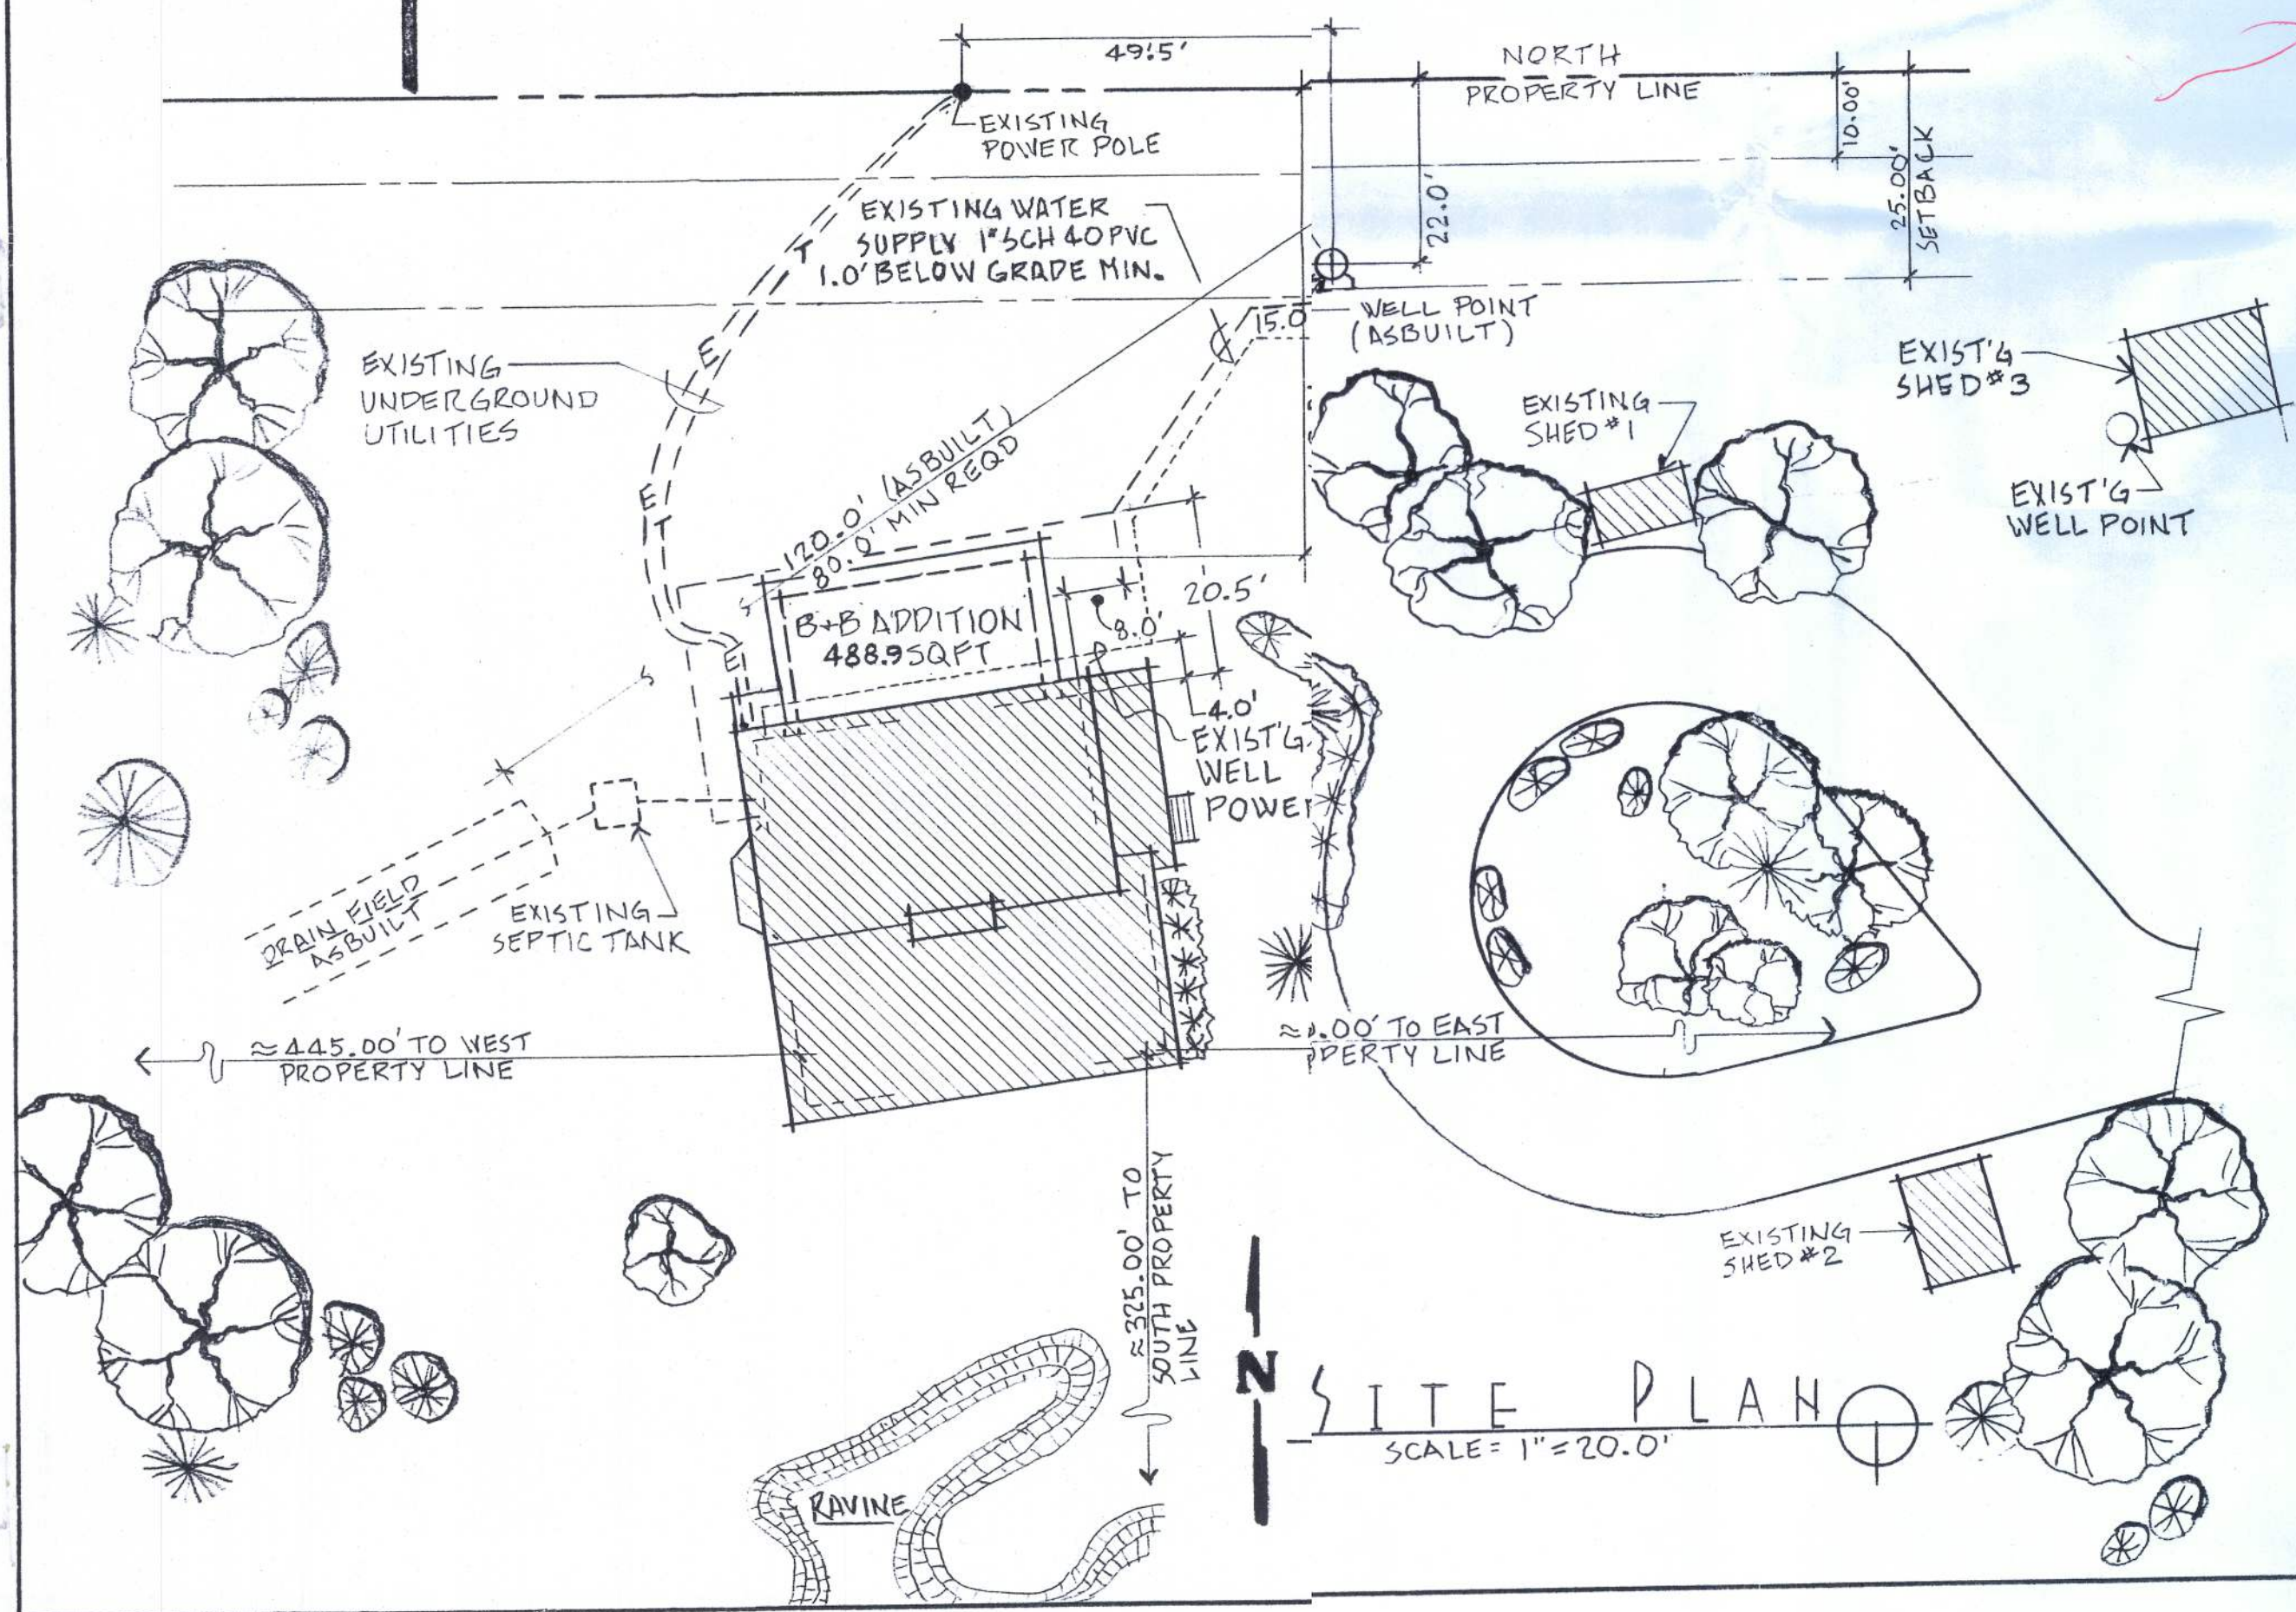

SITE PLAN
SCALE = 1" = 20.0'

REV. NO.		PERMIT NO.		PROJECT	
				DATE:	DESCRIPTION
1				10/27/14	GENERAL REVISIONS/CONTRATORS
3					APPLICATION FOR PERMIT



WINDLOAD DATA AND EXPOSURE

BASIC WIND SPEED = 120 MPH
 IMPORTANCE FACTOR = 1.0
 EXPOSURE CATEGORY = B
 HEIGHT AND EXPOSURE ADJUSTMENT COE. = 1.0
 RESIDENTIAL OCCUPANCY = GROUP R3
 MEAN ROOF HEIGHT = 15.0 FT
 ROOF CROSS SLOPE = 1.5 : 12
 EAVE OVERHANG = 2.0 FT
 WALL HEIGHT = 8.0 FT
 SHEAR WALL LOCATIONS = EXTERIOR WALLS ONLY (ALL WALLS 3.0 FT IN LGTH OR GRTR)
 COMPONENT AND CLADDING PRESSURES -
 ROOF (ZONE 1 = 14.9, -23.7, ZONE 2 = 14.9, -41.3 ZONE 3 = 14.9 - 61.0), WALL (ZONE 4 = 25.9, -28.1, ZONE 5 = 25.9, -34.7)
 (UNITS ARE IN PSF.)

SHEET INDEX

SHT. NO.	SHEET TITLE	CONSEC. NO.
T-1	SITE + PLOT PLANS, LEGAL DESCRIPTION	1
D-1	DEMOLITION PLAN	2
S-1	FOUNDATION PLAN	3
A-1	ELEVATION PLAN	4
A-2	FLOOR PLAN AND FINISH SCHEDULES	5
A-3	JOIST AND TRUSS PLANS, TRUSS LAYOUT	6
A-4	WALL SECTIONS	7
A-5	INTERIOR AND EXTERIOR ELEVATIONS	8
P-1	PLUMBING PLAN AND ISOMETRIC DETAIL	9
M-1	HVAC PLAN	10
E-1	ELECTRICAL PLAN	11

PROJECT: SPENCE RESIDENCE		
B+B ADDITION, 190 SW LONCALA LOOP		
SHEET TITLE:		
SITE + PLOT PLANS, LEGAL DESCRIPTION		
DRAWN BY:	DATE:	SHEET NO.
GD SPENCE	4 20 2014	T-1 1