

FLOOR PLAN

SCALE: 1/4" = 1'-0"

AREA SUMMARY	
LIVING	2470 SQ. FEET
GARAGE/STORAGE	574 SQ. FEET
FRONT/SIDE PORCH	414 SQ. FEET
REAR PATIO SLAB	254 SQ. FEET
TOTAL	3712 SQ. FEET

ROUNDTABLE, LLC

SCALE: SHOWN	DATE: 7-31-06	SPRINGS DRAFTING SERVICE	HIGH SPRINGS, FL
DRAWN BY: PJB	REV: 8-10-06		Ph. 386-697-1168


A NEW SINGLE FAMILY HOME AT:
RIVER RISE SPEC
RIVER RISE, FORT WORTH, FLORIDA





FRONT ELEVATION

SCALE: 1/4" = 1'-0"

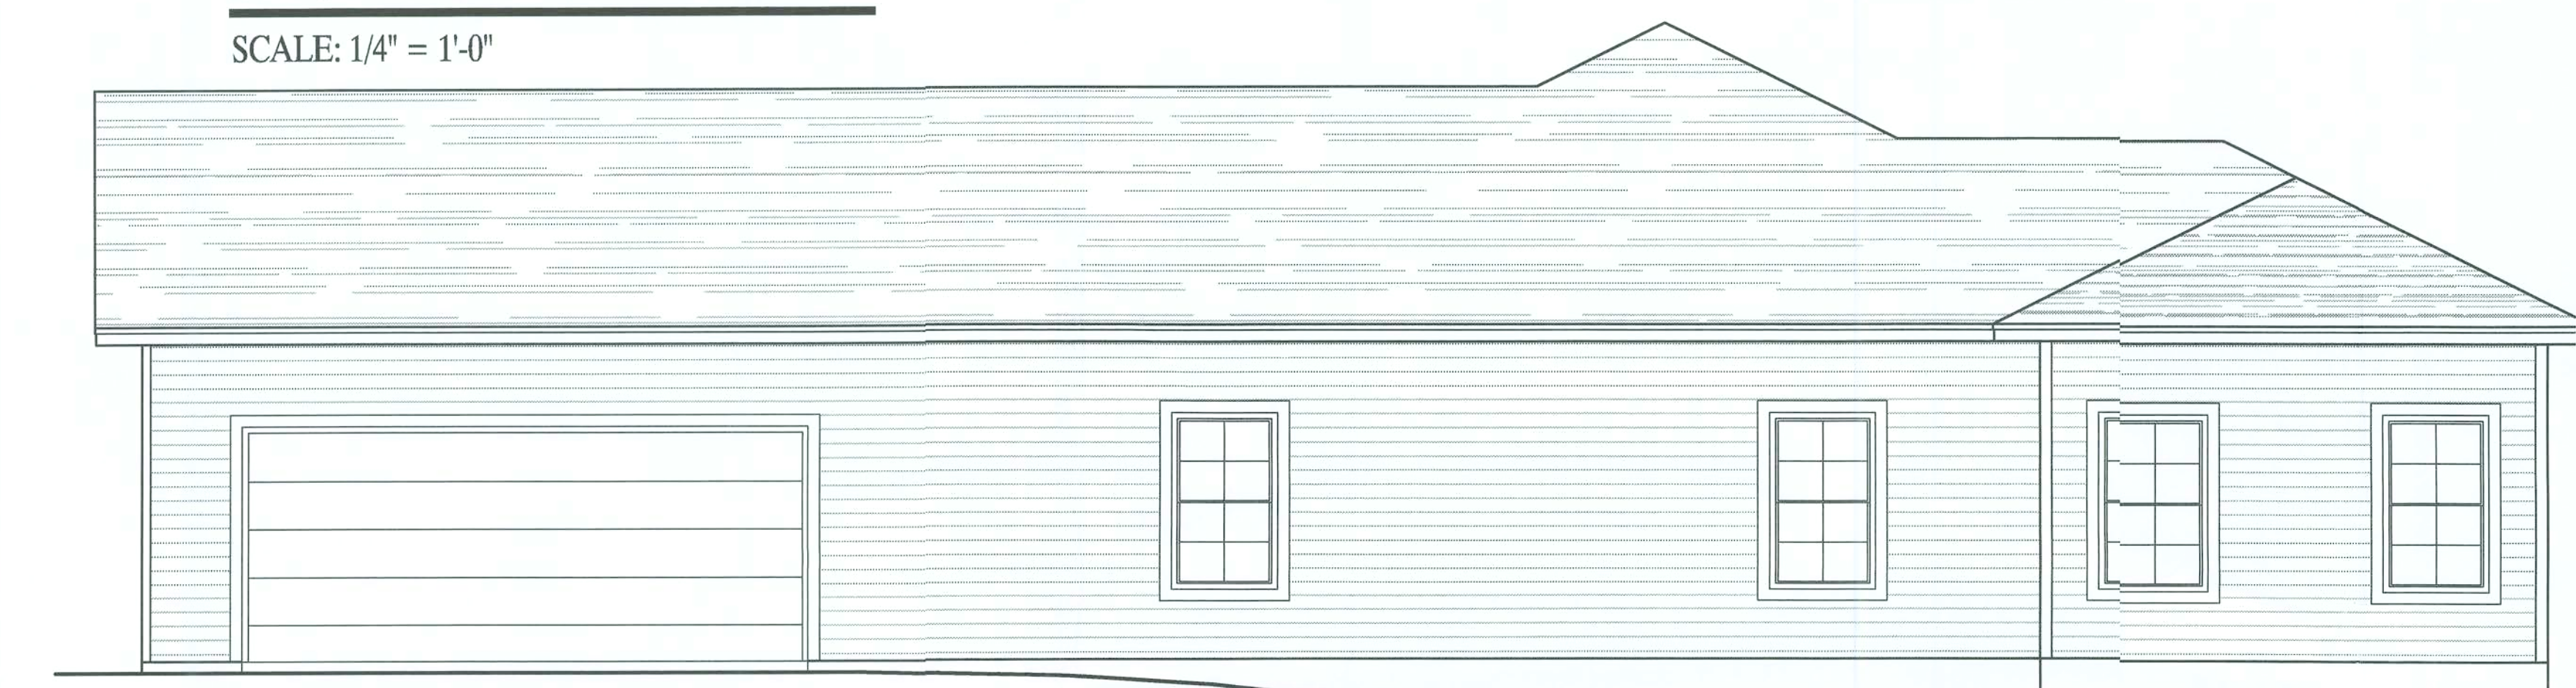

RIGHT ELEVATION

SCALE: 1/4" = 1'-0"



LEFT ELEVATION


SCALE: 1/4" = 1'-0"



REAR ELEVATION

SCALE: 1/4" = 1'-0"

ELECTRICAL SYMBOLS LEGEND	
	RECEPTACLE
	GROUND FAULT INTERRUPT RECEPTACLE
	220 VOLT RECEPTACLE
	SWITCH
	3 WAY SWITCH
	PREWIRE FOR CEILING FAN W/ LIGHT KIT
	C.L.G. MOUNTED INCANDESCENT FIXTURE
	RECESSED INCANDESCENT FIXTURE
	C.L.G. MOUNTED SMOKE DETECTOR
	CABLE TELEVISION OUTLET
	TELEPHONE JACK
	FLUORESCENT FIXTURE

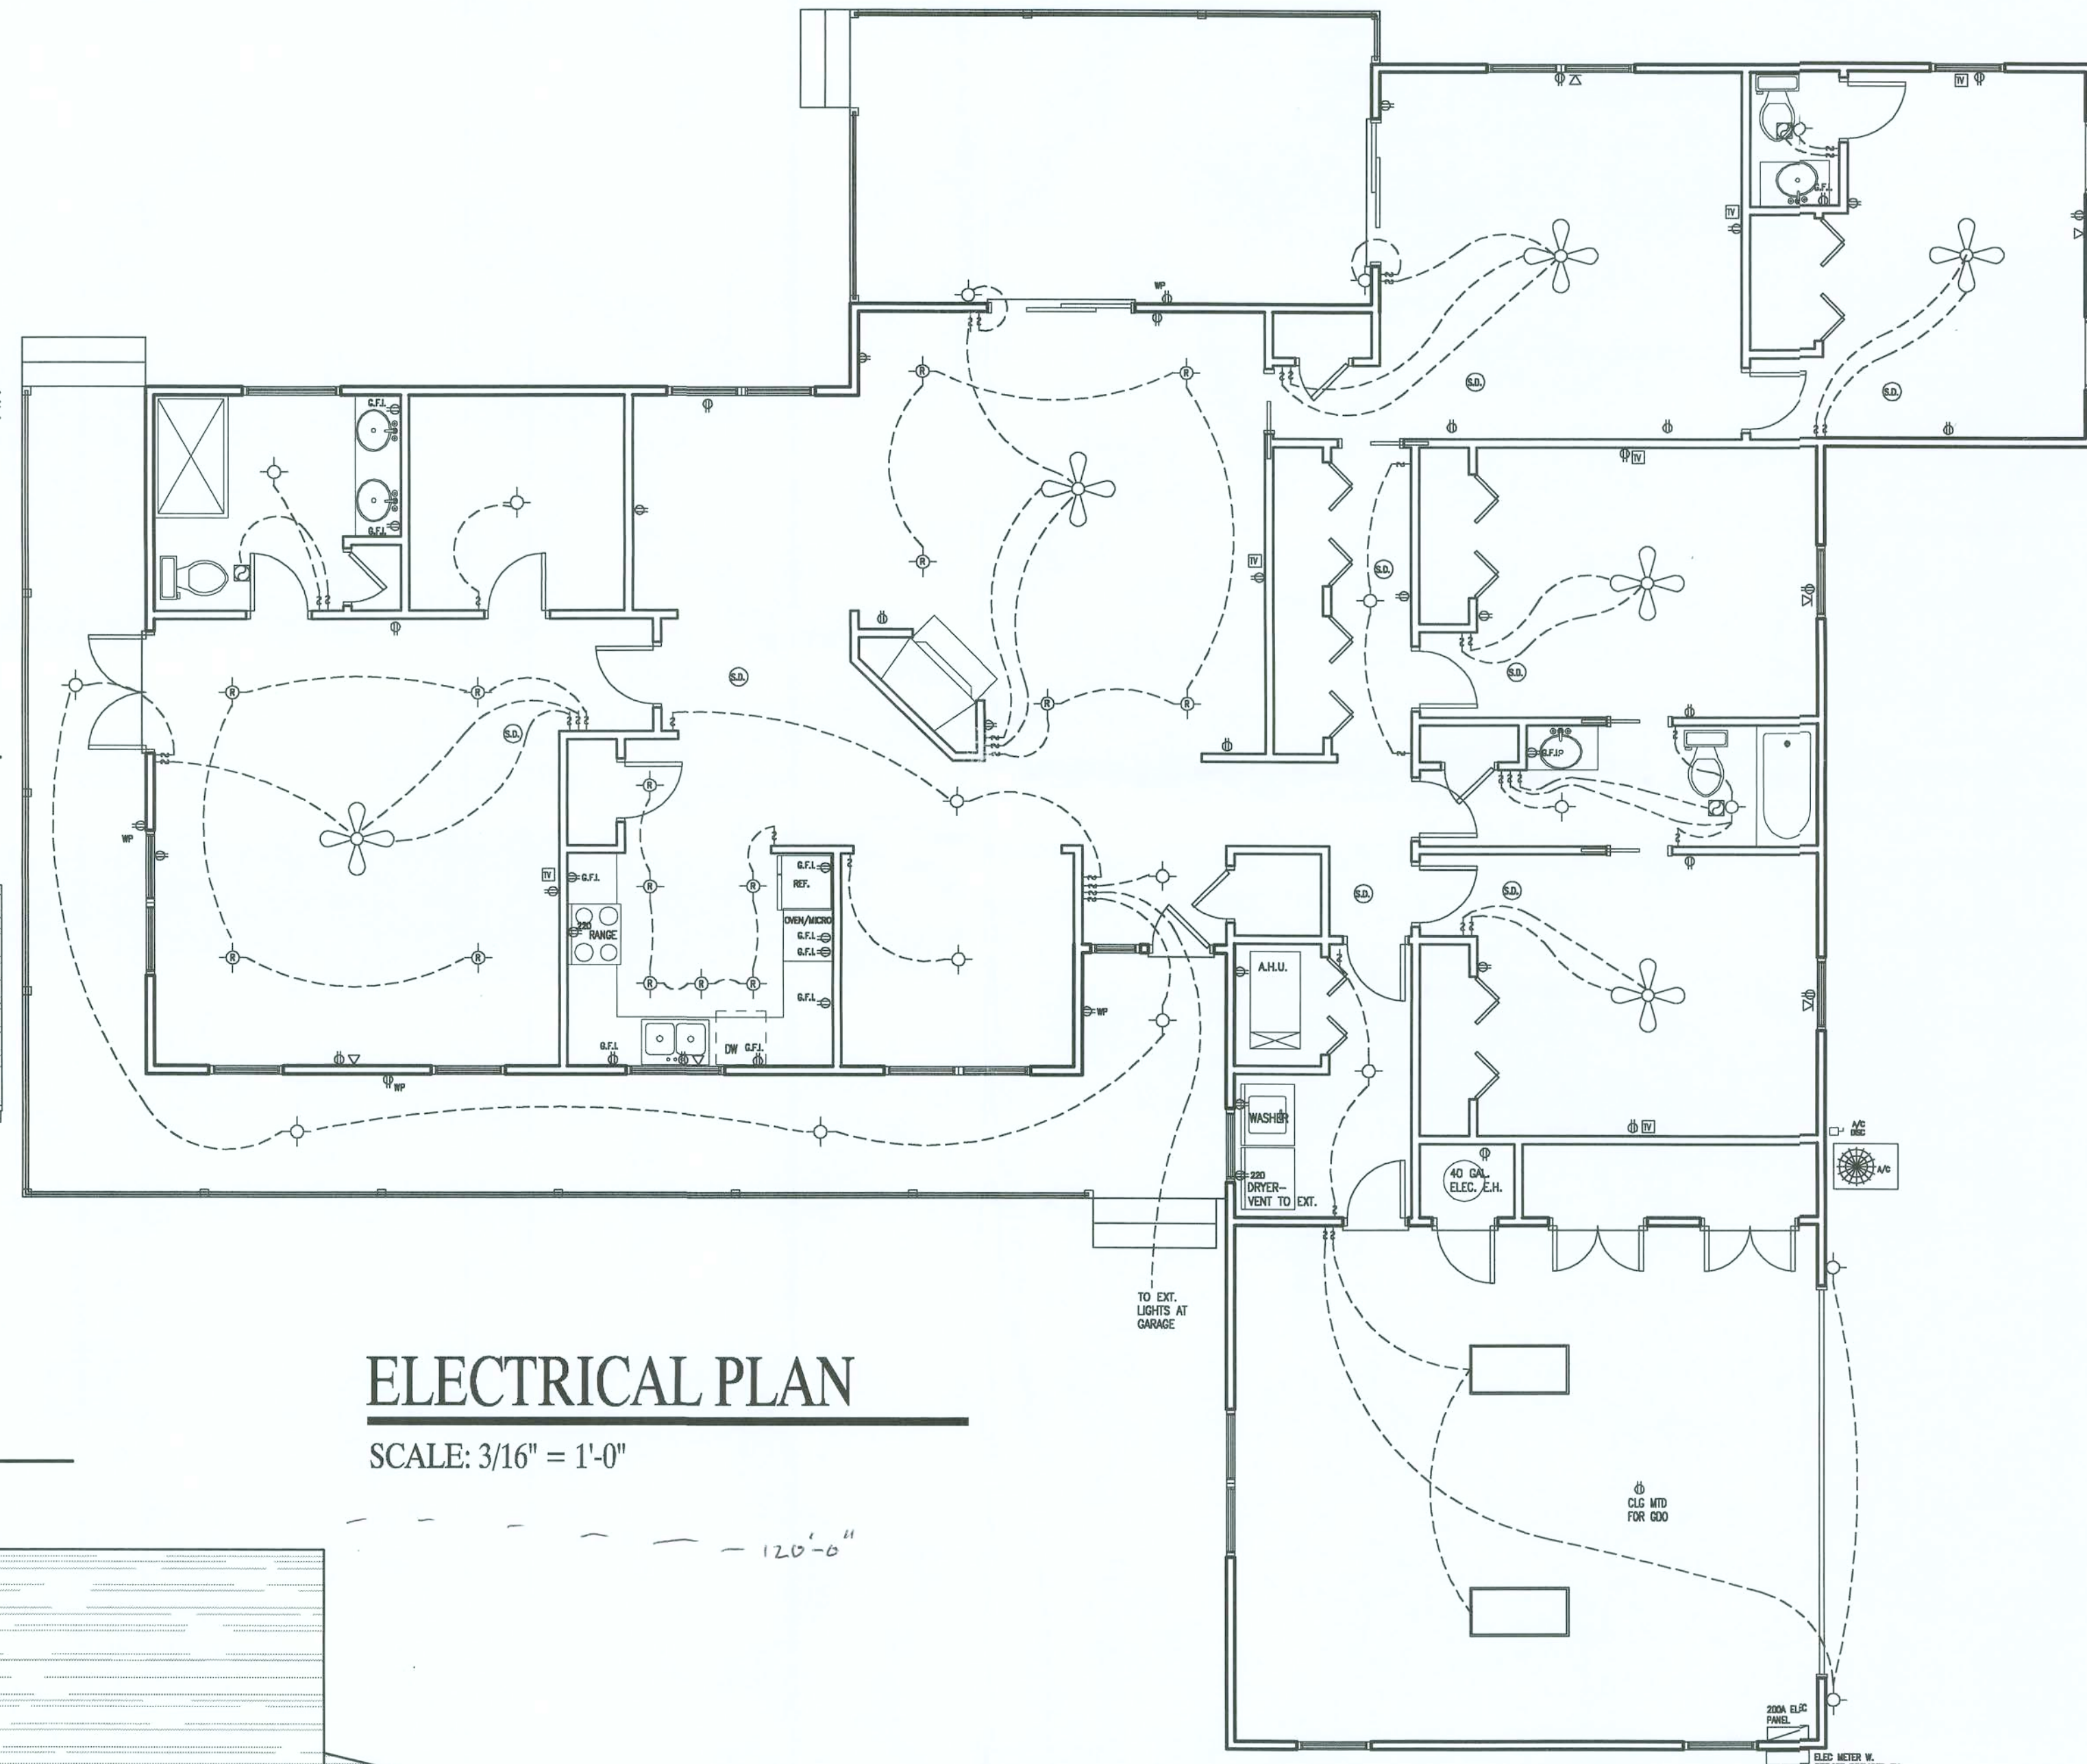

ELECTRICAL PLAN

SCALE: 3/16" = 1'-0"

ROUNDTABLE, LLC			
SCALE: SHOWN	DATE: 7-31-06	SPRINGS DRAFTING SERVICE	WILKIE SPRINGS, FL
SHEET	DRAWN BY: P.J.B.	REV: 8-10-06	PH: 386-697-468
A NEW SINGLE FAMILY HOME AT: RIVER RISE SPEC RIVER RISE, FORT WHITE, FLORIDA			