



Leslie Residence

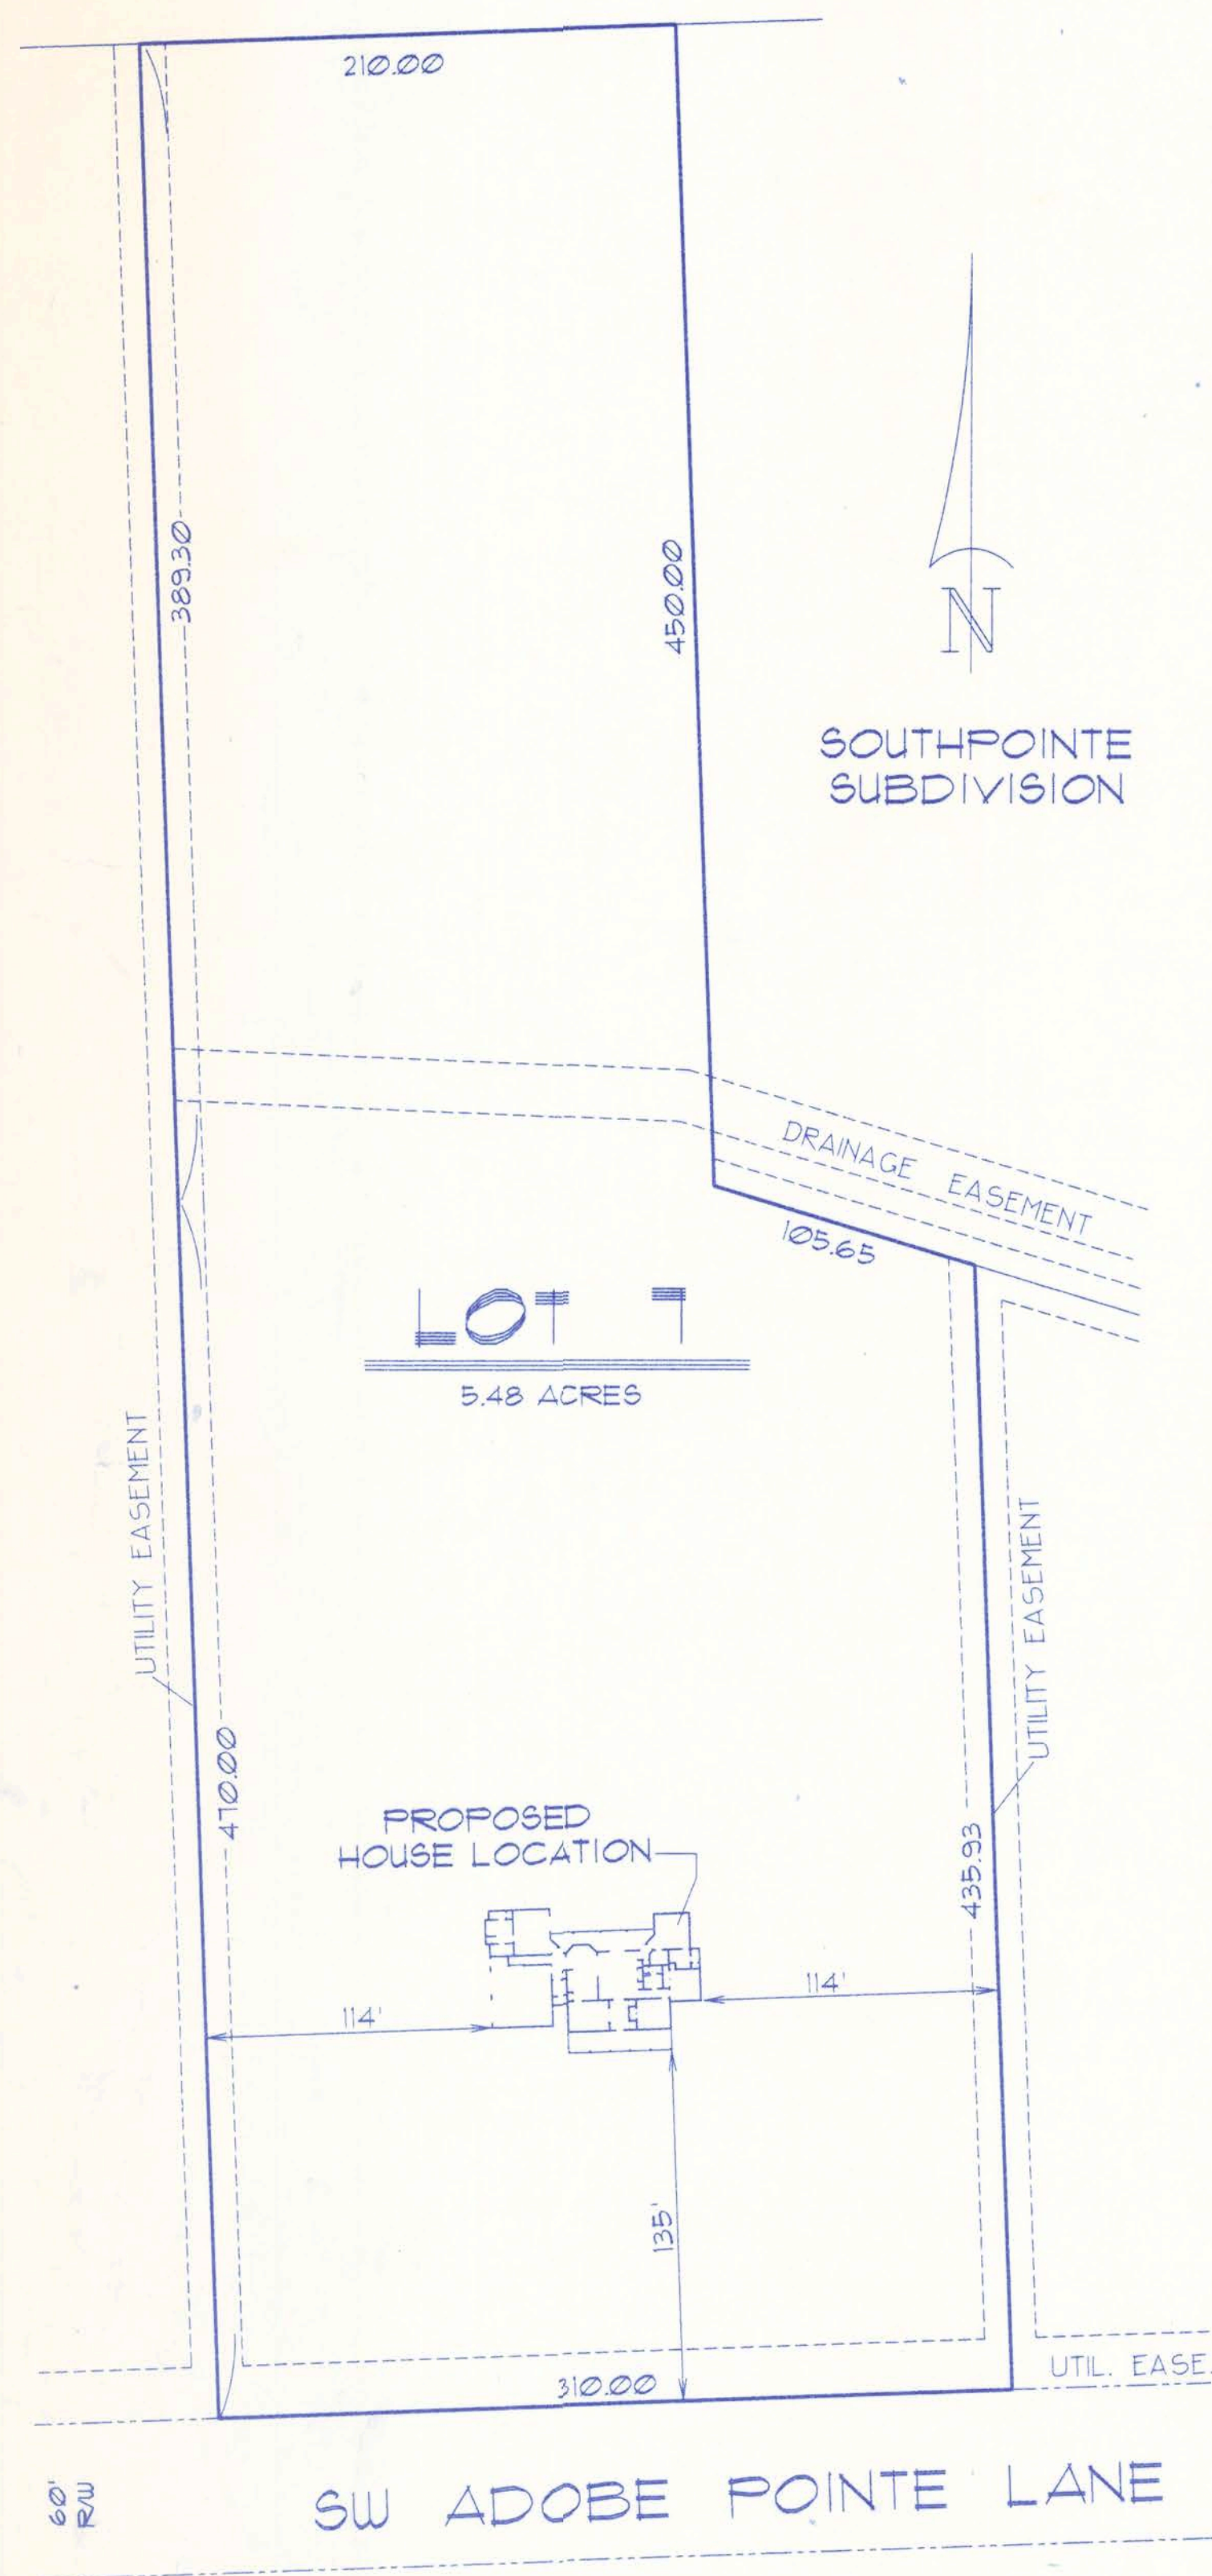

SITE PLAN
SCALE: 1 IN. = 60 FT.

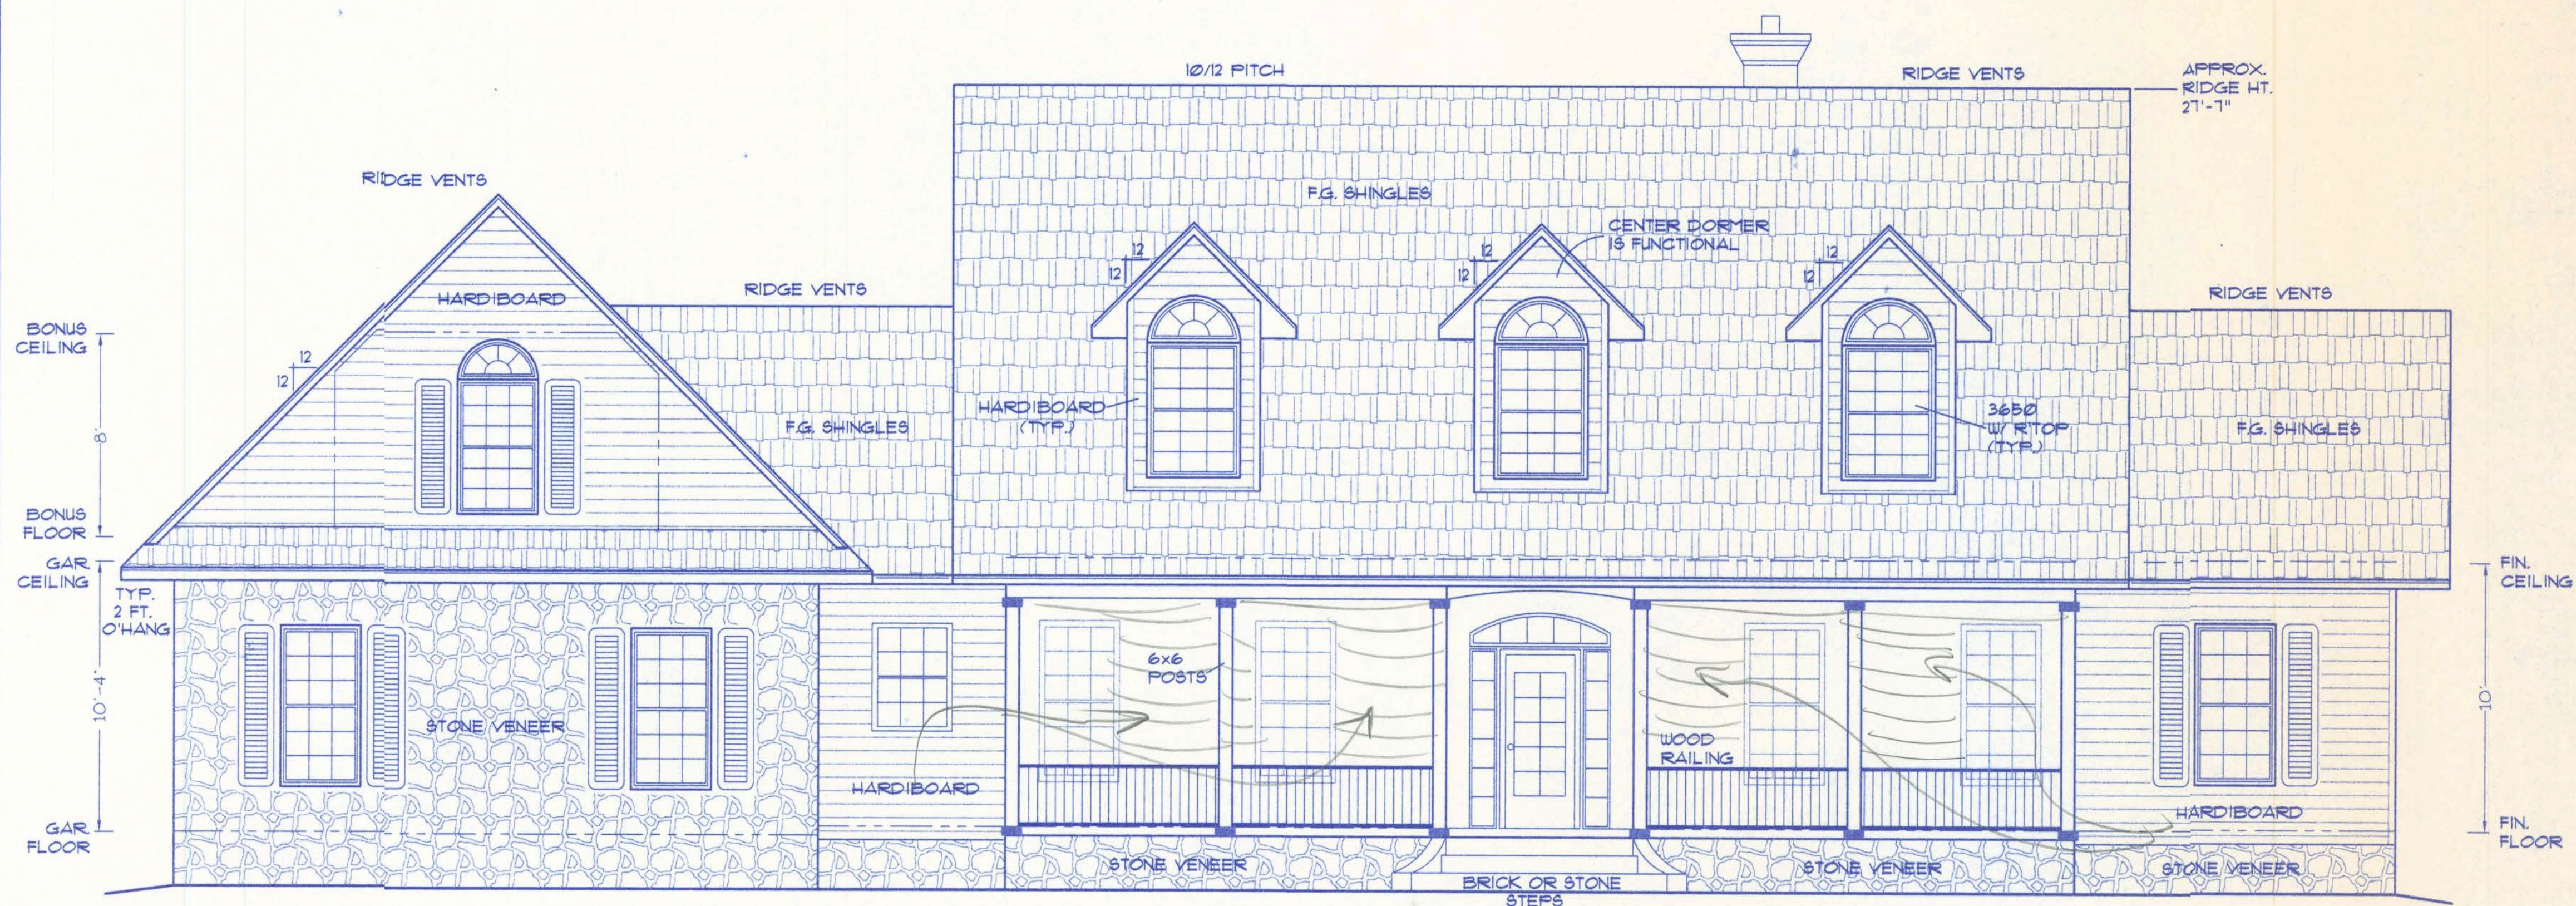

FRONT ELEVATION
SCALE: 1/4 IN. = 1 FT.

Index to Sheets

- SHEET 1 - ELEVATION + SITE PLAN
- SHEET 2 - ELEVATIONS
- SHEET 3 - FLOOR PLAN + GEN. NOTES
- SHEET 4 - WALL SECTION + PRELIM. FOUNDATION + PLUMBING FIXT.
- SHEET 5 - ELECTRICAL


BLOWN INSULATION

GENE LESLIE
(H) 755-4971
(C) 365-5458

SEE SHEET 3 FOR GENERAL NOTES
CONCERNING USES & LIMITATIONS OF THIS PLAN


1

FILE: 02-029	LESLIE RESIDENCE	SHEET: 1 of 5
DATE: 8-29-02	PREPARED BY: TIM DELBENE Residential Drafting + Design	CAD FILE: 02029
DRAWN: T A D	Rt. 4, Box 330, Lake City, FL 32055 Phone (904) 755-5891	REV:
CHECK: T A D		REV:

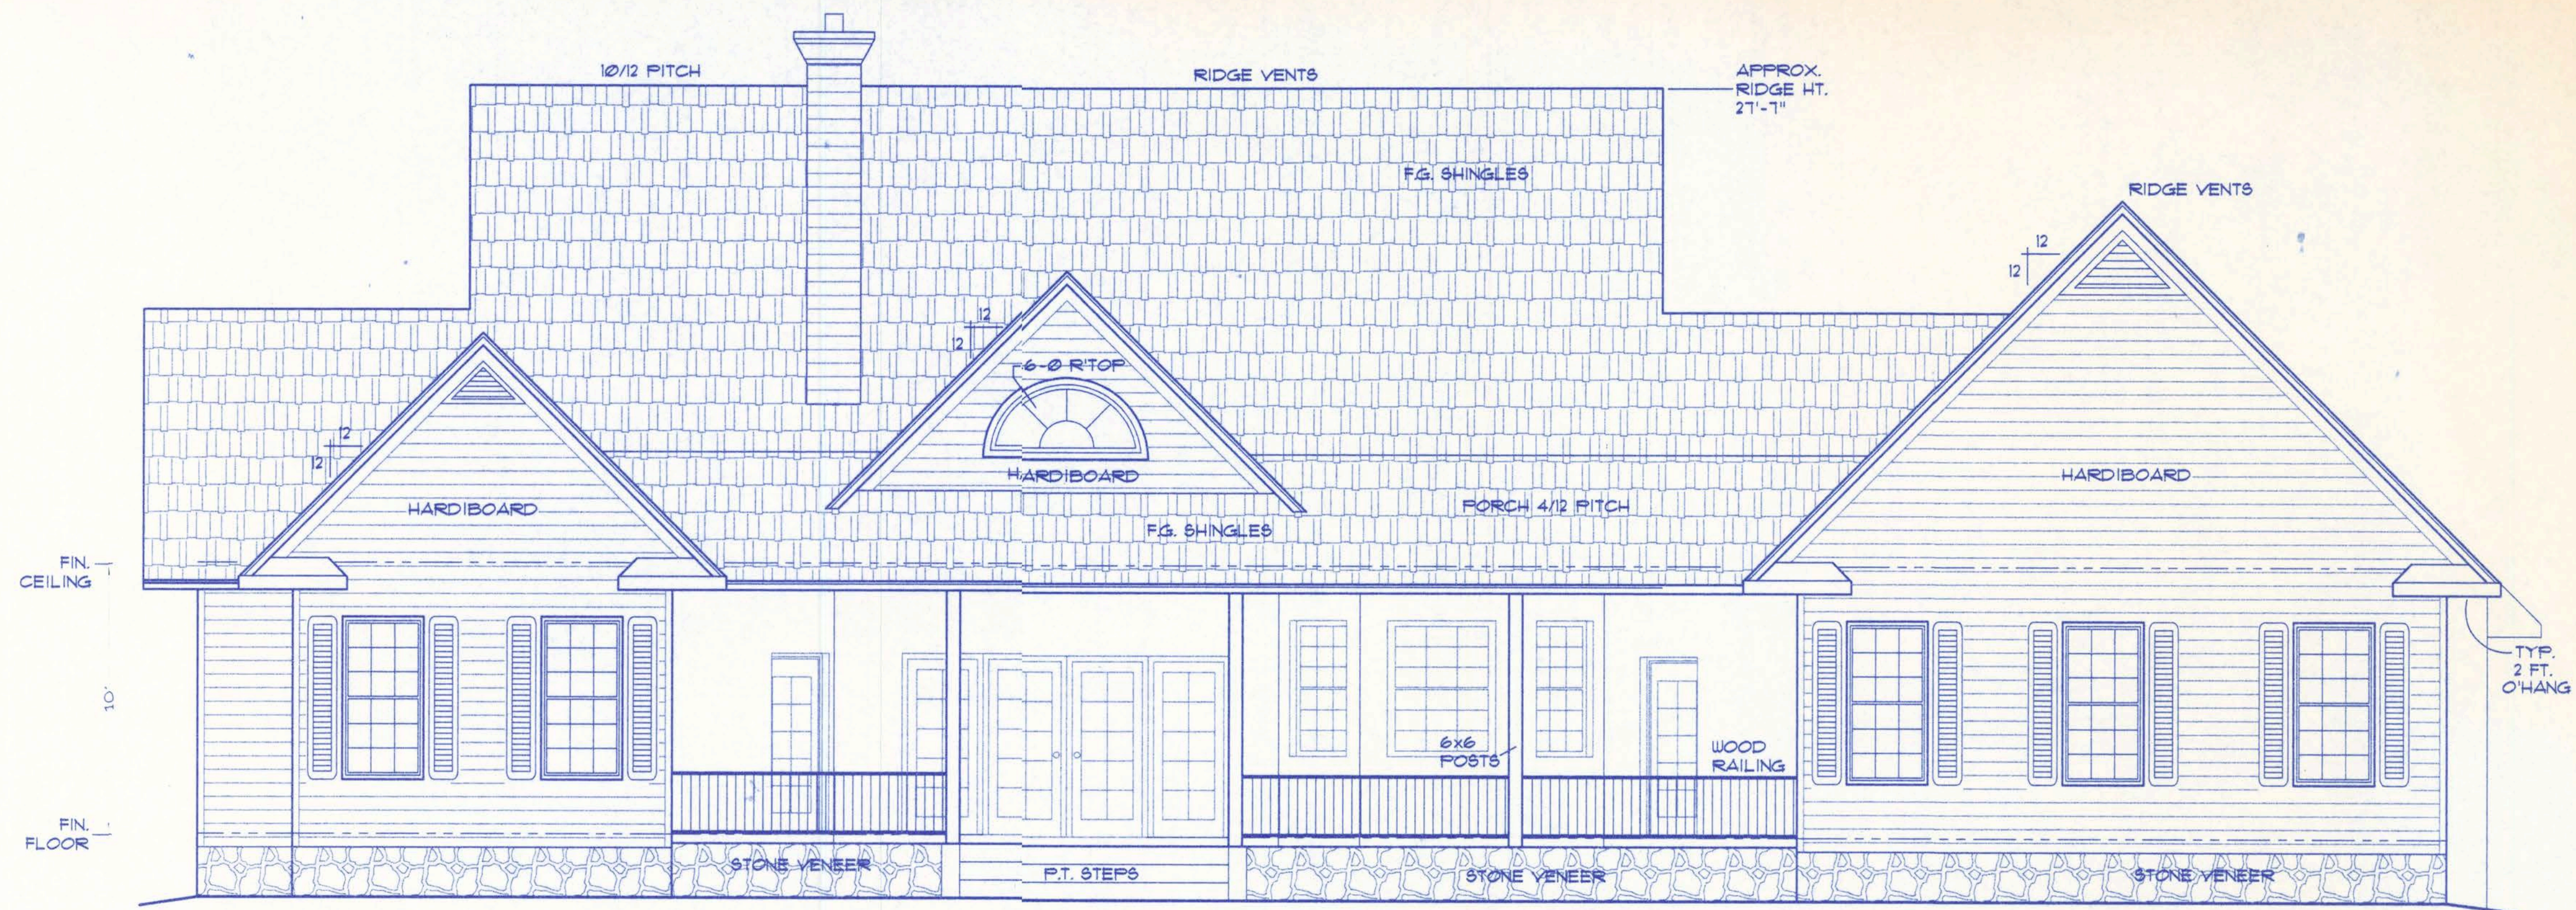


REAR ELEVATION

SCALE: 1/4 IN. = 1 FT.

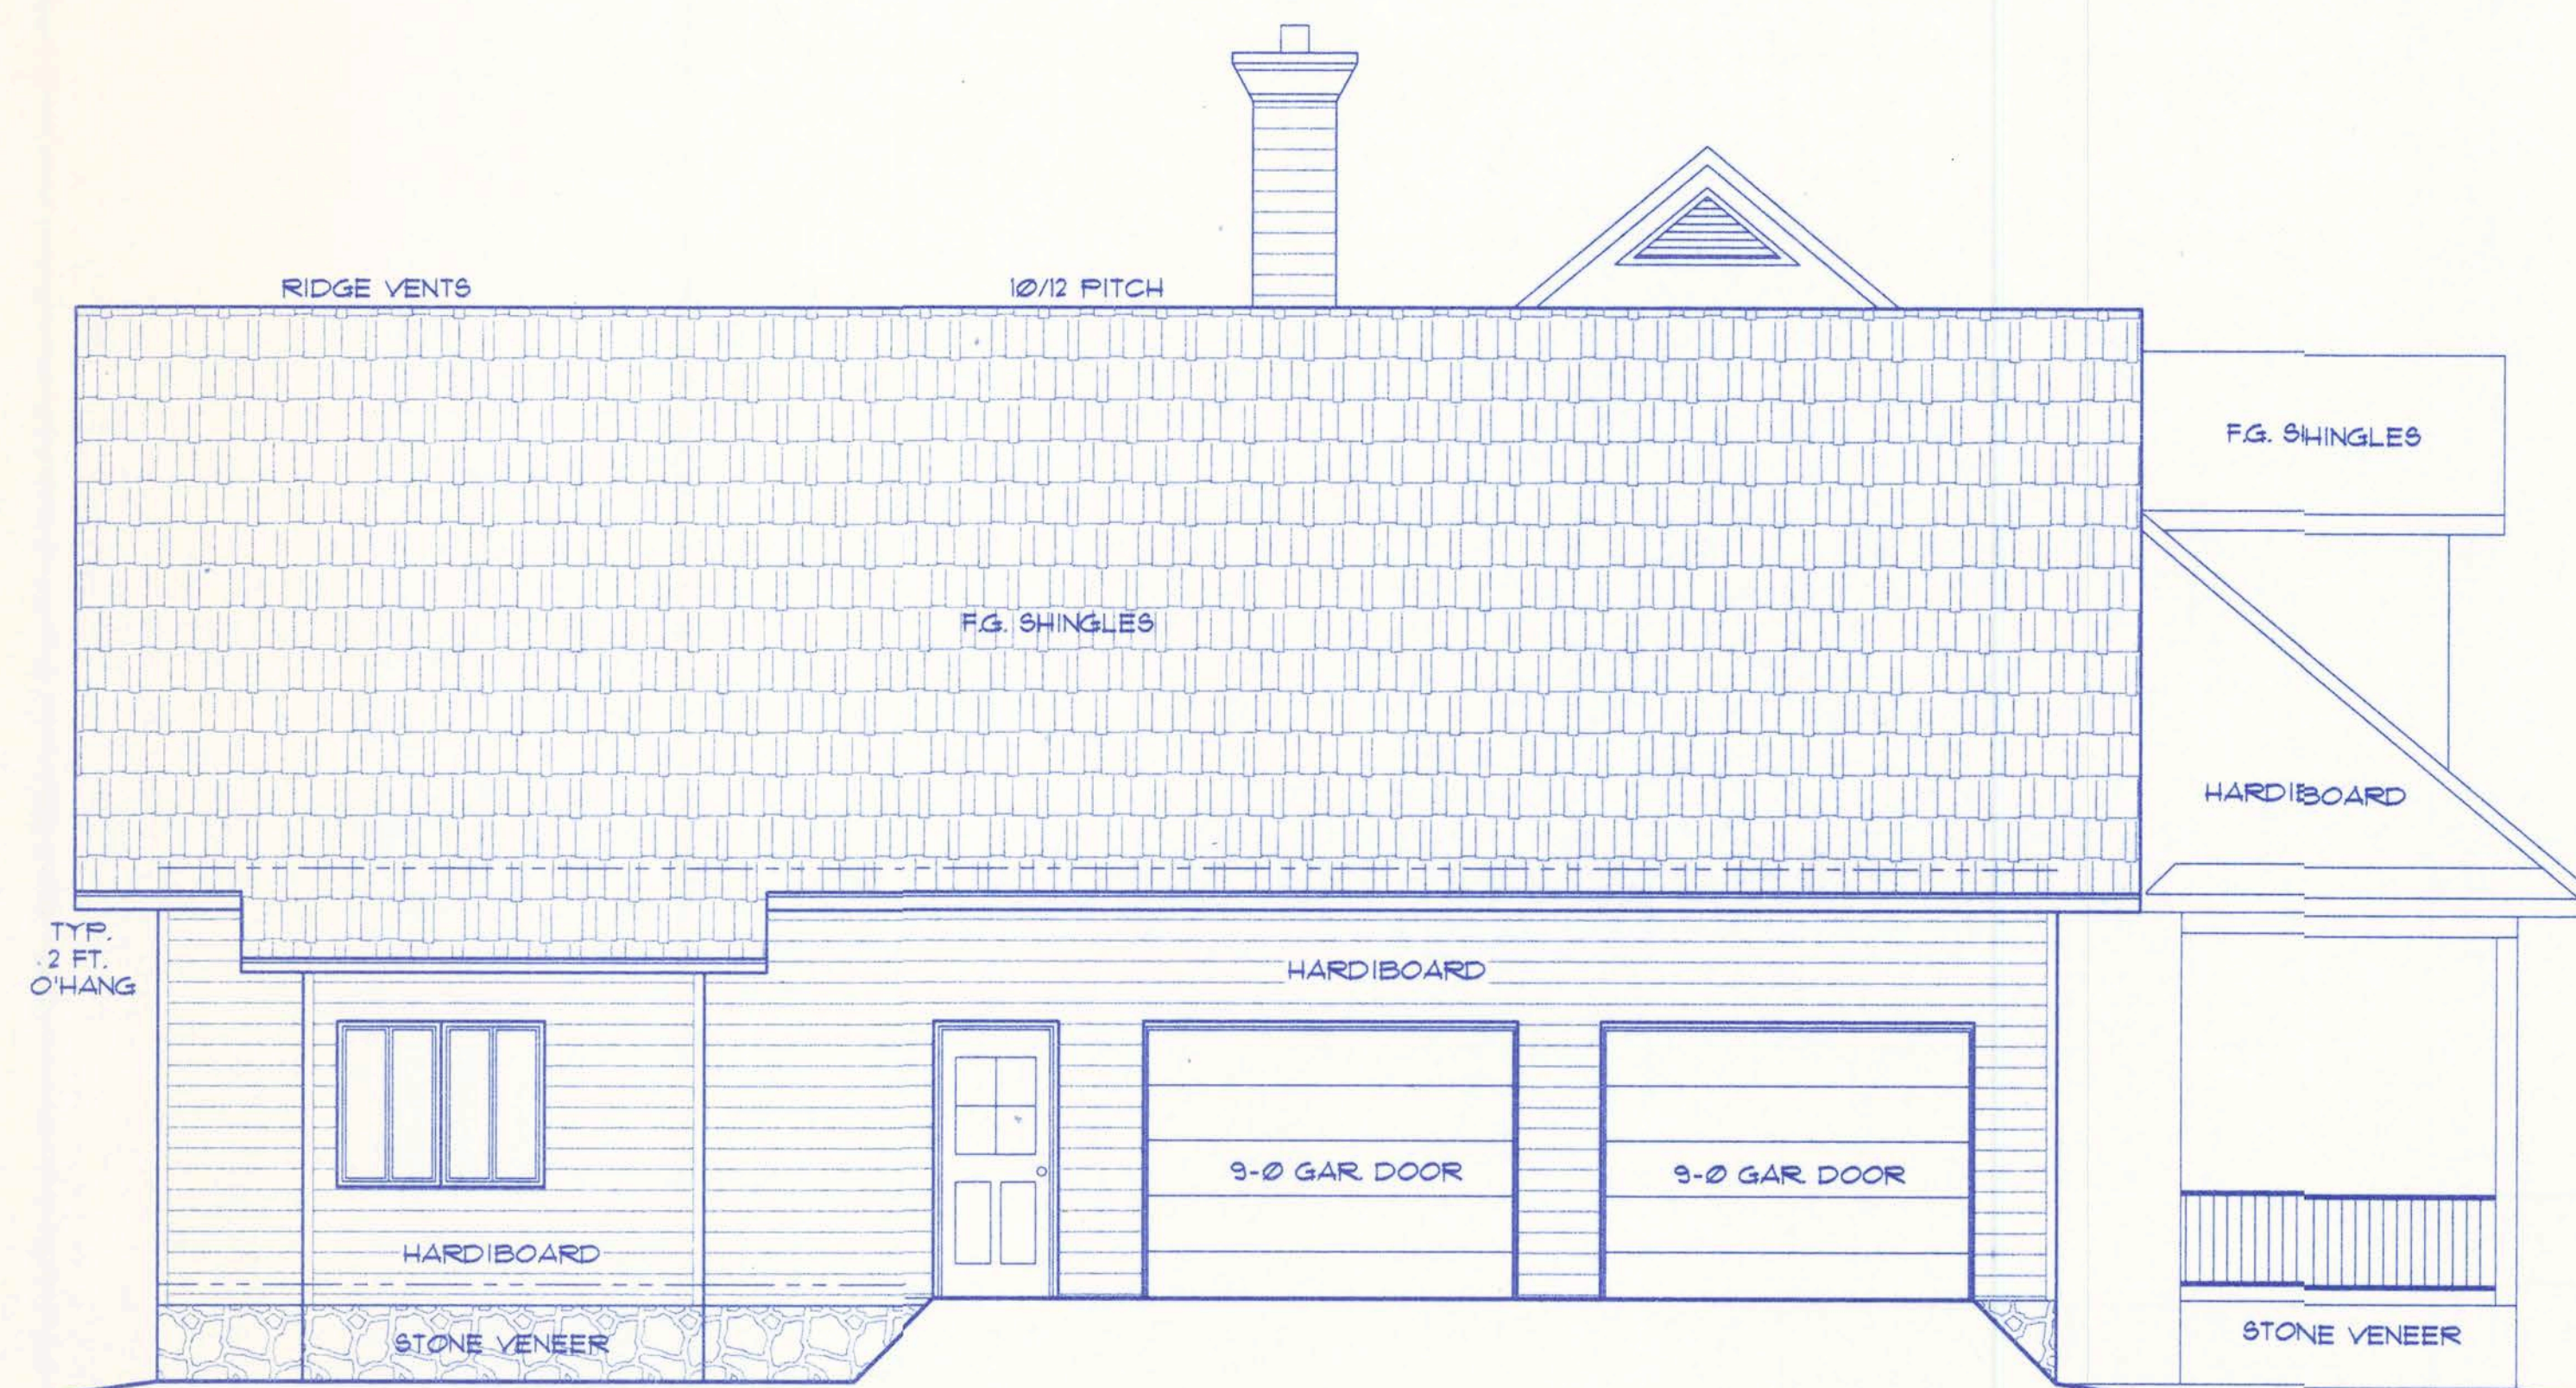

LEFT ELEVATION

SCALE: 1/4 IN. = 1 FT.

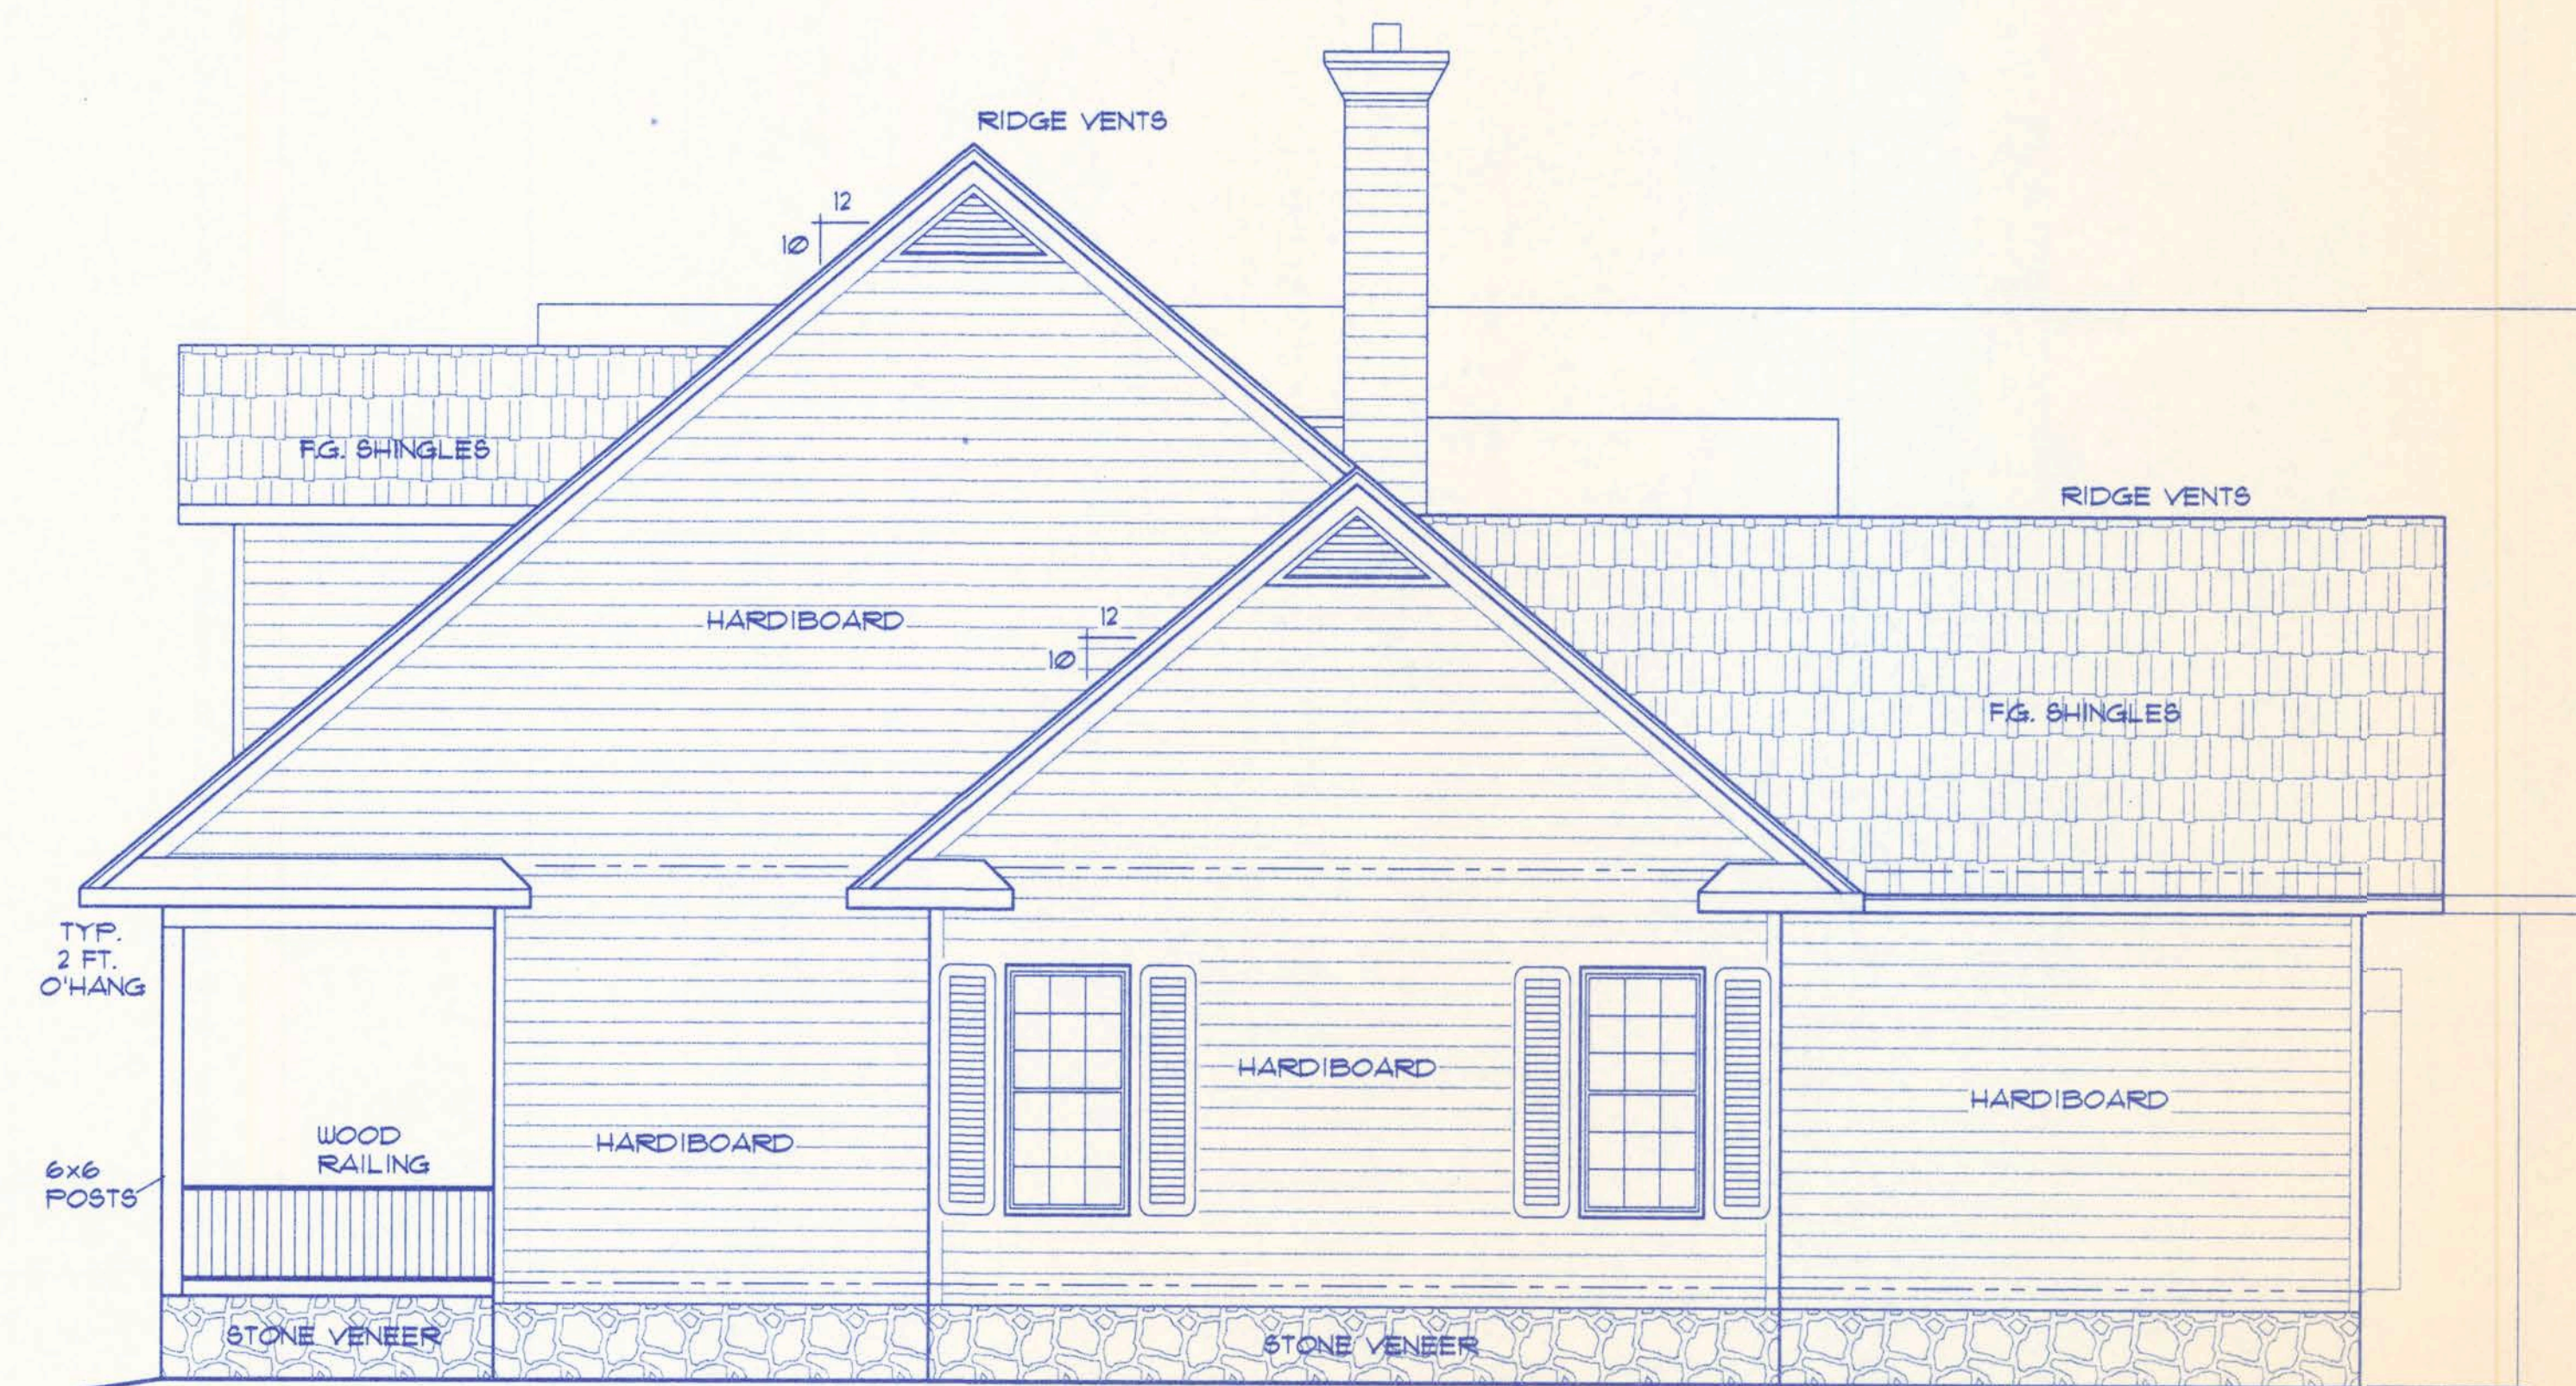


RIGHT ELEVATION

SCALE: 1/4 IN. = 1 FT.

SEE SHEET 3 FOR GENERAL NOTES
CONCERNING USES & LIMITATIONS OF THIS PLAN

2

FILE: 02-029	LESLIE RESIDENCE PREPARED BY: TIM DELBENE Residential Drafting + Design Rt. 4, Box 330, Lake City, FL 32055 Phone (904) 755-5891	SHEET: 2 of 5
DATE: 8-29-02		CAD FILE: 02029
DRAWN: T A D		REV:
CHECK: T A D		REV:

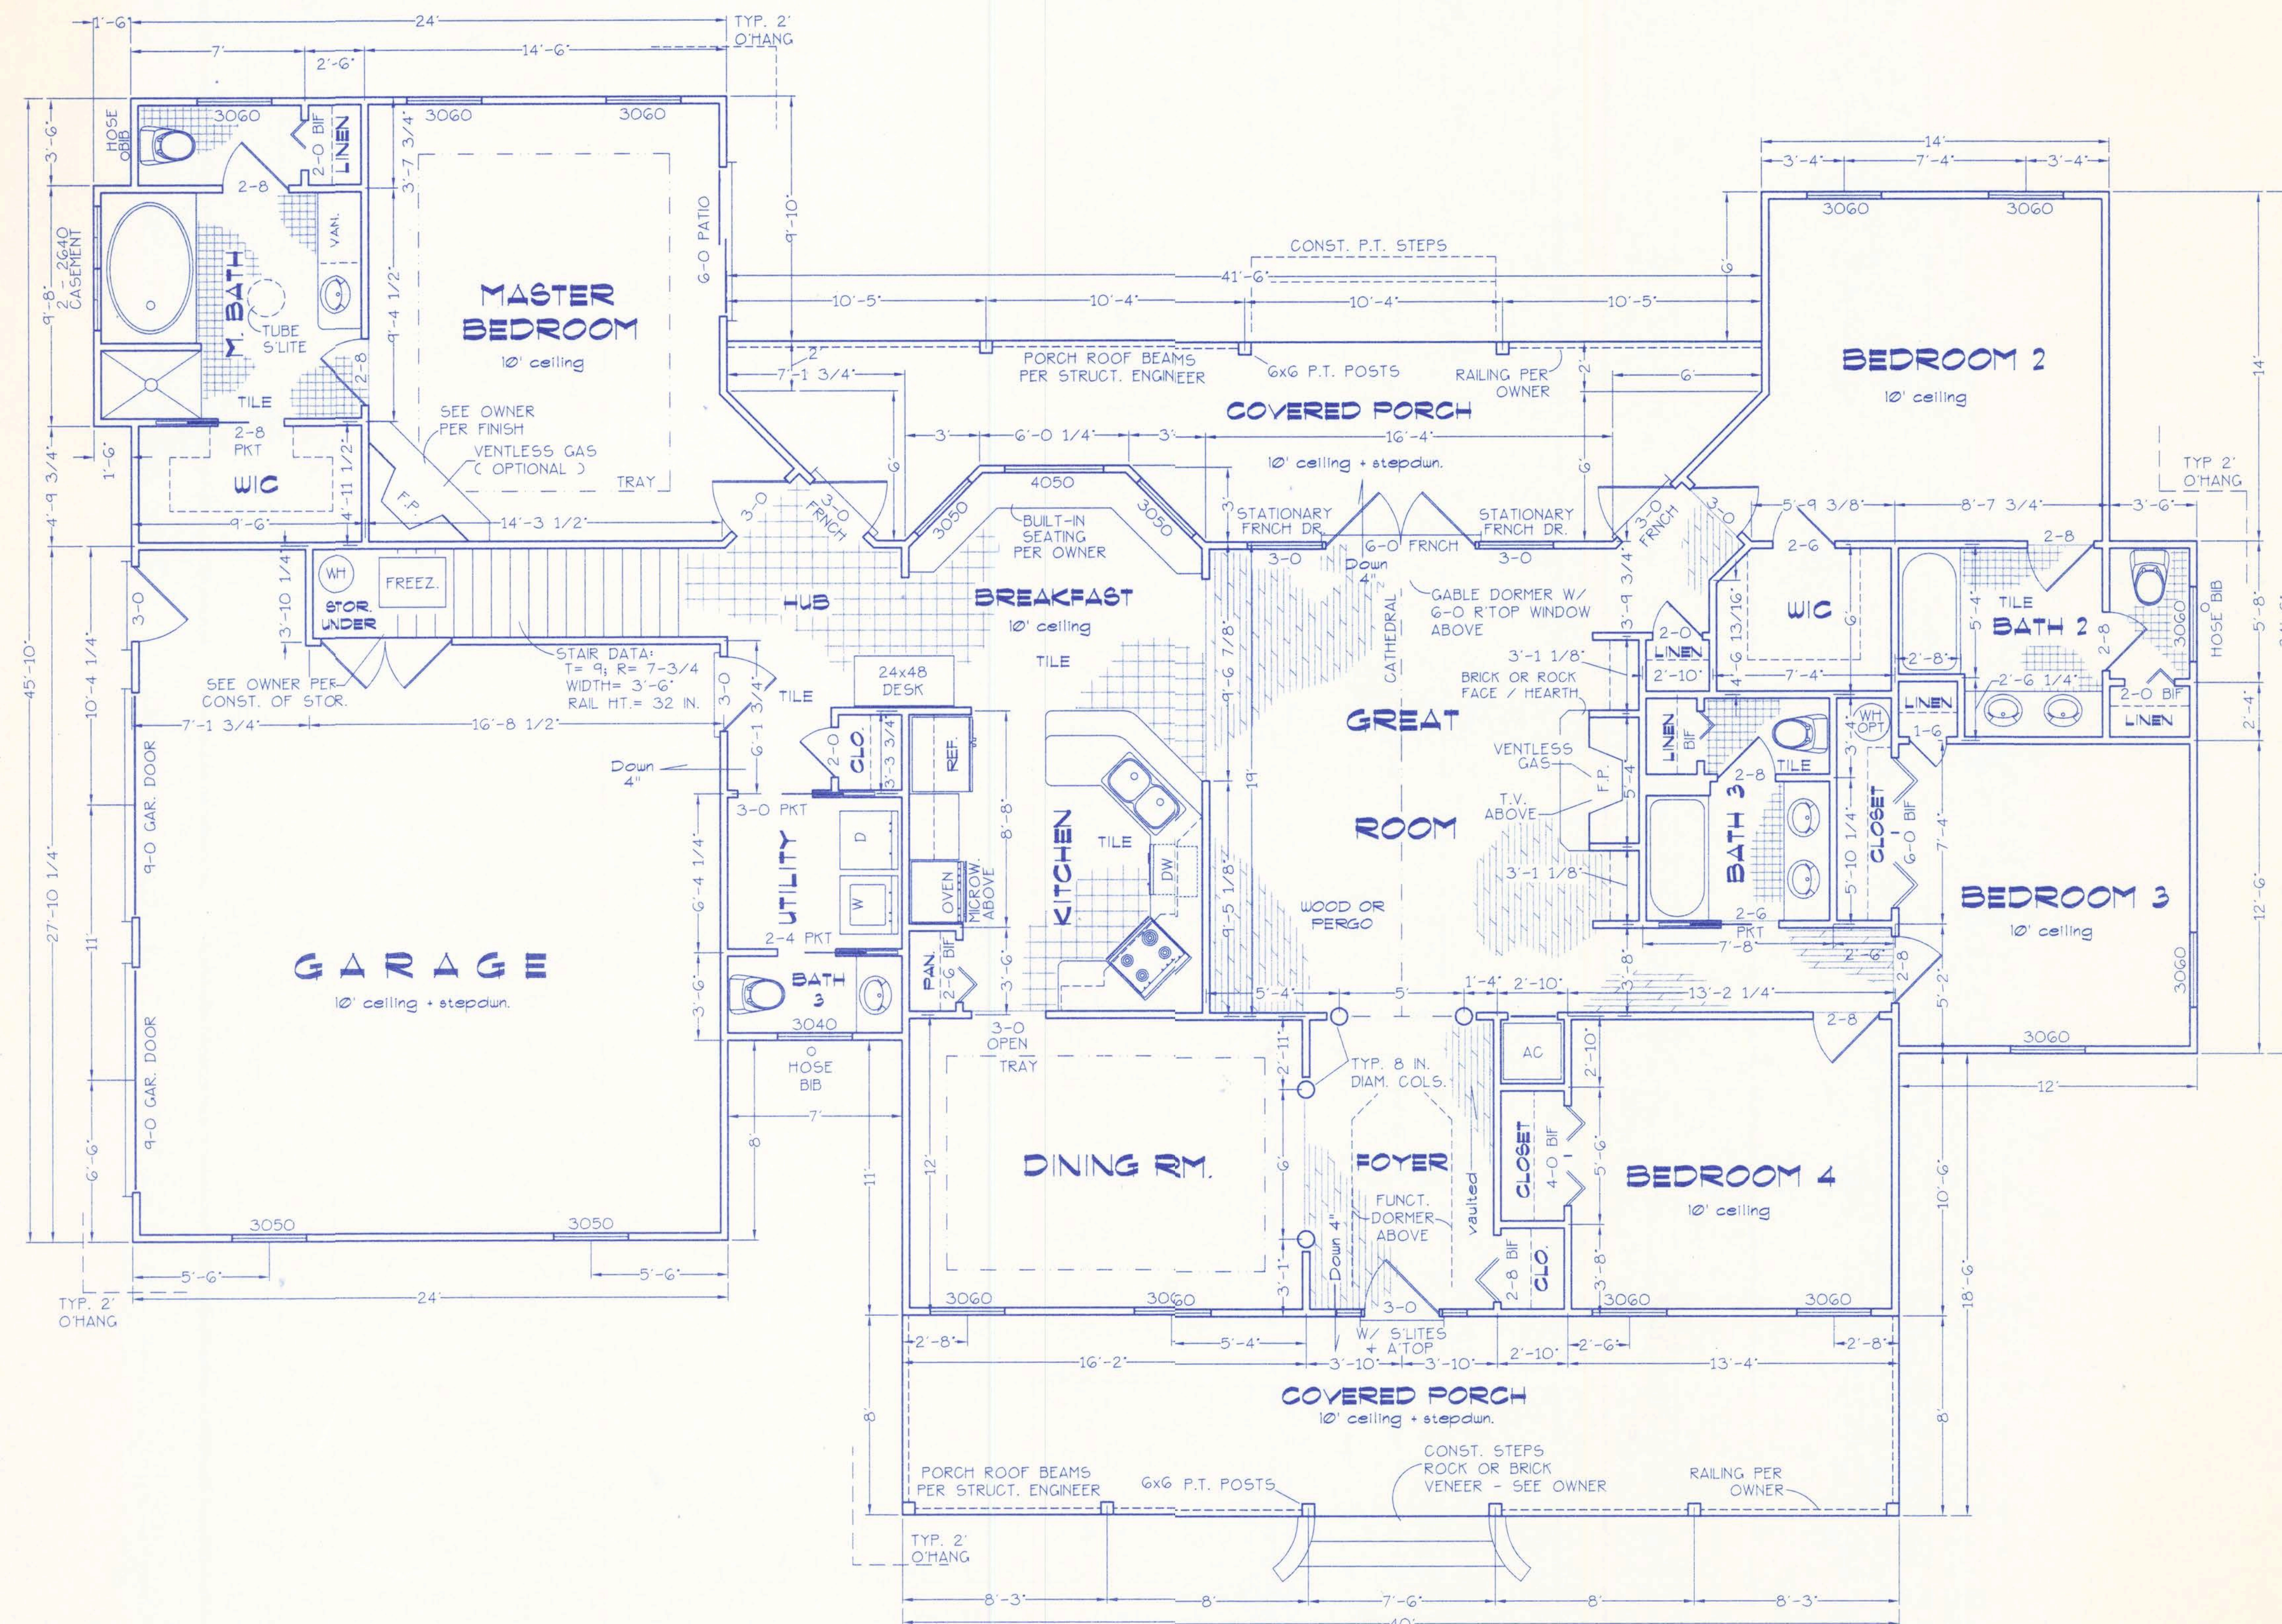

FLOOR PLAN
SCALE: 1/4 IN. = 1 FT.

AREA SUMMARY	
CONDITIONED	2340 SF
GARAGE	659 SF
FRONT PORCH	320 SF
REAR PORCH	269 SF
BONUS RM.	336 SF

GENERAL NOTES

- 1.) This Plan is to provide general design data only, and to be a source of information for Estimating, Planning and the production of other technical input by the Structural Engineer, the Contractor & Sub-contractors and materials suppliers. In and of itself it is only a portion of the information required for permitting purposes and shall be accompanied by Engineering / Technical data produced by others in accordance with the Florida Building Code 2001.
- 2.) Compliance with Section 1606 of the Florida Building Code 2001 (wind engineering) shall be the responsibility of the Structural Engineer.
- 3.) Roof and/or Floor Truss engineering shall be provided by the Truss supplier. The Truss supplier shall prepare engineered drawings indicating Truss placement, Girder locations, Truss-to-Truss connections, bearing requirements and any point loads.
- 4.) Site analysis or preparation is not a part of this plan and is the responsibility of the owner / contractor.
- 5.) Windows to be double glazed. Sizes shown are nominal and may vary with manufacturer. It shall be the contractor's responsibility to provide manufacturer's data for doors and windows that comply with wind pressure requirements set by the Structural Engineer.
- 6.) HVAC unit & duct design and Manual J report to be provided by the HVAC contractor.
- 7.) Cabinet and Millwork detail is not a part of this plan. The plan is a general design and these details shall be the responsibility of the owner and/or contractor.

3

FILE: 02-029	LESLIE RESIDENCE	SHEET: 3 of 5
DATE: 8-29-02		CAD FILE: 02029
DRAWN: T A D	PREPARED BY: TIM DELBENE Residential Drafting + Design Rt. 4, Box 330, Lake City, FL 32055 Phone: (904) 755-5891	REV:
CHECK: T A D		REV:

PLUMBING NOTES


- REFER TO FLOOR PLAN FOR APPROPRIATE DIMENSIONS
- FIXTURE BRANDS/MODELS PER OWNER/CONTRACTOR.
- INSTALLATION DETAILS OF WATER SERVICE, SUPPLY / WASTE LINES, ETC IS THE RESPONSIBILITY OF THE PLUMBING CONTRACTOR.

FIXTURE SCHEDULE

Ⓐ - WASHER HOOK-UP	Ⓔ - DISHWASHER
Ⓑ - LAUNDRY SINK w/s	⓫ - HVAC UNIT
Ⓒ - WATER HEATER	⓬ - ICE-MAKER SUPPLY
Ⓓ - COMMODE / TANK	⓭ - TUB / SHOWER COMBO
Ⓔ - SHOWER UNIT	⓮ - GARDEN TUB
Ⓕ - LAVATORY SINK	⓯ - HOSE BIB LOCATIONS
Ⓖ - KITCHEN SINK	


FOUNDATION NOTES:

- 1.) THE FOUNDATION INFORMATION BELOW IS PRELIMINARY IN NATURE AND IS SUPPLIED TO CONVEY THE OWNER'S INSTRUCTIONS FOR FOUNDATION CONSTRUCTION TO THE STRUCTURAL ENGINEER.
- 2.) TRUSS ENGINEERING AND OTHER FACTORS SHALL BE CONSIDERED BY THE STRUCTURAL ENGINEER TO PRODUCE A FINAL FOUNDATION PLAN.
- 3.) TRUSS SUPPLIER'S DESIGN SHALL PRECEDE STRUCTURAL ENGINEERING SO THAT THE TRUSS DESIGNER MAY CONSIDER ALL NECESSARY BEARING REQUIREMENTS FOR AN EFFICIENT DESIGN.

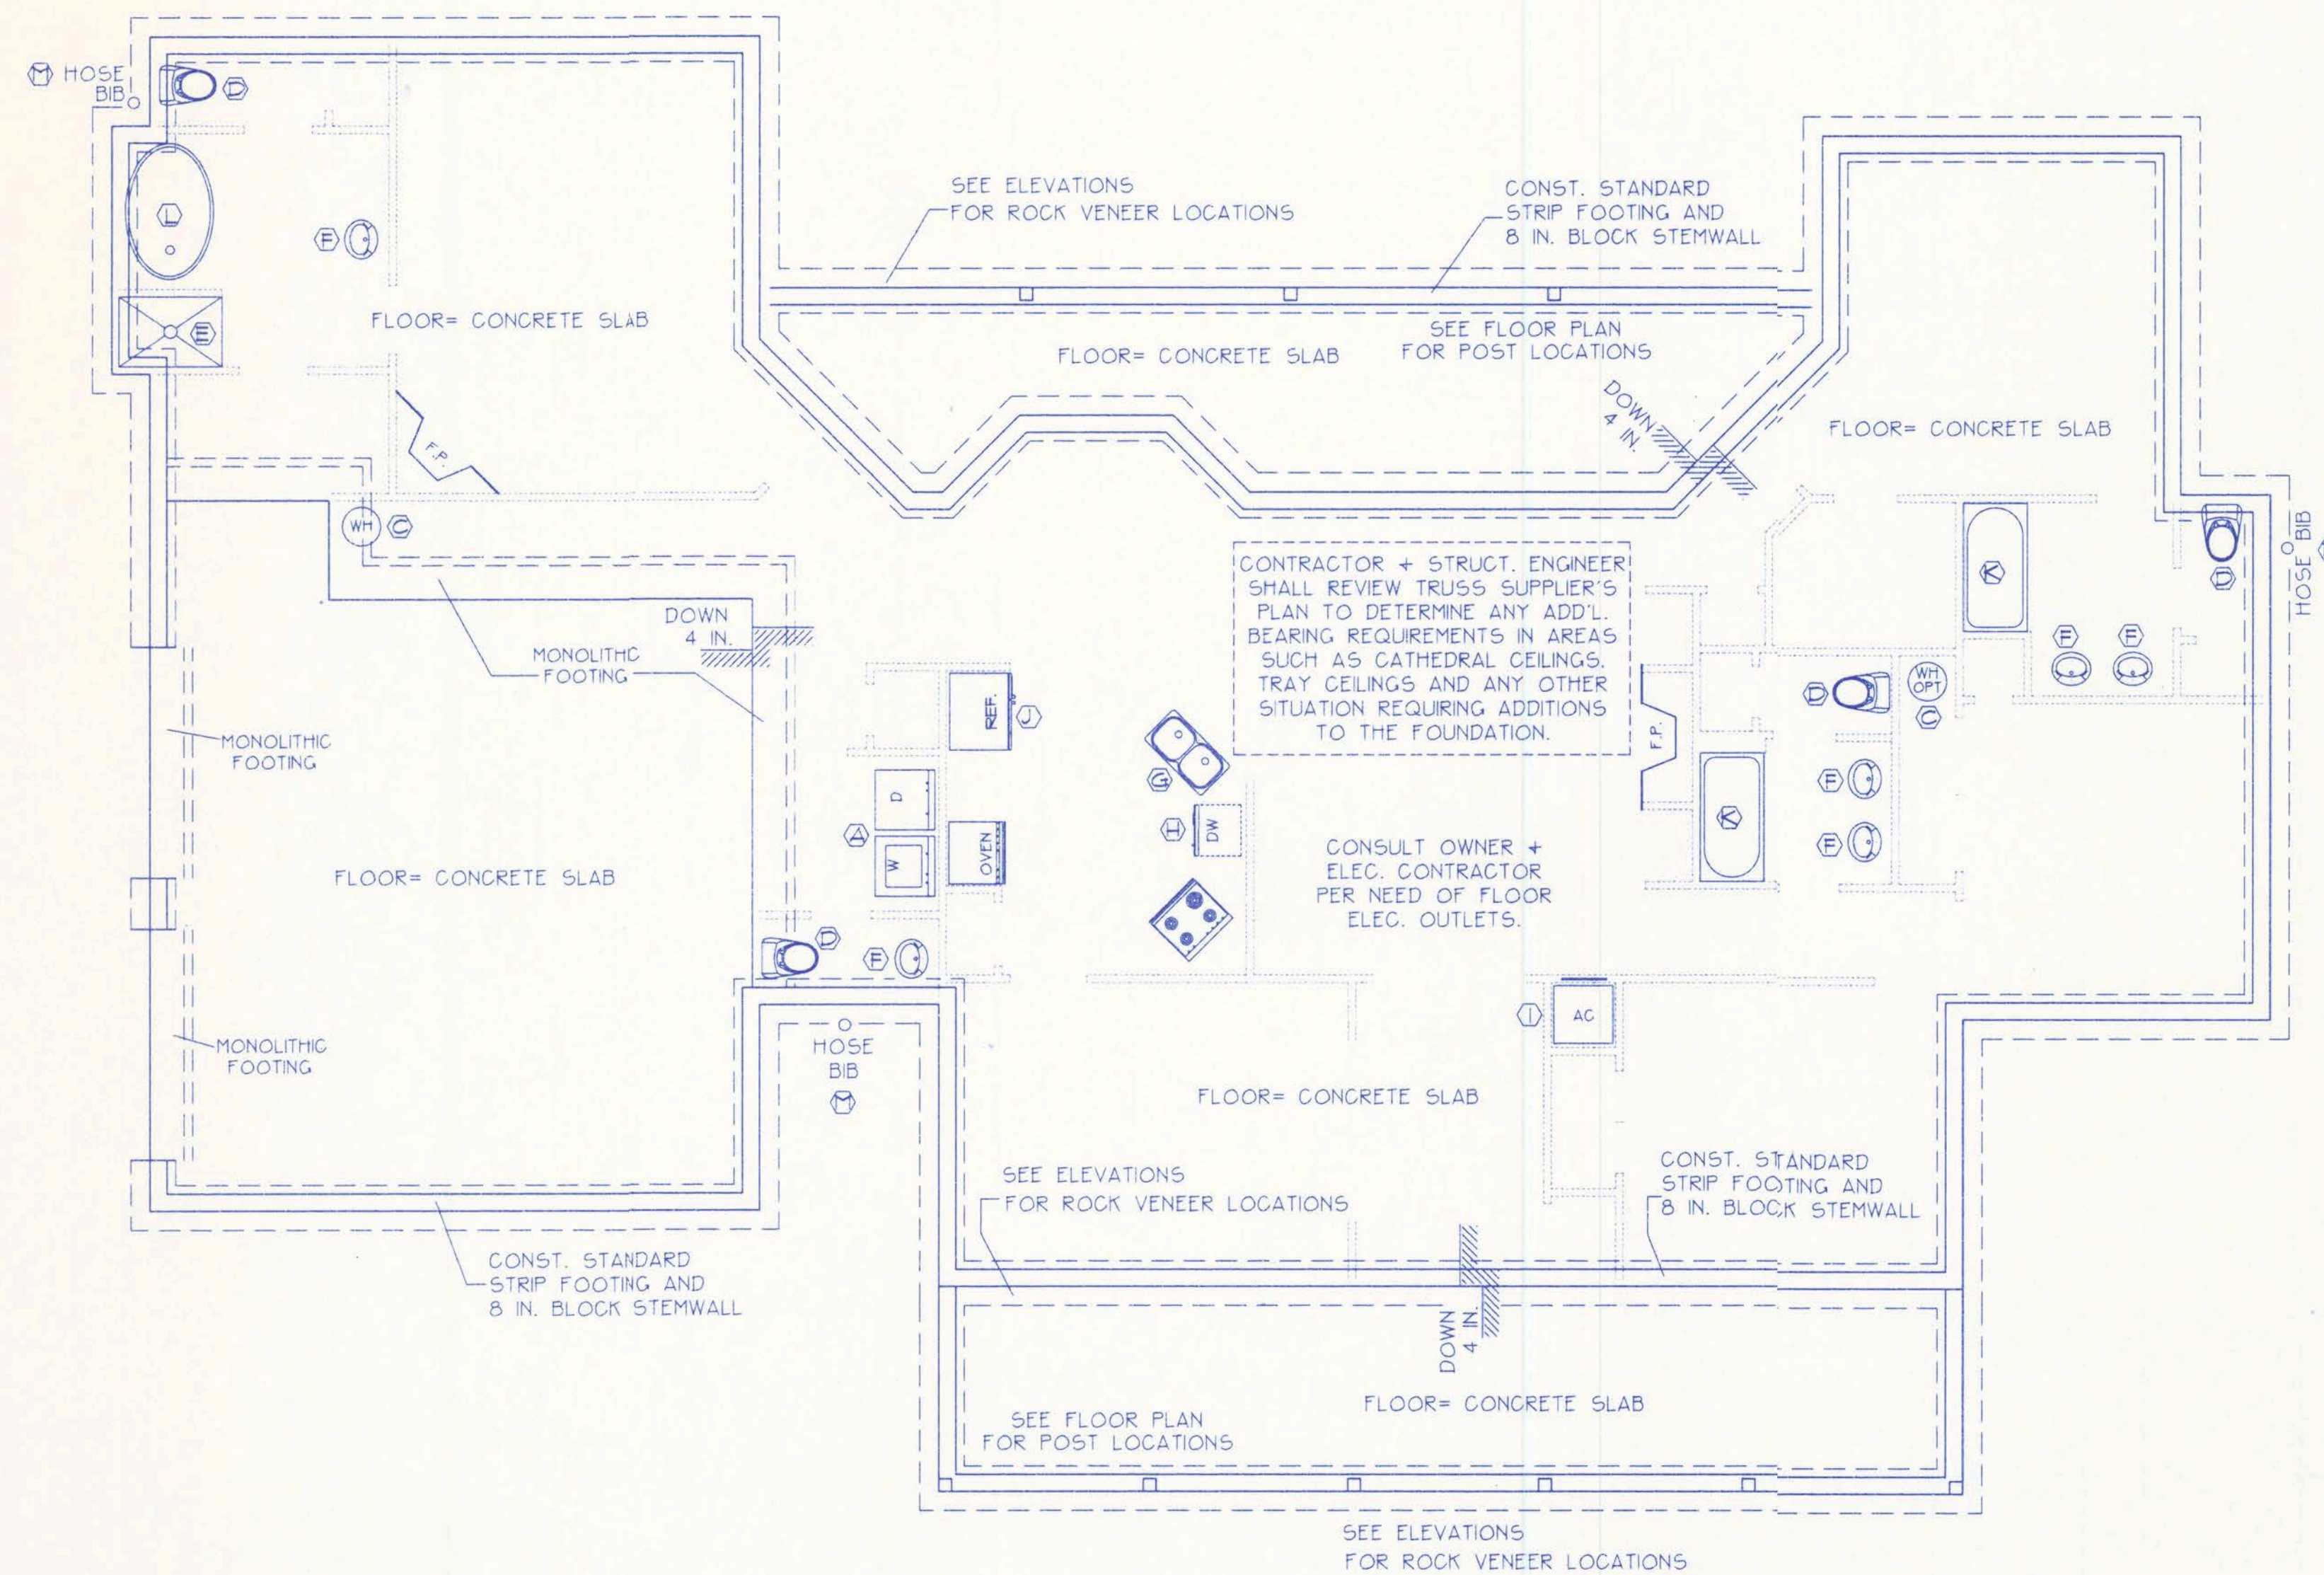

PRELIMINARY FOUNDATION
INFORMATION
+ PLUMBING FIXTURES
NOT TO SCALE

SEE SHEET 3 FOR GENERAL NOTES
CONCERNING USES & LIMITATIONS OF THIS PLAN

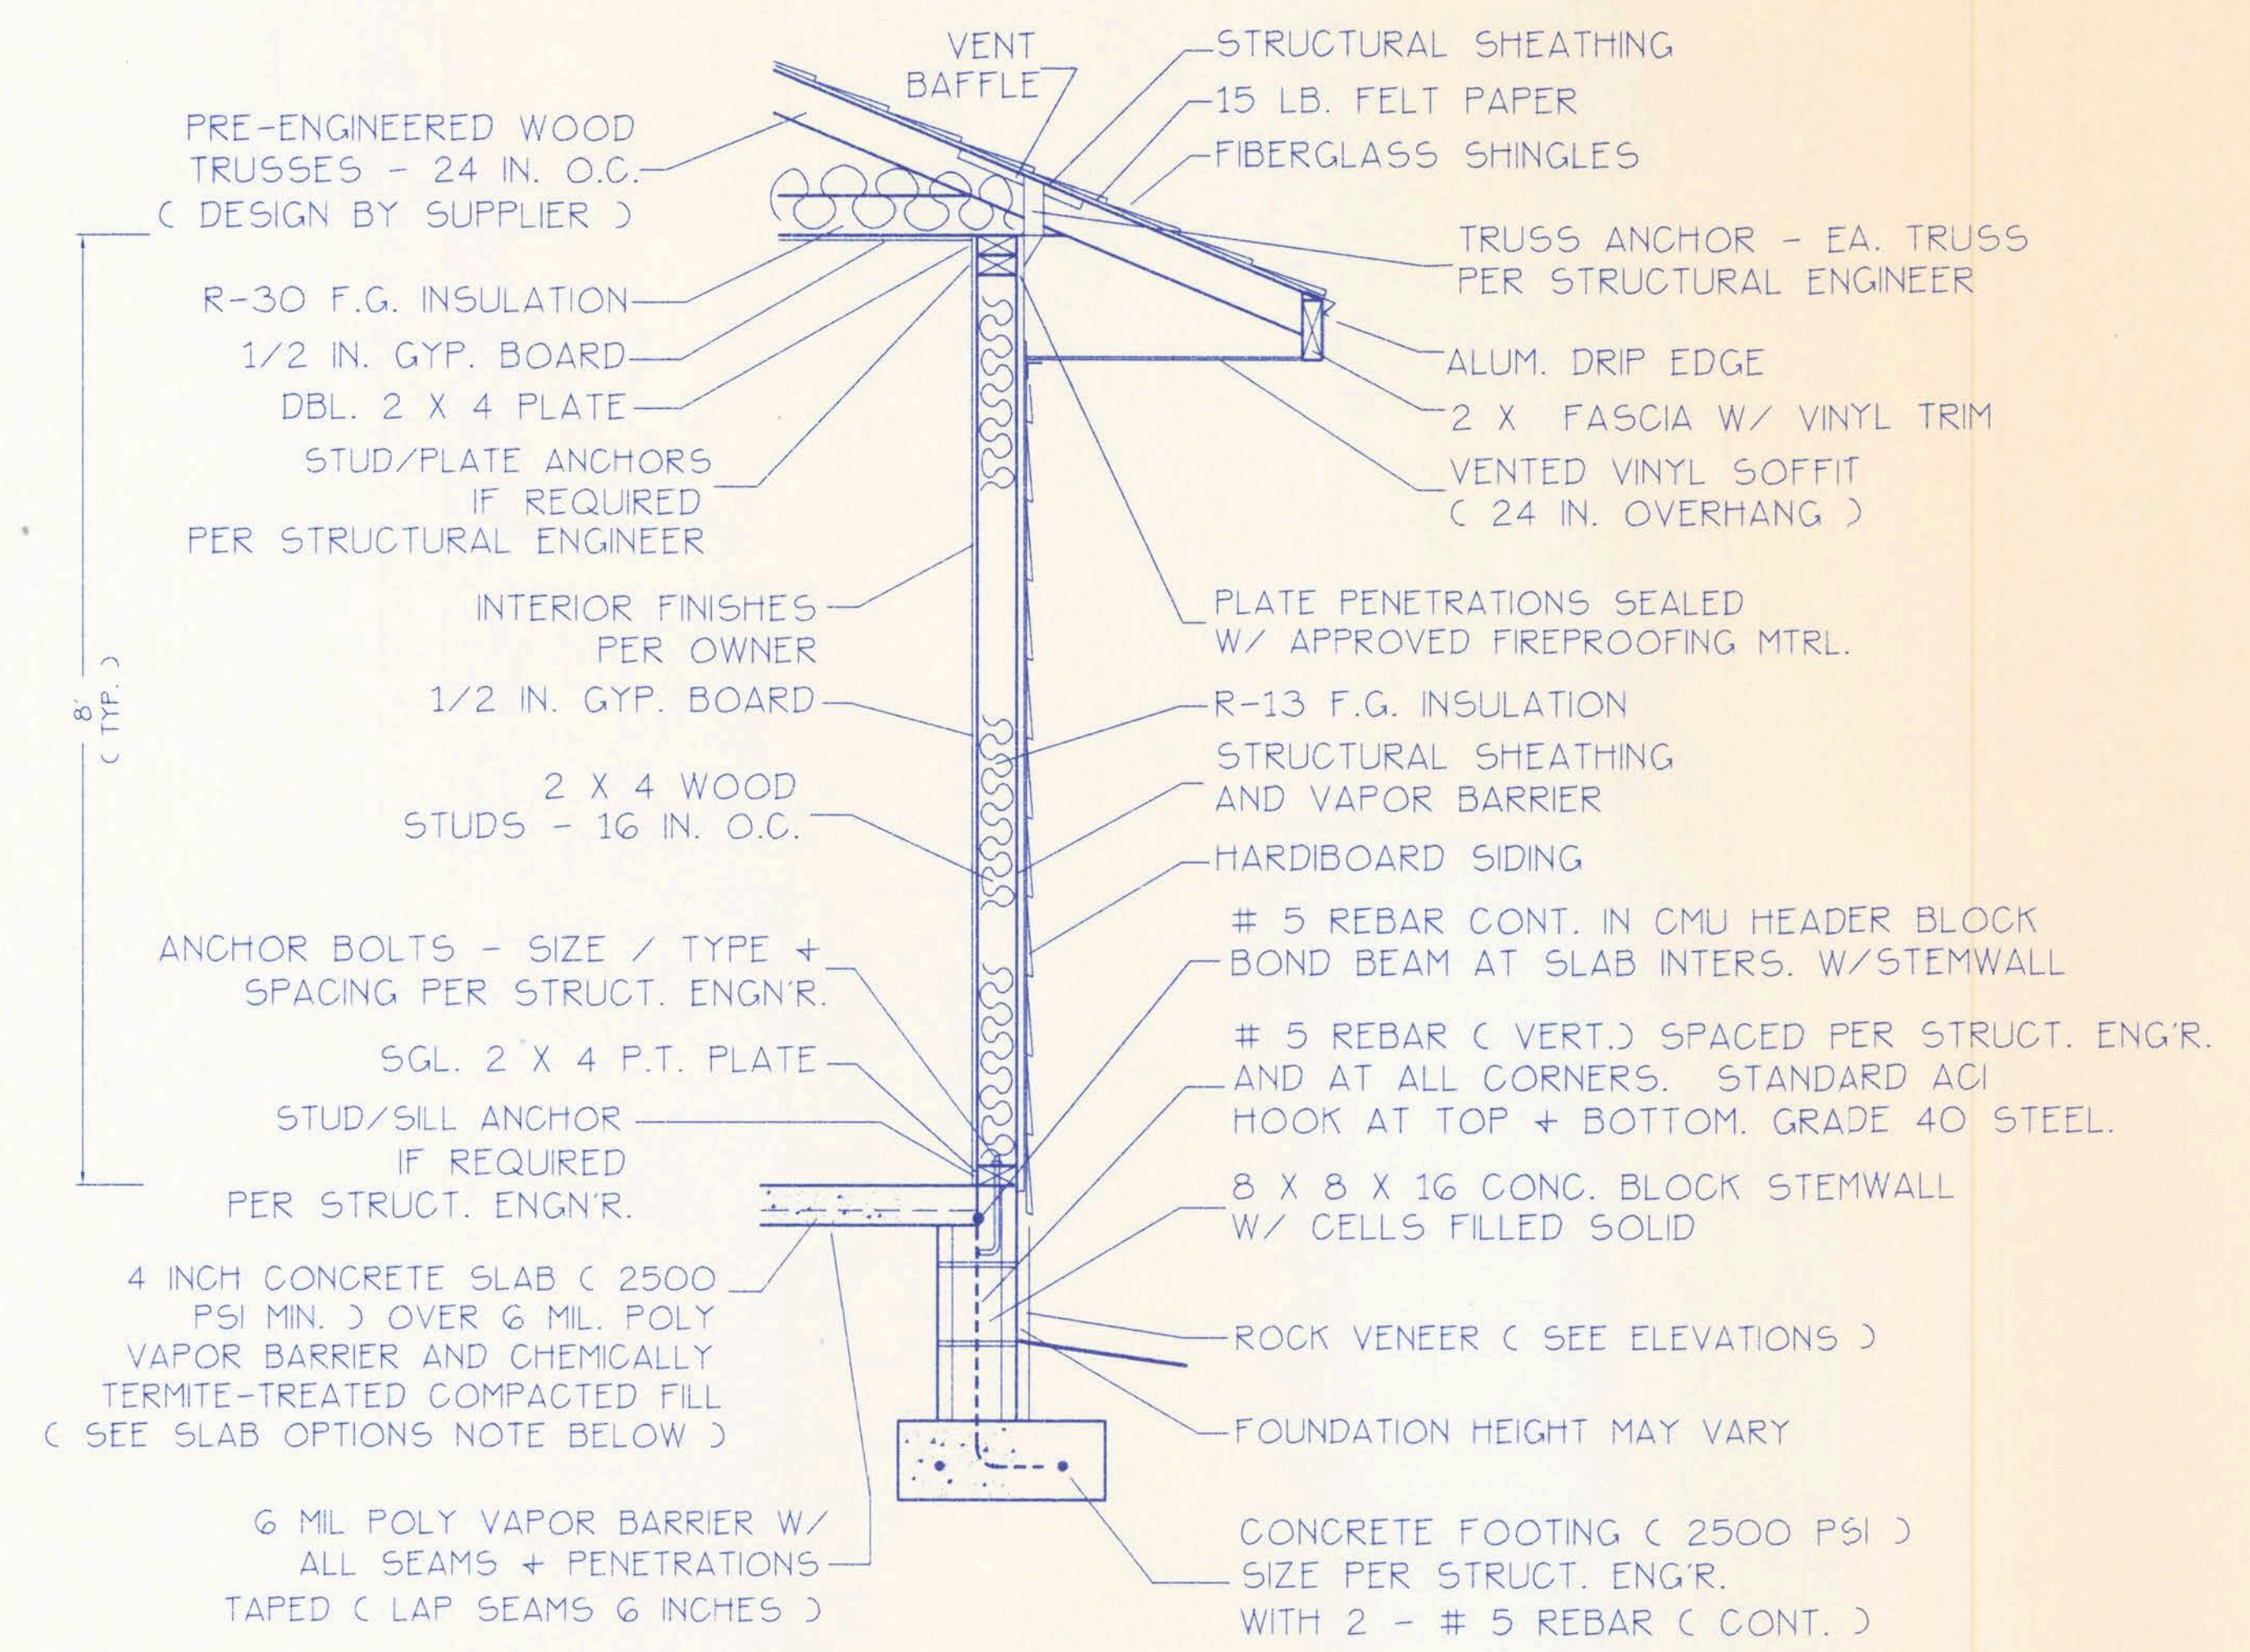

SLAB OPTIONS:

- OPTION 1 - Use 6x6 10/10 WWM reinforcing on chair supports at 3' O.C.
- OPTION 2 - Use Synthetic Fiber reinforced concrete.

WALL SECTION NOTES:


- This Typical Wall Section is for Estimating purposes only.
- All data shown in this Wall Section shall be subject to review and final input by the Structural Engineer.

DESIGN WALL SECTION NON-STRUCTURAL DATA

SCALE: 3/4 IN. = 1 FT.

4

FILE: 02-029	LESLIE RESIDENCE	SHEET: 4 of 5
DATE: 8-29-02		CAD FILE: 02029
DRAWN: T A D	PREPARED BY: TIM DELBENE Residential Drafting + Design Rt. 4, Box 330, Lake City, FL 32055 Phone (904) 755-5891	REV:
CHECK: T A D		REV:

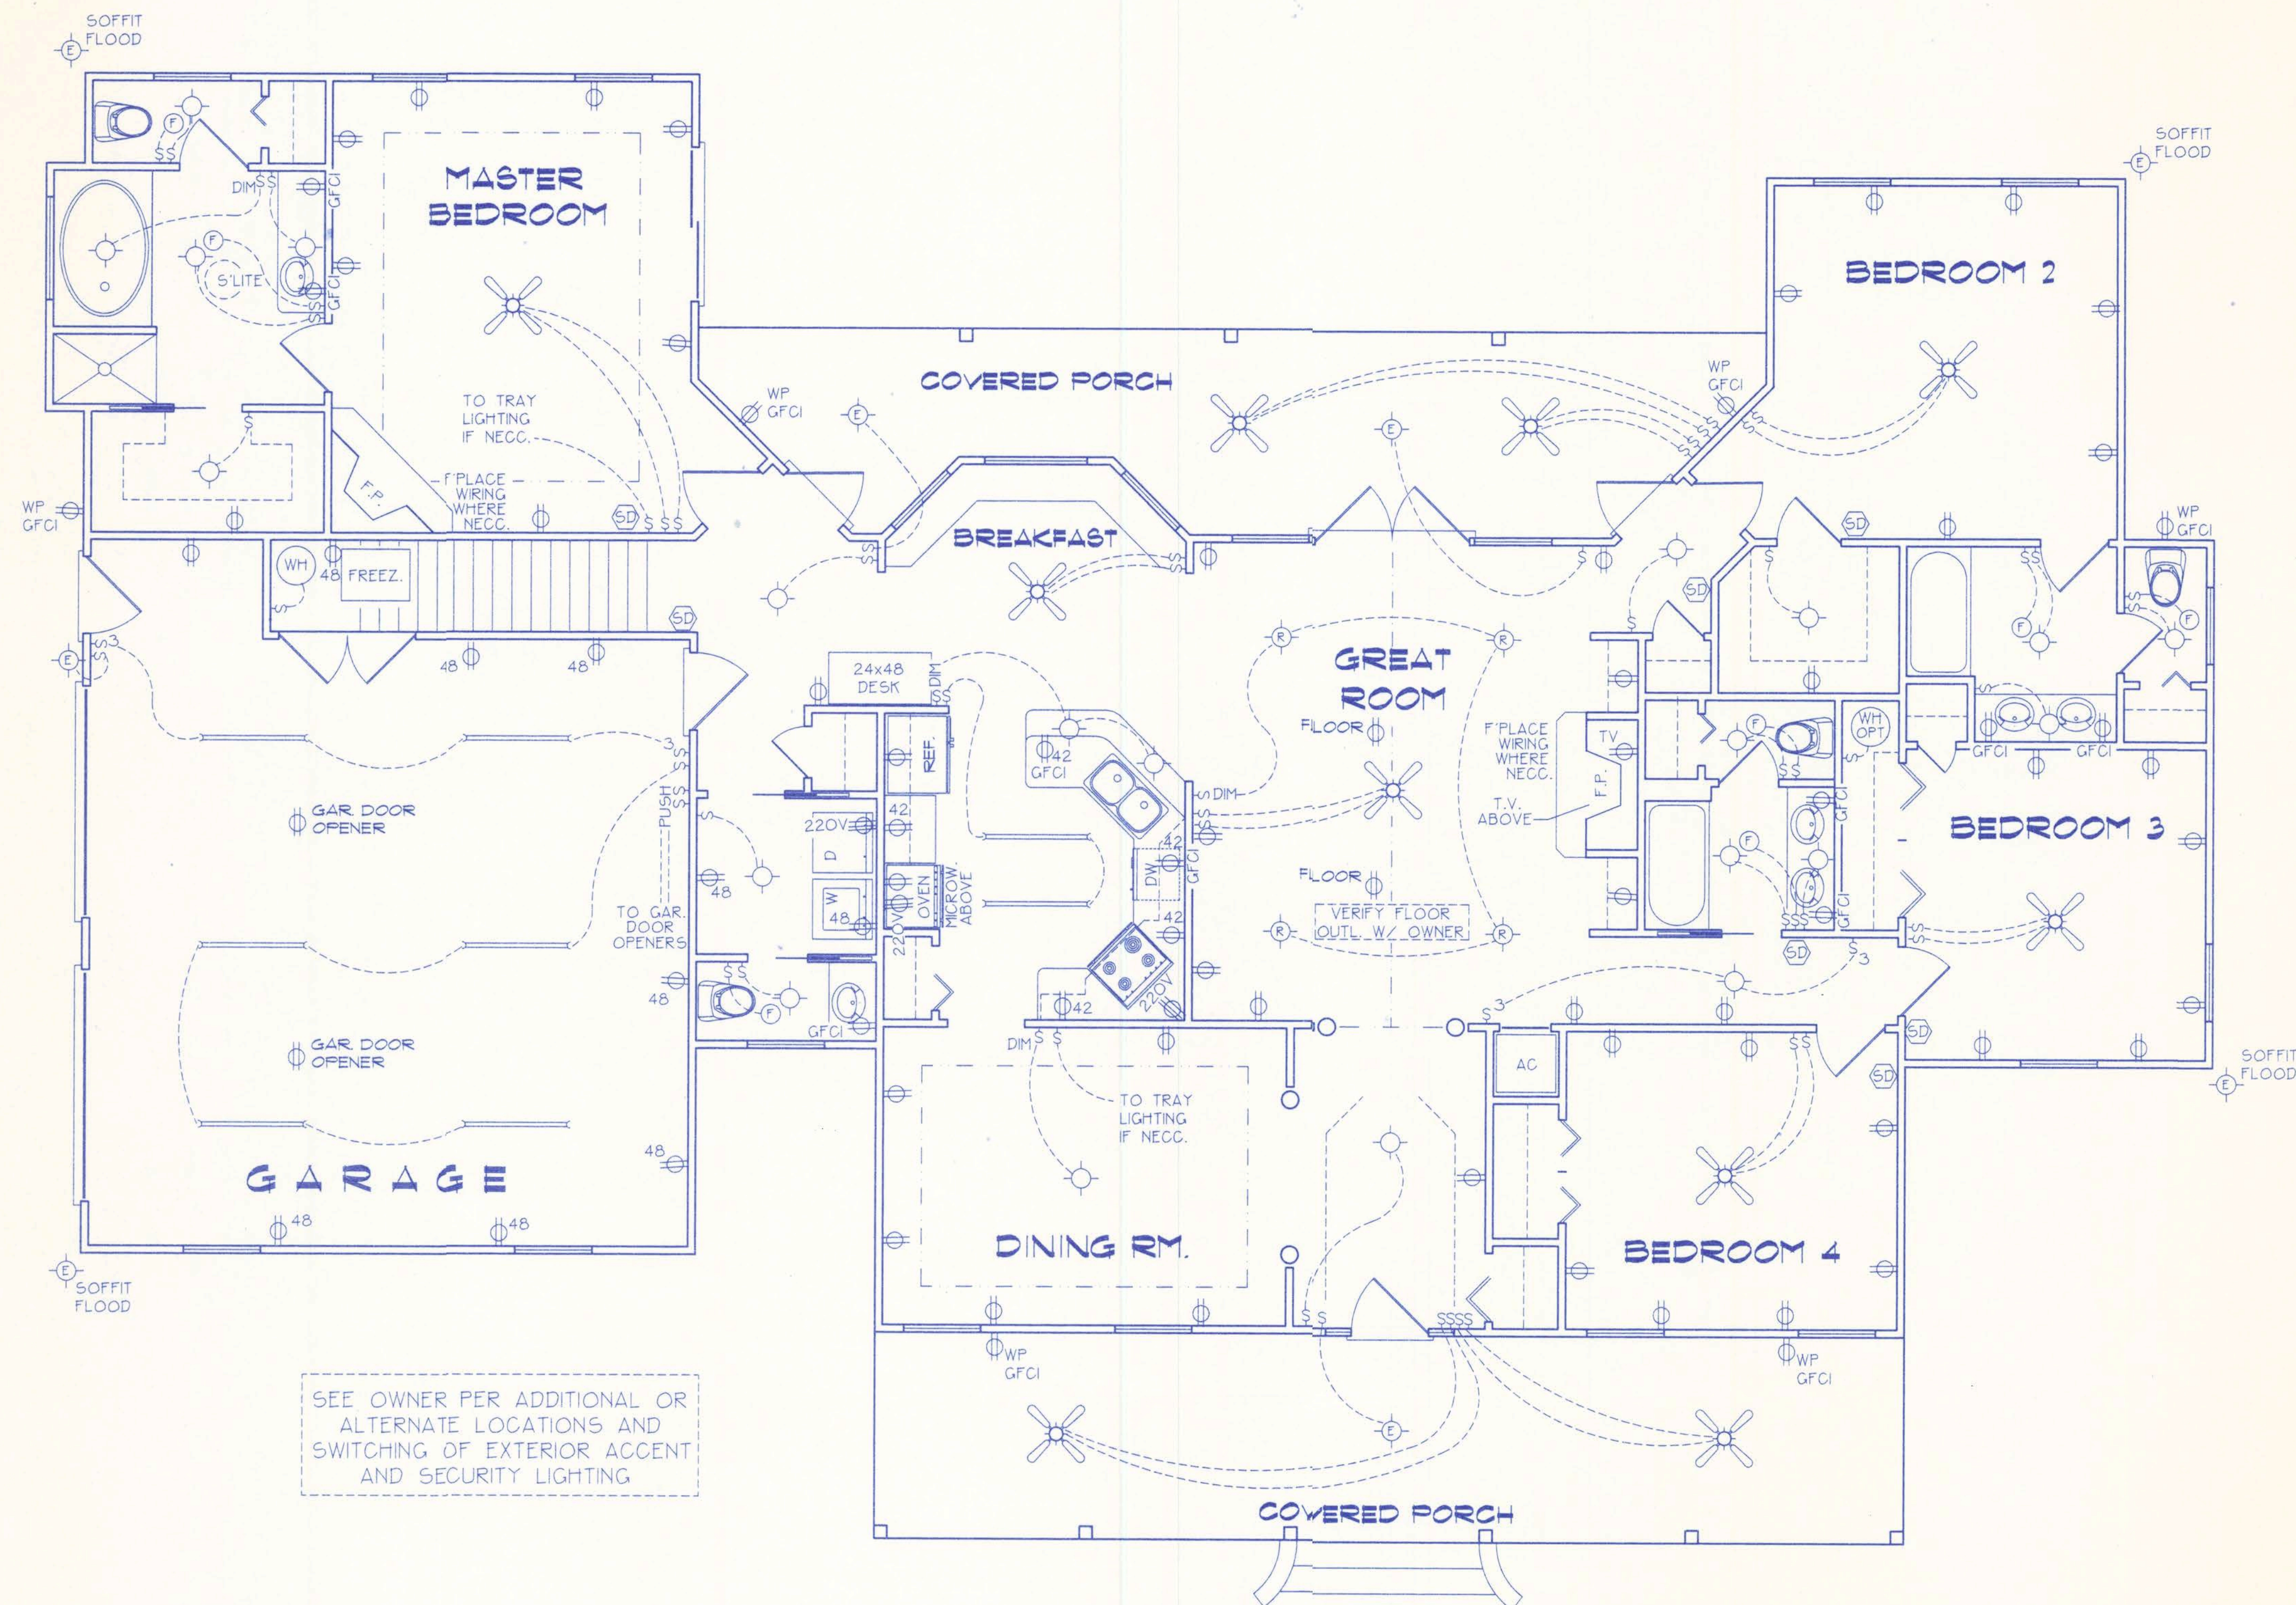

ELECTRICAL PLAN NOTES

- WIRE ALL APPLIANCES, HVAC UNITS AND OTHER EQUIPMENT PER MANUF. SPECIFICATIONS.
- CONSULT THE OWNER FOR THE NUMBER OF SEPERATE TELEPHONE LINES TO BE INSTALLED.
- ALL INSTALLATIONS SHALL BE PER NAT'L. ELECTRIC CODE.
- ALL SMOKE DETECTORS SHALL BE 120V W/ BATTERY BACKUP OF THE PHOTOELECTRIC TYPE, AND SHALL BE INTERLOCKED TOGETHER. INSTALL INSIDE AND NEAR ALL BEDROOMS.
- TELEPHONE, TELEVISION AND OTHER LOW VOLTAGE DEVICES OR OUTLETS SHALL BE AS PER THE OWNER'S DIRECTIONS, + IN ACCORDANCE W/ APPLICABLE SECTIONS OF NEC-LATEST EDITION.
- ELECTRICAL CONTR'L SHALL BE RESPONSIBLE FOR THE DESIGN + SIZING OF ELECTRICAL SERVICE AND CIRCUITS.
- ENTRY OF SERVICE (UNDERGROUND OR OVERHEAD) TO BE DETERMINED BY POWER COMPANY.
- ELECTRICAL CONTR'L SHALL VERIFY ALL FIXTURE TYPES AND SWITCHING LOCATIONS WITH OWNER.

ELECTRICAL SYMBOL LEGEND

	= FLOUORESCENT LIGHTING FIXTURE.
	= CEILING LIGHT FIXTURE
	= EXTERIOR LIGHTING FIXTURE
	= RECESSED LIGHTING FIXTURE
	= LIGHT SWITCH.
	= THREE-WAY SWITCH.
	= 110 V. DUPLEX OUTLET.
	= SPECIAL HEIGHT 110 V. DUPLEX OUTLET
	= GROUNDED OUTLET
	= 220 VOLT OUTLET (4 WIRE)
	= FAN LOCATION (CEILING)
	= FAN LOCATION (EXHAUST)
	= SMOKE DETECTOR


ELECTRICAL PLAN

NOT TO SCALE

5

FILE: O2-O29	LESLIE RESIDENCE	SHEET: 5 of 5
DATE: 8-29-02		CAD FILE: O2O29
DRAWN: T A D		REV:
CHECK: T A D		REV:

Leslie Residence

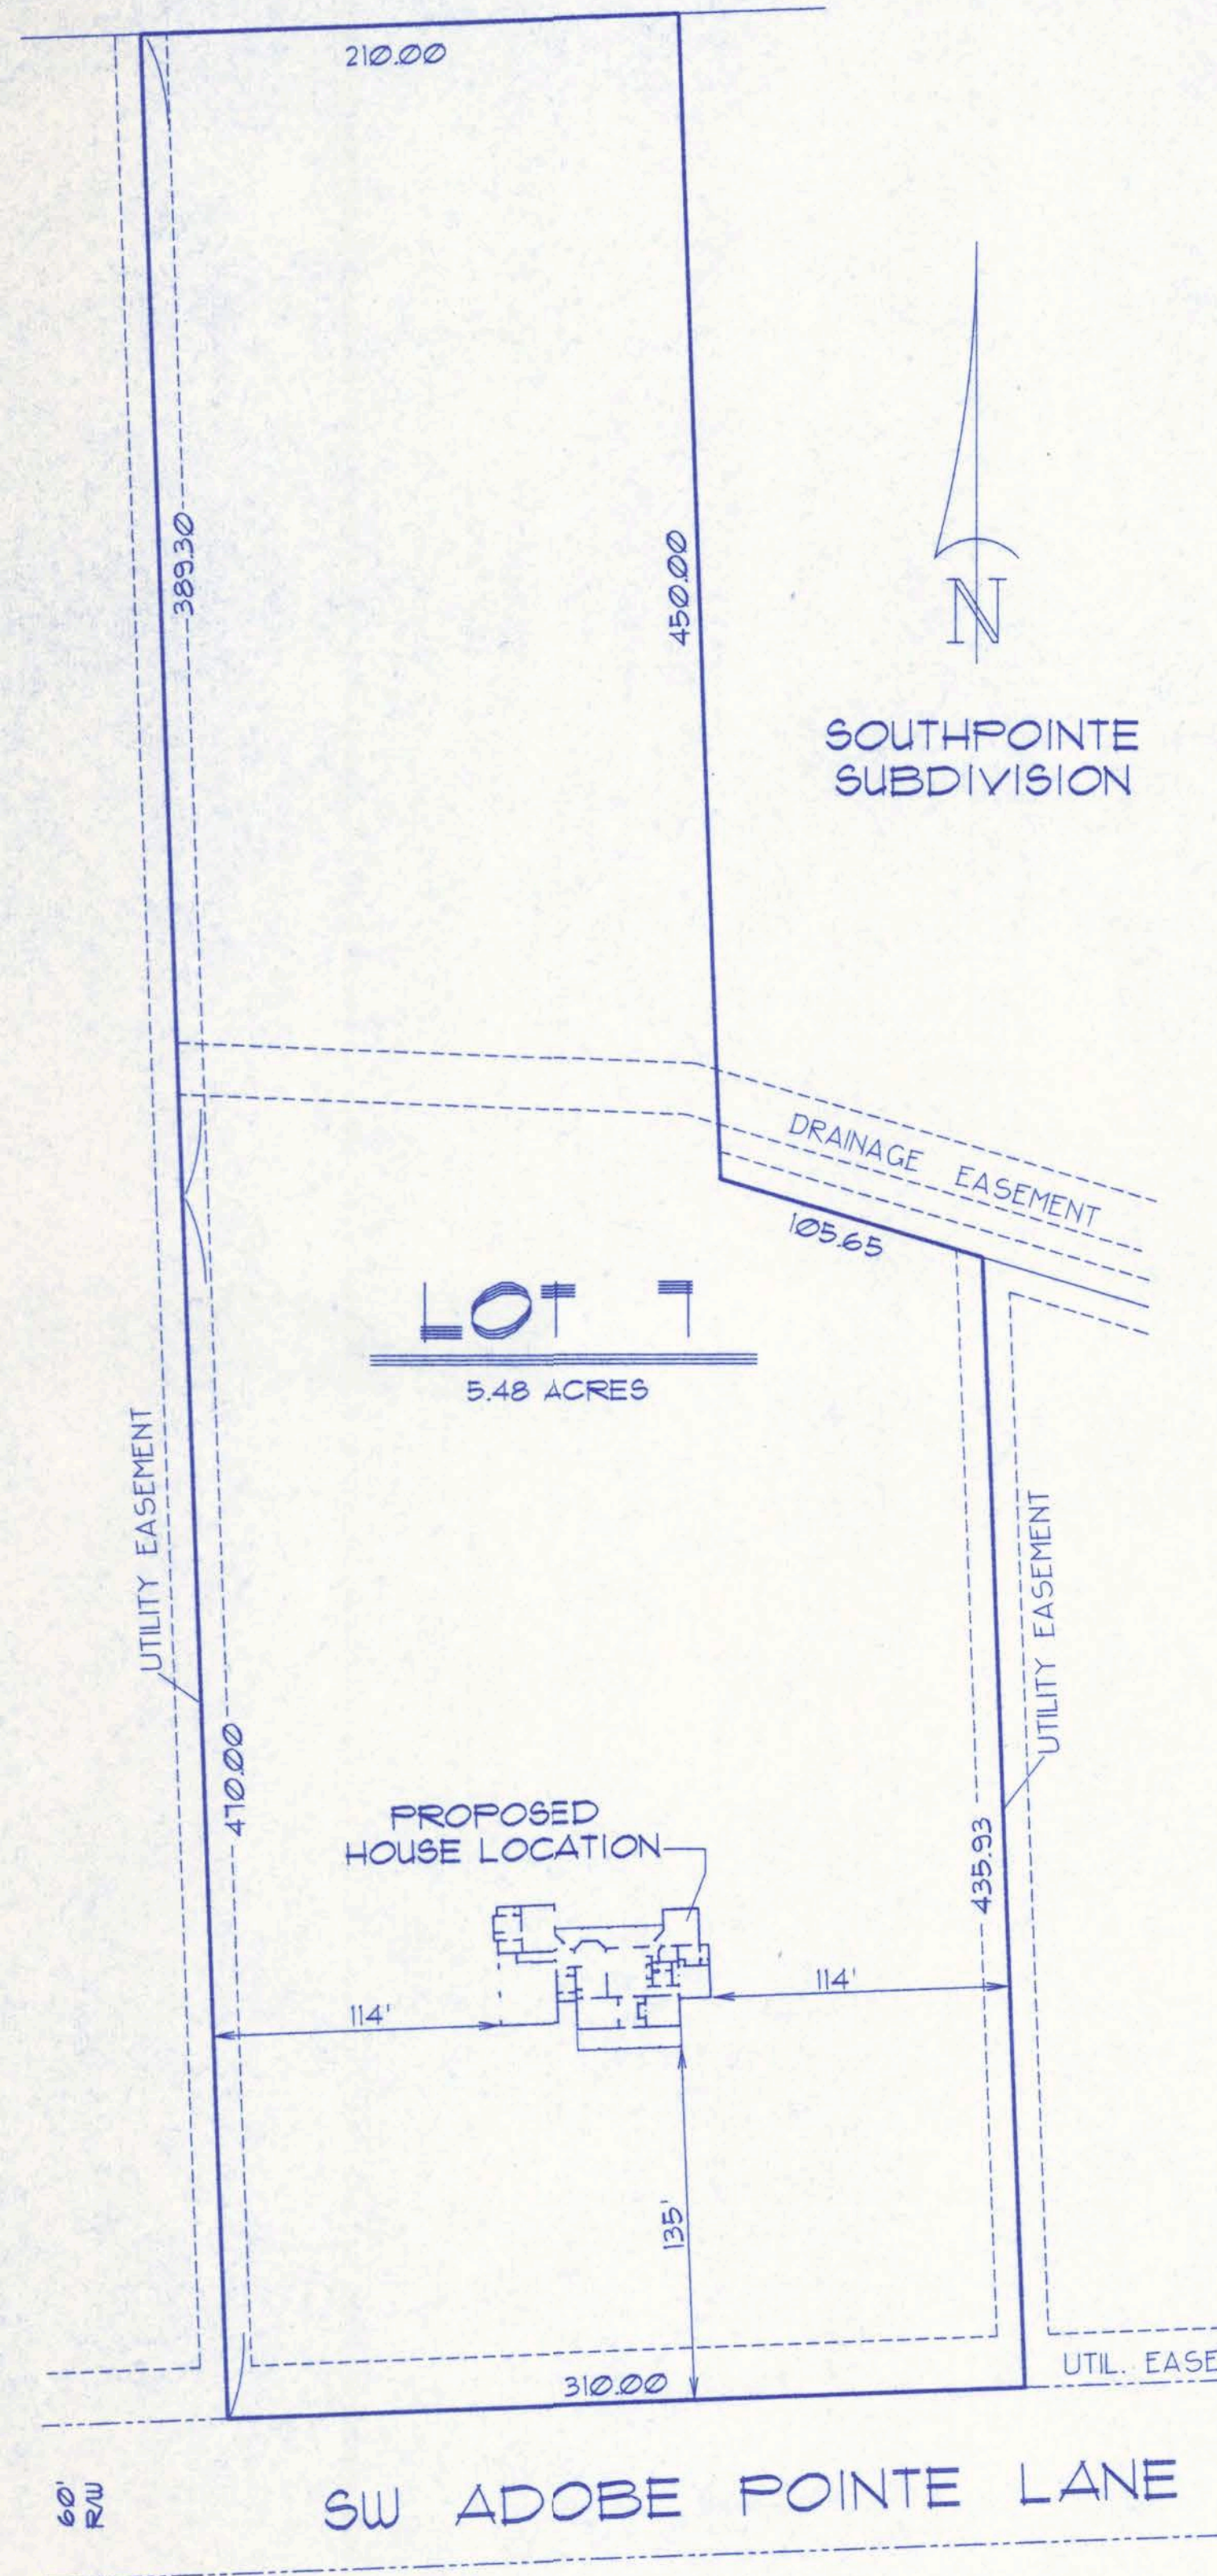

SITE PLAN
SCALE: 1 IN. = 60 FT.



FRONT ELEVATION
SCALE: 1/4 IN. = 1 FT.

Index to Sheets


- SHEET 1 - ELEVATION + SITE PLAN
- SHEET 2 - ELEVATIONS
- SHEET 3 - FLOOR PLAN + GEN. NOTES
- SHEET 4 - WALL SECTION + PRELIM. FOUNDATION + PLUMBING FIXT.
- SHEET 5 - ELECTRICAL

SEE SHEET 3 FOR GENERAL NOTES
CONCERNING USES & LIMITATIONS OF THIS PLAN

GENE LESLIE
755-4971(H)
365-5458(C)

1

FILE: 02-029	LESLIE RESIDENCE	SHEET: 1 of 5
DATE: 8-29-02		CAD FILE: 02029
DRAWN: T A D	PREPARED BY: TIM DELBENE Residential Drafting + Design	REV:
CHECK: T A D	Rt. 4, Box 330, Lake City, FL 32055 Phone (904) 755-5891	REV:

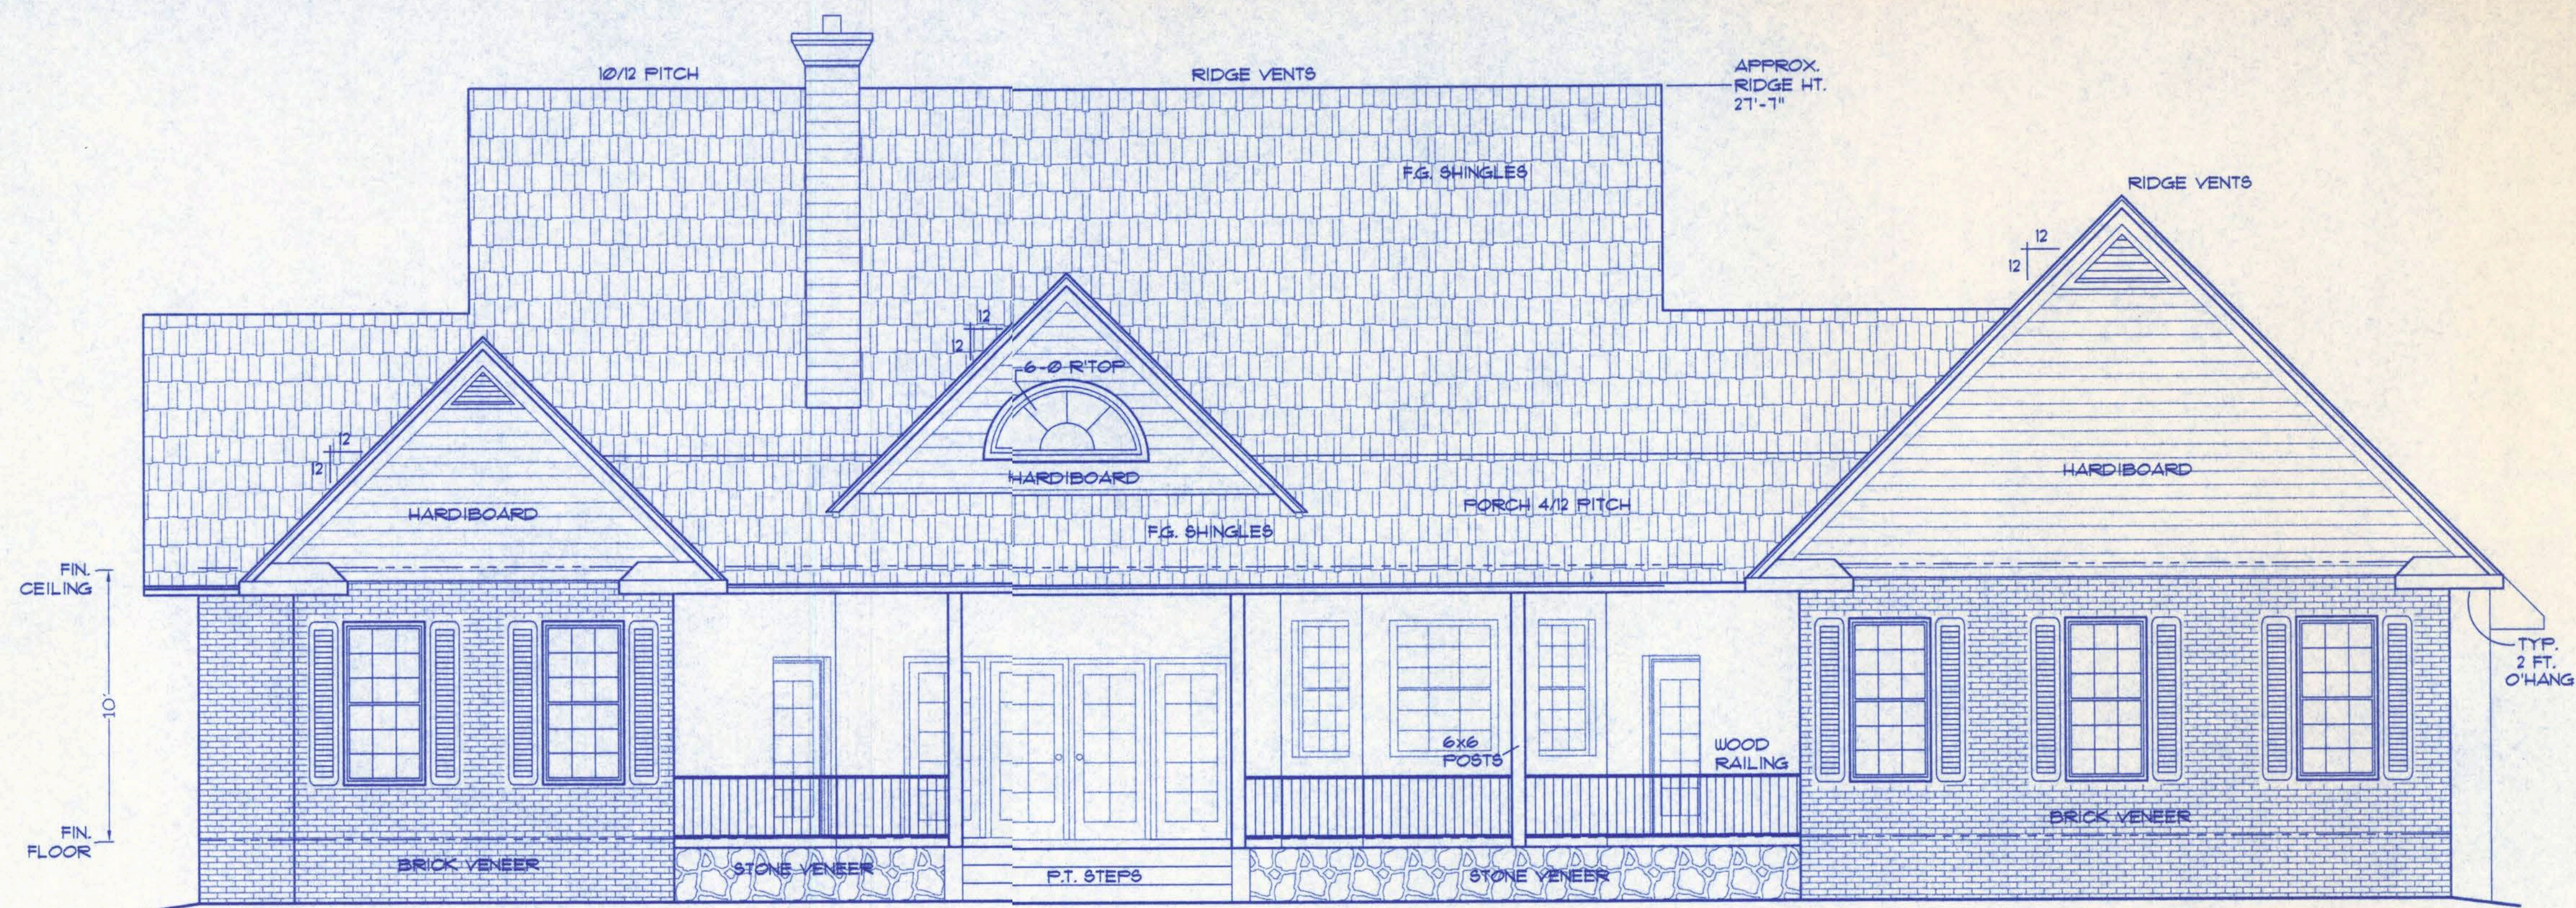


REAR ELEVATION

SCALE: 1/4 IN. = 1 FT.



LEFT ELEVATION

SCALE: 1/4 IN. = 1 FT.

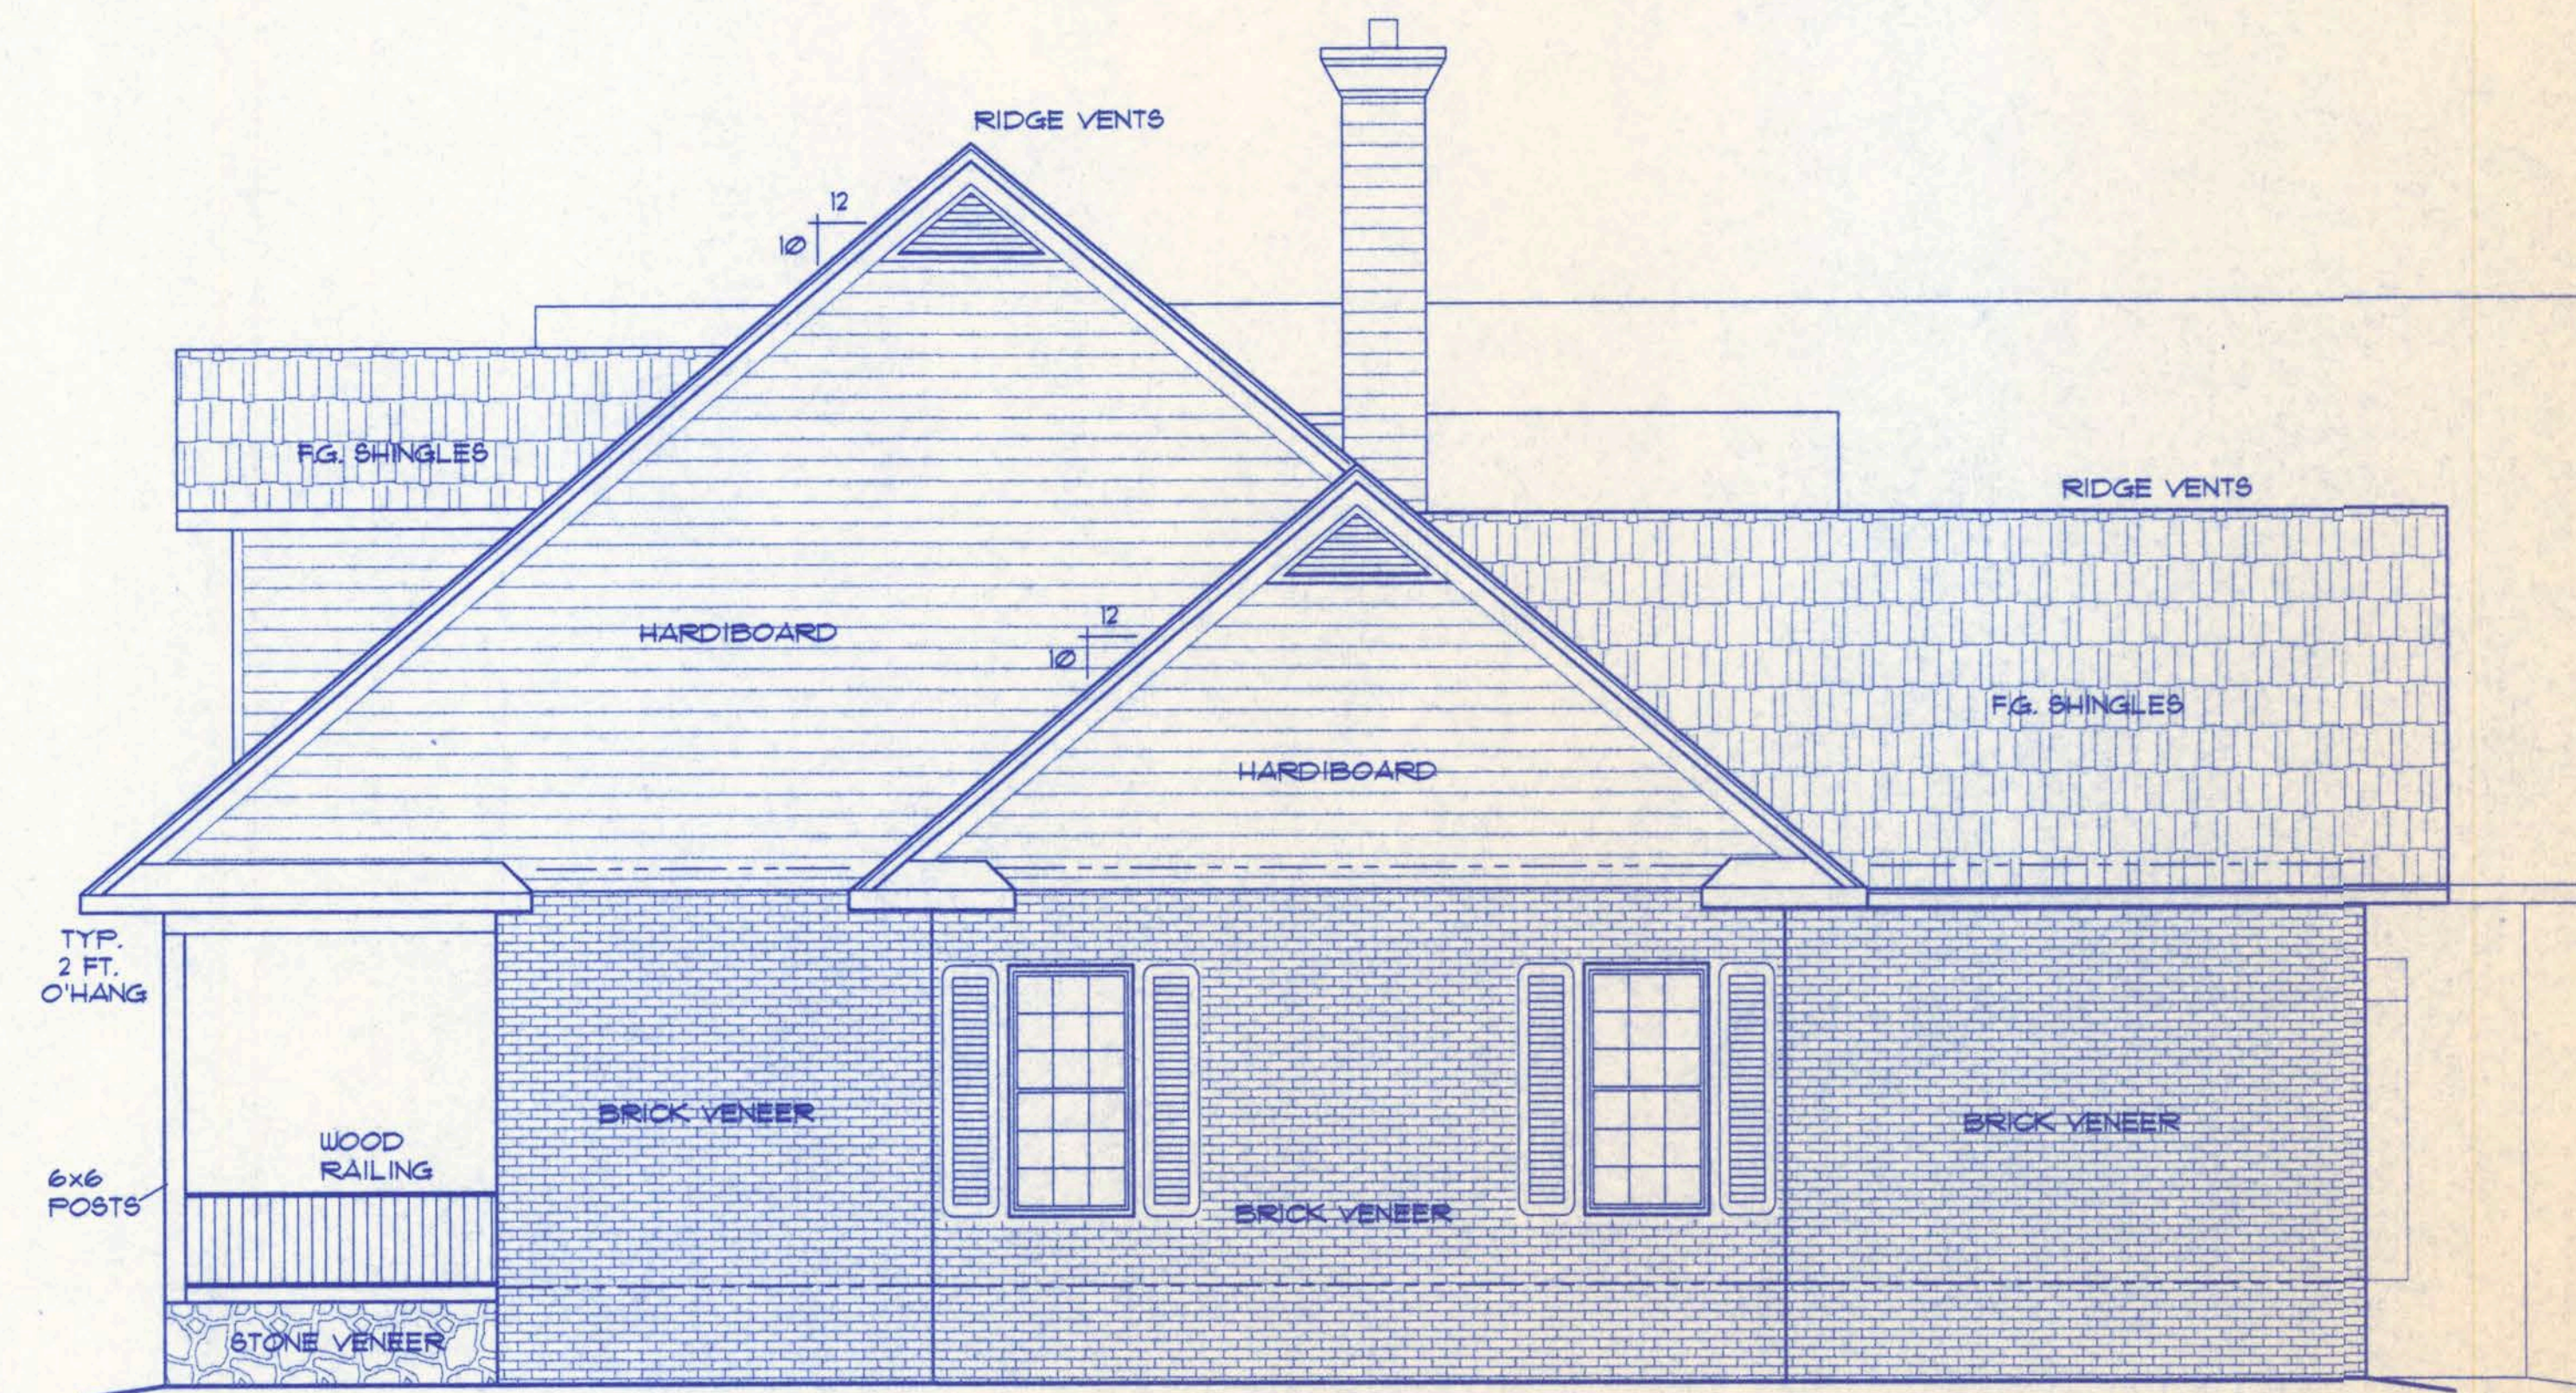


RIGHT ELEVATION

SCALE: 1/4 IN. = 1 FT.

SEE SHEET 3 FOR GENERAL NOTES
CONCERNING USES & LIMITATIONS OF THIS PLAN

2

FILE: 02-029	LESLIE RESIDENCE PREPARED BY: TIM DELBENE Residential Drafting + Design Rt. 4, Box 330, Lake City, FL 32055 Phone (904) 755-5891	SHEET: 2 of 5
DATE: 8-29-02		CAD FILE: 02029
DRAWN: T A D		REV:
CHECK: T A D		REV:

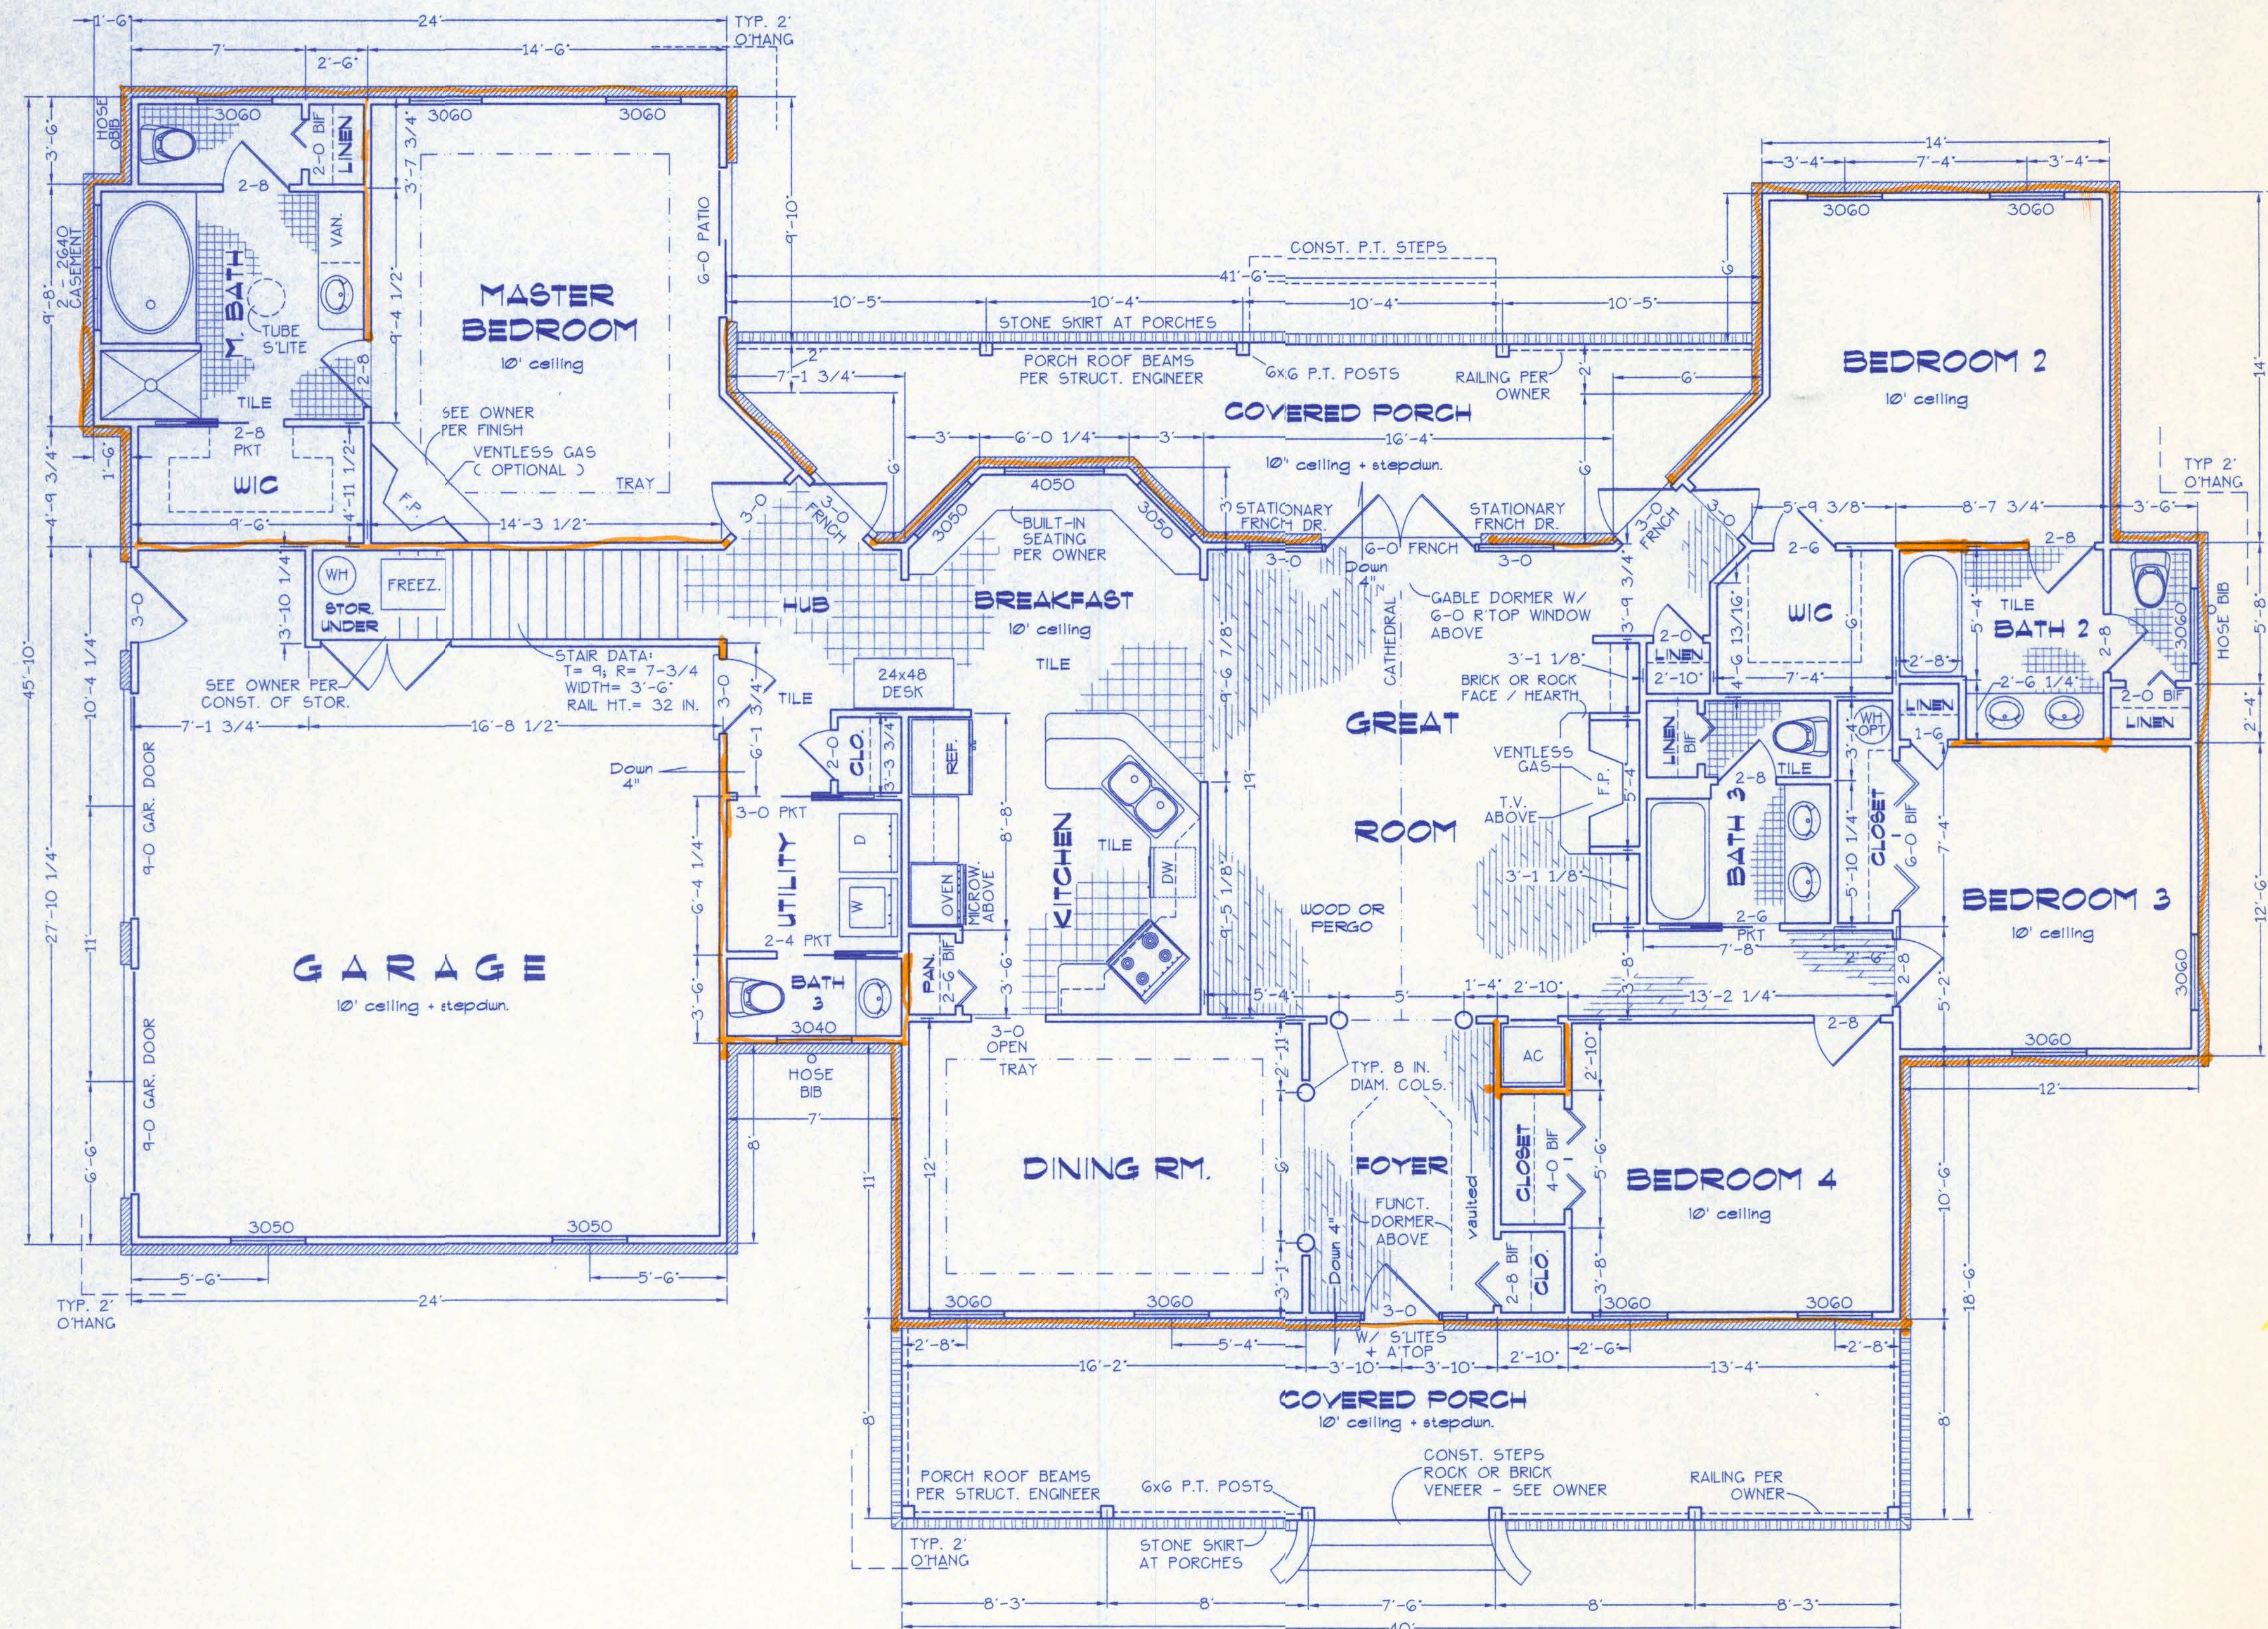

FLOOR PLAN
SCALE: 1/4 IN. = 1 FT.

AREA SUMMARY

CONDITIONED	2340 SF
GARAGE	659 SF
FRONT PORCH	320 SF
REAR PORCH	269 SF
BONUS RM.	336 SF

GENERAL NOTES

- 1.) This Plan is to provide general design data only, and to be a source of information for Estimating, Planning and the production of other technical input by the Structural Engineer, the Contractor & Sub-contractors and materials suppliers. In and of itself it is only a portion of the information required for permitting purposes and shall be accompanied by Engineering / Technical data produced by others in accordance with the Florida Building Code 2001.
- 2.) Compliance with Section 1606 of the Florida Building Code 2001 (wind engineering) shall be the responsibility of the Structural Engineer.
- 3.) Roof and/or Floor Truss engineering shall be provided by the Truss supplier. The Truss supplier shall prepare engineered drawings indicating Truss placement, Girder locations, Truss-to-Truss connections, bearing requirements and any point loads.
- 4.) Site analysis or preparation is not a part of this plan and is the responsibility of the owner / contractor.
- 5.) Windows to be double glazed. Sizes shown are nominal and may vary with manufacturer. It shall be the contractor's responsibility to provide manufacturer's data for doors and windows that comply with wind pressure requirements set by the Structural Engineer.
- 6.) HVAC unit & duct design and Manual J report to be provided by the HVAC contractor.
- 7.) Cabinet and Millwork detail is not a part of this plan. The plan is a general design and these details shall be the responsibility of the owner and/or contractor.

3

FILE: 02-029	LESLIE RESIDENCE	SHEET: 3 of 5
DATE: 8-29-02		CAD FILE: 02029
DRAWN: T A D	PREPARED BY: TIM DELBENE Residential Drafting + Design Rt. 4, Box 330, Lake City, FL 32055 Phone (904) 755-5891	REV:
CHECK: T A D		REV:

PLUMBING NOTES


- REFER TO FLOOR PLAN FOR APPROPRIATE DIMENSIONS
- FIXTURE BRANDS/MODELS PER OWNER/CONTRACTOR.
- INSTALLATION DETAILS OF WATER SERVICE, SUPPLY / WASTE LINES, ETC IS THE RESPONSIBILITY OF THE PLUMBING CONTRACTOR.

FIXTURE SCHEDULE

Ⓐ - WASHER HOOK-UP	Ⓓ - DISHWASHER
Ⓑ - LAUNDRY SINK n/a	Ⓔ - HVAC UNIT
Ⓒ - WATER HEATER	Ⓕ - ICE-MAKER SUPPLY
Ⓔ - COMMODE / TANK	Ⓖ - TUB / SHOWER COMBO
Ⓕ - SHOWER UNIT	Ⓗ - GARDEN TUB
Ⓖ - LAVATORY SINK	Ⓘ - HOSE BIB LOCATIONS
Ⓖ - KITCHEN SINK	


FOUNDATION NOTES:

- 1.) THE FOUNDATION INFORMATION BELOW IS PRELIMINARY IN NATURE AND IS SUPPLIED TO CONVEY THE OWNER'S INSTRUCTIONS FOR FOUNDATION CONSTRUCTION TO THE STRUCTURAL ENGINEER.
- 2.) TRUSS ENGINEERING AND OTHER FACTORS SHALL BE CONSIDERED BY THE STRUCTURAL ENGINEER TO PRODUCE A FINAL FOUNDATION PLAN.
- 3.) TRUSS SUPPLIER'S DESIGN SHALL PRECEDE STRUCTURAL ENGINEERING SO THAT THE TRUSS DESIGNER MAY CONSIDER ALL NECESSARY BEARING REQUIREMENTS FOR AN EFFICIENT DESIGN.

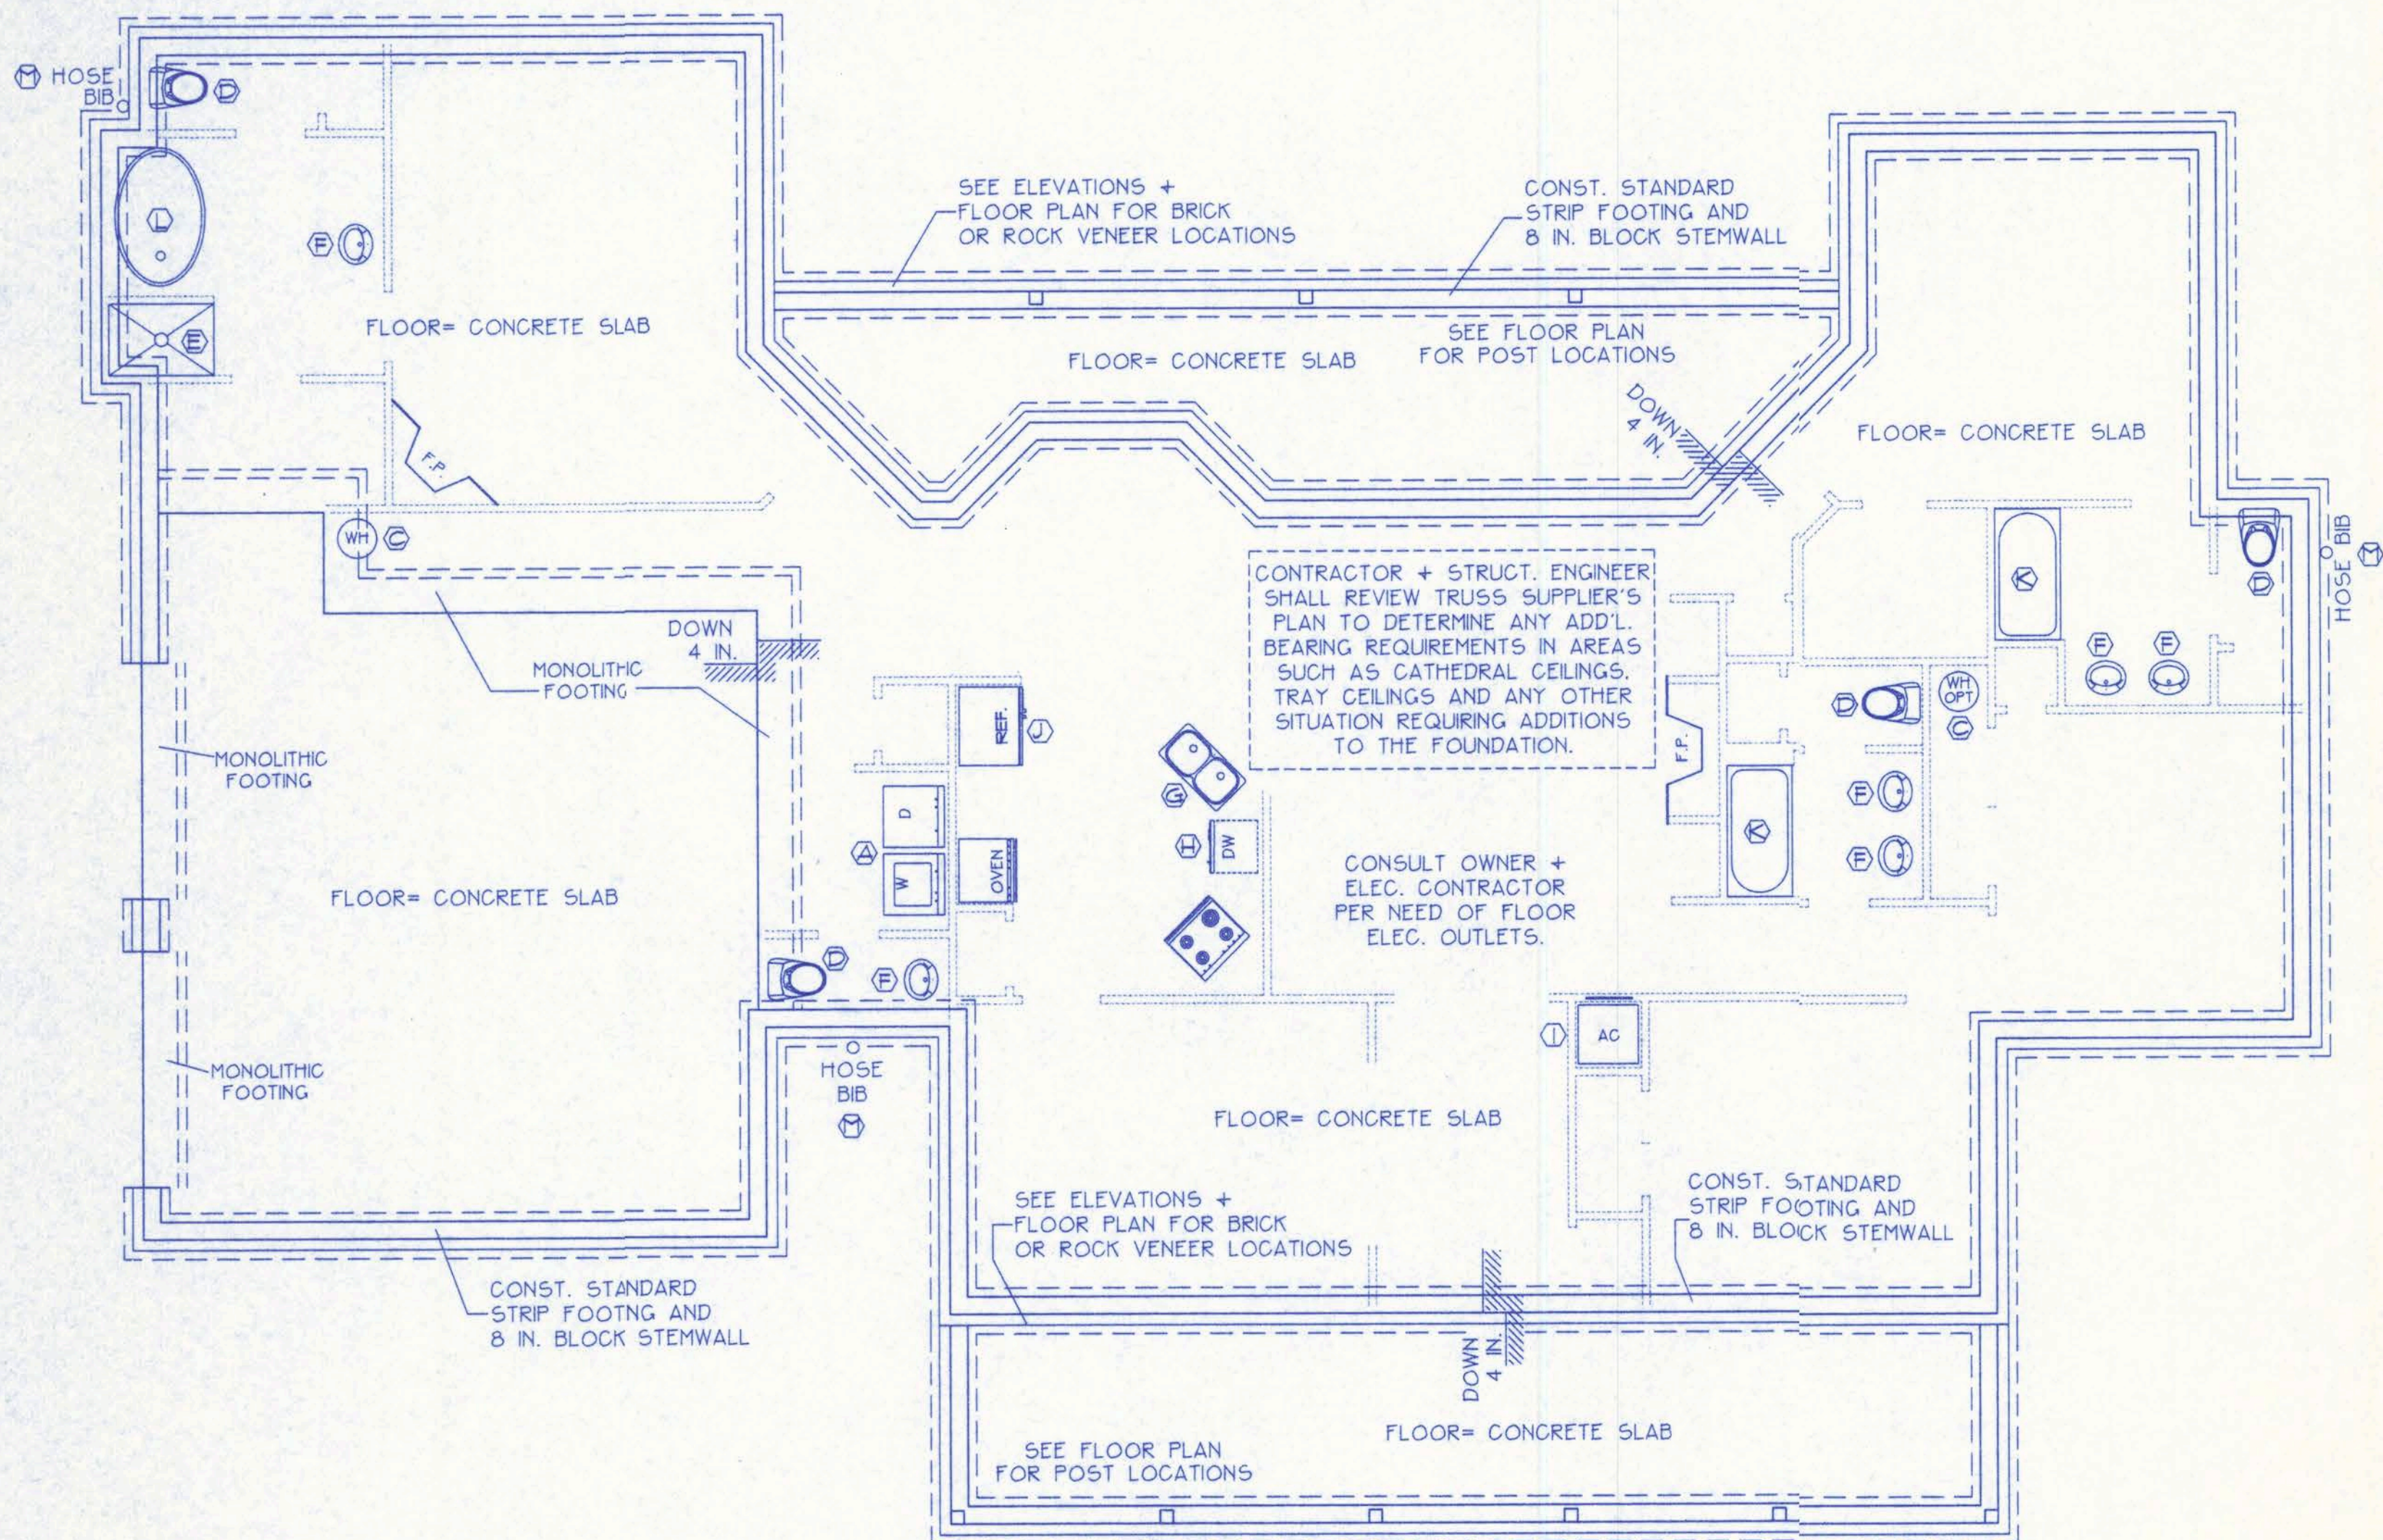

PRELIMINARY FOUNDATION
INFORMATION
+ PLUMBING FIXTURES
NOT TO SCALE

SEE SHEET 3 FOR GENERAL NOTES
CONCERNING USES & LIMITATIONS OF THIS PLAN

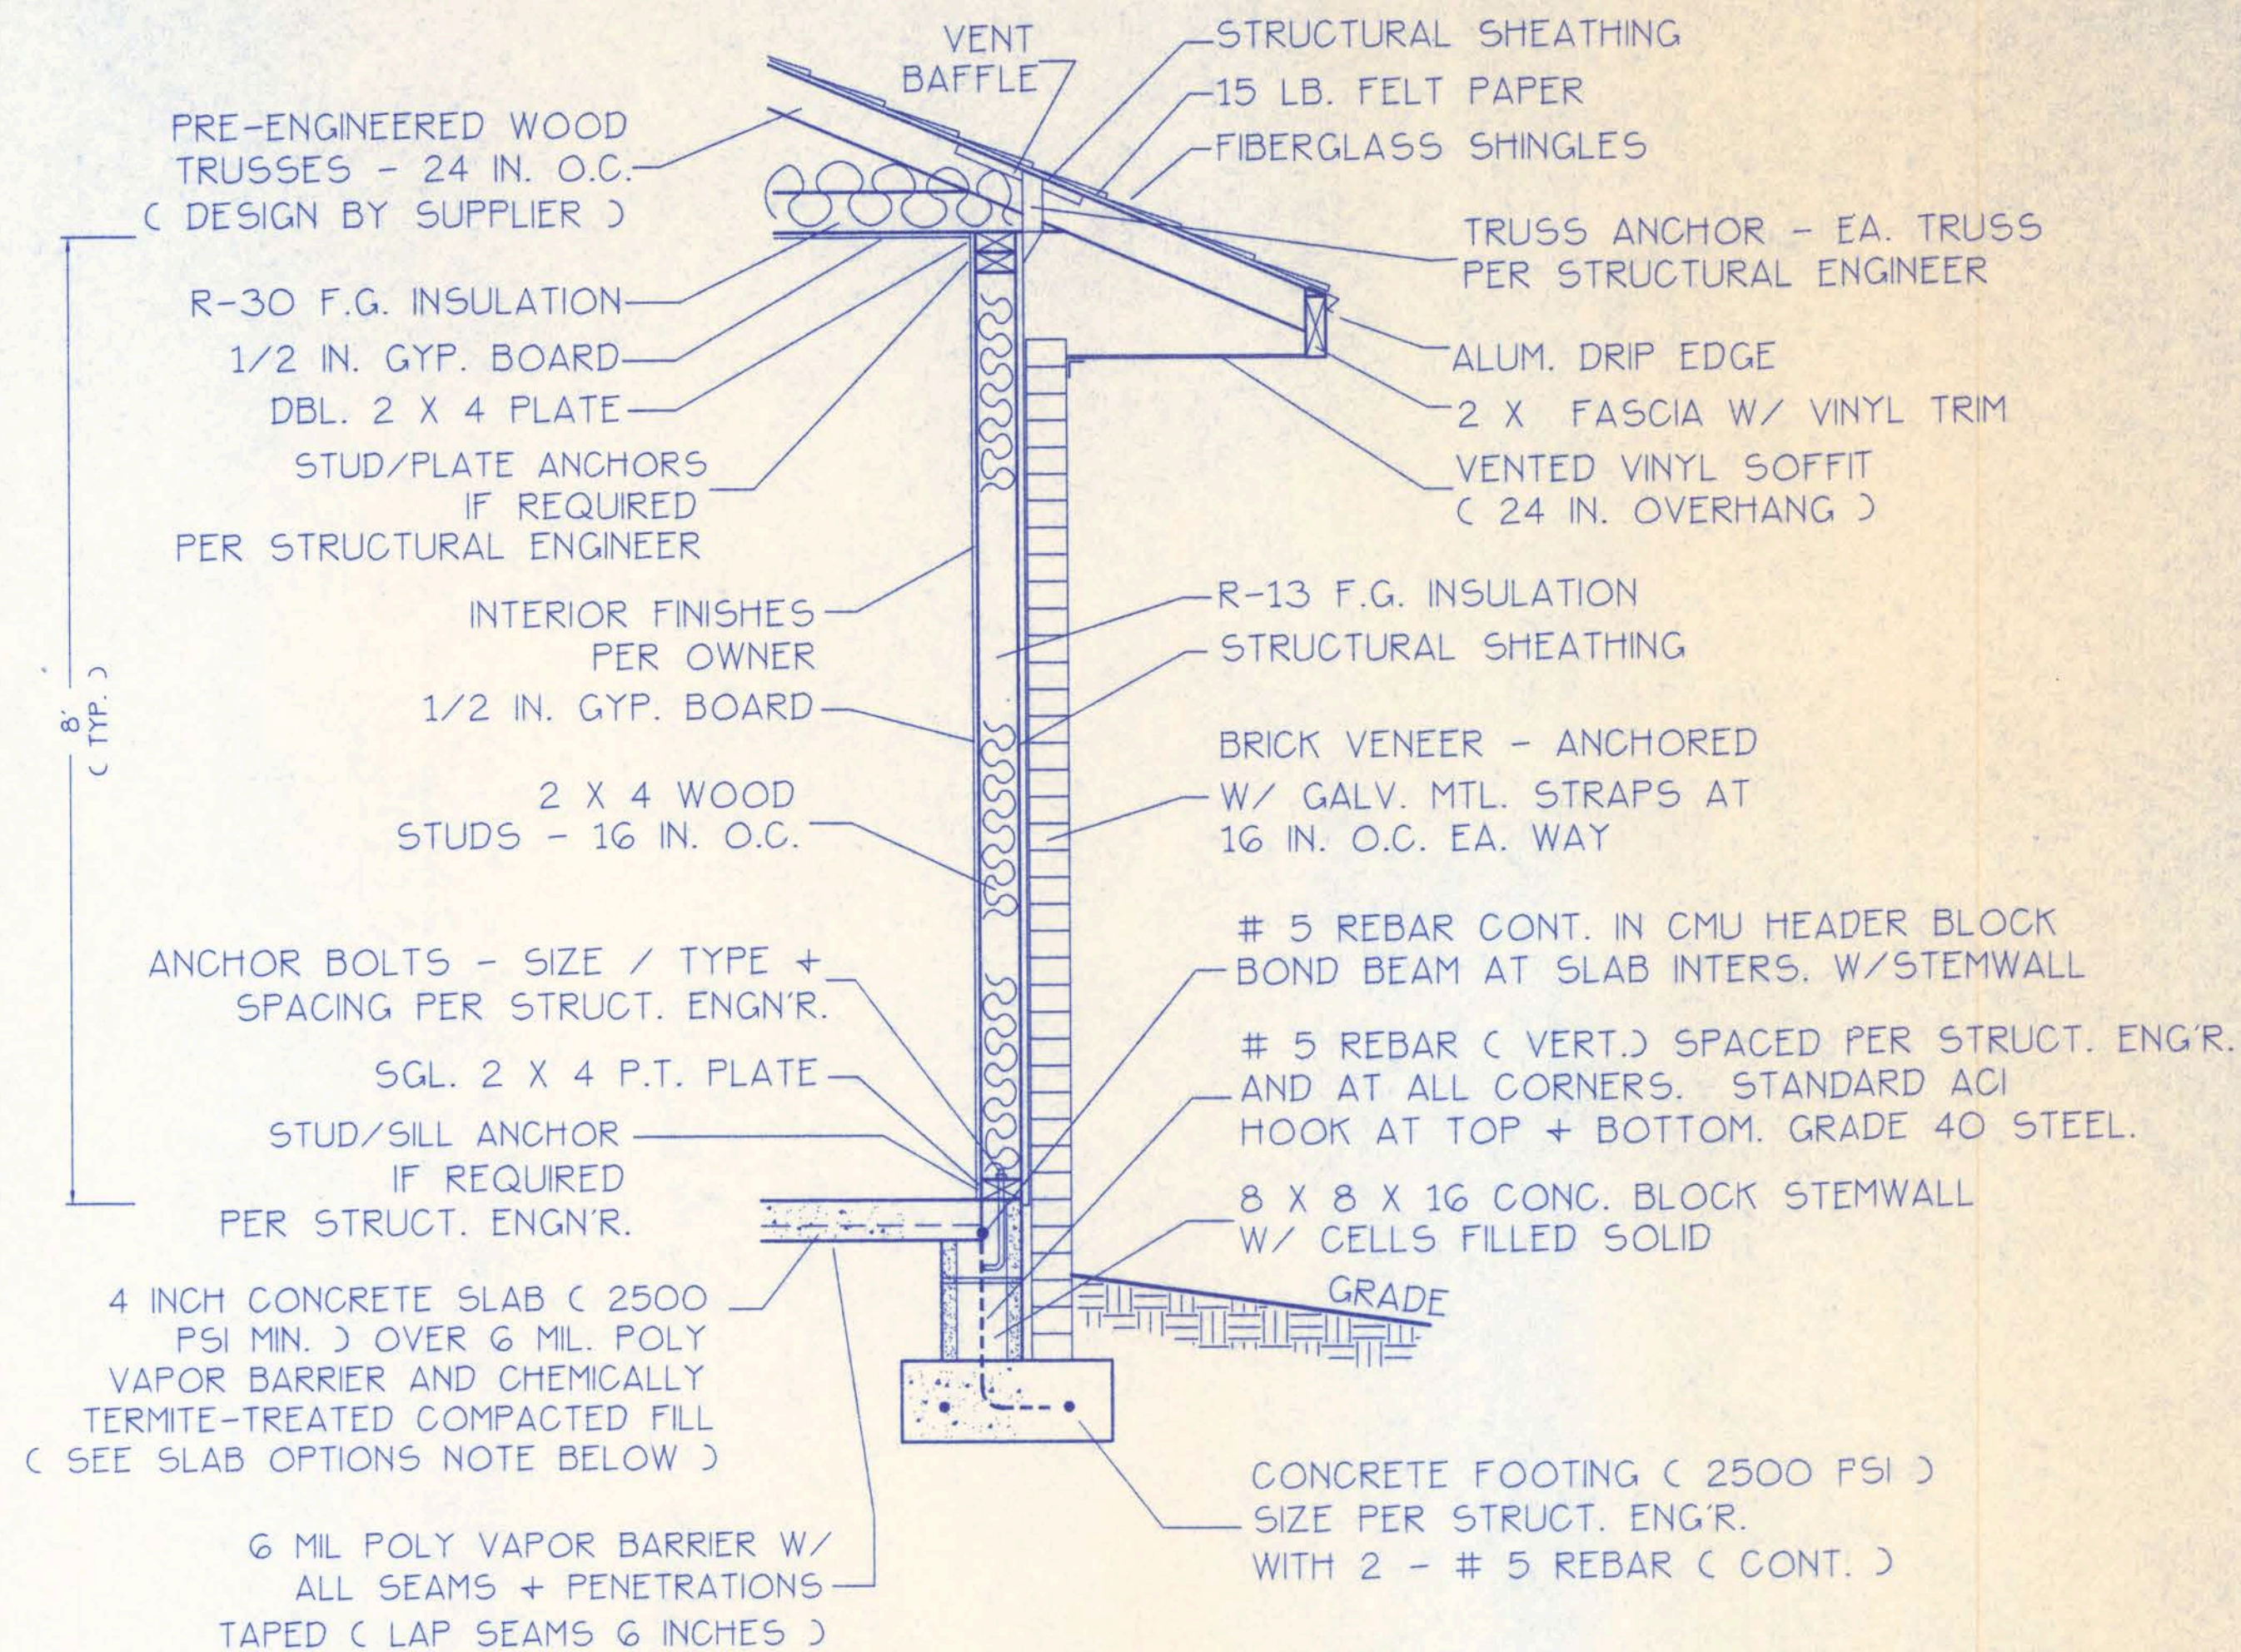

SLAB OPTIONS:

- OPTION 1 - Use 6x6 10/10 WWM reinforcing on chair supports at 3' O.C.
- OPTION 2 - Use Synthetic Fiber reinforced concrete.

WALL SECTION NOTES:

- This Typical Wall Section is for Estimating purposes only.
- All data shown in this Wall Section shall be subject to review and final input by the Structural Engineer.

DESIGN WALL SECTION

NON-STRUCTURAL DATA

SCALE: 3/4 IN. = 1 FT.

4

FILE: 02-029	LESLIE RESIDENCE	SHEET: 4 of 5
DATE: 8-29-02		CAD FILE: 02029
DRAWN: T A D	PREPARED BY: TIM DELBENE Residential Drafting + Design	REV:
CHECK: T A D	Rt. 4, Box 330, Lake City, FL 32055 Phone (904) 758-5891	REV:

GENERAL NOTES:

SITE ANALYSIS AND PREPARATION INFORMATION IS NOT PART OF THIS PLAN AND IS RESPONSIBILITY OF THE OWNER. ALL FOUNDATIONS AND FOOTING ARE DESIGNED FOR STABLE SOIL CONDITION WITH 2000 psf BEARING CAPACITY. IT IS THE OWNER'S / BUILDER'S RESPONSIBILITY TO VERIFY SOIL AND CLEAN FILL ARE COMPACTED TO PROVIDE 2000 psf MINIMUM BEARING CAPACITY OR TO REQUEST FOUNDATION DESIGN BASED ON ACTUAL SITE CONDITIONS.


MANUFACTURERS AND PRODUCT NUMBER FOR CONNECTORS, ANCHORS, AND REINFORCEMENT ARE LISTED FOR EXAMPLE NOT ENDORSEMENT. AN EQUIVALENT DEVICE OF THE SAME OR OTHER MANUFACTURER CAN BE SUBSTITUTED FOR ANY DEVICES LISTED IN THE EXAMPLE TABLES AS LONG AS IT MEETS THE REQUIRED LOAD CAPACITIES. MANUFACTURER'S INSTALLATION INSTRUCTIONS MUST BE FOLLOWED TO ACHIEVE RATED LOADS.

ANCHOR BOLTS - A-307. MINIMUM EMBEDMENT: 7" IN CONCRETE OR REINFORCED CONCRETE. 15" IN GROUTED CMU.

CONCRETE - MINIMUM COMPRESSIVE STRENGTH, $F_c = 2500$ psi.

REBAR - GRADE 40 DEFORMED BARS, $F_y = 36$ ksi. ALL LAPS 40" DB (25" FOR #5) UNLESS OTHERWISE SPECIFIED.

NAILS - ALL NAILS ARE COMMON NAILS UNLESS OTHERWISE SPECIFIED OR ACCEPTED BY SBC TEST REPORTS AS HAVING EQUAL STRUCTURAL VALUES.

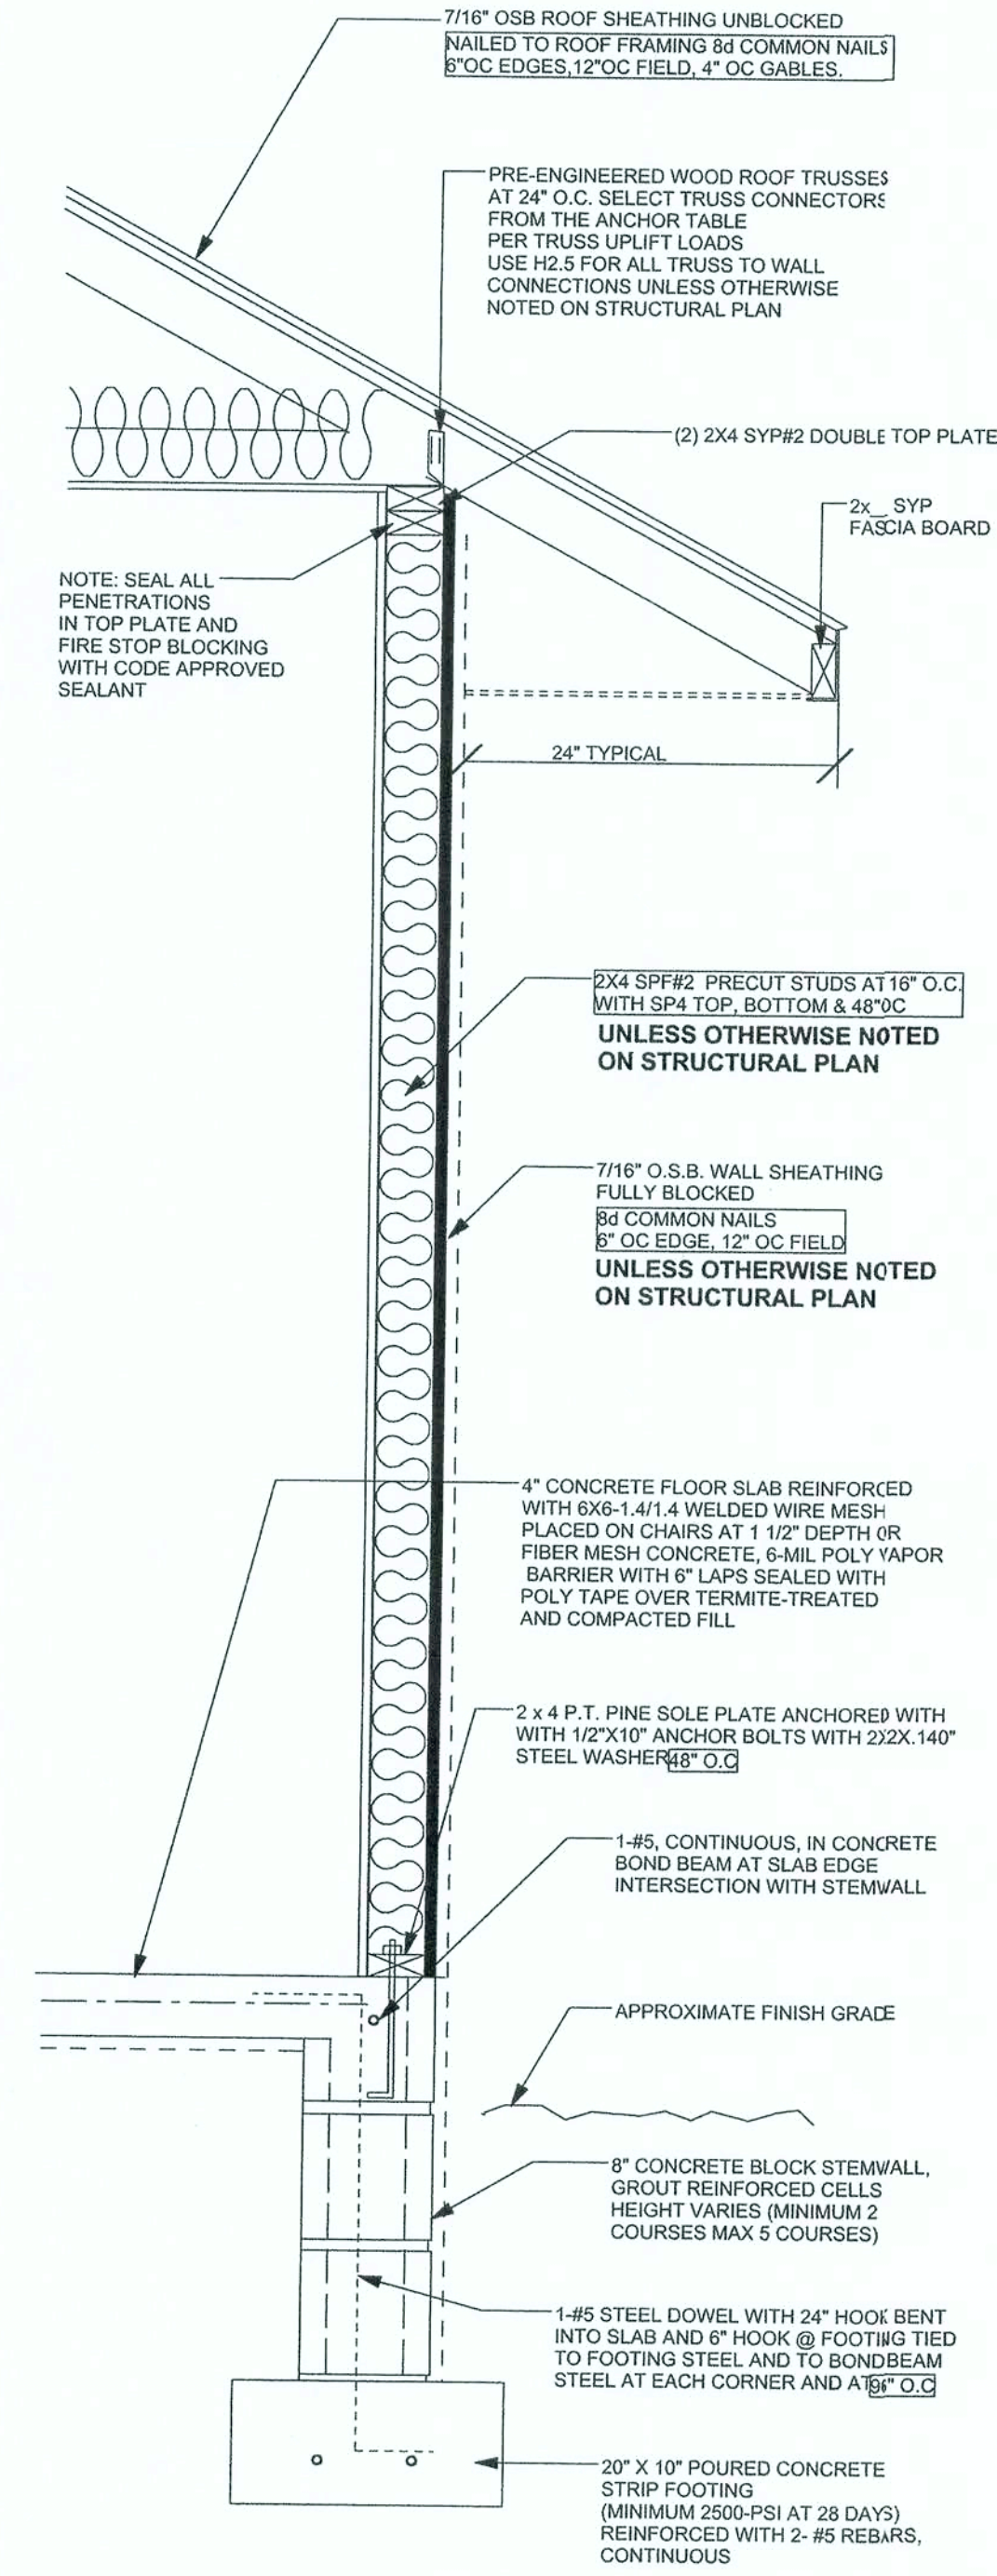

SINGLE STORY EXTERIOR WALL SECTION

ROOF SYSTEM DESIGN

THE SEAL ON THESE PLANS FOR COMPLIANCE WITH FBC 2001, SECTION 1606 IS BASED ON REACTIONS, UPLIFTS, AND BEARING LOCATIONS IN TRUSS ENGINEERING SUBMITTED TO THE WIND LOAD ENGINEER. IT IS THE RESPONSIBILITY OF THE BUILDER TO CHECK ALL DETAILS OF THE COMPLETE ROOF SYSTEM DESIGN SUBMITTED BY THE TRUSS MANUFACTURER AND HAVE IT SIGNED, AND SEALED BY A DESIGN PROFESSIONAL FOR CORRECT APPLICATION OF FBC 2001 REQUIRED LOADS AND ANY SPECIAL LOADS. THE BUILDER IS RESPONSIBLE TO REVIEW EACH INDIVIDUAL TRUSS MEMBER AND THE TRUSS ROOF SYSTEM AS A WHOLE AND TO PROVIDE RESTRAINT FOR ANY LATERAL BRACING. THE BUILDER SHOULD USE CARE CHECKING THE ROOF DESIGN BECAUSE THE WIND LOAD ENGINEER IS SPECIFICALLY NOT RESPONSIBLE FOR THE TRUSS LAYOUT WHICH WAS CREATED BY THE TRUSS MANUFACTURER AND THE TRUSS DESIGNER ALSO DENIES RESPONSIBILITY FOR THE LAYOUT PER NOTES ON THEIR SEALED TRUSS SHEETS.

BUILDER'S RESPONSIBILITY:

THE BUILDER AND OWNER ARE RESPONSIBLE FOR THE FOLLOWING, WHICH ARE SPECIFICALLY NOT PART OF THE WIND LOAD ENGINEER'S SCOPE OF WORK.

CONFIRM SITE CONDITIONS, FOUNDATION BEARING CAPACITY, GRADE AND BACKFILL HEIGHT, WIND SPEED AND DEBRIS ZONE, AND FLOOD ZONE.

PROVIDE MATERIALS AND CONSTRUCTION TECHNIQUES, WHICH COMPLY WITH FBC 2001 REQUIREMENTS FOR THE STATED WIND VELOCITY AND DESIGN PRESSURES.

PROVIDE A CONTINUOUS LOAD PATH FROM TRUSSES TO FOUNDATION. IF YOU BELIEVE THE PLAN OMMITS A CONTINUOUS LOAD PATH CONNECTION, CALL THE WIND LOAD ENGINEER IMMEDIATELY.

VERIFY THE TRUSS MANUFACTURER'S SEALED ENGINEERING INCLUDES TRUSS DESIGN, PLACEMENT PLANS, TEMPORARY AND PERMANENT BRACING DETAILS, TRUSS-TO-TRUSS CONNECTIONS, AND UPLIFT AND REACTION LOADS FOR ALL BEARING LOCATIONS. SELECT UPLIFT CONNECTIONS AND PROVIDE FOOTINGS BASED ON TRUSS ENGINEERING REACTIONS. FURNISH TRUSS ENGINEERING TO WIND LOAD ENGINEER FOR REVIEW OF TRUSS REACTIONS.


ANCHOR TABLE

OBTAIN UPLIFT REQUIREMENTS FROM TRUSS MANUFACTURER'S ENGINEERING

UPLIFT LBS.	TRUSS CONNECTOR*	TO PLATES	TO RAFTER	TO STUDS
< 415	H2.5	5-8d, 1 1/2"	5-8d, 1 1/2"	
< 750	H16	4-10d, 1 1/2"	2-10d, 1 1/2"	
< 905	H10 - 1	8-8d, 1 1/2"	8-8d, 1 1/2"	
< 655	H10 - 2	6-10d, 1 1/2"	6-10d, 1 1/2"	
< 1120	H15 - 1	4-10d, 1 1/2"	12-10d, 1 1/2"	12-10d, 1 1/2"
< 1120	H15 - 2	4-10d, 1 1/2"	4-10d, 1 1/2"	12-10d, 1 1/2"
< 1265	H16 - 1	10-10d, 1 1/2"	2-10d, 1 1/2"	
< 1265	H16 - 2	10-10d, 1 1/2"	2-10d, 1 1/2"	
< 860	MTS20	7-10d, 1 1/2"	7-10d, 1 1/2"	
< 1245	HTS20	12-10d, 1 1/2"	12-10d, 1 1/2"	
< 2490	2 - HTS20			
< 1785	LGT2	14-16d, 1 1/2"	14-16d, 1 1/2"	
STUD STRAP CONNECTOR*				
< 735	SP4	6-10d, 1 1/2"		
< 735	SP6	6-10d, 1 1/2"		
< 905	LSTA21	16-10d, 1 1/2"		
< 1240	SPH4	10-10d, 1 1/2"		
< 1005	CS20	18-8d, 1 1/2"		
< 1650	CS16	28-8d, 1 1/2"		
STUD ANCHORS*				
< 1205	LTT19	8-16d	1/2" AB	
< 2185	LTT131	18-10d	1/2" AB	
< 2565	HD2A	2-5/8" BOLTS	5/8" AB	
< 3480	HTT16	18-16d 1 1/2"	5/8" AB	
< 2200	ABU44	12-16d	1/2" AB	
< 2300	ABU66	12-16d	1/2" AB	
< 2320	ABU88	18-16d	(2) 5/8" AB	

WALL STUD TABLE

1 - 2 X 4 @ 16" OC	TO 10' WALL HEIGHT
1 - 2 X 4 @ 12" OC	TO 12.5' WALL HEIGHT
1 - 2 X 6 @ 16" OC	TO 16.0' WALL HEIGHT
1 - 2 X 6 @ 12" OC	TO 20.0' WALL HEIGHT

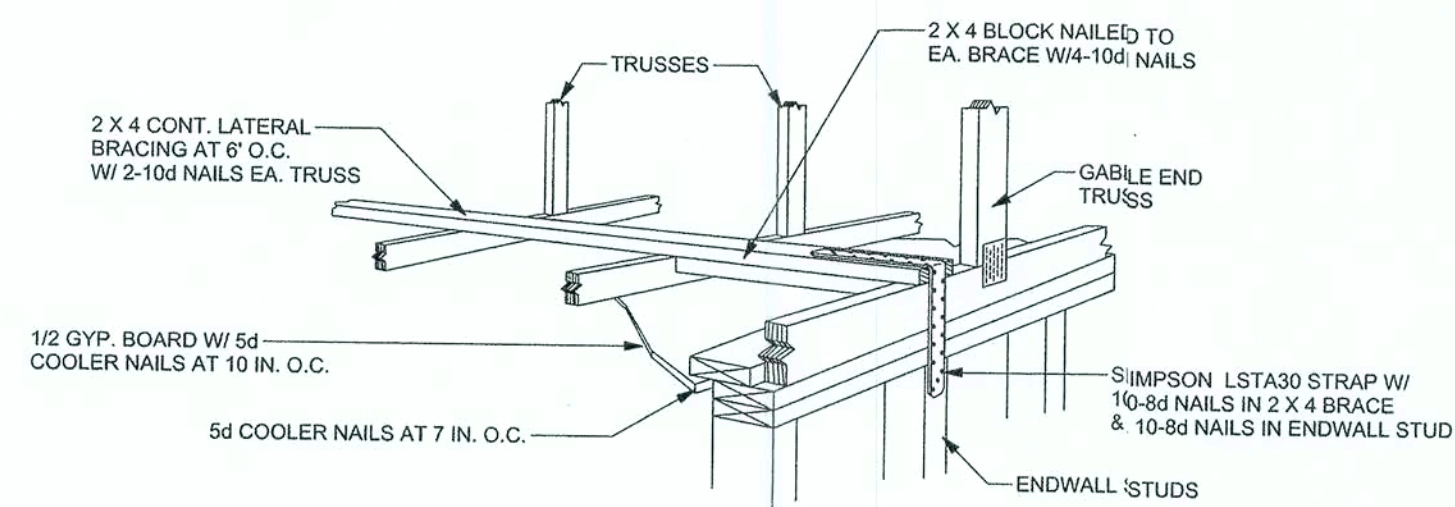


GYPSUM CEILING DIAPHRAGM

OPTION - GABLE END WALL
SCALE: NONE


ALTERNATIVE TO BALLOON FRAMING IS GYPSUM CEILING DIAPHRAGM AS SPECIFIED IN THE "WOOD FRAME CONSTRUCTION MANUAL" (WFCM). SEE WFCM TABLE 3.13 AND FIGURE 3.6a. SHOWN ABOVE, PROTECT GYPSUM FROM MOISTURE TO PRESERVE STRENGTH OF DIAPHRAGM.

NOTE: EXTEND RAIL RUN BRACES GABLE TO GABLE OR A LENGTH EQUAL TO 1/2 OF GABLE WIDTH FOR ROOF'S UP TO 7:12 AND 5/8 OF GABLE WIDTH OVER 7:12

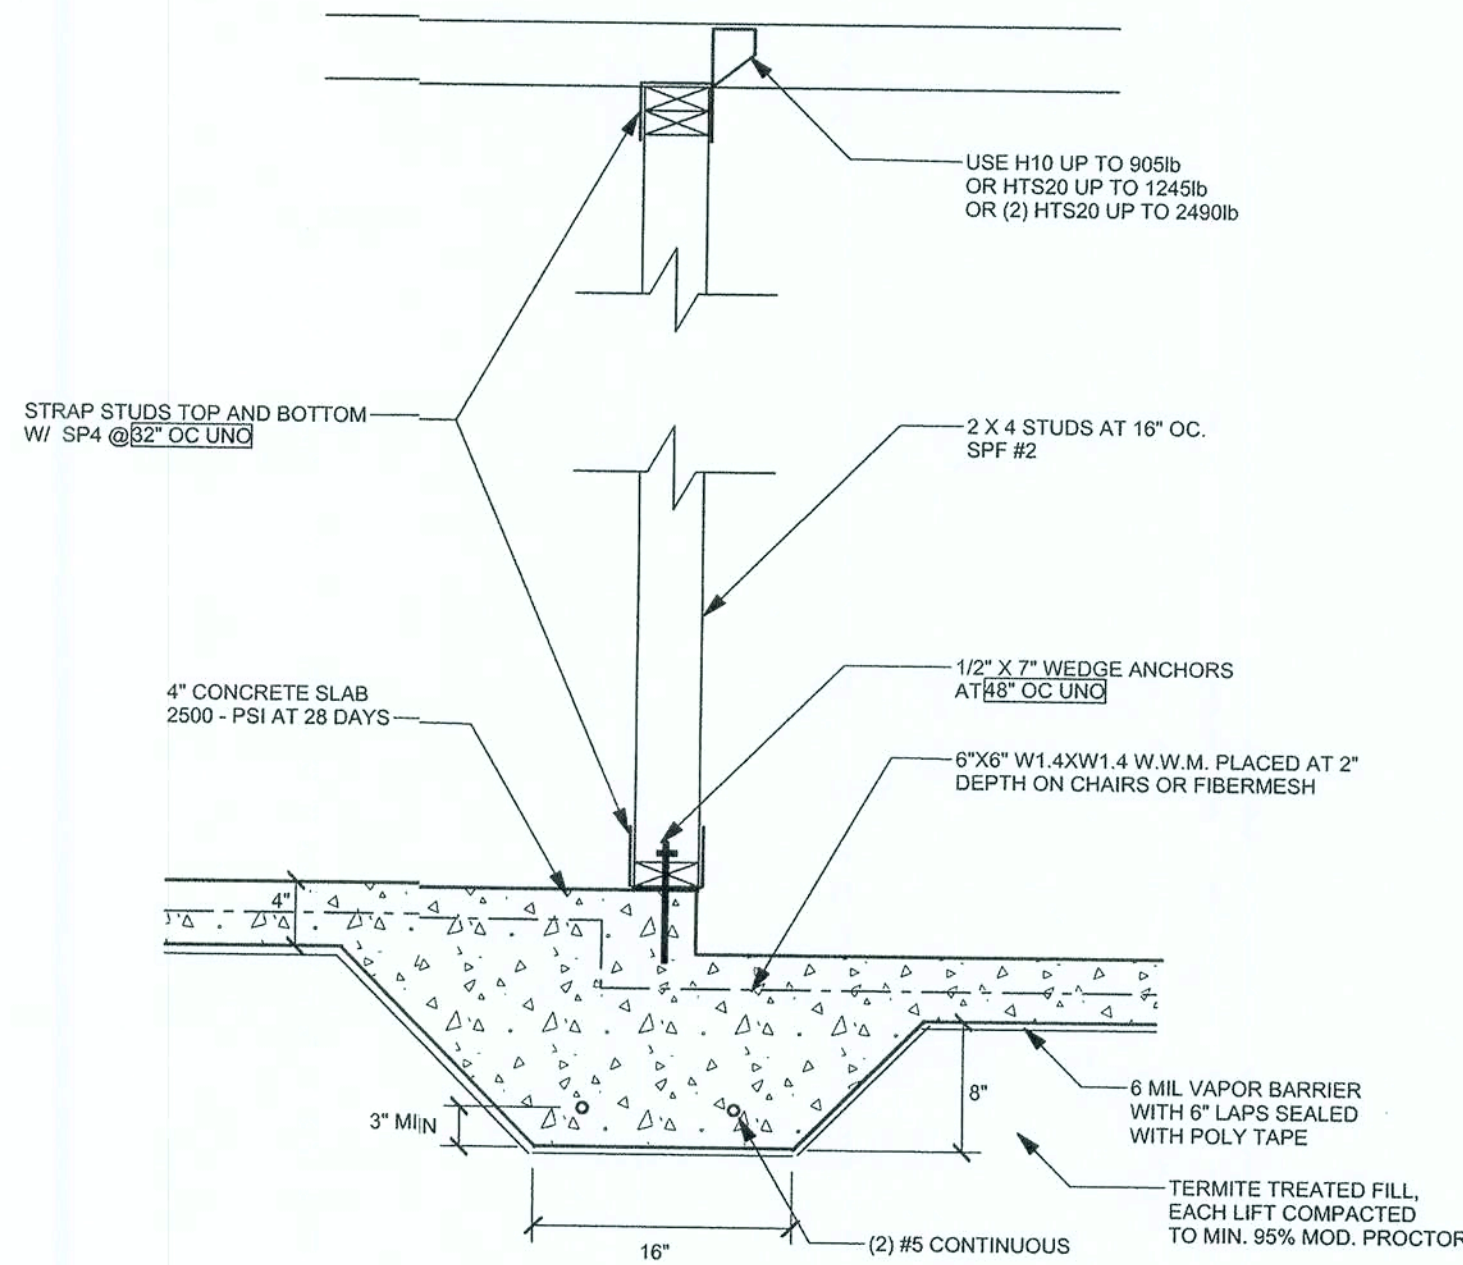


F5 - INTERIOR BEARING STEP FOOTING

SCALE: 1" = 1'-0"

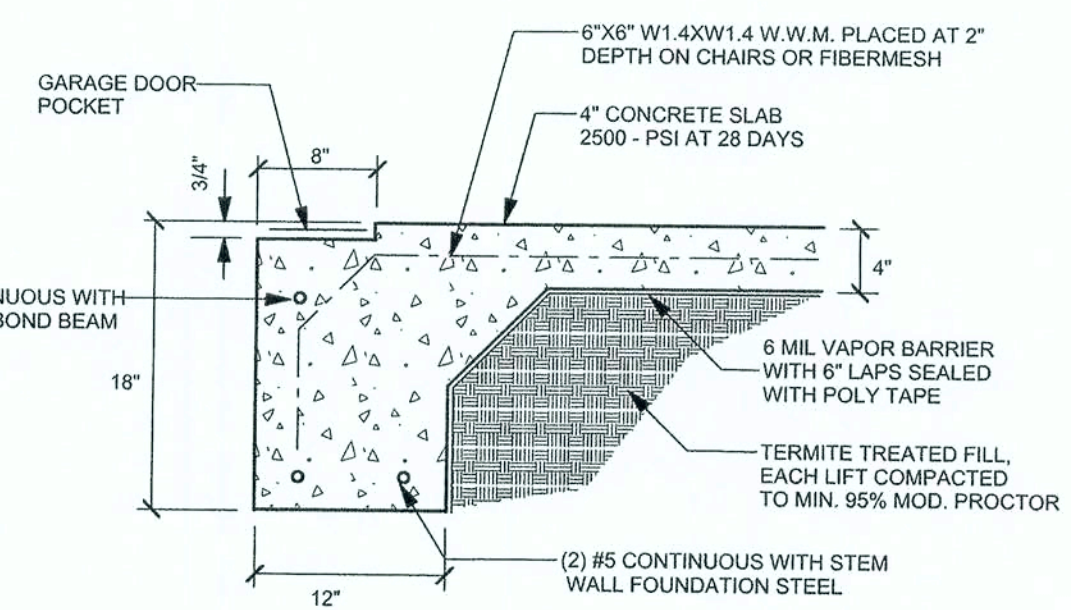


F2 - GARAGE DOOR POCKET

SCALE: 1" = 1'-0"

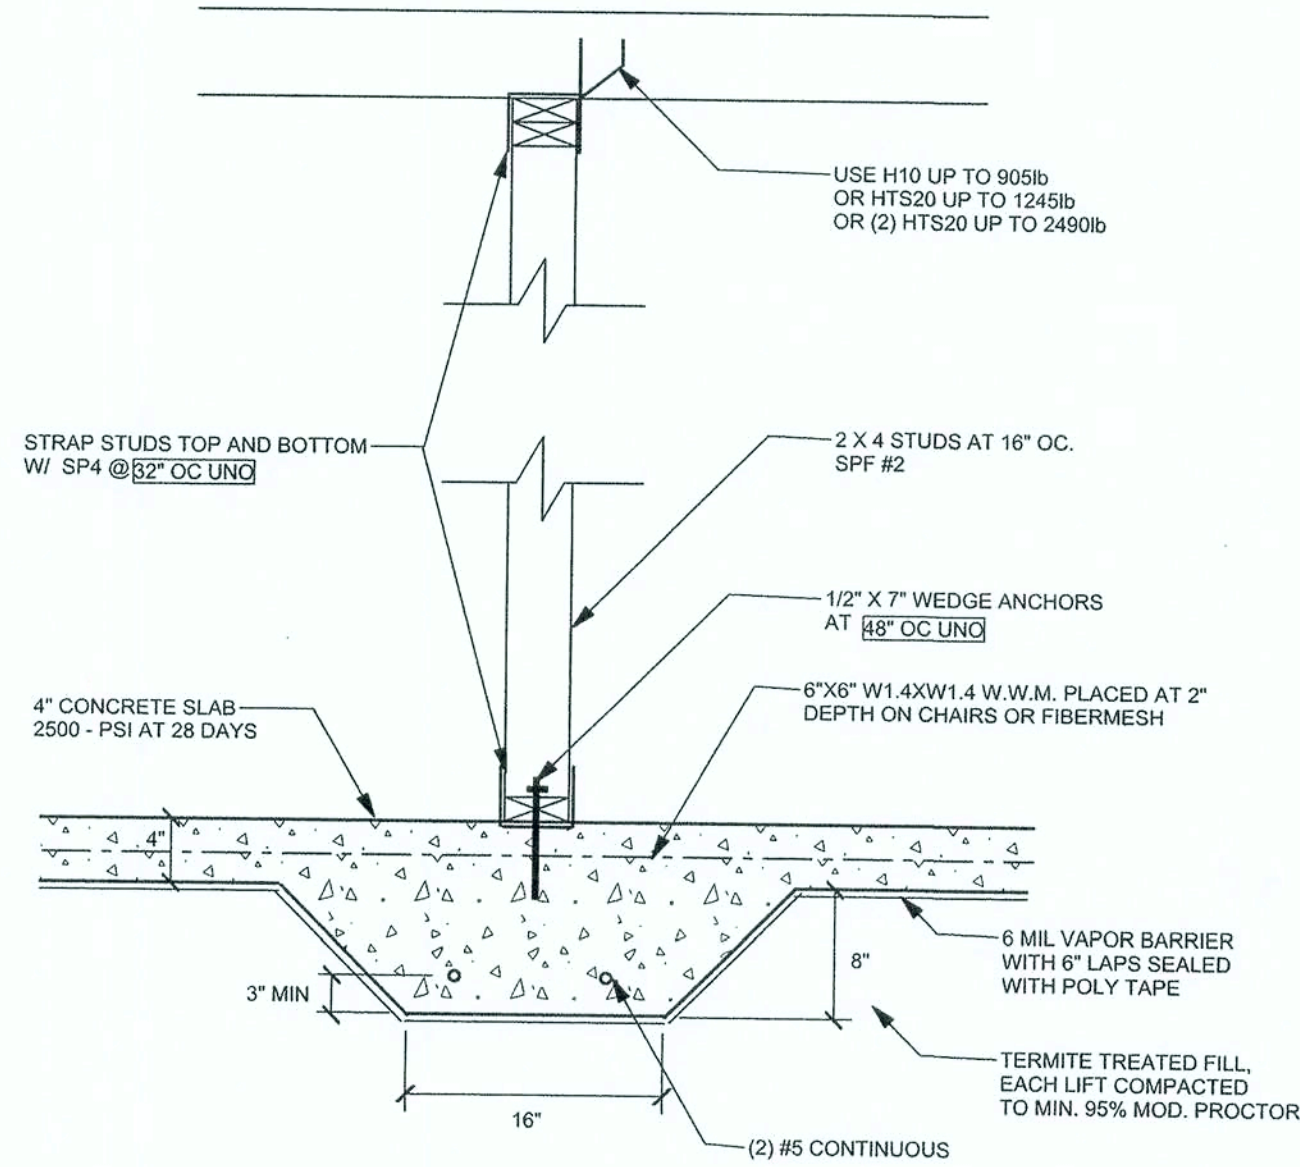

F4 - INTERIOR BEARING FOOTING

SCALE: 1" = 1'-0"

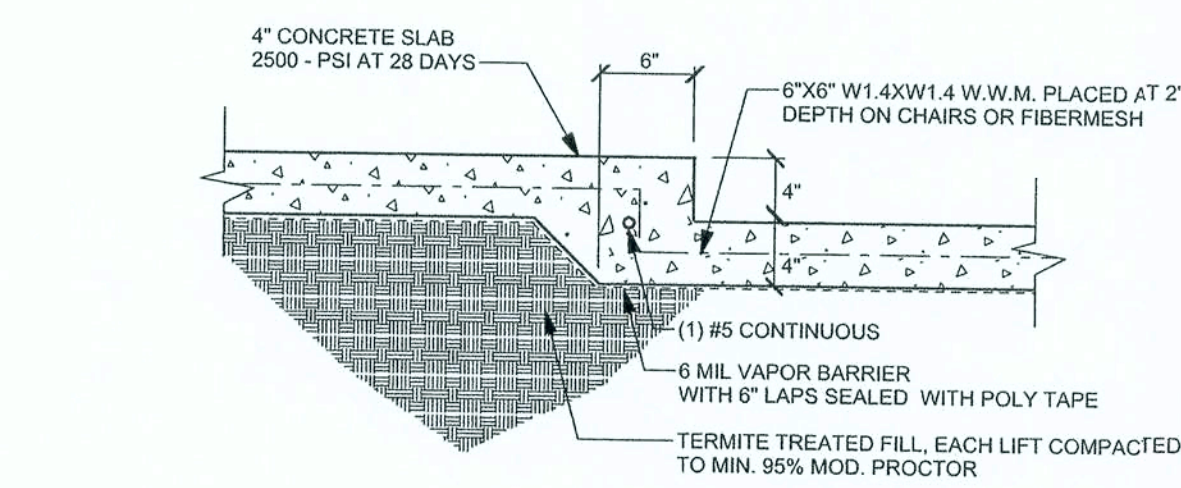

F3 - TYPICAL NON - BEARING STEP FOOTING

SCALE: 1" = 1'-0"

DESIGN DATA

WIND LOADS ARE PER FLORIDA BUILDING CODE 2001, SECTION 1606.2 (FOR ENCLOSED SIMPLE DIAPHRAGM BUILDINGS WITH FLAT, HIPPED AND GABLE-SHAPED ROOFS HAVING A MEAN ROOF HEIGHT NOT EXCEEDING THE LEAST HORIZONTAL DIMENSION OF THE BUILDING OR 60 FT; NOT SITED ON THE UPPER HALF OF A HILL OR ESCARPMENT 60 FT IN EXPOSURE B, 30 FT IN EXPOSURE C AND >10% SLOPE AND UNOBSTRUCTED UPWIND FOR 50x HEIGHT OR 1 MILE WHICHEVER IS LESS.)

BUILDING IS NOT IN THE HIGH VELOCITY HURRICANE ZONE

BUILDING IS NOT IN THE WIND-BORNE DEBRIS REGION

1.) BASIC WIND SPEED = 110 MPH

2.) WIND IMPORTANCE FACTOR = 1

3.) BUILDING CATEGORY = II

4.) INTERNAL PRESSURE COEFFICIENT = N/A (ENCLOSED BUILDING)

5.) COMPONENTS AND CLADDING DESIGN WIND PRESSURES: (DOORS & WINDOWS) +21.8 / -29.1 PSF
GARAGE DOOR 9x7 +19.3 / -22.2 PSF; 16x7, +18.5 / -20.9

DESIGN LOADS

FLOOR 40 PSF (ALL OTHER DWELLING ROOMS)
30 PSF (SLEEPING ROOMS)
30 PSF (ATTICS WITH STORAGE)
10 PSF (ATTICS WITHOUT STORAGE, <3:12)

ROOF 20 PSF (FLAT OR <4:12)
16 PSF (4:12 TO <12:12)
12 PSF (12:12 AND GREATER)

STAIRS 40 PSF (ONE & TWO FAMILY DWELLINGS)

NO SNOW LOAD

BUILDING IS NOT IN A FLOOD ZONE

WIND LOADS ARE PER FLORIDA BUILDING CODE 2001, SECTION 1606.2

REVISIONS

MARK DISOSWAY, P.E.

P.O. BOX 868, LAKE CITY, FL 32056

PHONE: (386) 754-5419 FAX: (386) 754-6749

GENE LESLIE RESIDENCE

ADDRESS: LOT #7 SOUTHPOINTE SUBDIVISION, COLUMBIA COUNTY, FLORIDA

I HEREBY CERTIFY THAT I HAVE EXAMINED THIS PLAN, AND THAT THE APPLICABLE PORTIONS OF THE PLAN, RELATING TO WIND ENGINEERING COMPLY WITH SECTION 1606, FLORIDA BUILDING CODE 2001, TO THE BEST OF MY KNOWLEDGE.

30 / SEP / 02

MARK DISOSWAY
P.E. 53915

SEAL


SHEET NAME

S - 1

JOB NUMBER

209271

MARK DISOSWAY, P.E. HEREBY EXPRESSLY RESERVES ITS COMMON LAW COPYRIGHTS AND PROPERTY RIGHTS. THIS DRAWING IS NOT TO BE REPRODUCED, ALTERED OR COPIED IN ANY FORM WITHOUT THE EXPRESS WRITTEN PERMISSION OF MARK DISOSWAY. THIS DRAWING IS NOT VALID FOR CONSTRUCTION UNLESS RAISED SEAL IS AFFIXED.

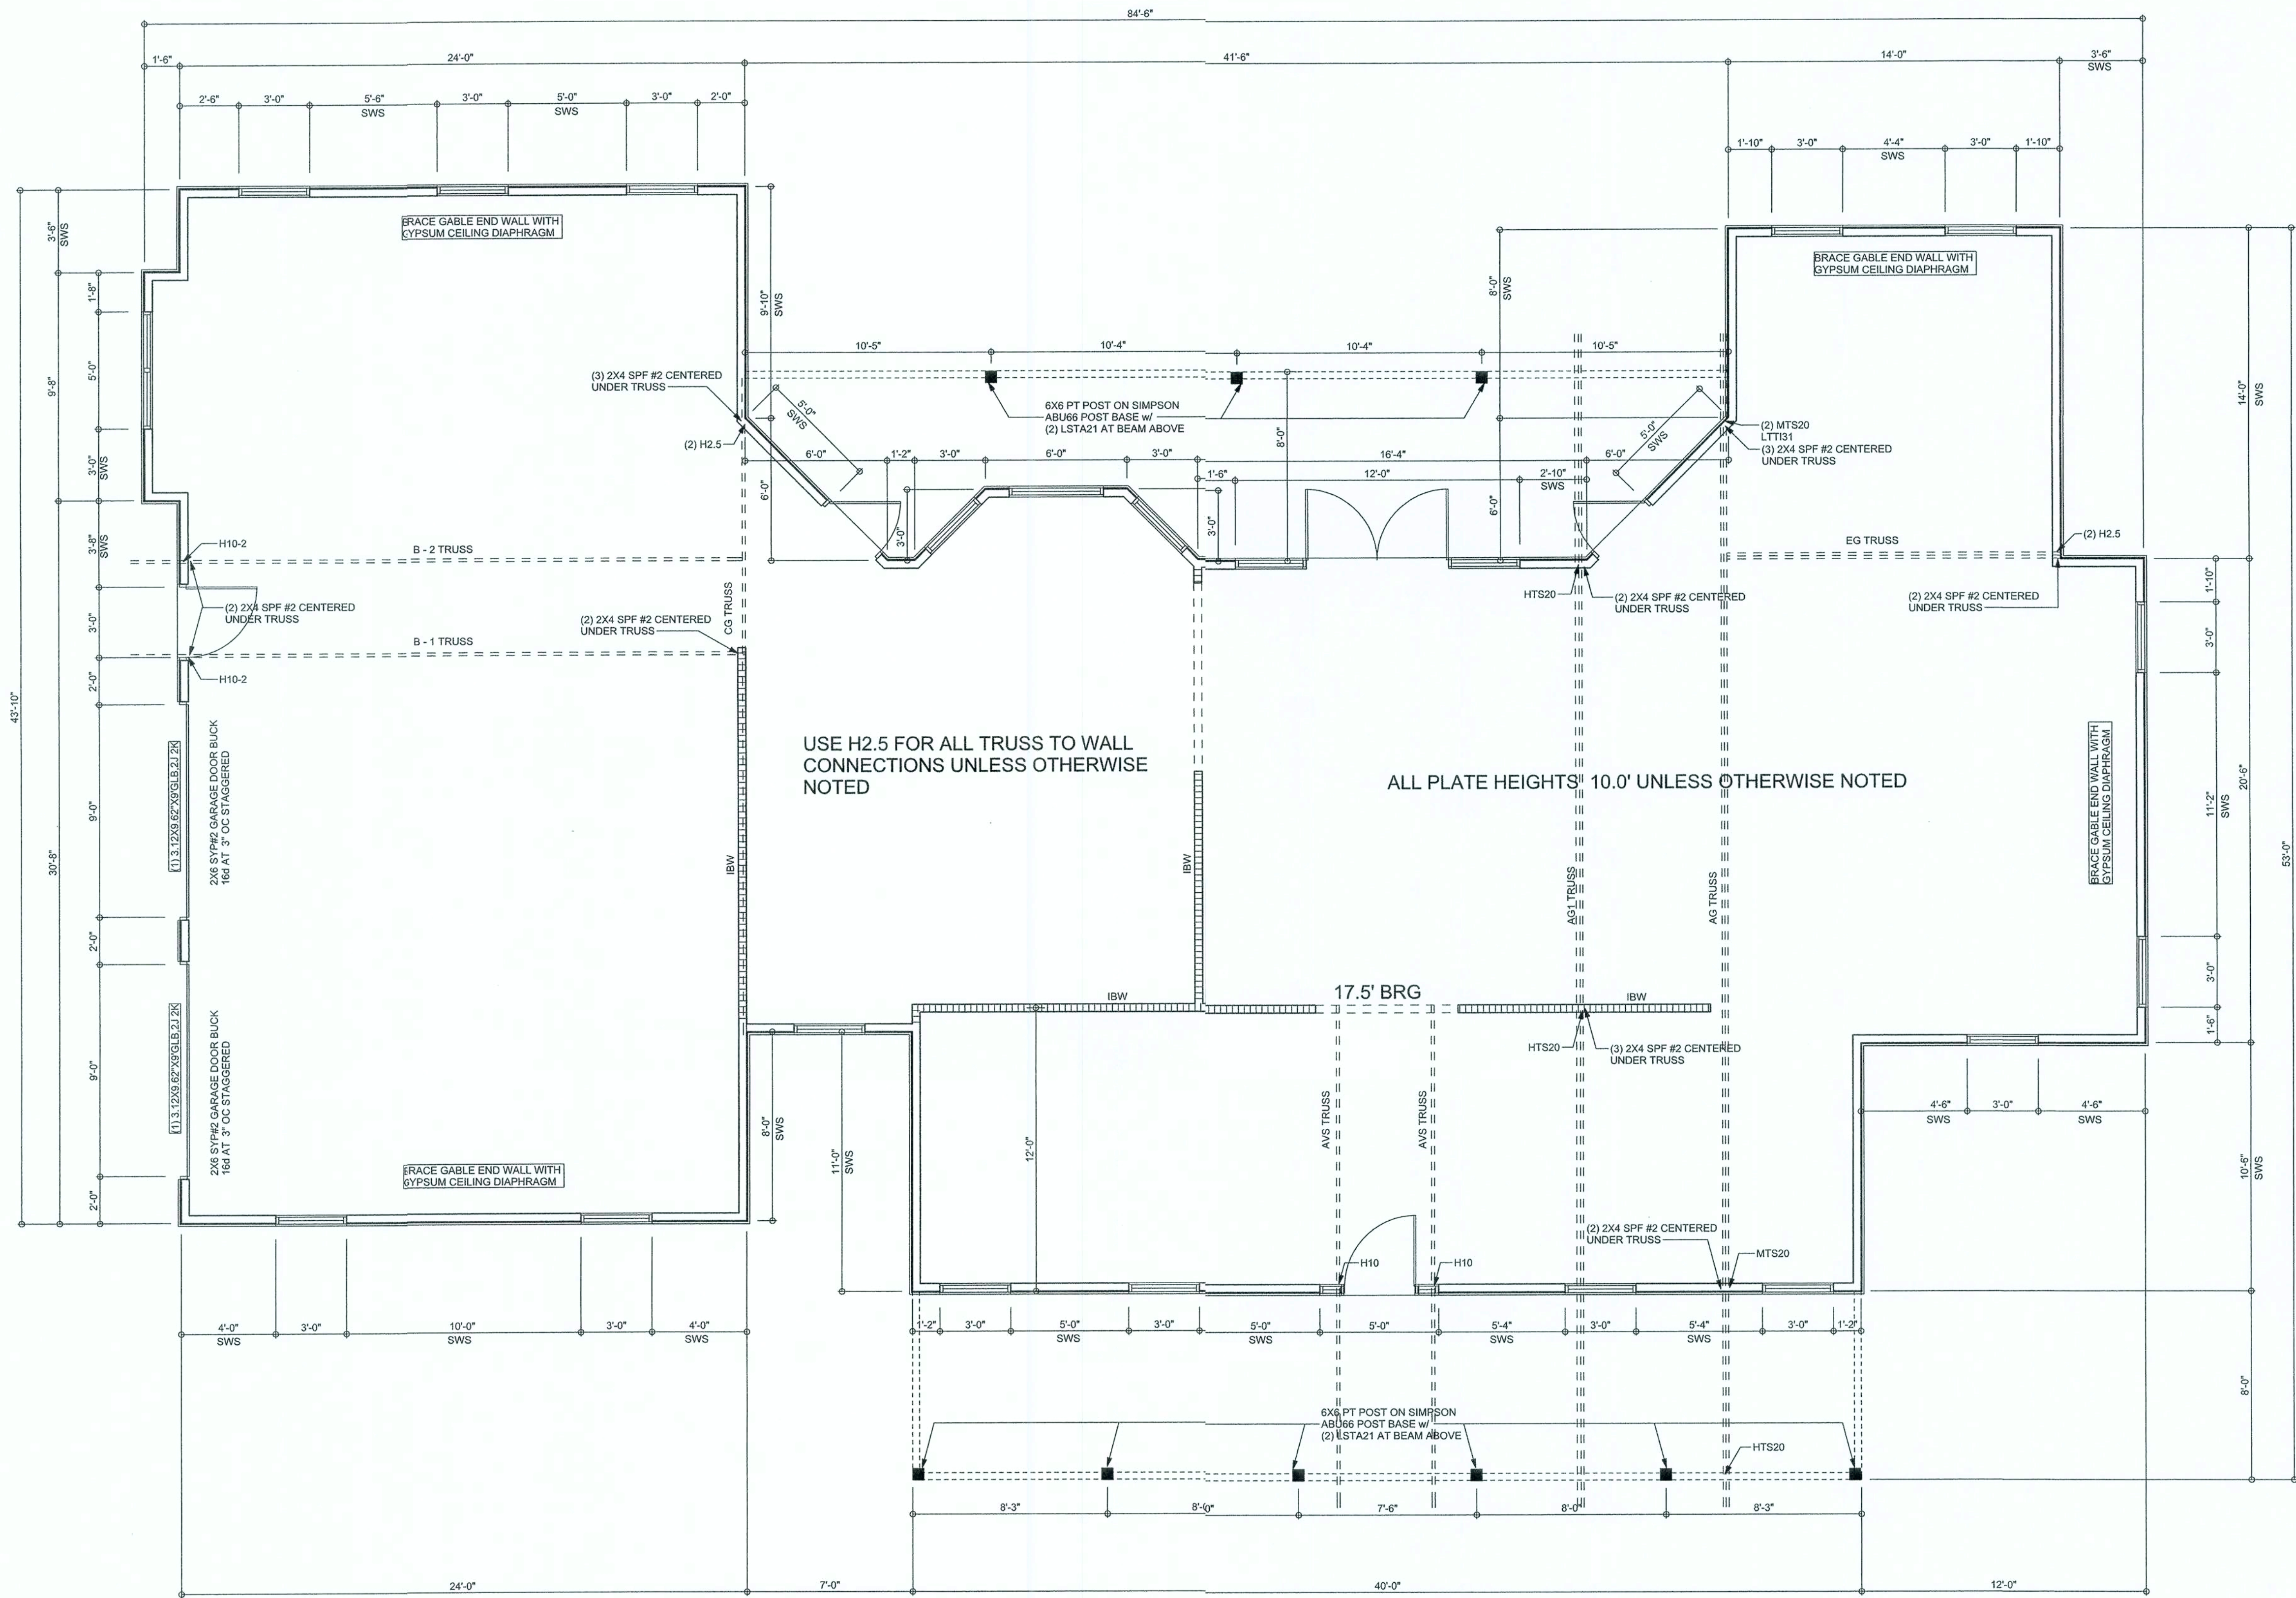

STRUCTURAL PLAN
SCALE: 1/4" = 1'-0"

- LEGEND
- (2) 2X10X8' @ 12' - HEADER/BEAM CALL-OUT
 - (2) 2X10X8' @ 12' - NUMBER OF JACK STUDS (FULL LENGTH)
 - (2) 2X10X8' @ 12' - NUMBER OF JACK STUDS (UNDER HEADER)
 - (2) 2X10X8' @ 12' - SPAN OF HEADER
 - (2) 2X10X8' @ 12' - SIZE OF HEADER MATERIAL
 - (2) 2X10X8' @ 12' - NUMBER OF PLIES IN HEADER

SWS	7/16" O.S.B. WALL SHEATHING FULLY BLOCKED 8d COMMON NAILS 6" OC EDGE, 12" OC FIELD
IBW	NOTE: ALL LOAD BEARING HEADERS SHALL BE A MINIMUM OF (2) 2X10 SYP#2 (U.O.A.) DIMENSIONS ON STRUCTURAL SHEETS ARE NOT EXACT. REFER TO ARCHITECTURAL FLOOR PLAN FOR ACTUAL DIMENSIONS
	INTERIOR BEARING WALL WITH 1/2" WEDGE ANCHOR @48" OC & SP4 @ 32" OC

TOTAL SHEAR WALL SEGMENTS

	REQUIRED	ACTUAL
TRANSVERSE	21.0'	87.6'
LONGITUDINAL	22.1'	73.0'

CONNECTIONS, WALL, & HEADER DESIGN IS BASED
ON REACTIONS & UPLIFTS FROM TRUSS ENGINEERING
FURNISHED BY BUILDER. (ANDERSON TRUSS CO.
LAKE CITY, FLORIDA JOB-406, DATE 09/11/92)

REVISIONS

MARK DISOSWAY, P.E.
P.O. BOX 868, LAKE CITY, FL 32056
PHONE: (386) 754-5419 FAX: (386) 754-6749

GENE LESLIE RESIDENCE
ADDRESS: LOT #7 SOUTHPOINTE SUBDIVISION, COLUMBIA COUNTY, FLORIDA

I HEREBY CERTIFY
THAT I HAVE EXAMINED
THIS PLAN, AND THAT
THE APPLICABLE
PORTIONS OF THE
PLAN, RELATING TO WIND
ENGINEERING COMPLY
WITH SECTION 1606,
FLORIDA BUILDING
CODE 2001, TO THE BEST
OF MY KNOWLEDGE.


30 / SEP / 02

MARK DISOSWAY
P.E. 53915
Mark Disosway
30 SEP 02
SEAL

SHEET NAME
S - 2

JOB NUMBER
209271

MARK DISOSWAY, P.E. HEREBY EXPRESSLY RESERVES ITS COMMON LAW COPYRIGHTS AND PROPERTY RIGHTS. THIS DRAWING IS NOT TO BE REPRODUCED, ALTERED OR COPIED IN ANY FORM WITHOUT THE EXPRESS WRITTEN PERMISSION OF MARK DISOSWAY. STATED DIMENSIONS SUPERCEDE SCALED DIMENSIONS. REFER ALL QUESTIONS TO MARK DISOSWAY, P.E. FOR RESOLUTION. DO NOT PROCEED WITHOUT CLARIFICATION. THIS DRAWING IS NOT VALID FOR CONSTRUCTION UNLESS RAISED SEAL IS AFFIXED.

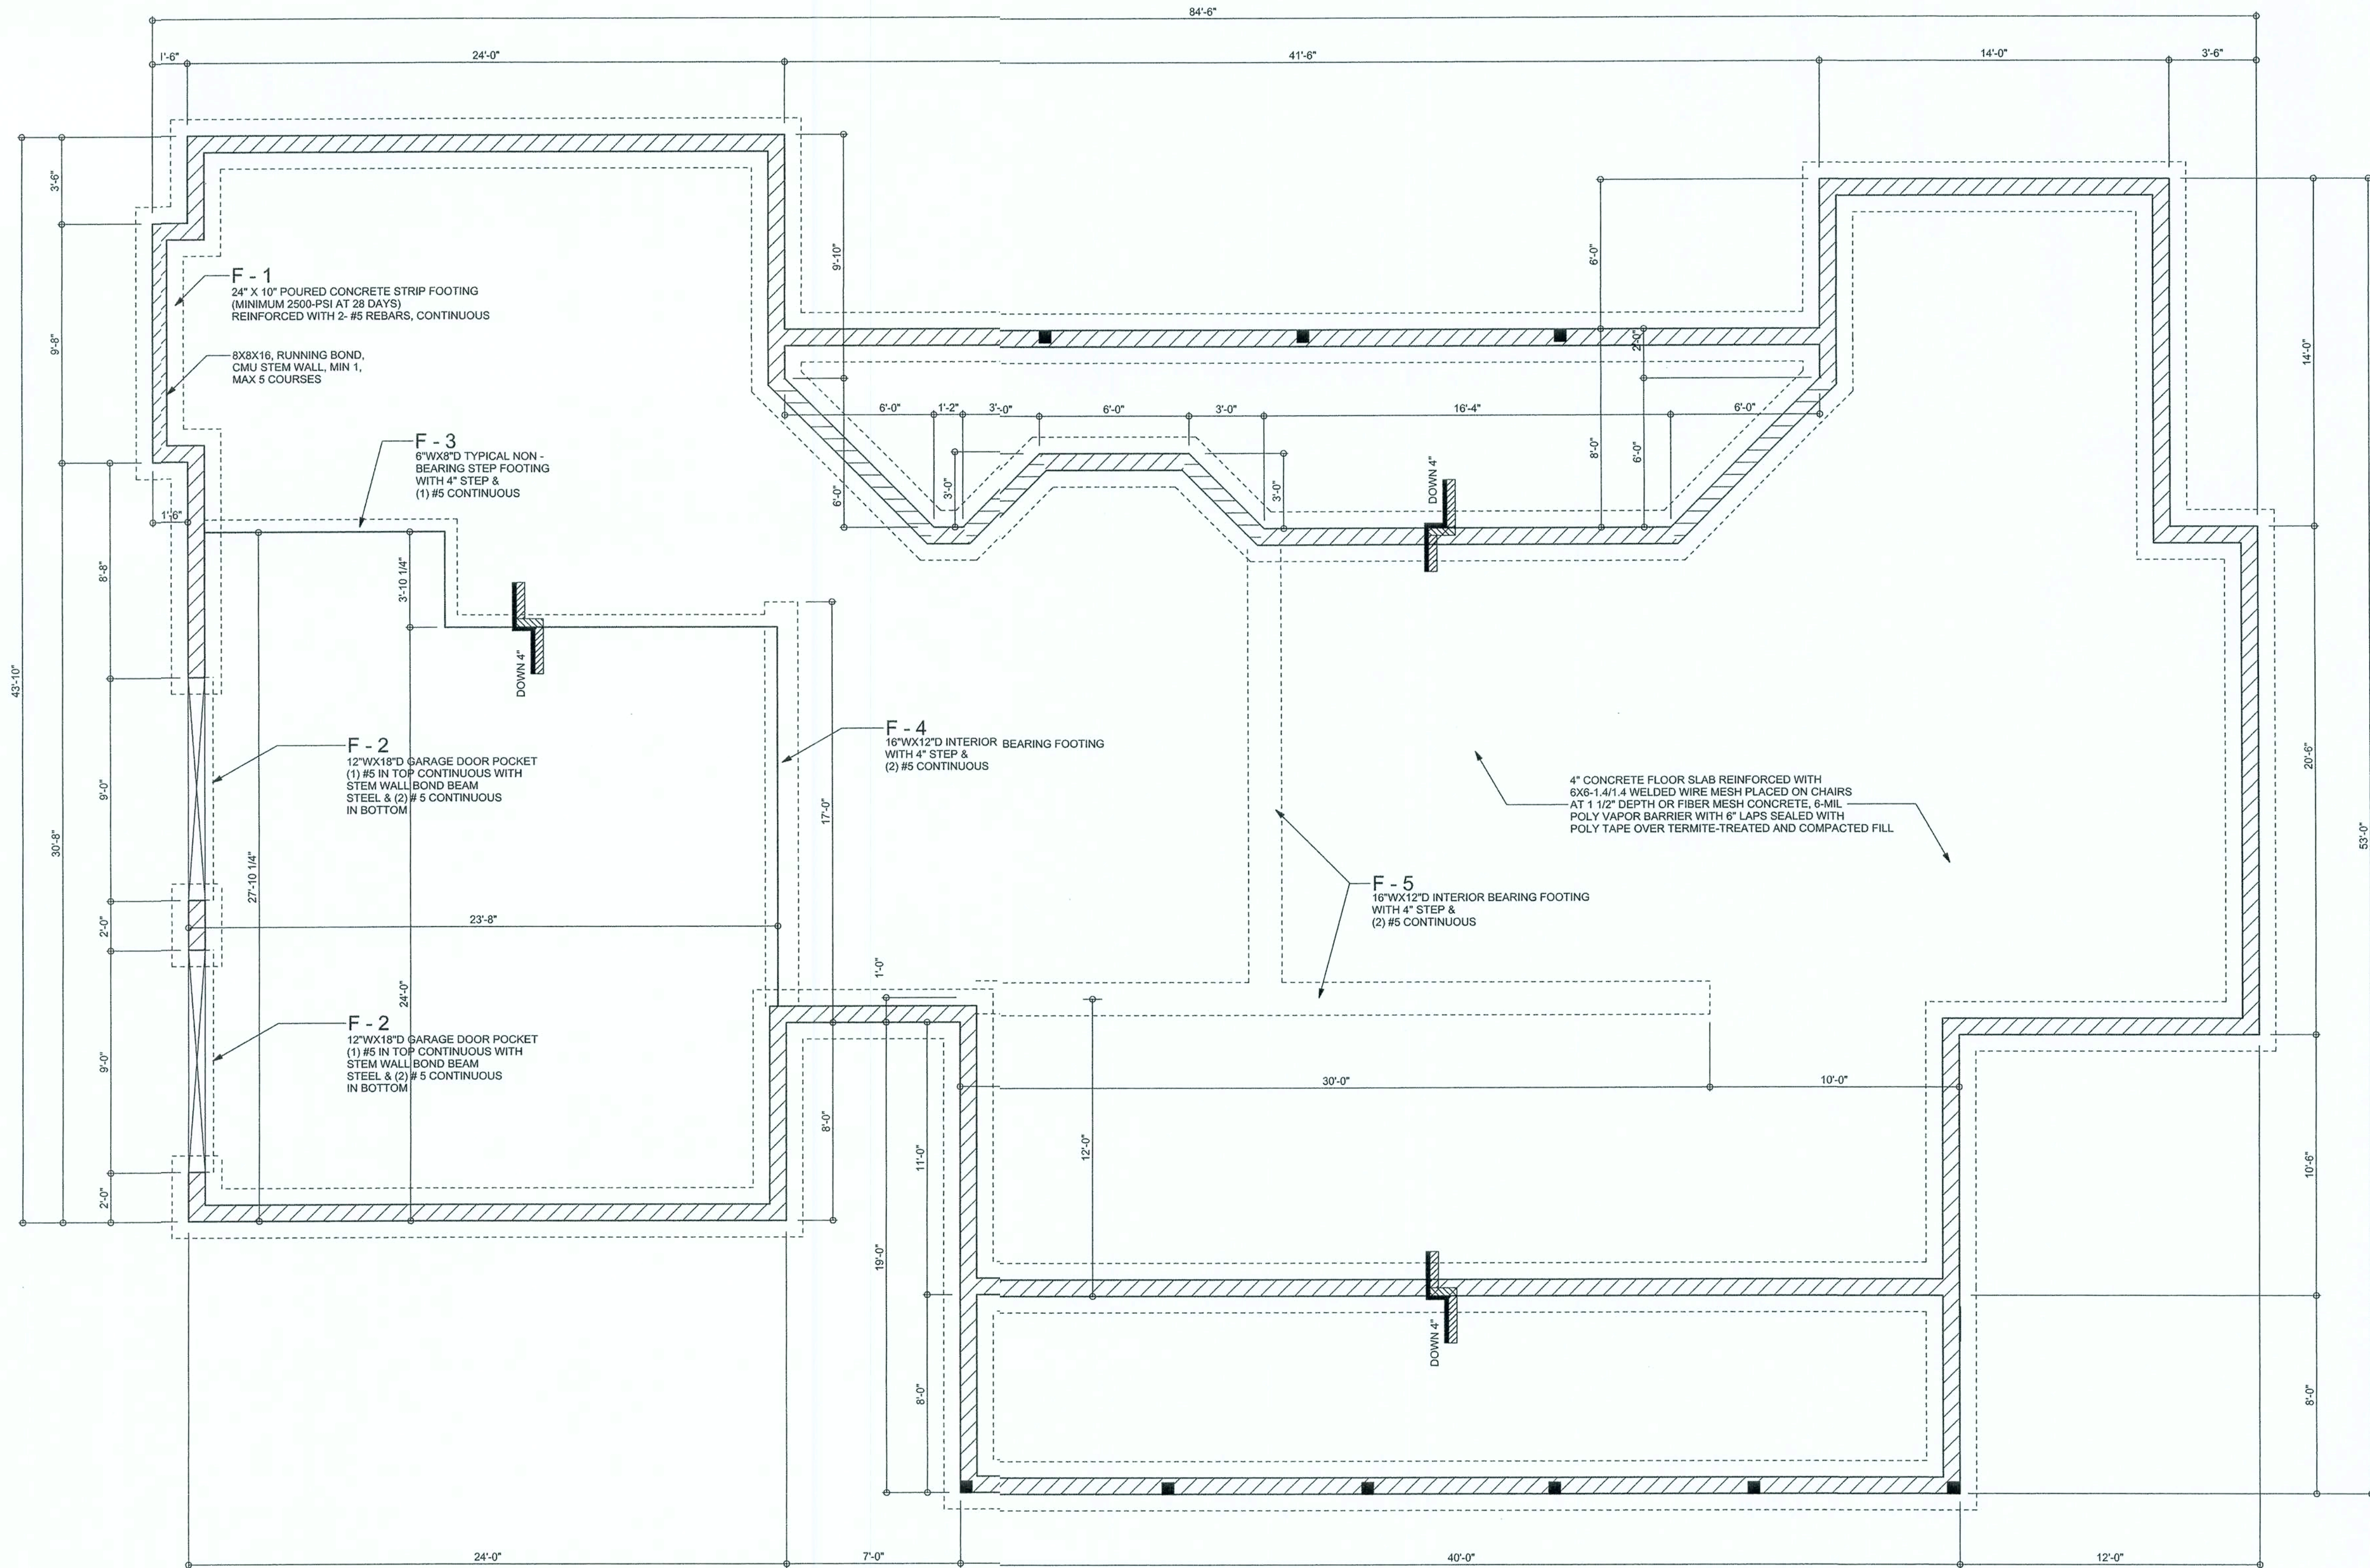

FOUNDATION PLAN
SCALE: 1/4" = 1'-0"

MARK DISOSWAY, P.E. HEREBY EXPRESSLY RESERVES ITS COMMON LAW COPYRIGHTS AND PROPERTY RIGHTS. THIS DRAWING IS NOT TO BE REPRODUCED, ALTERED OR COPIED IN ANY FORM WITHOUT THE EXPRESS WRITTEN PERMISSION OF MARK DISOSWAY. STATED DIMENSIONS SUPERCEDE SCALED DIMENSIONS. REFER ALL QUESTIONS TO MARK DISOSWAY, P.E. FOR RESOLUTION. DO NOT PROCEED WITHOUT CLARIFICATION. THIS DRAWING IS NOT VALID FOR CONSTRUCTION UNLESS RAISED SEAL IS AFFIXED.

REVISIONS

MARK DISOSWAY, P.E.
P.O. BOX 868, LAKE CITY, FL 32056
PHONE: (386) 754-5419 FAX: (386) 754-6749

GENE LESLIE RESIDENCE

ADDRESS: LOT #7 SOUTHPOINTE SUBDIVISION, COLUMBIA COUNTY, FLORIDA

I HEREBY CERTIFY THAT I HAVE EXAMINED THIS PLAN, AND THAT THE APPLICABLE PORTIONS OF THE PLAN, RELATING TO WIND ENGINEERING COMPLY WITH SECTION 1606, FLORIDA BUILDING CODE 2001, TO THE BEST OF MY KNOWLEDGE.

30 / SEP / 02

MARK DISOSWAY
P.E. 53915
Mark Disosway
30 SEP 02
SEAL

SHEET NAME
S - 3

JOB NUMBER
209271