



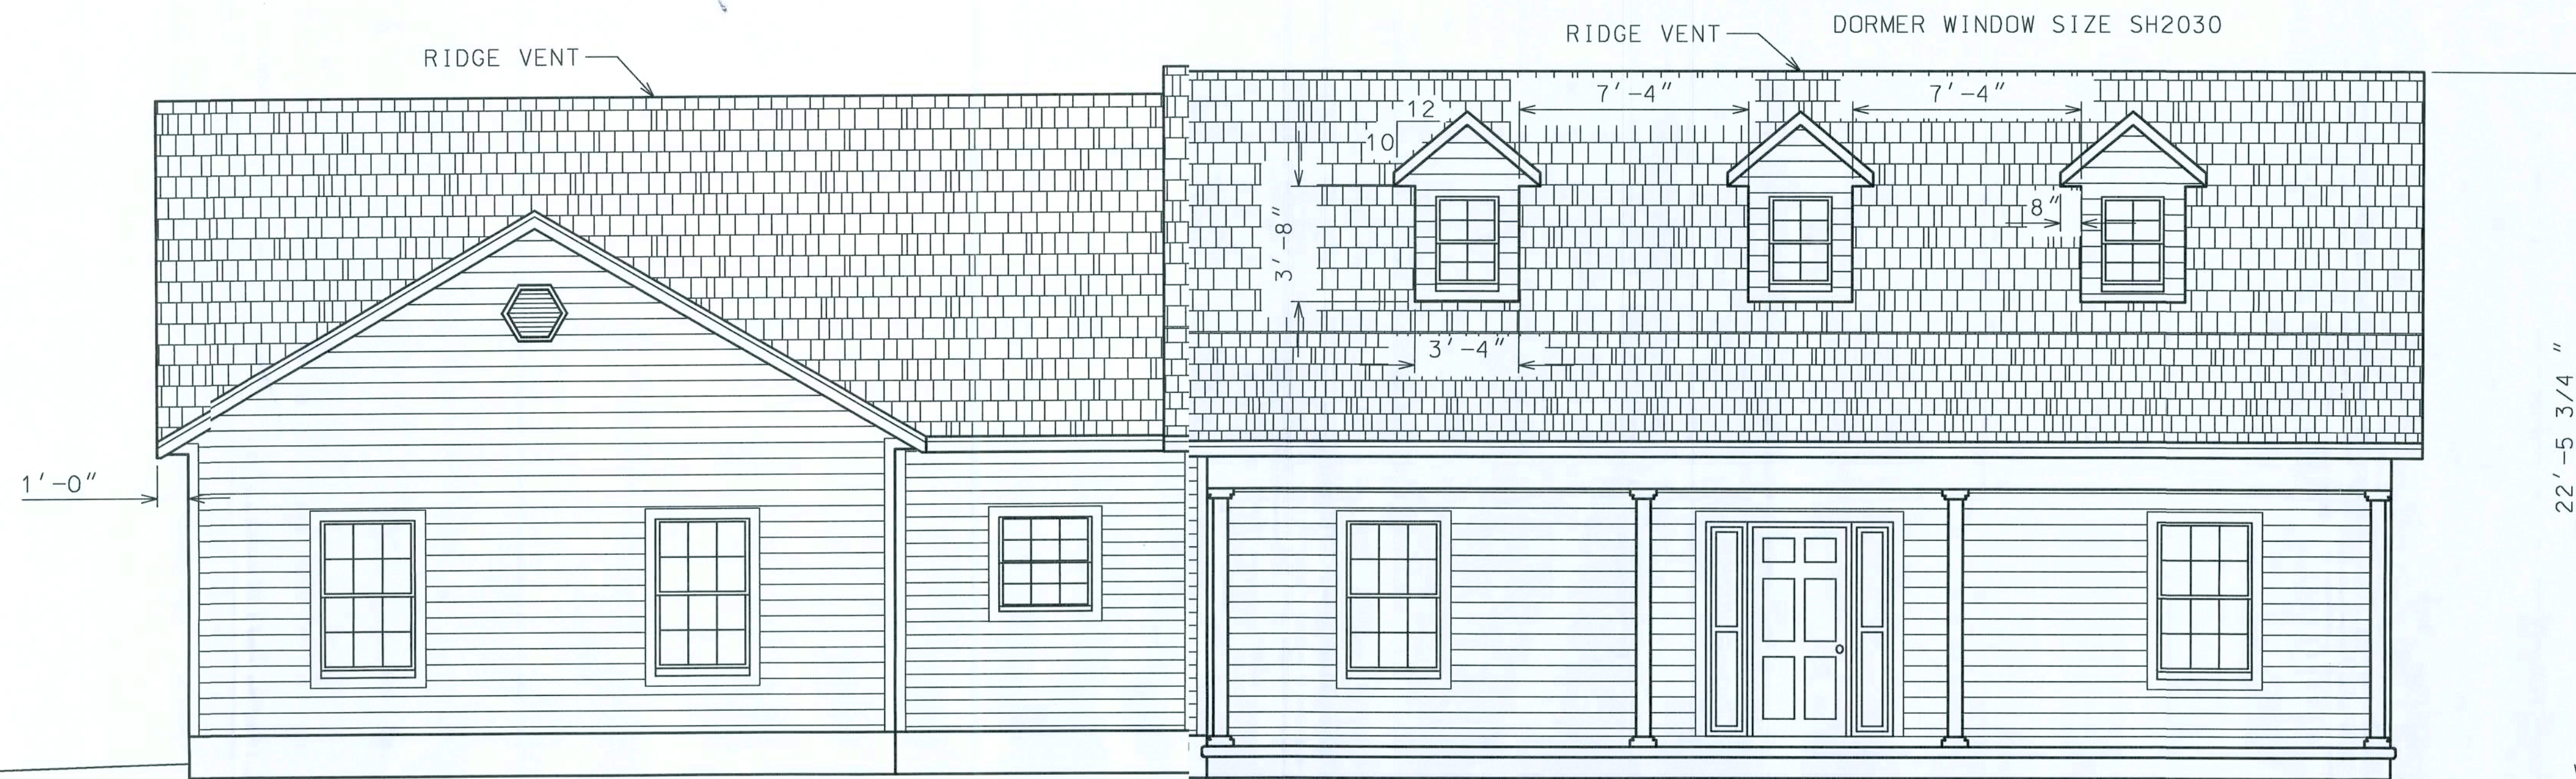

FRONT ELEVATION

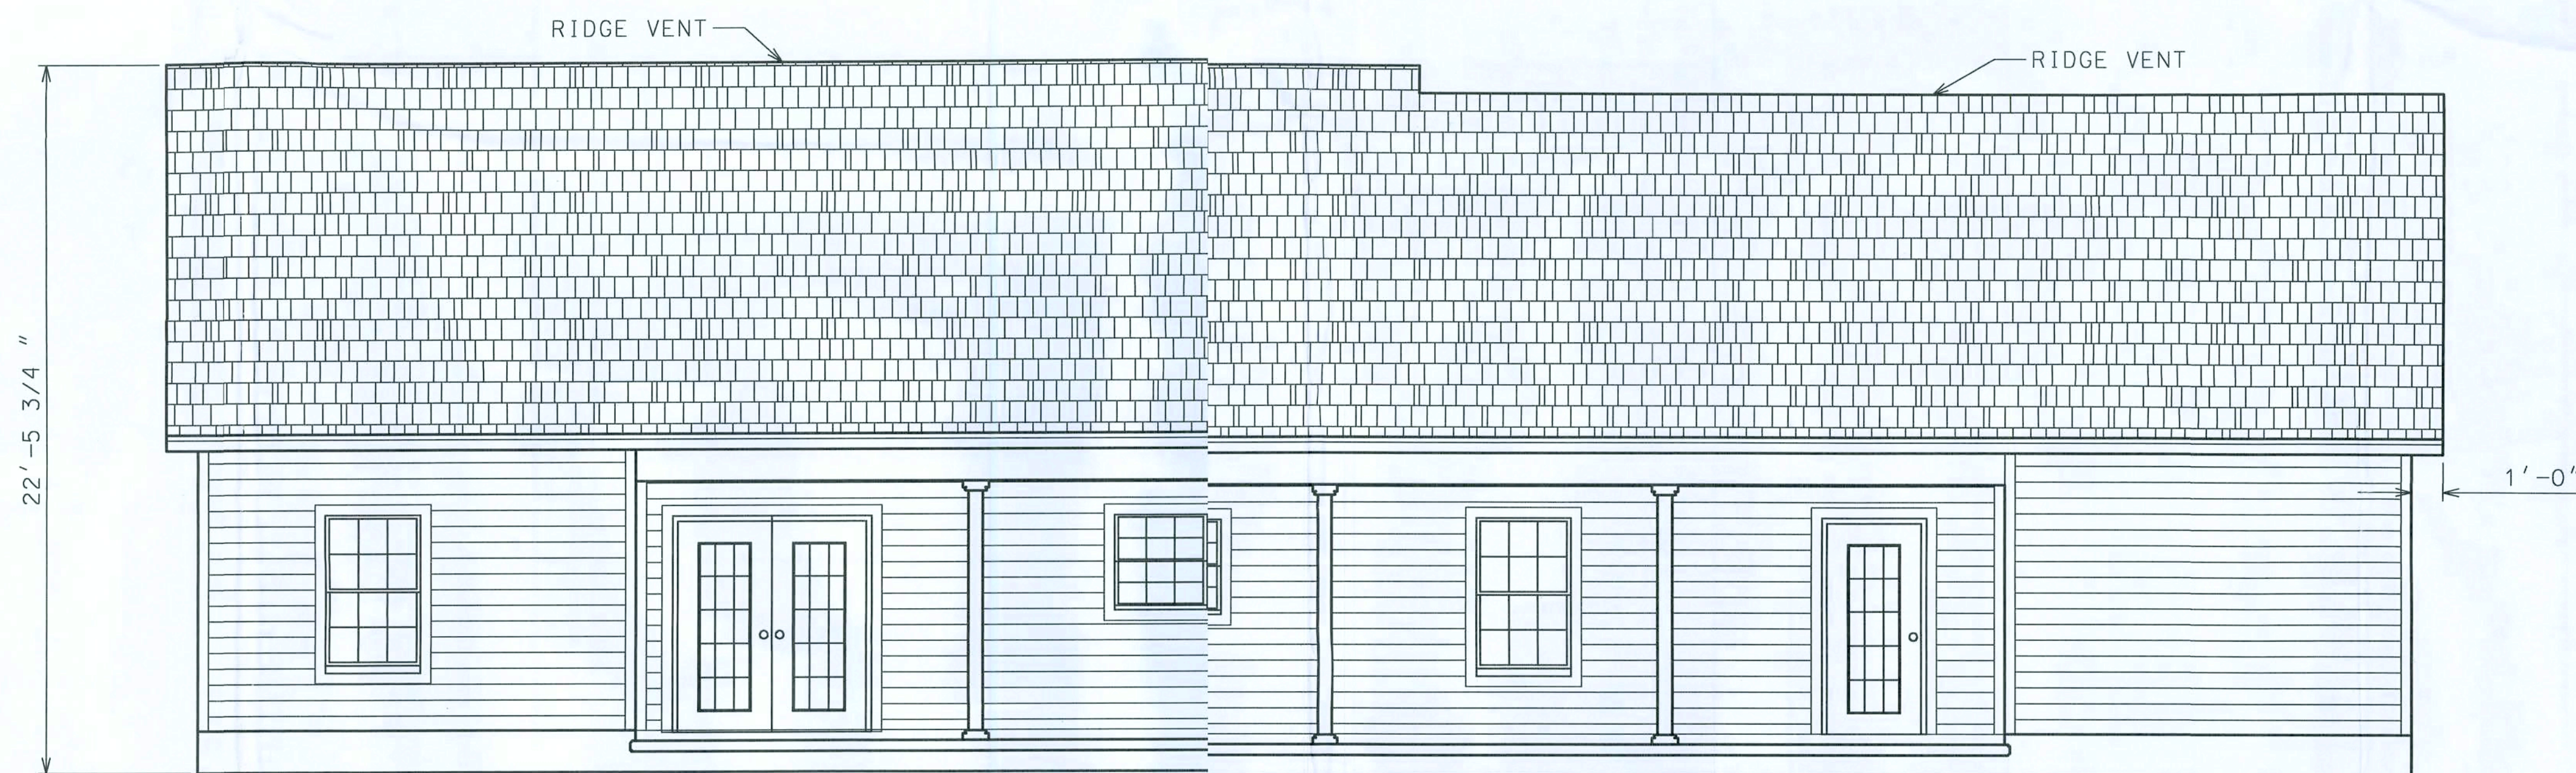

REAR ELEVATION

KNIGHT RESIDENT

THESE DRAWINGS, AS INSTRUMENTS OF SERVICE, ARE THE SOLE PROPERTY OF HAYGOOD HOMES, INC., AND ARE MAY NOT BE USED, COPIED OR REPRODUCED IN WHOLE OR IN PART FOR USE ON OR INCORPORATED WITHIN ANY OTHER JOB WITHOL' SPECIFIC AND INDIVIDUAL AUTHORIZATION BY HAYGOOD HOMES, INC..



HAYGOOD HOMES INC.


12592 So. U.S. HWY 441
LAKE CITY FL. 32025
OFFICE (386) 752-3496
MOBILE (386) 303-1981
CR-C1326715

Jeff & Christina Knight


Lake City Florida

ELEVATION

PLAN No.	SCALE	DATE	SHEET NO.
P 0901	1/4" = 1'	5/03/09	1

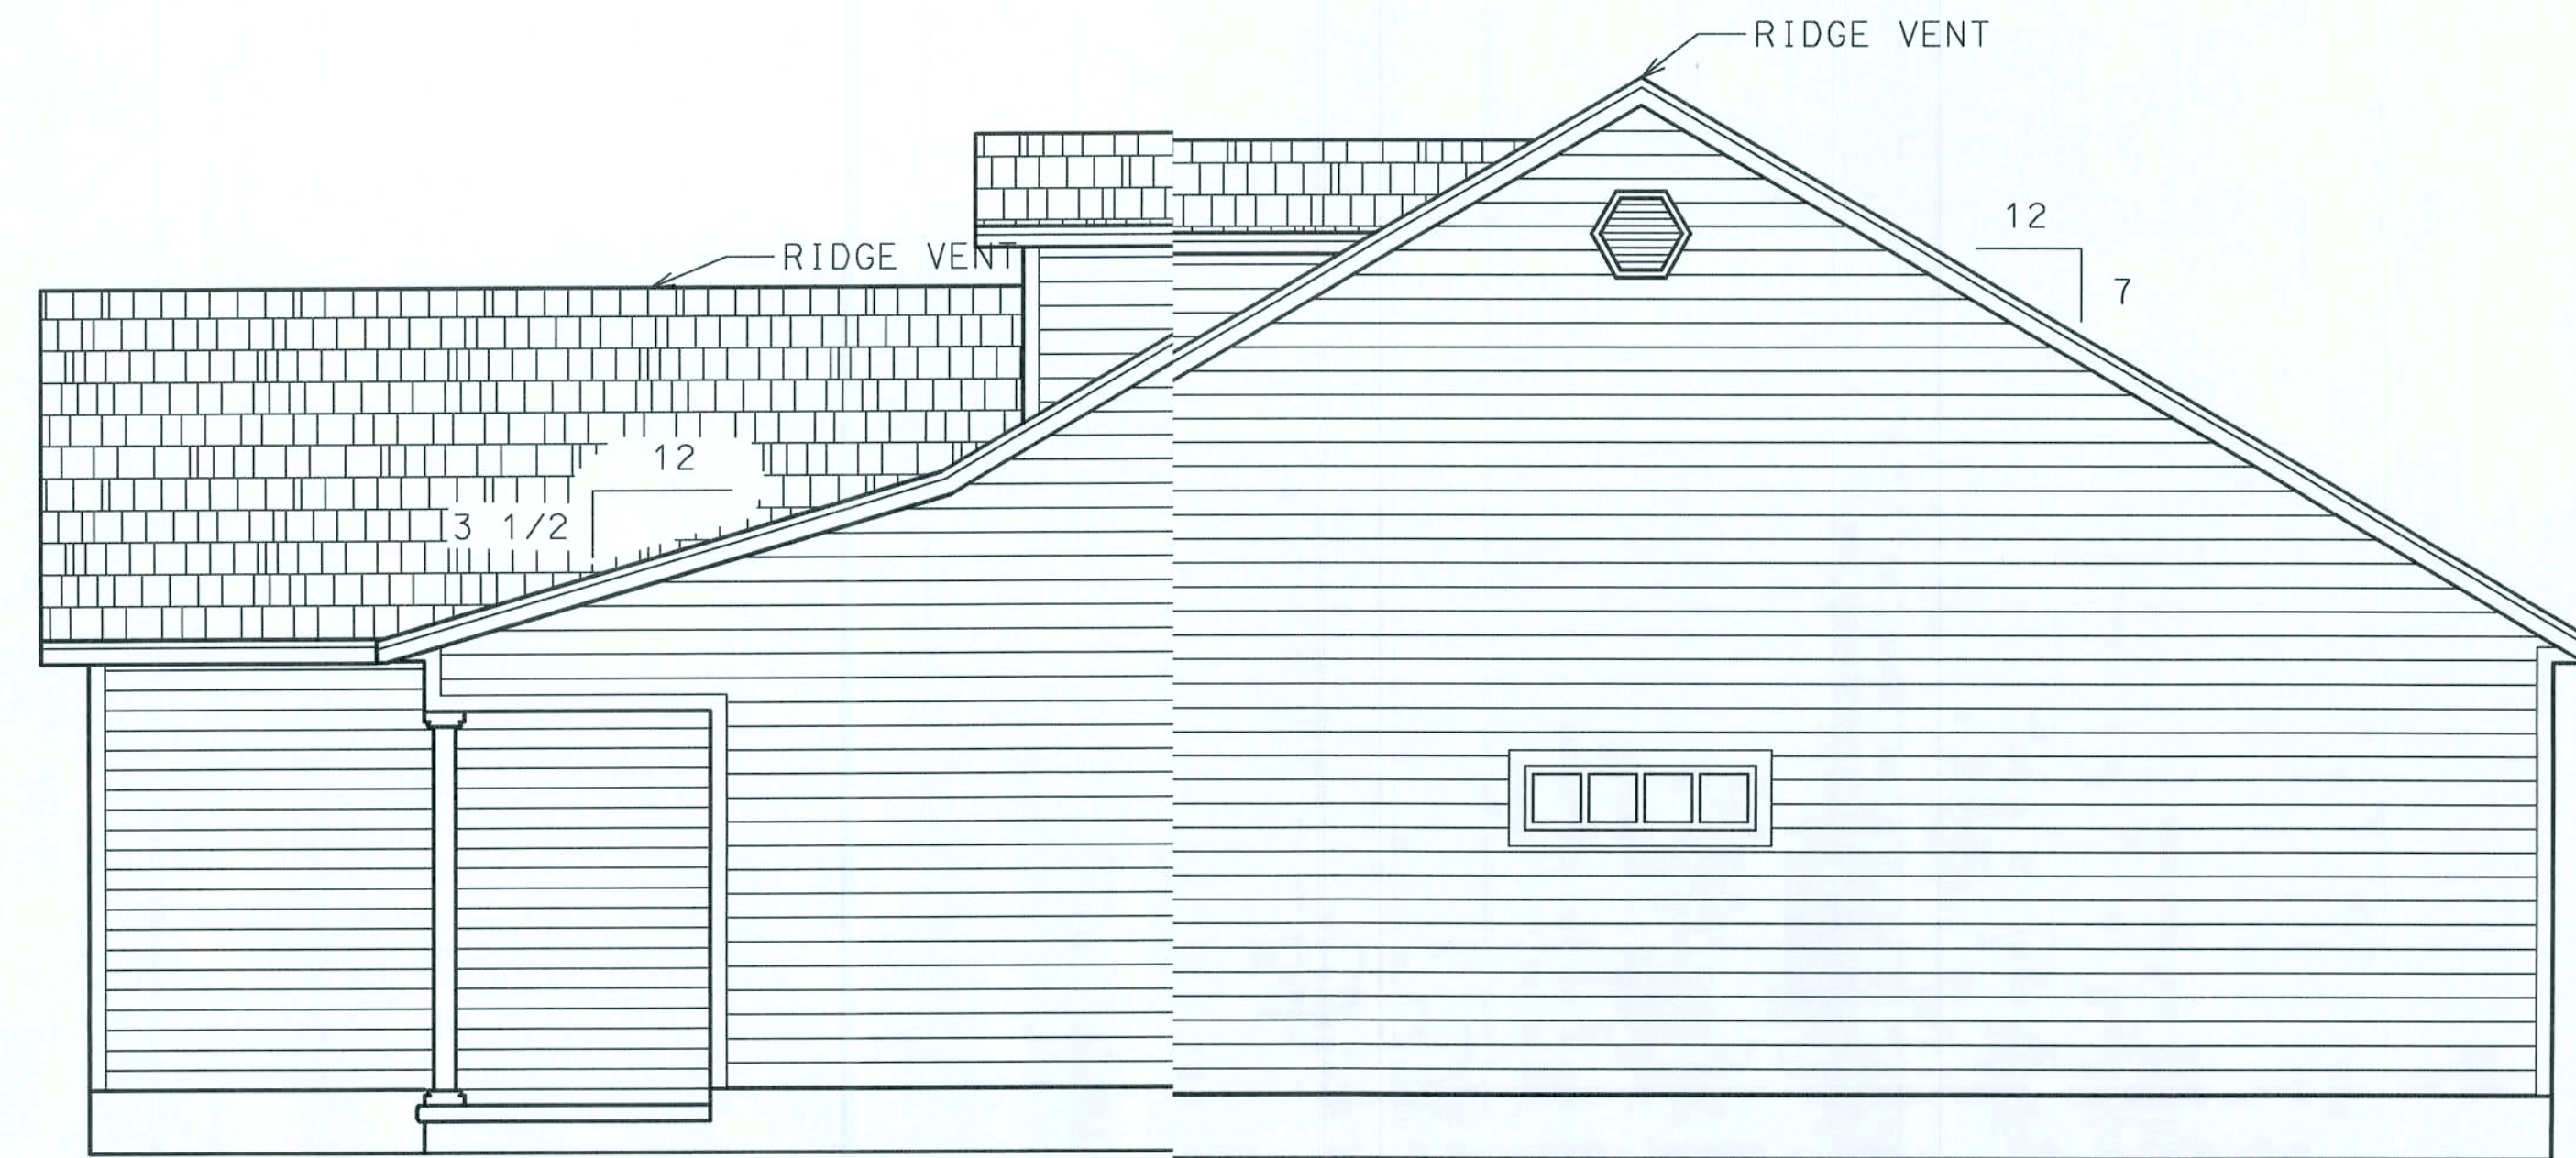

RIGHT ELEVATION

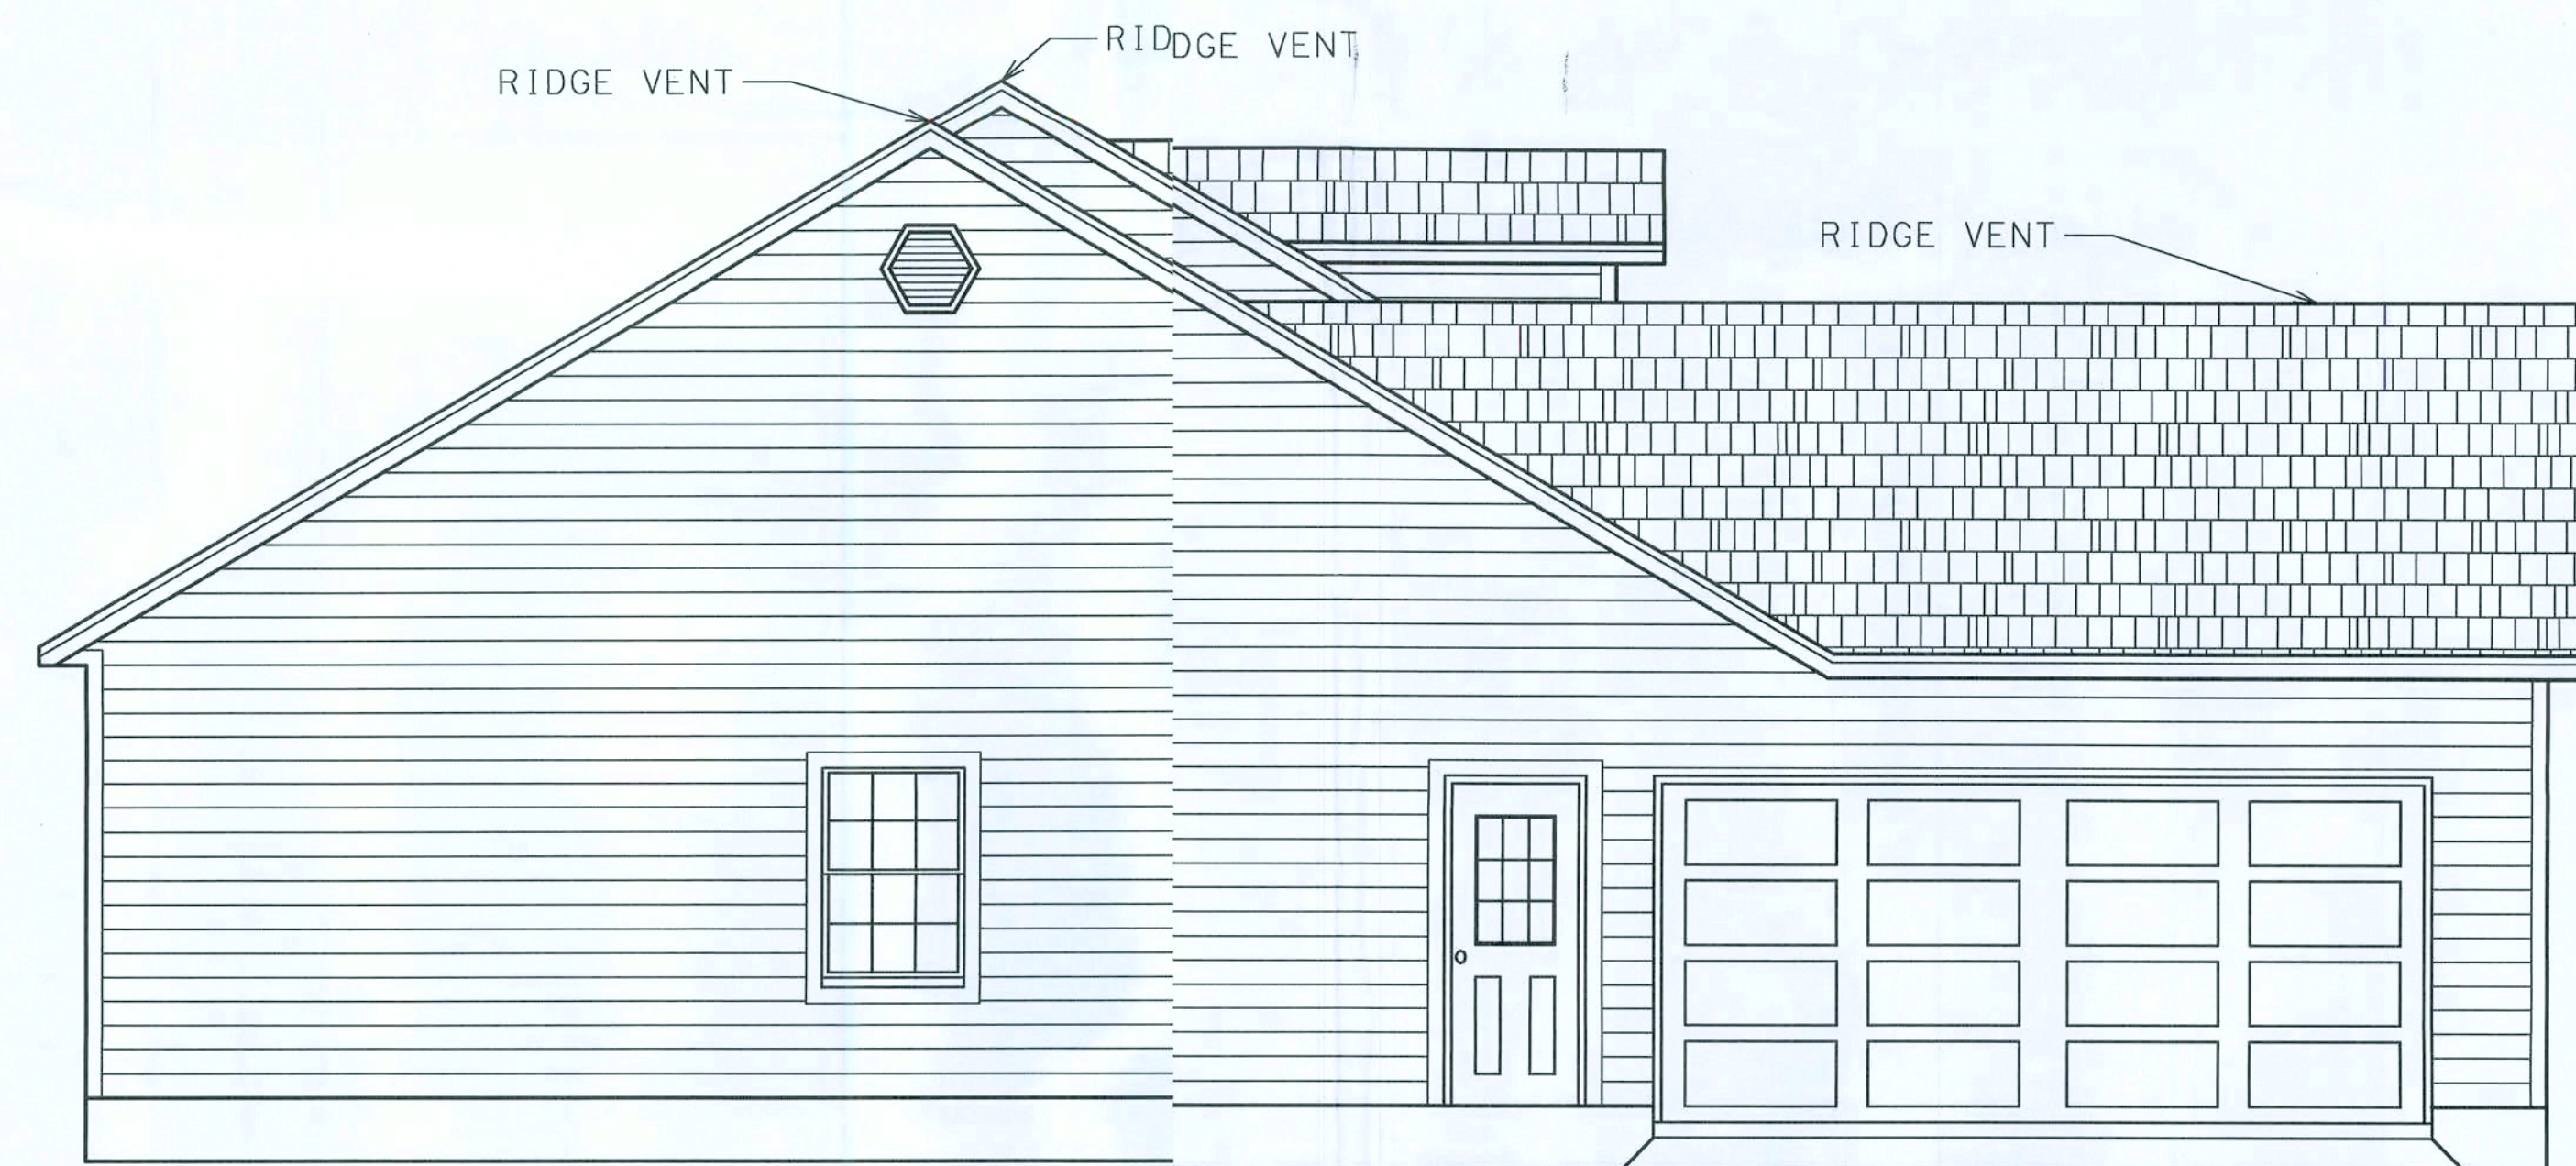

LEFT ELEVATION

THESE DRAWINGS, AS INSTRUMENTS OF SERVICE, ARE THE SOLE PROPERTY OF HAYGOOD HOMES, INC., AND ARE MAY NOT BE USED, COPIED OR REPRODUCED IN WHOLE OR IN PART FOR USE ON OR INCORPORATED WITHIN ANY OTHER JOB WITHOU SPECIFIC AND INDIVIDUAL AUTHORIZATION BY HAYGOOD HOMES, INC.,

Jeff & Christina Knight

Jeff & Christina Knight

Lake City Florida


ELEVATION



HAYGOOD HOMES INC.

12592 So. U.S. HWY 441
LAKE CITY FL 32025
OFFICE (386) 752-3496
MOBILE (386) 303-1981
CR-C1326715

PLAN No.	SCALE	DATE	SHEET NO.
P 0901	1/4" = 1'	5/03/09	2

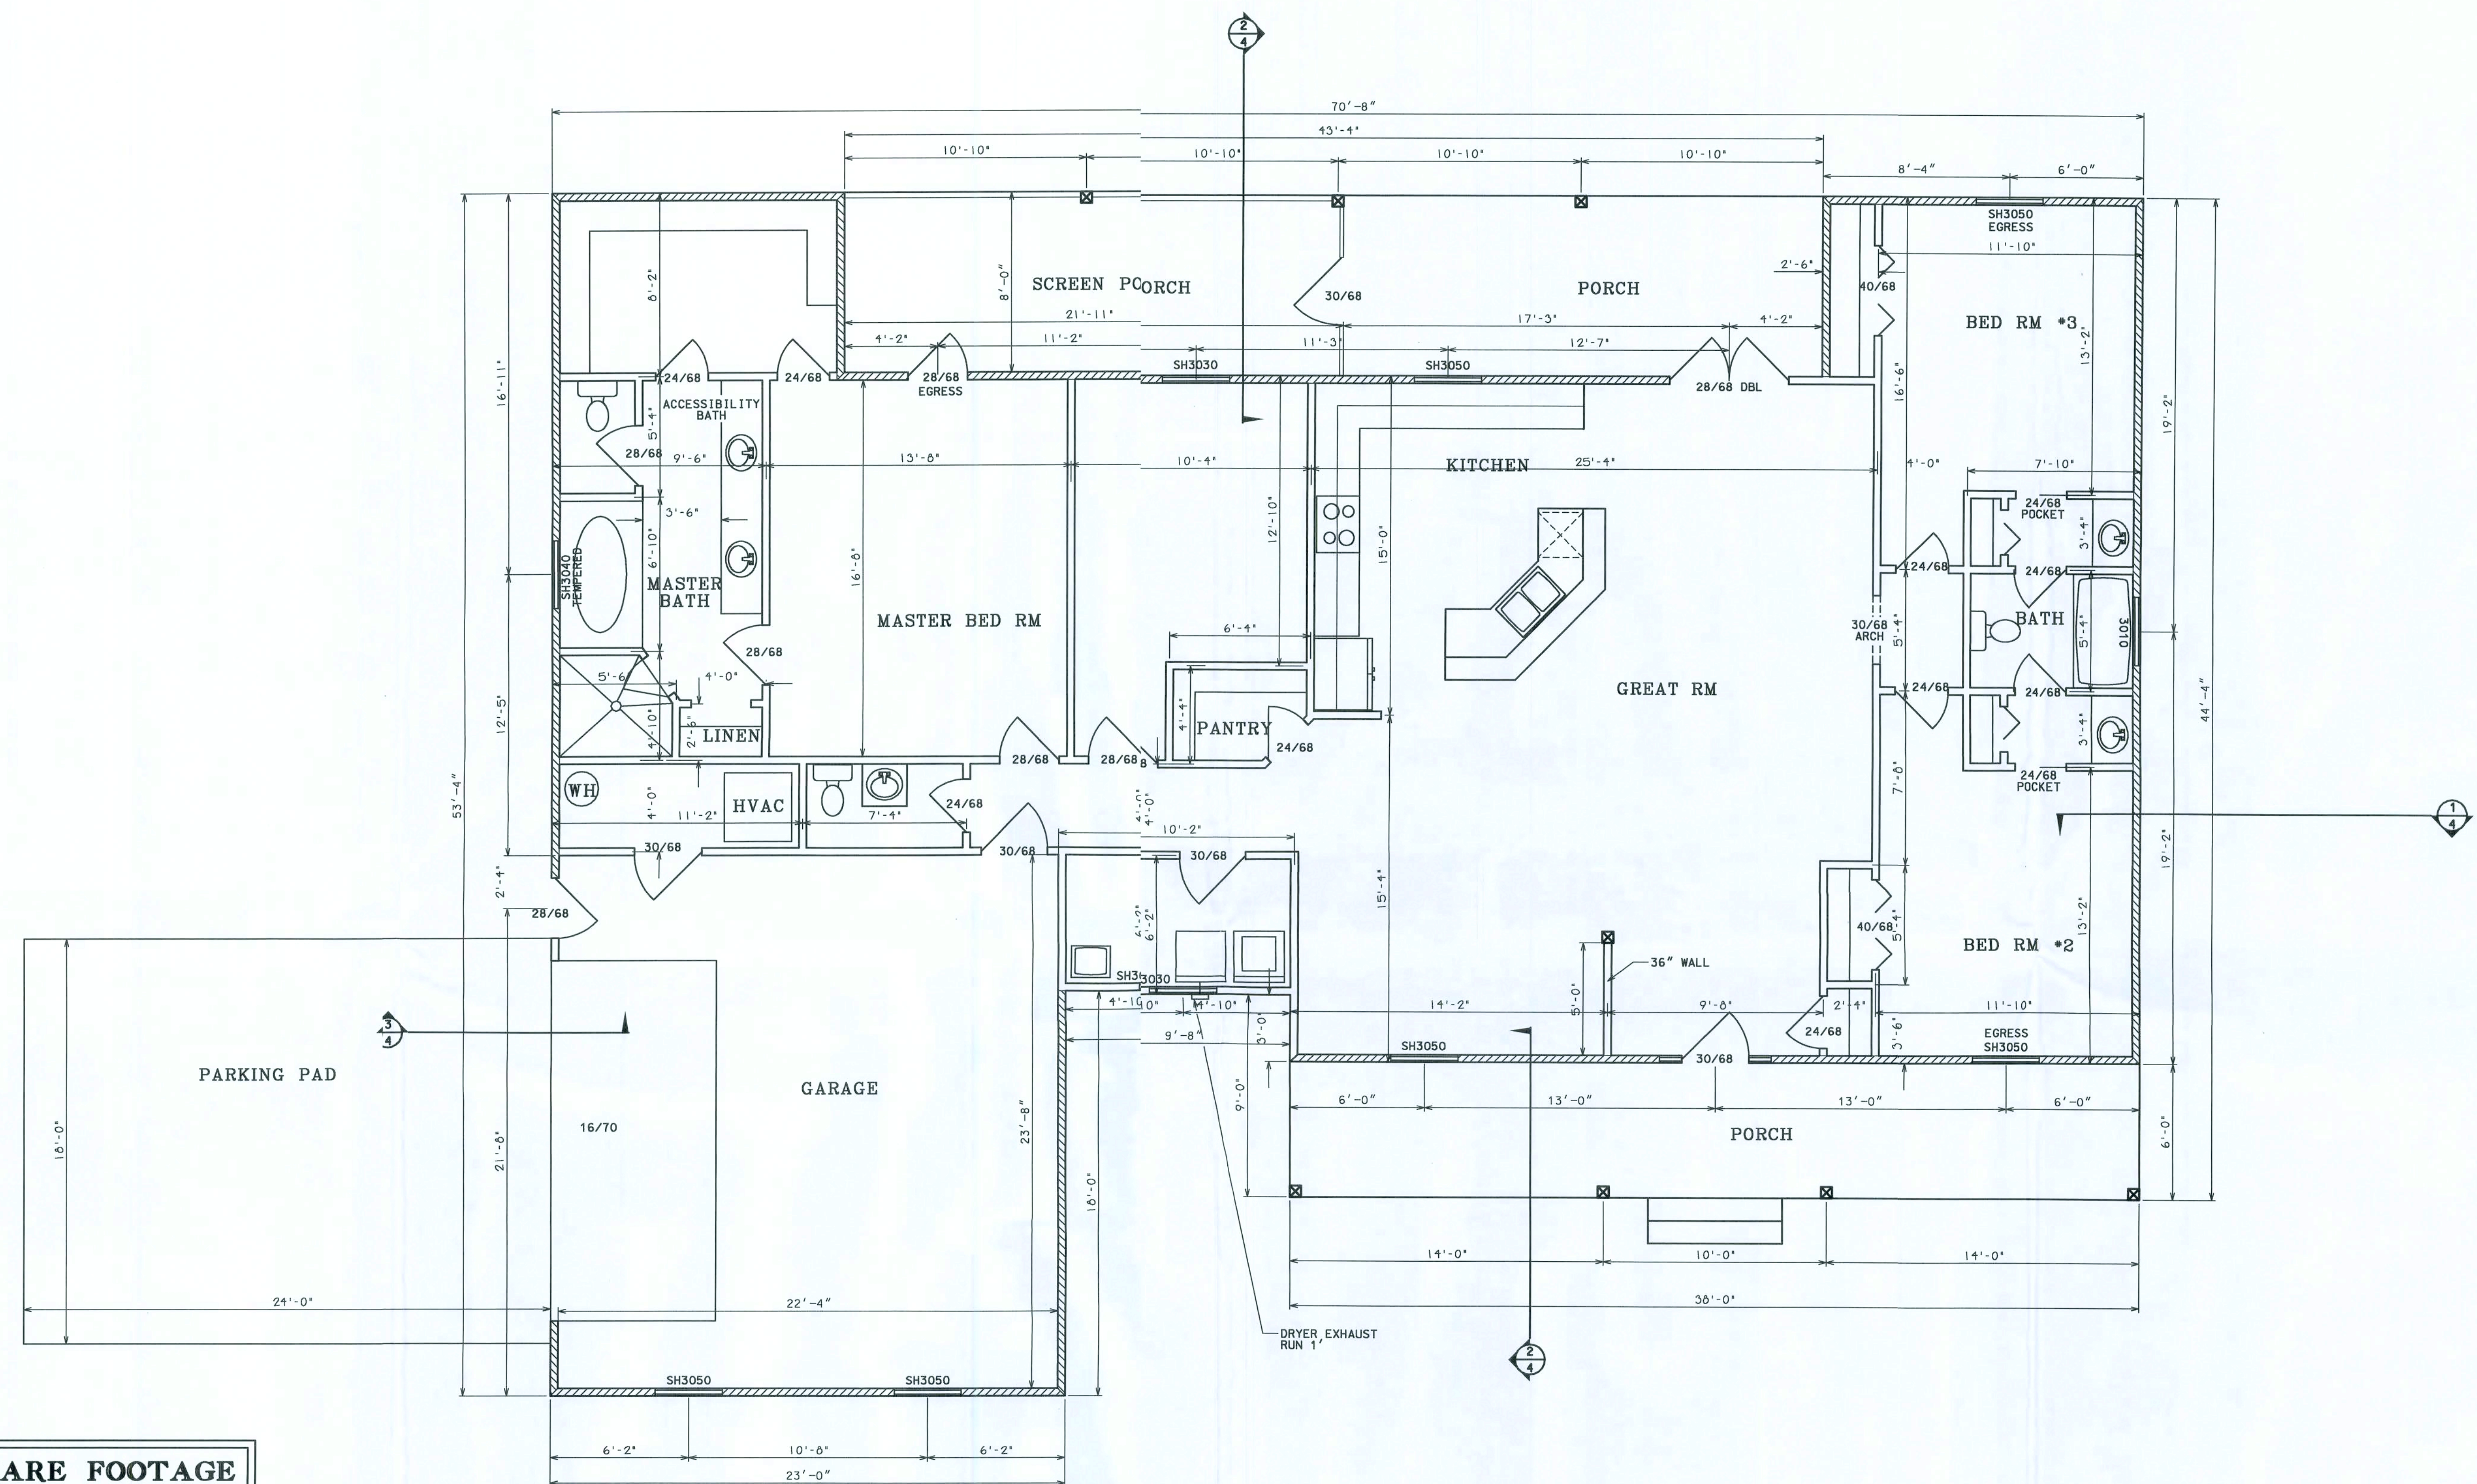

SQUARE FOOTAGE	
HEATED AREA	2081 SF
GARAGE	552 SF
PORCH	567 SF
TOTAL	3200 SF

THESE DRAWINGS, AS INSTRUMENTS OF SERVICE, ARE THE SOLE PROPERTY OF HAYGOOD HOMES, INC., AND ARE MAY NOT BE USED, COPIED OR REPRODUCED IN WHOLE OR IN PART FOR USE ON OR INCORPORATED WITHIN ANY OTHER JOI WITHOUT SPECIFIC AND INDIVIDUAL AUTHORIZATION BY HAYGOOD HOMES, INC.,

Jeff & Christina Knight



HAYGOOD HOMES INC.

12592 So. U.S. HWY 441
LAKE CITY FL 32025
OFFICE (386) 752-3496
MOBILE (386) 303-1981
CR-C1326715


Jeff & Christina Knight

Lake City Florida



FLOOR PLAN

PLAN No.	SCALE	DATE	SHEET NO.
P 0901	1/4" = 1'	3/1/09	3



...\\Projects\\Knight\\Floorplan.dgn 7/7/2009 9:15:21 PM

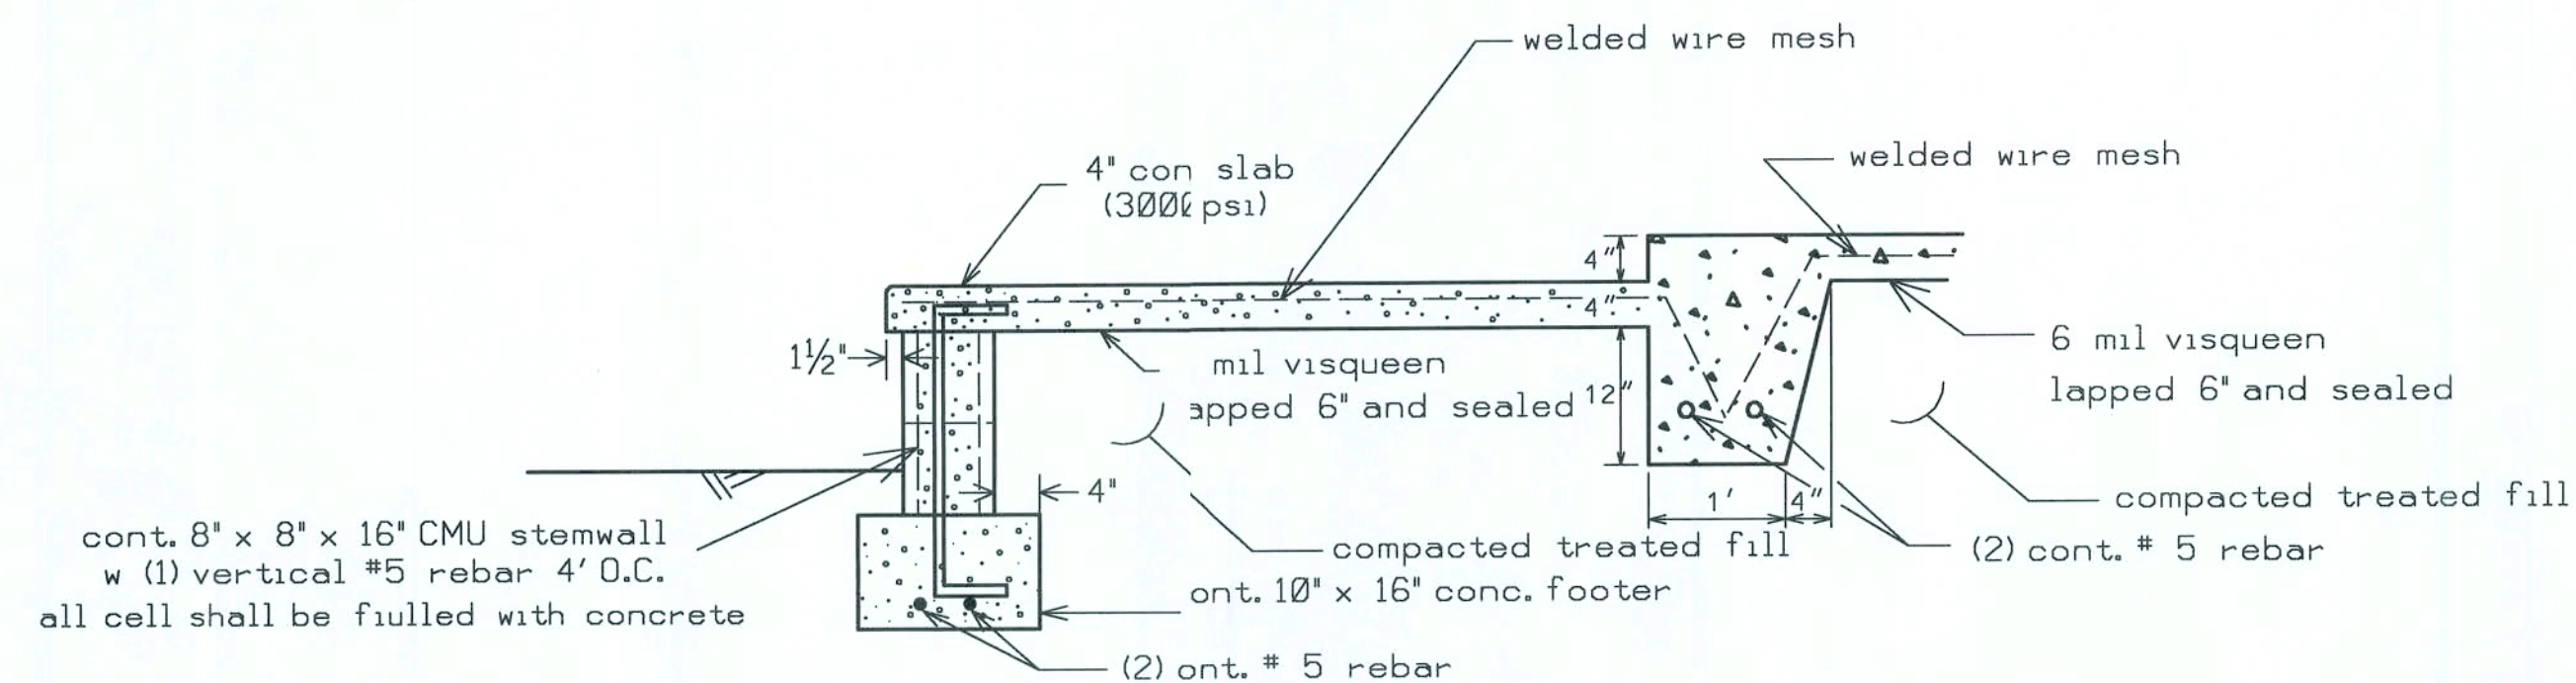

PORCH FOUNDATION (N.T.S.)

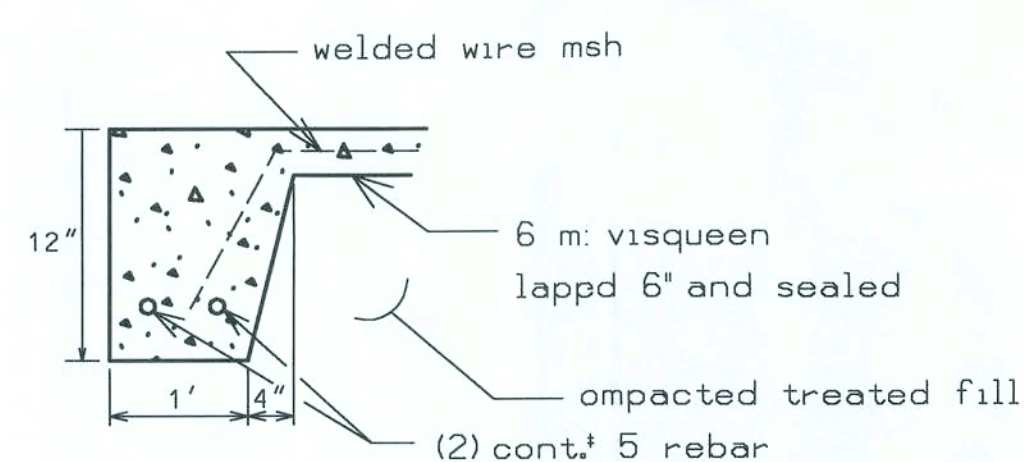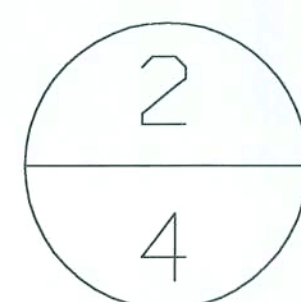

GARAGE DOOR FOUNDATION (N.T.S.)

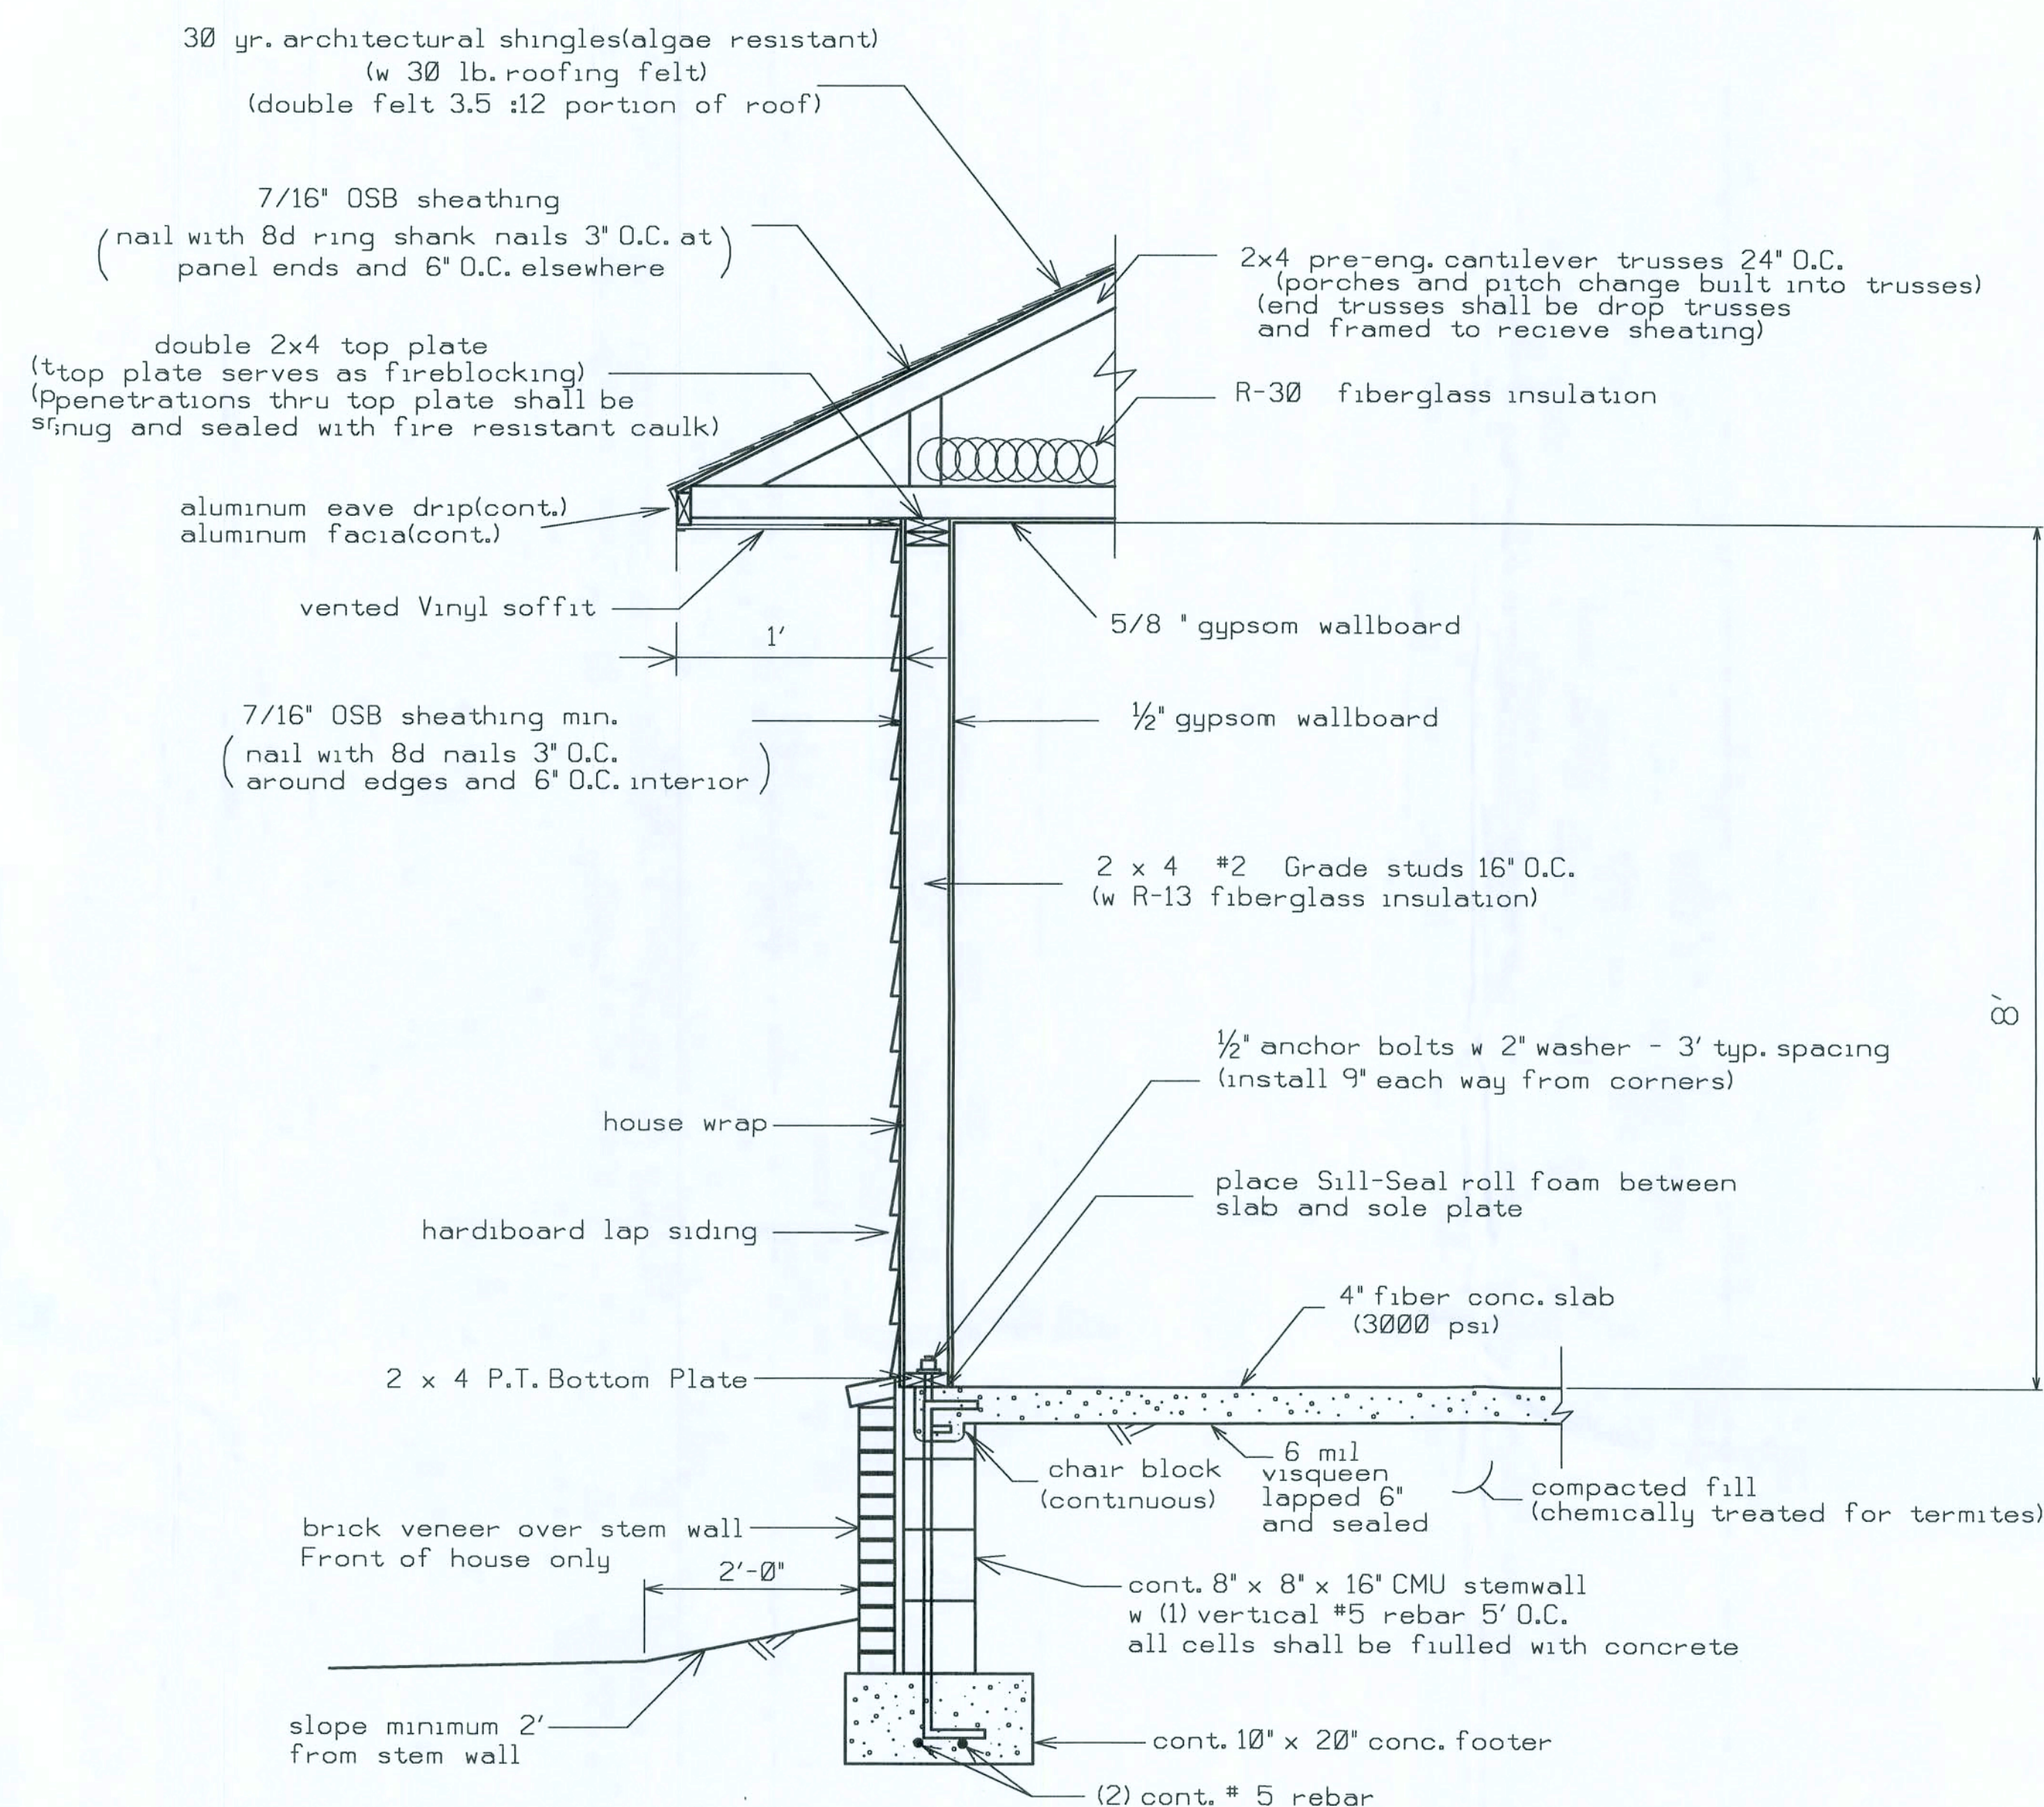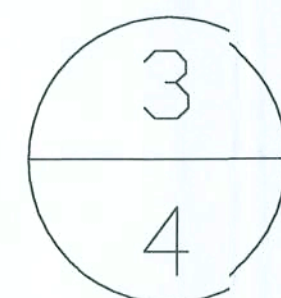


HEADER SIZES/MATERIAL SHALL BE AS FOLLOWS:

WINDOW AND DOOR OPENINGS (2 - #2 SYP 2X12's with 1/2\"/>

FOOTER DESIGN 1000 PSF

WALL DETAIL (TYP.) (N.T.S.)

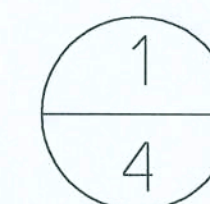

NOTE: See attached Wind Load Analysis Requirements for nailing patterns, Strapping and anchor Requirements, Gable end bracing requirements, Foundation requirements, and Header requirements.

THESE DRAWINGS, AS INSTRUMENTS OF SERVICE, ARE THE SOLE PROPERTY OF HAYGOOD HOMES, INC., AND ARE MAY NOT BE USED, COPIED OR REPRODUCED IN WHOLE OR IN PART FOR USE ON OR INCORPORATED WITHIN ANY OTHER JOB WITHOUT SPECIFIC AND INDIVIDUAL AUTHORIZATION BY HAYGOOD HOMES, INC..



HAYGOOD HOMES INC.

12592 So. U.S. HWY 441
LAKE CITY FL 32025
OFFICE (386) 752-3496
MOBILE (386) 303-1981
CR-C1326715

Jeff & Christina Knight

Lake City Florida


DETAILS

PLAN No.	SCALE	DATE	SHEET NO.
P 0901	1/4" = 1'	04/28/09	4

... Projects\Knight\DETAILS.dgn 7/7/2009 9:17:46 PM

MAIN OVERCURRENT PROTECTION DEVICE

-  - METER BASE
-  - VANITY LIGHT AS SPECIFIED
-  - LIGHT FIXTURE
-  - LIGHT FIXTURE
-  - SINGLE POLE SWITCH
-  - THREE-WAY SWITCH
-  - RECEPT.
-  - SECURITY LIGHT
-  - EXHAUST
-  - 220 V.
-  - SMOKE DETECTOR (AC/DC and interconnected)

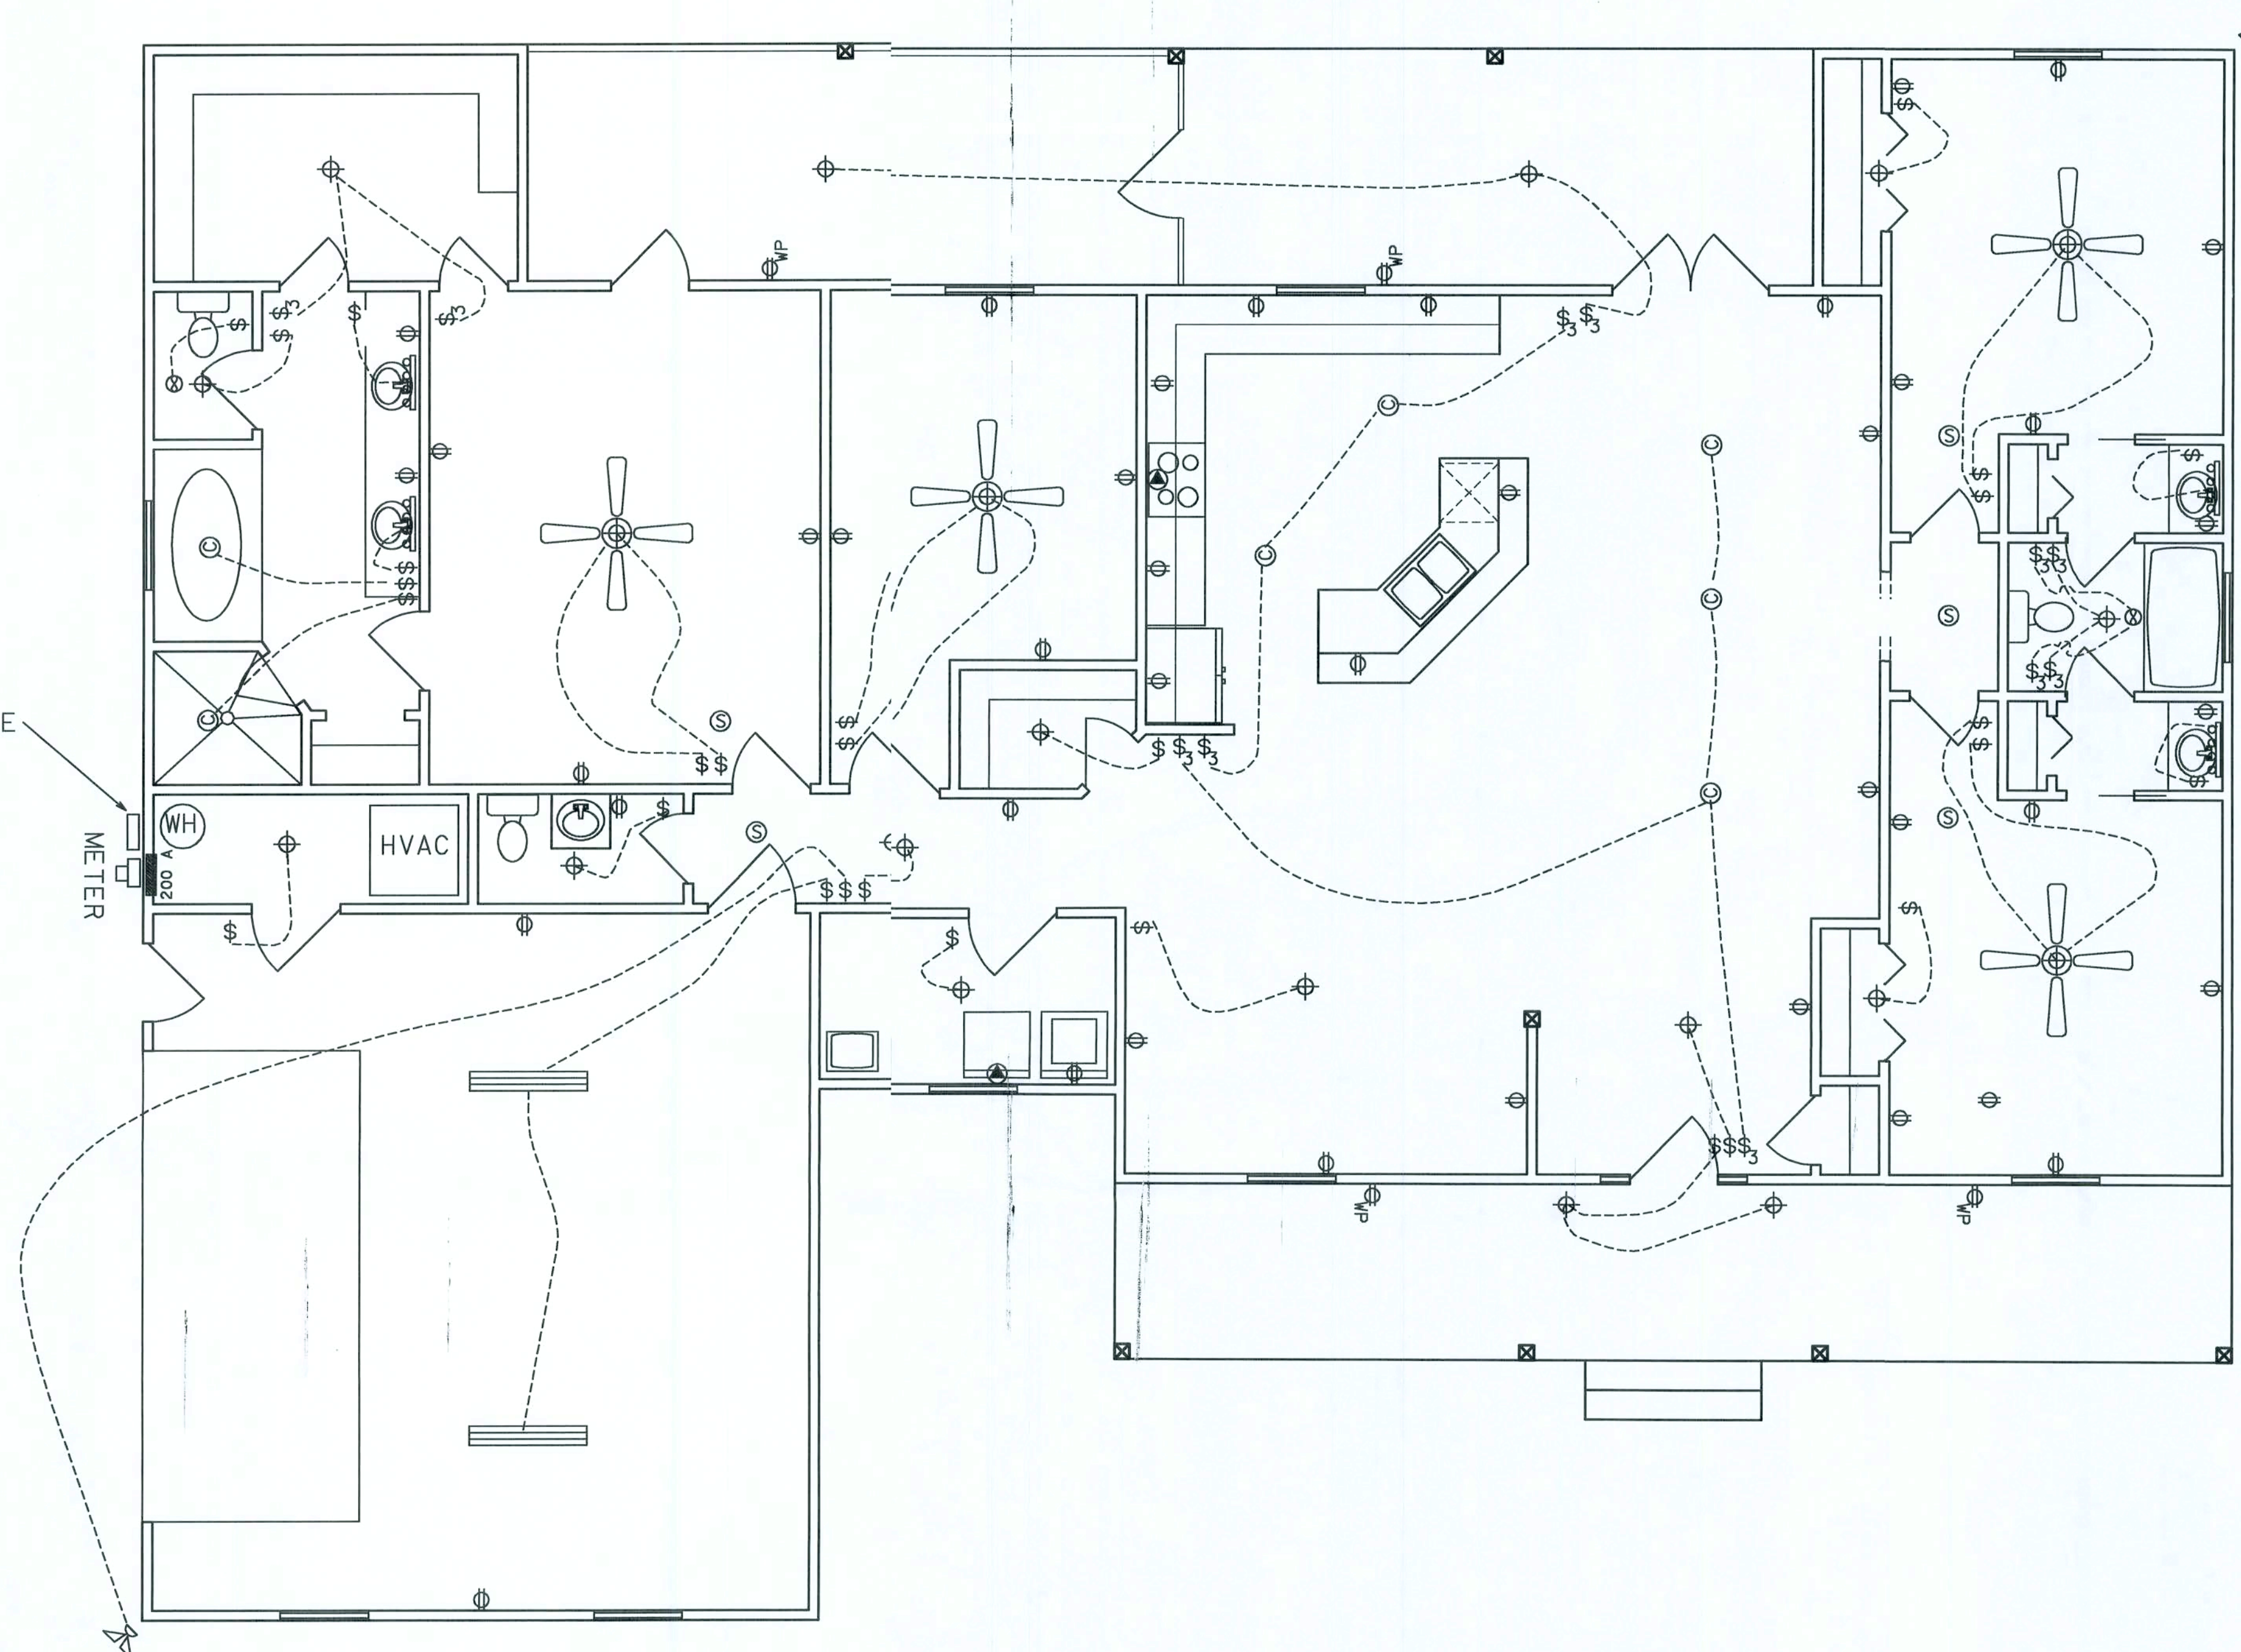

NOTES:

- 1.) ALL EXTERIOR RECEPTACLES SHALL EITHER BE GFI OUTLETS OR PART OF A GFI CIRCUIT. ALL EXTERIOR RECEPTACLES SHALL BE WEATHERPROOF.
- 3.) ALL BATHROOM, KITCHEN, AND GARAGE RECEPTACLES SHALL BE PART OF A GFI CIRCUIT.
- 4.) ALL BEDROOM RECEPTACLES SHALL BE PART OF AN AFI CIRCUIT.

THESE DRAWINGS, AS INSTRUMENTS OF SERVICE, ARE THE SOLE PROPERTY OF HAYGOOD HOMES, INC., AND ARE MAY NOT BE USED, COPIED OR REPRODUCED IN WHOLE OR IN PART FOR USE ON OR INCORPORATED WITHIN ANY OTHER JO WITHOUT SPECIFIC AND INDIVIDUAL AUTHORIZATION BY HAYGOOD HOMES, INC.,

Jeff & Christina Knight
 Jeff & Christina Knight
 Lake, City Florida

HH HAYGOOD HOMES INC.

12592 So. U.S. HWY 441
 LAKE CITY FL 32025
 OFFICE (386) 752-3496
 MOBILE (386) 303-1981
 CR-C1326715

ELECTRICAL PLAN

PLAN No.	SCALE	DATE	SHEET NO.
P 0901	1/4" = 1'	04/29/09	6

...Projects\Knight\ELC.dwg 7/7/2009 9:17:17 PM