

1607 22-11-04

BEDENBAUGH RESIDENCE

IN
COLUMBIA COUNTY, FL.

CONSTRUCTION PLANS
FOR

GREG & JUDI BEDENBAUGH
LAKE CITY FL. ~~32024~~
32025

SQUARE FOOTAGE	
HEATED AREA	2413 SF
PORCHS	412 SF
TOTAL	2825 SF


INDEX	
SHEET No.	NAME
1	TITLE SHEET
2 - 3	ELEVATIONS
4	FLOOR PLAN
5	ELECTRICAL
6	DETAILS
7	FOUNDATION

PREPARED BY: 




HAYGOOD HOMES INC.
12592 So. U.S. HWY 441
LAKE CITY FL. 32025
OFFICE (386) 752-3496
MOBILE (386) 303-1981
CR-C1326715

PLAN No.	SCALE	DATE	SHEET NO.
P0503	1/4" = 1'	08/22/05	1

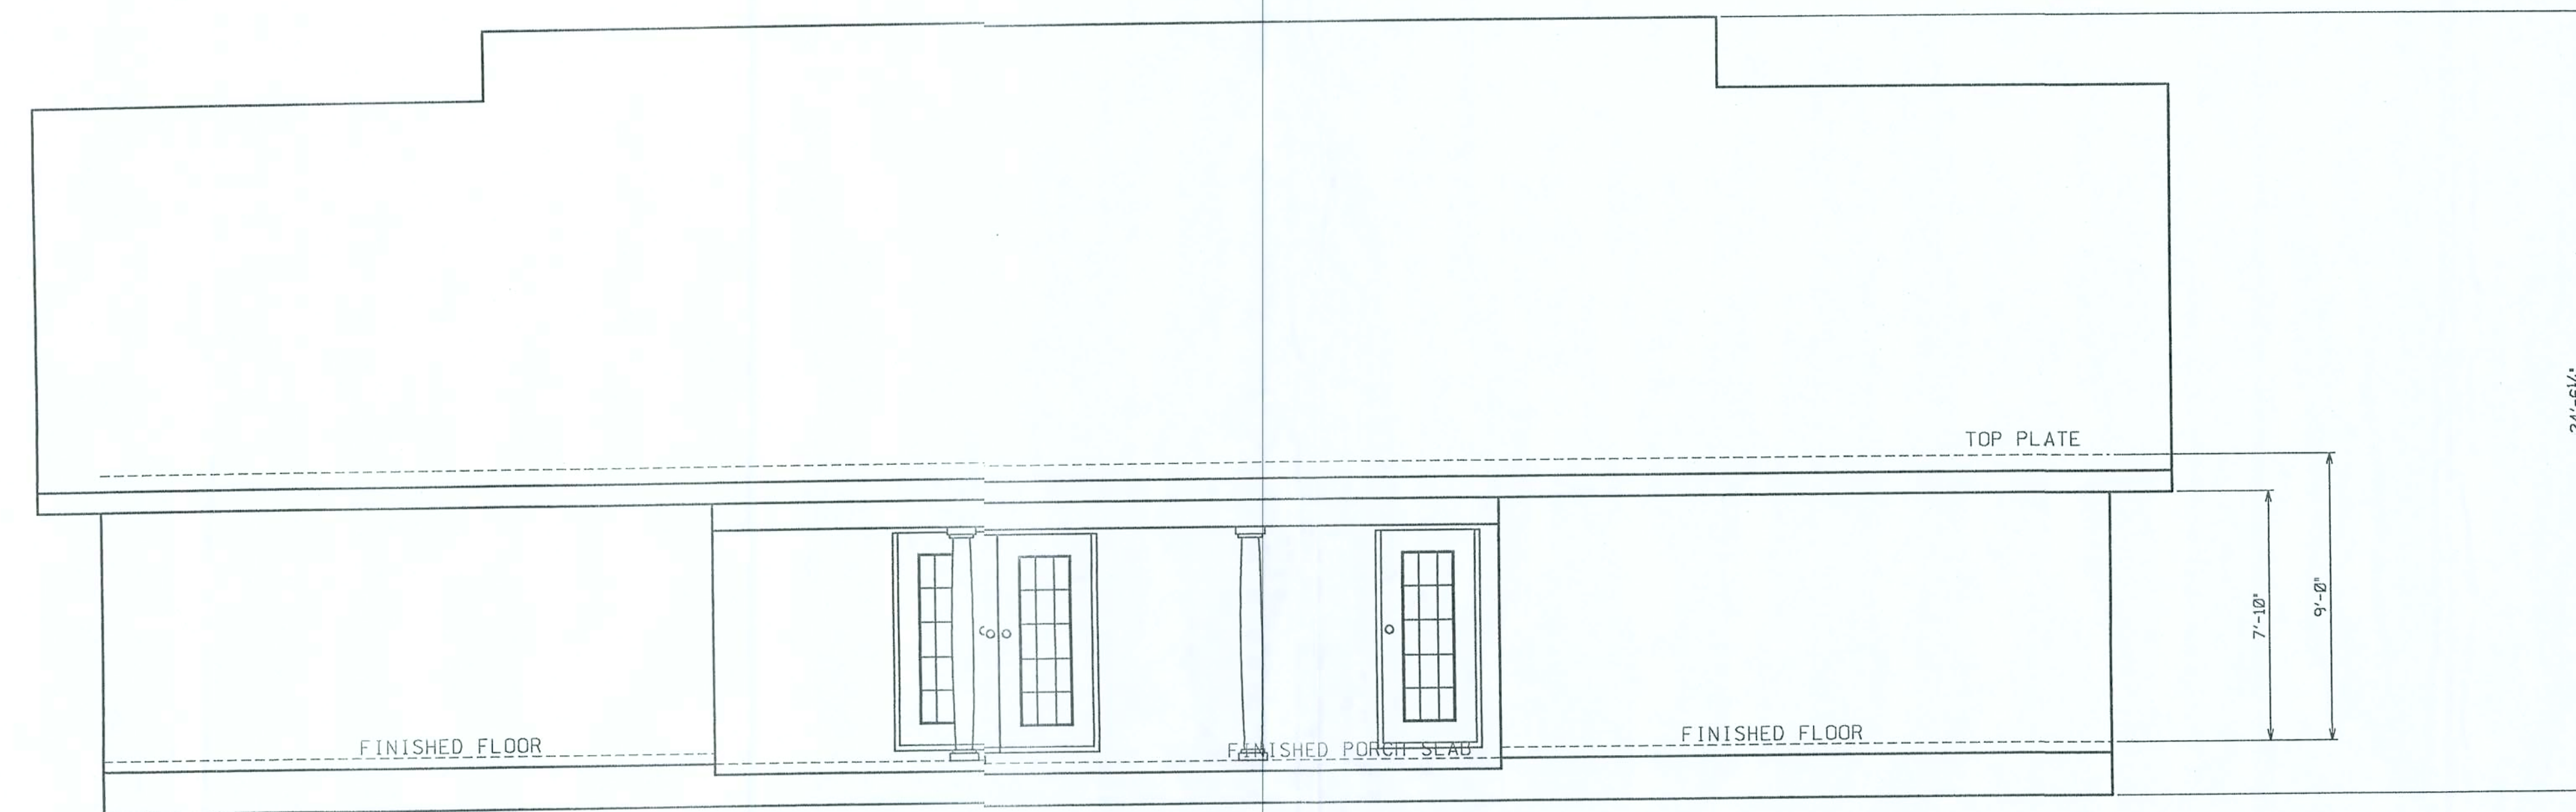

REAR ELEVATION

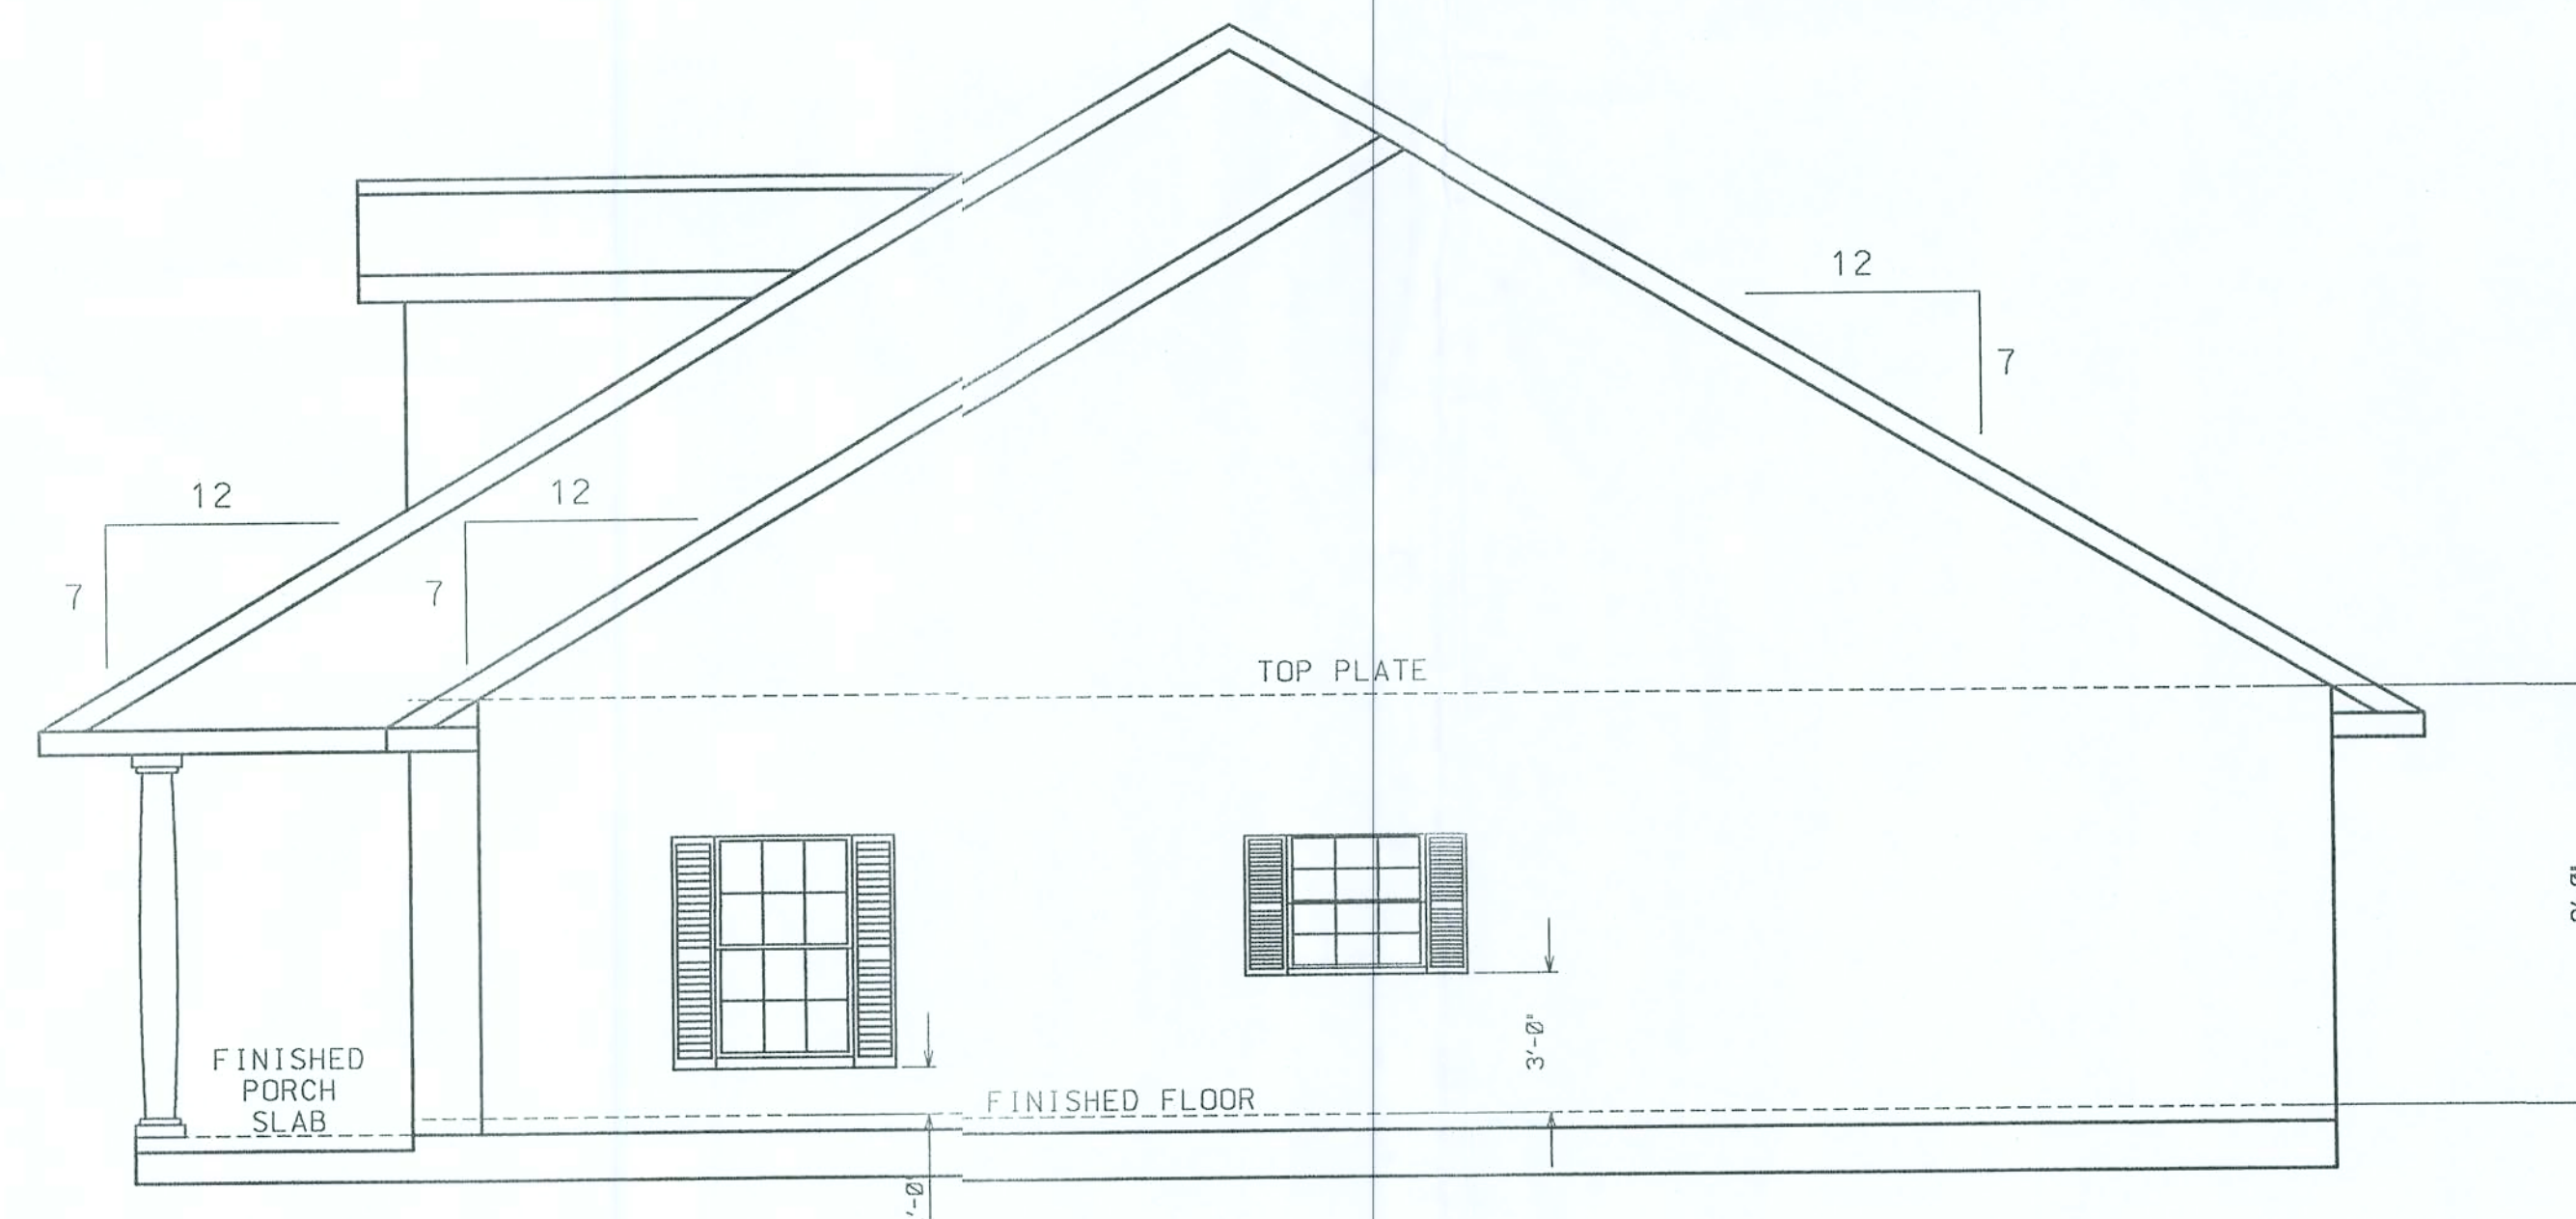

RIGHT ELEVATION

THESE DRAWINGS, AS INSTRUMENTS OF SERVICE, ARE THE SOLE PROPERTY OF HAYGOOD HOMES, INC., AND ARE NOT TO BE USED, COPIED OR REPRODUCED IN WHOLE OR IN PART FOR USE ON OR INCORPORATED WITHIN ANY OTHER JOB WITHOUT SPECIFIC AND INDIVIDUAL AUTHORIZATION BY HAYGOOD HOMES, INC.



HAYGOOD HOMES INC.


12592 So. U.S. HWY 441
LAKE CITY FL. 32025
OFFICE (386) 752-3496
MOBILE (386) 303-1981
CR-C1326715

MR. & MRS. GREG BENDENBAUGH
LAKE CITY FL.

FLOOR PLAN

PLAN No.	SCALE	DATE	SHEET NO.
P 0503	1/4" = 1'	05/30/05	2

... Bendenbaugh Elevation.dgn 5/29/2005 9:37:05 PM

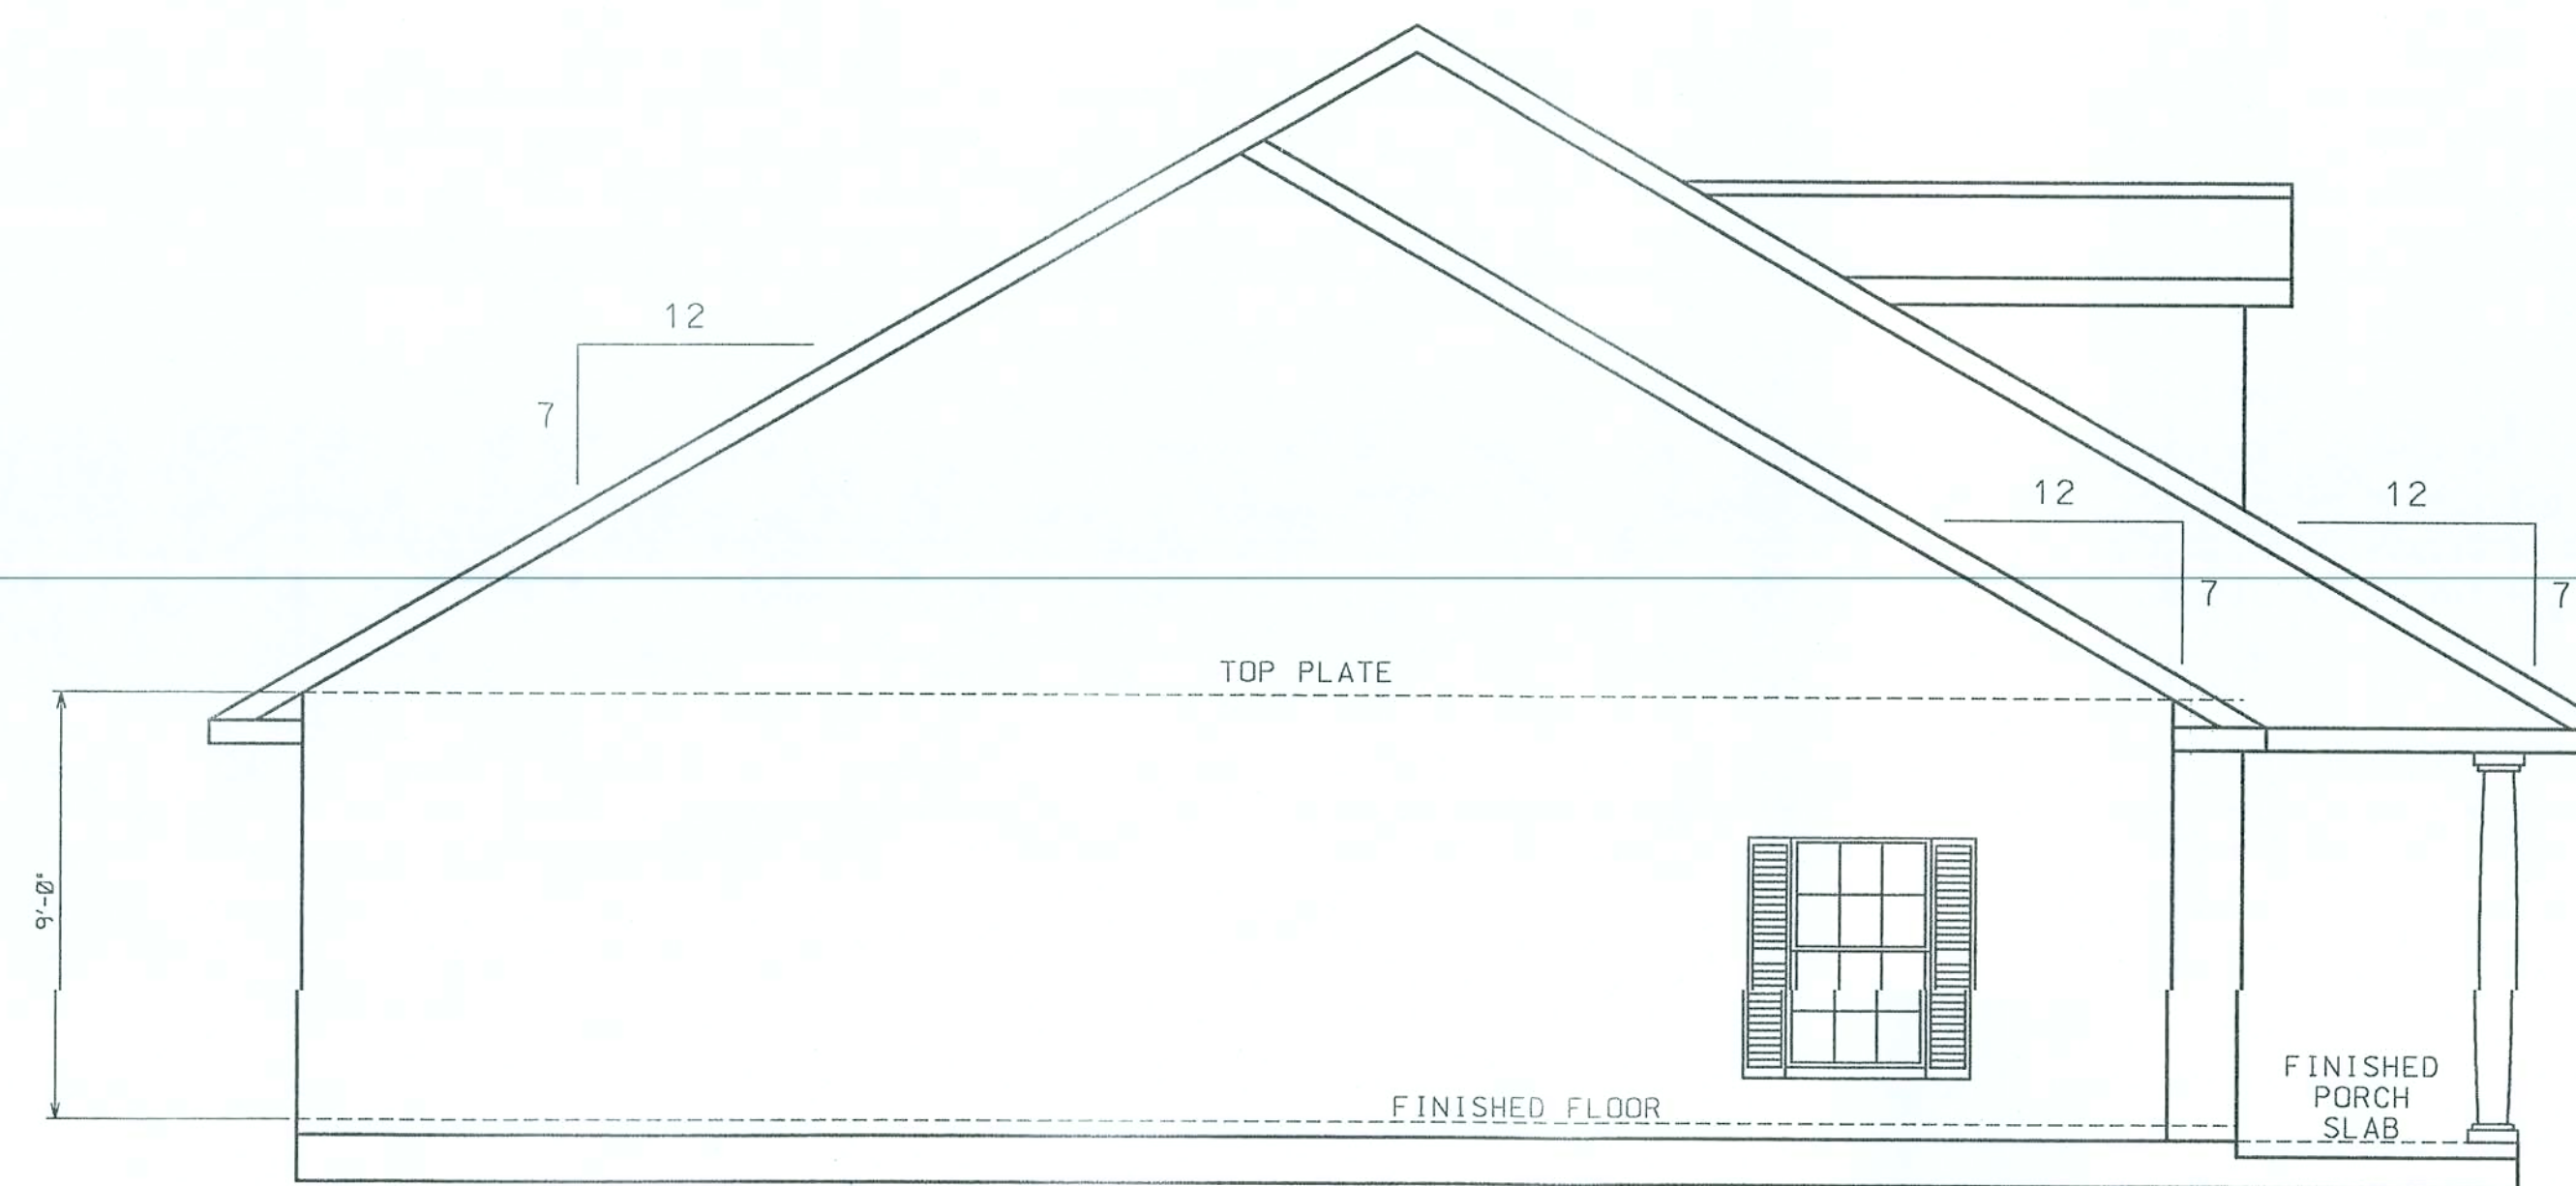

LEFT ELEVATION



FRONT ELEVATION

THESE DRAWINGS, AS INSTRUMENTS OF SERVICE, ARE THE SOLE PROPERTY OF HAYGOOD HOMES, INC., AND ARE NOT TO BE USED, COPIED OR REPRODUCED IN WHOLE OR IN PART FOR USE ON OR INCORPORATED WITHIN ANY OTHER JOB WITHOUT SPECIFIC AND INDIVIDUAL AUTHORIZATION BY HAYGOOD HOMES, INC.



HAYGOOD HOMES INC.


12592 So. U.S. HWY 441
LAKE CITY FL. 32025
OFFICE (386) 752-3496
MOBILE (386) 303-1981
CR-C1326715

MR. & MRS. GREG BEDENBAUGH

LAKE CITY FL.

FLOOR PLAN

PLAN No.	SCALE	DATE	SHEET NO.
P 0503	1/4" = 1'	05/30/05	3

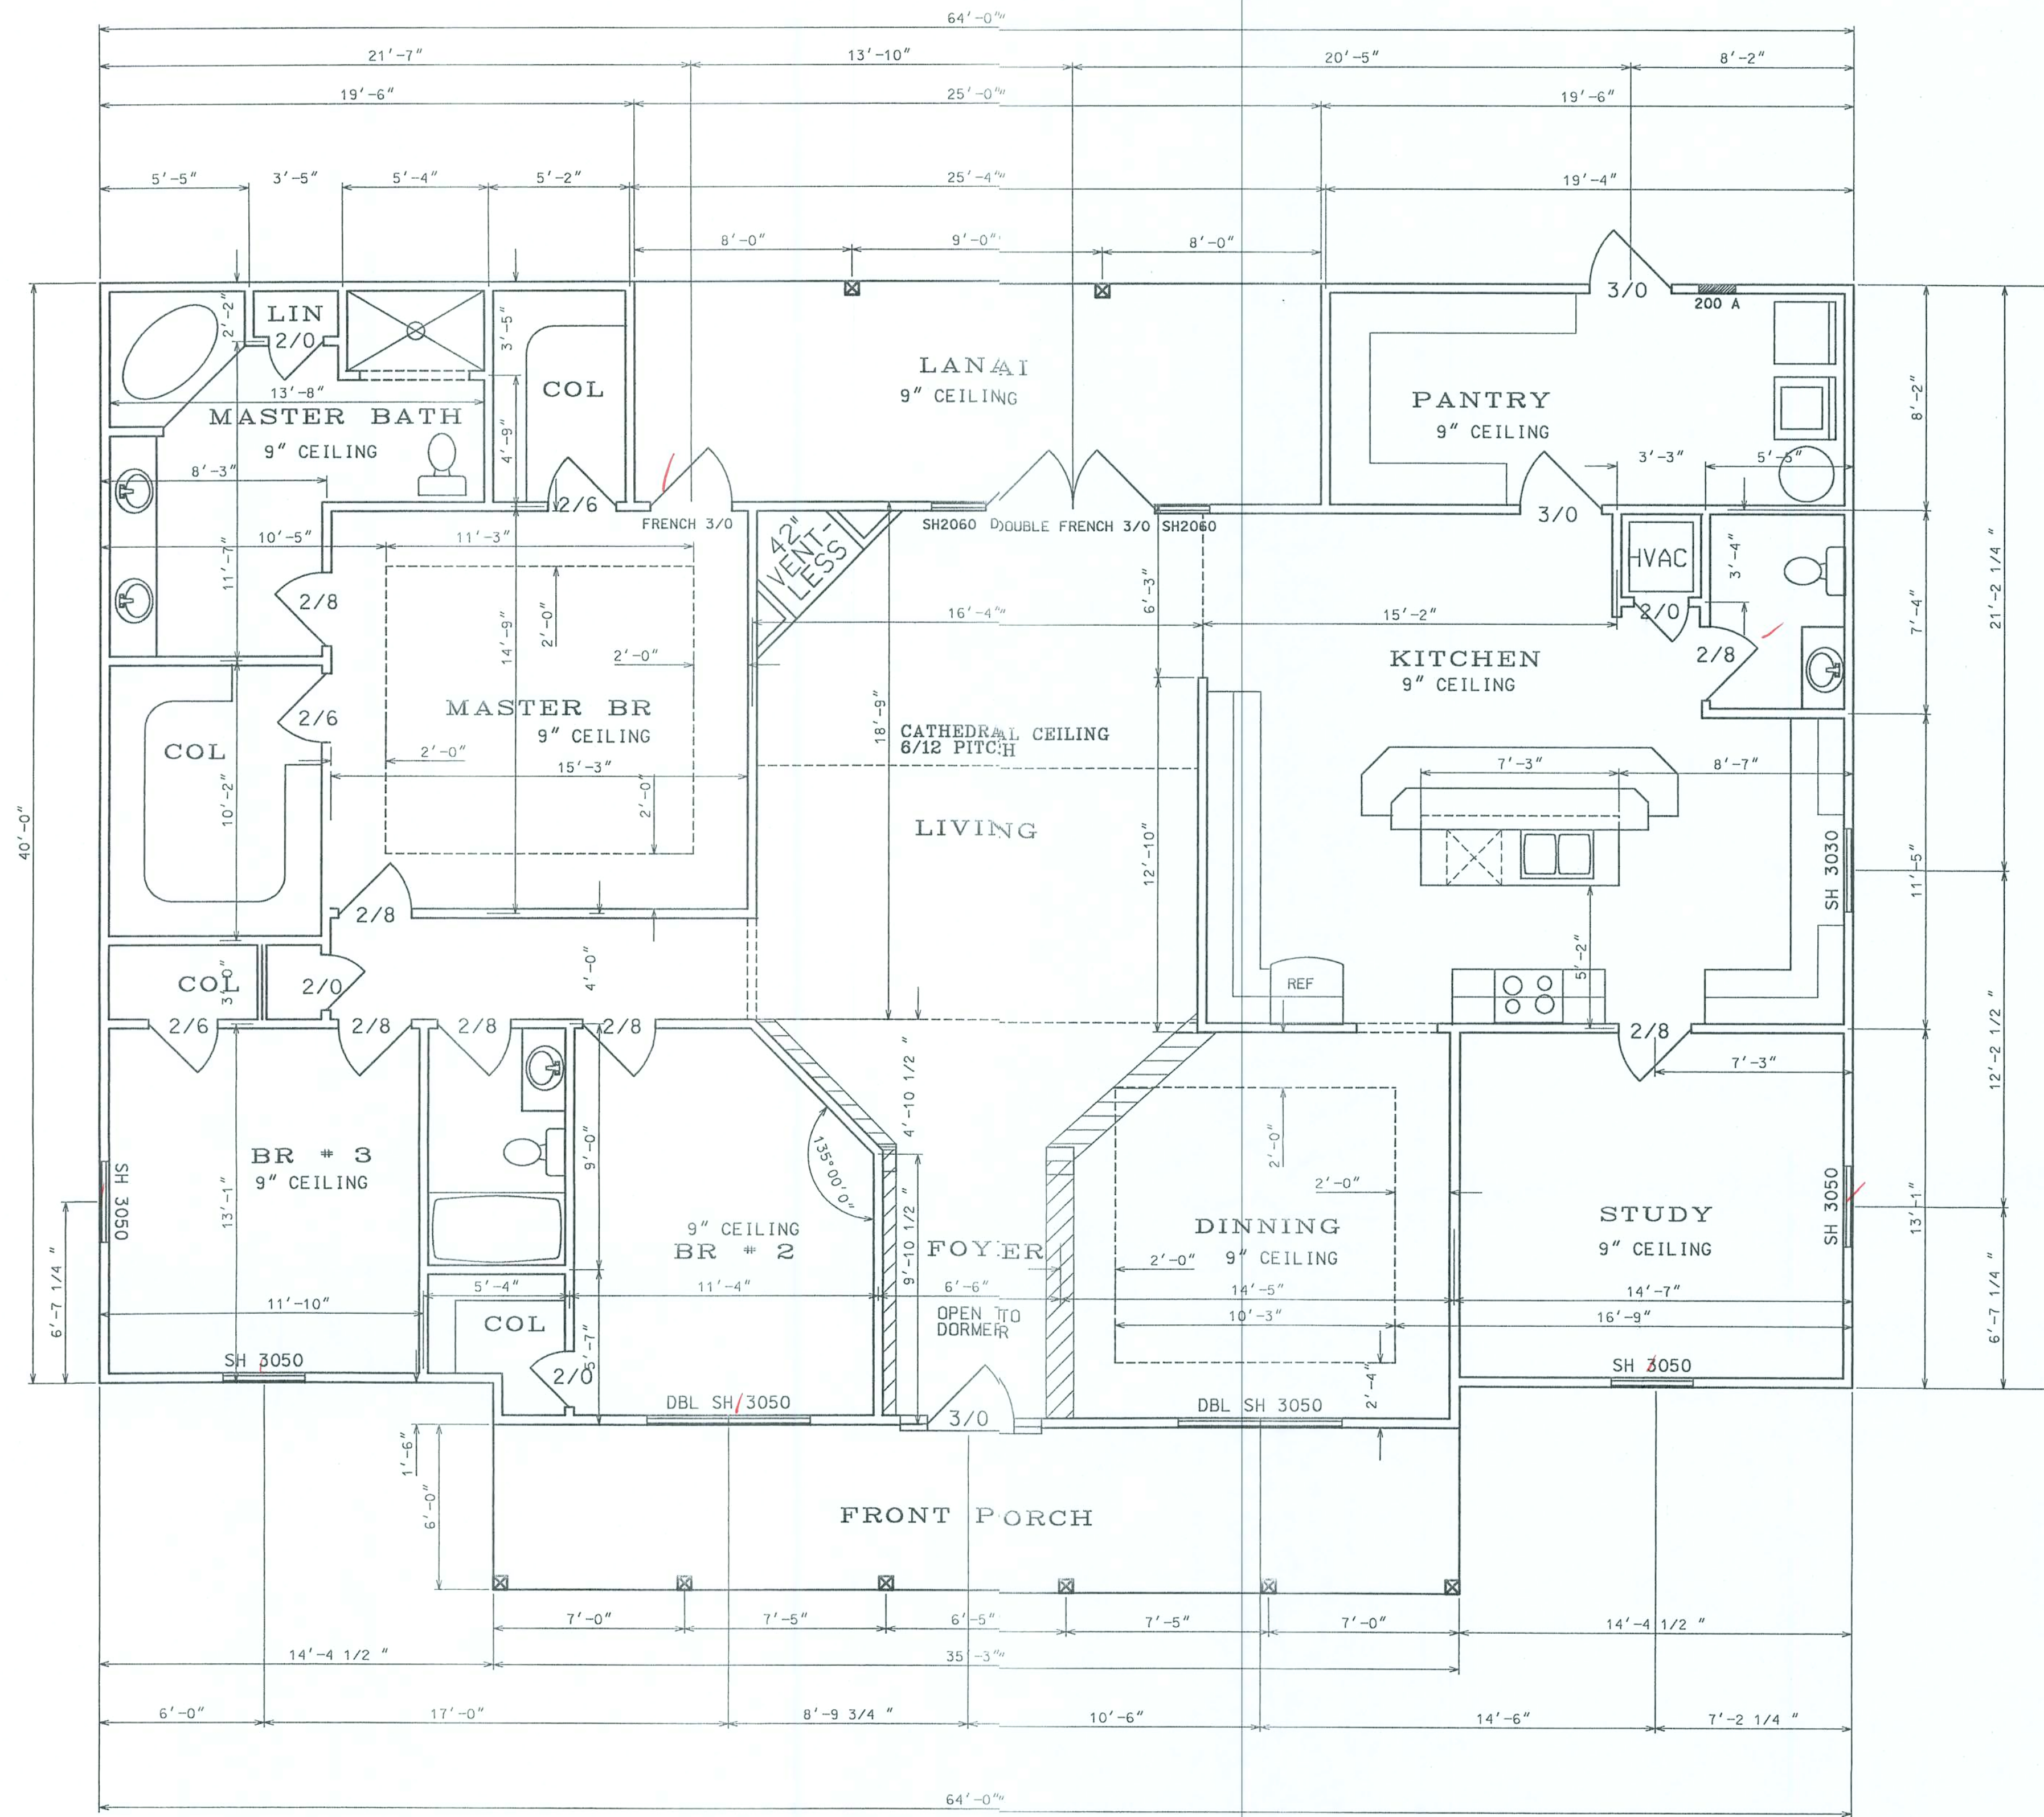

DOOR SCHEDULE	
No.	SIZE & TYPE
1	3' - 0" METAL ENTRY WITH SIDE LIGHTS
1	6' - 0" METAL DBL 3/0 FRENCH EXTERIOR
1	3' - 0" 9 LITE ENTRY DOOR EXTERIOR
1	3' - 0" FRENCH EXTERIOR
1	3' - 0" COLONIAL INTERIOR
7	2' - 8" COLONIAL INTERIOR
3	2' - 6" COLONIAL INTERIOR
4	2' - 0" COLONIAL INTERIOR


WINDOW SCHEDULE	
No.	SIZE & TYPE
2	3' 0" - 5' 0" DBL SINGLE HUNG VINYL
4	3' 0" - 5' 0" SINGLE HUNG VINYL
1	3' 0" - 3' 0" SINGLE HUNG VINYL
2	2' 0" - 6' 0" SINGLE HUNG VINYL

SQUARE FOOTAGE	
HEATED AREA	2413 SF
PORCH	412 SF
TOTAL	2825 SF

THESE DRAWINGS, AS INSTRUMENTS OF SERVICE, ARE THE SOLE PROPERTY OF HAYGOOD HOMES, INC., AND ARE NOT TO BE USED, COPIED, REPRODUCED IN WHOLE OR IN PART FOR USE ON OR INCORPORATED WITHIN ANY OTHER JOB WITHOUT SPECIFIC AND INDIVIDUAL AUTHORIZATION BY HAYGOOD HOMES, INC.

 HAYGOOD HOMES INC.	12592 So. U.S. HWY 441 LAKE CITY FL 32025 OFFICE (386) 752-3496 MOBILE (386) 303-1981 CR-C1326715	MR. & MRS. GREG BEDENBAUGH LAKE CITY FL.	FLOOR PLAN	PLAN No.	SCALE	DATE	SHEET NO.
				P 0503	1/4" = 1'	05/30/05	4

...Bedenbaugh\FloorPlan.dgn 5/29/2005 9:36:43 PM

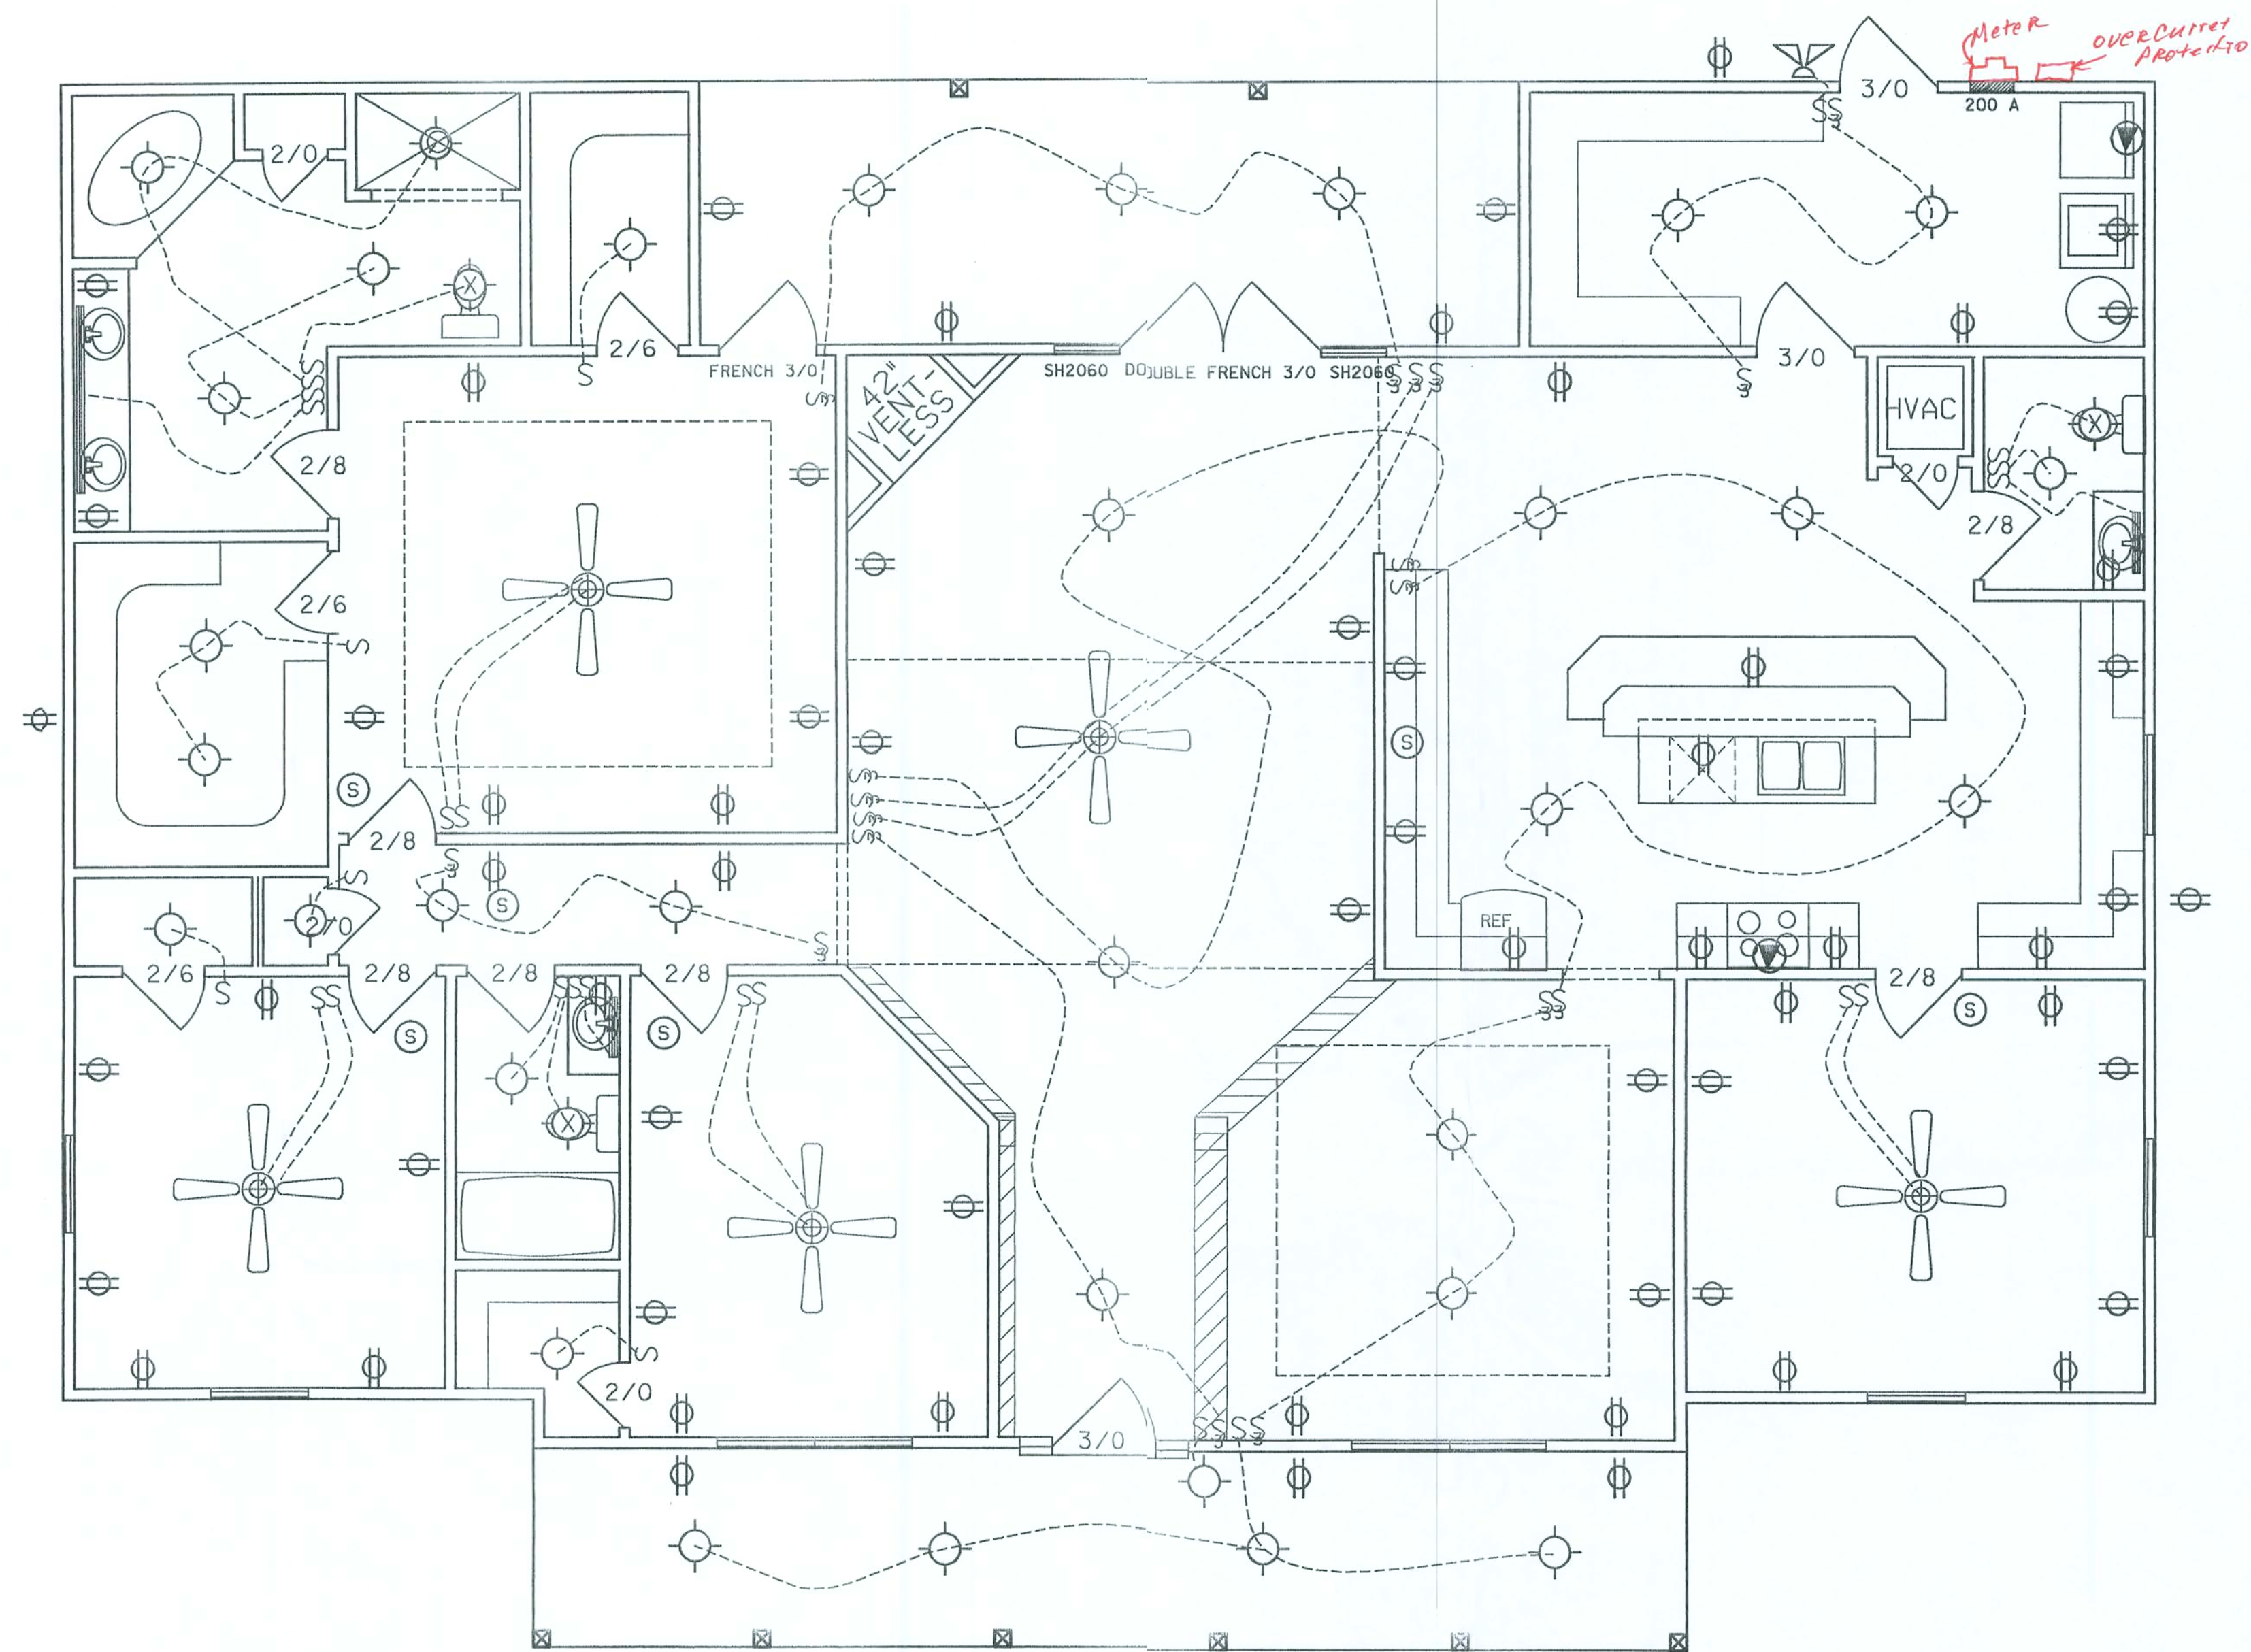

- METER BASE
- VANITY LIGHT AS SPECIFIED
- CEILING FAN w LIGHTS
- LIGHT FIXTURE
- RECESSED CAN LIGHT FIXTURE
- S - SINGLE POLE SWITCH
- § - THREE-WAY SWITCH
- RECEPT.
- MOTION SECURITY LIGHT
- EXHAUST
- HEAT LAMP / EXHAUST FAN
- 220 V.
- SMOKE DETECTOR (AC/DC and interconnected)
- COAX & TELEPHONE
- TELEPHONE
- 200 AMP SERVICE PANEL

NOTES:

- 1.) PULL HOMERUNS OF TELEPHONE CABLE AND COAX CABLE TO COMMUNICATION PANEL (NO JUNCTIONS ALLOWED IN ATTIC)
- 2.) ALL EXTERIOR RECEPTACLES SHALL EITHER BE GFI RECEPTACLES OR PART OF A GFI CIRCUIT. ALL EXTERIOR RECEPTACLES SHALL BE WEATHERPROOF.
- 3.) ALL BATHROOM, KITCHEN, AND GARAGE RECEPTACLES SHALL BE PART OF A GFI CIRCUIT.
- 4.) ALL BEDROOM RECEPTACLES SHALL BE PART OF AN AFI CIRCUIT.
- 5.) ALL BATHROOM RECEPTACLES SHALL BE A SEPARATE DEDICATED 20amp GFI CIRCUIT.

NOTE:

THE ELECTRICAL PLAN IS INTENDED TO SHOW SCHEMATICALLY THE LAYOUT OF THE ELECTRICAL COMPONENTS. FINAL LOCATIONS AND SIZEING OF THE COMPONENTS SHALL BE THE RESPONSIBILITY OF A LICENSED ELECTRICAL CONTRACTOR. ALL WORK SHALL BE PERFORMED IN ACCORDANCE WITH ALL APPLICABLE CODES.

THESE DRAWINGS, AS INSTRUMENTS OF SERVICE, ARE THE SOLE PROPERTY OF HAYGOOD HOMES, INC., AND ARE NOT BE LOANED, COPIED, REPRODUCED, IN WHOLE OR IN PART FOR USE ON OR IN CONNECTION WITH ANY OTHER AND WITHOUT SPECIFIC AND INDIVIDUAL AUTHORIZATION BY HAYGOOD HOMES, INC.



HAYGOOD HOMES INC.


12592 So. U.S. HWY 441
LAKE CITY FL. 32025
OFFICE (386) 752-3496
MOBILE (386) 303-1981
CR-C1326715

M.R. & MRS. GREG BEDENBAUGH
LAKE CITY FL.


ELECTRICAL

PLAN No.	SCALE	DATE	SHEET NO.
P 0503	1/4" = 1'	05/30/05	5

...Bedenbaugh/Electrical.dgn 5/29/2005 9:36:13 PM

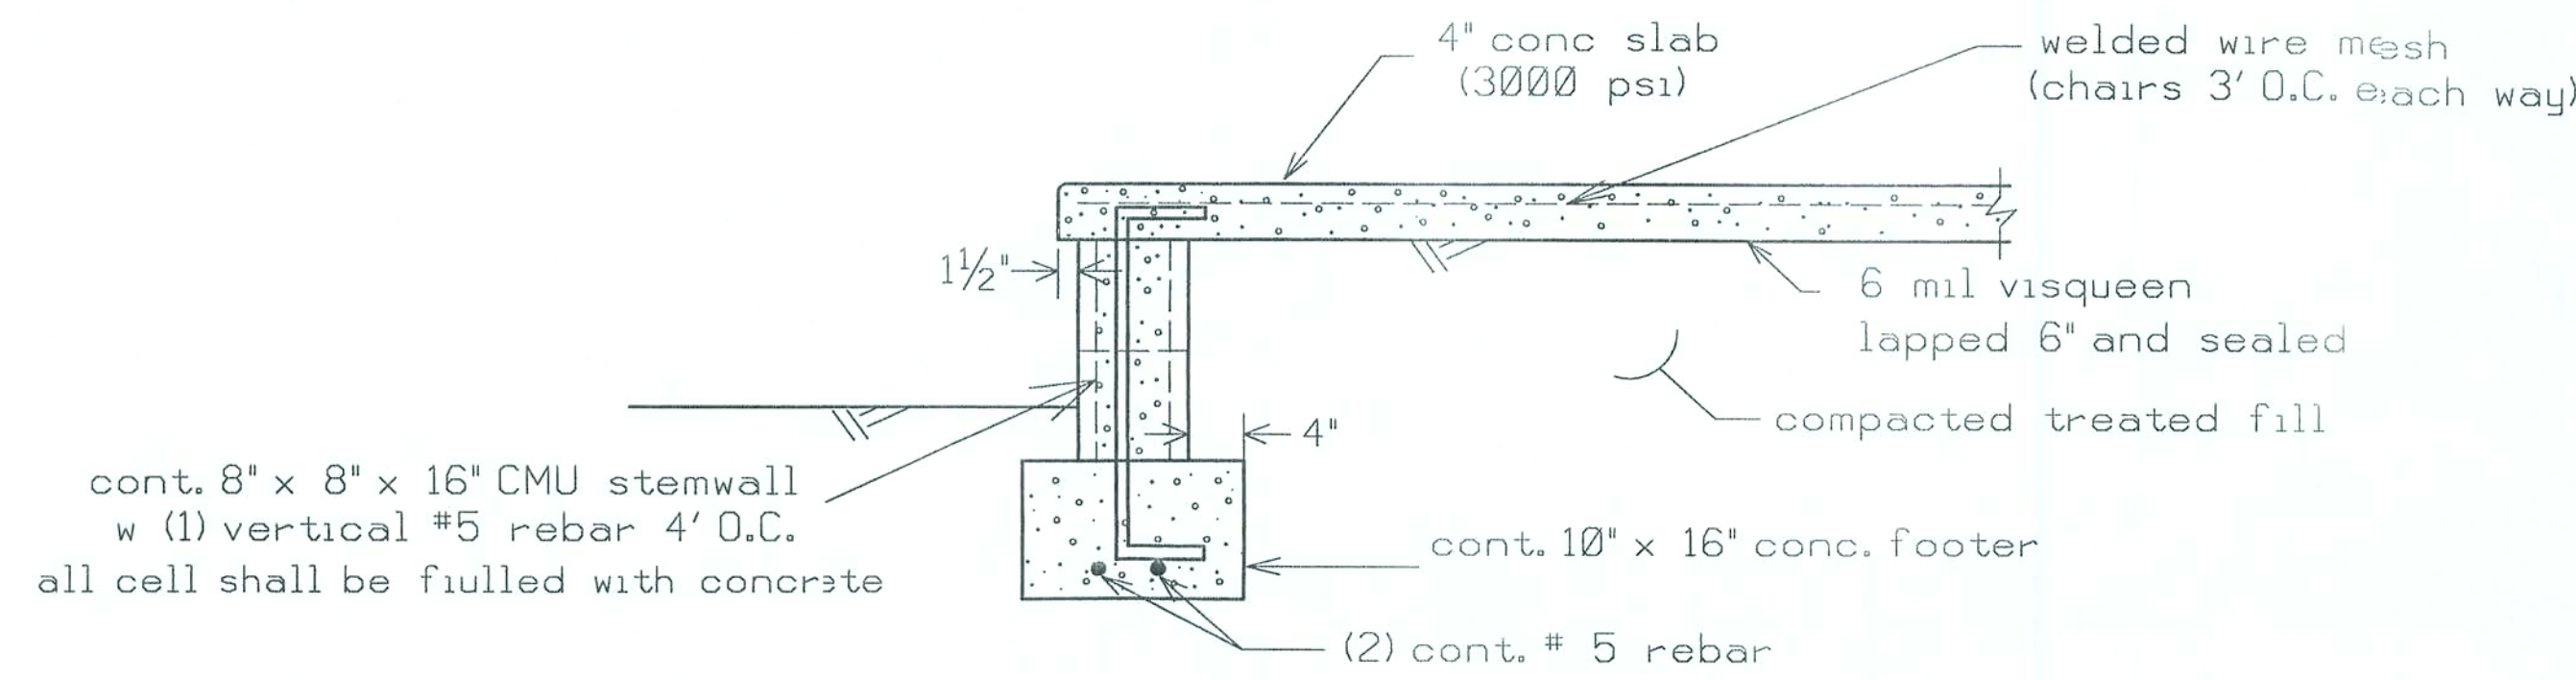

PORCH FOUNDATION(N.T.S.)

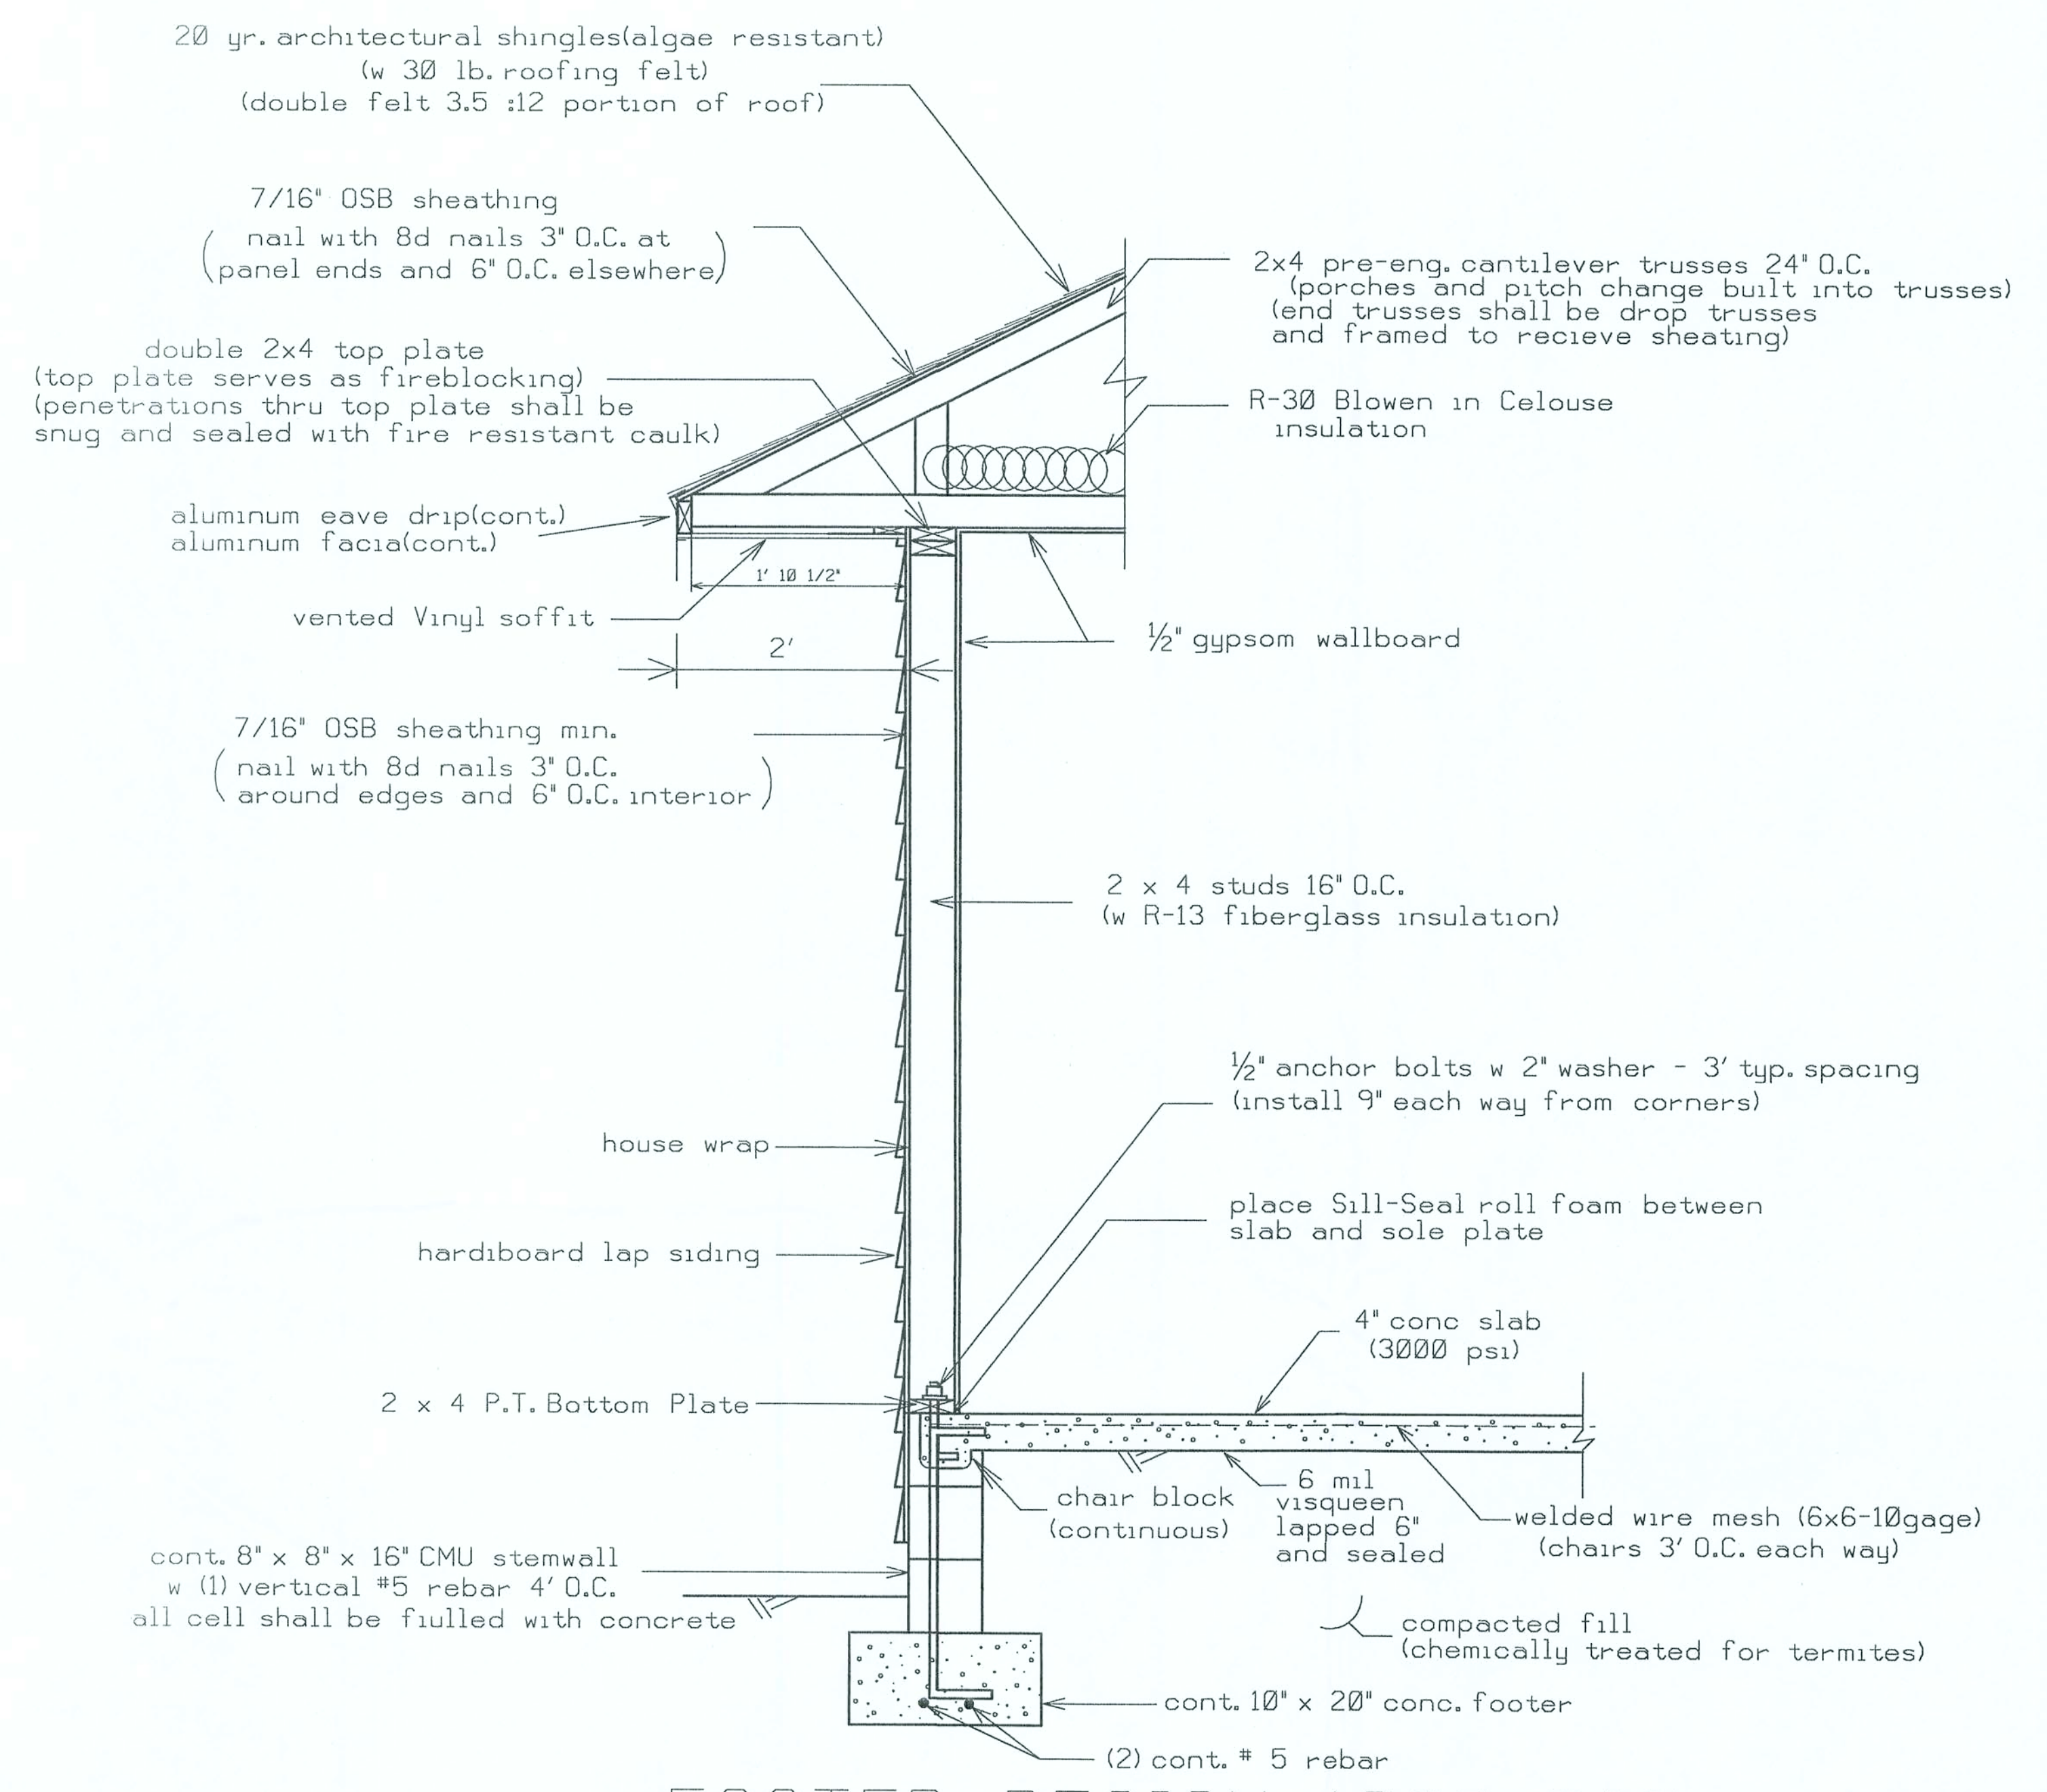

FOOTER DESIGN 1000 PSF

WALL DETAIL(TYP.) (N.T.S.)

HEADER SIZES/MATERIAL SHALL BE AS FOLLOWS:

WINDOW AND DOOR OPENINGS(2 - #2 SYP 2X12's with 1/2" plywood between)
PORCH BEAMS (2 - #2 SYP 2X10's with 1/2" plywood between)

THESE DRAWINGS, AND INSTRUMENTS OF SERVICE, ARE THE SOLE PROPERTY OF HAYGOOD HOMES, INC., AND ARE NOT TO BE LOANED, COPIED OR REPRODUCED IN WHOLE OR IN PART FOR USE ON OR INCORPORATED WITHIN ANY OTHER JOB WITHOUT SPECIFIED AND INDIVIDUAL AUTHORIZATION BY HAYGOOD HOMES, INC.



HAYGOOD HOMES INC.

12592 So. U.S. HWY 441
LAKE CITY FL. 32025
OFFICE (386) 752-3496
MOBILE (386) 303-1981
CR-C1326715

MR. & MRS. GREG BEDENBAUGH
LAKE CITY FL.

DETAIL SHEET

PLAN No.	SCALE	DATE	SHEET NO.
P 0503	1/4" = 1'	05/29/05	6

Bedenbaugh/Details.dgn 5/29/2005 9:33:23 AM

