


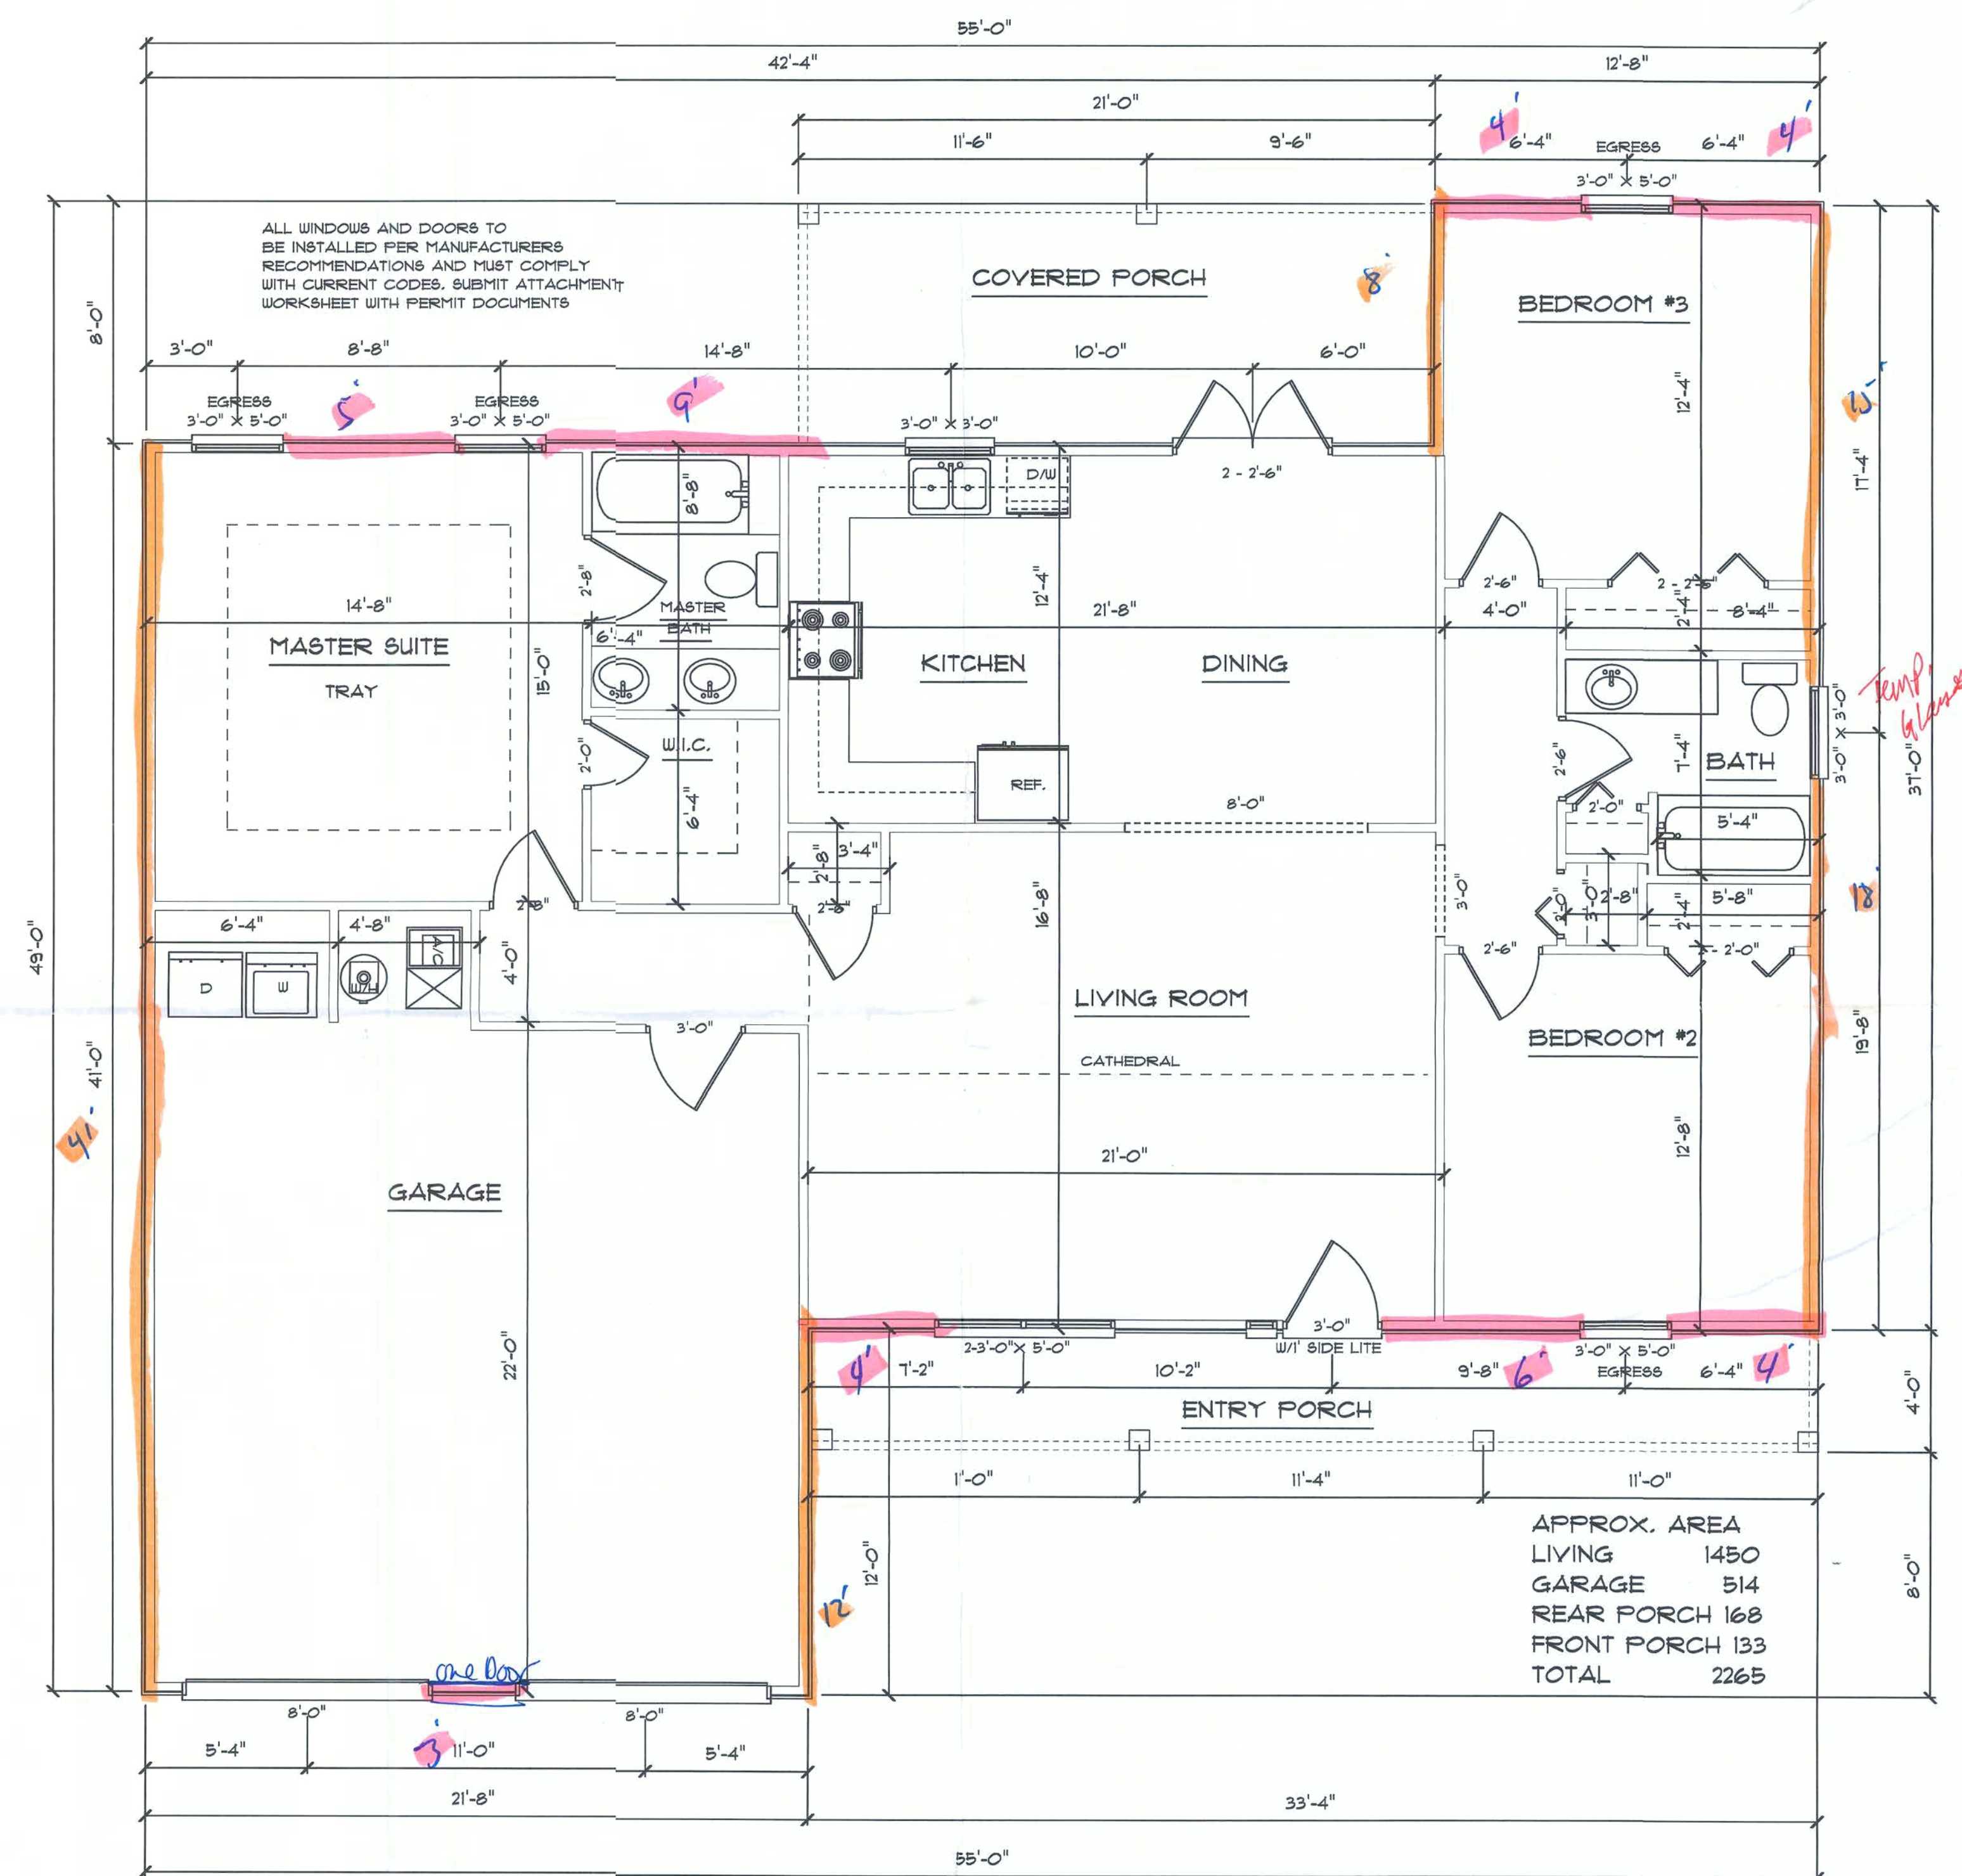

IT IS THE OWNER AND OR THE CONTRACTORS RESPONSIBILITY TO VERIFY ALL STRUCTURAL ASPECTS OF THESE DRAWINGS. THIS INCLUDES BUT NOT LIMITED TO DIMENSIONS, WALL HEIGHTS AND MATERIAL, WINDOW SIZE AND LOCATION. ALSO ALL STATE AND LOCAL CODES MUST BE FOLLOWED

MAIN FLOOR PLAN

10-94'
long-39'

of the

ET, WHITE MODEL

SCALE $1/4" = 1'$

DRAWN BY P.A.C.


APPROVED

**ROYALE
HOMES**


DATE	10/21/04
RECEIVED	
RECEIVED	

COLACINO
DRAFTING&DESIGN
PH. 352-472-3462


1

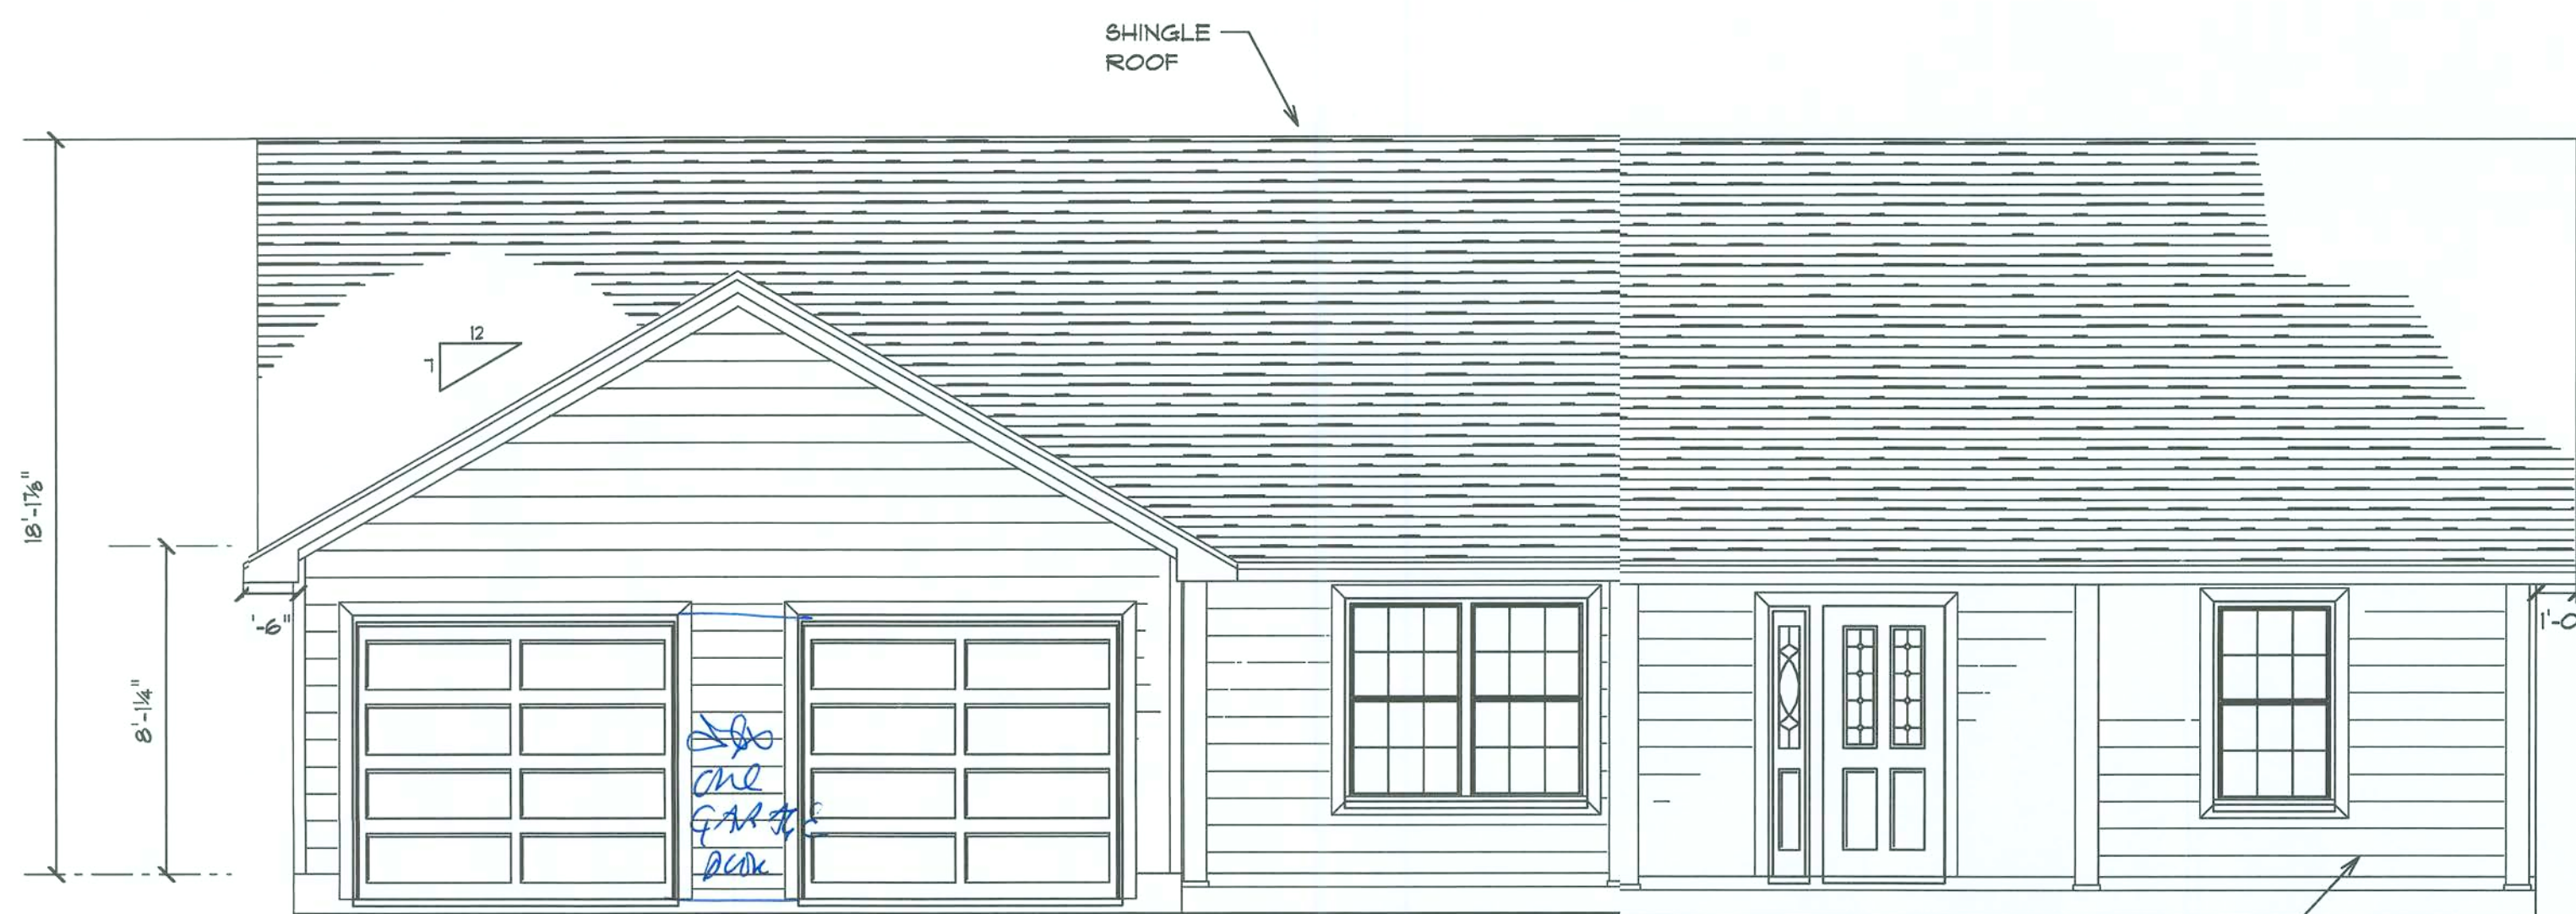


FRONT ELEVATION

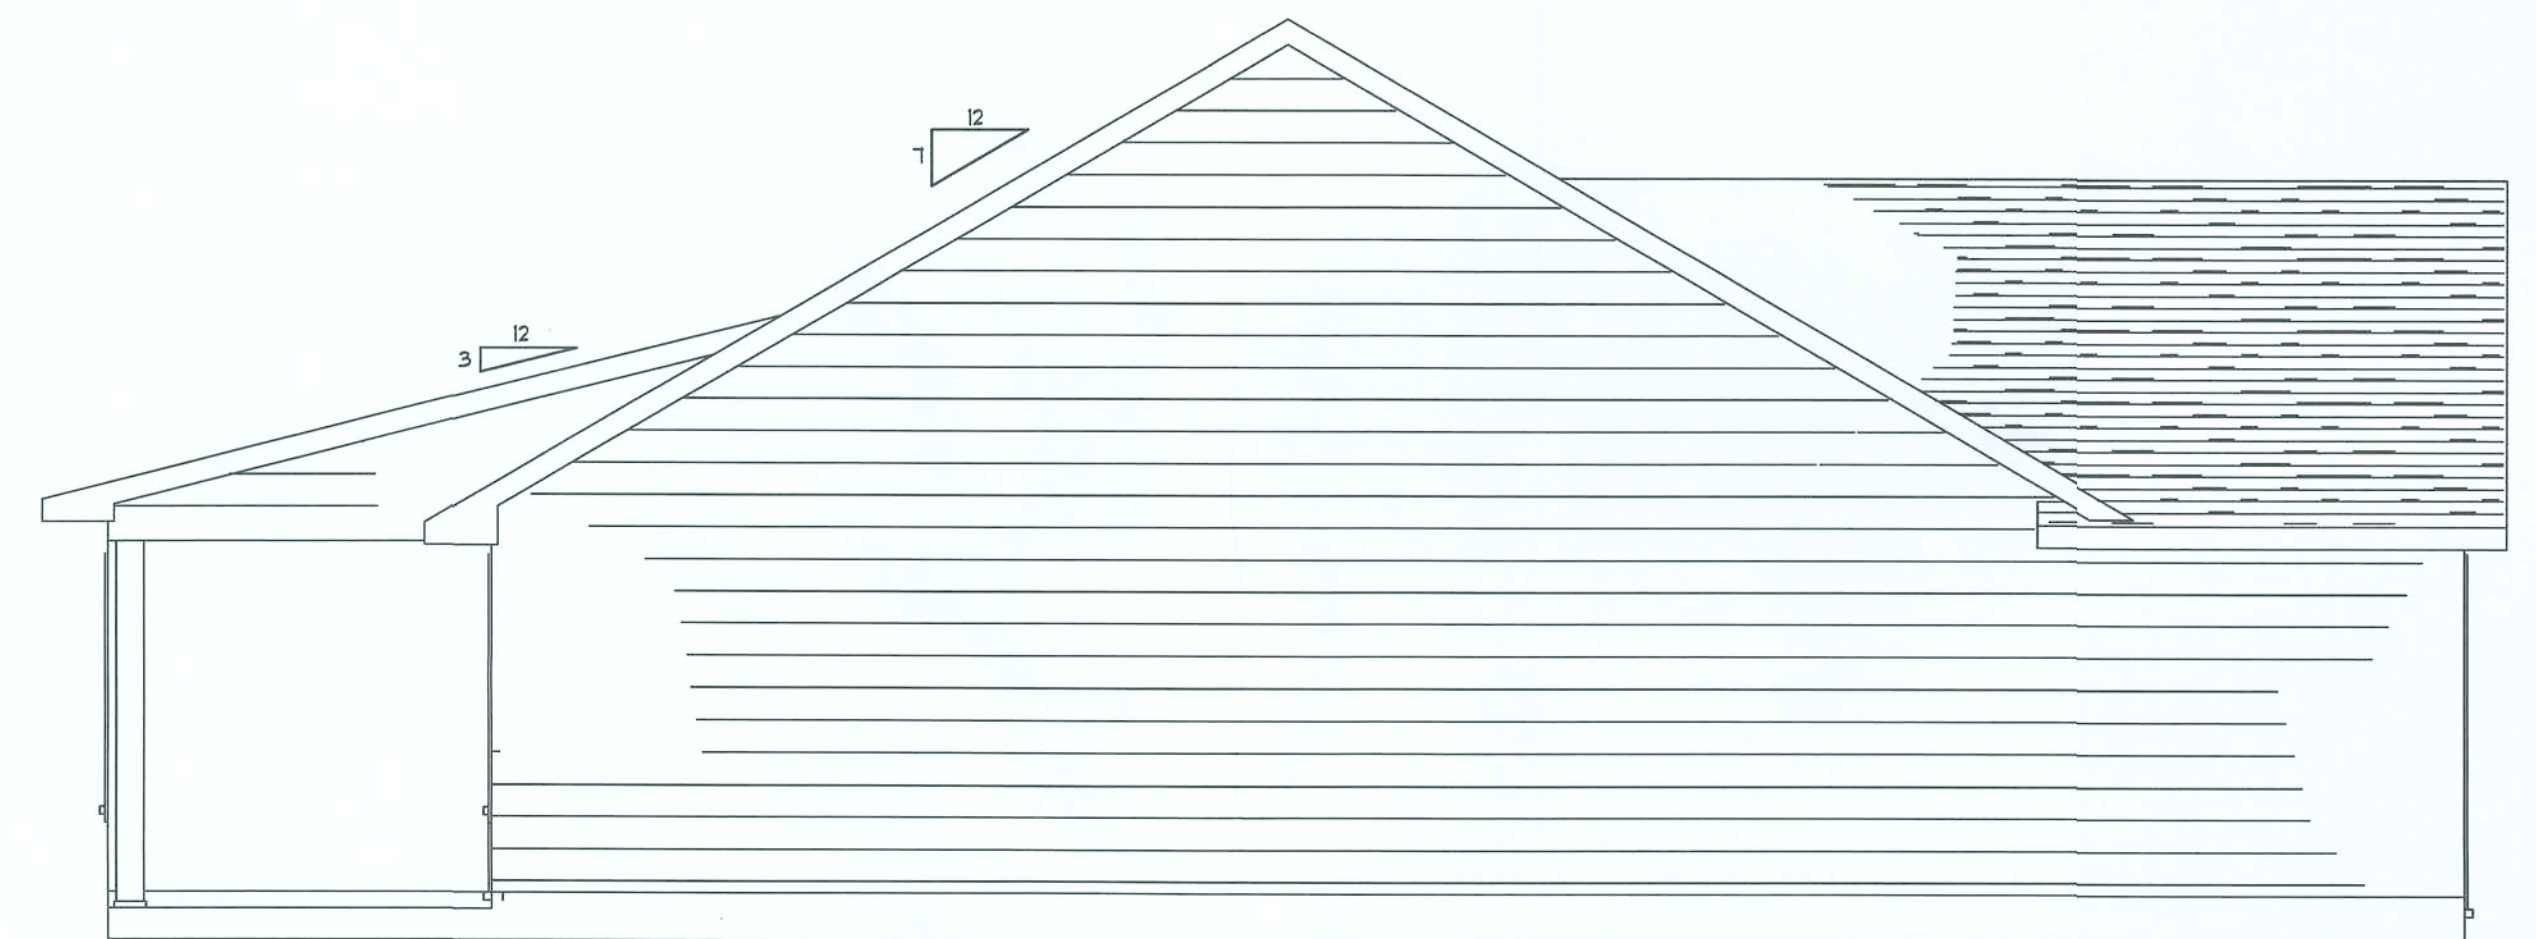




LEFT ELEVATION

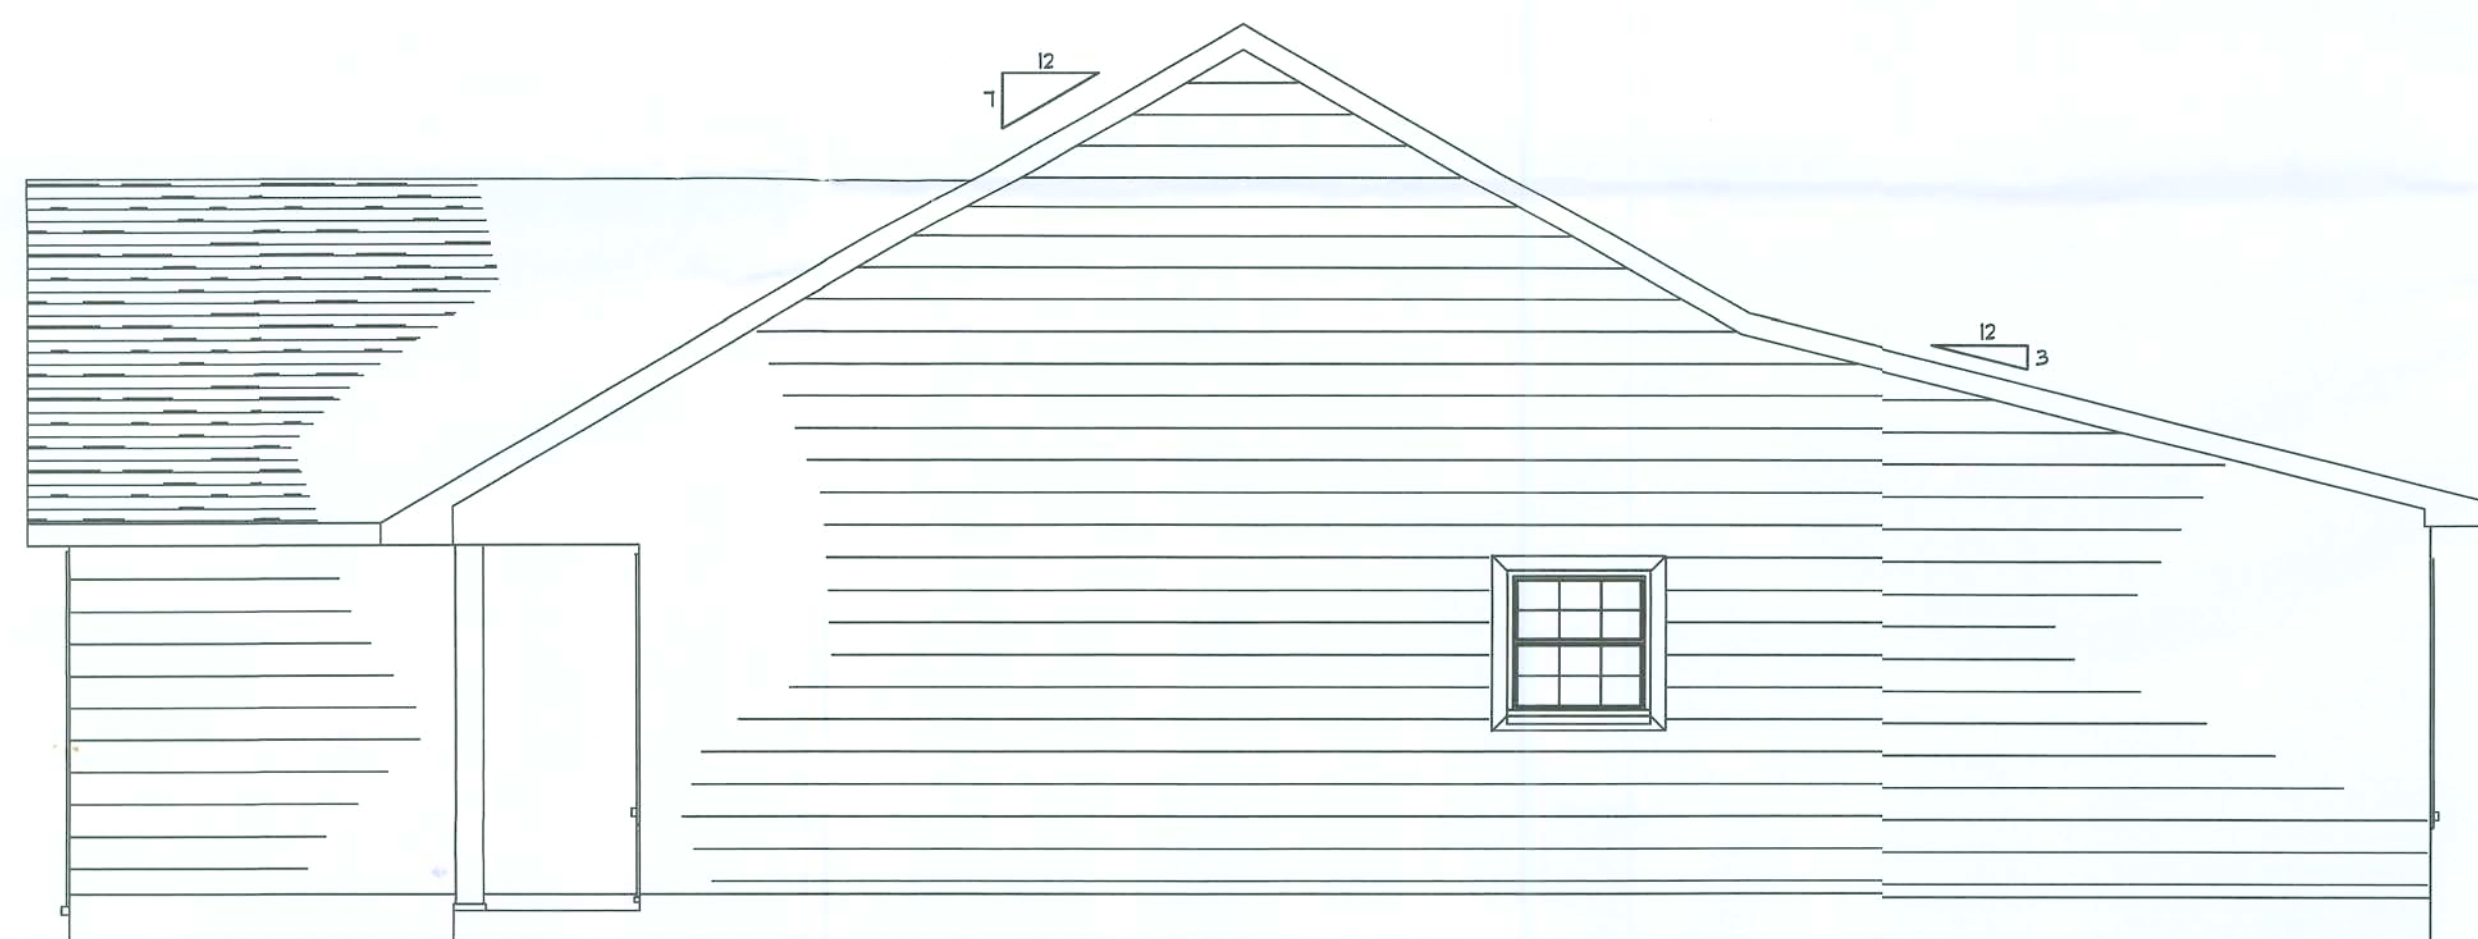

RIGHT ELEVATION

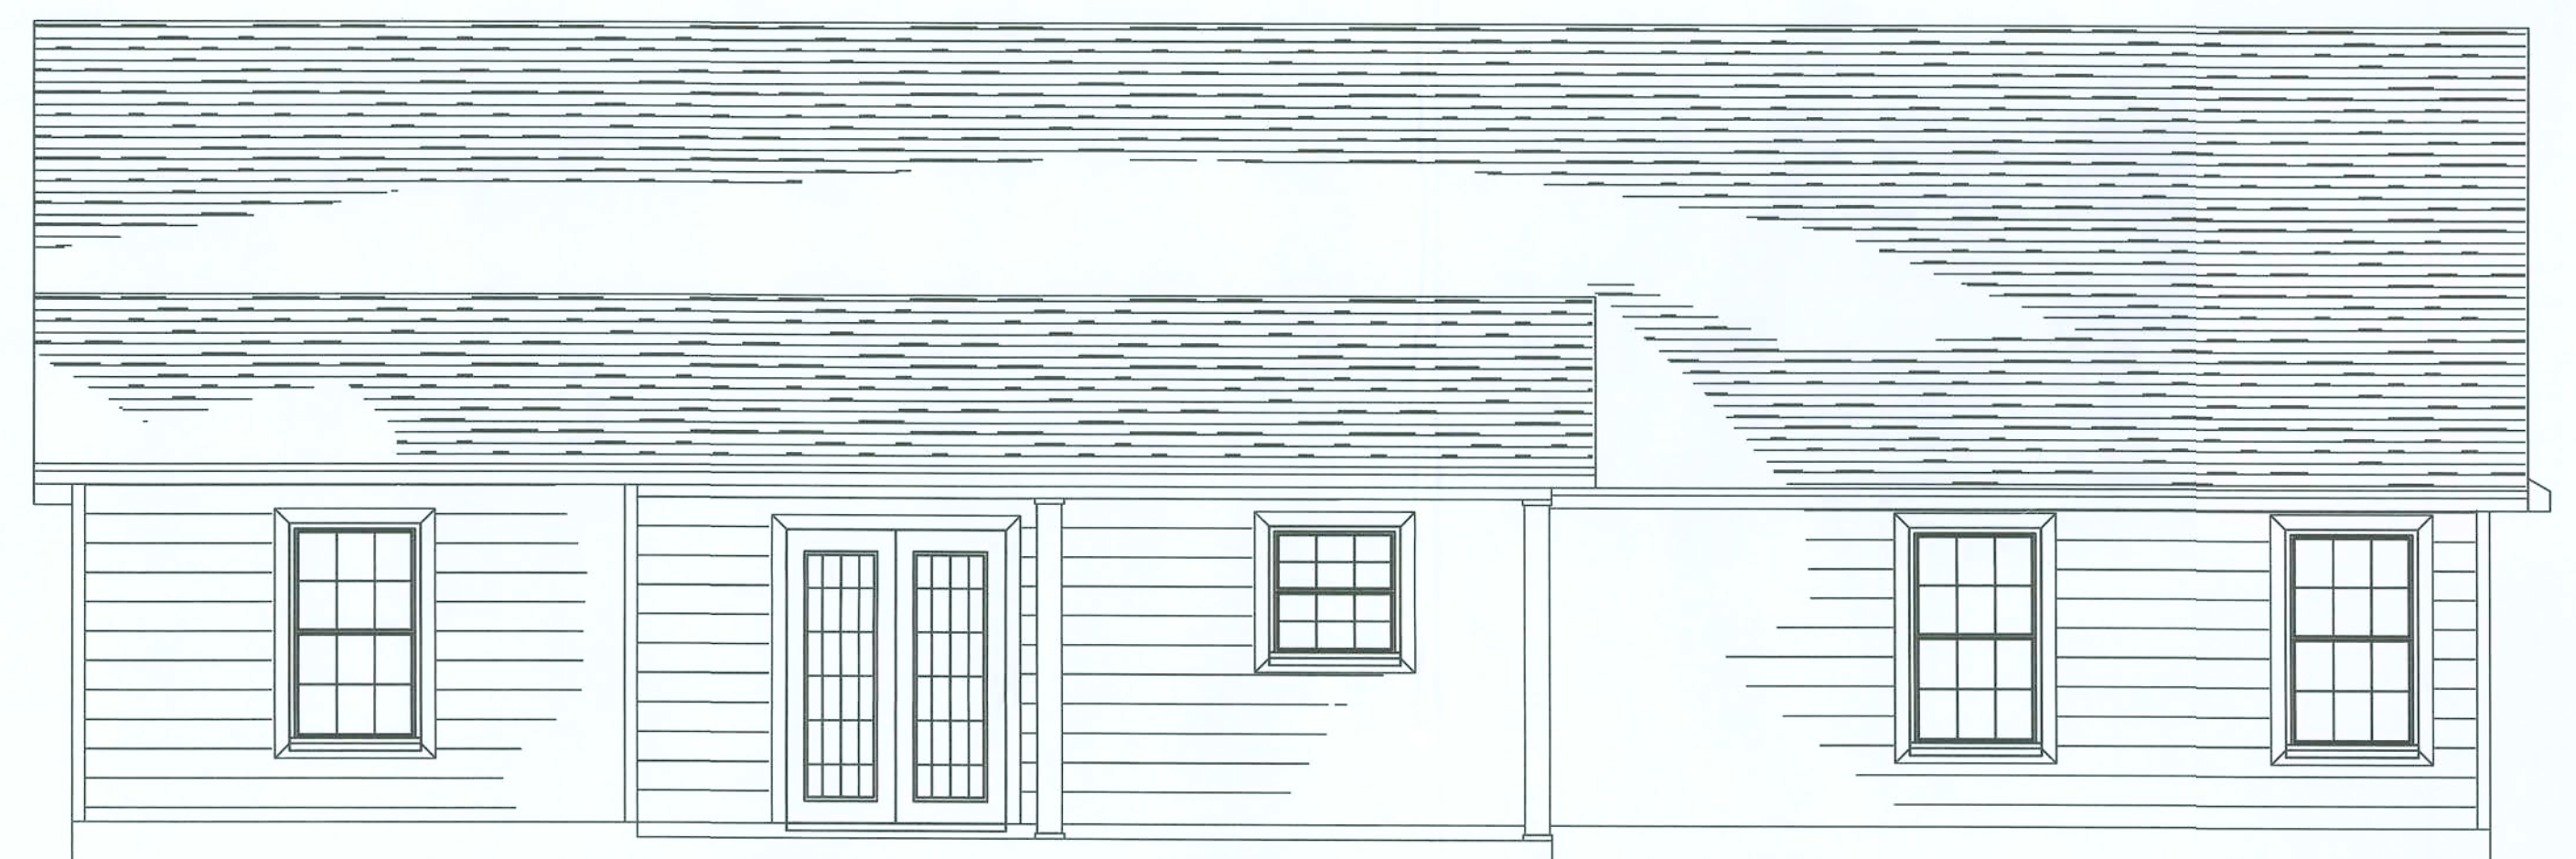

REAR ELEVATION

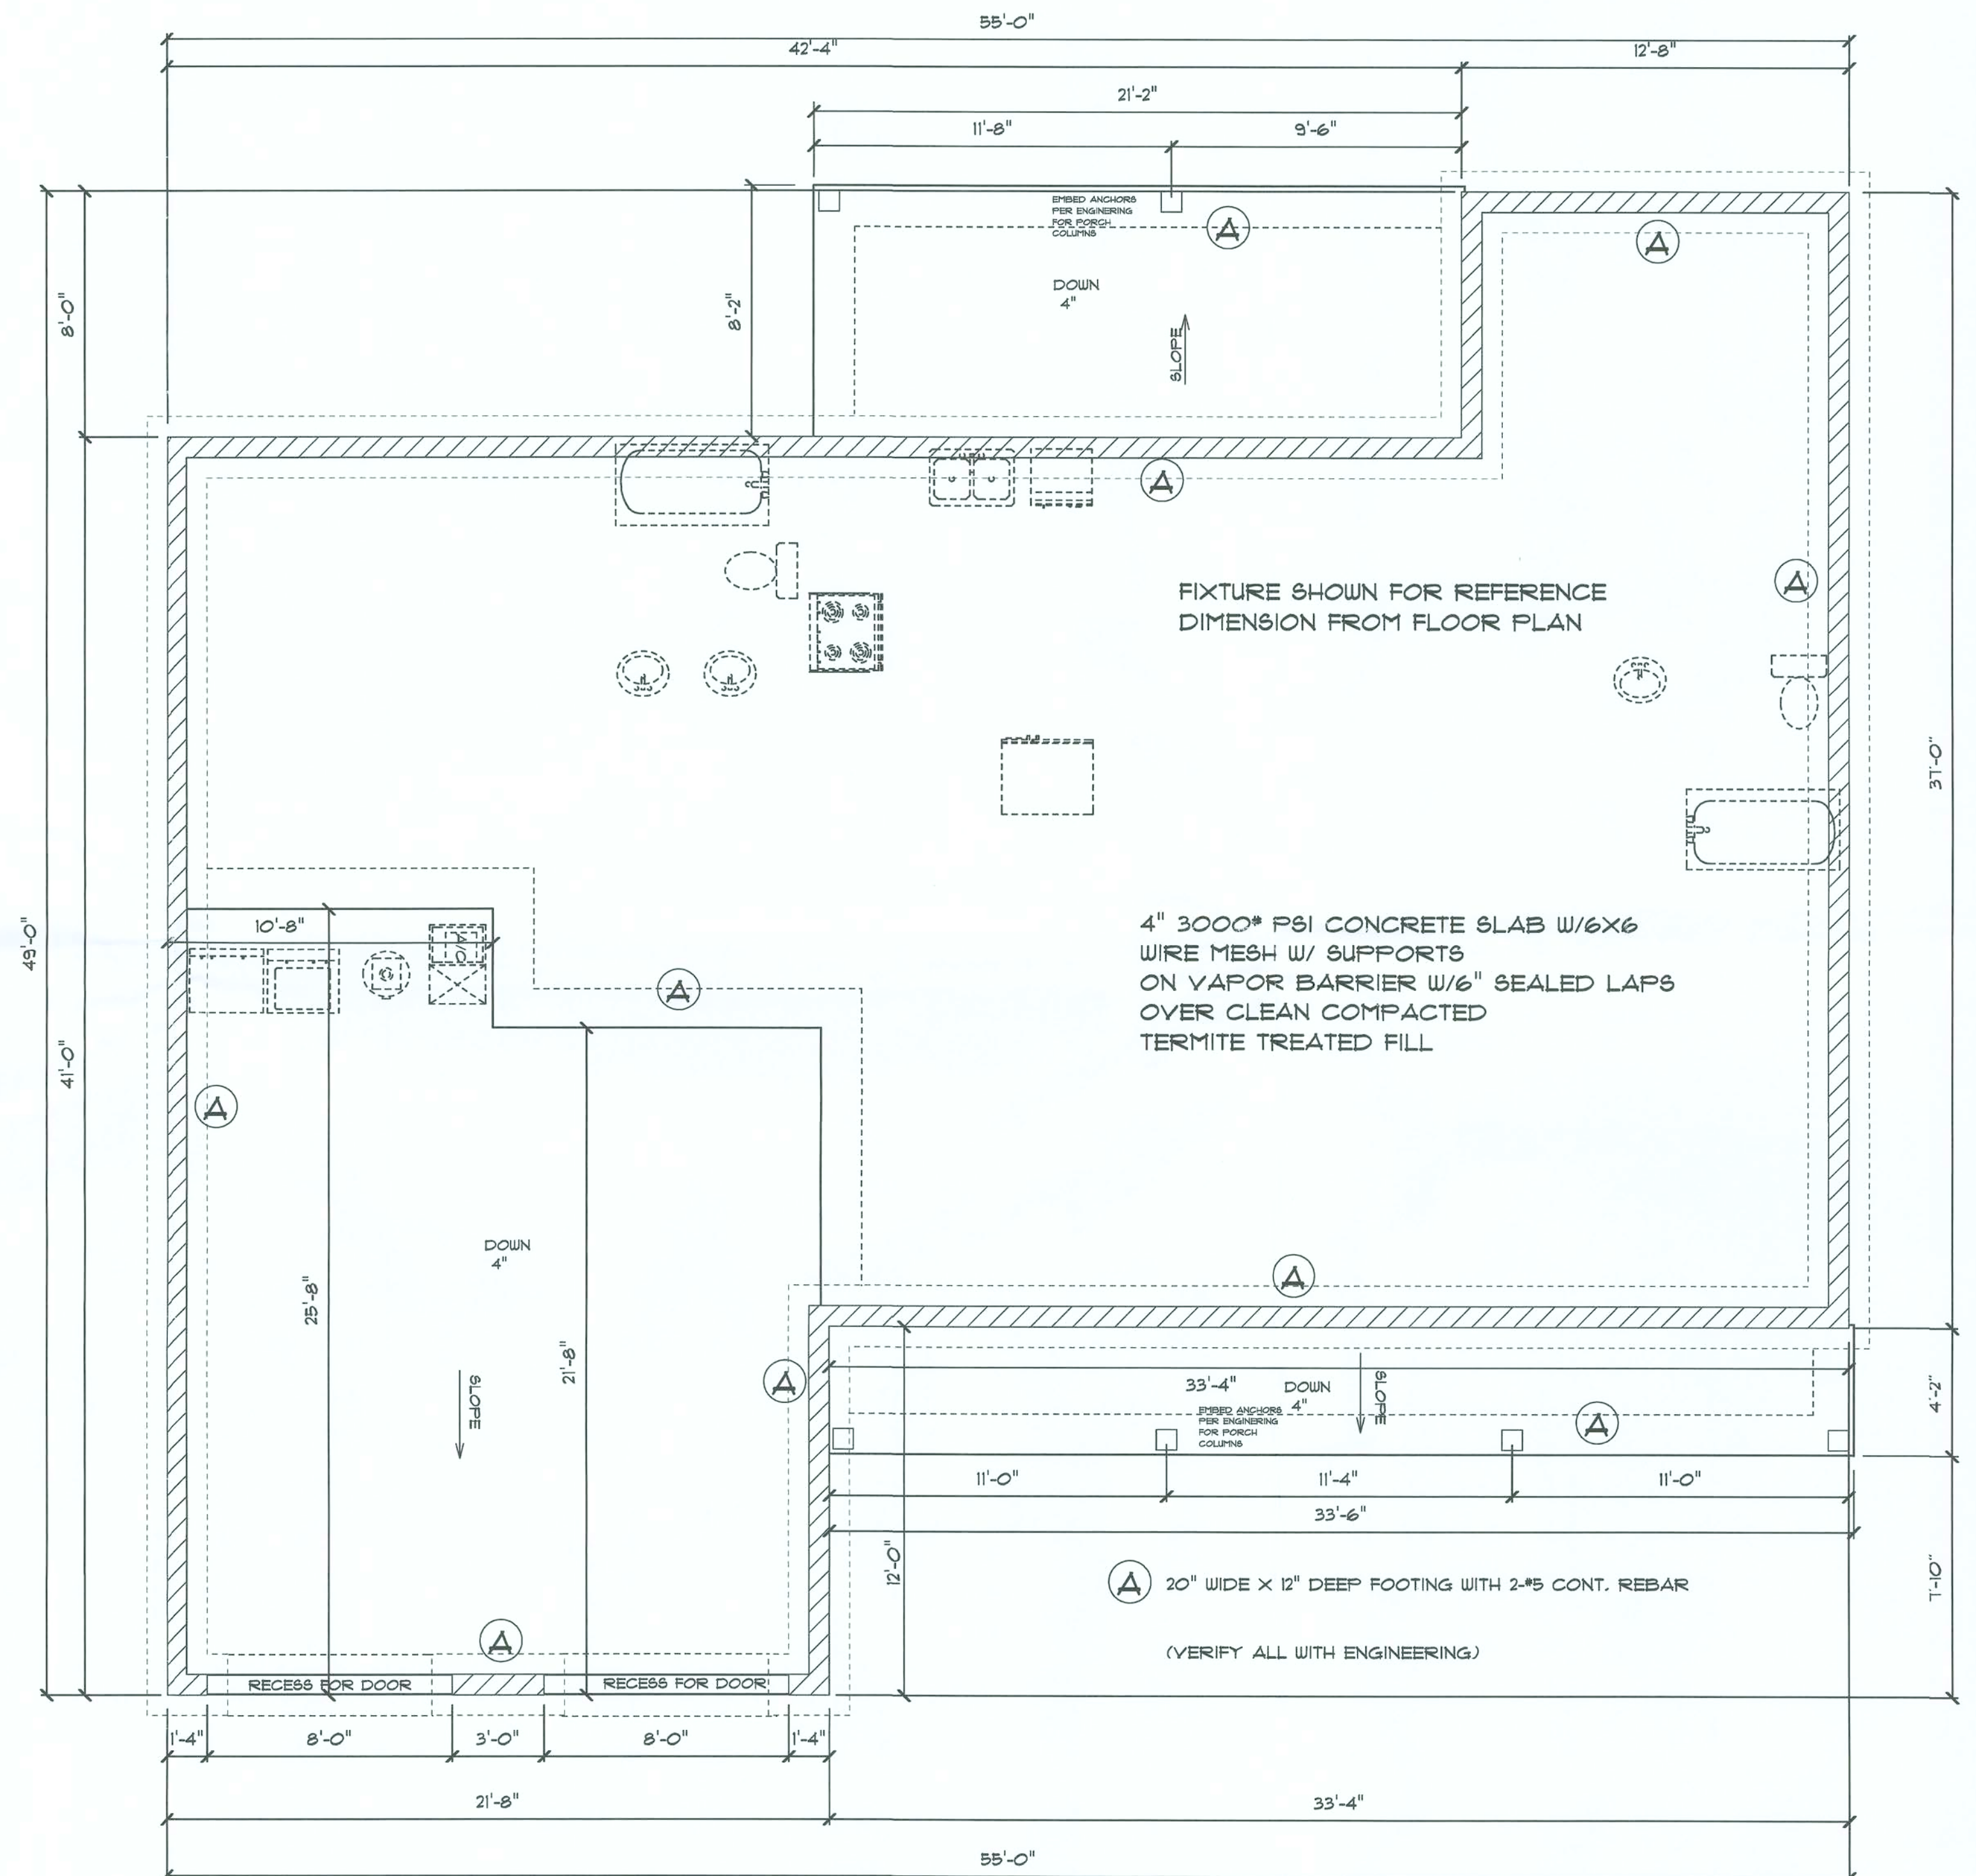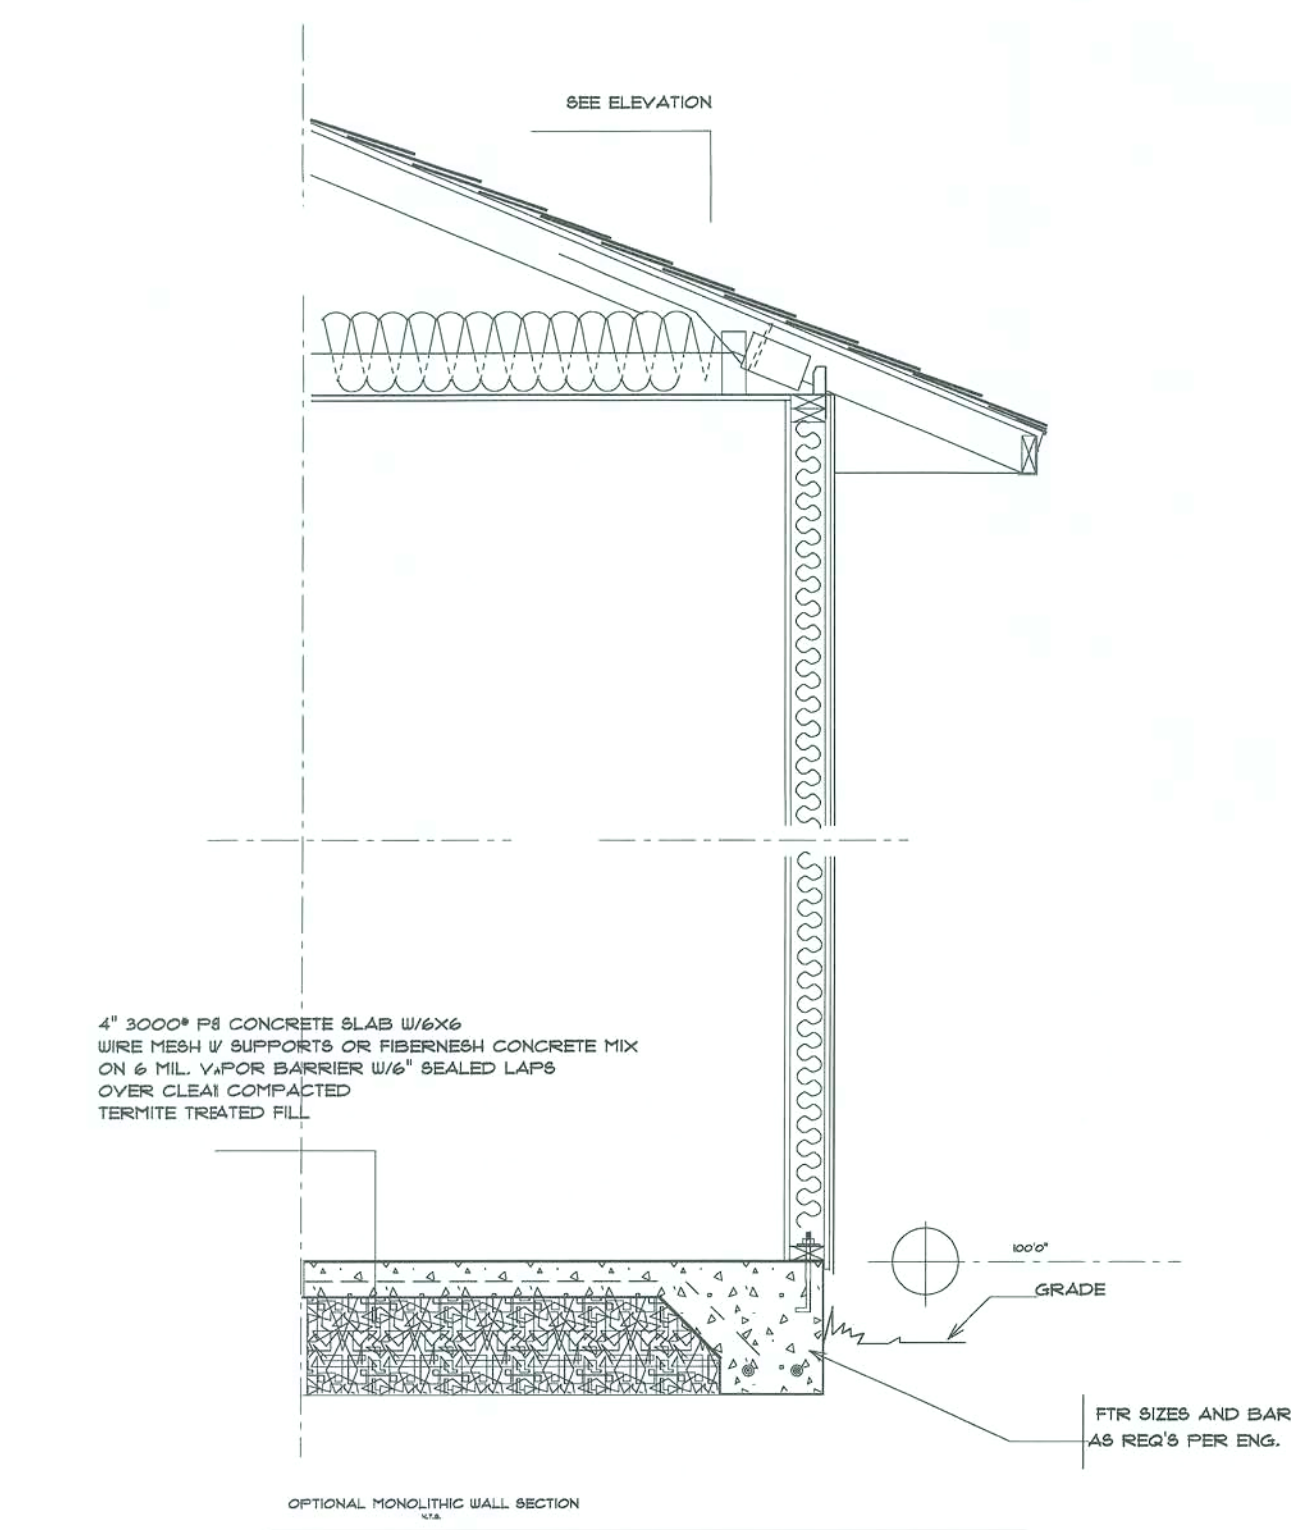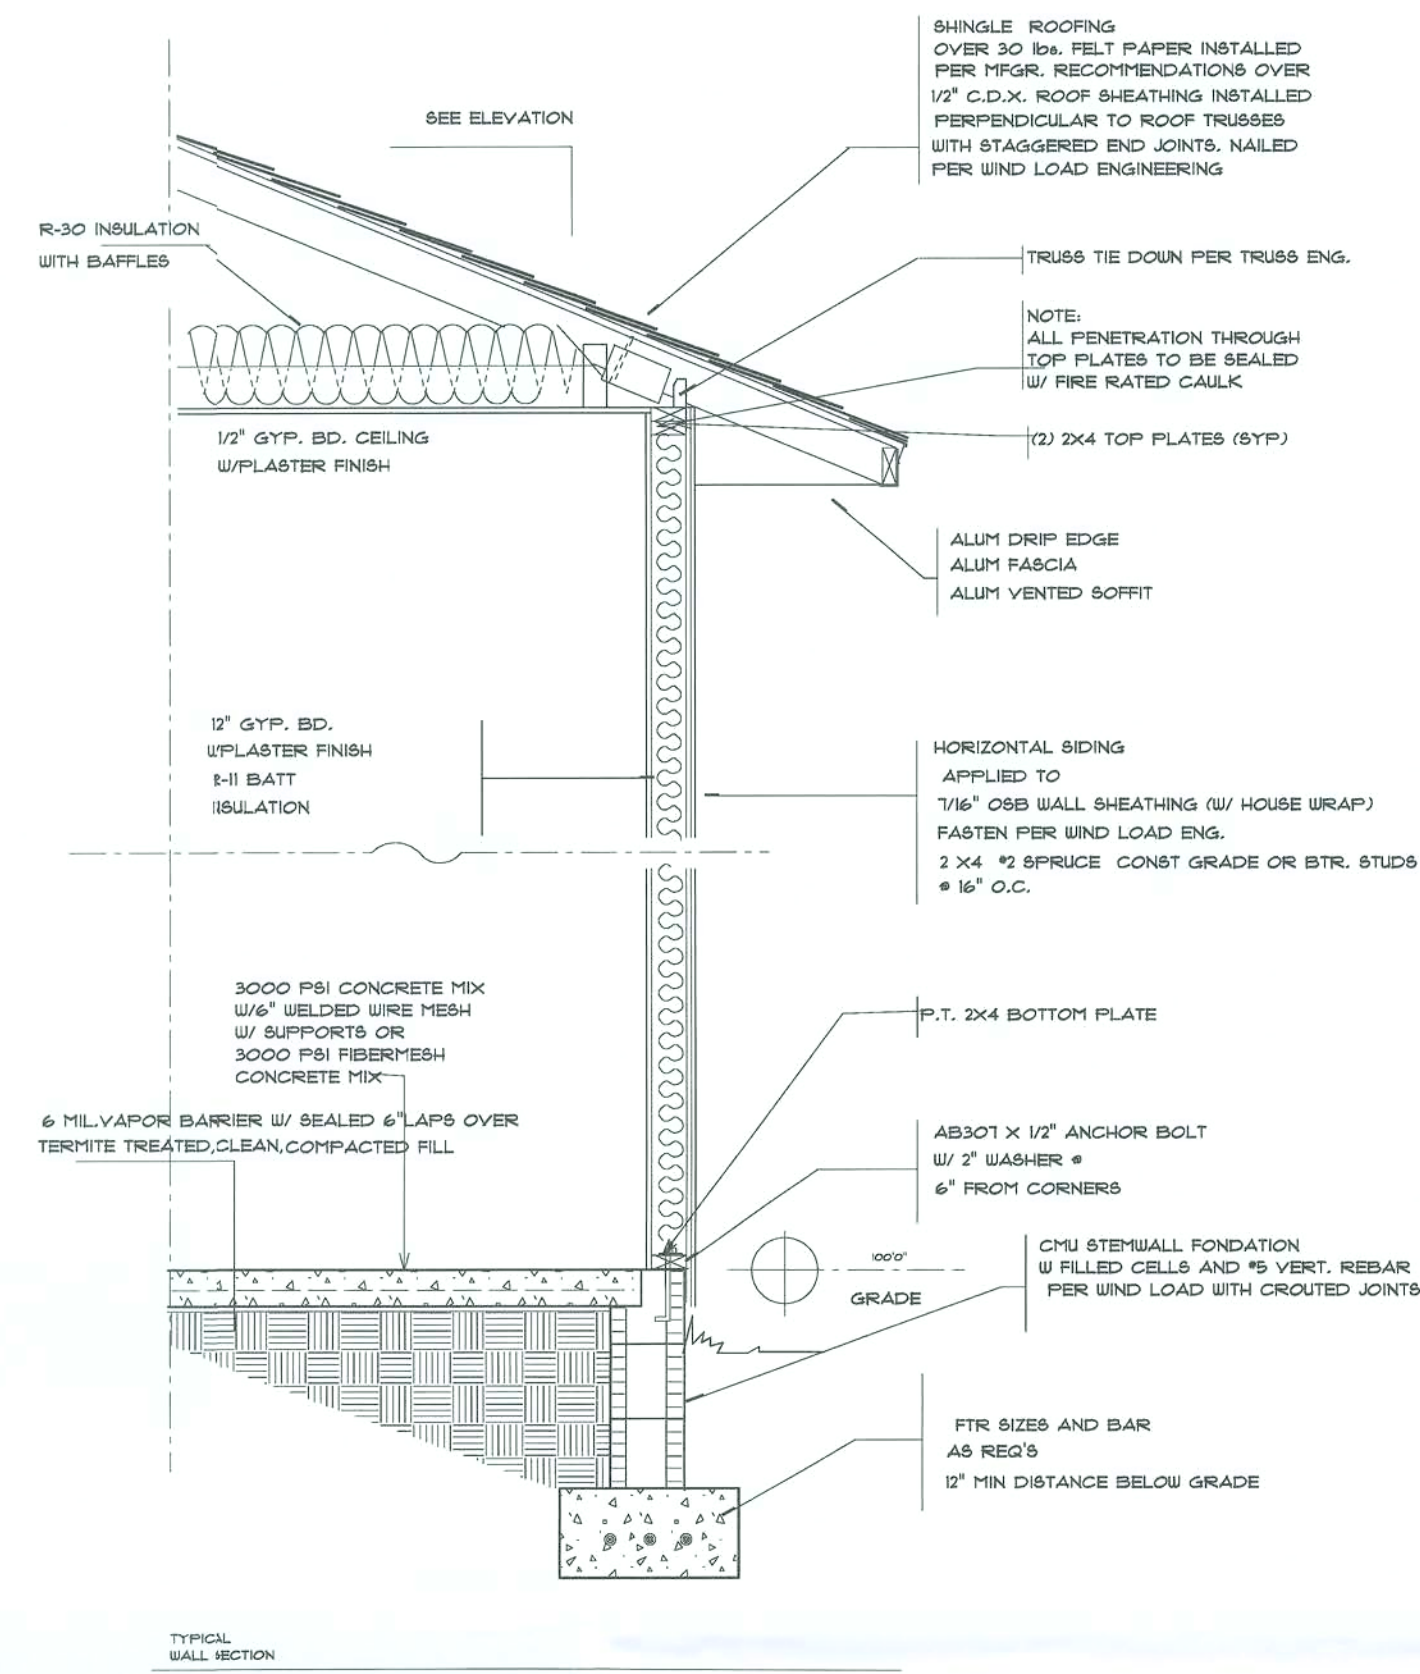

FOUNDATION PLAN

[illegible]


ELECTRICAL PLAN

ELECTRICAL SYMBOLS	
OUTLET	
220 OUTLET	
SWITCH	
LIGHT	
RECESS LIGHT	
PULL CHAIN	
FLUORESCENT	
CEILING FAN	
WALL MOUNT LIGHT	
VANITY LIGHT	
FLOOD LIGHT	
CLG. LITE/FAN	
PANEL	
SMOKE DETECTOR	

SMOKE DETECTORS TO BE 110 WIRED
W/ BATTERY BACK UP AS REQUIRED BY CODE

HEADER SPANS (FT-IN)		BUILDING WIDTH (FT)					
		30		38		46	
		SPAN	NJ	SPAN	NJ	SPAN	NJ
2-2X4	3-6	1	3-2	1	2-10	1	
2-2X6	5-5	1	4-8	1	4-2	1	
2-2X8	6-10	1	5-11	2	5-4	2	
2-2X10	8-5	2	7-3	2	6-6	2	
2-2X12	9-9	2	8-5	2	7-6	2	
3-2X8	8-4	1	7-5	1	6-8	1	
3-2X10	10-6	1	9-1	2	8-2	2	
3-2X12	12-2	2	10-7	2	9-5	2	
4-2X8	9-2	1	8-4	1	7-6	1	
4-2X10	11-8	1	10-6	1	9-5	2	
4-2X12	14-1	1	12-2	2	10-11	2	

Overcurrent protection device shall be installed on the exterior of structures to serve as a disconnecting means. Conductors used from the exterior disconnecting means to a panel or sub panel shall have four-wire conductors, of which one conductor shall be used as an equipment ground.

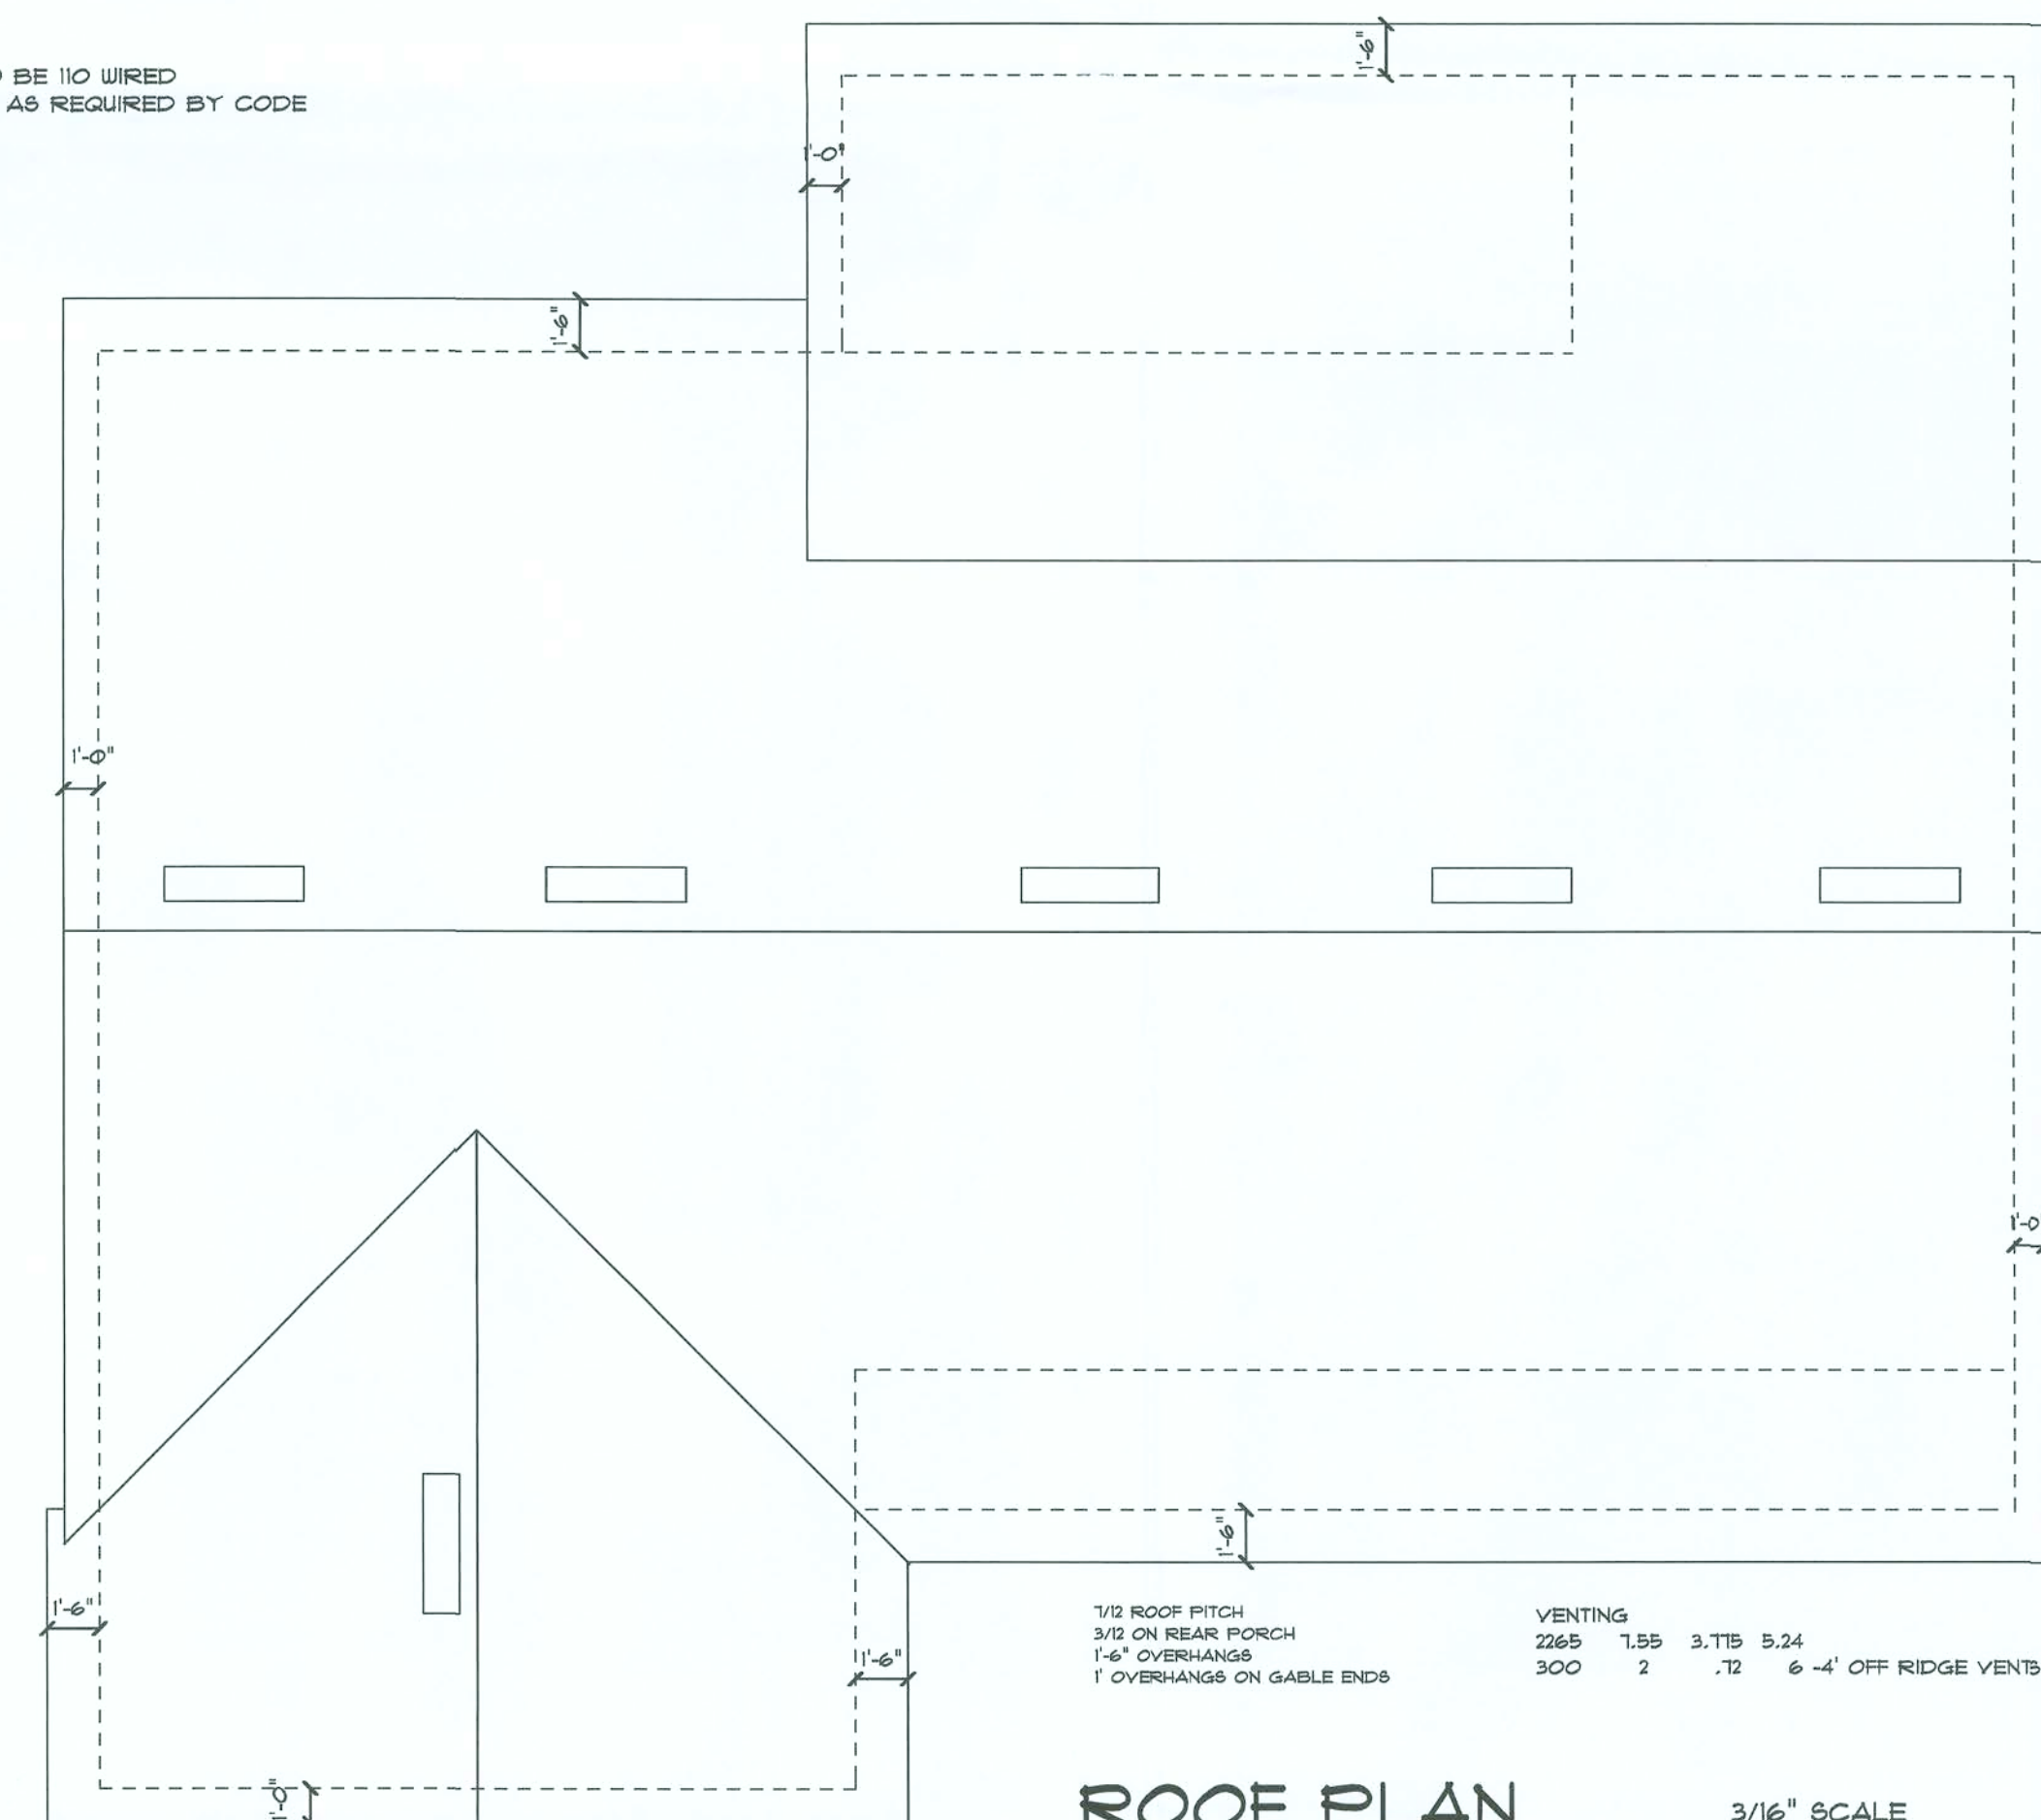

ROOF PLAN

3/16" SCALE