


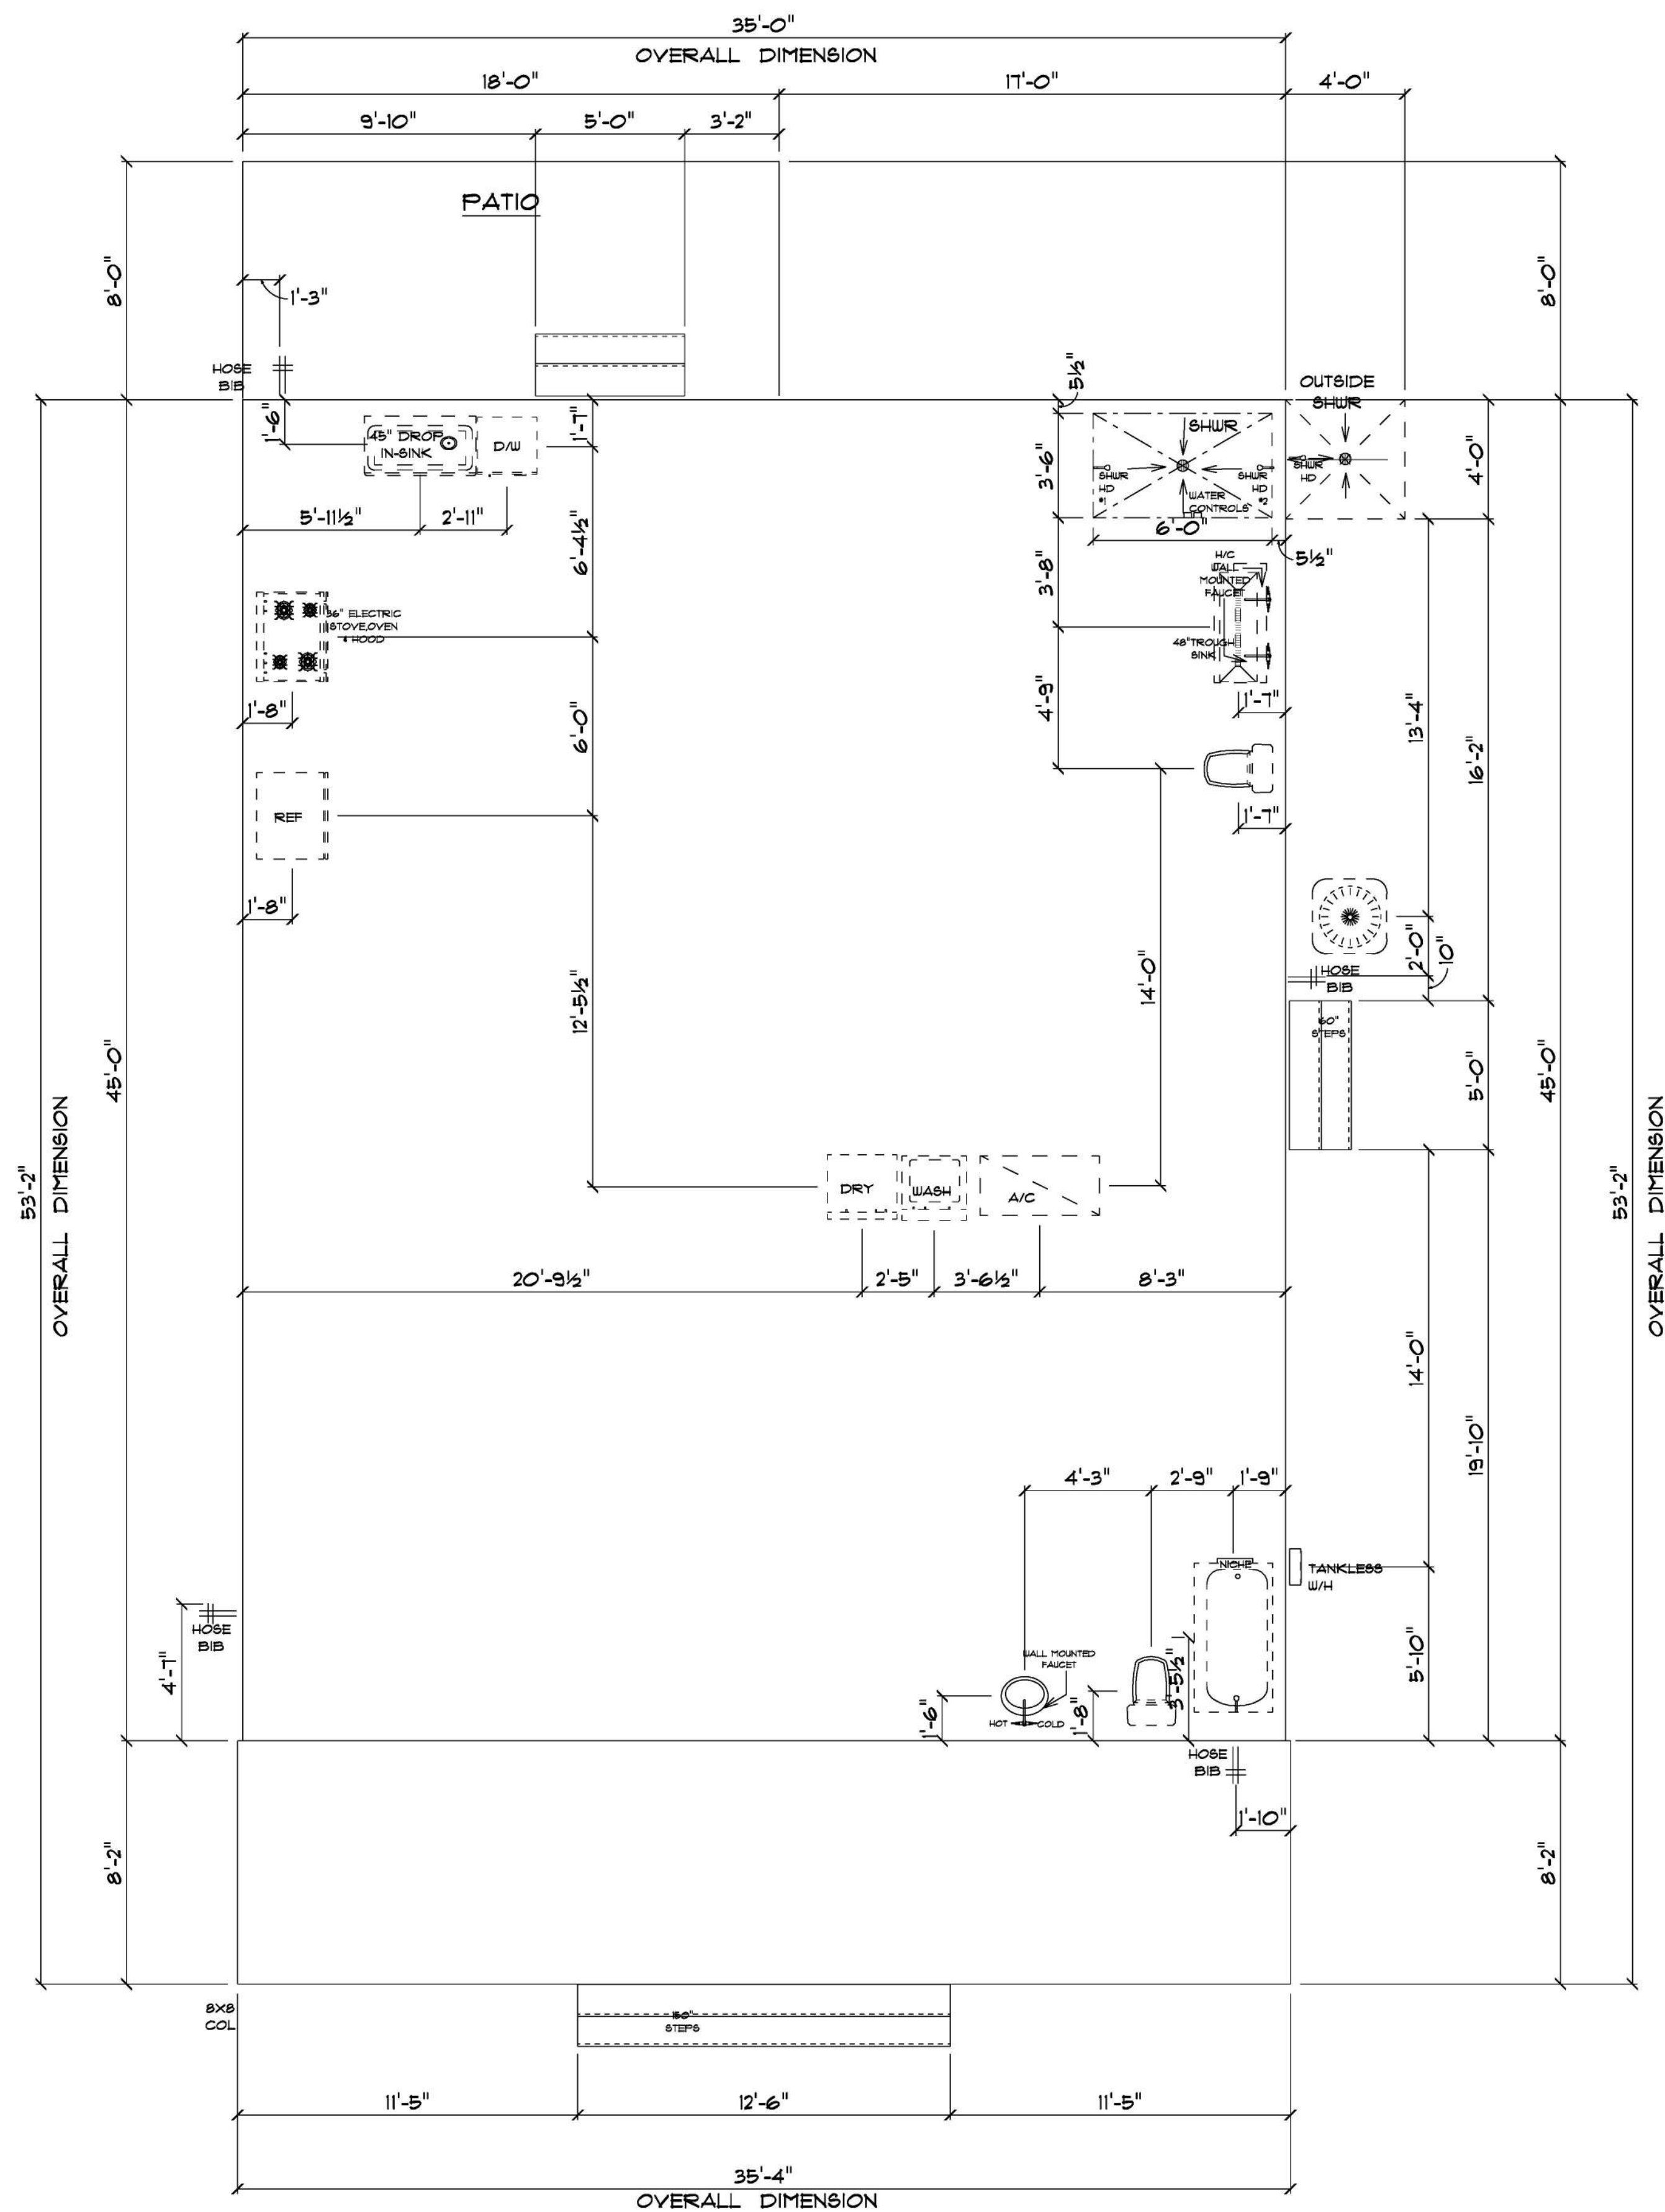

* PLUMBING *
* FOUNDATION PLAN *

SCALE : 1/4" = 1'-0"

IMPORTANT NOTES:
1. IT IS THE BUILDER'S RESPONSIBILITY TO VERIFY ALL GEOMETRY AND DIMENSIONS BEFORE ORDERING ANY MATERIALS OR BEGINNING CONSTRUCTION.
2. THESE PLANS ARE FOR LAYOUT AND DESIGN PURPOSES ONLY. ALL STRUCTURAL NOTES AND DETAILS TO BE PROVIDED BY AN ENGINEER.

RESIDENCE
for
SANDRA
TAN

429 SW RIVERSIDE AVE
FORT WHITE, FLORIDA
32038

Teena M. Ruffo
2925 SW 8R 41
Lake City Florida, 32025
Cell: (386) 861-1191
Email: teenaruffo@gmail.com

PRINTED DATE:
Friday, December 23, 2022

DRAWN BY: Teena M. Ruffo
CHECKED BY:


BUILDING CONTRACTOR
PLUMB LEVEL CONSTRUCTION

FINAL DATE:

JOB NUMBER:

DRAWING NUMBER
A-2

OF 6 SHEET(S)

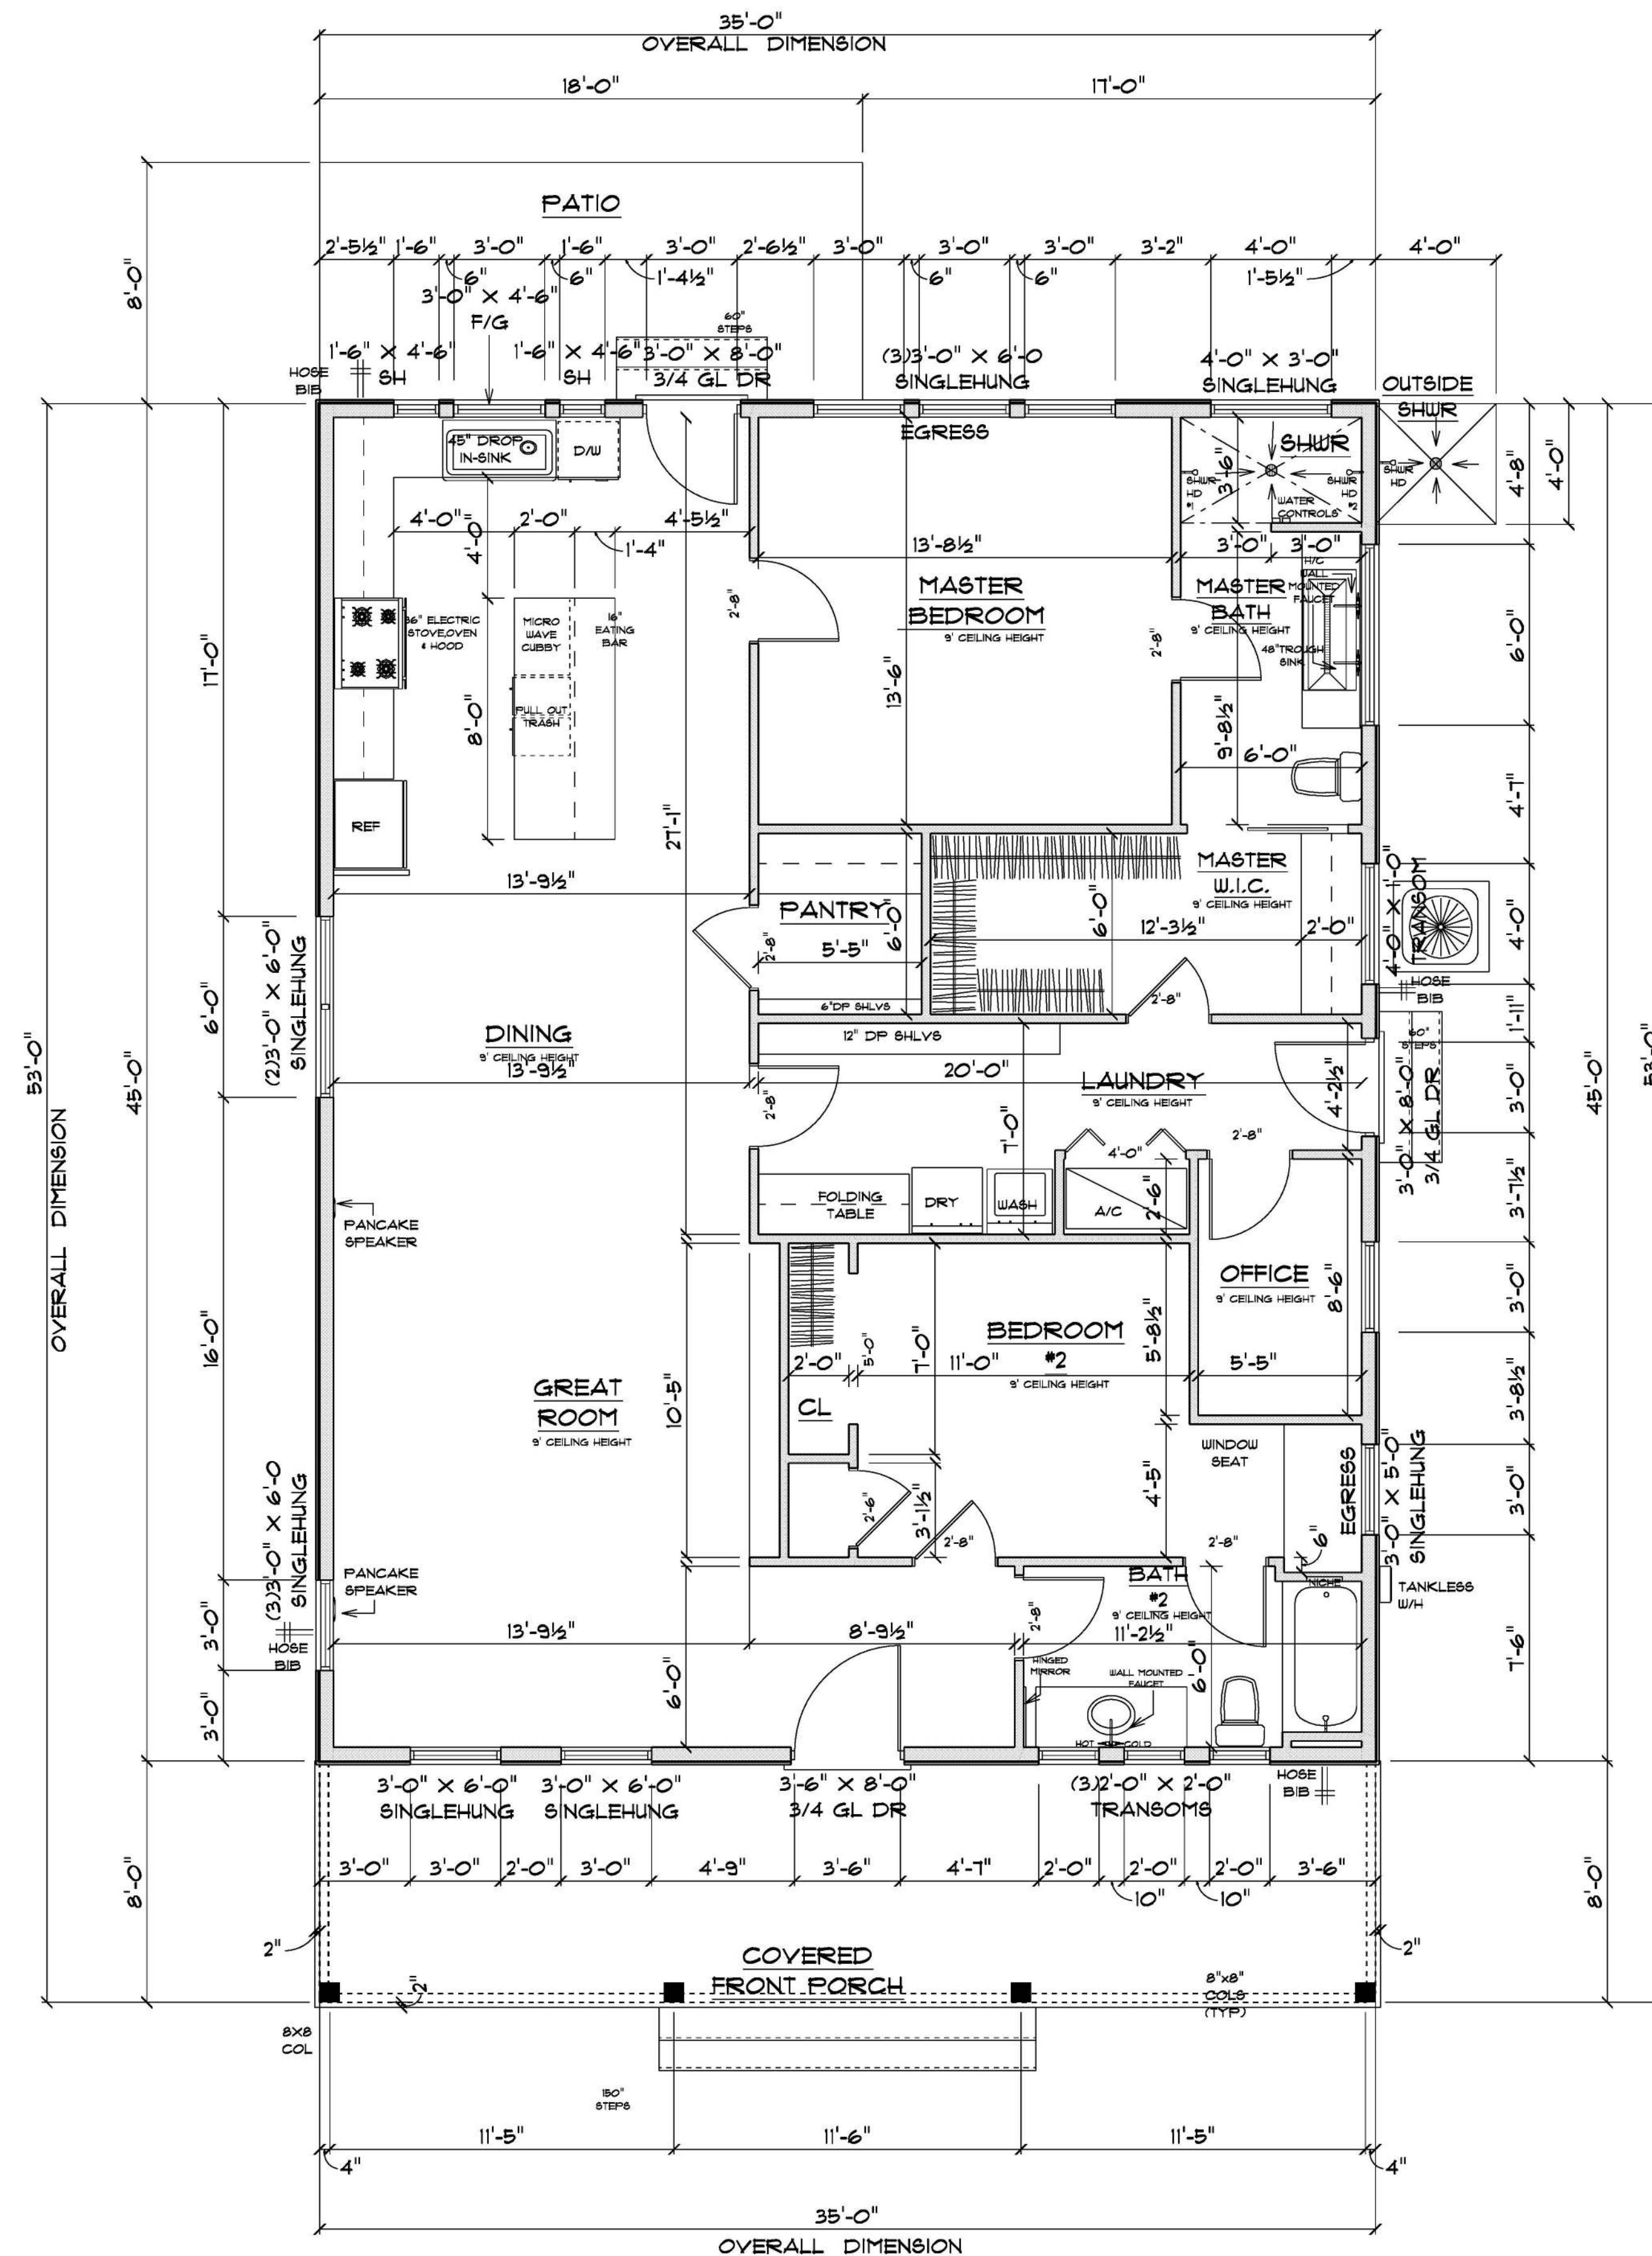

* FLOOR PLAN *

SCALE : 1/4" = 1'-0"

A/C LIVING AREA	= 1,575 S.F.
COVERED PORCH	= 268 S.F.
TOTAL AREA UNDER ROOF	= 1,843 S.F.

IMPORTANT NOTES:
1. IT IS THE BUILDERS RESPONSIBILITY TO VERIFY ALL GEOMETRY AND DIMENSIONS BEFORE ORDERING ANY MATERIALS OR BEGINNING CONSTRUCTION.
2. THESE PLANS ARE FOR LAYOUT AND DESIGN PURPOSES ONLY ALL STRUCTURAL NOTES AND DETAILS TO BE PROVIDED BY AN ENGINEER.

RESIDENCE
for
SANDRA
TAN

429 SW RIVERSIDE AVE
FORT WHITE, FLORIDA
32038

Teena M. Ruffo
2925 SW 8R 47
Lake City Florida, 32025
Cell: (386) 861 - 1191
Email: teenaruffo@gmail.com

PRINTED DATE:
Friday, December 23, 2022

DRAWN BY: Teena M. Ruffo
CHECKED BY:

BUILDING CONTRACTOR
PLUMB LEVEL CONSTRUCTION


FINAL DATE:

JOB NUMBER:

DRAWING NUMBER


A-3

OF 6 SHEET(S)

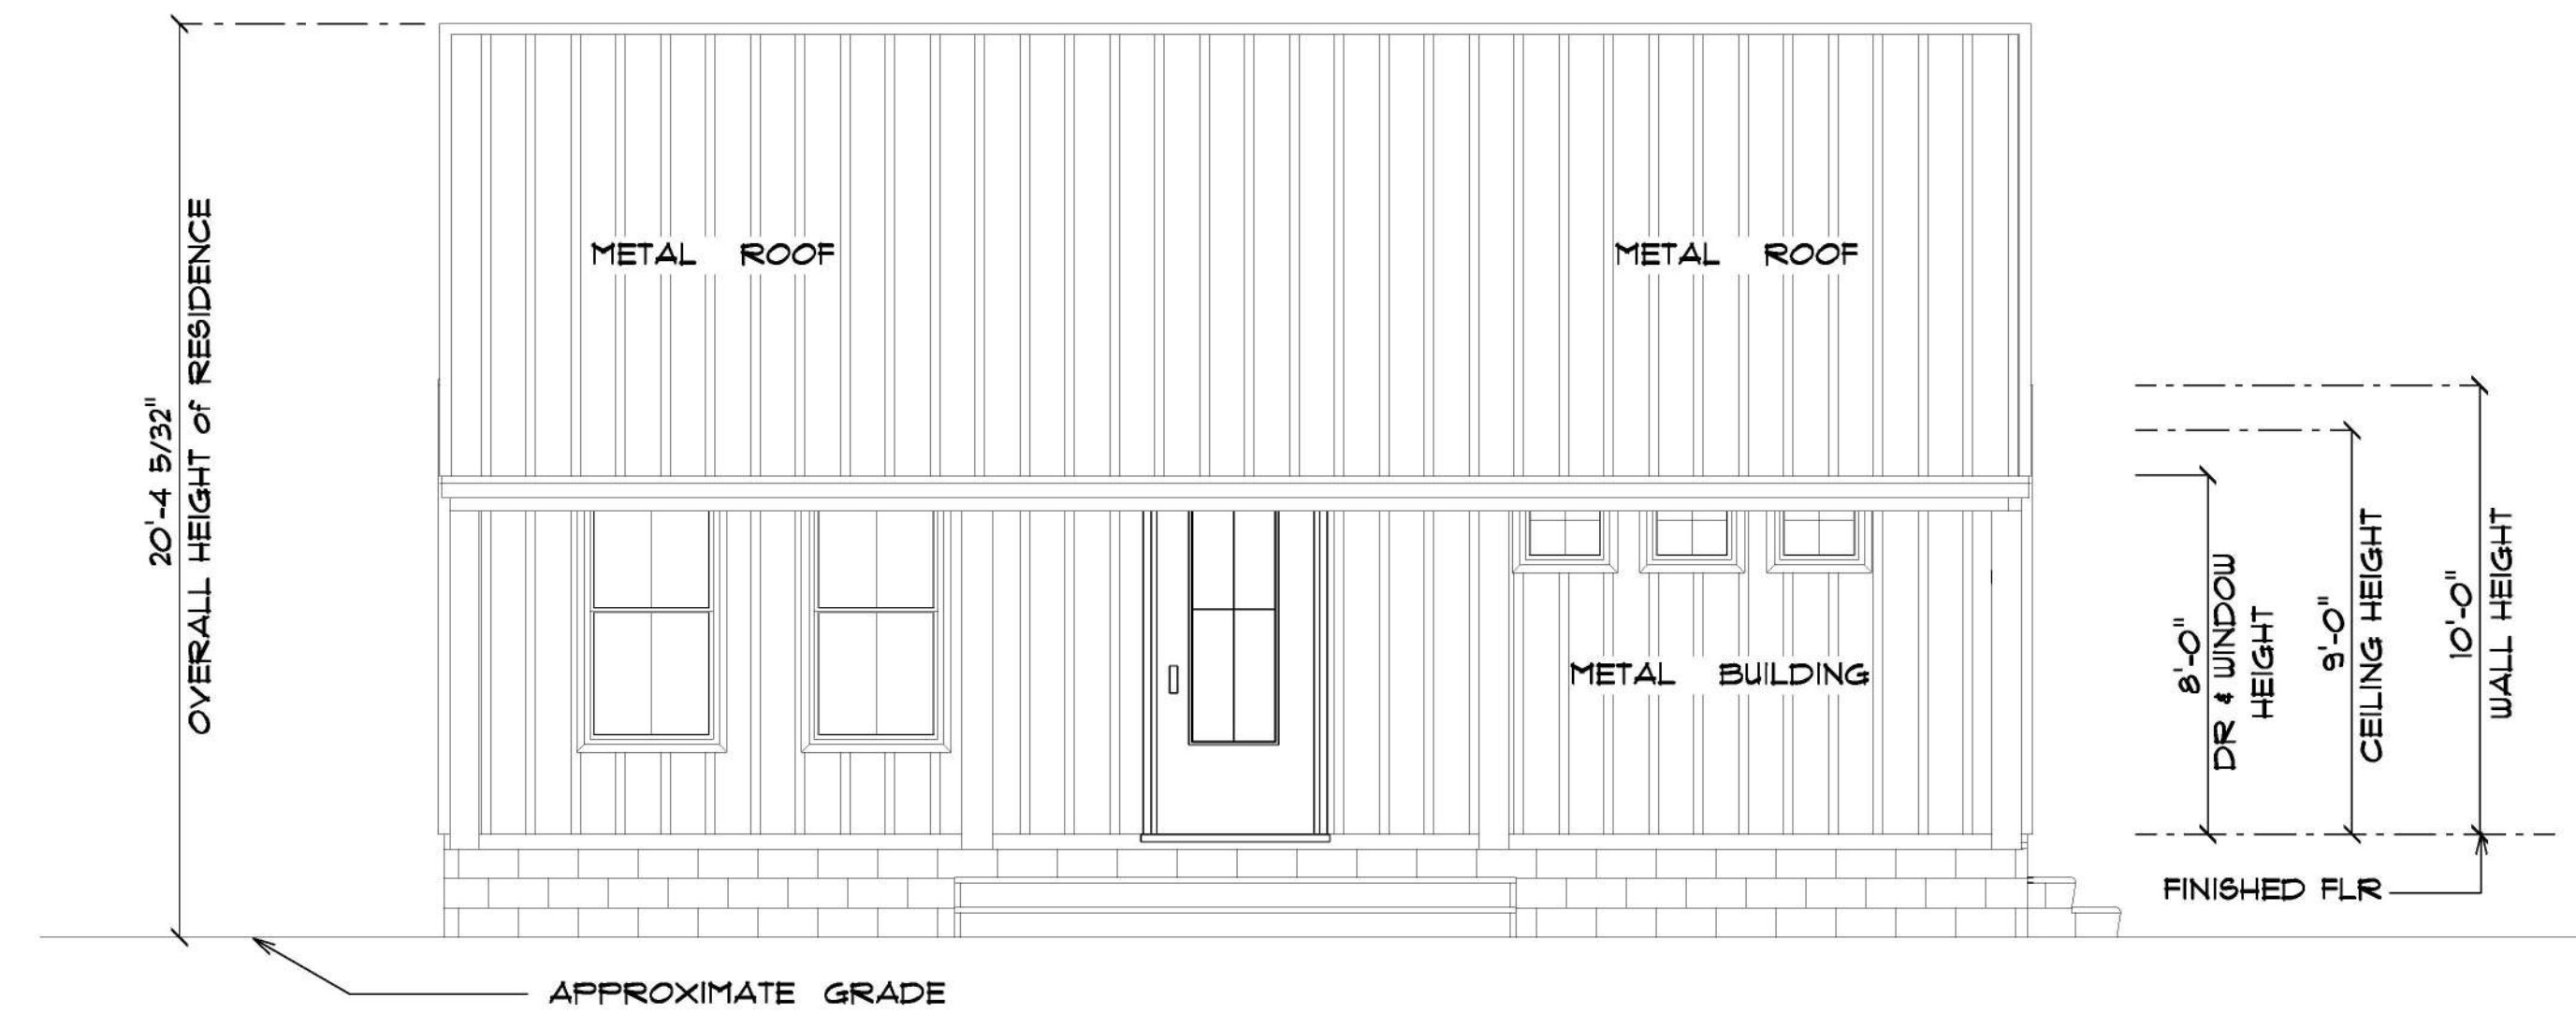

* FRONT ELEVATION *

SCALE : 1/4" = 1'-0"

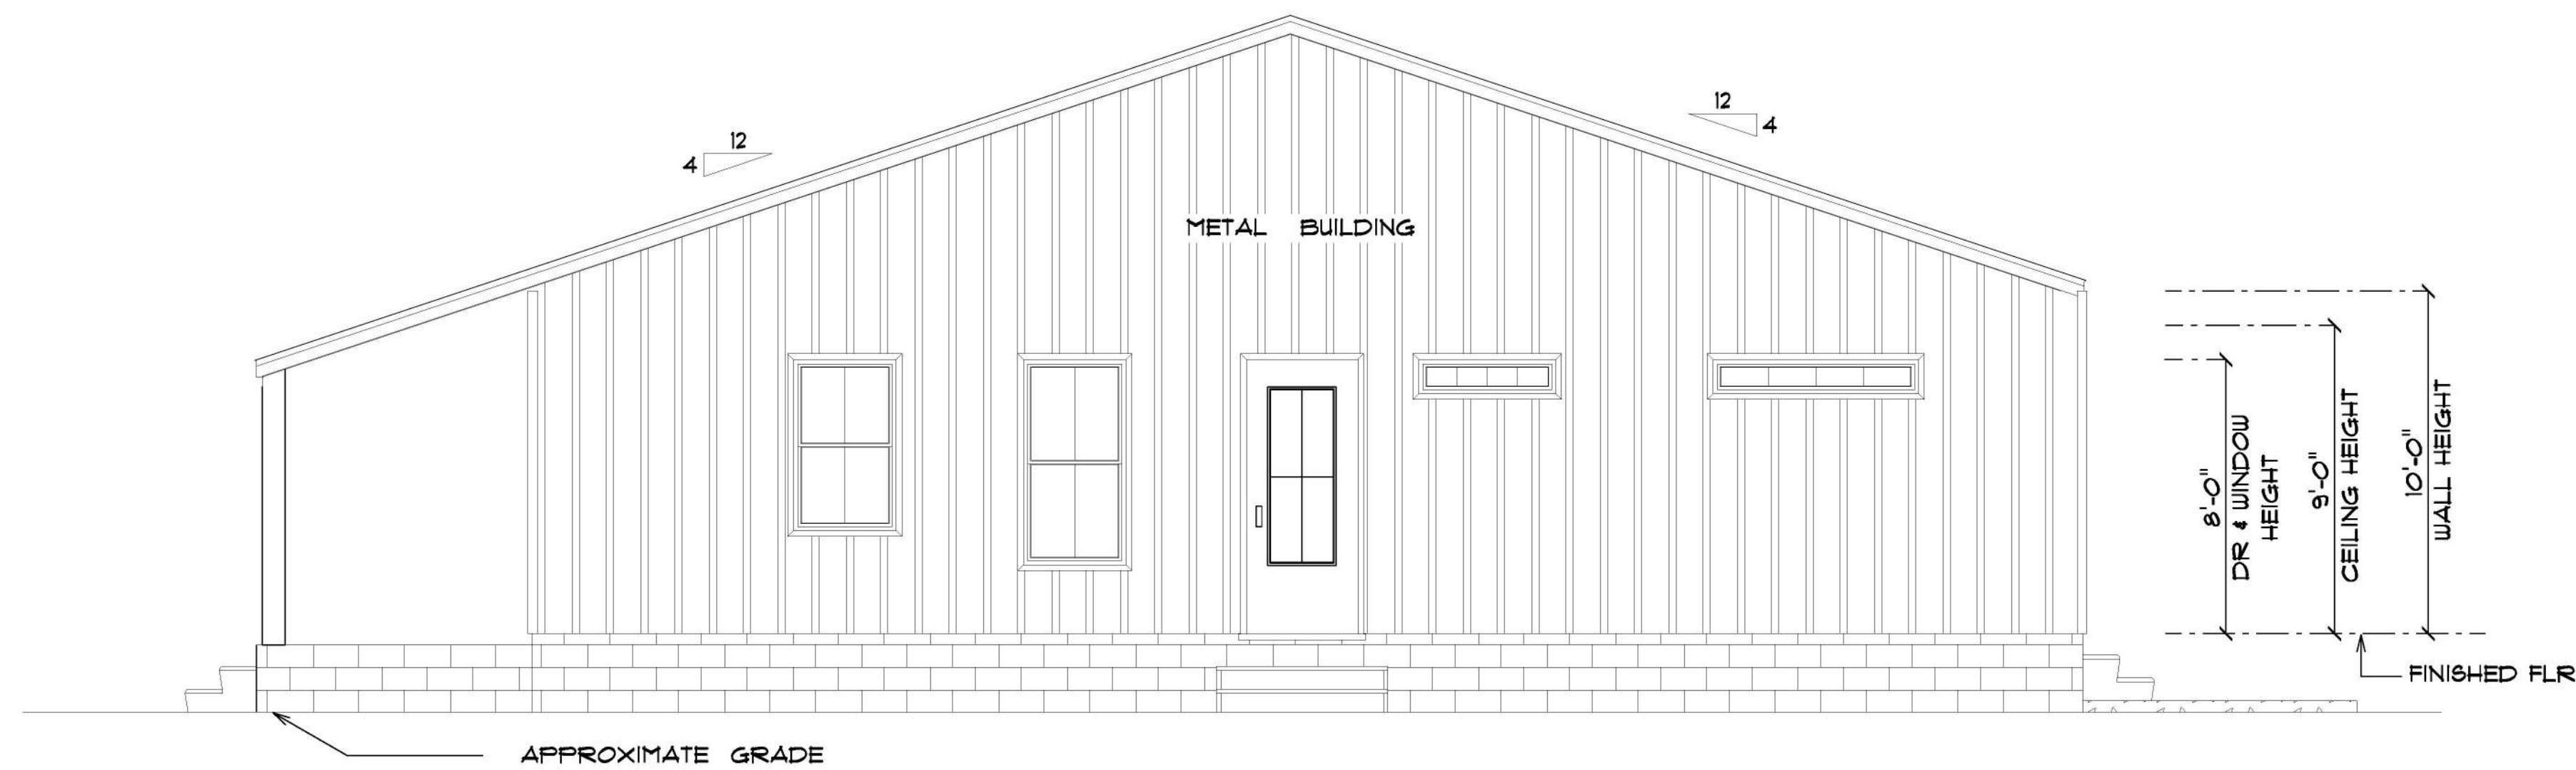

* RIGHT ELEVATION *

SCALE : 1/4" = 1'-0"

RESIDENCE
for
SANDRA
TAN

429 SW RIVERSIDE AVE
FORT WHITE, FLORIDA
32038

Teena M. Ruffo
2925 SW SR 47
Lake City Florida, 32025
Cell: (386) 867 - 1191
Email: teenaruffo@gmail.com

PRINTED DATE:
Friday, December 23, 2022

DRAWN BY: Teena M. Ruffo CHECKED BY:

BUILDING CONTRACTOR
PLUMB LEVEL CONSTRUCTION


FINAL DATE:

JOB NUMBER:

DRAWING NUMBER


A-4

OF 6 SHEET(S)

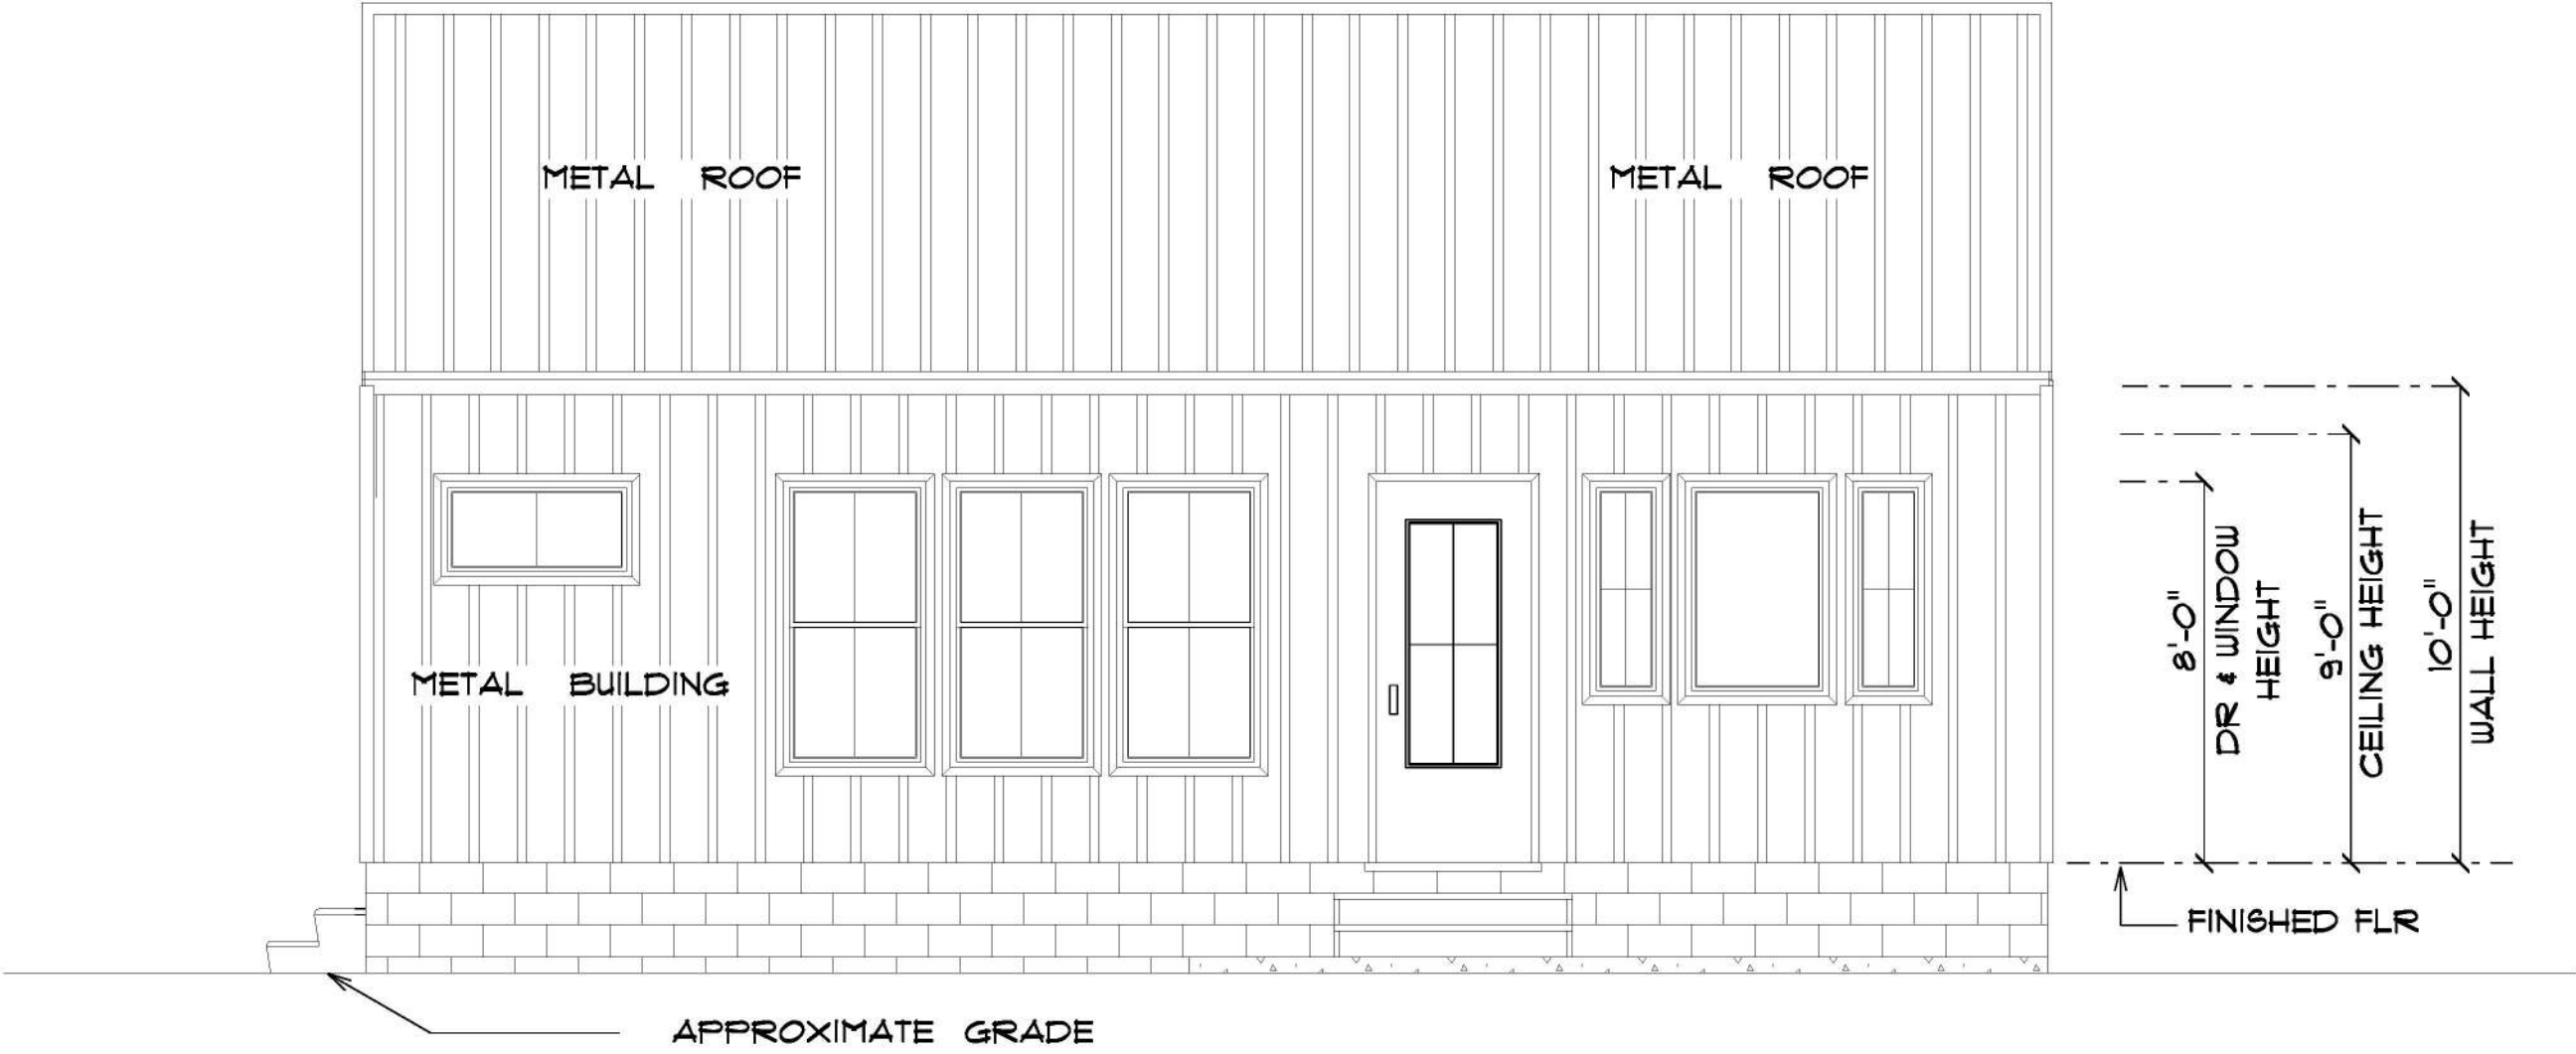

* REAR ELEVATION *

SCALE : 1/4" = 1'-0"

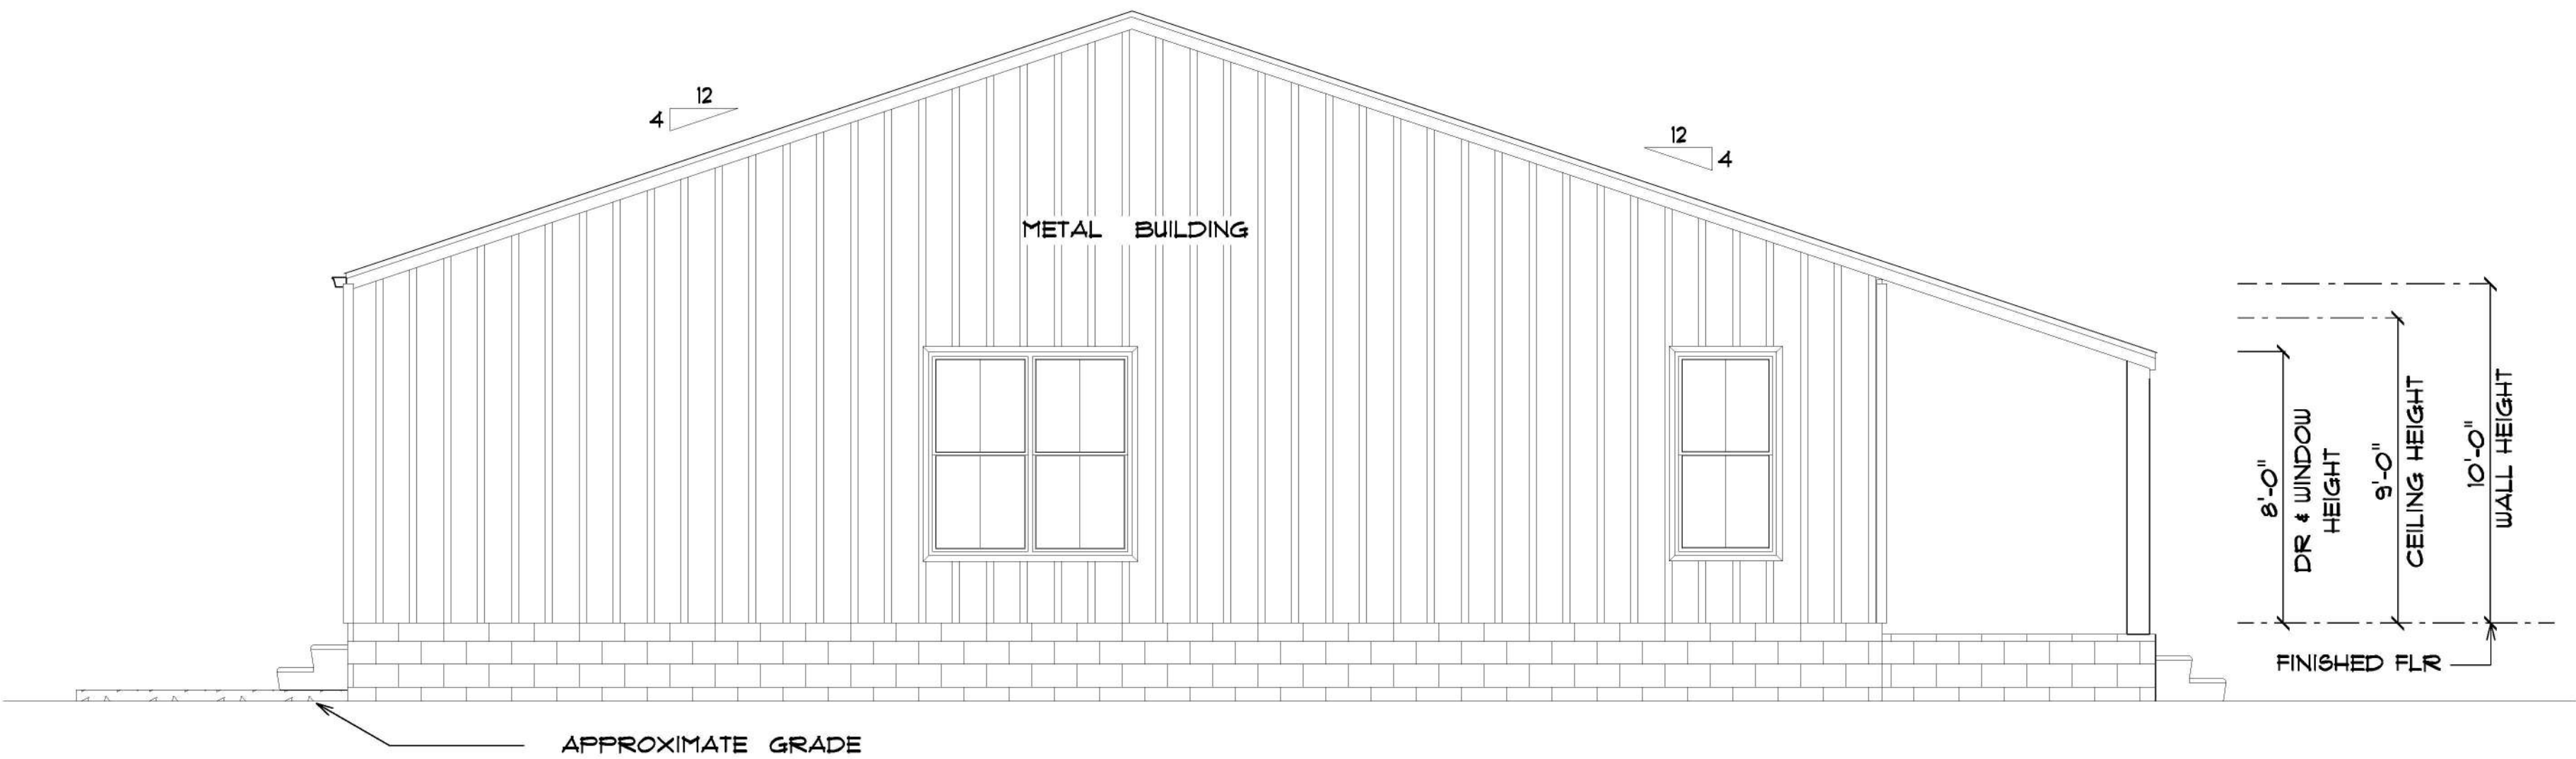

* LEFT ELEVATION *

SCALE : 1/4" = 1'-0"

RESIDENCE
for
SANDRA
TAN

429 SW RIVERSIDE AVE
FORT WHITE, FLORIDA
32038

Teena M. Ruffo
2925 SW SR 47
Lake City Florida, 32025
Cell: (386) 867 - 1191
Email: teenaruffo@gmail.com

PRINTED DATE:
Friday, December 23, 2022

DRAWN BY: Teena M. Ruffo
CHECKED BY:

BUILDING CONTRACTOR
PLUMB LEVEL CONSTRUCTION

FINAL DATE:


JOB NUMBER:

DRAWING NUMBER
A-5
OF 6 SHEET(S)

ELECTRICAL LEGEND		
ELECTRICAL	COUNT	SYMBOL
ceiling fan 4 bladed 01	3	
pendant cube	3	
pot light	12	
spotlight double	2	
wall mount savoy	4	
Smoke Detector	4	
wall sconce	3	
electrical panel	1	
dimmer switch	3	
floor receptacle duplex	1	
light	6	
outlet	31	
outlet 220v	4	
outlet gfi	11	
outlet wp	7	
switch	21	
switch 3 way	6	
vent light combo	2	
wall mounted 03 1 light	3	

ELECTRICAL PLAN NOTES

- E-1 WIRE ALL APPLIANCES, HVAC UNITS AND OTHER EQUIPMENT PER MANUFACTURER'S SPECIFICATIONS.
- E-2 ALL INSTALLATIONS SHALL BE PER NATIONAL ELECTRIC CODE.
- E-3 ALL SMOKE /CARBON MONOXIDE DETECTORS SHALL BE 120V W/BATTERY BACKUP OF THE PHOTOELECTRIC TYPE, AND SHALL BE INTERLOCKED TOGETHER. INSTALL INSIDE AND NEAR ALL BEDROOMS AS PER CODE.
- E-4 TELEPHONE, TELEVISION AND OTHER LOW VOLTAGE DEVICES OR OUTLETS SHALL BE AS PER THE OWNER'S DIRECTION AND IN ACCORDANCE WITH APPLICABLE SECTIONS OF NATIONAL ELCT. CODE LATEST EDITION.
- E-5 ELECTRICAL CONTRACTOR SHALL BE RESPONSIBLE FOR THE DESIGN AND SIZING OF ELECTRICAL SERVICE AND CIRCUITS.
- E-6 ENTRY OF SERVICE UNDERGROUND OR OVERHEAD) IS TO BE DETERMINED BY THE POWER COMPANY.
- E-7 ALL BEDROOM RECEPTALS ARE TO BE AFCI (ARC FAULT CIRCUIT INTERRUPT)
- E-8 75% OF ALL PERMANENT LIGHTS TO BE ENERGY EFFICIENT.

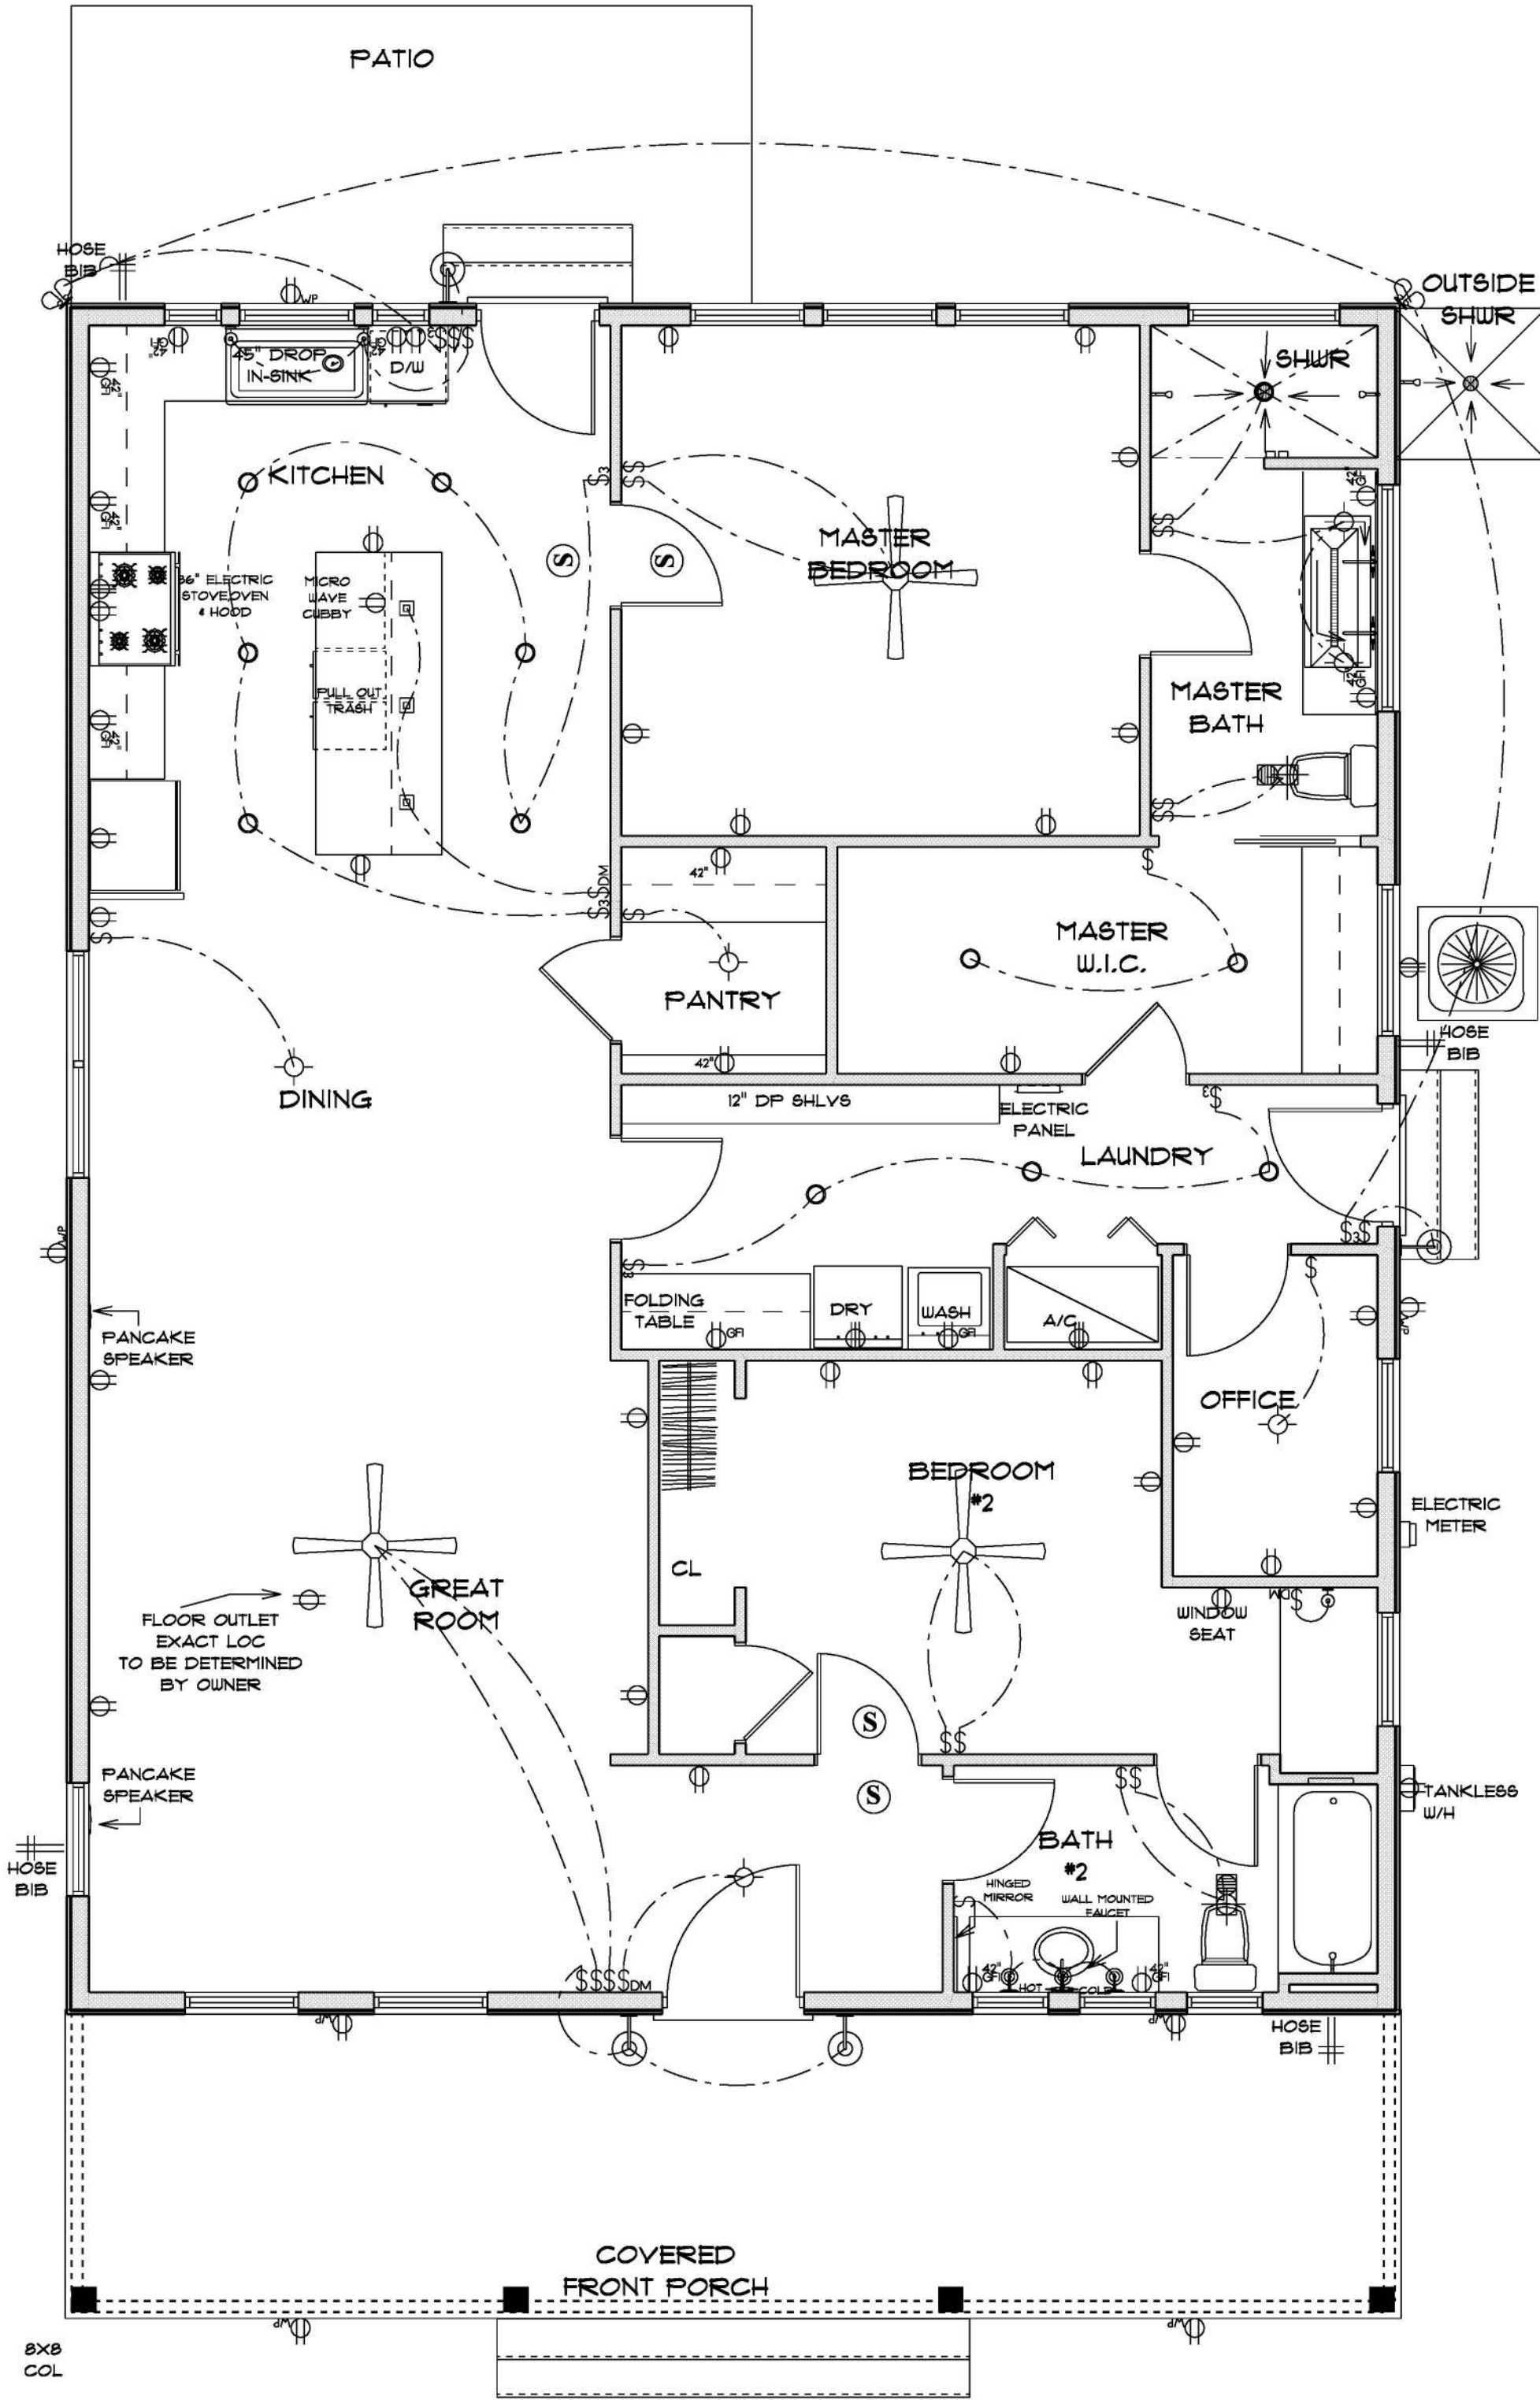

* ELECTRIC PLAN *

SCALE : 1/4" = 1'-0"

RESIDENCE
for
SANDRA
TAN

429 SW RIVERSIDE AVE
FORT WHITE, FLORIDA
32038

Teena M. Ruffo
2925 SW 8R 47
Lake City Florida, 32025
Cell: (386) 861 - 1191
Email: teenaruffo@gmail.com

PRINTED DATE:
Friday, December 23, 2022

DRAWN BY: Teena M. Ruffo CHECKED BY:

BUILDING CONTRACTOR
PLUMB LEVEL CONSTRUCTION

FINAL DATE:

JOB NUMBER:

DRAWING NUMBER

A-6

OF 6 SHEET(S)