


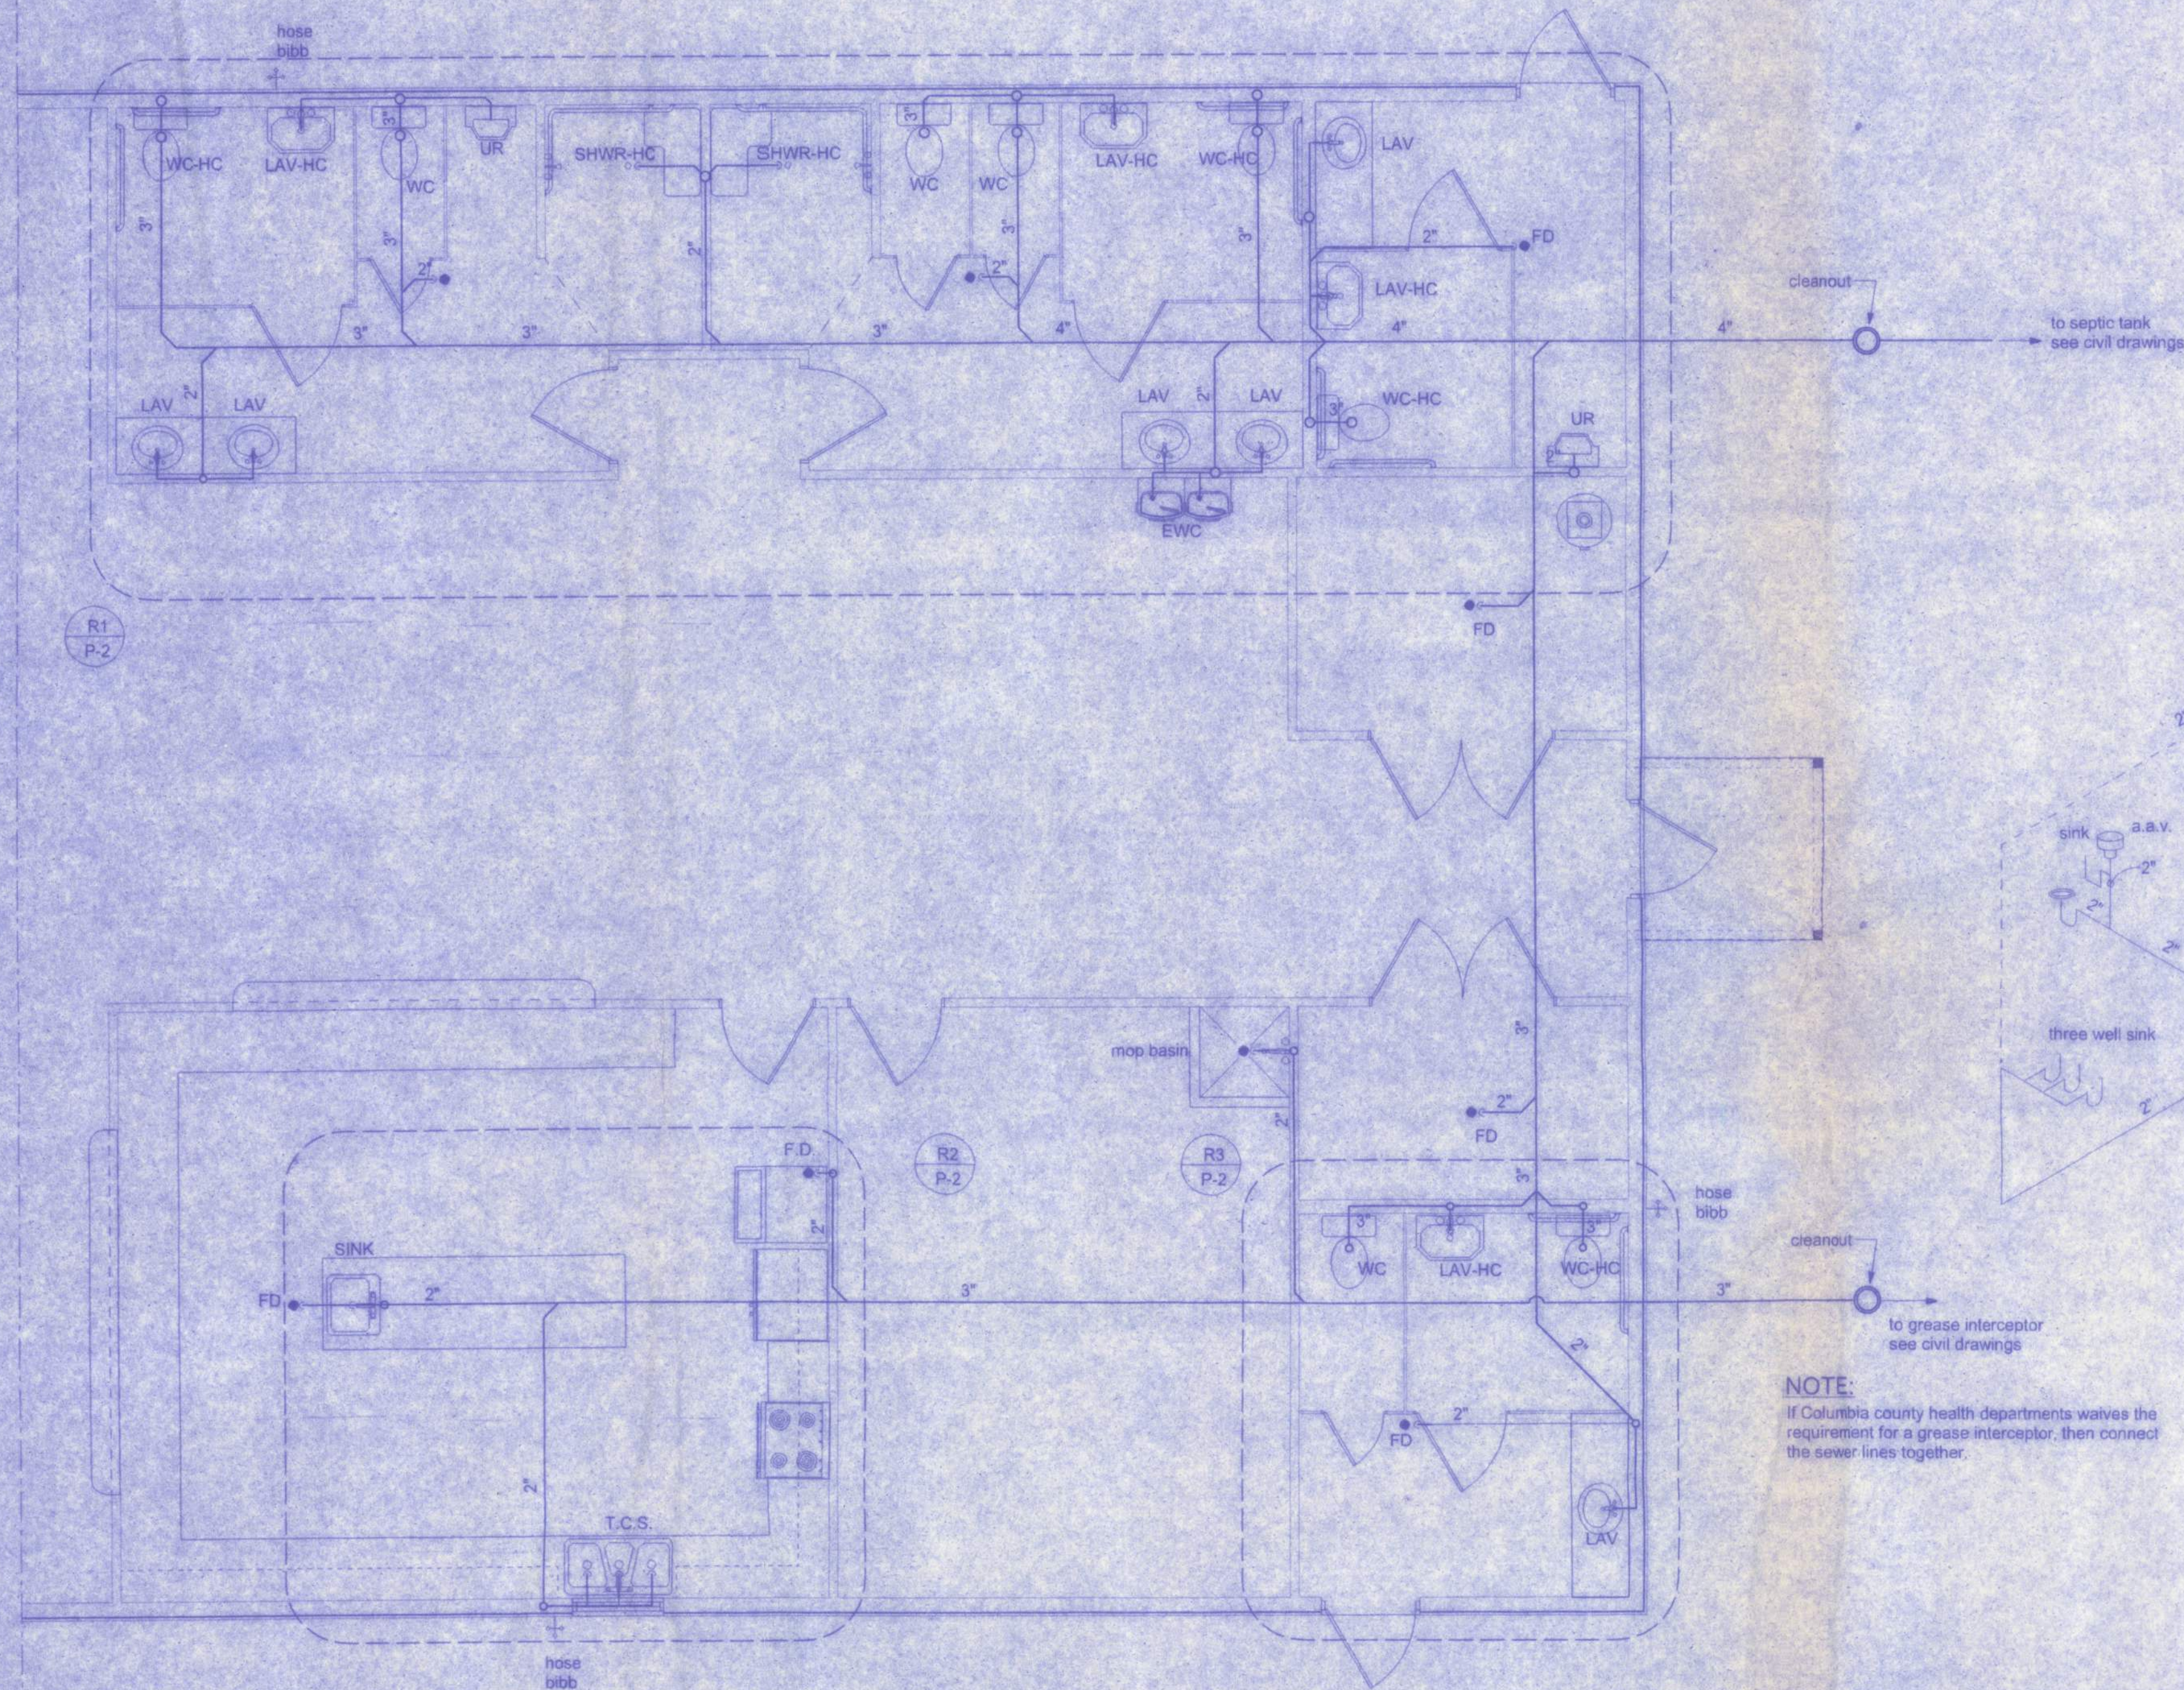

NOTE:
If Columbia county health departments waives the requirement for a grease interceptor, then connect the sewer lines together.

Plumbing Specifications:

1. No foam core PVC piping shall be permitted.
2. All vertical plumbing shall be plumb to within 1/8" per 4'.
3. Use trap primer tail piece in lieu of mechanical type.
4. All hot water piping shall have 1" thick pipe insulation.
5. All water closet bends shall have a stainless steel top flange.
6. All cold water lines located in uninsulated areas shall have 1" thick insulation.

PLUMBING PLAN - SANITARY WASTE VENT
SCALE: 1/4" = 1'-0"

NOTE!
ADDED FILL SHALL BE APPLIED IN 8" LIFTS - EA. LIFT SHALL BE COMPACTED TO 98% DRY COMPACTION PER THE "MODIFIED PROCTOR" METHOD.


NOTE!
PROVIDE TRAP PRIMERS FOR ALL FLOOR DRAINS - PRIME EACH F.D. INDIVIDUALLY, DO NOT MANIFOLD

NOTE!
PROVIDE PLUMBING CLEAN-OUTS AT THE BASE OF ALL STACKS, A MAXIMUM OF 75' O.C. ALONG ALL MAIN DRAIN RUNS AND THE UP-STREAM ENDS OF MAIN DRAIN RUNS, WHERE THE MAIN BUILDING DRAIN EXITS THE BUILDING AND AT 75' INTERVALS TO THE DISPOSAL SITE.

NOTE:
Where water heaters or hot water storage tanks are installed above the ground floor space, or in attics or ceiling areas, the tank or water heater shall be installed in a galvanized steel or other metal pan of equal corrosion resistance having a minimum thickness of 24 gage, 0.0276 inch (0.70 mm). Electric water heaters shall be installed in a metal pan as herein required or in a high-impact plastic pan of at least 0.0625 inch (1.59 mm) thickness.

Pan size and drain: The pan shall not be less than 1-1/2 inches (38 mm) deep and shall be of sufficient size and shape to receive all dripping or condensate from the tank or water heater. The pan shall be drained by an indirect waste pipe having a minimum diameter of 3/4 inch.

Pan drain termination: The pan drain shall extend full-size and terminate over a suitably located indirect waste receptor or floor drain or extend to the exterior of the building and terminate not less than 6 inches (152 mm) or more than 24 inches (610 mm) above the adjacent ground surface.

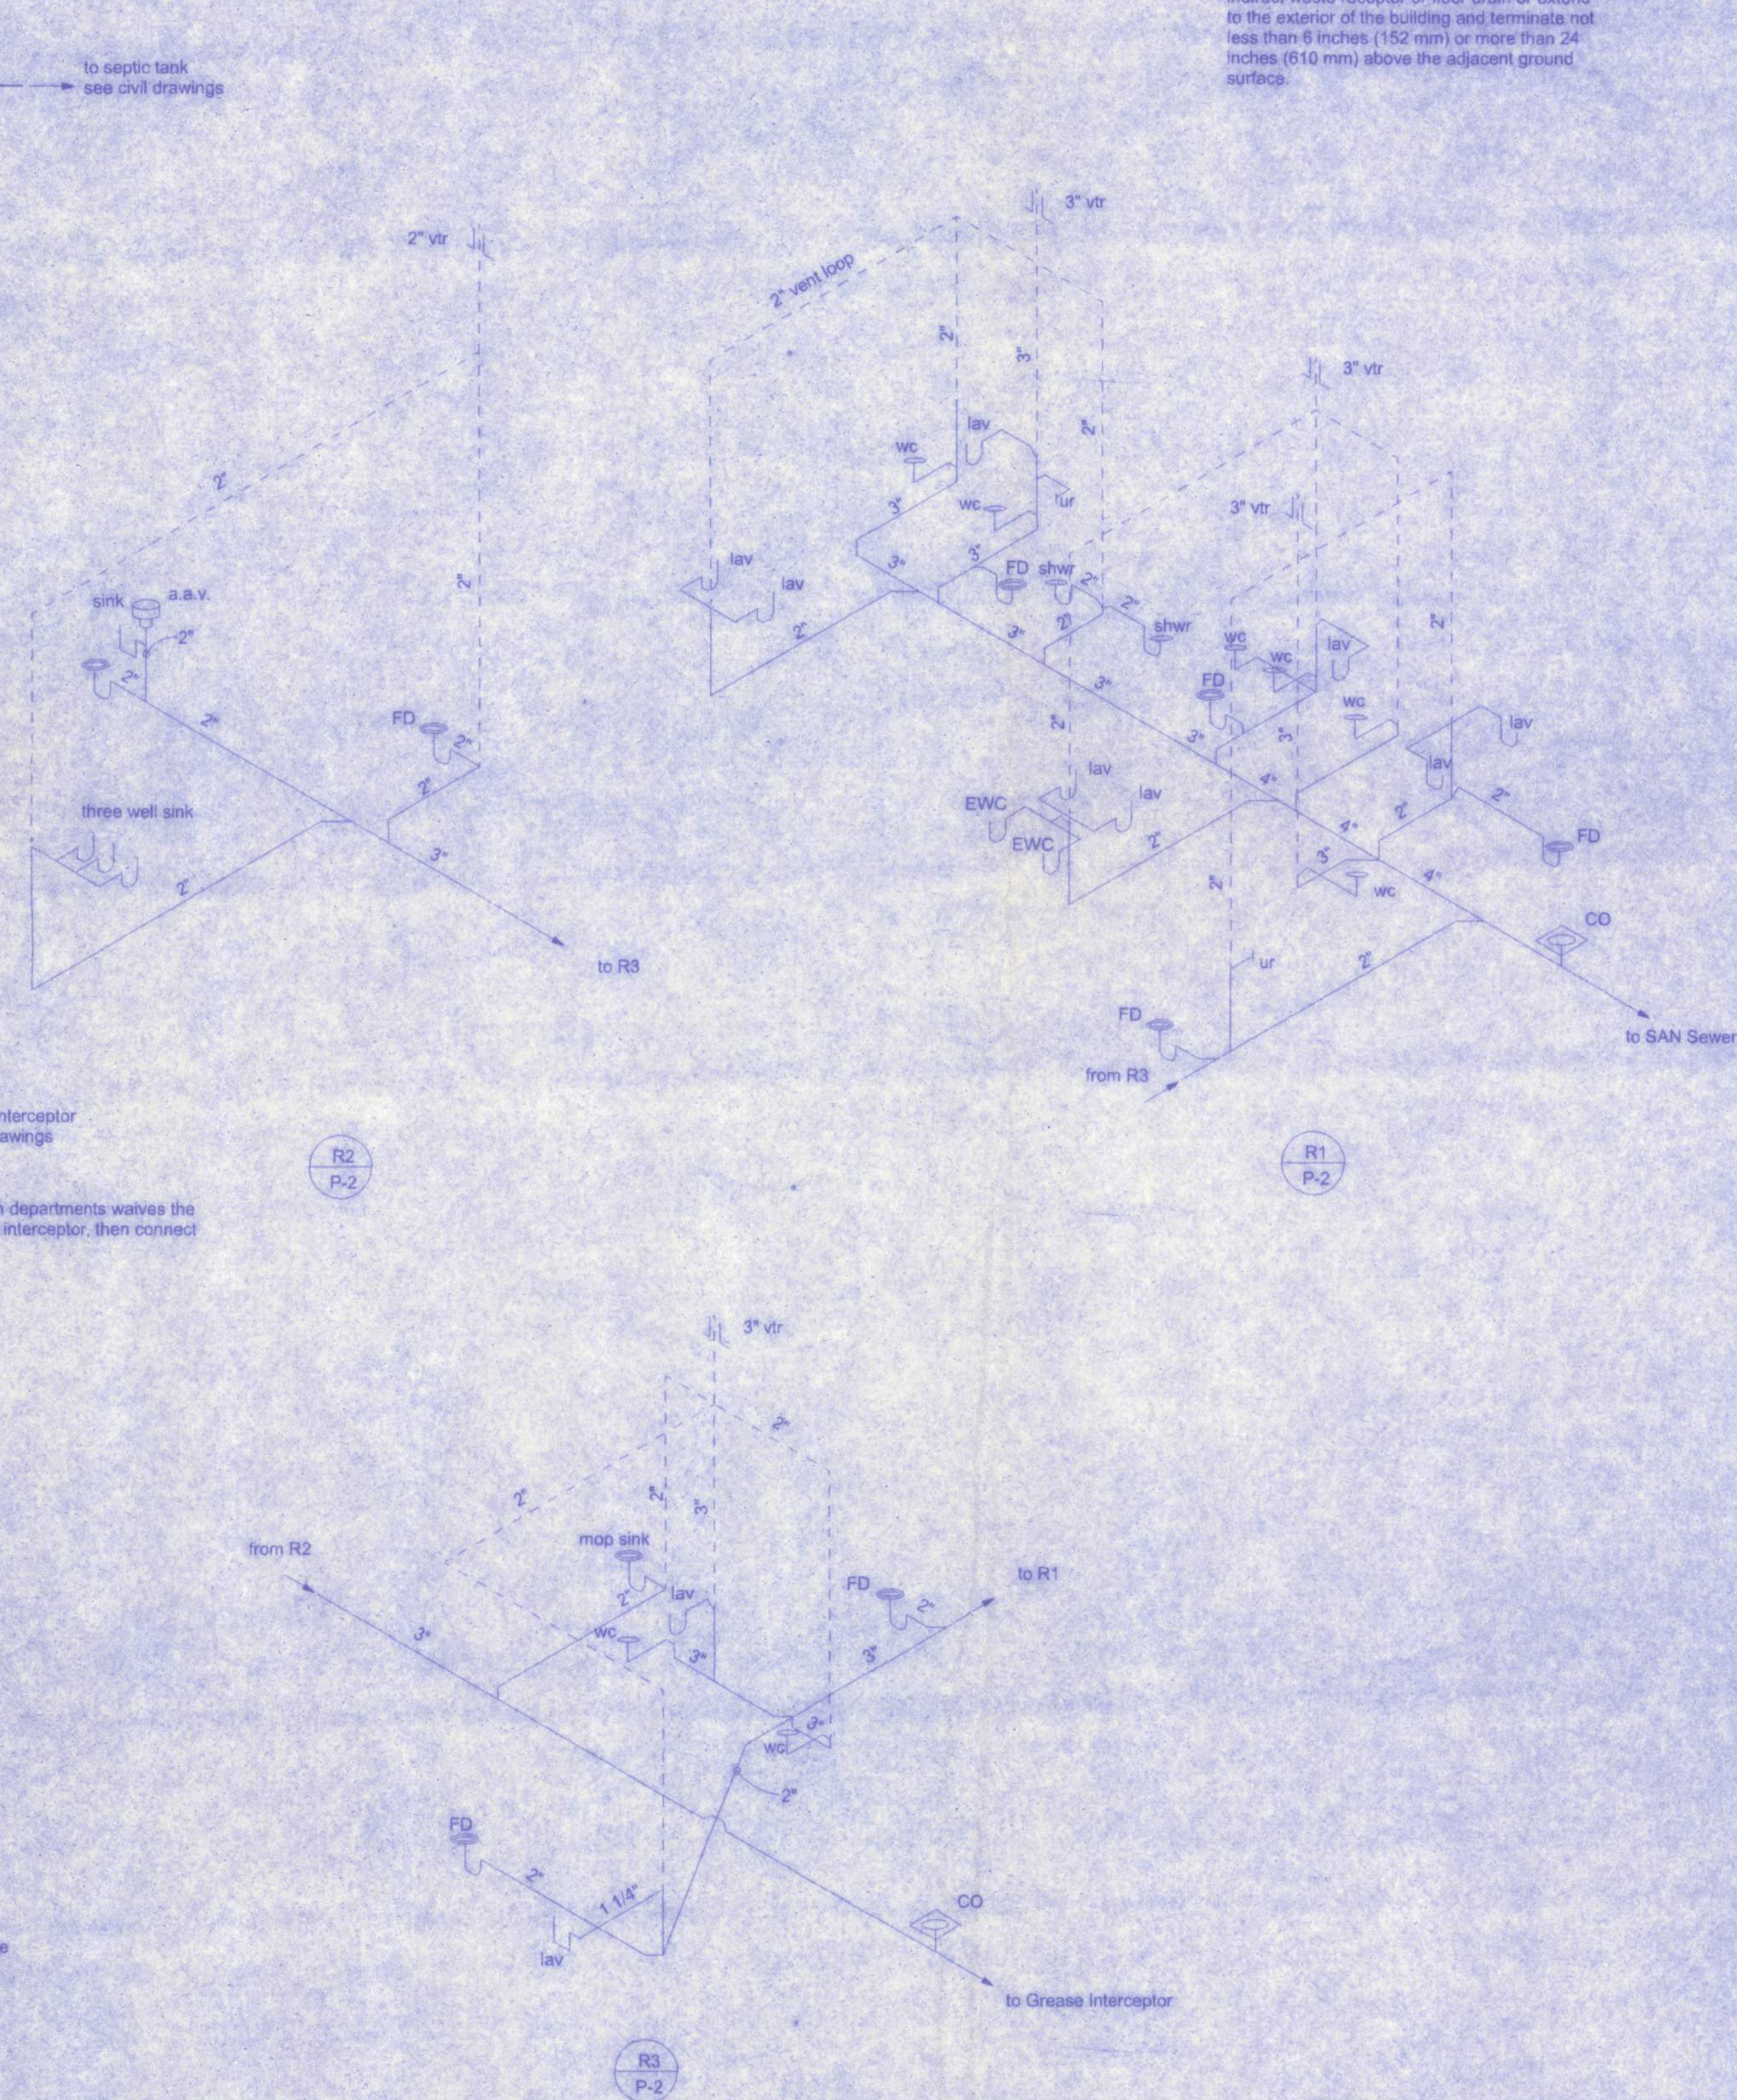

WEST SIDE COMMUNITY CENTER

128 SW NASSAU STREET
LAKE CITY, FL 32025
(886)758-4209

Freeman
Design Group Inc.

DATE 11/5/10
DRAWN BY W.H.F.
APPROVED W.H.F.

REVISIONS

SHEET P-2

OF 3

PROJECT NO.
09.0037

CERTIFICATE OF AUTHORIZATION # 00000701