

Floor: Load: 55# psf; 40 TCLL, 10 TCDL, 00 BCLL, 05 BCDL; Dur.: 1.00  
Design checked for 10 psf non-concurrent LL on BC.

Roof: Load: 40# psf; 20 TCLL, 10 TCDL, 00 BCLL, 10 BCDL; Dur.: 1.25  
Design checked for 10 psf non-concurrent LL on BC


○ Installation shall be per connector manufacturer's guidelines. All connectors and tie downs other than truss to girder truss connectors are to be specified and supplied by others.

Only points listed above have reactions > 5000# or Uplift > 1000#.  
Values shown on the sealed Truss Design Drawings supersede the above.

 Diamond indicates left side of truss on truss design drawings

Rev	

Date	:	10/07/25	Scale	:	1/4" = 1'-0"	D= 1/4
Revised	:		Drawn By	:	Steve R.	
Sheet #	:	1 of 1	Job #	:	6252401	

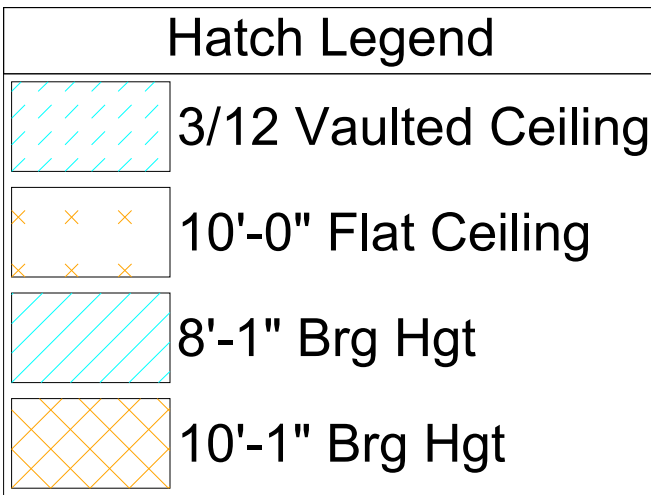

Please Print	Name	Employed By	Approval Date
--------------	------	-------------	---------------