



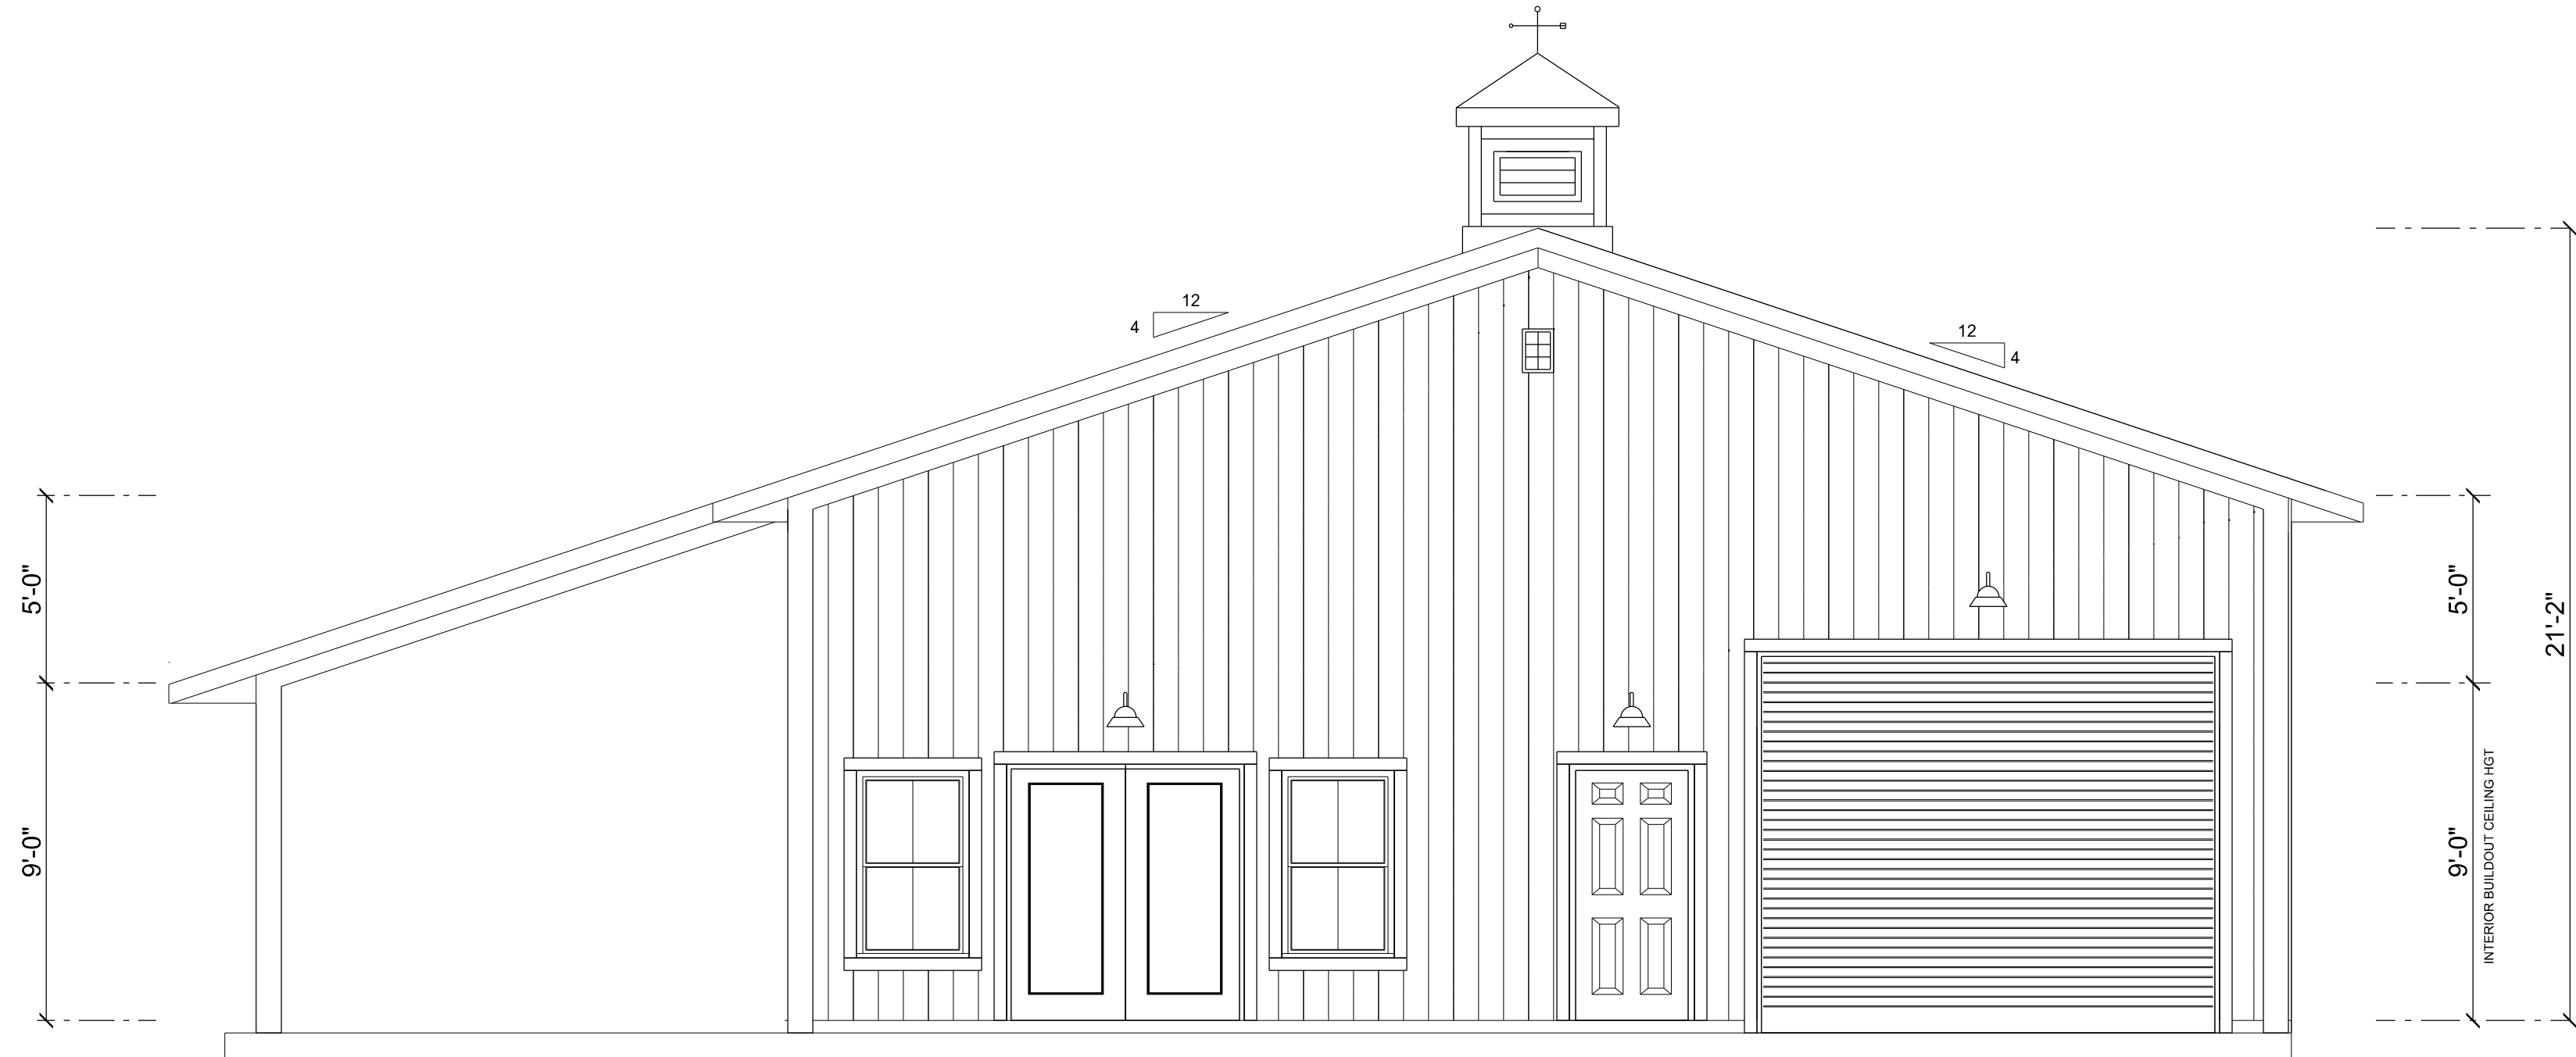

FRONT ELEVATION
SCALE: 1/4" = 1'-0"

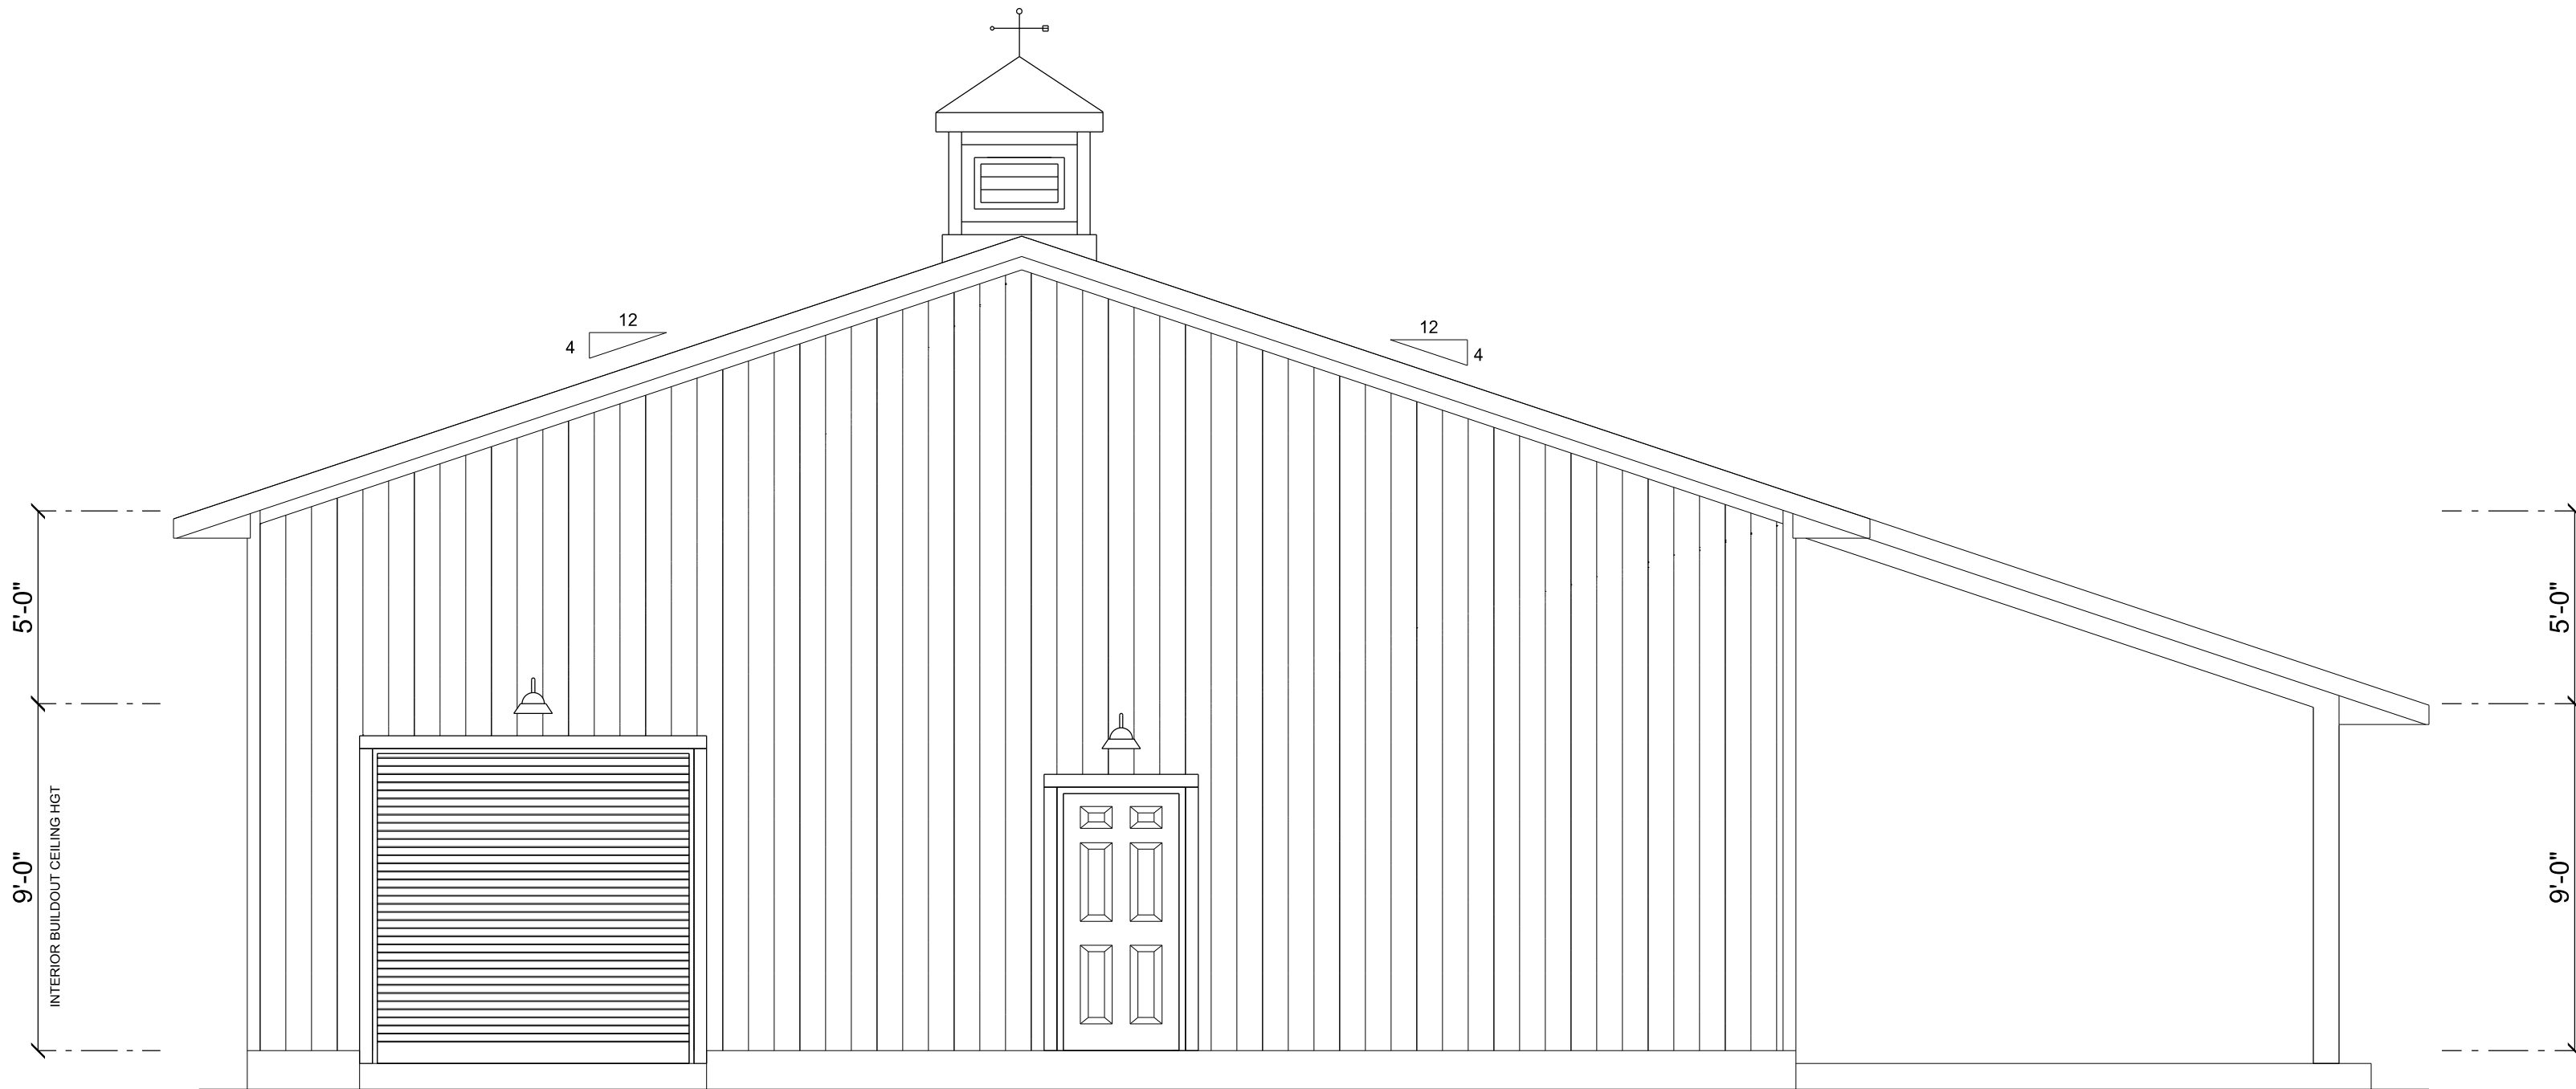

REAR ELEVATION
SCALE: 1/4" = 1'-0"

REVISIONS SCHEDULE	
PROPOSAL	May 5th, 2023
REVISIONS	June 27th, 2023
REVISIONS	JULY 14th, 2023

CUSTOM HOME FOR:
METCALF RESIDENCE
COLUMBIA COUNTY, FLORIDA


**RIDGEPOINT
DESIGN**

566 SW ARLINGTON BLVD. STE 101, LAKE CITY, FL 32025
P: 386-288-1188
E: RIDGEPOINTDESIGN@GMAIL.COM



LEFT ELEVATION

SCALE: 1/4" = 1'-0"

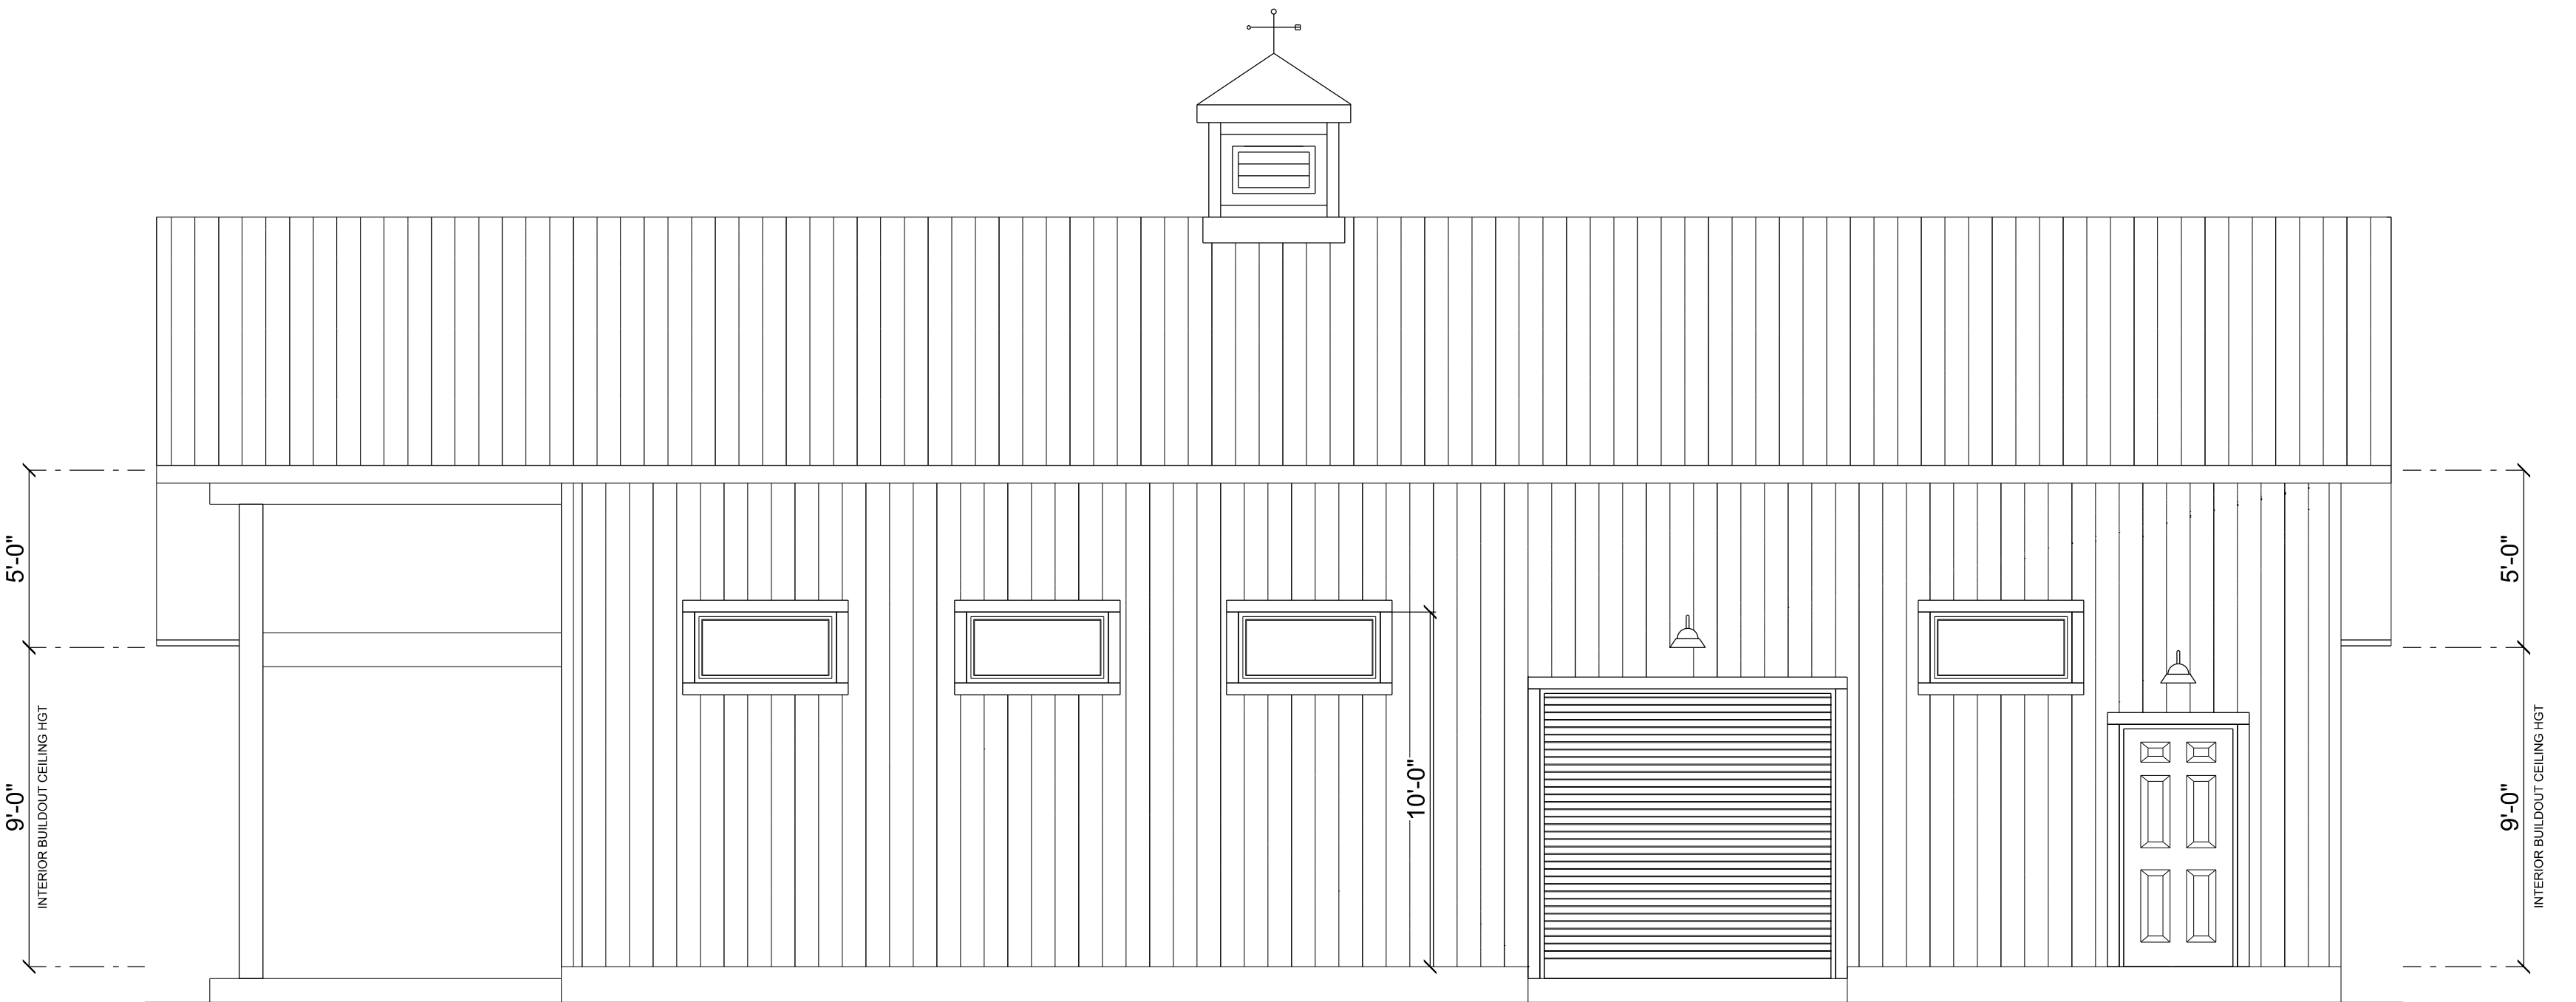

RIGHT ELEVATION

SCALE: 1/4" = 1'-0"

REVISIONS SCHEDULE			
PROPOSAL		May 5th, 2023	
REVISIONS		June 27th, 2023	
REVISIONS		JULY 14th, 2023	

CUSTOM HOME FOR:

METCALF RESIDENCE

COLUMBIA COUNTY, FLORIDA

RIDGEPOINT


DESIGN

566 SW ARLINGTON BLVD. STE. 101, LAKE CITY, FL 32025
P: 386-288-1188
E: RIDGEPOINTDESIGN@GMAIL.COM

SHEET NUMBER

A.2

OF 8 SHEETS

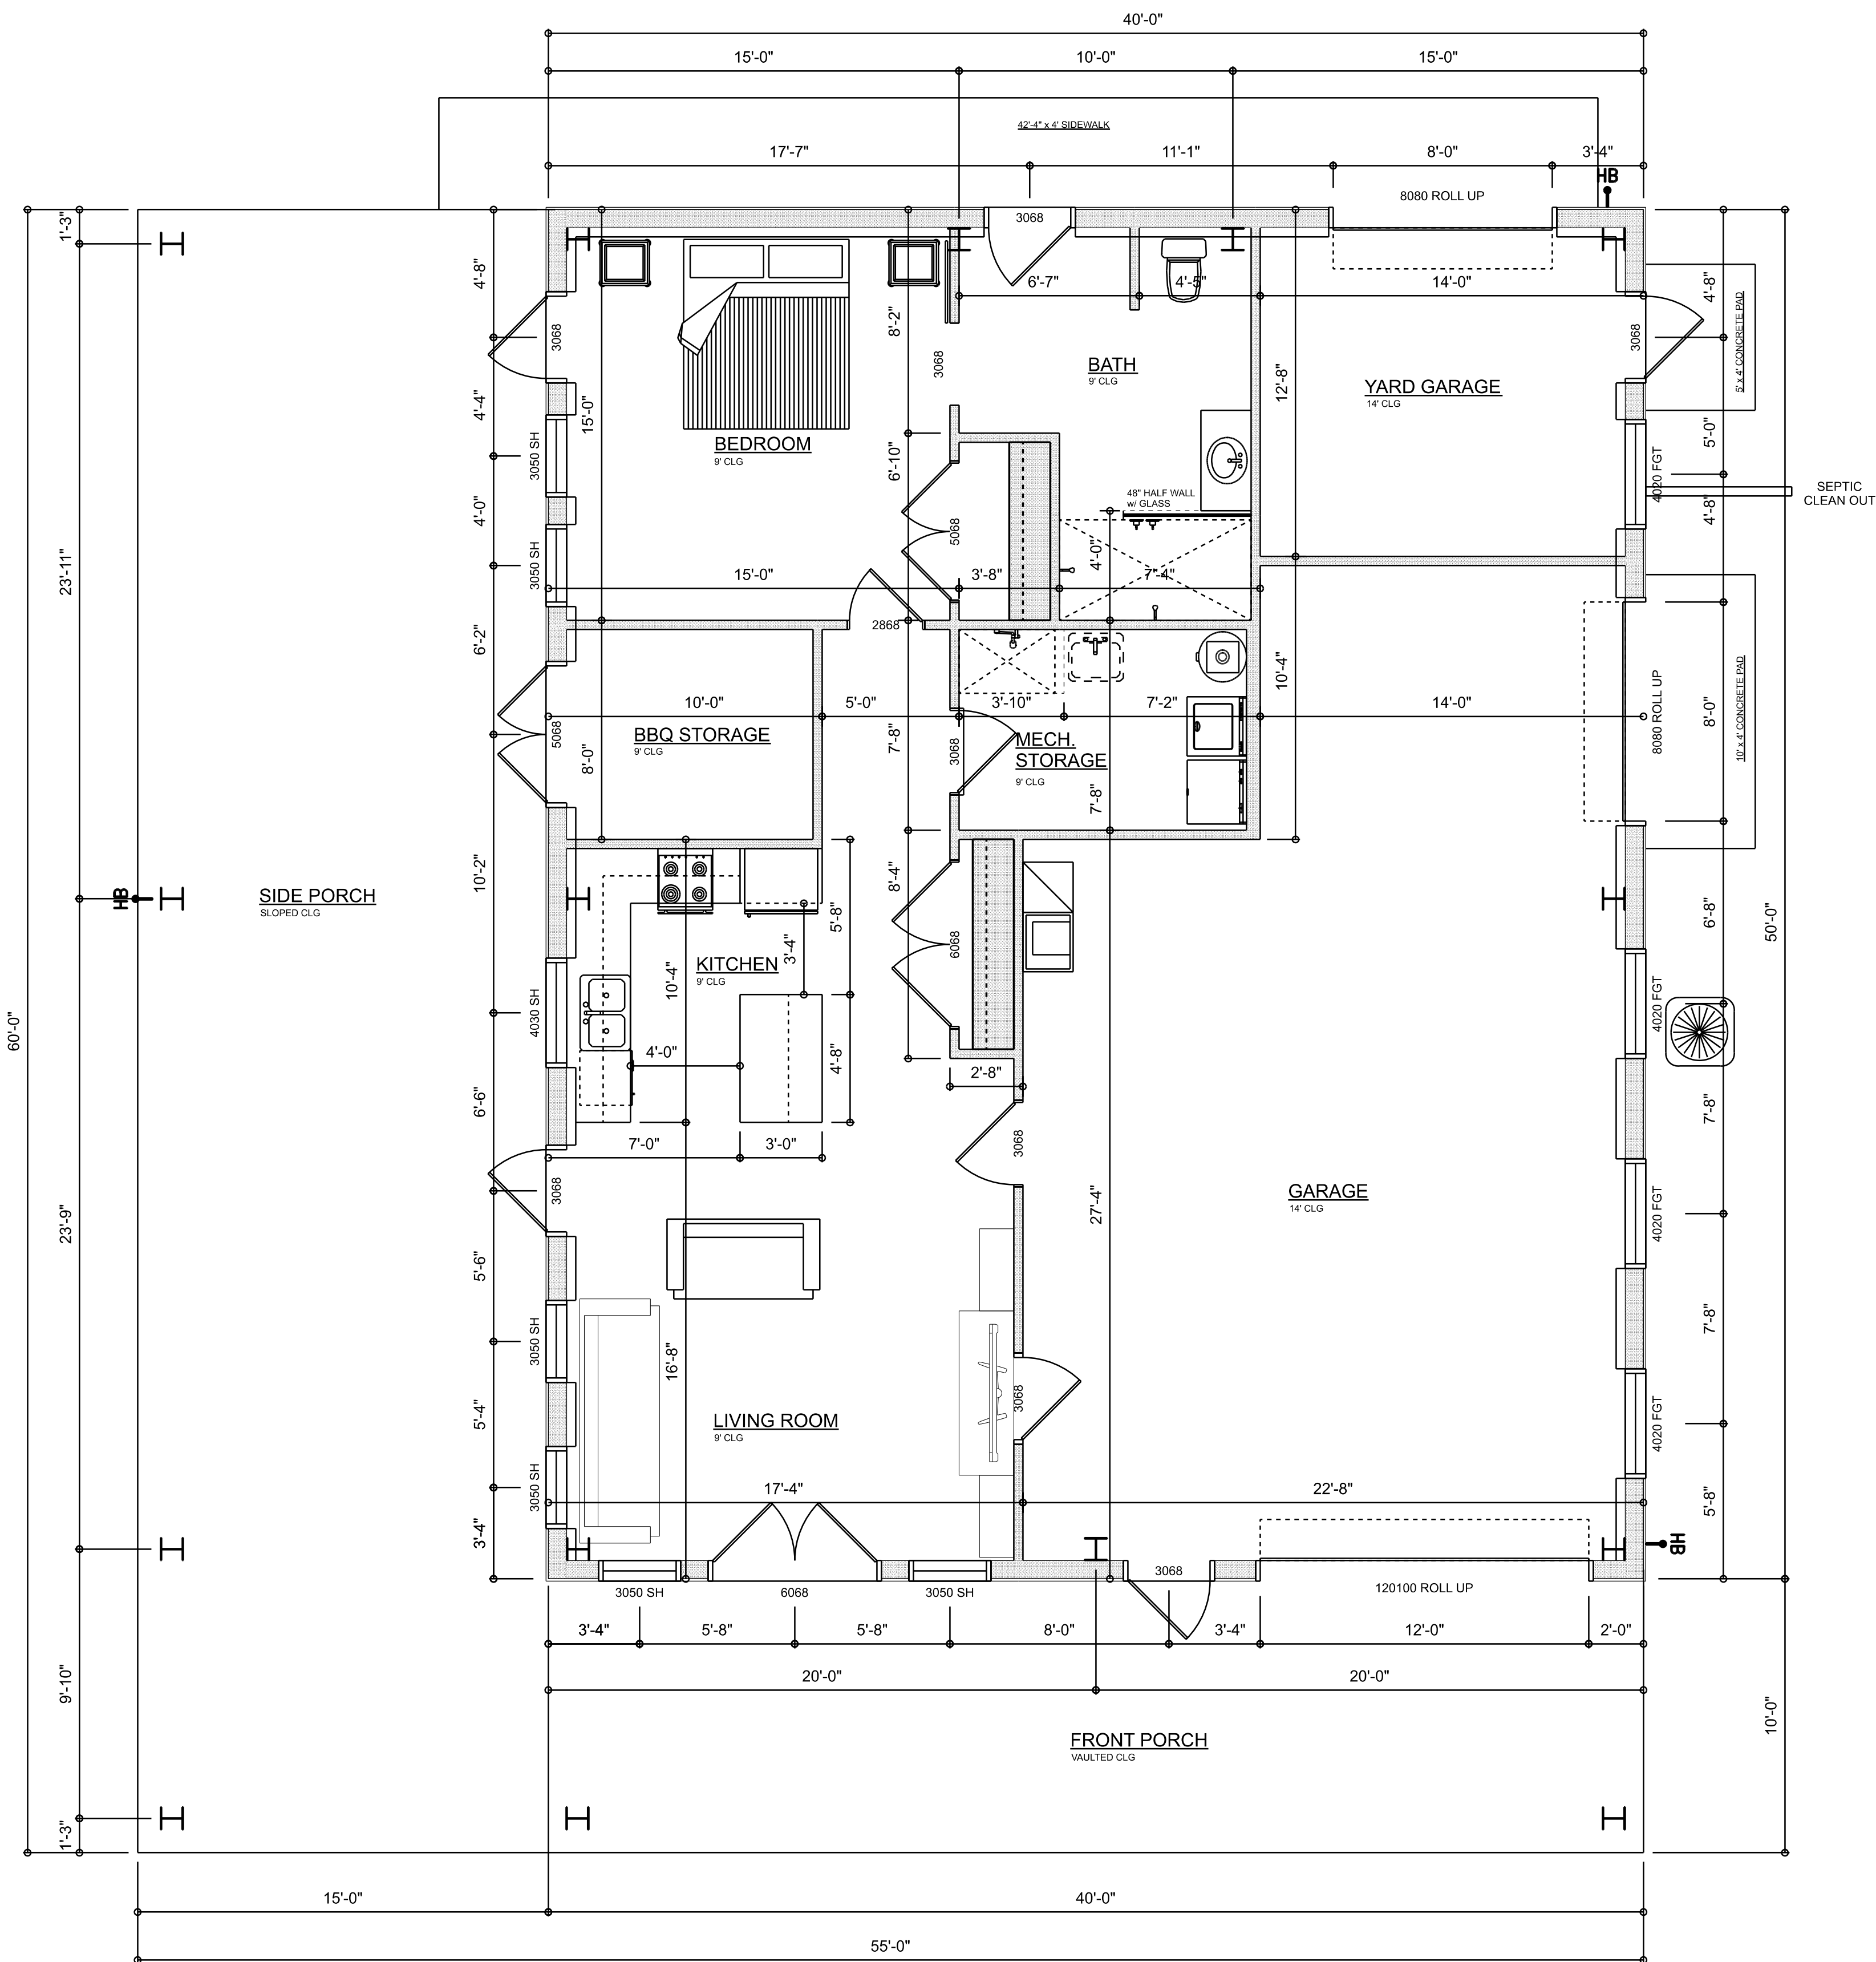


DIMENSIONED FLOOR PLAN

SCALE: 1/4" = 1'-0"

AREA SUMMARY

LIVING	796	S.F.
BBQ STORAGE	84	S.F.
ENTRY PORCH	400	S.F.
SIDE PORCH	901	S.F.
GARAGE / STORAGE	1,121	S.F.
TOTAL AREA	3,301	S.F.

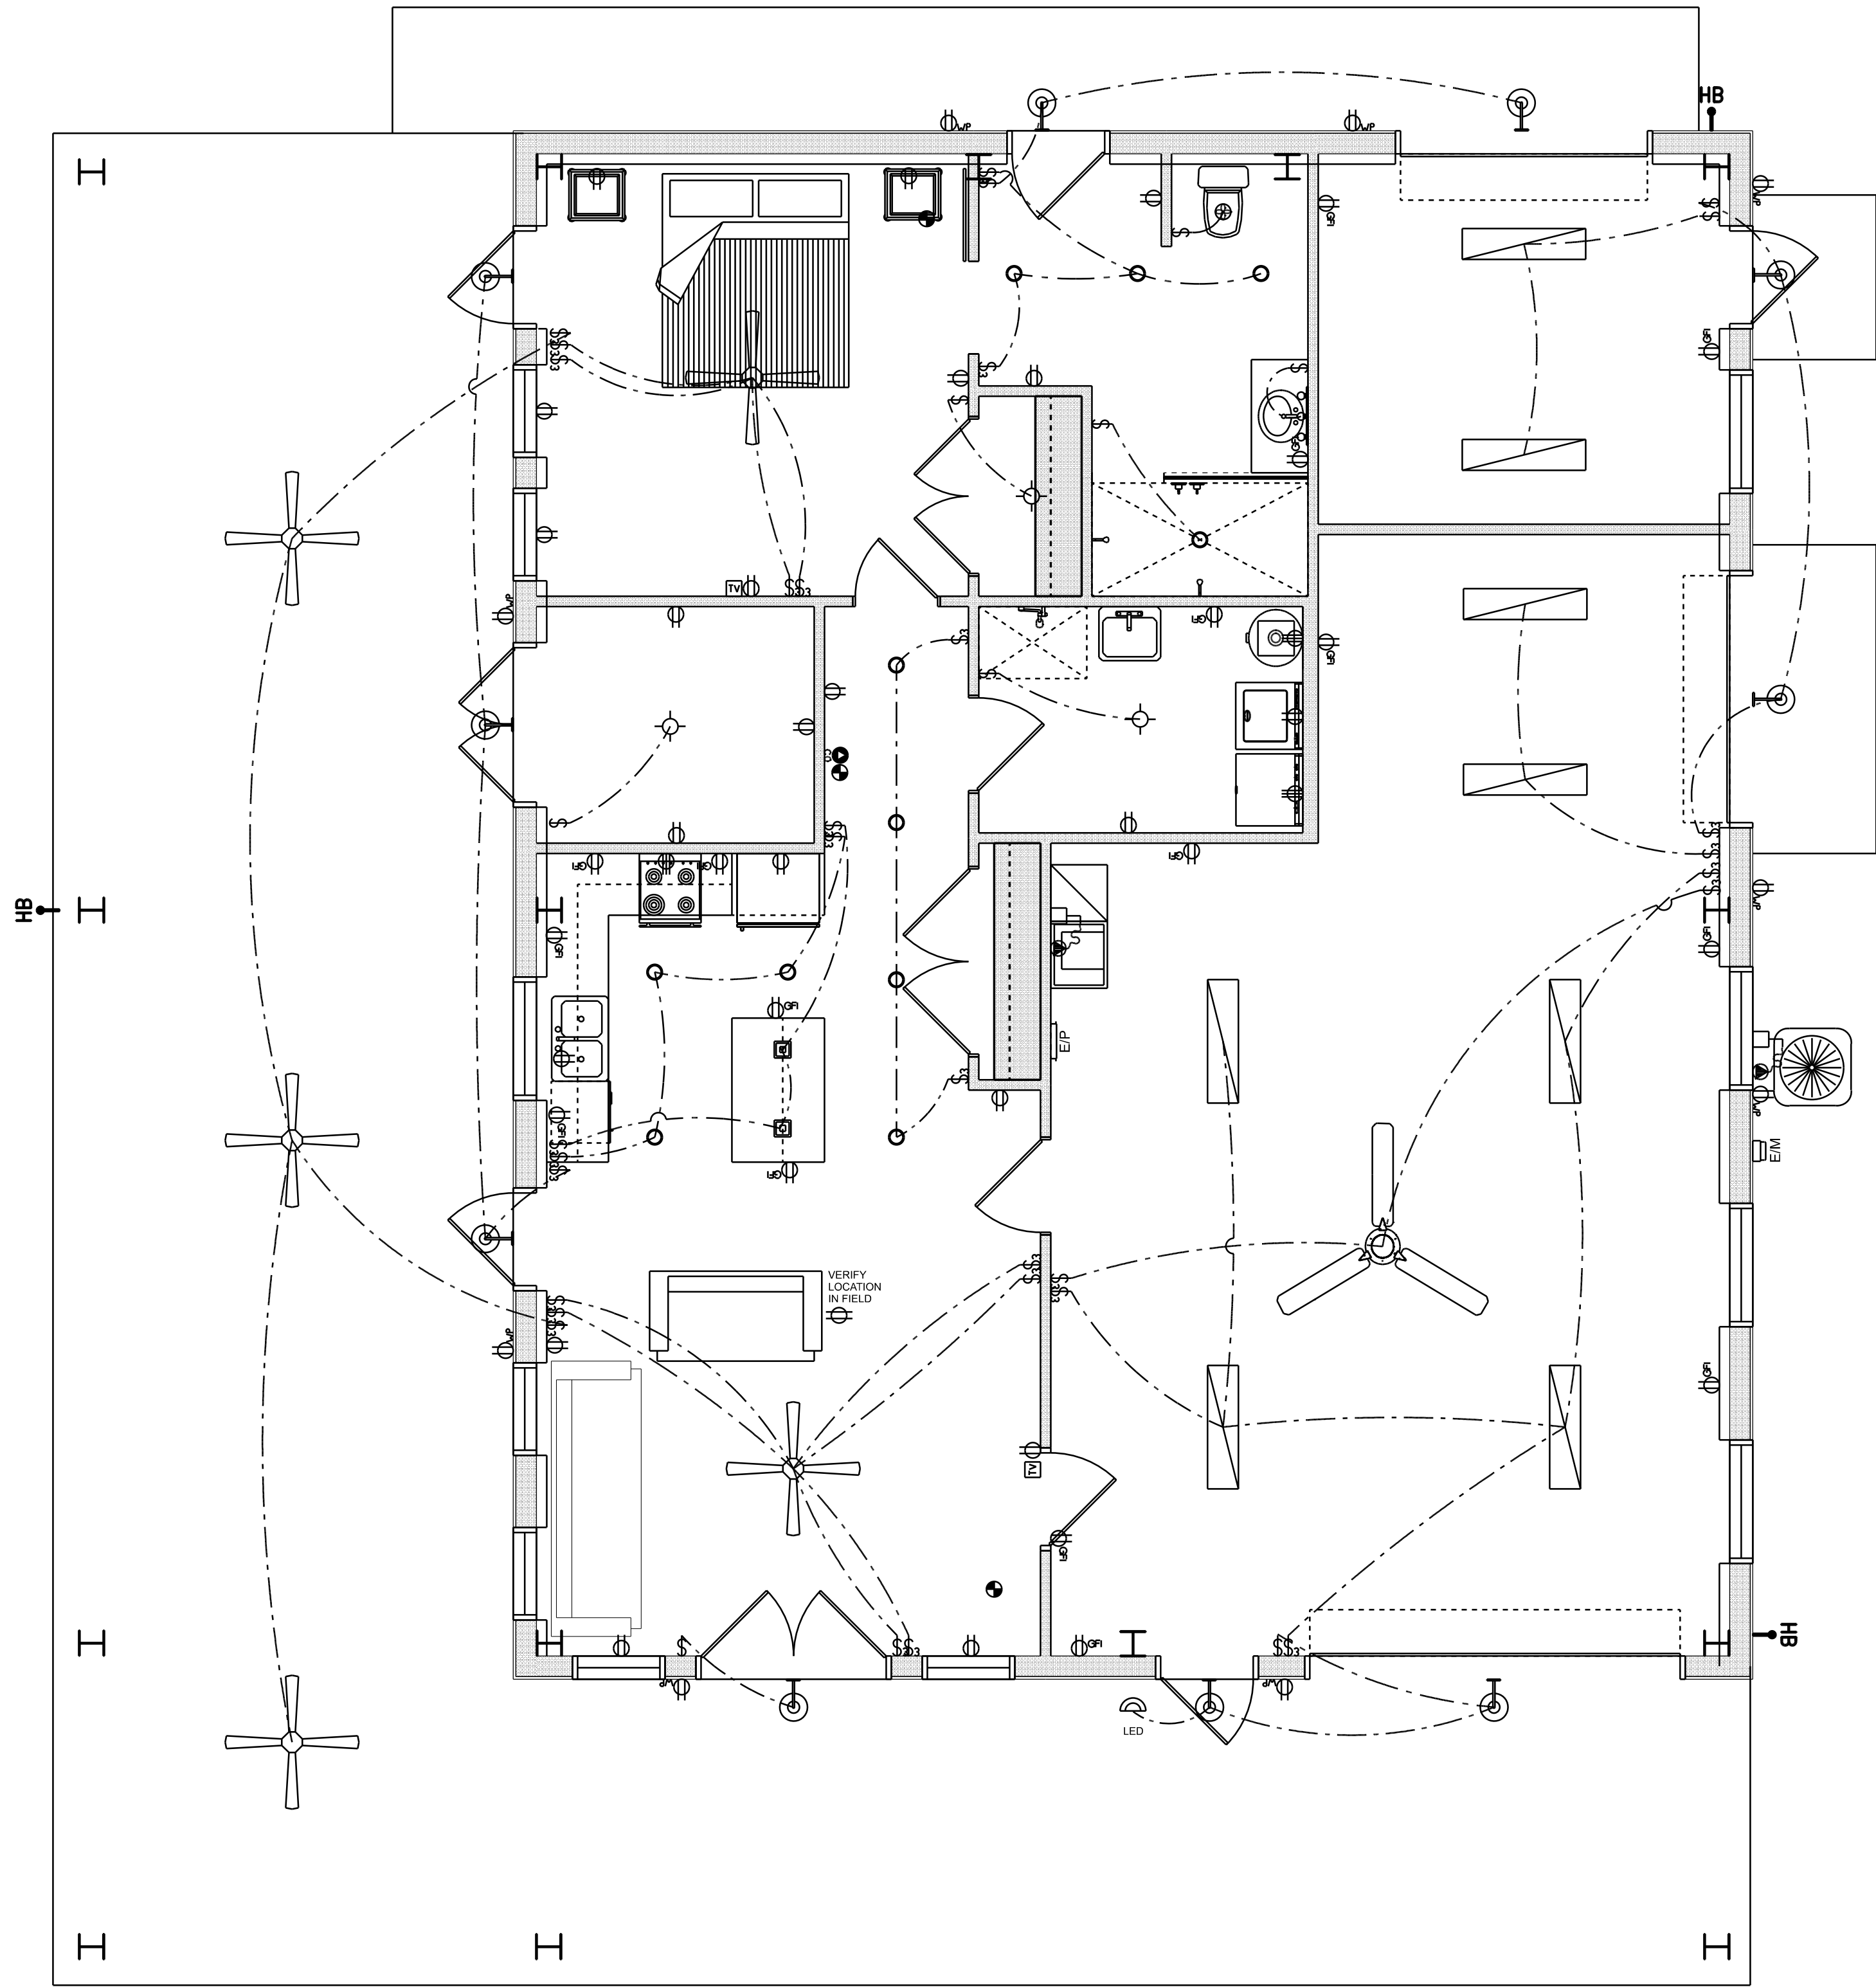

ELECTRICAL PLAN
SCALE: 1/4" = 1'-0"


ELECTRICAL LEGEND		
ELECTRICAL	COUNT	SYMBOL
CEILING FAN	5	
CAN LIGHT 6inch	11	
LED CEILING LIGHT 1x4	8	
wall mount savoy	10	
AC DISCONNECT	2	
CARBON DETECTOR	1	
COAX OUTLET	2	
EXHAUST FAN	1	
FLOOR OULET DUPLEX	1	
OUTLET	21	
OUTLET 220v	3	
OUTLET GFI	16	
OUTLET WP	9	
SMOKE DETECTOR	3	
STANDARD LIGHT	3	
SWITCH	11	
SWITCH 3 WAY	28	
VANITY BAR LIGHT - SMALL	1	
WALL MOUNT LED FLOODLIGHT	1	
PENDANT LIGHT	2	
ELECTRIC PANEL	1	
ceiling fan 3 bladed large	1	

ELECTRICAL PLAN NOTES:


- INSTALLATION SHALL BE PER LATEST NAT'L ELECTRIC CODE.
- WIRE ALL APPLIANCES, HVAC UNITS AND OTHER EQUIPMENT PER MANUF. SPECIFICATIONS
- CONSULT WITH THE OWNER FOR THE NUMBER OF SEPERATE TELEPHONE LINES TO BE INSTALLED
- ALL SMOKE DETECTORS SHALL BE 120v W/ BATTERY BACKUP OF THE PHOTOELECTRIC TYPE, AND SHALL BE INTERLOCKED TOGETHER. INSTALL INSIDE AND NEAR ALL BEDROOMS
- TELEPHONE, TELEVISION AND OTHER LOW VOLTAGE DEVICES OR OUTLETS SHALL BE AS PER THE OWNER'S DIRECTIONS. & IN ACCORDANCE W/ APPLICABLE SECTIONS OF NEC-LATEST EDITION.
- ALL RECEPTICALS, NOT OTHERWISE NOTED, SHALL BE ARC FAULT INTERRUPTER TYPE, EXCEPT DEDICATED OUTLETS
- ALL RECEPTICALS IN WET AREAS SHALL BE GROUND FAULT INTERRUPTER TYPE (GFI)
- ALL EXTERIOR RECEPTICALS SHALL BE WEATHERPROOF GROUD FAULT INTERRUPTER TYPE (WP/GFI)
- NOTE:
ELECTRICAL CONTR SHALL PREPARE "AS-BUILT" SHOP DWGS INDICATING ALL ELECTRICAL WORK, INCLUDING ANY CHANGES TO THE ELEC. PLAN, ADD'NS TO THE ELEC. PLAN, RISER DIAGRAM, AS-BUILT PANEL SCHEDULE W/ ALL CKTS IDENTIFIED W/ CKT Nr. DESCRIPTION & BRKR. SERVICE ENT. & ALL UNDERGROUND WIRE LOCATIONS/ROUTING / DEPTH. RISER DIA. SHALL INCLUDE WIRE SIZES/TYPE & EQUIPMENT TYPE W/ RATINGS & LOADS.
CONTRACTOR SHALL PROVIDE 1 COPY OF AS-BUILT DWGS TO OWNER & 1 COPY TO THE PERMIT ISSUING AUTHORITY

REVISIONS SCHEDULE	
PROPOSAL	May 5th, 2023
REVISIONS	June 27th, 2023
REVISIONS	JULY 14th, 2023

CUSTOM HOME FOR:
METCALF RESIDENCE
COLUMBIA COUNTY, FLORIDA

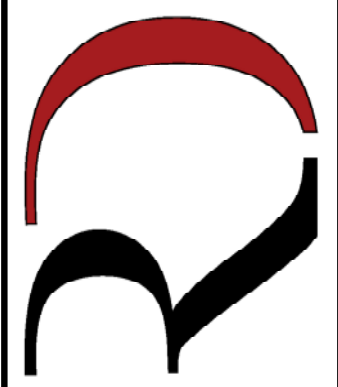**RIDGEPOINT
DESIGN**

566 SW ARLINGTON BLVD. STE 101, LAKE CITY, FL 32025
P: 386-288-1188
E: RIDGEPOINTDESIGN@GMAIL.COM

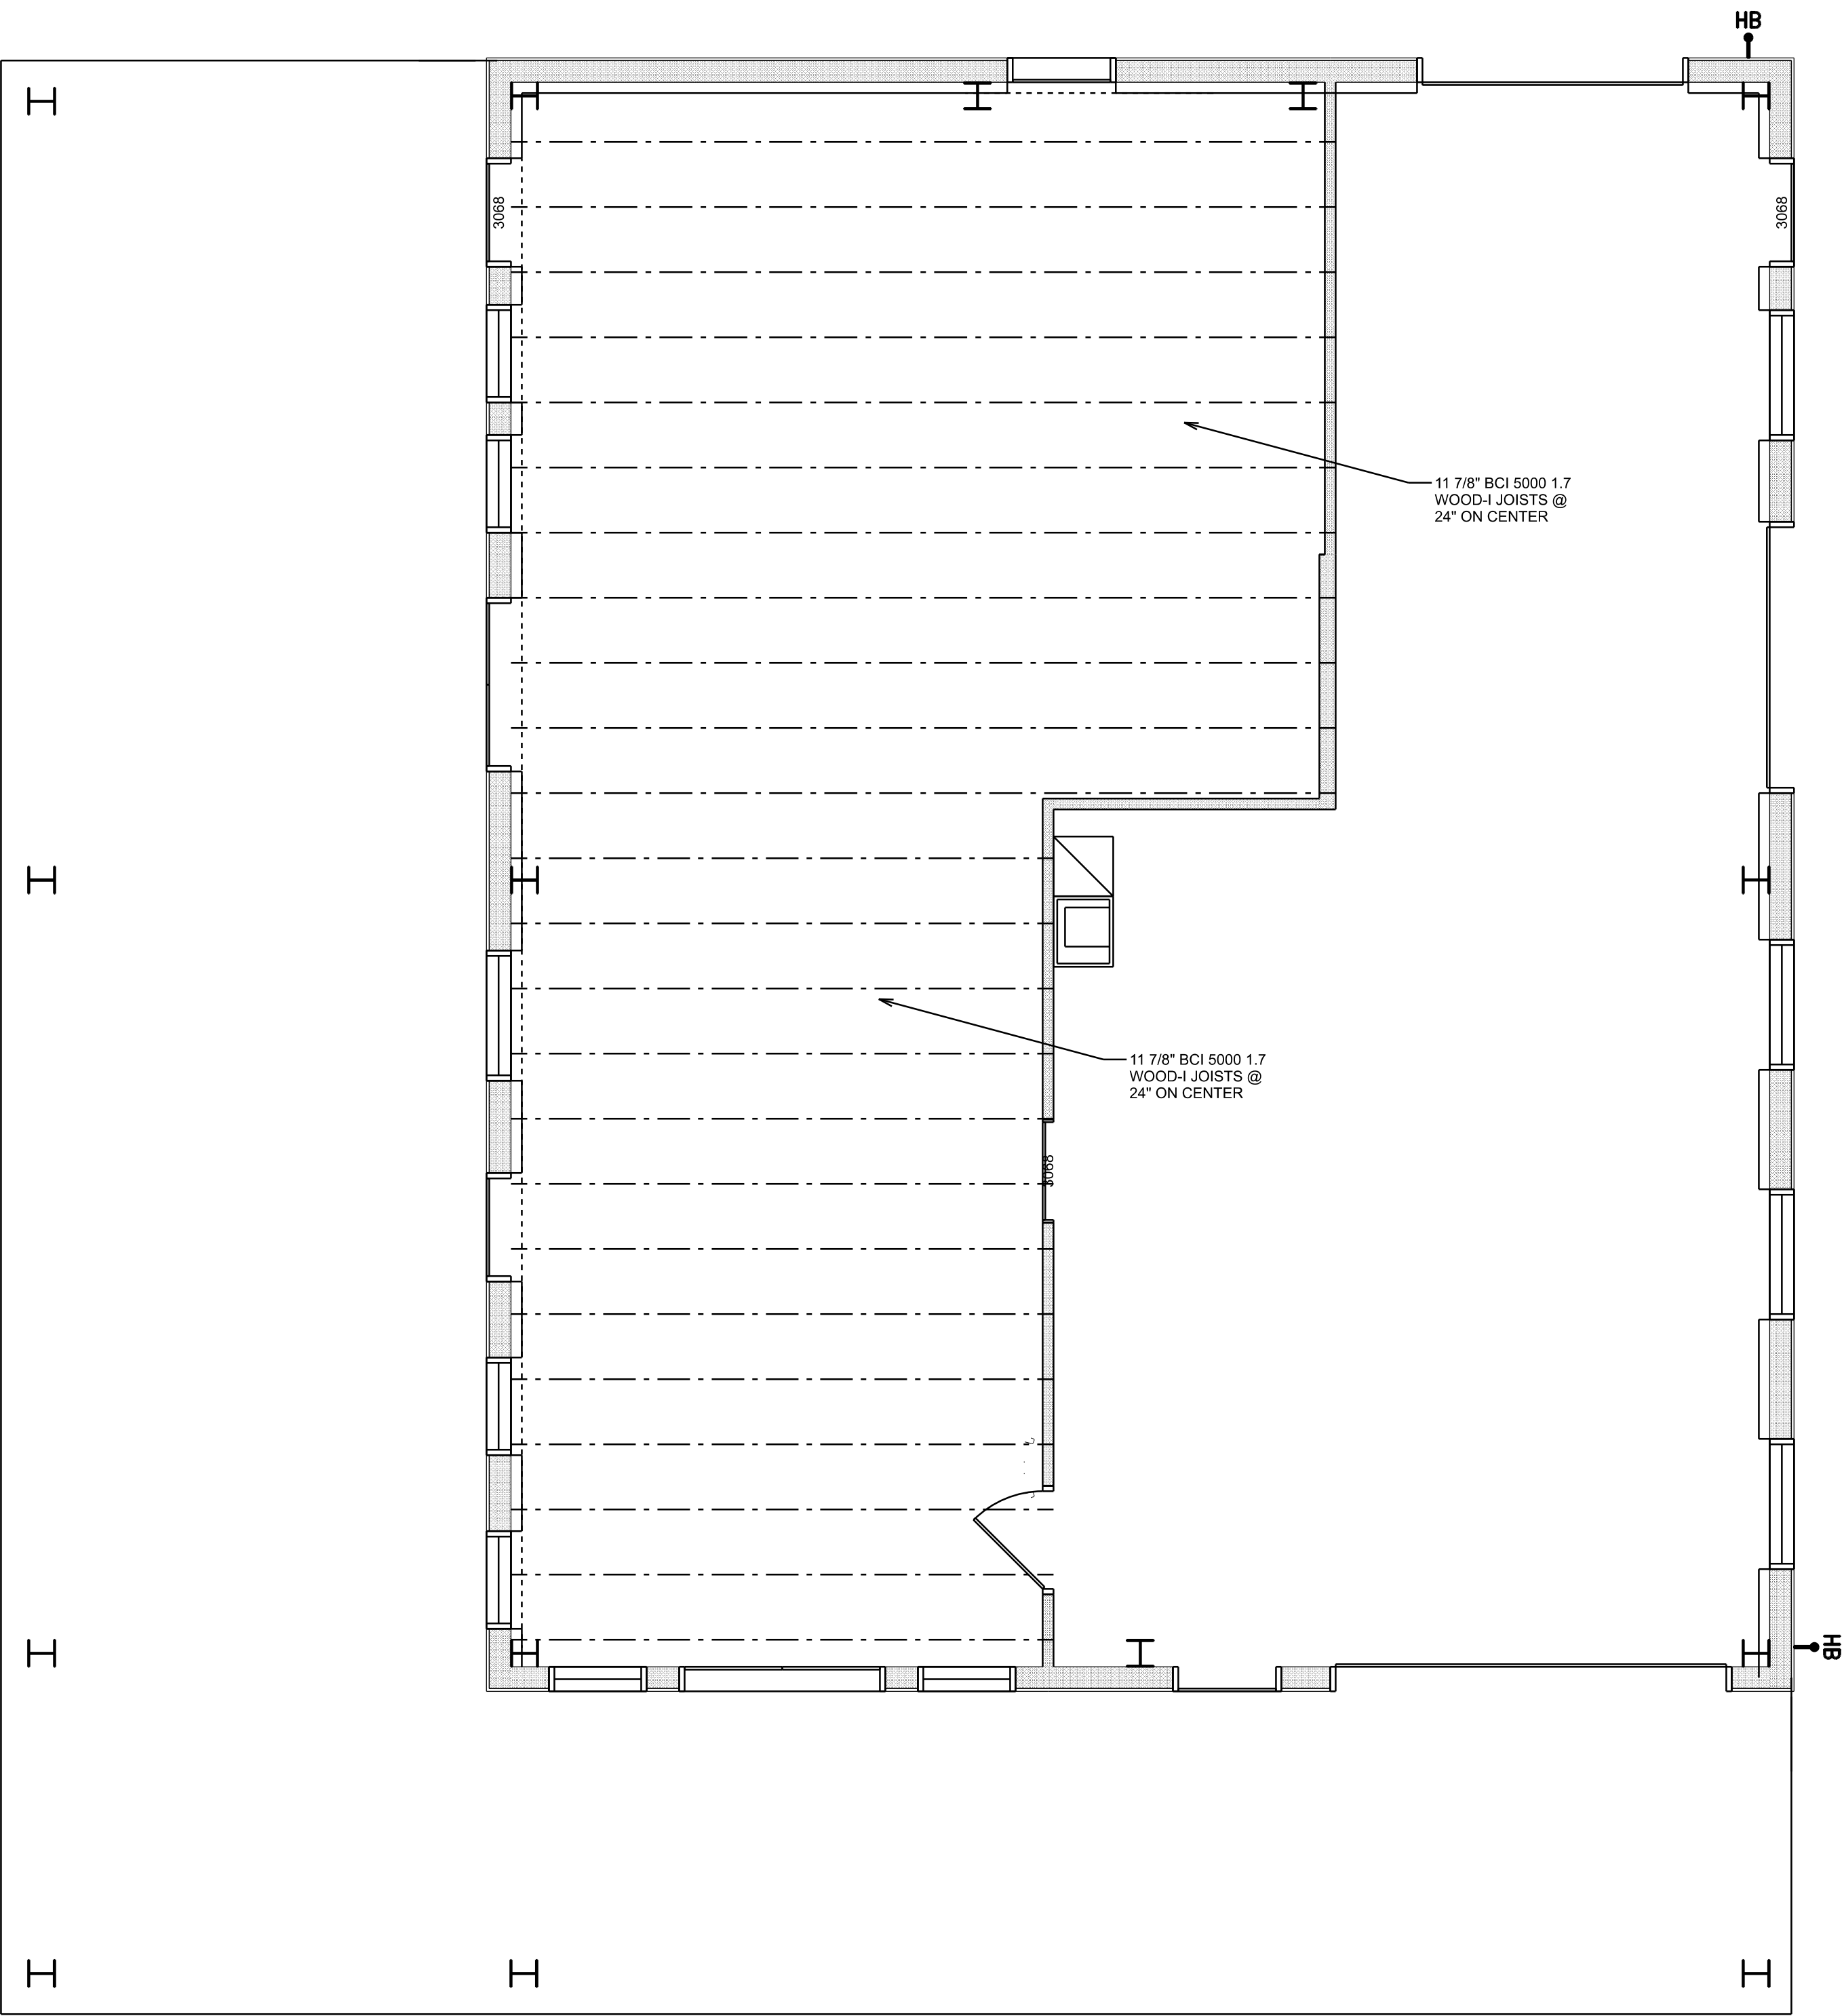

CEILING PLAN
SCALE: 1/4" = 1'-0"

REVISIONS SCHEDULE	
PROPOSAL	May 5th, 2023
REVISIONS	June 27th, 2023
REVISIONS	JULY 14th, 2023



CUSTOM HOME FOR:
METCALF RESIDENCE
COLUMBIA COUNTY, FLORIDA

SHEET NUMBER

P.1

OF 8 SHEETS