

STATE OF FLORIDA
DEPARTMENT OF HEALTH
APPLICATION FOR CONSTRUCTION PERMIT

Permit Application Number

13-0397-N

----- PART II - SITEPLAN -----

Scale: Each block represents 10 feet and 1 inch = 40 feet

SEE ATTACHED DETAIL

Notes. ONE SYSTEM PER TWO CLASSROOMS.

Site Plan submitted by:

Plan Approved ☒

Not Approved ☐

By Julie Ford Env Health Director Columbia

Agent


Date

7/31/13

County Health Department

ALL CHANGES MUST BE APPROVED BY THE COUNTY HEALTH DEPARTMENT

13-0397-N

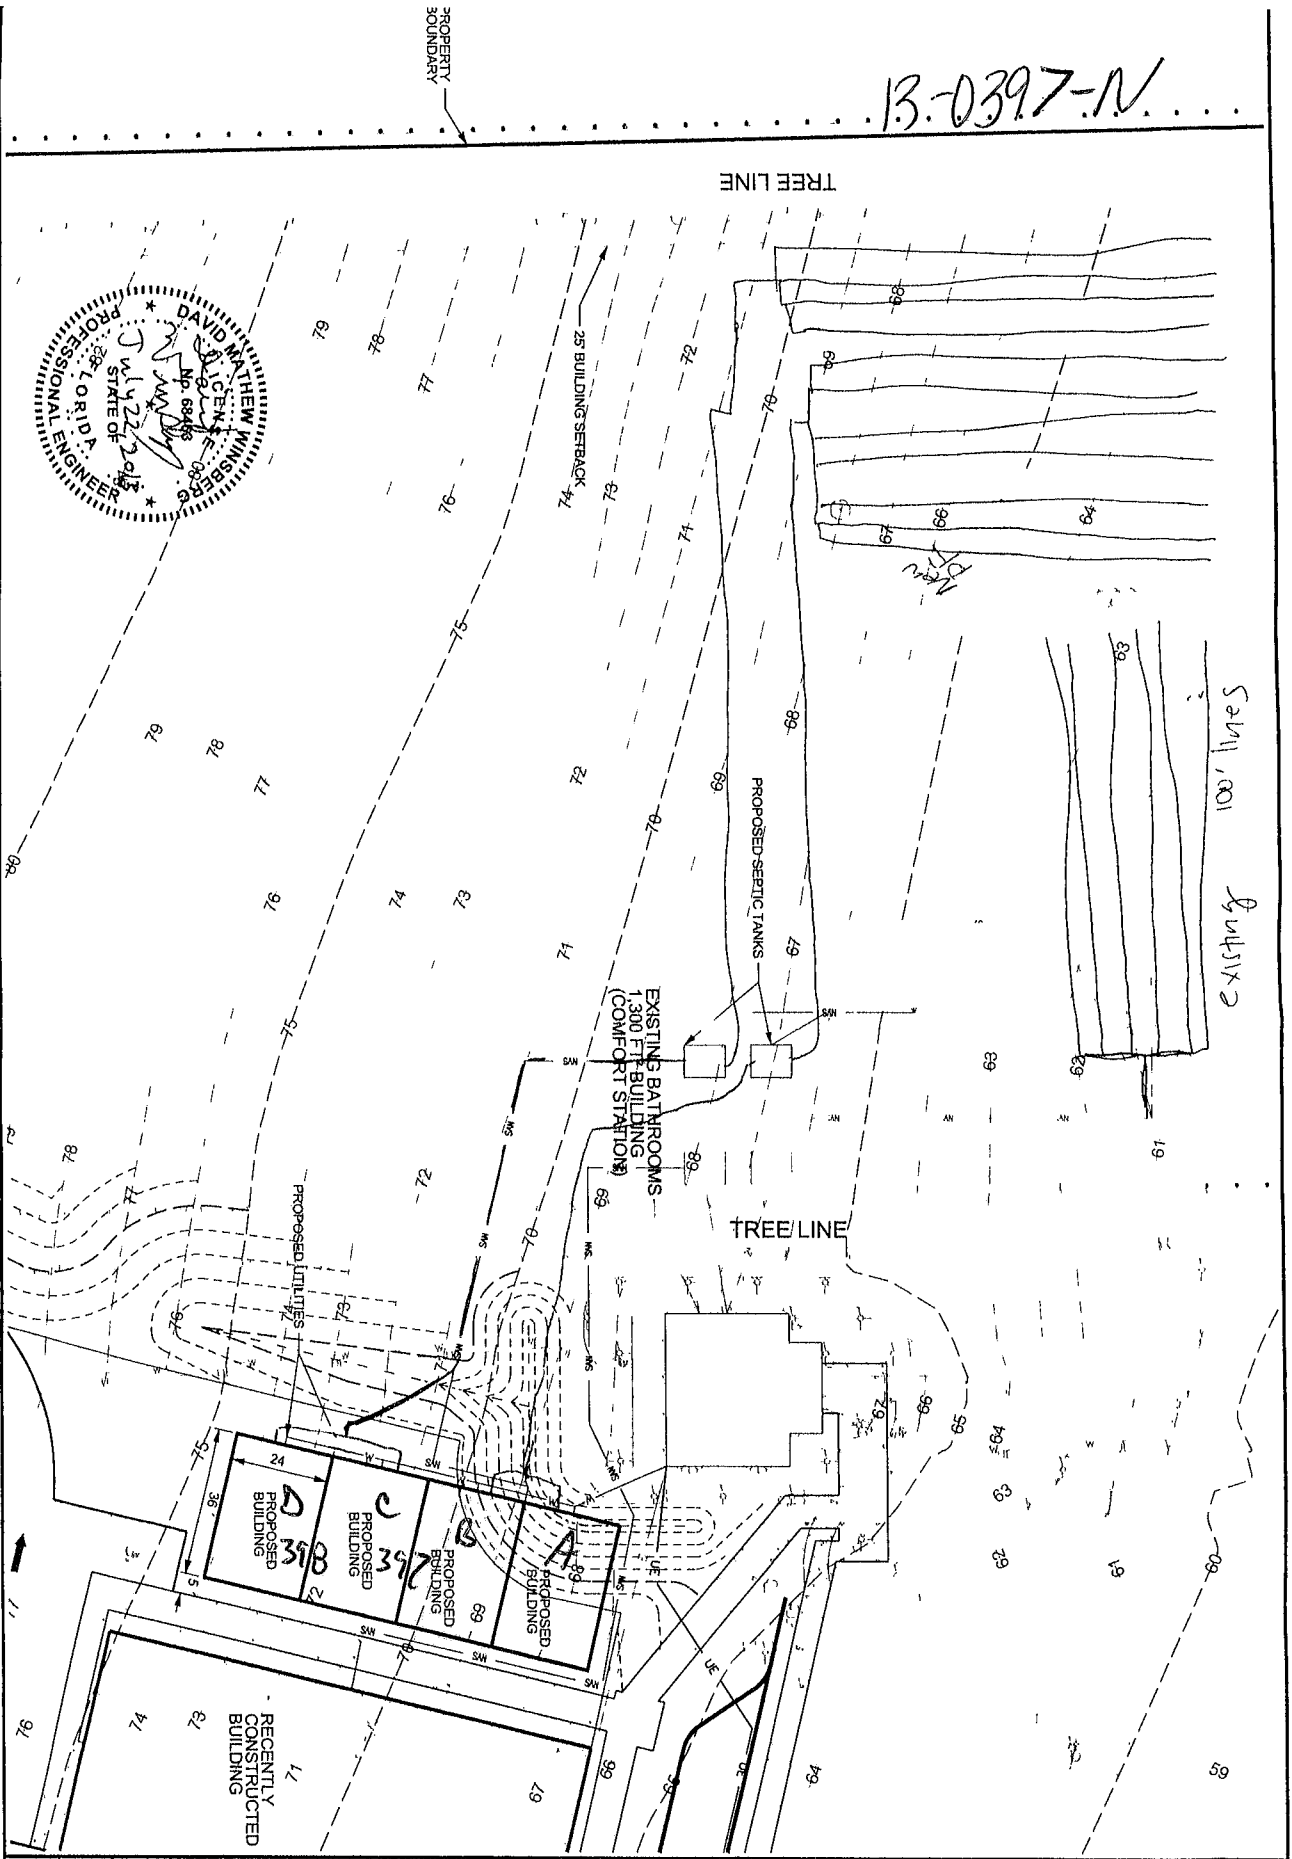

\\1130 Mountaintop Ministries\Belmont Church Location\CAD\PORTABLE\EST\01.dgn 7/22/2013 1:46:58 AM

REVISION NOTES		DATE
BELMONT ACADEMY PORTABLE CLASSROOM STRUCTURES		
SITE PLAN		
David M Winsberg Winsberg, Inc. P O Box 2815 Lake City FL, 32056 PE# 68463 - CA# 29596		
For Permitting and Review Not Final		
DRAWN BY DW	CHECKED BY DW	PROJECT # 1130
SHEET		