



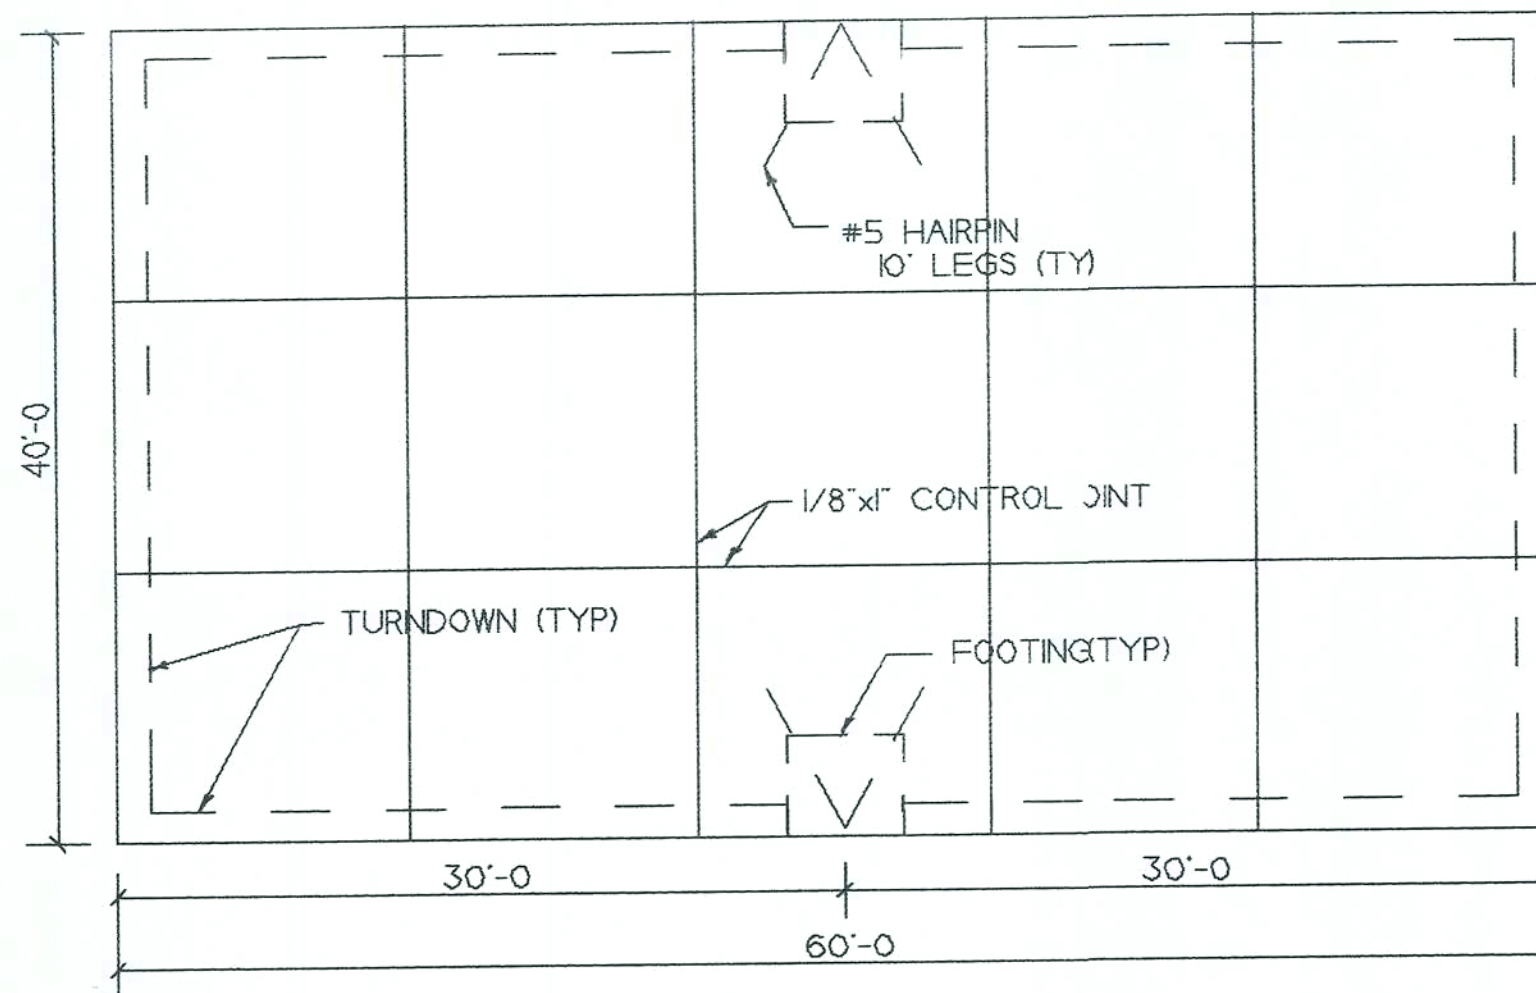


FOUNDATION PLAN
NOT TO SCALE

NOTES:

1. FOUNDATION IS DESIGNED TO BEAR ON SOIL CAPABLE OF SUPPORTING 2000 PSF.
2. CONCRETE WORK SHALL CONFORM TO ACI 318-83.
3. CONCRETE SHALL HAVE A MINIMUM COMPRESSIVE STRENGTH OF 3000 PSI IN 28 DAYS.
4. REINFORCING STEEL SHALL CONFORM TO ASTM A618 GRADE 60 AND HAVE A MINIMUM SPLICE LAP OF 2 INCHES. CORNER BARS SHALL BE PROVIDED AT EACH CORNER.
5. WELDED WIRE FABRIC SHALL CONFORM TO ASTM A5 AND HAVE A MINIMUM SIDE LAP OF 8 INCHES.
6. FIBER MESH MAY BE USED IN LIEU OF WELDED WIRE FABRIC.

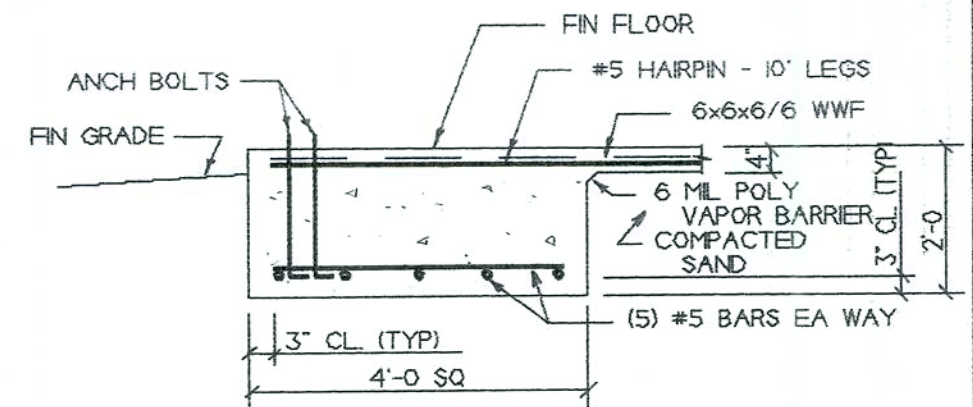

TYPICAL FOOTING SECTION
NOT TO SCALE

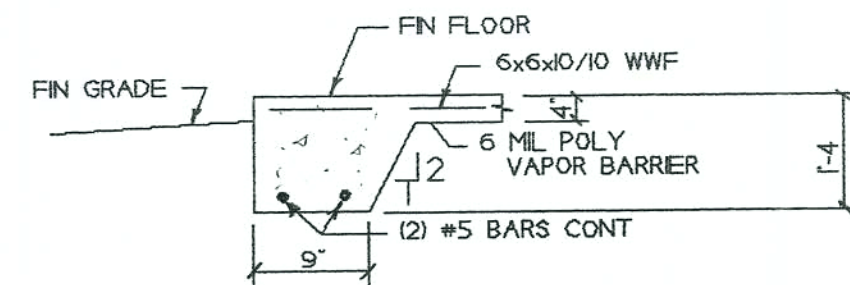

TYPICAL TURNDOWN
NOT TO SCALE

EXCELSIOR BUILDINGS
3724 US 82 WEST TIFTON, GA


FOUNDATION PLAN
VINCE RICHARDS
COLUMBIA COUNTY, FL

HARRY V. WHIDDON, P.E.
2195 OLD QUITMAN RD ADEL, GA
(229) 549-6215 PE 38969

DATE	1-23-08	REV.		DRWN	V.W.
SCALE	AS SHOWN	REV.		SHEET	1 OF 2

[Signature]
1-23-08

DATE 1-23-08	REV.	DRWN V.W.
SCALE AS SHOWN	REV.	SHEET 2 OF 2

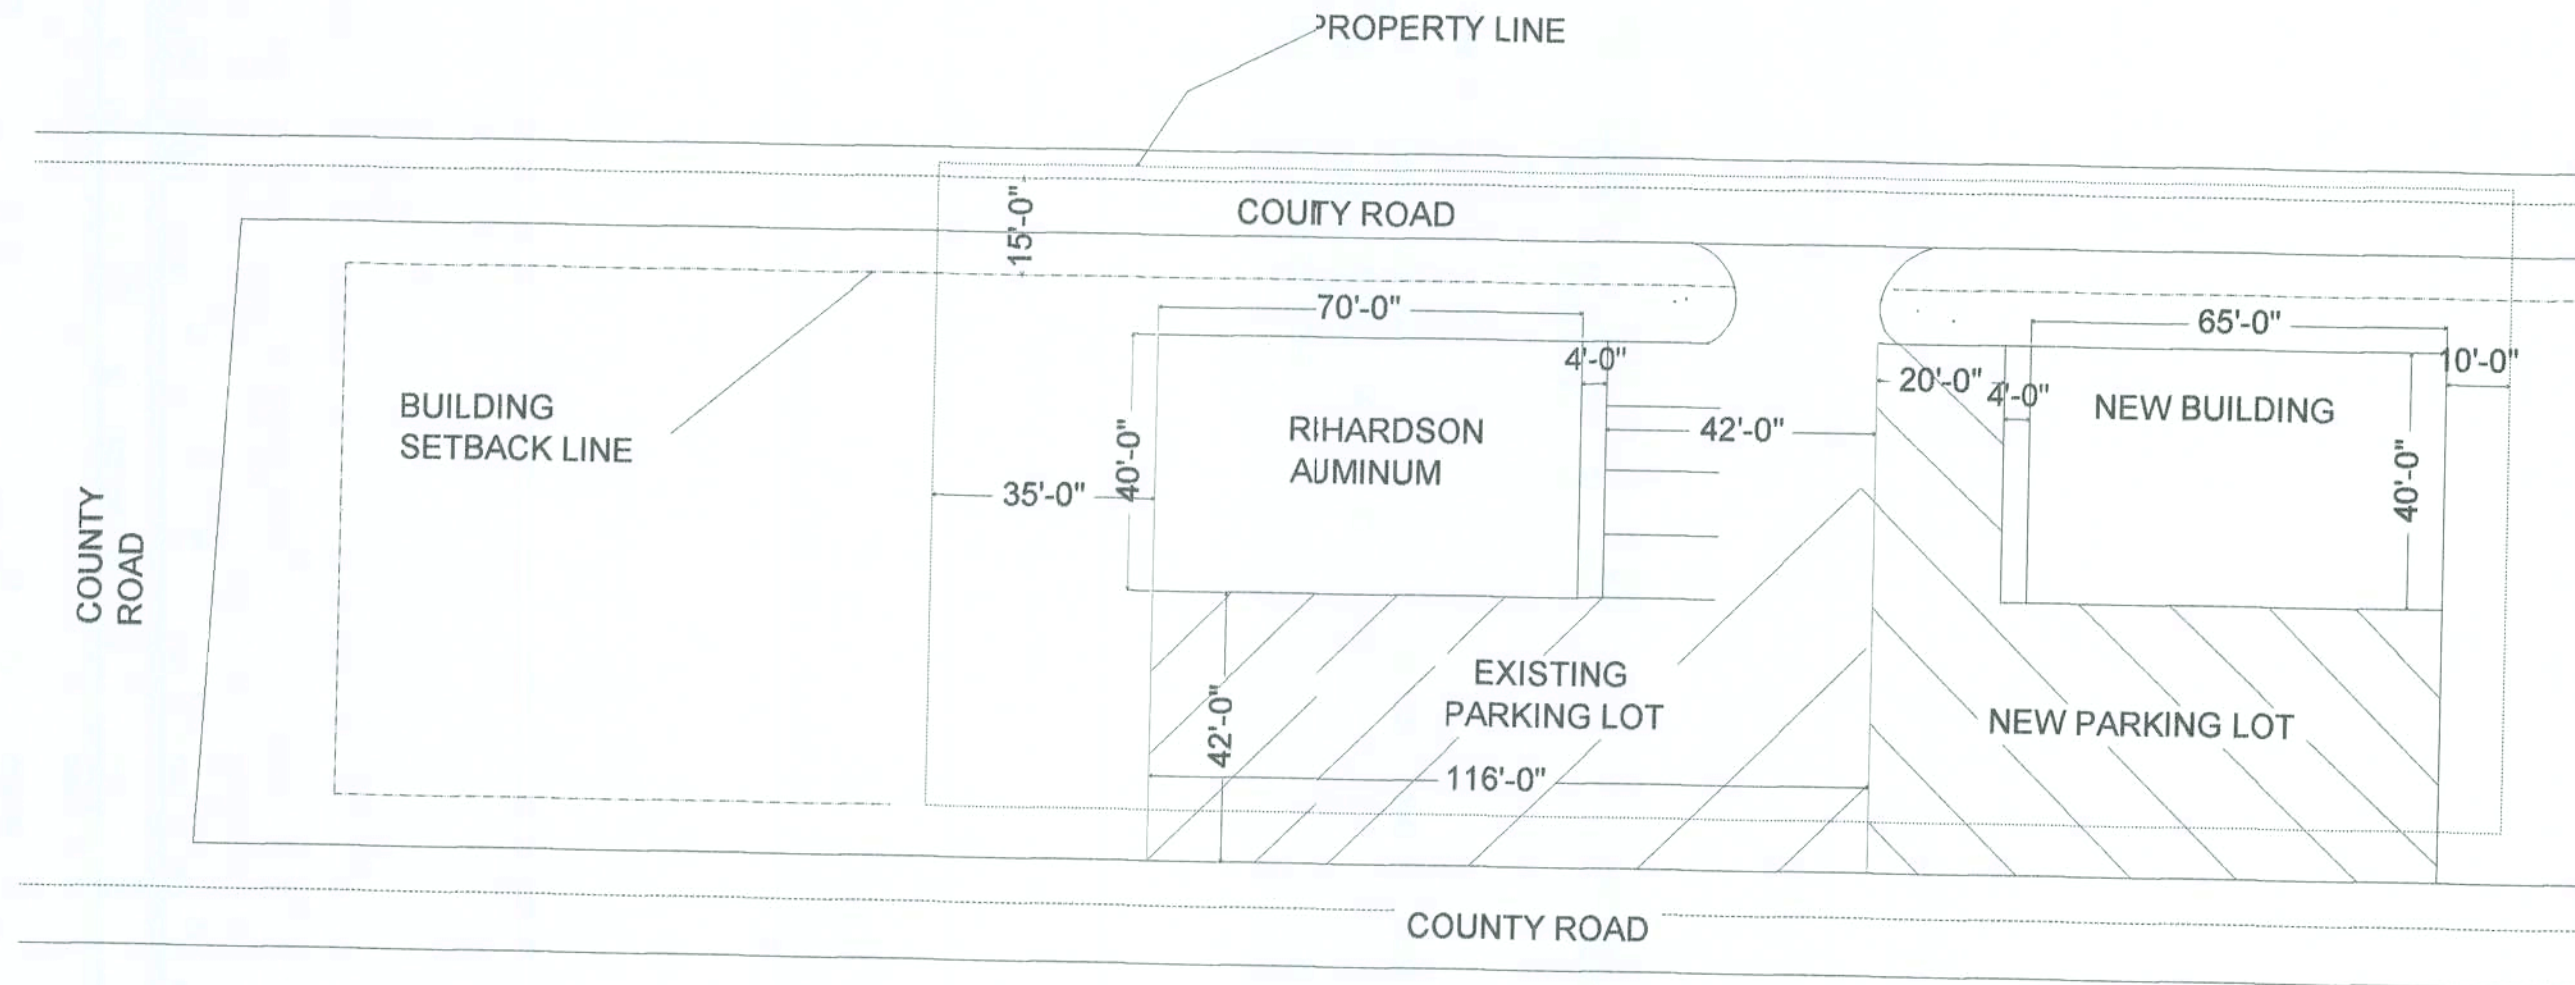

SITE PLAN

SCALE
1" = 30'


PAGE

2 OF 2

RICHARDSON
ALUMINUM

DATE: 1/25/08


DONNY WILLIAMS CONSTRUCTION
541 SW AIRPARK GLEN
LAKE CITY, FL 32025
PHONE 386-755-0764

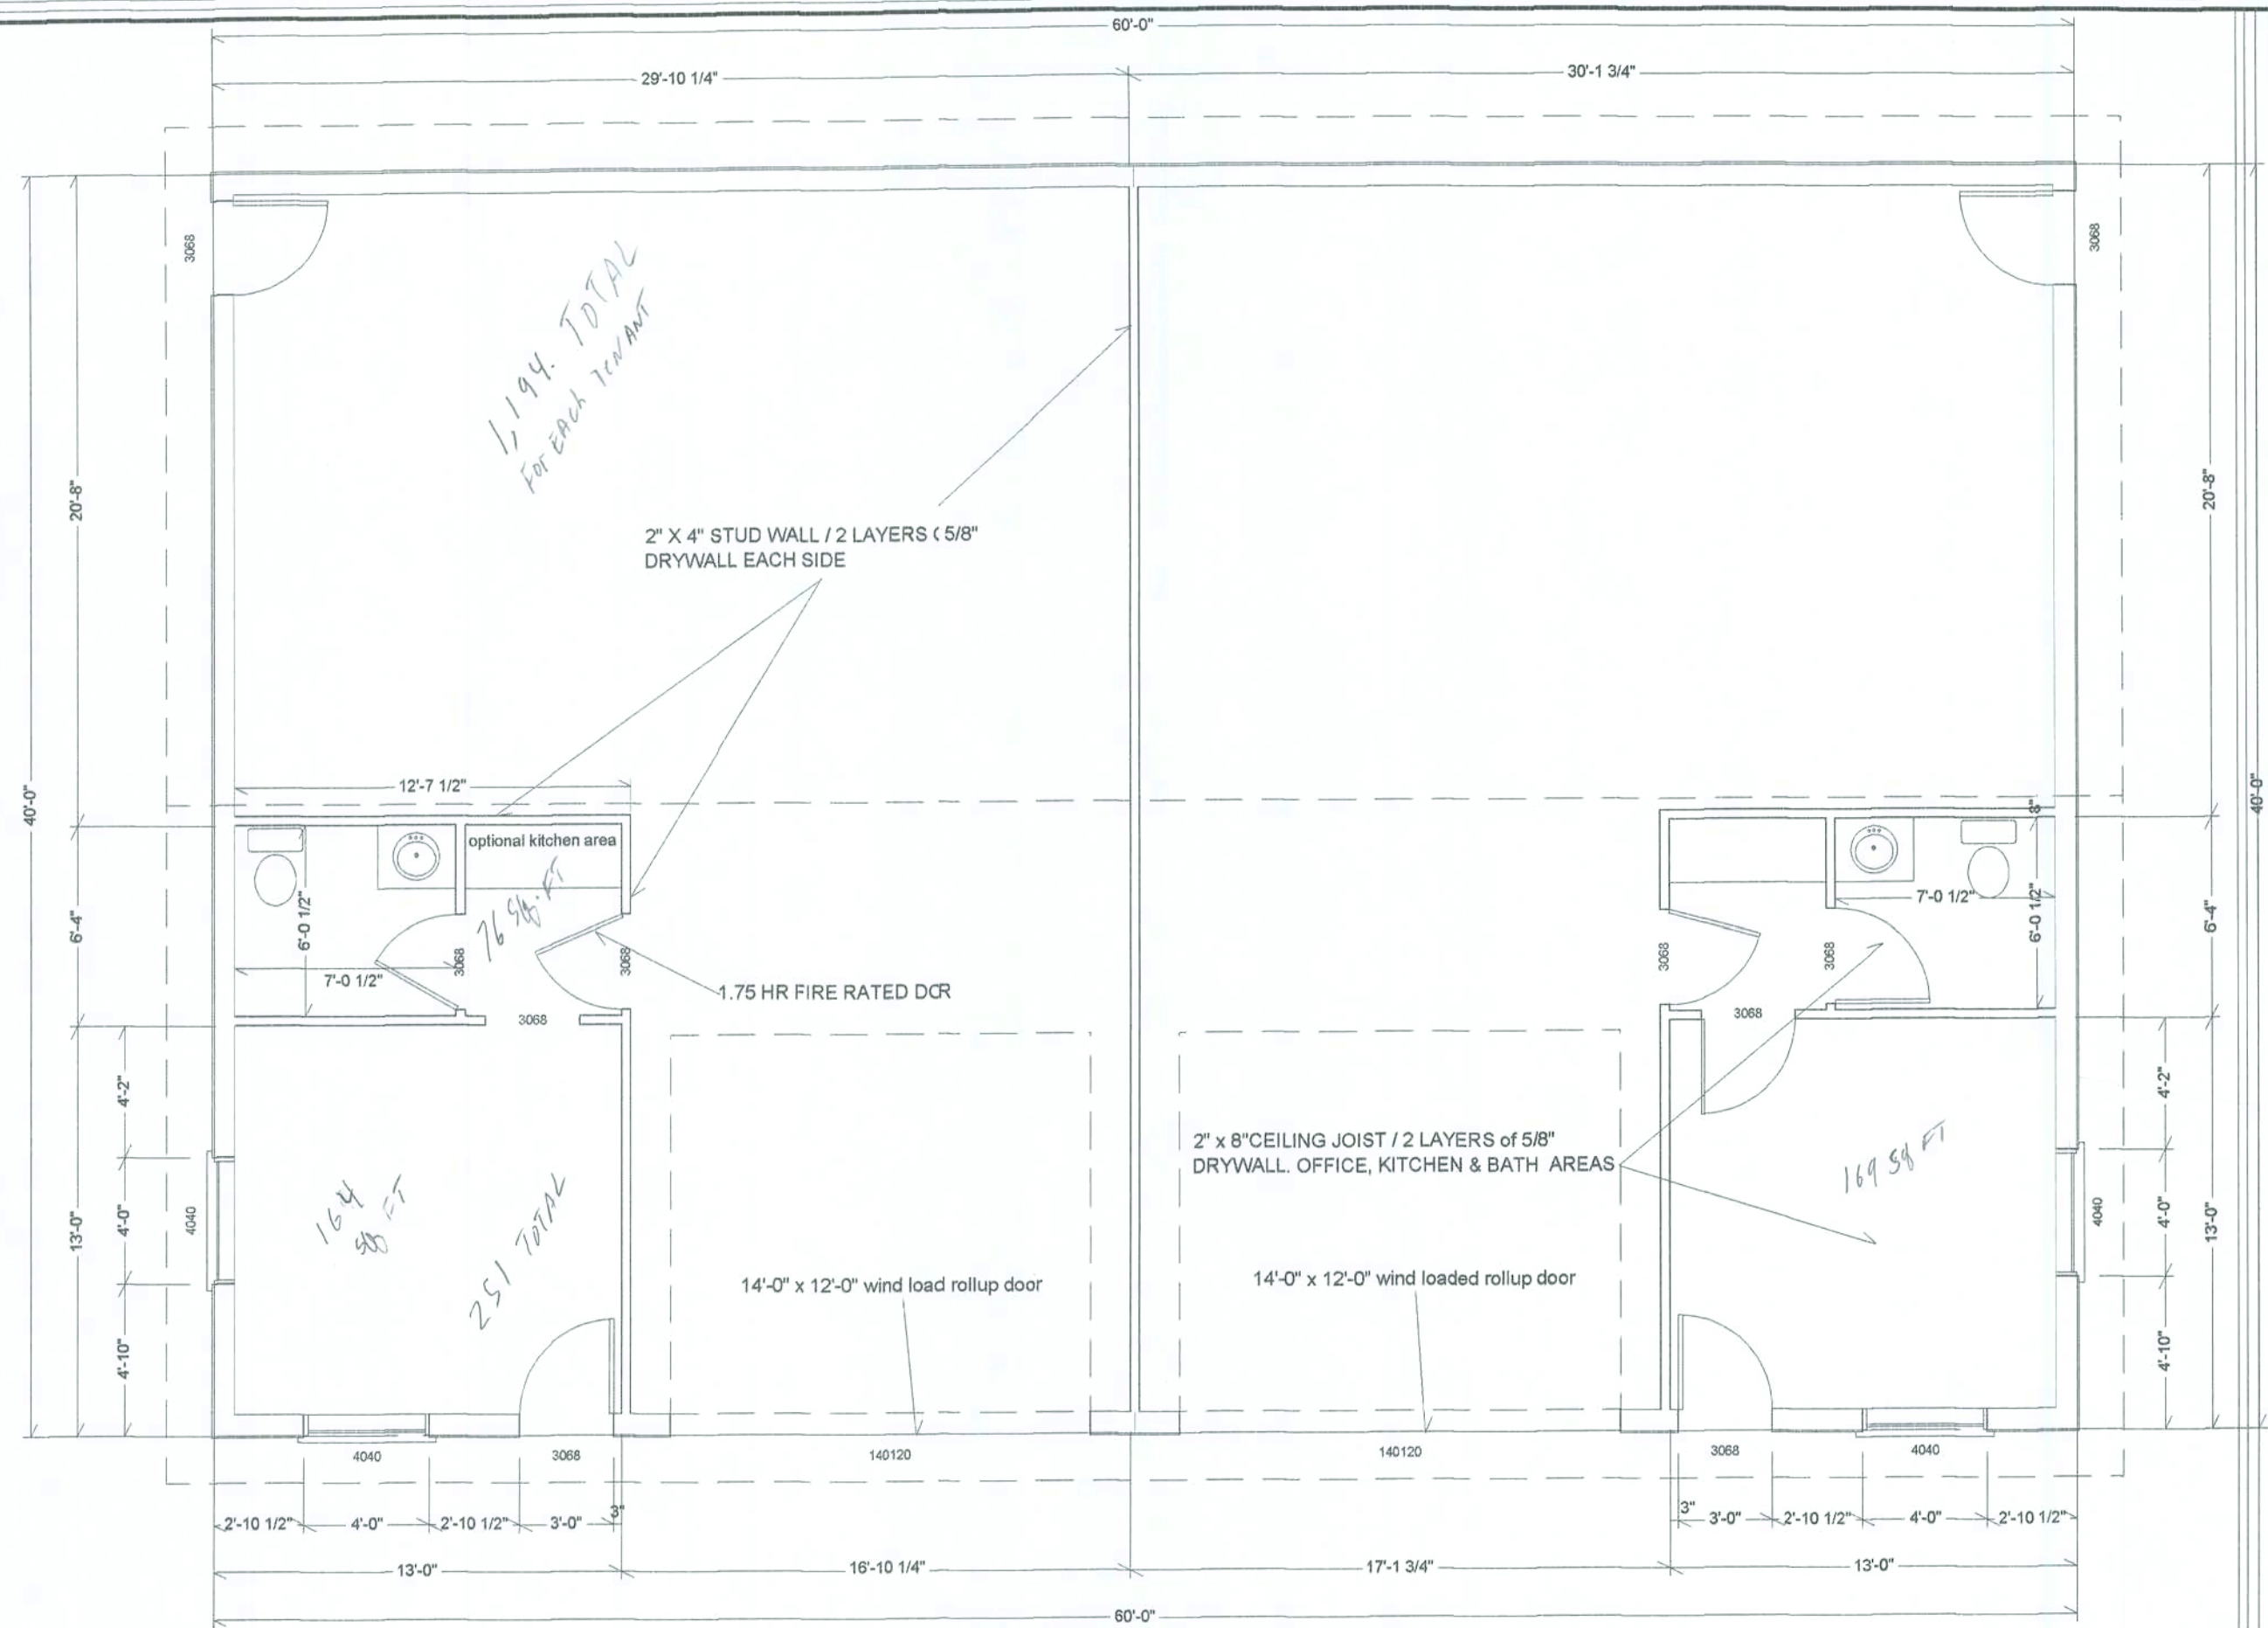

VINCE RICHARDSON BUILDING 2

DONNY WILLIAMS CONSTRUCTION
541 SW AIRPARK GLEN
LAKE CITY, FL 32025
PHONE 386-755-0764

RICHARDSON
ALUMINUM
DATE: 1/25/08

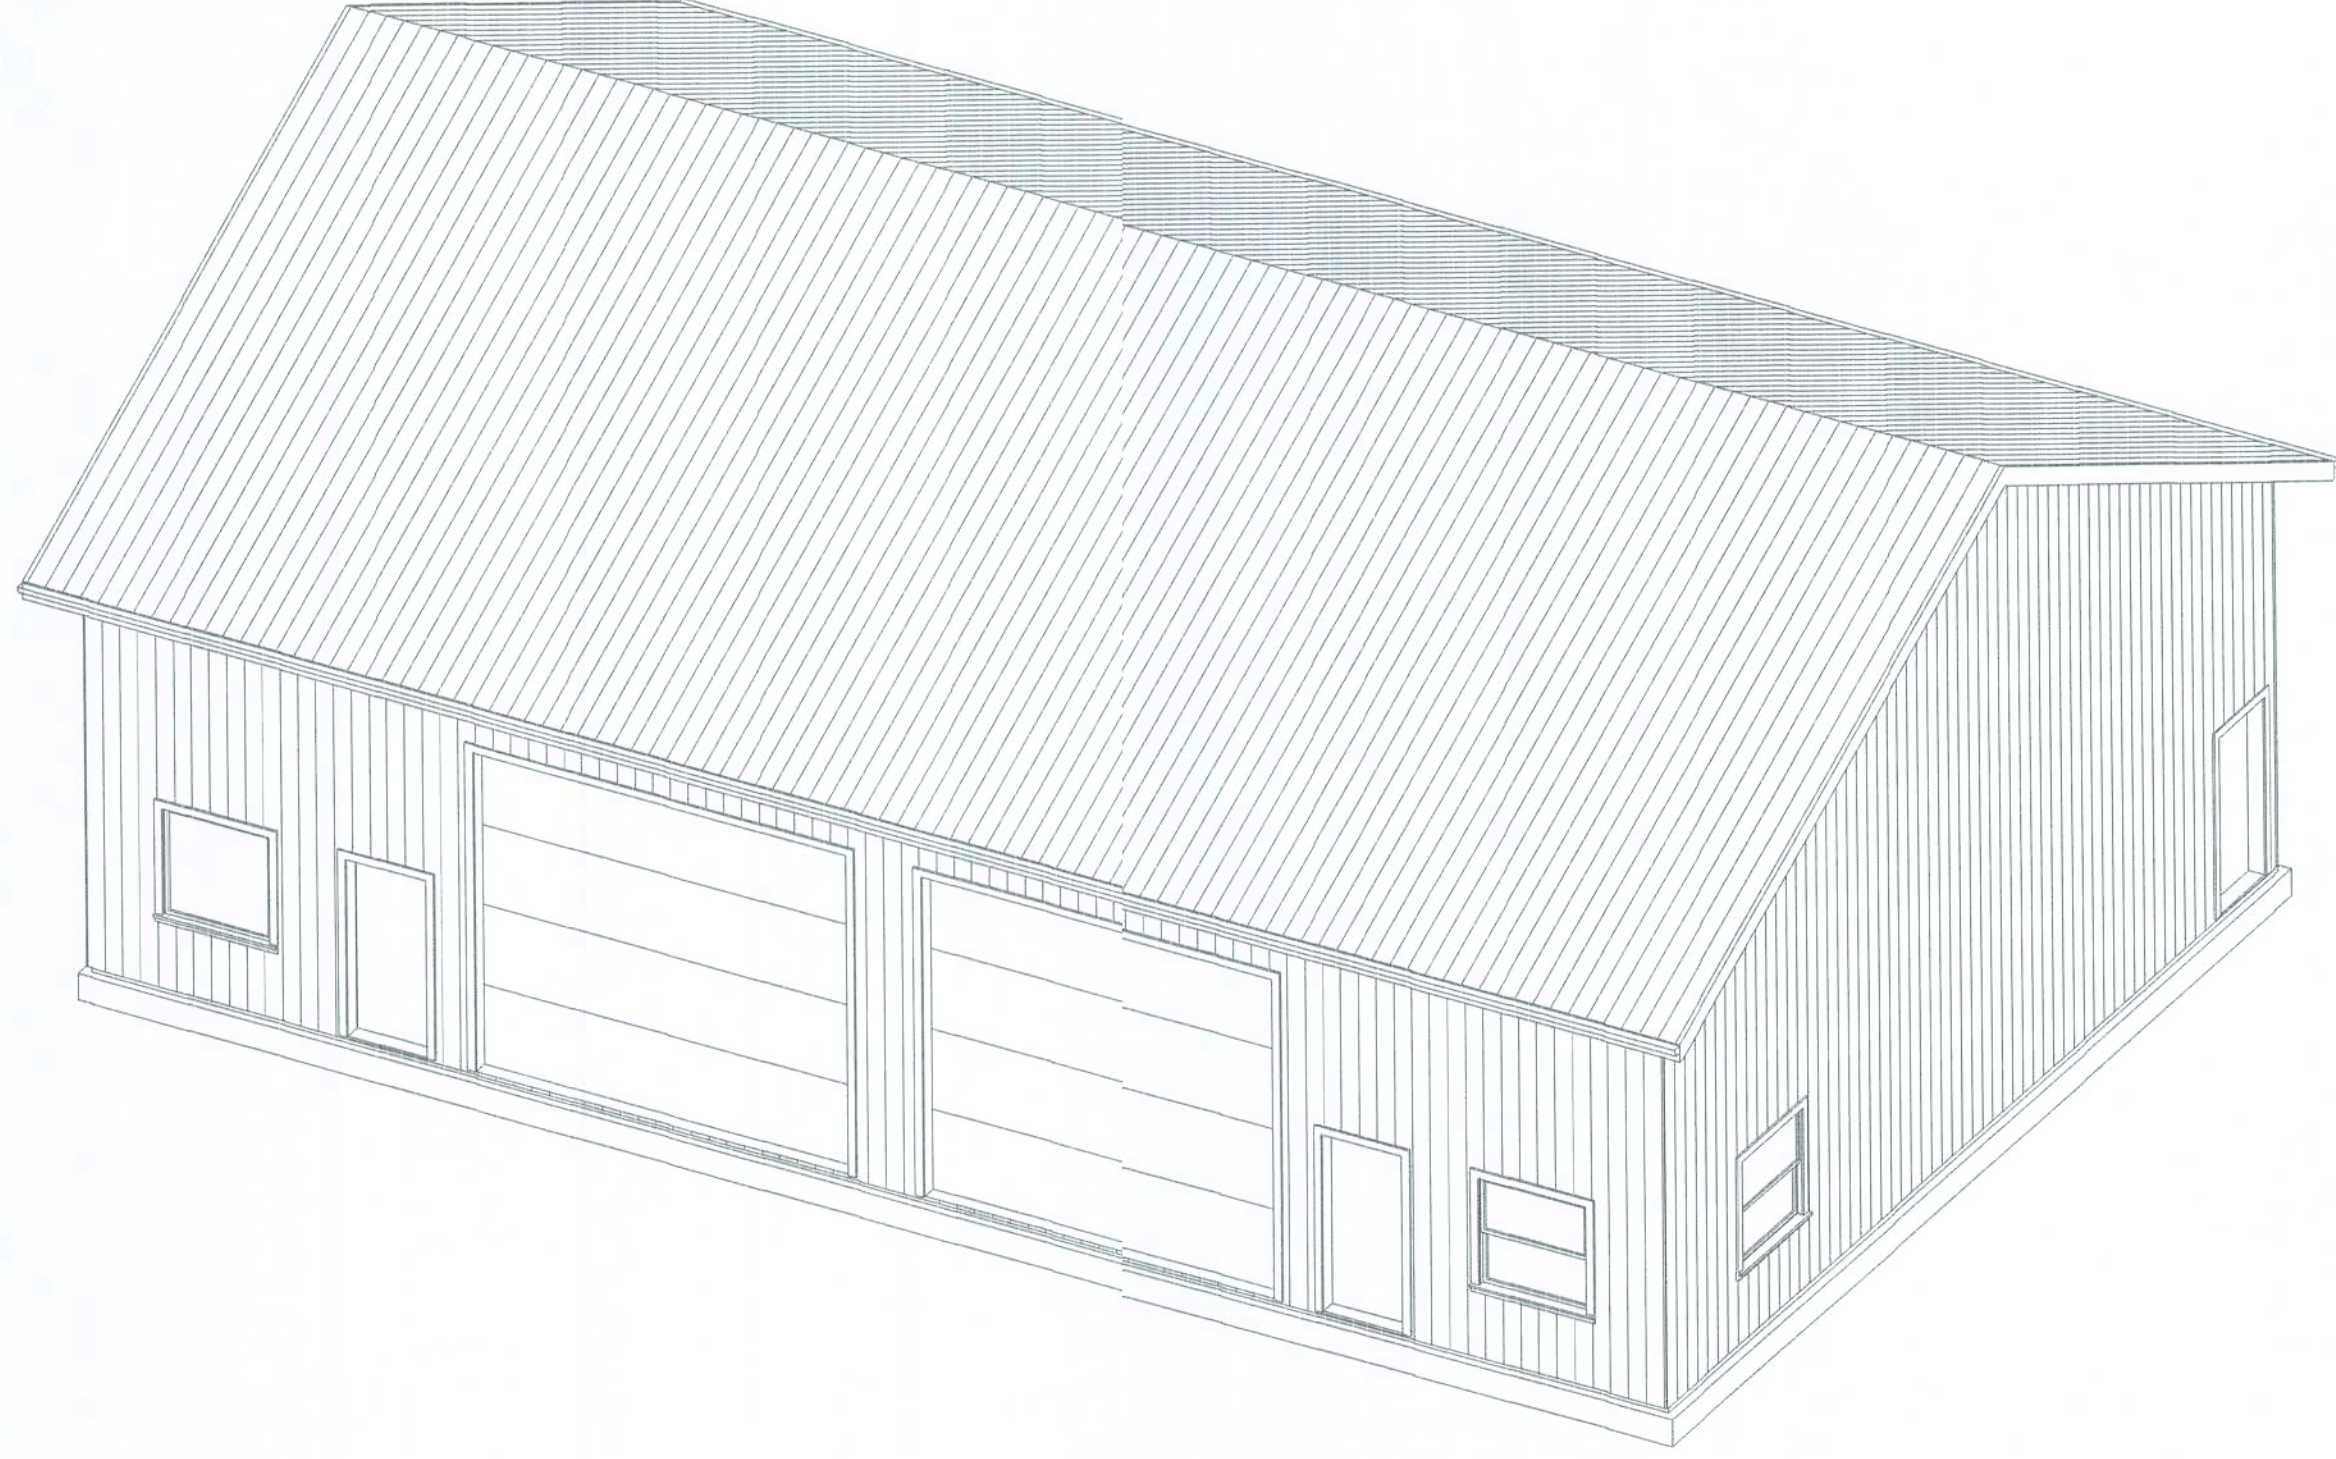

PAGE


4 OF 2

RICHARDSON

ALUMINUM

DATE: 1/25/08

DONNY WILLIAMS CONSTRUCTION
541 SW AIRPARK GLEN
LAKE CITY, FL 32025
PHONE 386-755-0764

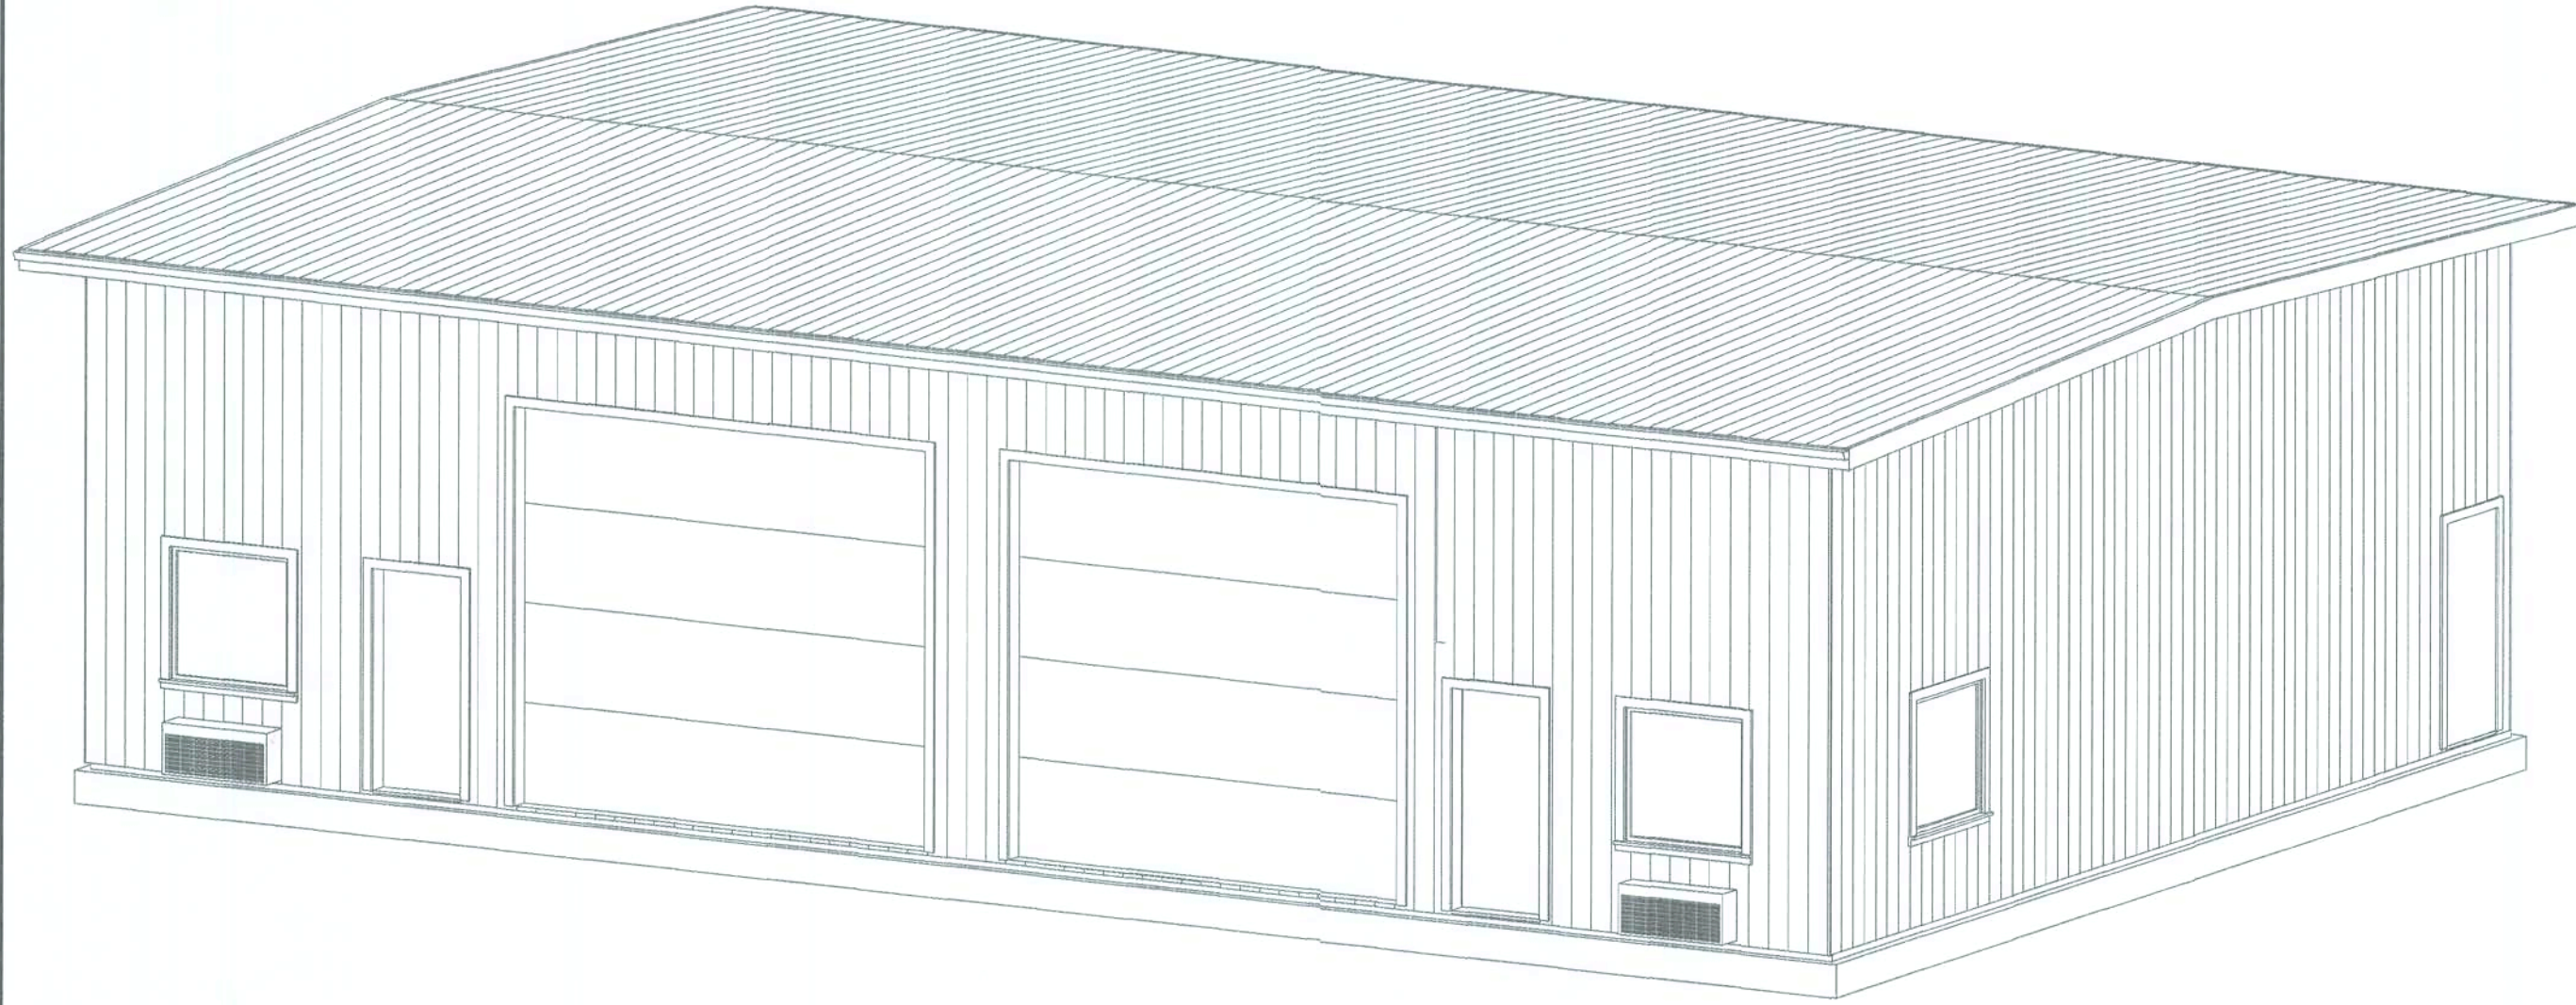

RICHARDSON BUILDING #2

DONNY WILLIAMS CONSTRUCTION
541 SW AIRPARK GLEN
LAKE CITY, FL 32025
PHONE 386-755-0764
FAX 386-733-0134

RICHARDSON
ALUMINUM
DATE: 1/25/08
BY: _____

PAGE
1 OF 7




DONNY WILLIAMS CONSTRUCTION
541 SW AIRPARK GLEN
LAKE CITY, FL 32025
PHONE 386-755-0764

**RICHARDSON
ALUMINUM**


DATE: 1/25/08

PAGE

2 OF 7

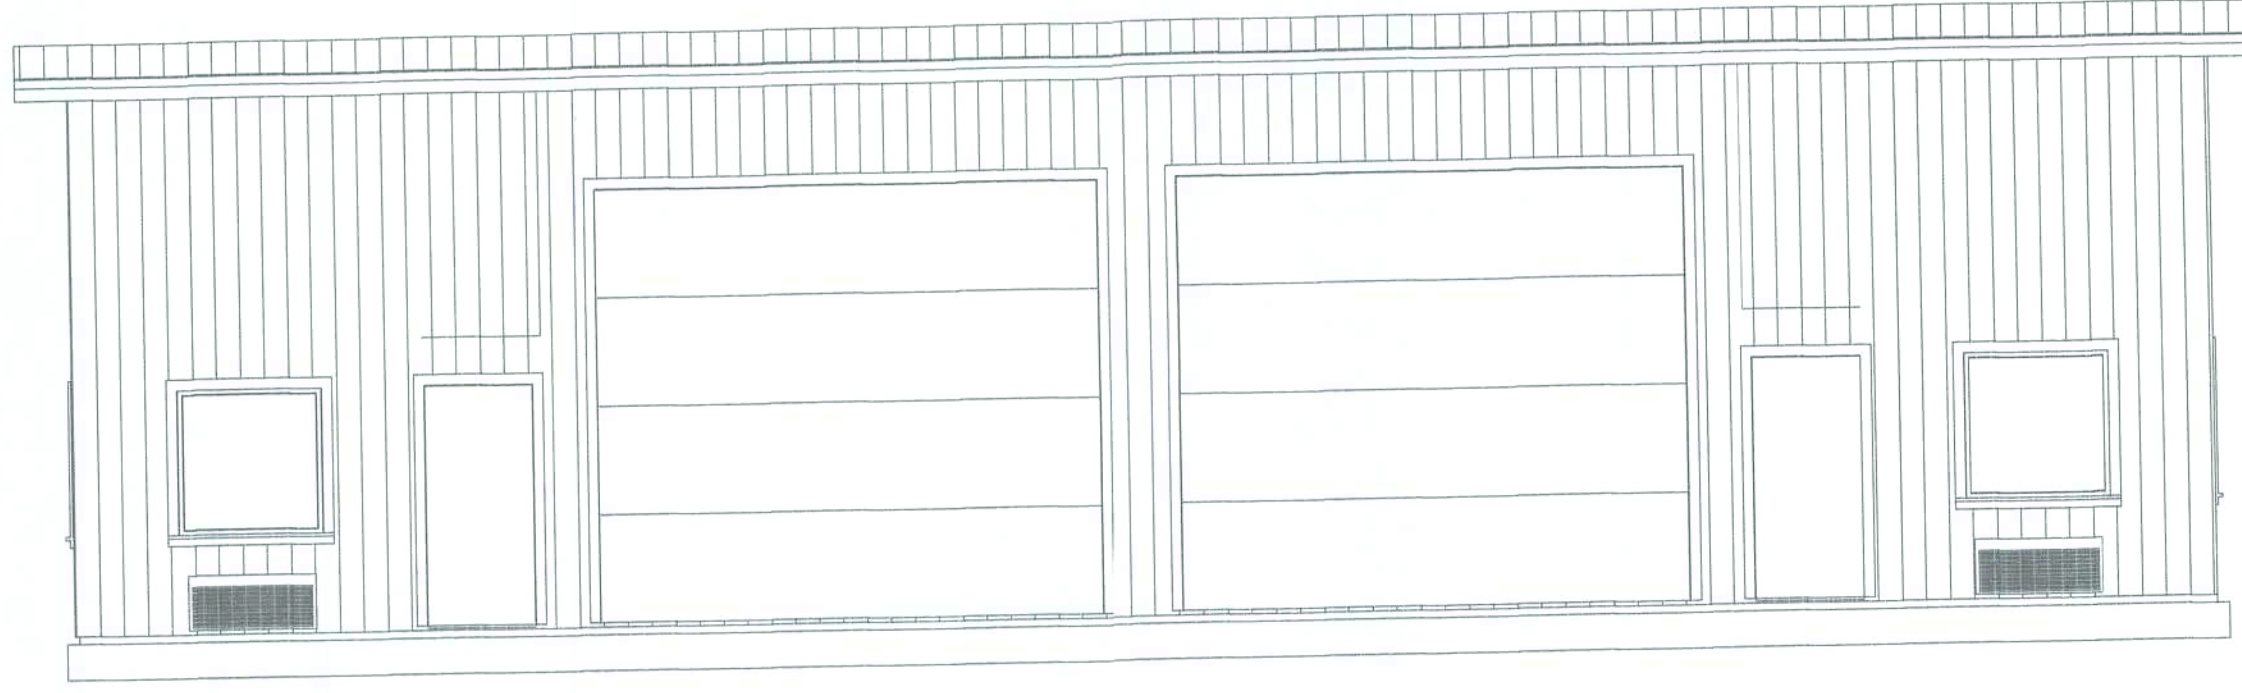

FRONTELEVATION

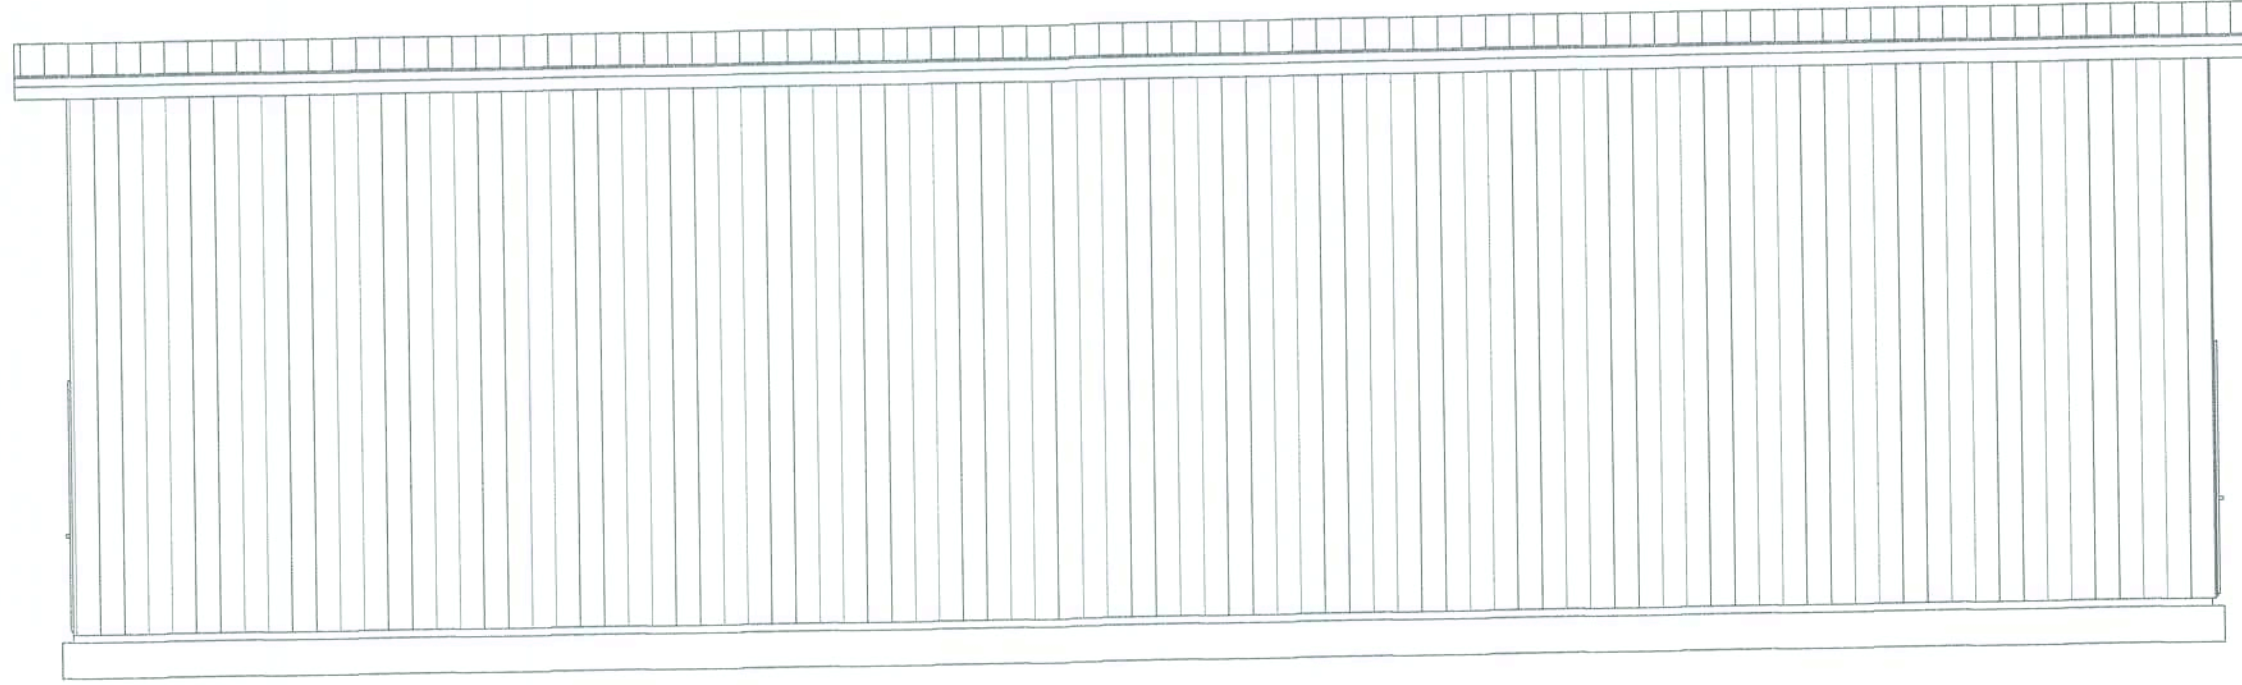

REAR ELEVATION


PAGE

3 OF 7


RICHARDSON
ALUMINUM

DATE: 1/25/08

DONNY WILLIAMS CONSTRUCTION
541 SW AIRPARK GLEN
LAKE CITY, FL 32025
PHONE 386-755-0764

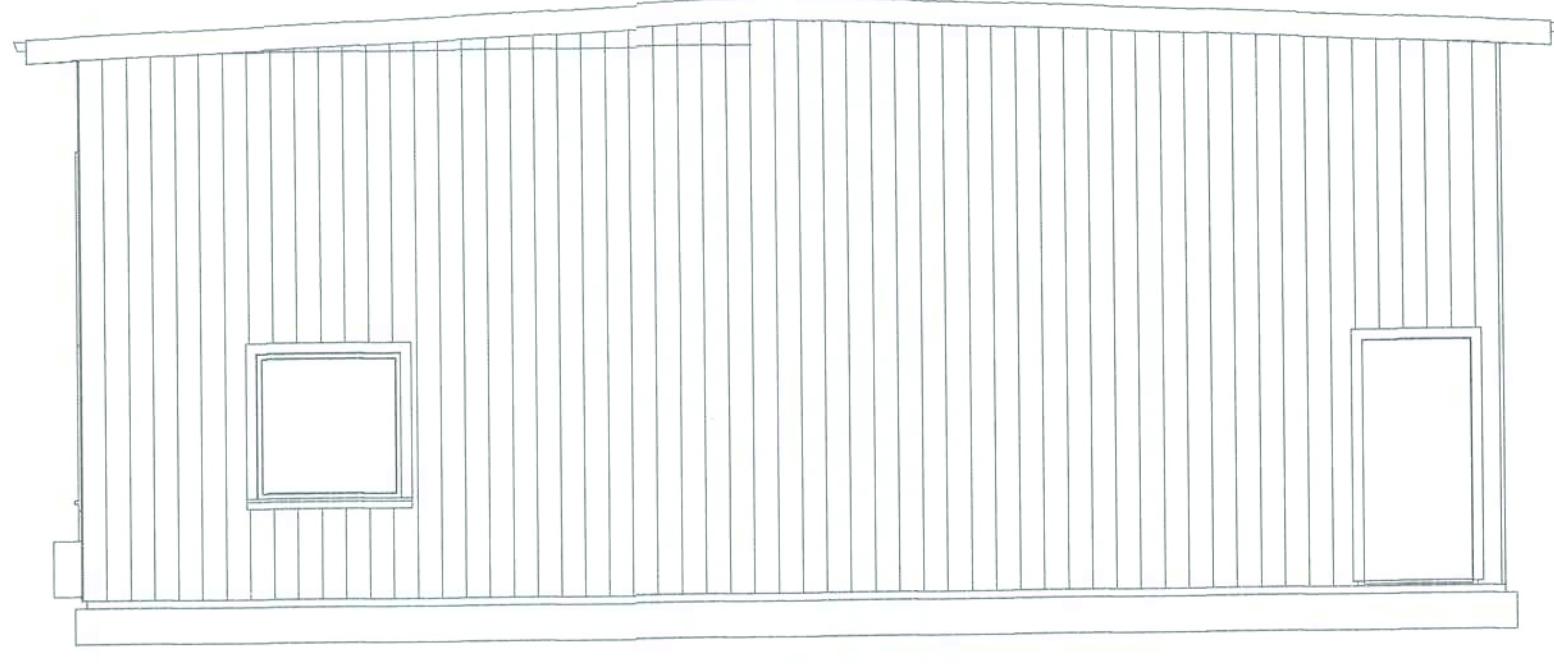

RIGHT ELEVATION

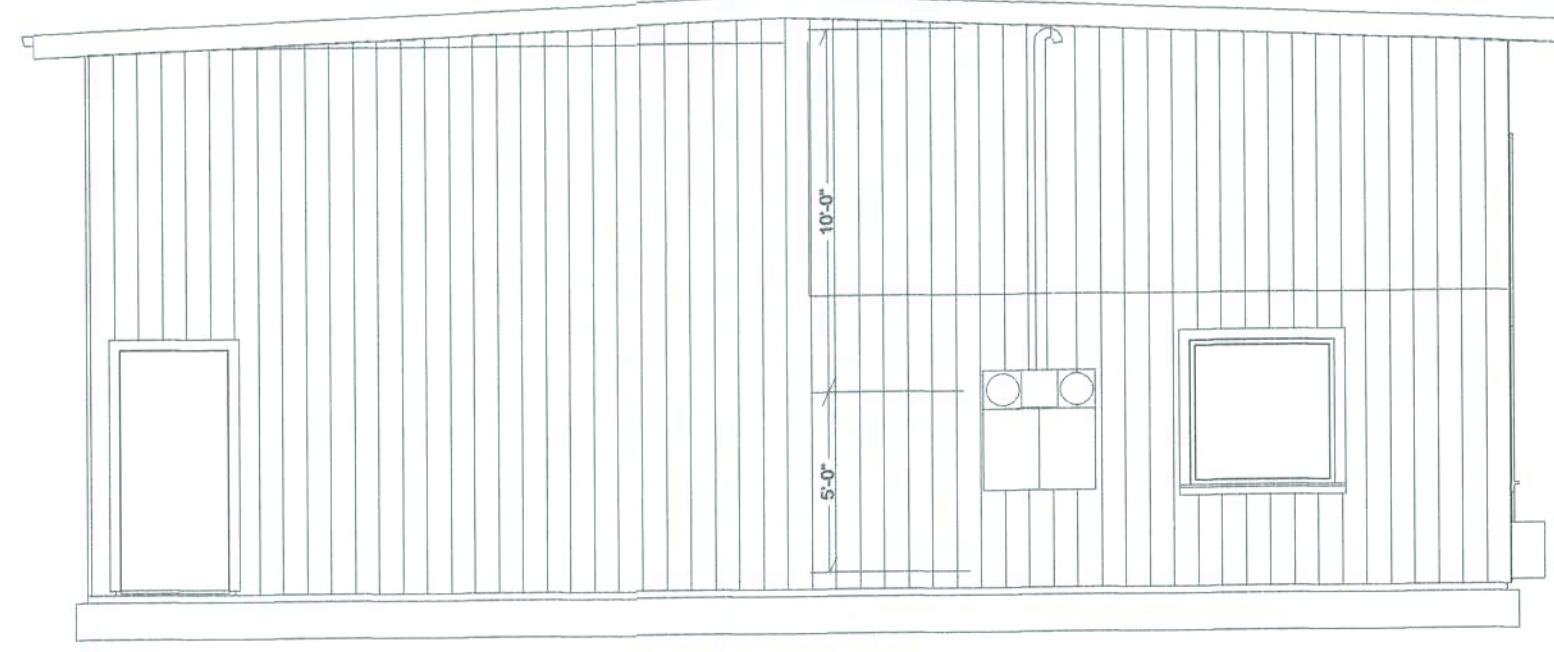


LEFT ELEVATION

PAGE
4 OF 7

RICHARDSON
ALUMINUM
DATE: 1/25/08

DONNY WILLIAMS CONSTRUCTION
541 SW AIRPARK GLEN
LAKE CITY, FL 32025
PHONE 386-755-0764

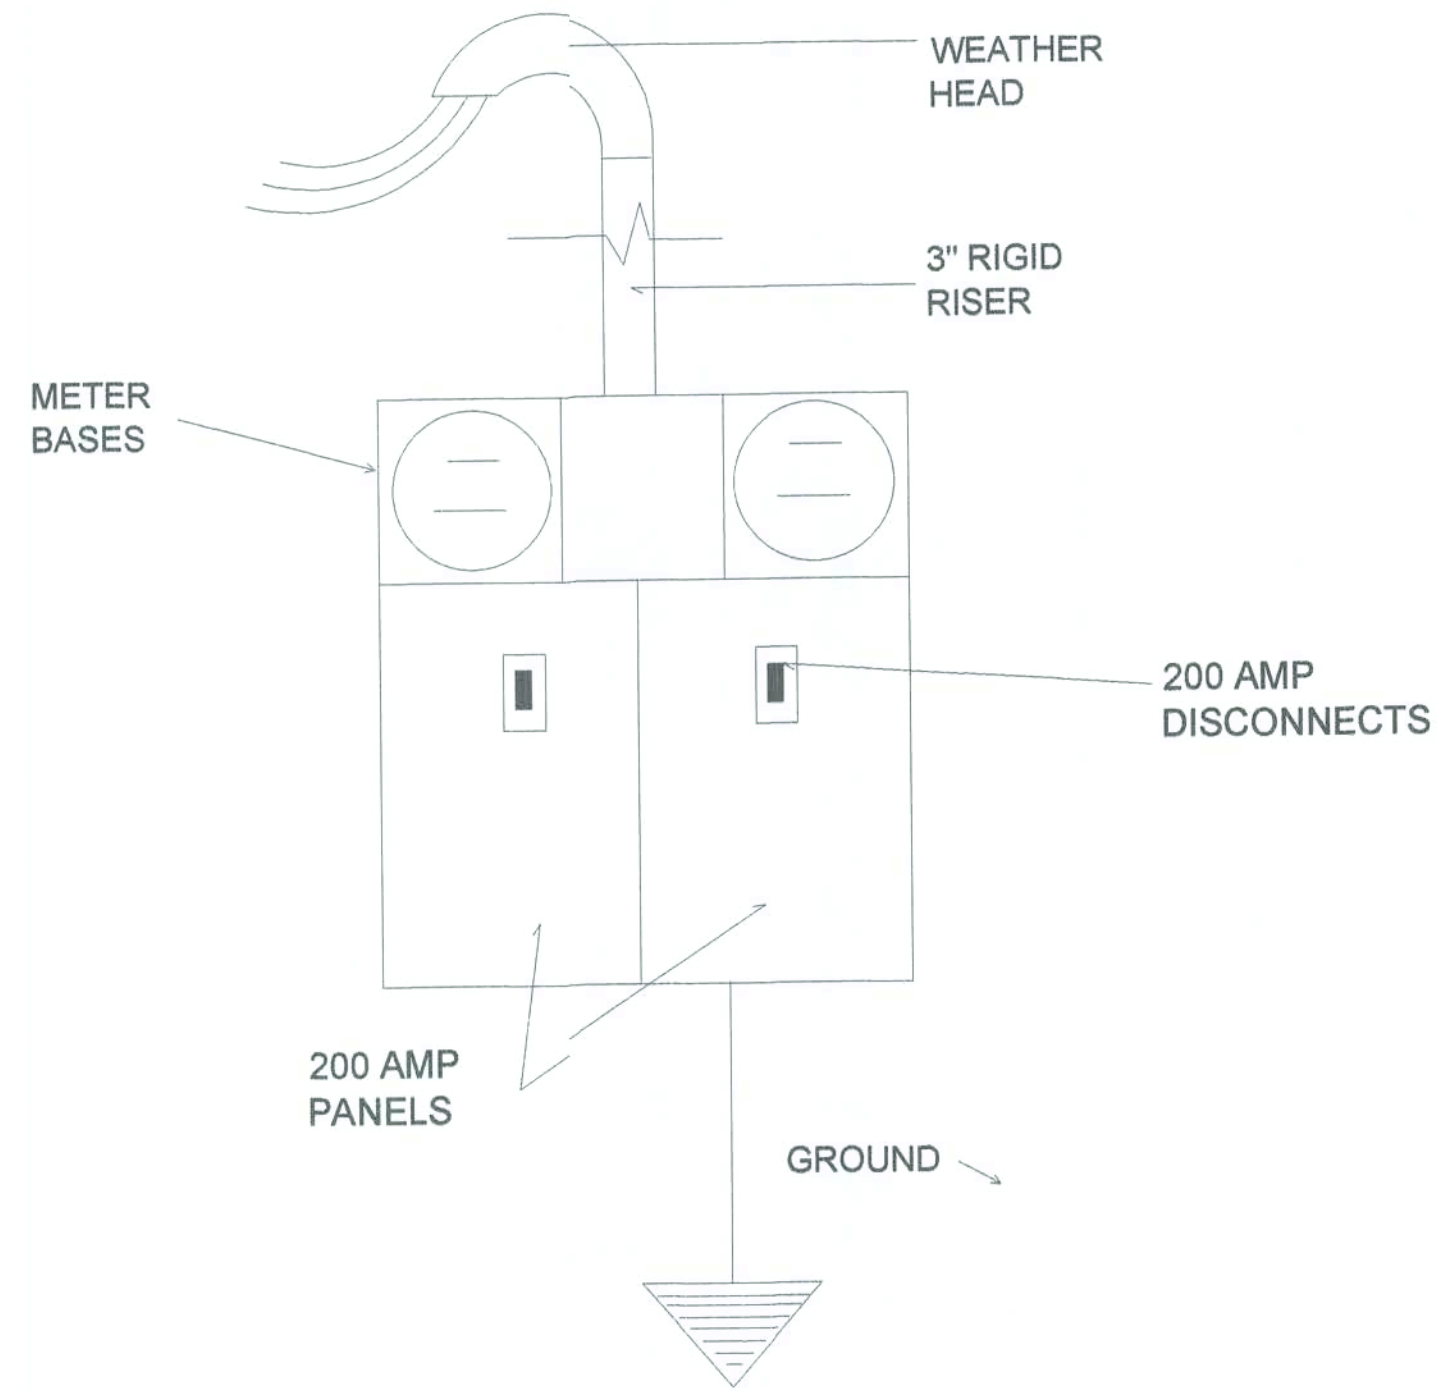

ELECTRICAL RISER DIAGRAM

ALSO SEE EFT ELEVATION DRAWING

DONNY WILLIAMS CONSTRUCTION
541 SW AIRPARK GLEN
LAKE CITY, FL 32025

PHONE 386-755-0764

RICHARDSON
ALUMINUM

DATE: 1/25/08

PAGE

5 OF 7

COUNTY
ROAD

BUILDING
SETBACK LINE

COUNTY ROAD

RICHARDSON
ALUMINUM

EXISTING
PARKING LOT

NEW BUILDING

NEW PARKING LOT

COUNTY ROAD

POWER
POLE

FIRE HYDRANT
+/-1000'

PROPERTY LINE

EDGE OF
ROAD

SCALE
1" = 30'

SITE PLAN


DONNY WILLIAMS CONSTRUCTION
541 SW AIRPARK GLEN
LAKE CITY, FL 32025
PHONE 386-755-0764

RICHARDSON
ALUMINUM

DATE: 1/25/08

PAGE

6 OF 7

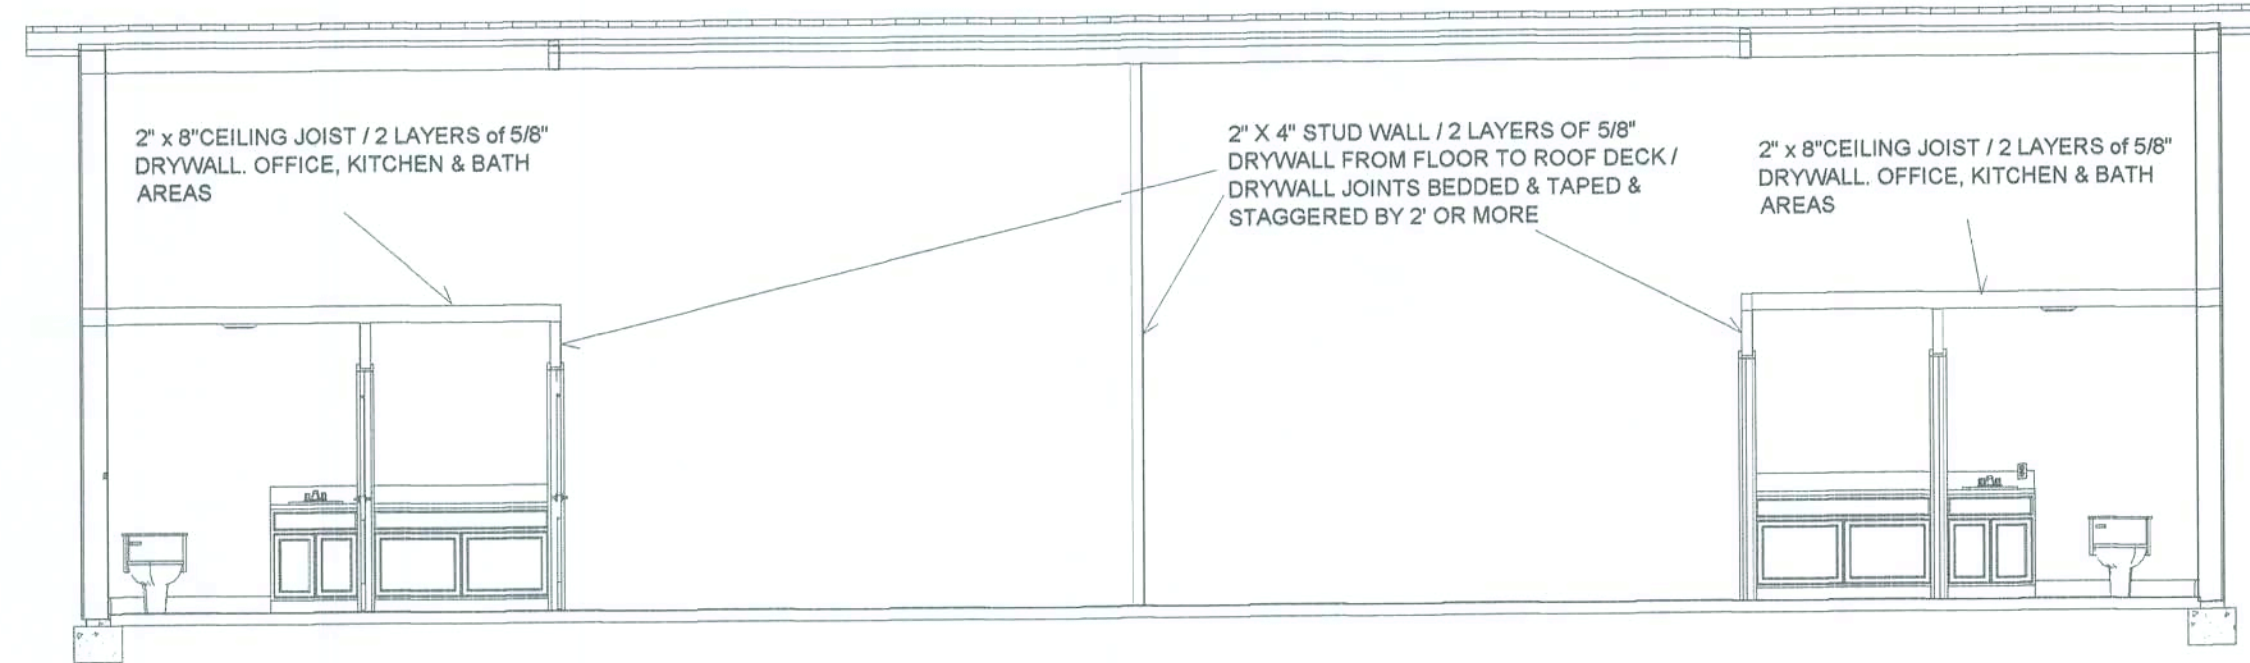

**CROSS SECTION OF PARTITION WALL
AND OTHER 2 HR WALLS**

DONNY WILLIAMS CONSTRUCTION
541 SW AIRPARK GLEN
LAKE CITY, FL 32025
PHONE 386-755-0764

RICHARDSON
ALUMINUM
DATE: 1/25/08