


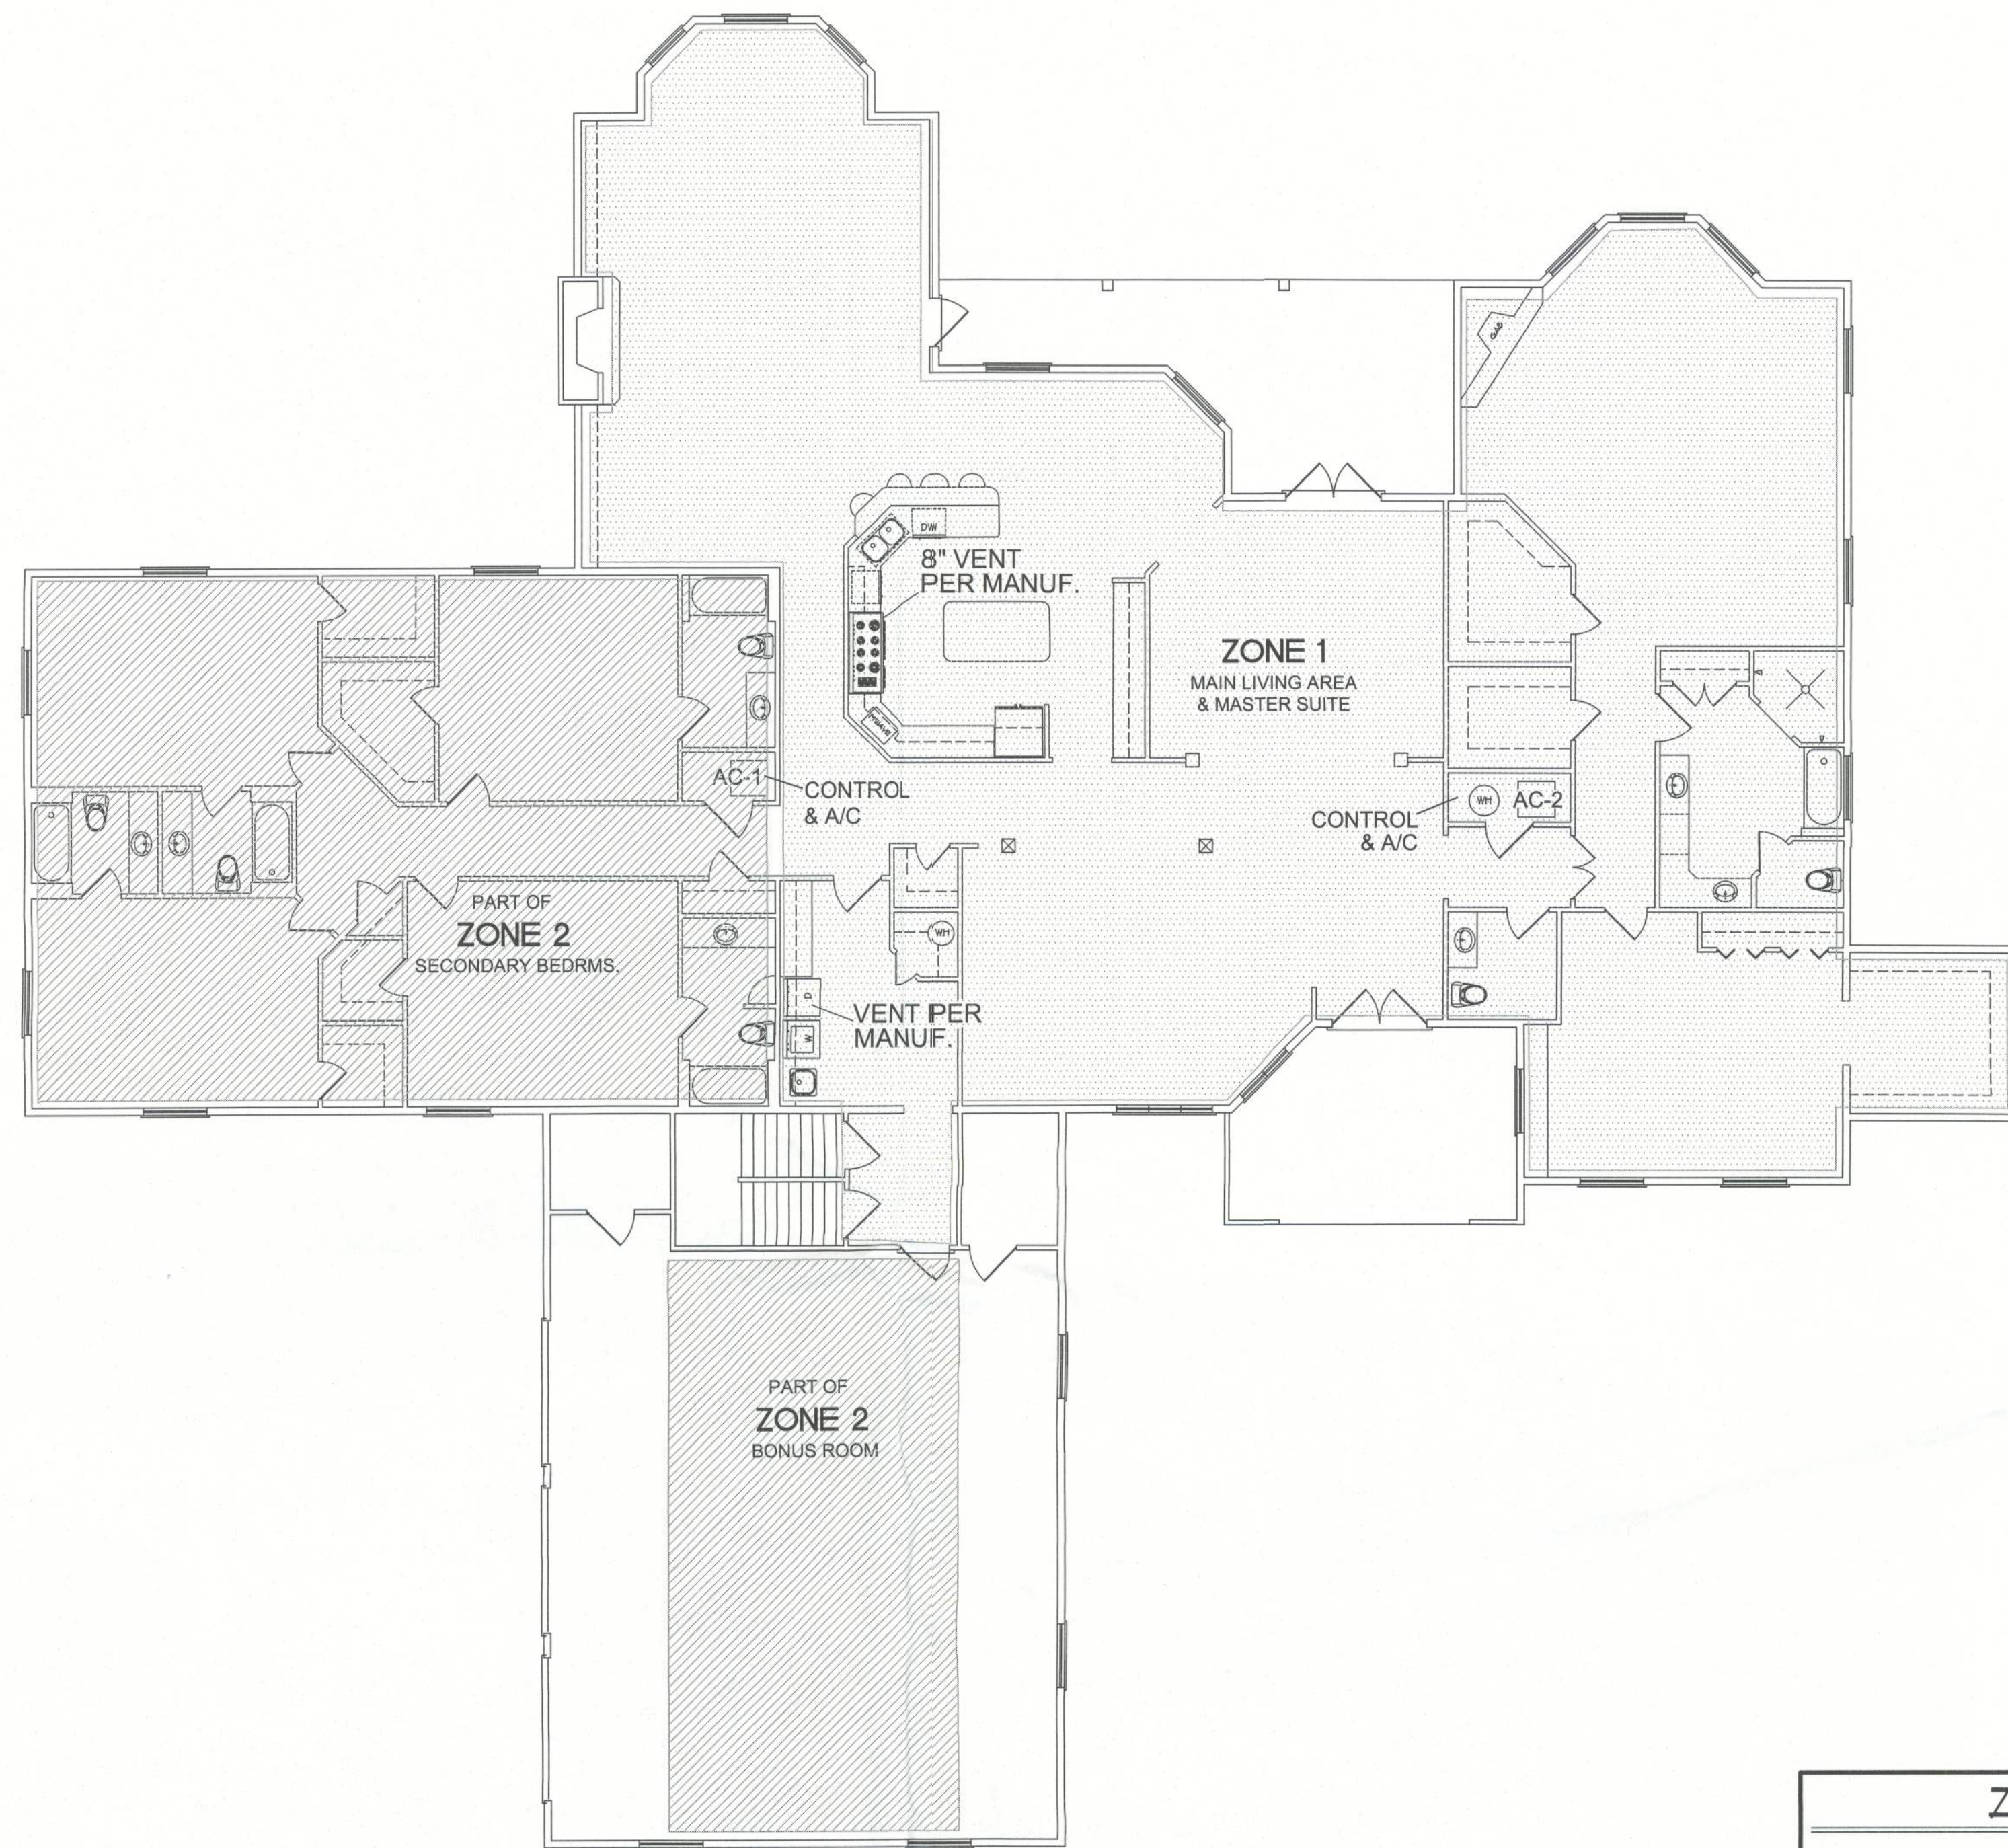

AC UNIT No. 1

5.1 TON Highest Efficiency - EER= Over 30
Carrier Model 50YDV-064 - 2 Stage Heating & Cooling - 10 year warranty
Variable Speed Blower - H.W.G. Domestic Hot Water Generator with Pump

AC UNIT No. 2

3.4 TON Highest Efficiency - EER= 31.5
Carrier Model YEVD38 - 2 Stage Heating & Cooling - 10 year warranty
Variable Speed Blower - H.W.G. Domestic Hot Water Generator with Pump


HVAC SYSTEM DATA

SCALE: 1/8 IN. = 1 FT.

ZONES

- = ZONE 1 - A/C & PLUMBING
- = ZONE 2 - A/C & PLUMBING


NOTE: SAME ZONES USED FOR BOTH HVAC & PLUMBING PLAN

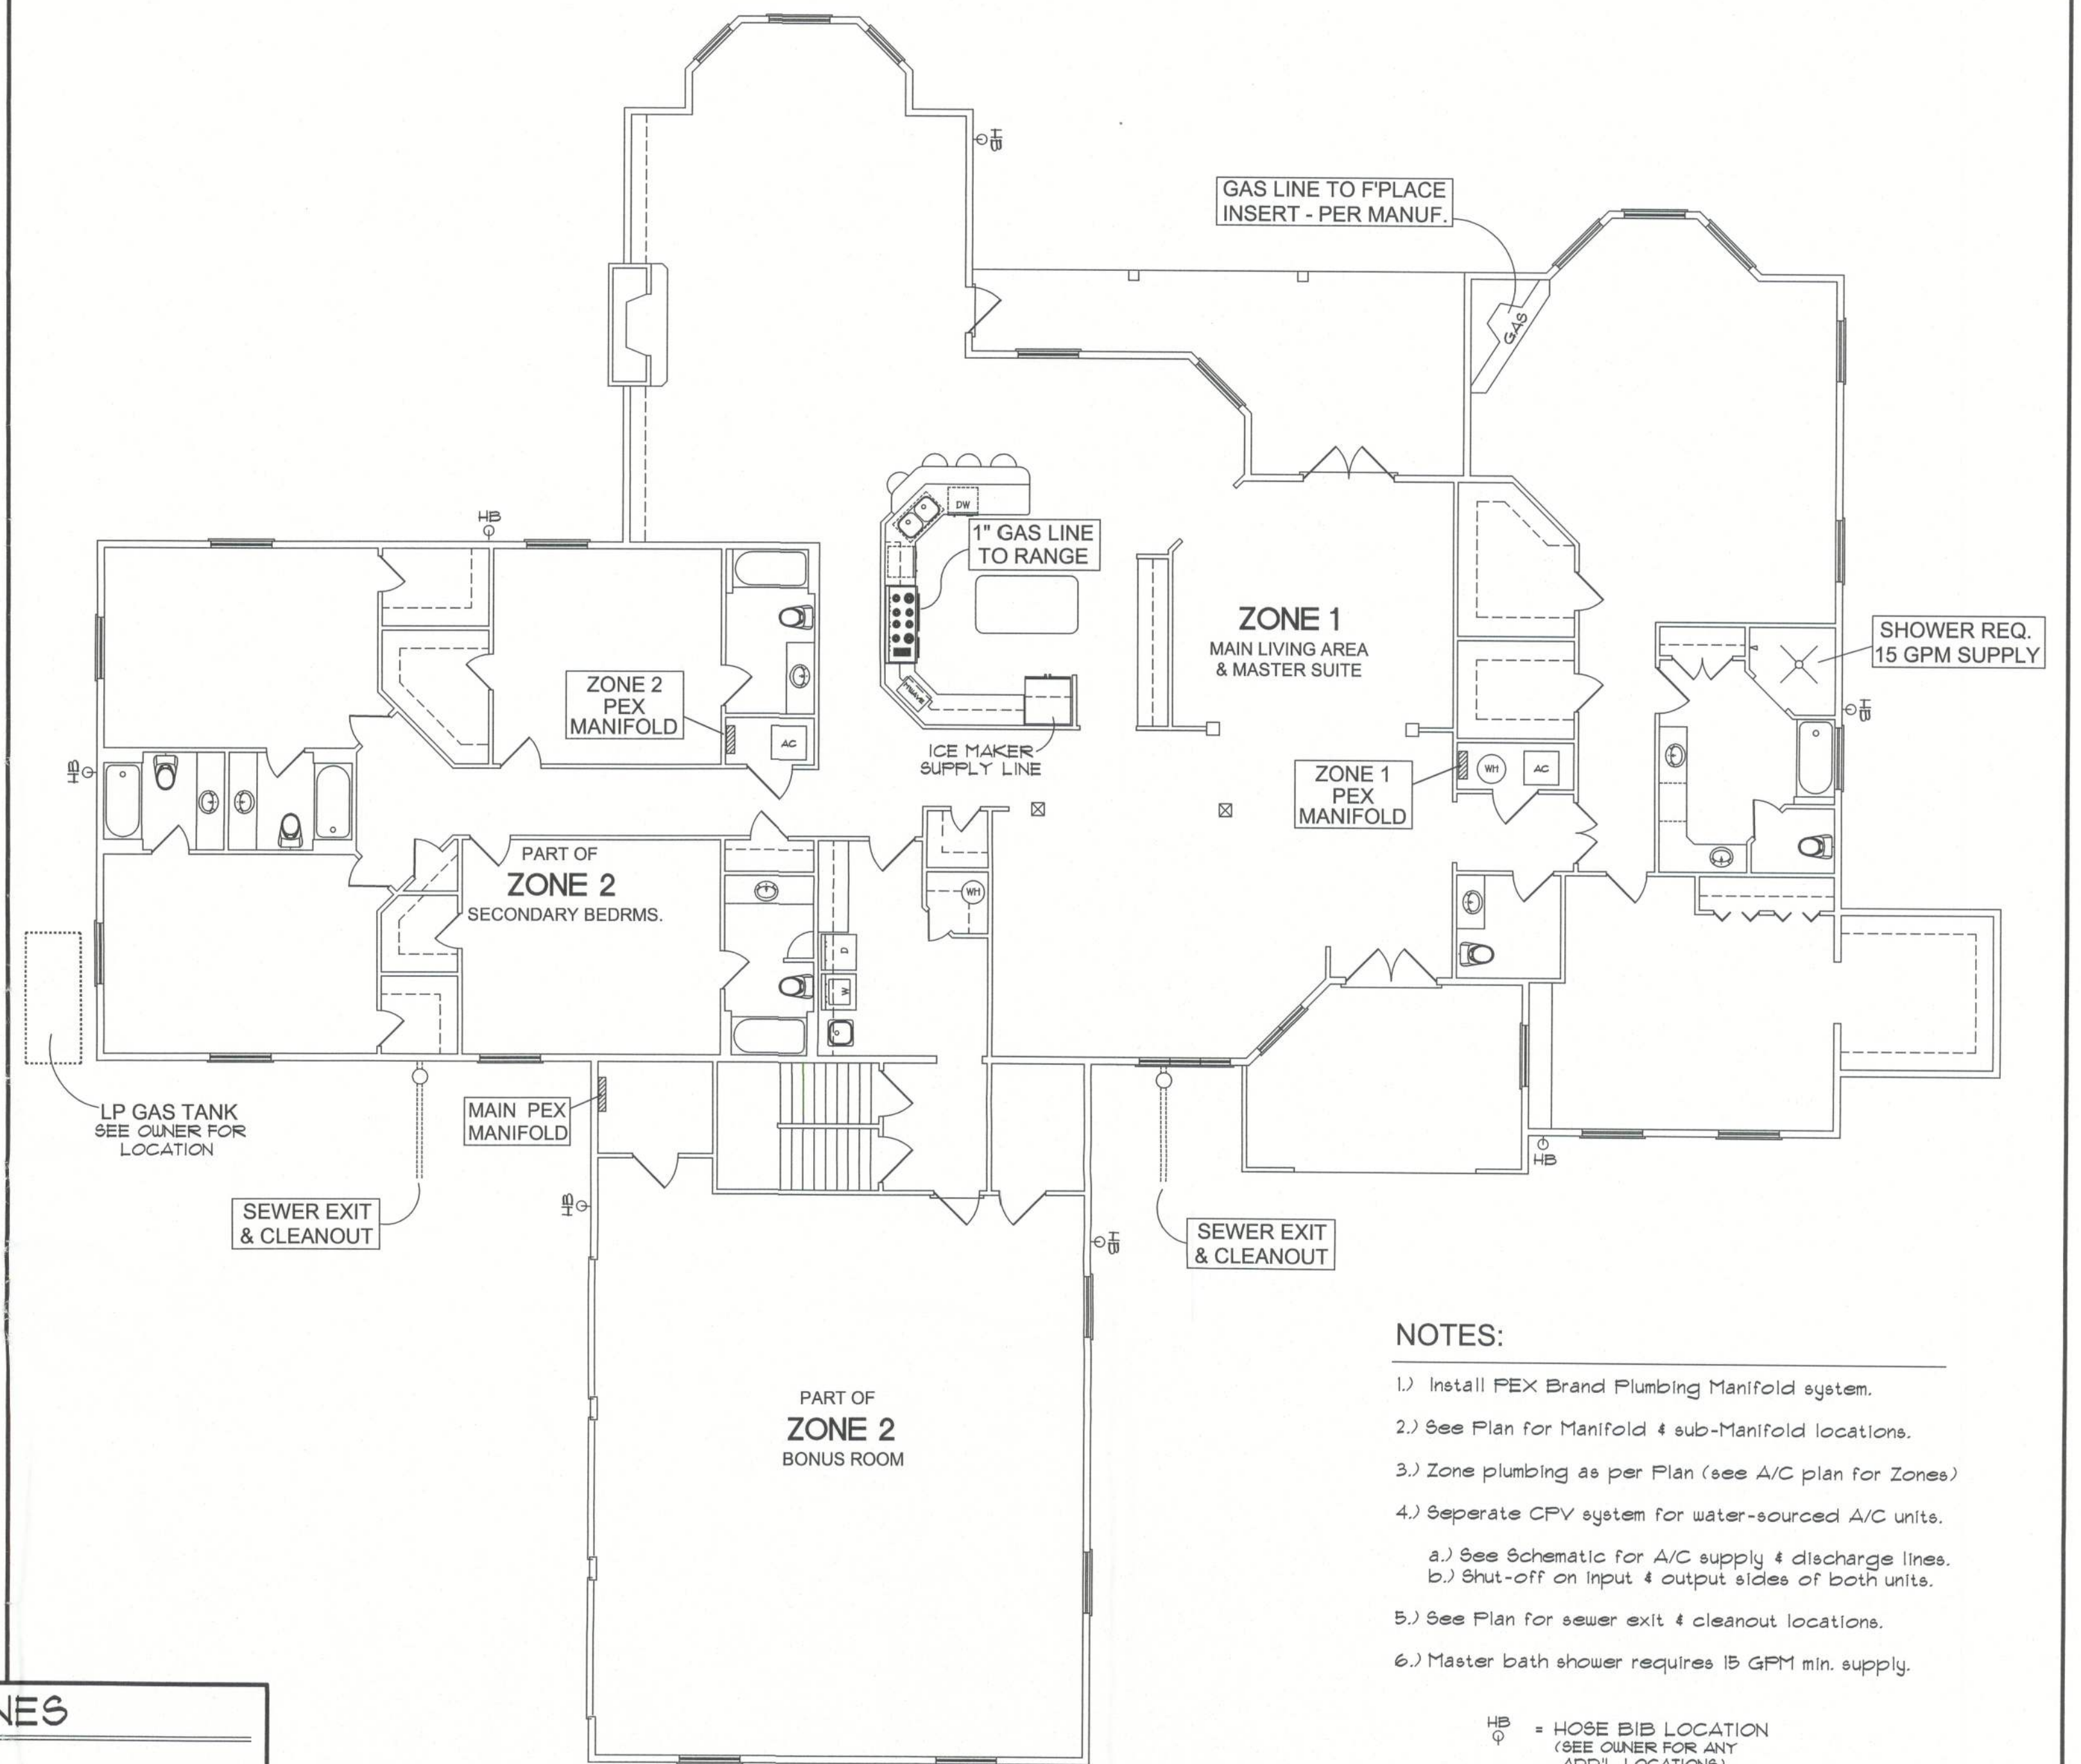

NOTES:


- 1.) Install PEX Brand Plumbing Manifold system.
- 2.) See Plan for Manifold & sub-Manifold locations.
- 3.) Zone plumbing as per Plan (see A/C plan for Zones)
- 4.) Separate CPV system for water-sourced A/C units.
 - a.) See Schematic for A/C supply & discharge lines.
 - b.) Shut-off on input & output sides of both units.
- 5.) See Plan for sewer exit & cleanout locations.
- 6.) Master bath shower requires 15 GPM min. supply.

HB = HOSE BIB LOCATION
(SEE OWNER FOR ANY ADD'L. LOCATIONS)

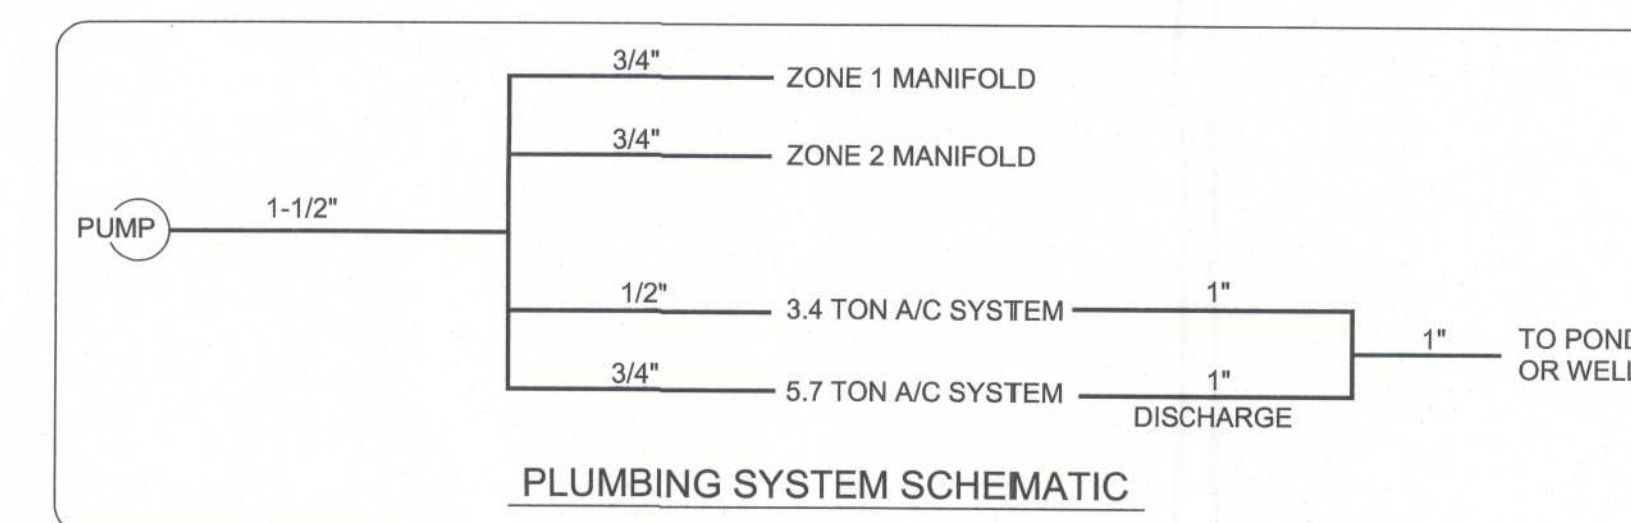

PLUMBING PLAN + DATA

NOT TO SCALE

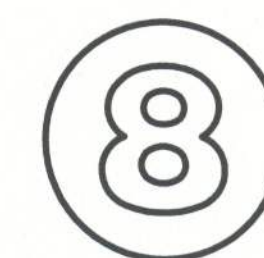

FILE: 11-007	JORDAN RESIDENCE	SHEET: 8
DATE: 11/29/11		CAD FILE: 11-007
DRAWN: T A D		REV:
CHECK: T A D		REV:

PREPARED BY:
TIM DELBENE
Residential Drafting + Design
Rt. 4, Box 330, Lake City, FL 32055
Phone (904) 755-5891