



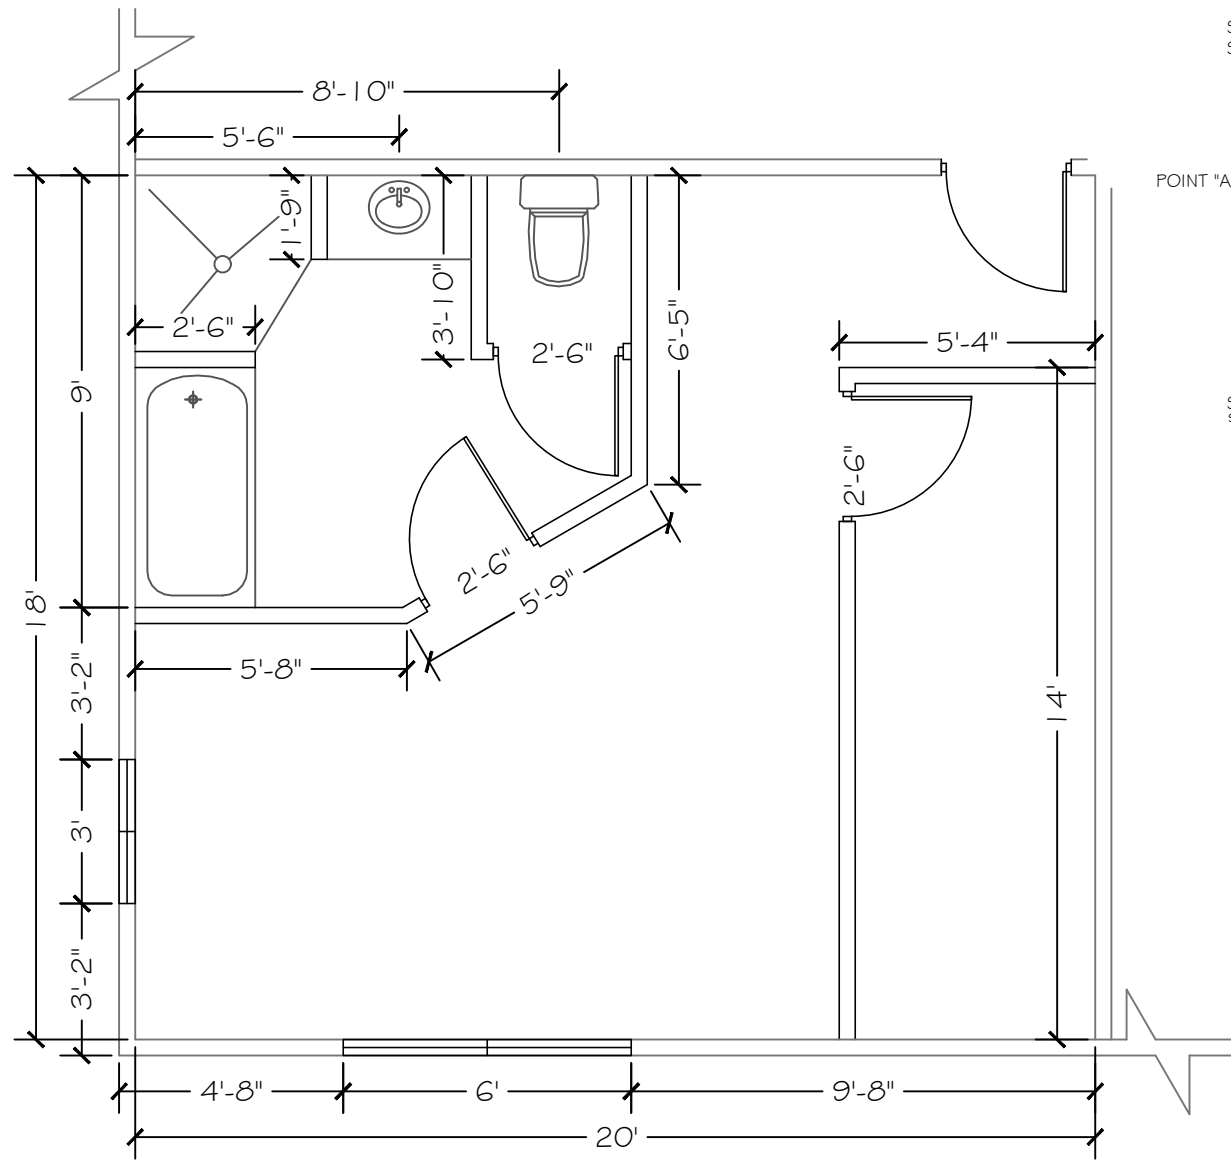

SCALE: 1/4" = 1'

SEE HEADER
SCHEDULE FOR SIZE

OPENINGS AT 5' WIDE USE (1)
TPP4/6 TOP AND BOTTOM
OPENINGS 5' - 7' WIDE USE
(2) TPP4/6 TOP AND BOTTOM

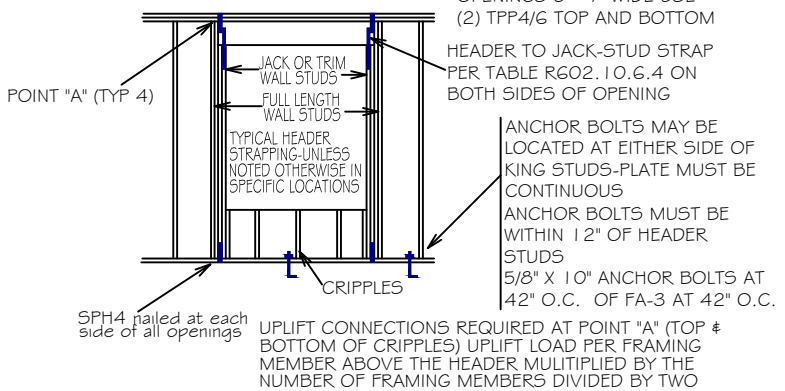

TYPICAL HEADER STRAPPING
NOT TO SCALE

NOTES

1. REMOVE EXISTING GARAGE DOOR & FRAME WITH 2X4 WALL USING P.T. BOTTOM PLATE WITH 1/2" X 4" SLEEVE ANCORS @ 4" O.C.
2. MATCH EXISTING EXTERIOR FINISH


HEADER SCHEDULE

NOTE:
UPLIFT CONNECTION IS REQUIRED AT EACH END OF HEADER AND AT BOTTOM OF HEADER STUDS IN ADDITION TO CONNECTORS AT WALL STUDS AND AT TOP AND BOTTOM OF CRIPPLES

MAXIMUM HEADER SPAN					
3'	6'	9'	12'	15'	18'

NUMBER OF HEADER STUDS (JACKS) SUPPORTING END OF HEADER					
1	1	2	2	2	2

NUMBER OF FULL LENGTH STUDS (KINGS) AT END OF HEADER	
	2

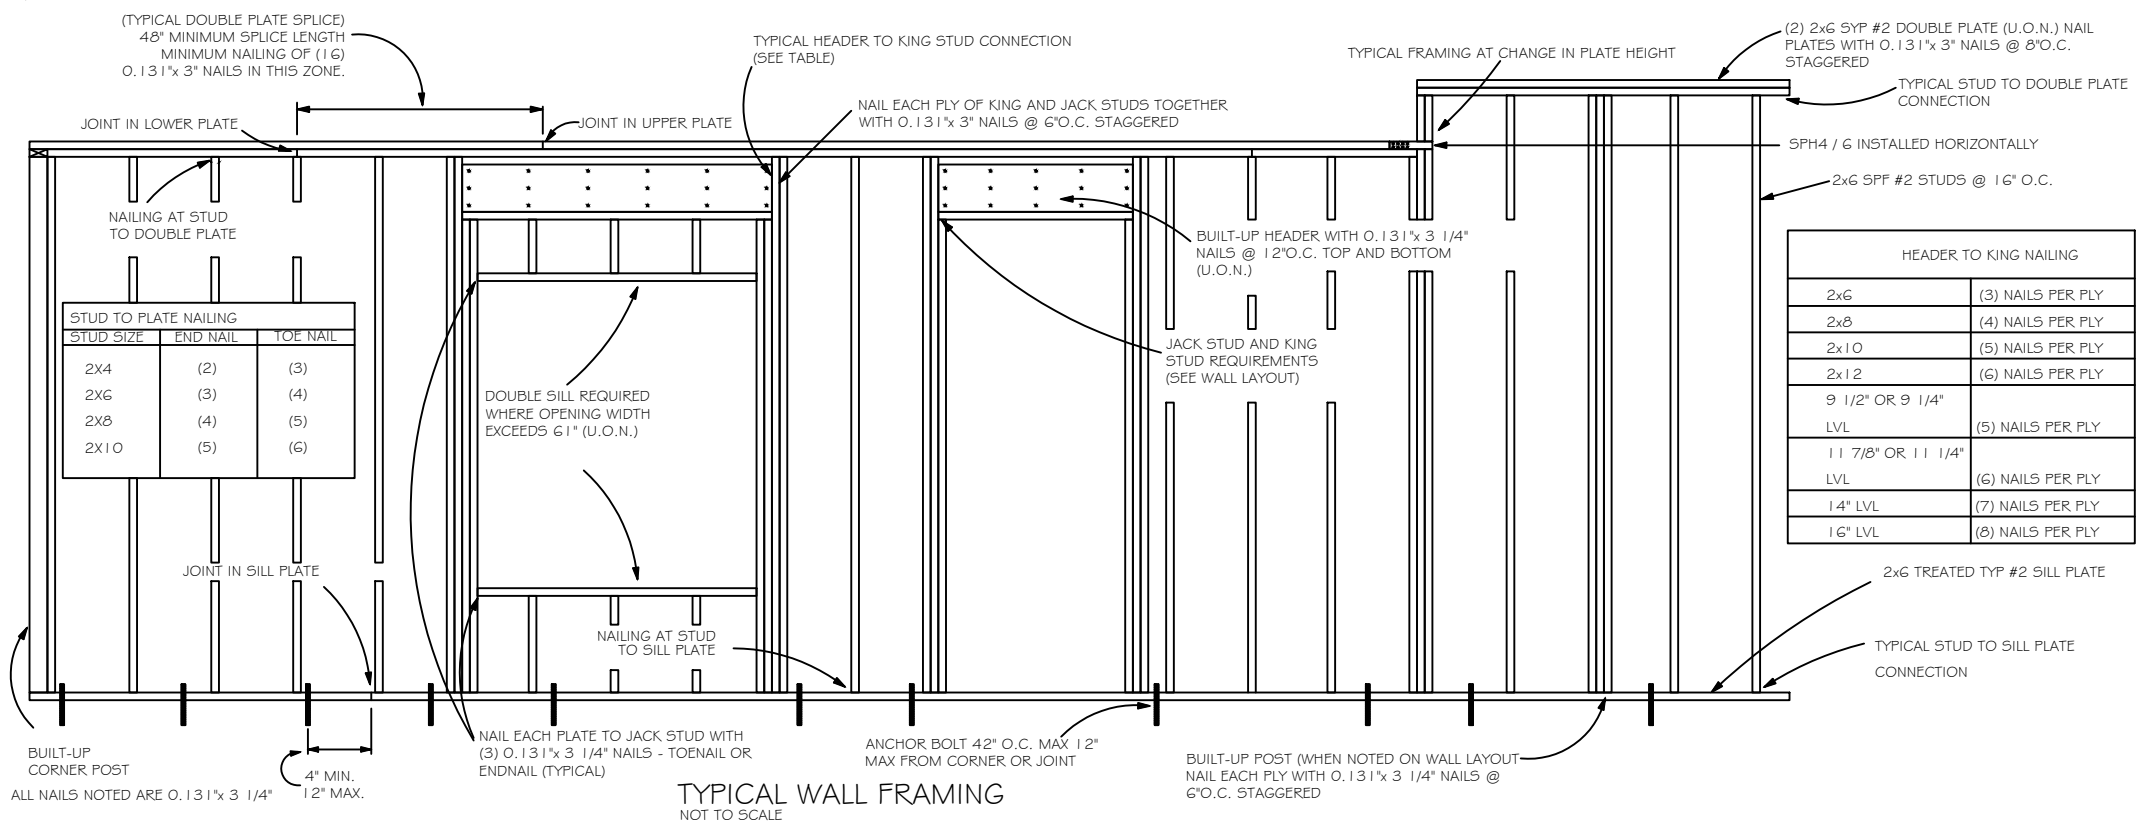

STUD TO PLATE NAILING		
STUD SIZE	END NAIL	TOE NAIL
2x4	(2)	(3)
2x6	(3)	(4)
2x8	(4)	(5)
2x10	(5)	(6)

HEADER TO KING NAILING	
2x6	(3) NAILS PER PLY
2x8	(4) NAILS PER PLY
2x10	(5) NAILS PER PLY
2x12	(6) NAILS PER PLY
9 1/2" OR 9 1/4"	(6) NAILS PER PLY
LVL	(5) NAILS PER PLY
11 7/8" OR 11 1/4"	(6) NAILS PER PLY
LVL	(6) NAILS PER PLY
14" LVL	(7) NAILS PER PLY
16" LVL	(8) NAILS PER PLY

TURNER GARAGE REMODEL
FOUNDATION PLAN

 
PROJECT NO. FL20110
DATE OCT. 29, 2020
REVISION DATE
SHEET S-1

PREPARED FOR:
PLUMB LEVEL CONSTRUCTION
KEVIN BEDENBAUGH, JR.
386.365.5264

REVISION DESCRIPTION
DATE

CAROL CHADWICK, PE
No. 92260
STATE OF FLORIDA
PROFESSIONAL ENGINEER

Carol Chadwick, PE
cn=Carol
Chadwick, PE,
o=This item has
been electronically
signed and sealed
by Carol Chadwick,
PE using a digital
signature., ou,
email=ccpewyo@g
mail.com, c=US
2020.10.29
14:02:28 -04'00'



	DUPLEX WALL RECEPTACLE
	GFI DUPLEX WALL RECEPTACLE
	SPST WALL SWITCH
	LIGHT
	120V SMOKE DETECTOR
	LIGHT/FAN
	CEILING FAN

Carol Chadwick, PE
 cn=Carol Chadwick,
 PE, o=This item has
 been electronically
 signed and sealed
 by Carol Chadwick,
 PE using a digital
 signature., ou,
 email=ccpewyo@g
 mail.com, c=US
 2020.10.29 14:02:57
 -04'00'



TURNER GARAGE REMODEL ELECTRIC PLAN

PREPARED FOR
PLUMB LEVEL CONSTRUCTION
KEVIN BEDENBAUGH, JR.
386.365.5264

[illegible]