




EMERGENCY/EXIT SIGNS AND LIGHTS (TYP): INSTALL EMERGENCY LIGHTS AND EXIT SIGNS (CENTERED AT 9'-0" A.F.F. TO BE ABOVE FIXTURES & MERCHANDISE) THROUGHOUT THE BLDG. IN COMPLIANCE WITH ALL APPLICABLE CODES. PROVIDE REMOTE HEADS AT ALL EXTERIOR LOCATIONS. CONNECT UNSWITCHED HOT LEG OF NEAREST NORMAL LIGHTING CKT. ALL EXIT DISCHARGE LIGHTING SHALL BE 2 LAMP, IN ACCORDANCE 2011 NEC, ARTICLE 700.16.

CEILING PLAN LEGEND

	8' LIGHT FIXTURE		BI-DIRECTIONAL
	4' LIGHT FIXTURE		NEW CEILING GRID
	WALLPACK		EXISTING CEILING GRID
	EXISTING SPEAKER		EMERGENCY FIXTURE
	EXIT LIGHT		REMOTE EMERGENCY HEAD
	EXISTING LIGHT FIXTURE		
	EXISTING RELOCATED LIGHT FIXTURE		

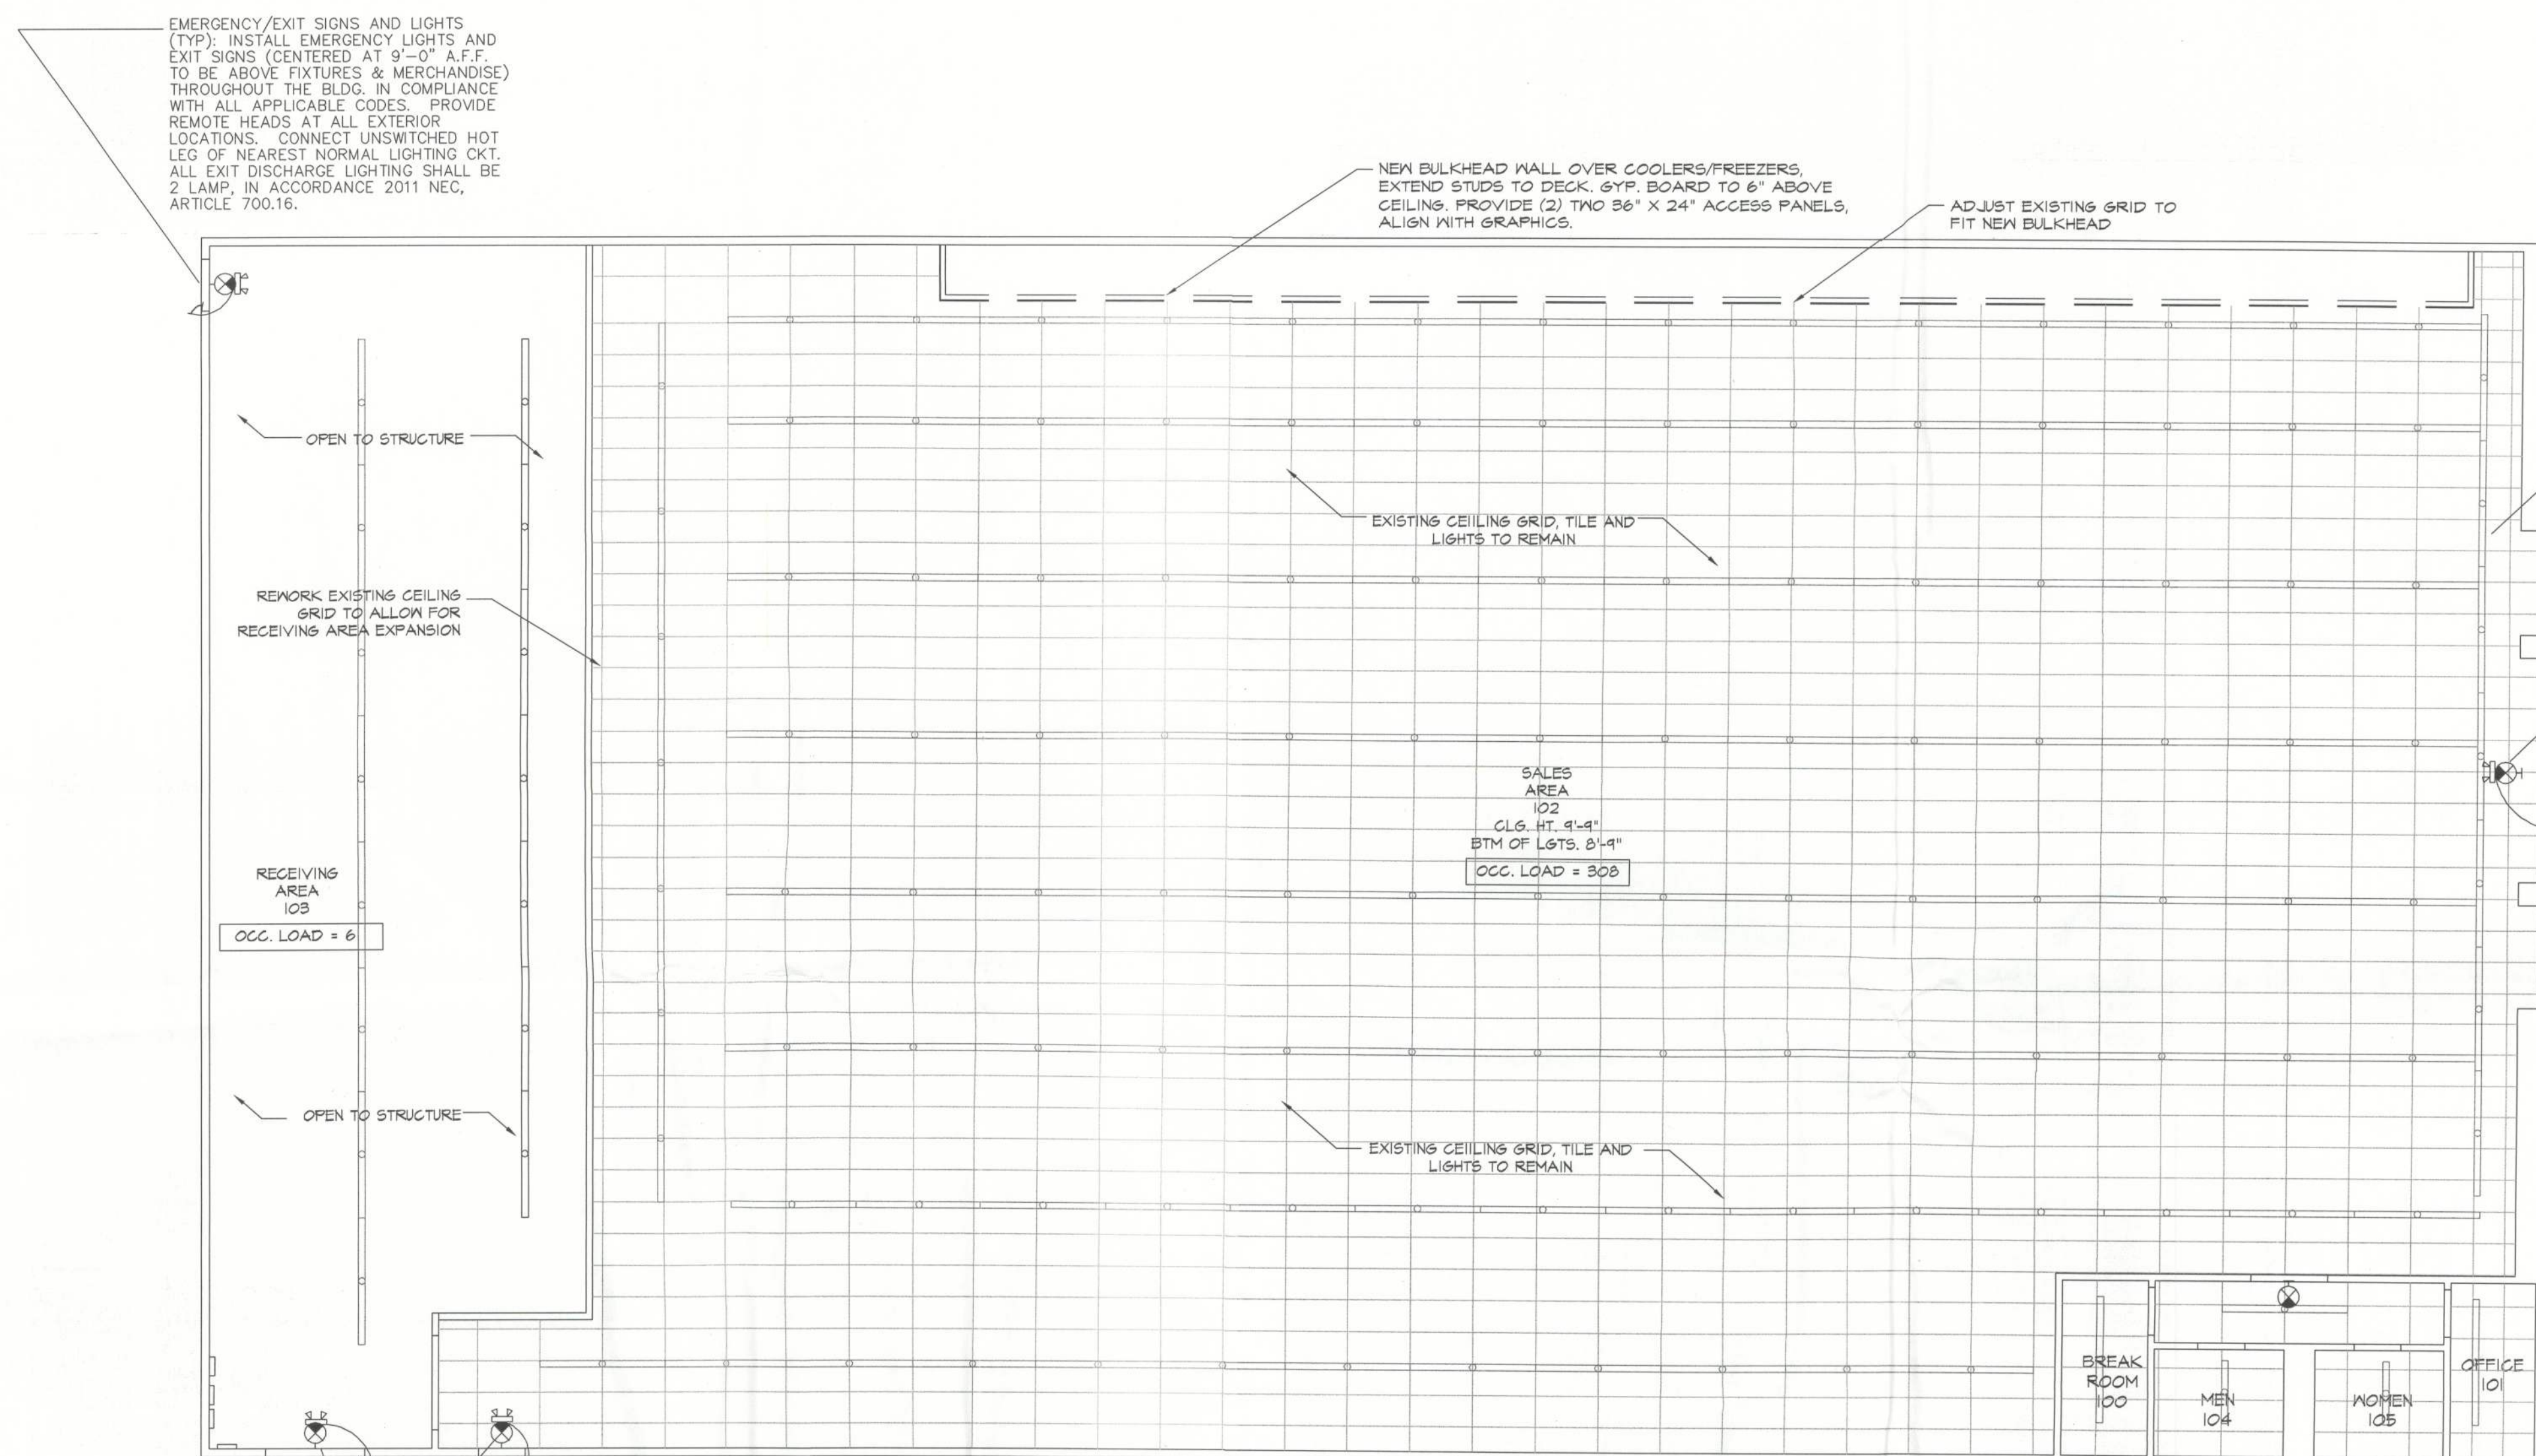

1 LIGHTING PLAN

SCALE: 1/8" = 1'-0"