



ALL DRAWINGS NOT TO BE SCALED, WRITTEN DIMENSIONS TAKE PRECEDENCE OVER SCALED DIMENSIONS

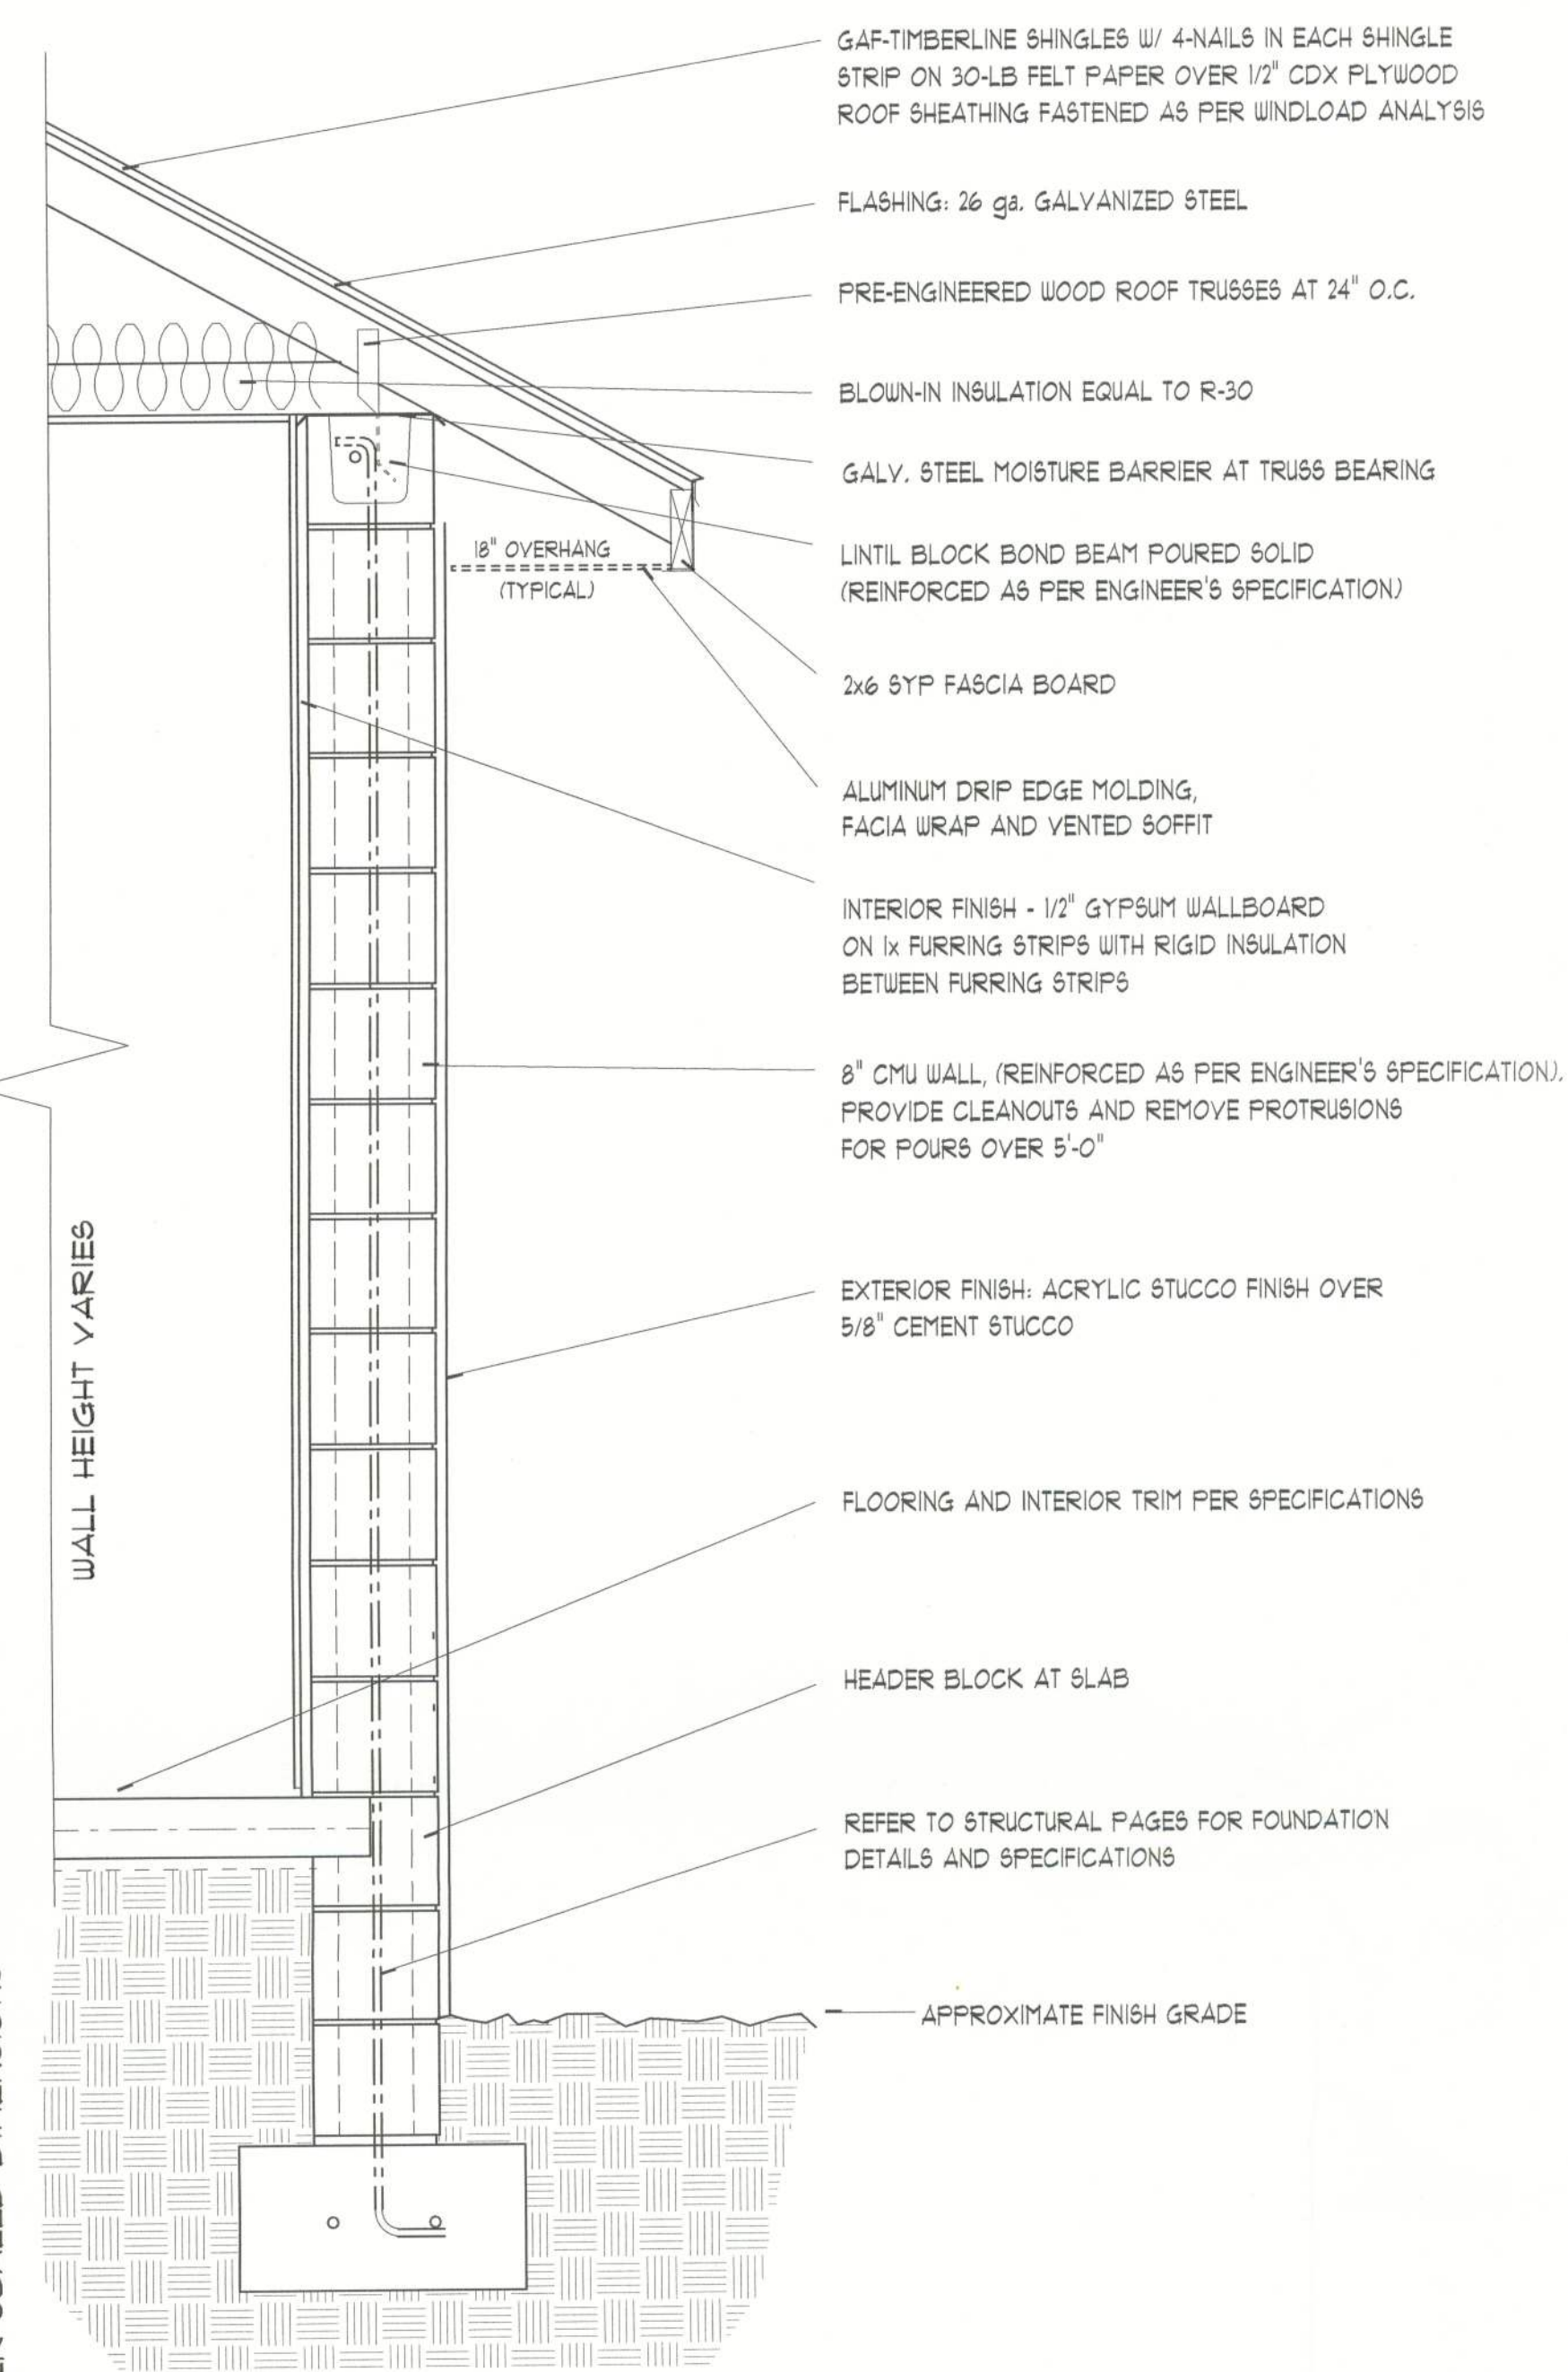


**TYPICAL WALL SECTION**  
SCALE: 1" = 1'

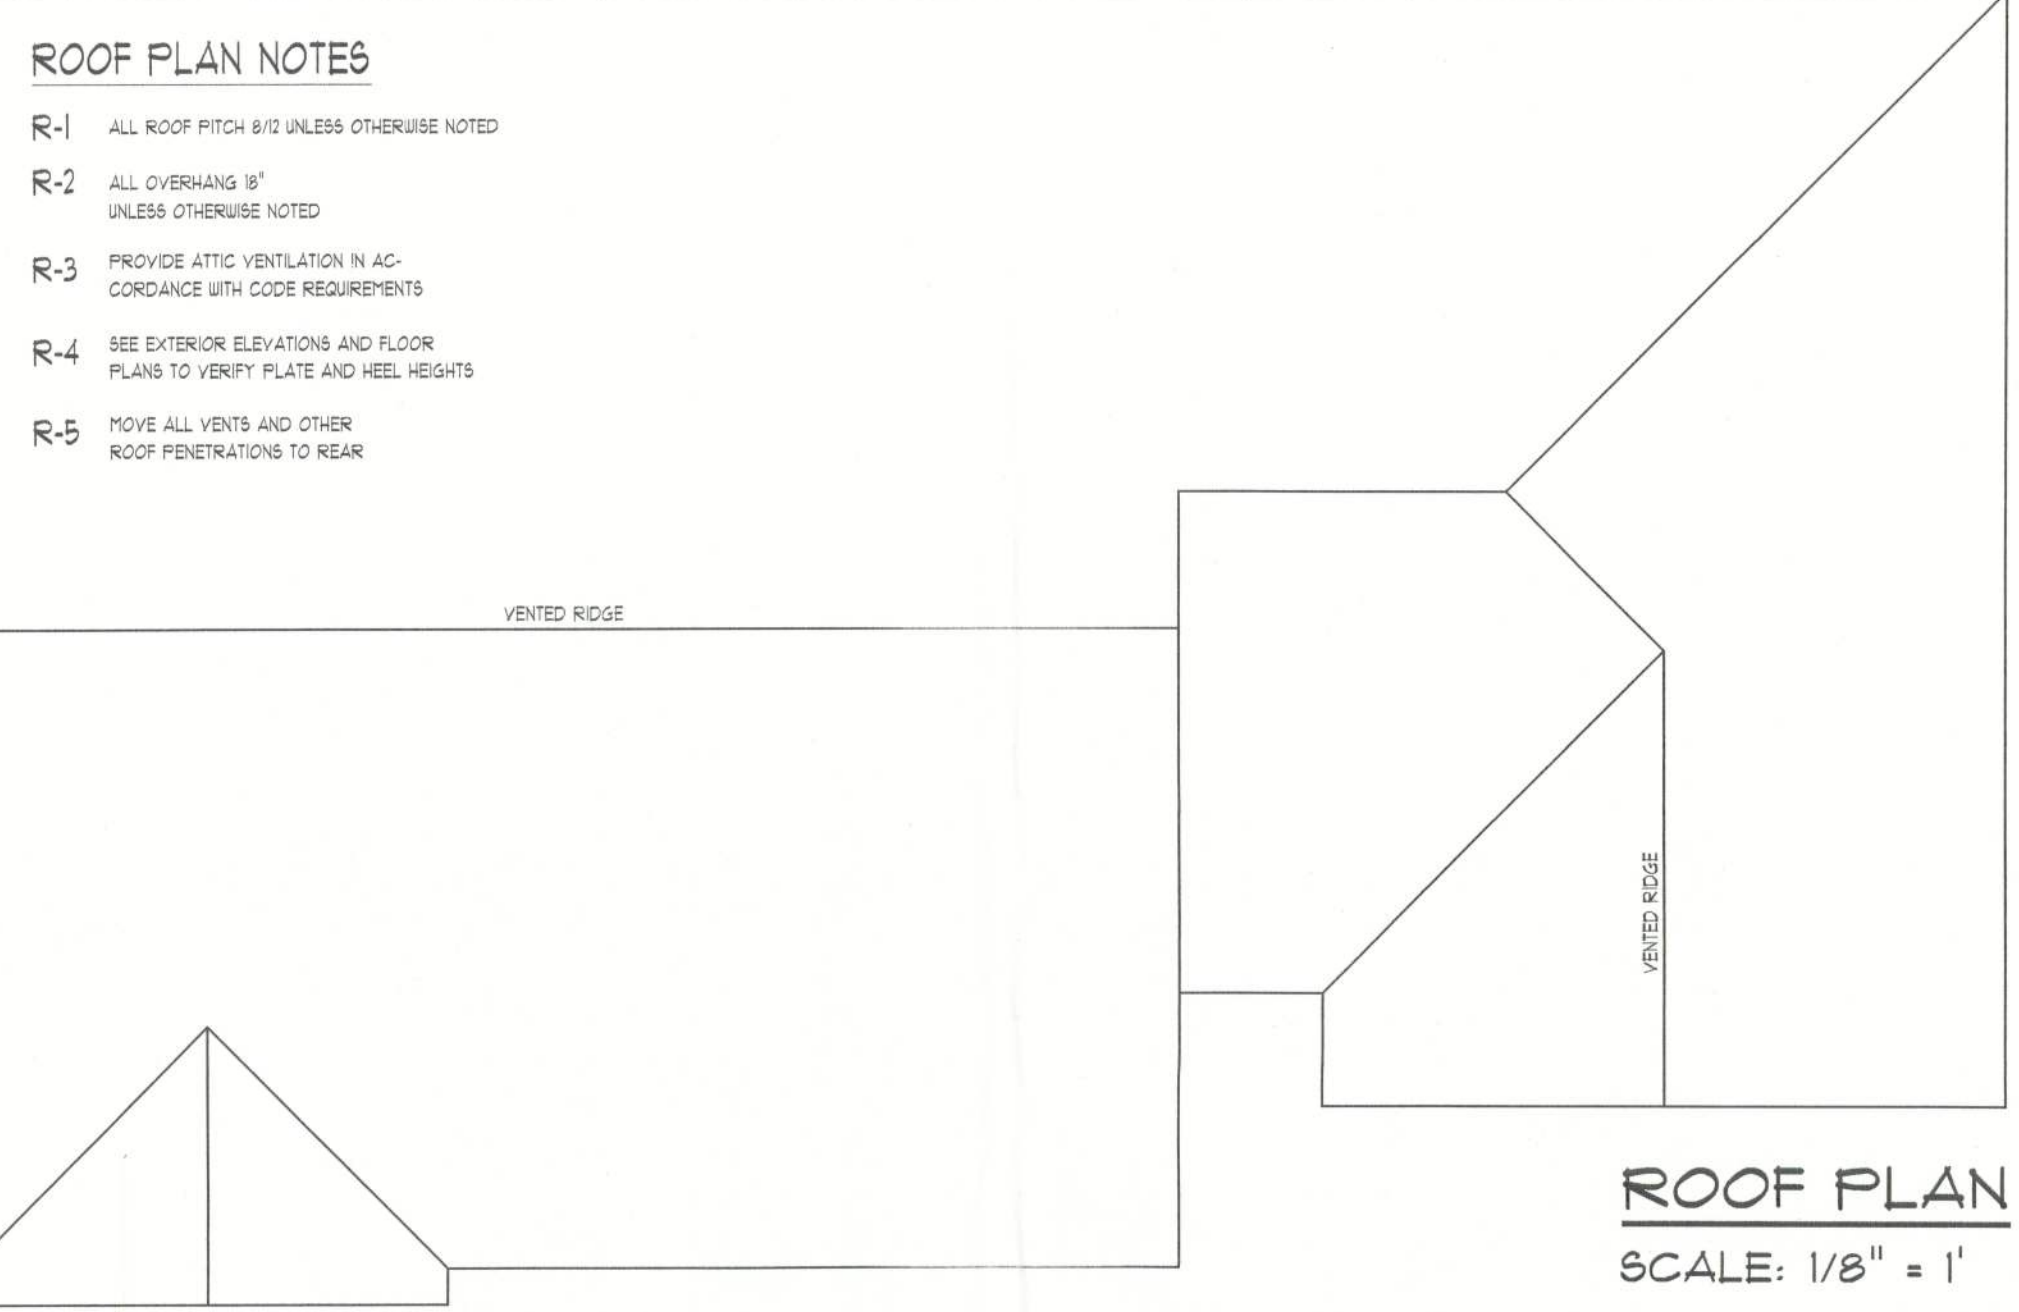

- ROOF PLAN NOTES**
- R-1 ALL ROOF PITCH 8/12 UNLESS OTHERWISE NOTED
  - R-2 ALL OVERHANG 18" UNLESS OTHERWISE NOTED
  - R-3 PROVIDE ATTIC VENTILATION IN ACCORDANCE WITH CODE REQUIREMENTS
  - R-4 SEE EXTERIOR ELEVATIONS AND FLOOR PLANS TO VERIFY PLATE AND HEEL HEIGHTS
  - R-5 MOVE ALL VENTS AND OTHER ROOF PENETRATIONS TO REAR

**ROOF PLAN**  
SCALE: 1/8" = 1'

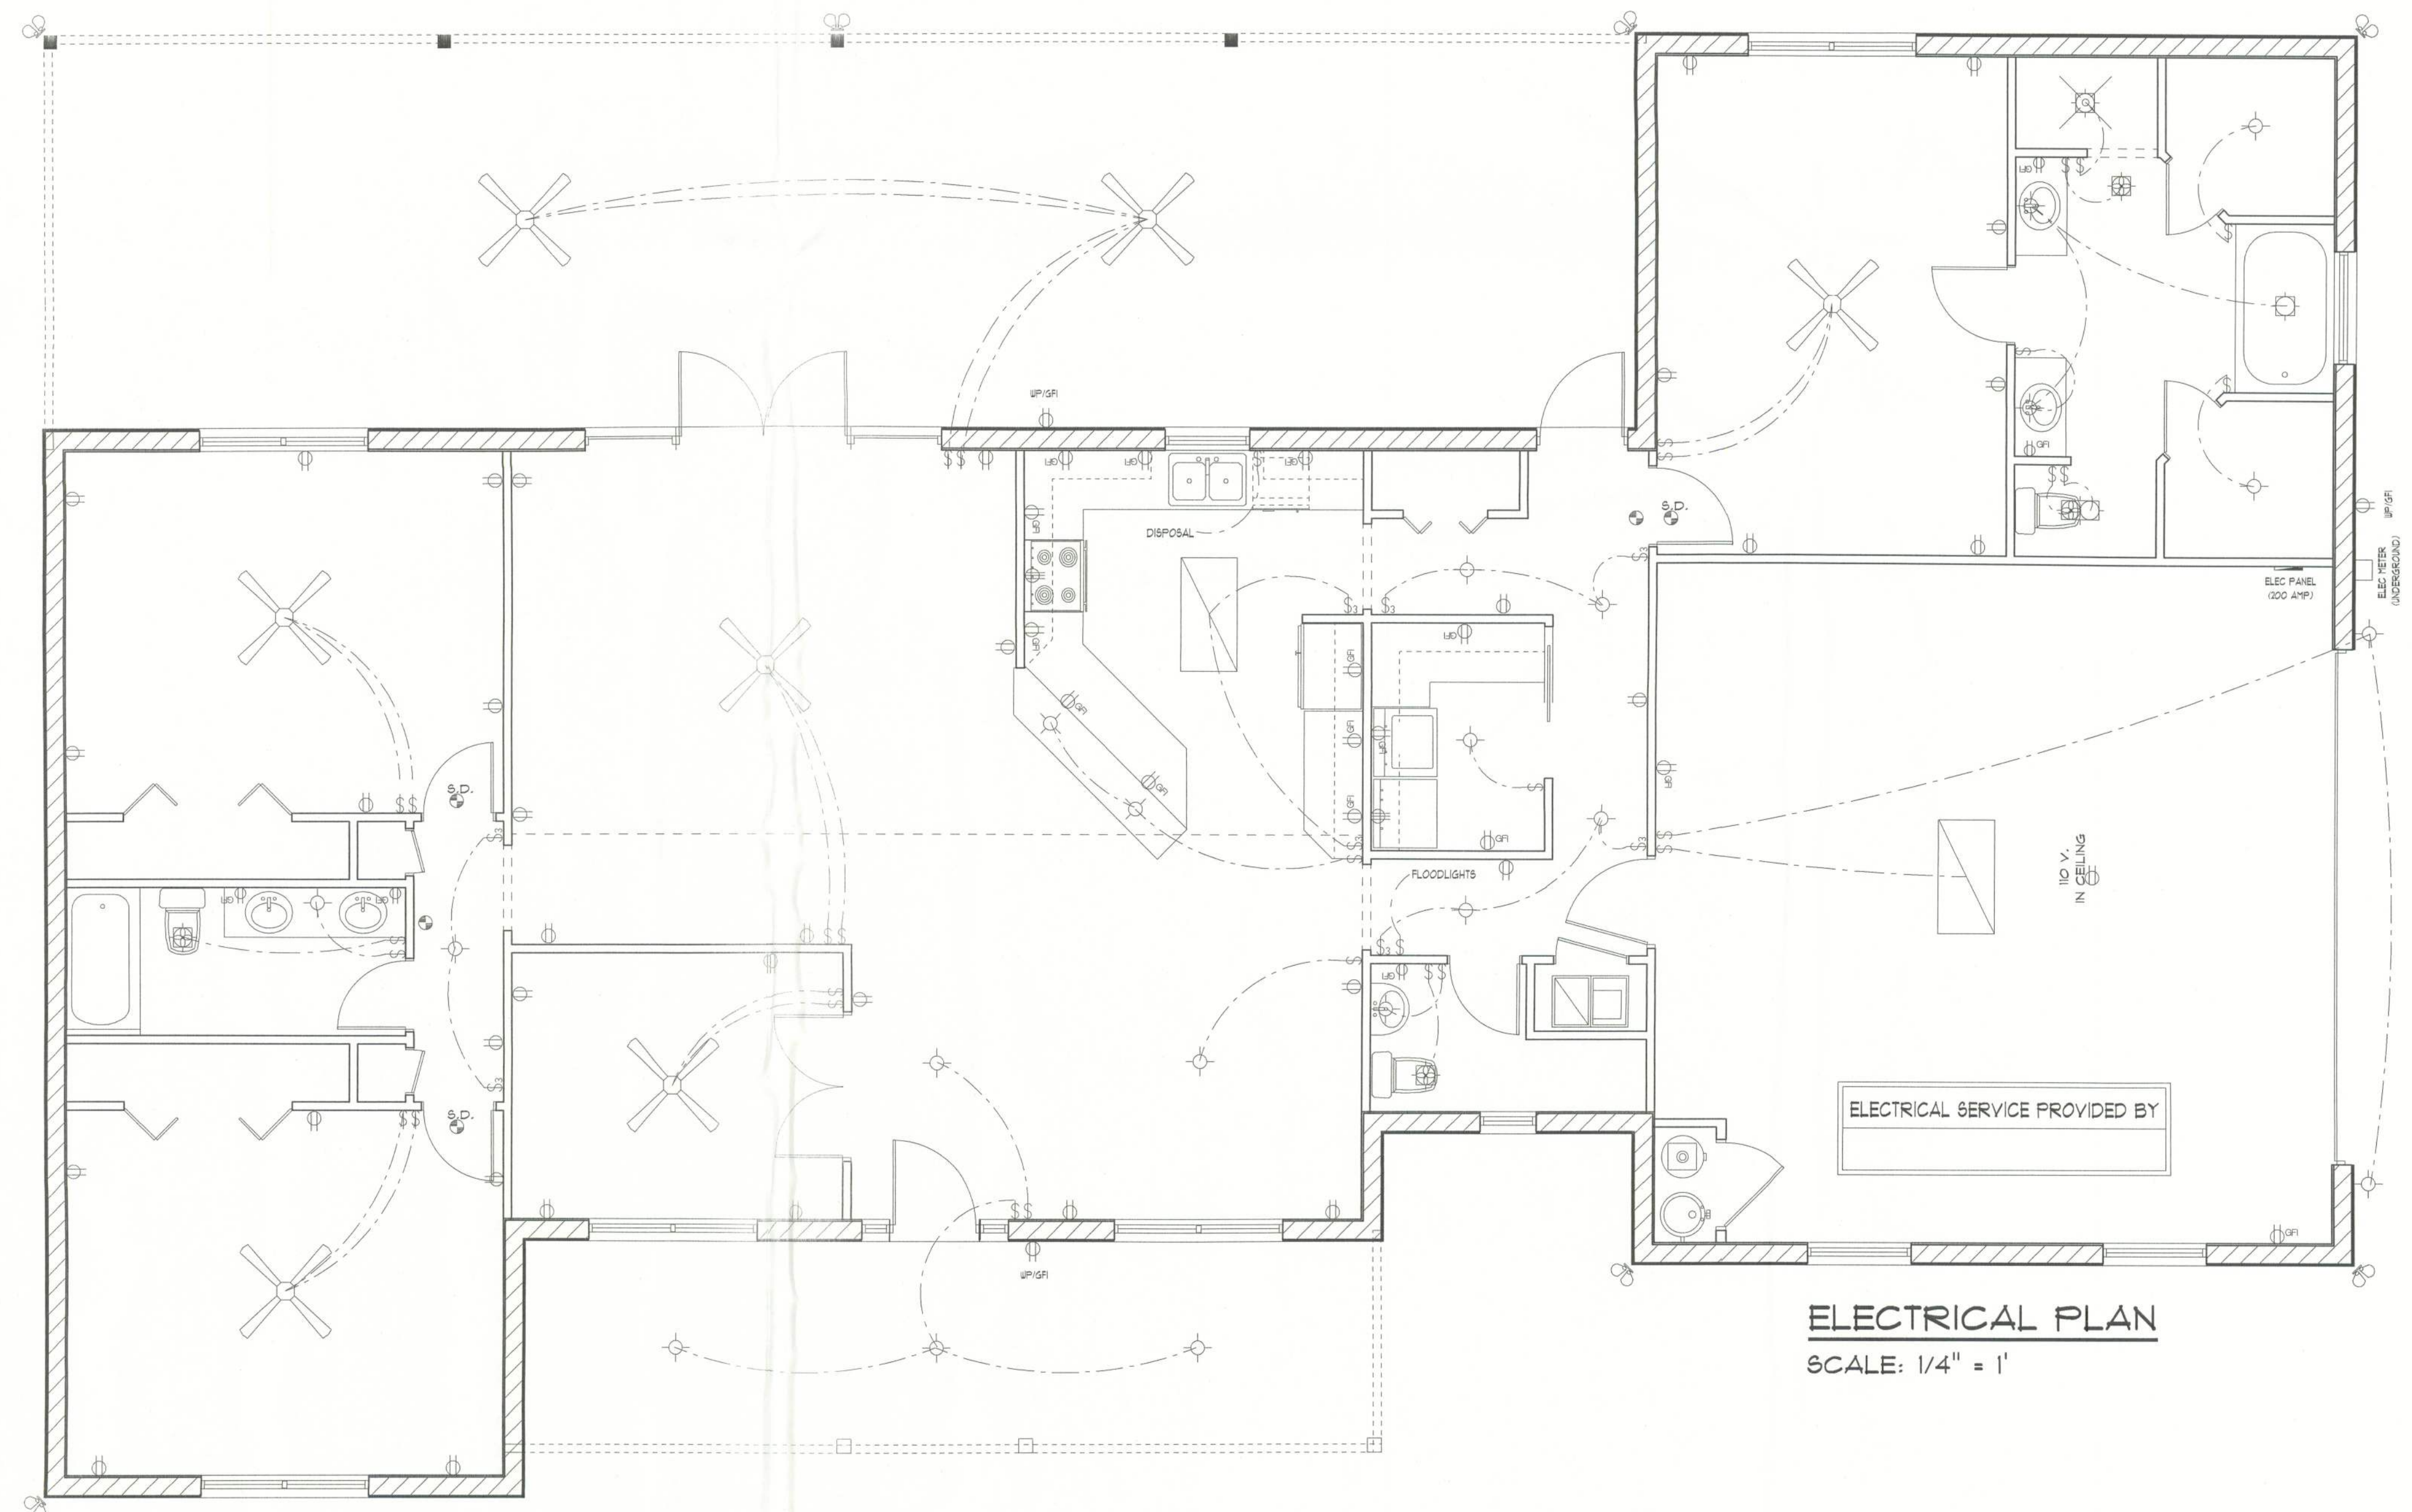

**ELECTRICAL PLAN NOTES**

- E-1 ALL WORK SHALL COMPLY WITH THE NATIONAL ELECTRICAL CODE, LATEST EDITION, AND ALL OTHER APPLICABLE LOCAL CODES AND ORDINANCES.
- E-2 NOTE: ALL SMOKE DETECTORS TO BE WIRED TOGETHER TO ACTUATE ALL ALARMS IF ANY ONE UNIT IS ACTUATED.
- E-3 PROVIDE WIRING AS REQUIRED FOR APPLIANCES, AIR CONDITIONING, HEATING AND WATER HEATING EQUIPMENT.
- E-4 ALL BEDROOM RECEPTACLES SHALL BE AFCI (ARC FAULT CIRCUIT INTERRUPT).

**NOTE:**  
THIS ELECTRICAL PLAN IS A SCHEMATIC WITH SUGGESTED SWITCH, RECEPTACLE AND LIGHT FIXTURE LOCATIONS. DUE TO VARYING LOCAL AND STATE CODES, REGULATIONS, AND STATUTES, IT IS THE RESPONSIBILITY OF THE OWNER AND/OR CONTRACTOR TO COMPLY WITH ALL LOCAL AND STATE CODES, REGULATIONS AND STATUTES.

**ELECTRICAL PLAN**  
SCALE: 1/4" = 1'

*Daniel Shaheen*  
**Daniel Shaheen**

2-06-03



**ARCHITECTURAL DESIGN**  
P.O. Box 273  
LAKE CITY FL 32056  
(386) 754-0181

COPYRIGHTED BY:

**MARK DISOSWAY, P.E.**  
POB 866, LAKE CITY, FL 32056  
Ph: (804) 754-5419  
Ph: (804) 754-6749  
FLORIDA P.E. 53915

ENGINEERED BY:

**DAVID & JUDITH ONORATI**

DESIGNED FOR:

**ELECTRICAL PLAN**  
**ROOF PLAN**  
**TYPICAL WALL SECTION**

SHEET NUMBER  
3 of 3

All work shall comply with the standard building code, and all applicable local codes and ordinances.  
Contractor shall verify all dimensions prior to commencing construction.