


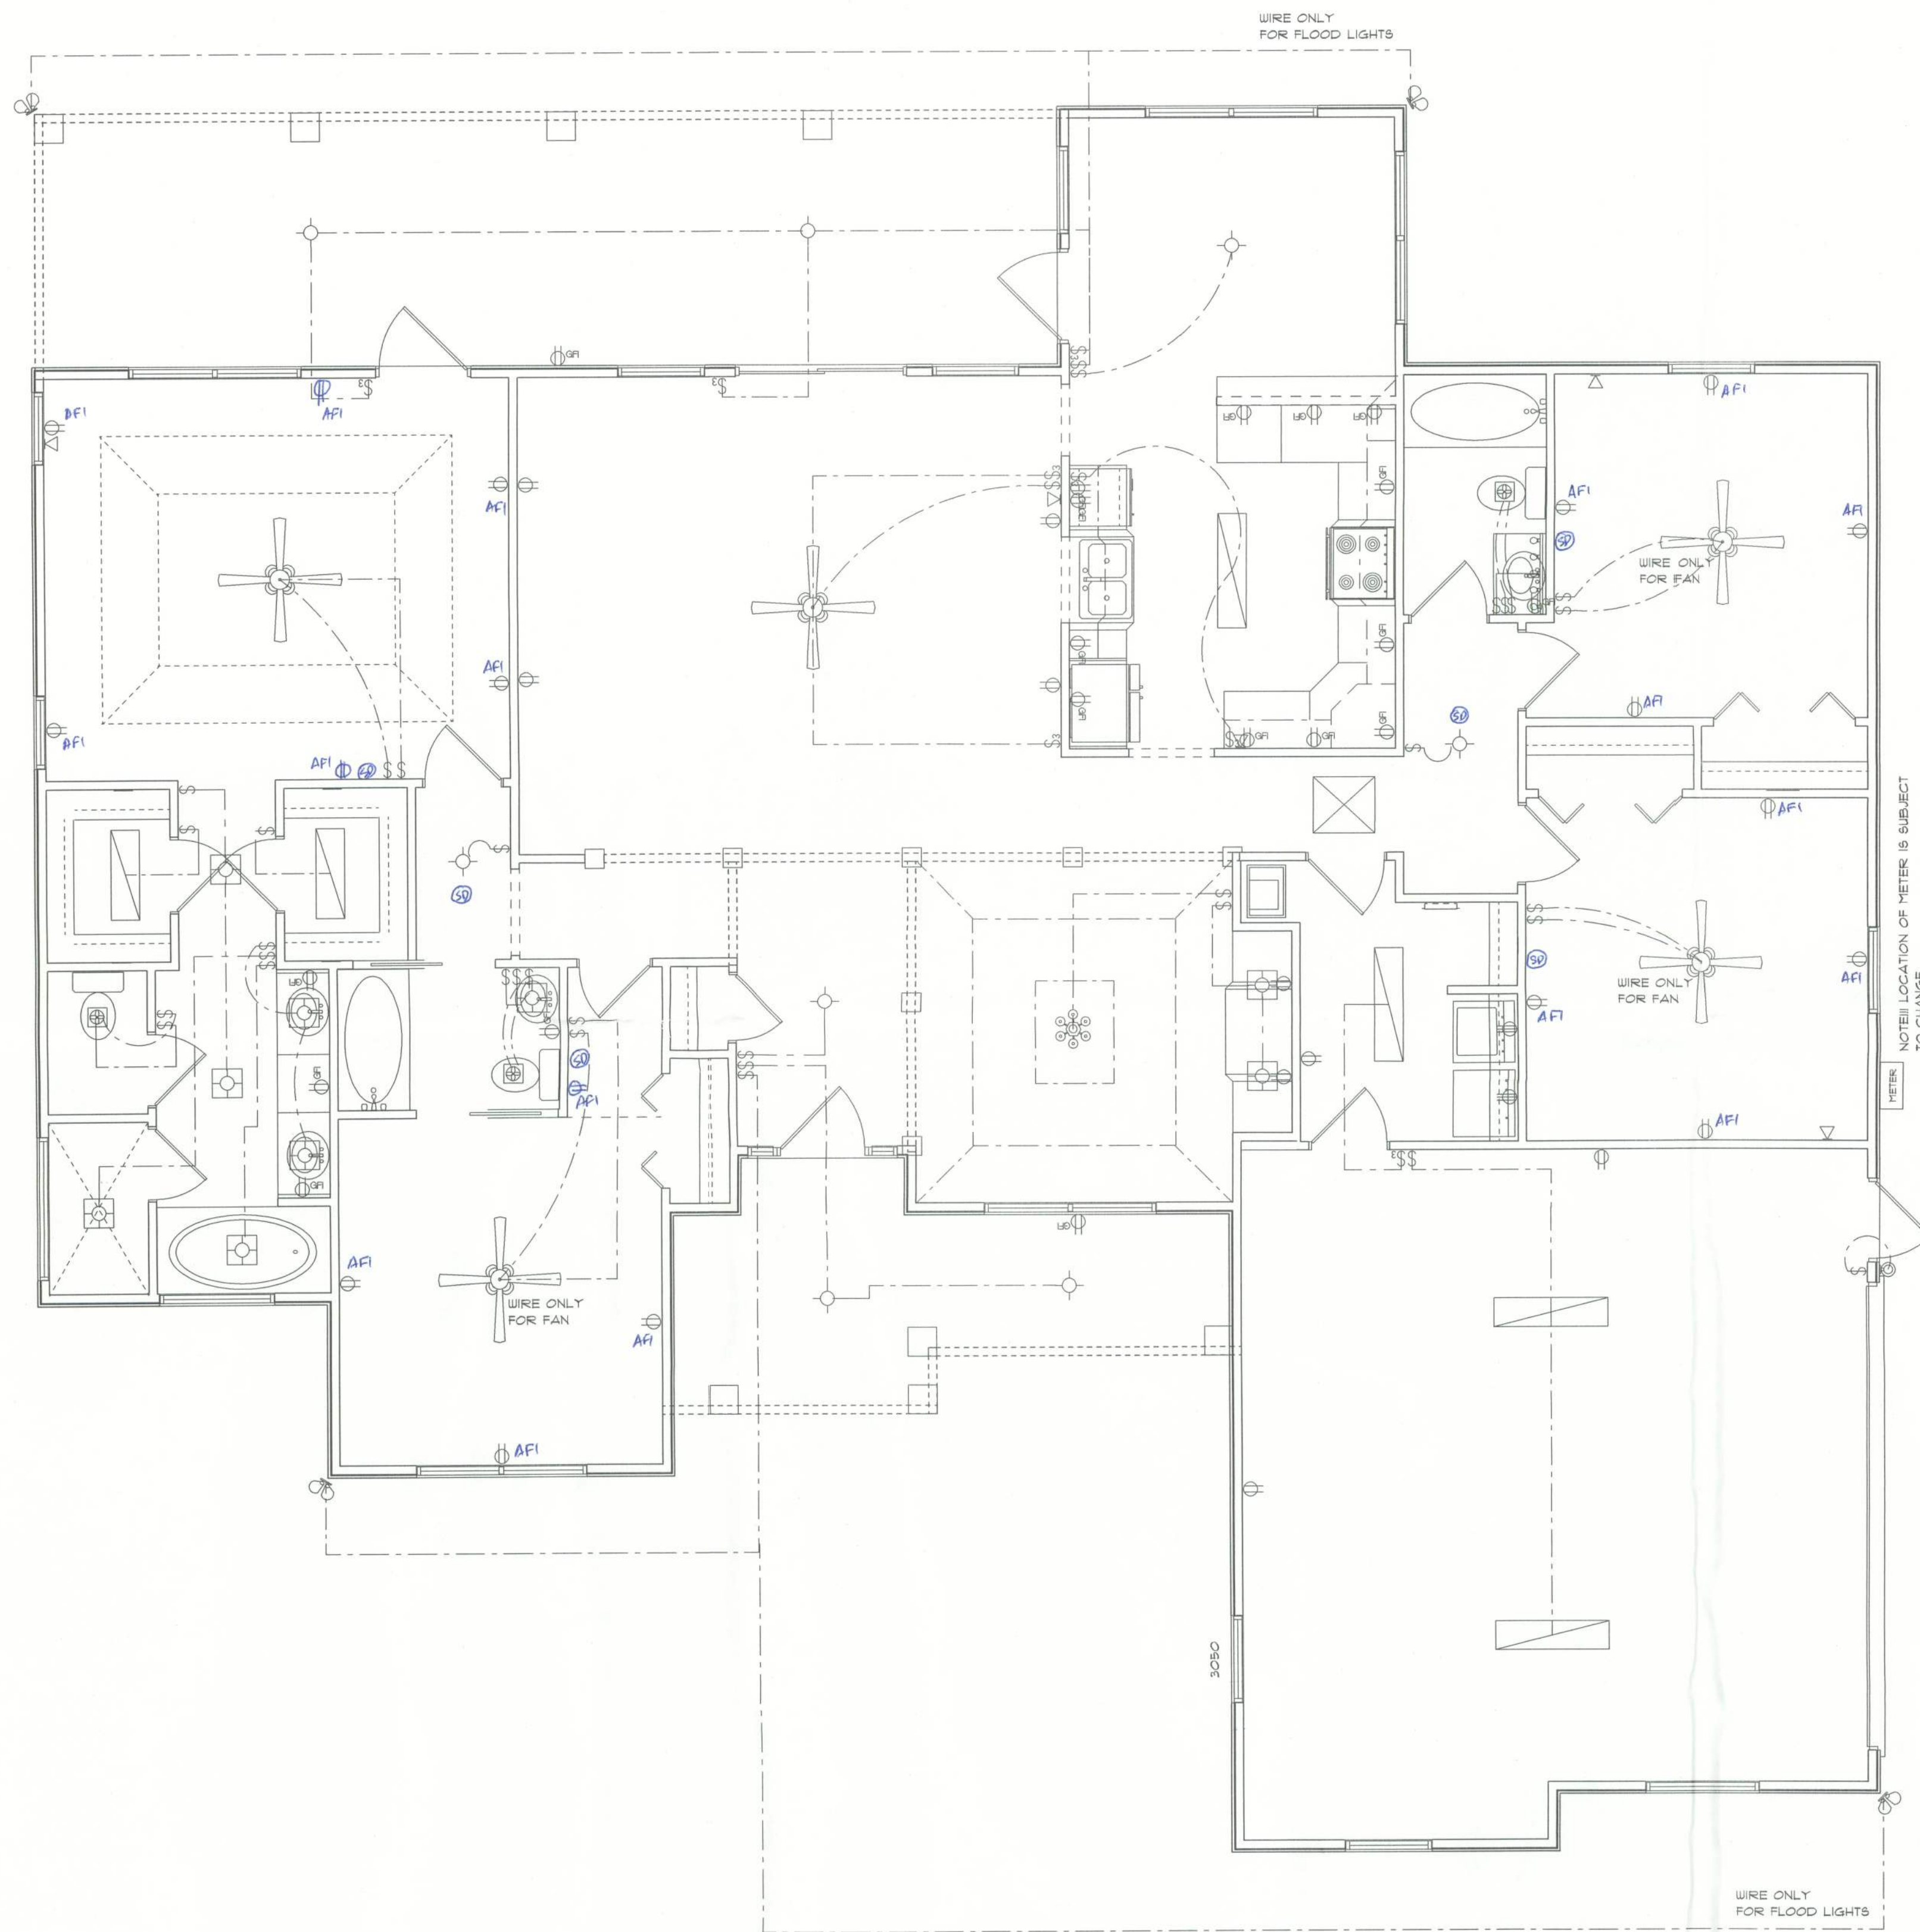

ELECTRICAL	COUNT	SYMBOL
ceiling fan spotlights 2	5	
can light	3	
chandelier	1	
double spotlight	4	
fluorescent fixture	6	
vanity bar light	1	
wall mount 1	1	
electrical panel	1	
fan with light	3	
light	8	
outlet	24	
outlet 220v	2	
outlet gfi	19	
switch	36	
switch 3 way	8	
telephone	5	

Smoke Detector 6

ELECTRICAL PLAN NOTES

ALL RECEPTICALS IN ALL BEDROOMS SHALL BE AFCI CIRCUITS.
WIRE ALL APPLIANCES, HVAC UNITS AND OTHER EQUIPMENT PER MANUF. SPECIFICATIONS.

CONSULT THE OWNER FOR THE NUMBER OF SEPERATE TELEPHONE LINES TO BE INSTALLED.

INSTALLATION SHALL BE PER NATL. ELECTRIC CODE.

ALL SMOKE DETECTORS SHALL BE 120V W/ BATTERY BACKUP OF THE PHOTOELECTRIC TYPE, AND SHALL BE INTERLOCKED TOGETHER. INSTALL INSIDE AND NEAR ALL BEDROOMS.

TELEPHONE, TELEVISION AND OTHER LOW VOLTAGE DEVICES OR OUTLETS SHALL BE AS PER THE OWNER'S DIRECTIONS, & IN ACCORDANCE W/ APPLICABLE SECTIONS OF NEC-LATEST EDITION.

ELECTRICAL CONTR SHALL PREPARE "AS-BUILT" SHOP DWGS INDICATING ALL ELECTRICAL WORK, INCLUDING ANY CHANGES TO THE ELEC. PLAN, ADD'NS TO THE ELEC. PLAN, RISER DIAGRAM, AS-BUILT PANEL SCHEDULE W/ ALL CKTS IDENTIFIED W/ CKT N., DESCRIPTION & BRKR, SERVICE ENT. & ALL UNDERGROUND WIRE LOCATIONS/ROUTING/DEPTH. RISER DIA. SHALL INCLUDE WIRE SIZES/TYPE & EQUIPMENT TYPE W/ RATINGS & LOADS. CONTRACTOR SHALL PROVIDE 1 COPY OF AS-BUILT DWGS TO OWNER & 1 COPY TO THE PERMIT ISSUING AUTHORITY.

STANLEY CRAWFORD CONSTRUCTION

NEW SPEC HOME FOR:
TURKEY RUN LOT 48



NICHOLAS
PAUL
GESLER
ARCHITECT
N.C.A.A.B. Certified

A Joint
Venture With

FIRST IMPRESSIONS
ARCHITECTURAL DESIGN, LLC
2105 W U.S. HWY 90 SUITE 110-144
LAKE CITY, FL 32095
(386) 755-8891

ELECTRICAL PLAN
SCALE: 1/4"=1'-0"

SHEET NUMBER

A-7
OF 7 SHEETS

AR0001005
07 DEC 2005