



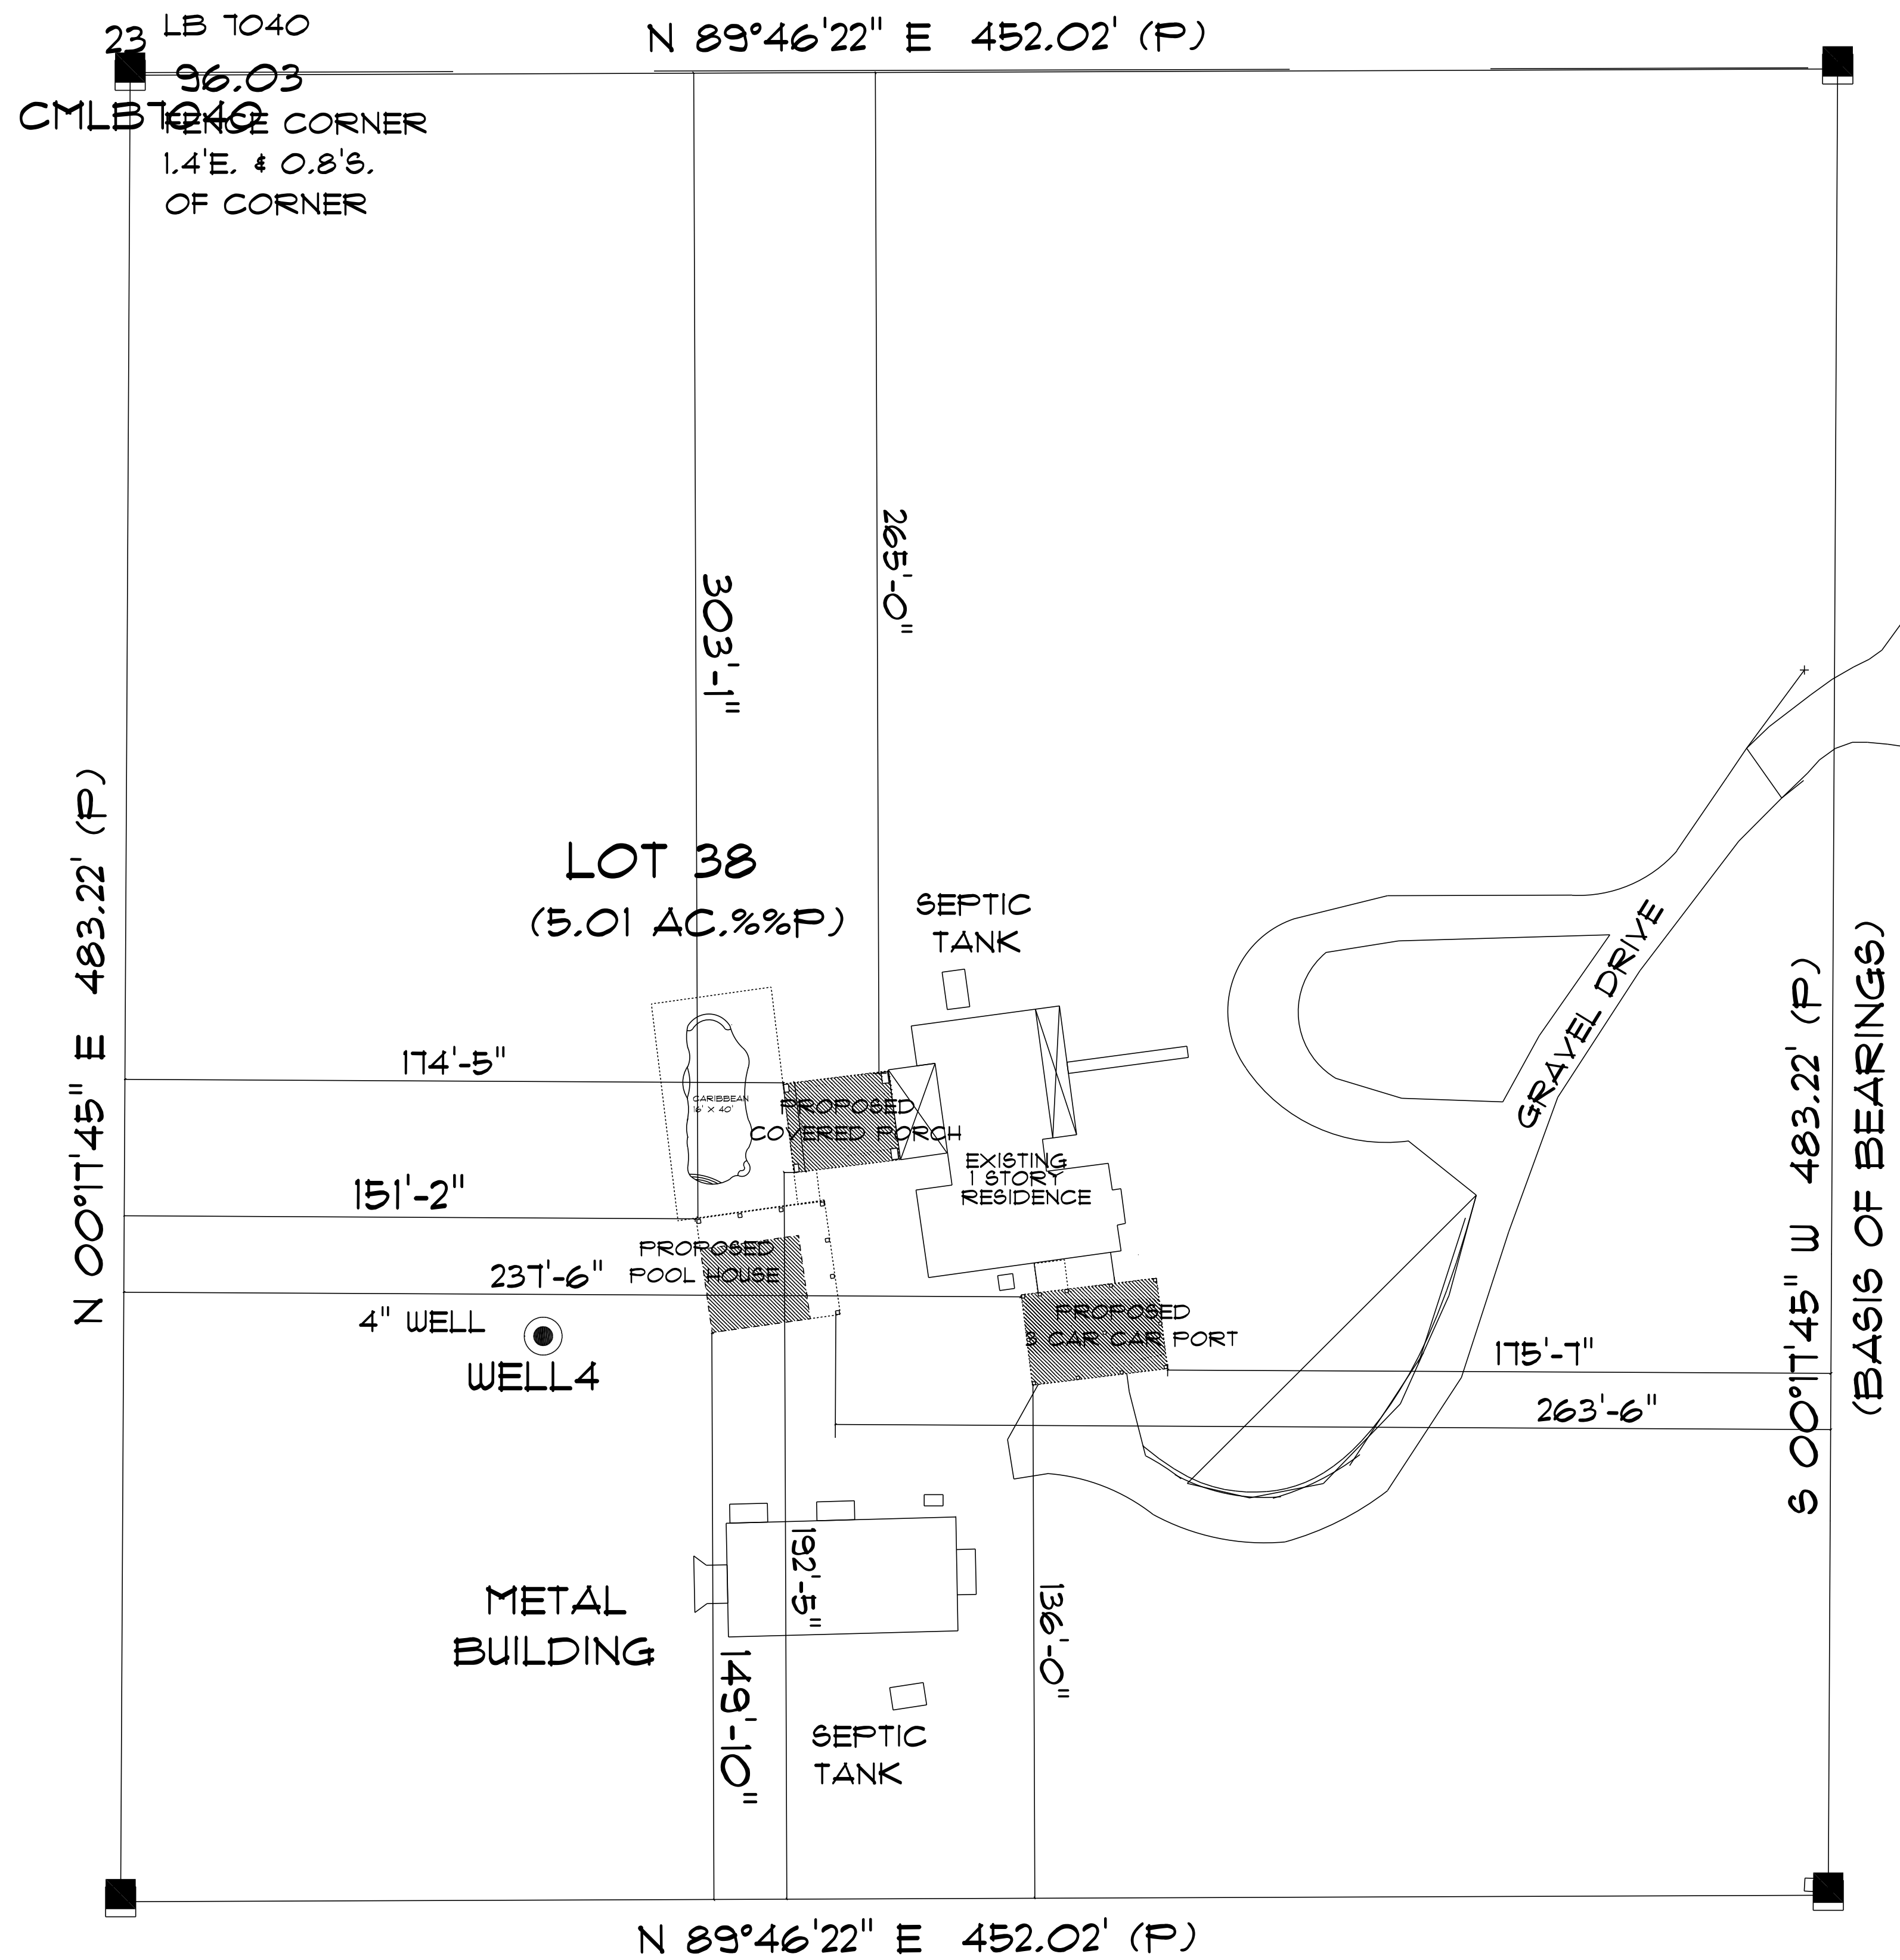

* SITE PLAN *

SCALE : 1" = 30'

EXISTING A/C LIVING AREA	=	2216 S.F.
EXISTING COVERED ENTRY	=	139 S.F.
EXISTING COVERED BACK PORCH	=	265 S.F.
EXISTING 2 CAR CARPORT	=	676 S.F.
TOTAL EXISTING AREA UNDER ROOF	=	3,296 S.F.
NEW A/C AREA UNDER ROOF	=	584 S.F.
NEW COVERED PORCHES	=	1,075 S.F.
NEW 3 CAR CARPORT	=	931 S.F.
TOTAL NEW SQUARE FOOTAGE	=	2,590 S.F.
TOTAL NEW/EXISTING AREA UNDER ROOF	=	5,886 S.F.

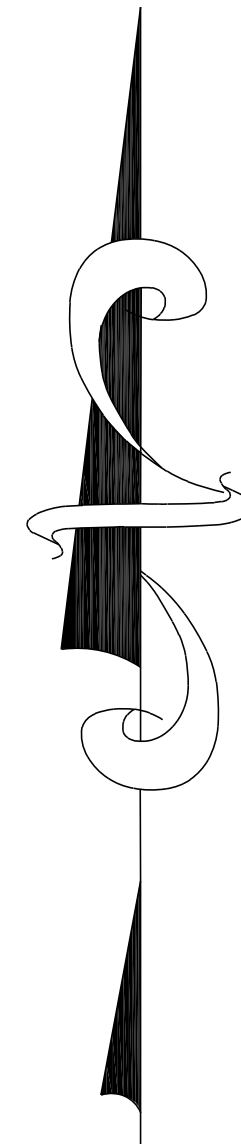

PATTY & CHRIS
METRICK

3891 SW PINEMOUNT RD
LAKE CITY, FLORIDA

Teena M. Ruffo
2925 SW SR 47
Lake City Florida, 32025
Cell: (386) 867-1191
Email: teenaruffo@gmail.com

PRINTED DATE:
Wednesday, July 7, 2021

DRAWN BY: Teena M. Ruffo
CHECKED BY:

BUILDING CONTRACTOR


FINAL DATE:

JOB NUMBER:

DRAWING NUMBER

A-1


OF 8 SHEETS

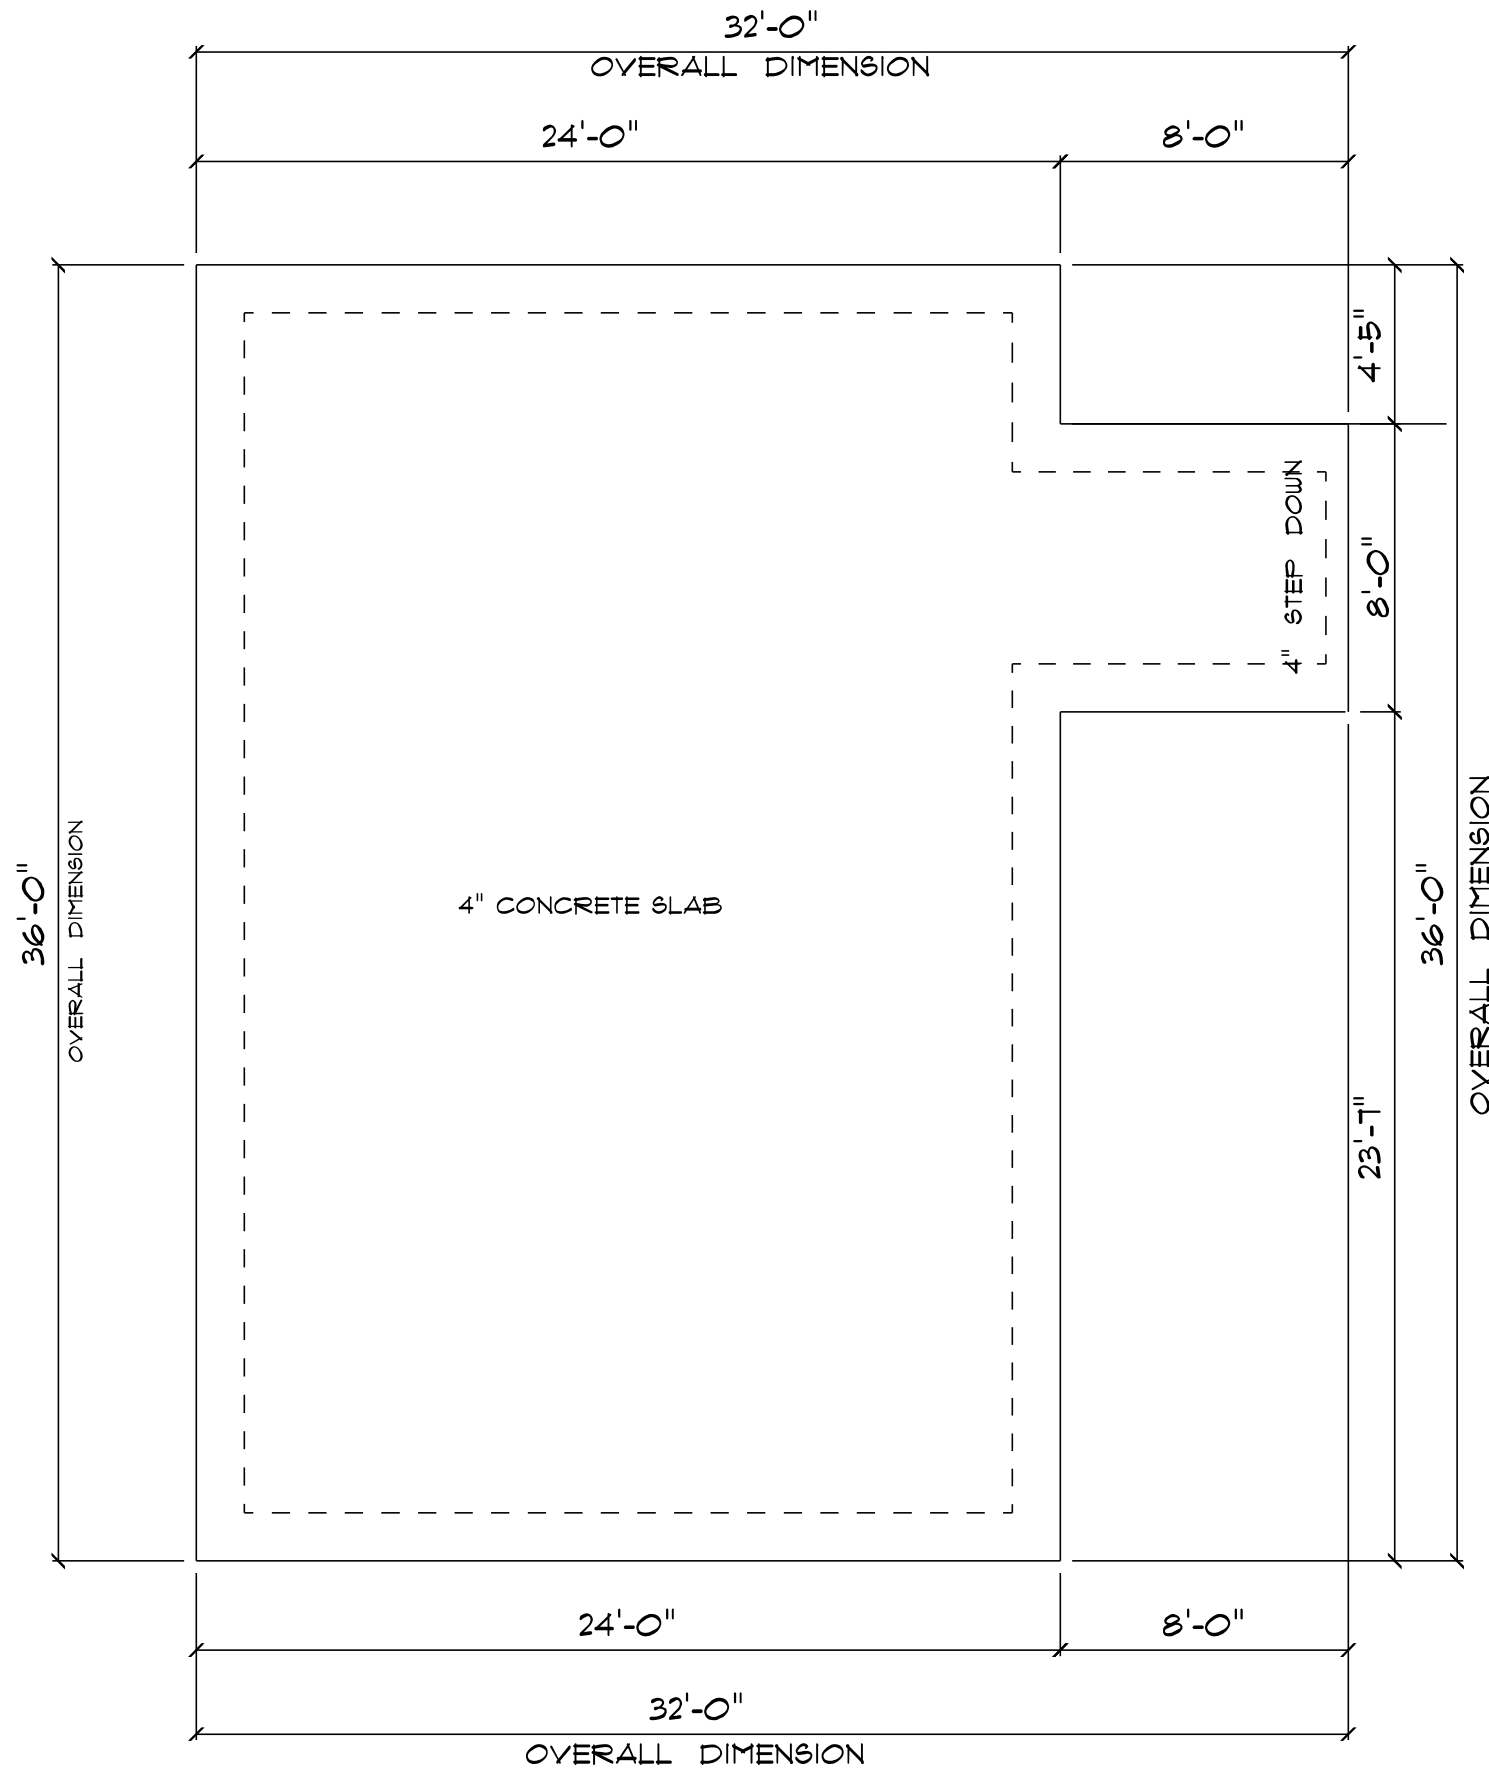

* CARPORT FOUNDATION PLAN *

SCALE : 1/4" = 1'-0"


- IMPORTANT NOTES:
1. IT IS THE BUILDER'S RESPONSIBILITY TO VERIFY ALL GEOMETRY AND DIMENSIONS BEFORE ORDERING ANY MATERIALS OR BEGINNING CONSTRUCTION.
 2. THESE PLANS ARE FOR LAYOUT AND DESIGN PURPOSES ONLY. ALL STRUCTURAL NOTES AND DETAILS TO BE PROVIDED BY AN ENGINEER.
 3. ALL EXTERIOR DOORS TO BE 8'-0"

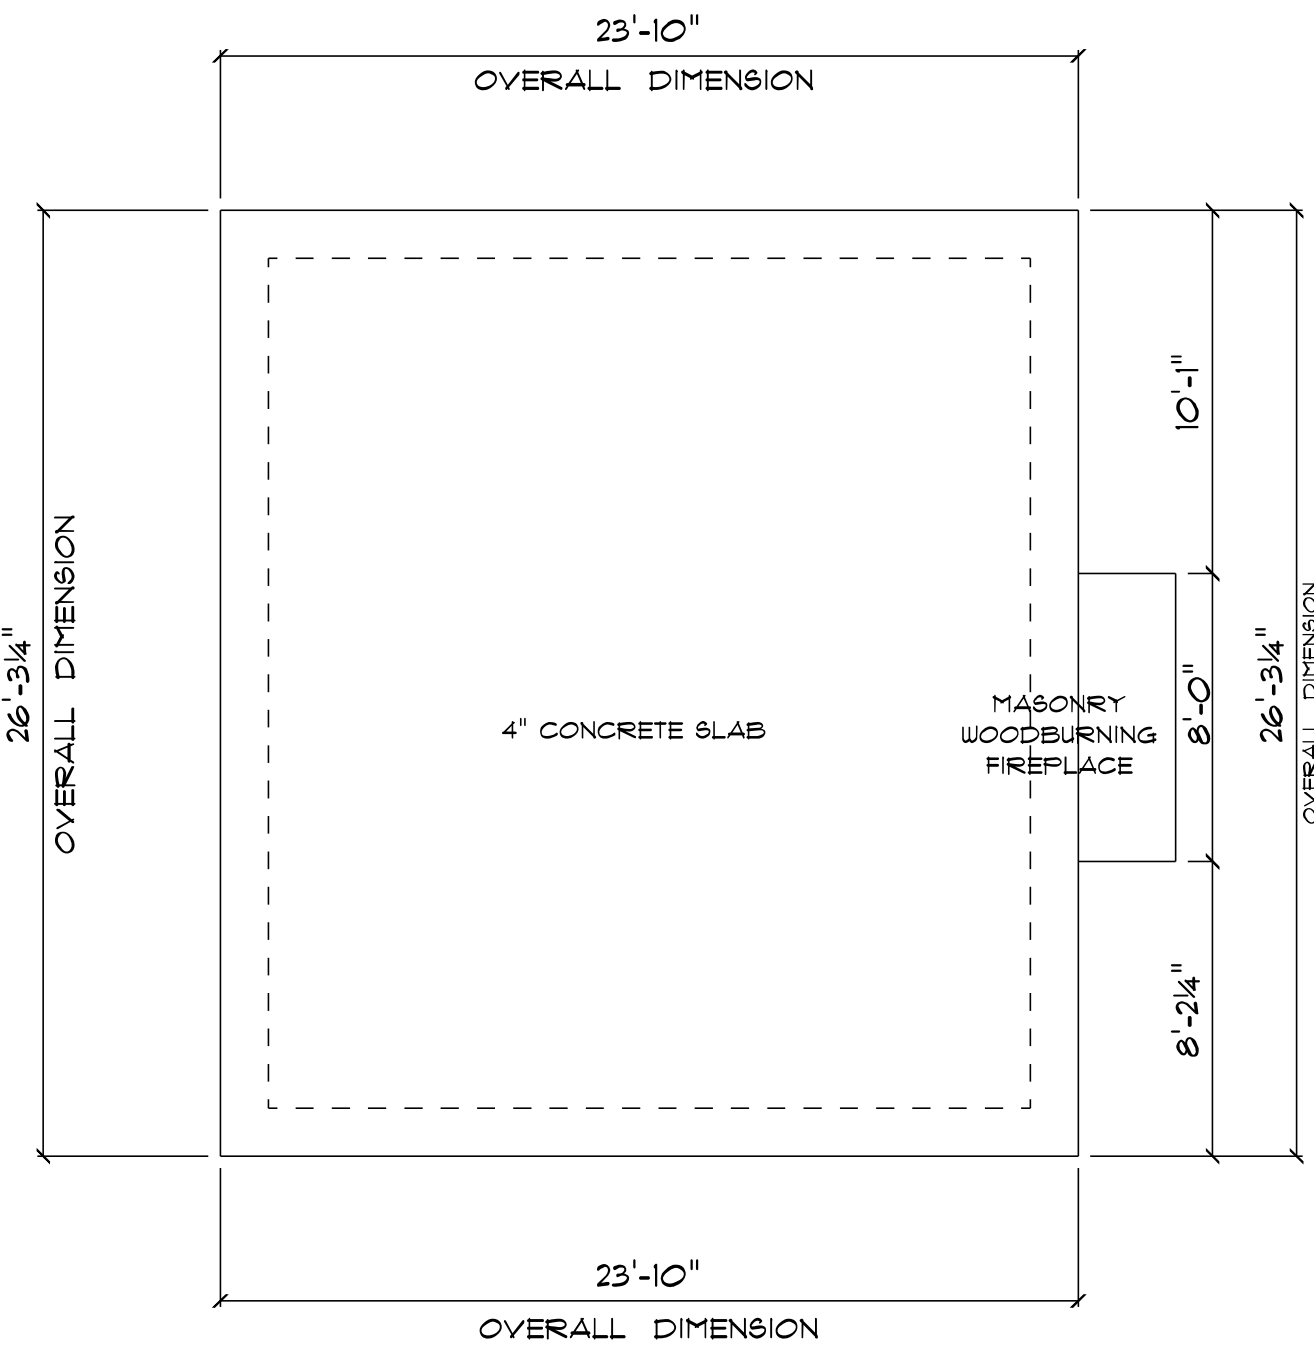

* COVERED PORCH FOUNDATION PLAN *

SCALE : 1/4" = 1'-0"

- IMPORTANT NOTES:
1. IT IS THE BUILDER'S RESPONSIBILITY TO VERIFY ALL GEOMETRY AND DIMENSIONS BEFORE ORDERING ANY MATERIALS OR BEGINNING CONSTRUCTION.
 2. THESE PLANS ARE FOR LAYOUT AND DESIGN PURPOSES ONLY. ALL STRUCTURAL NOTES AND DETAILS TO BE PROVIDED BY AN ENGINEER.

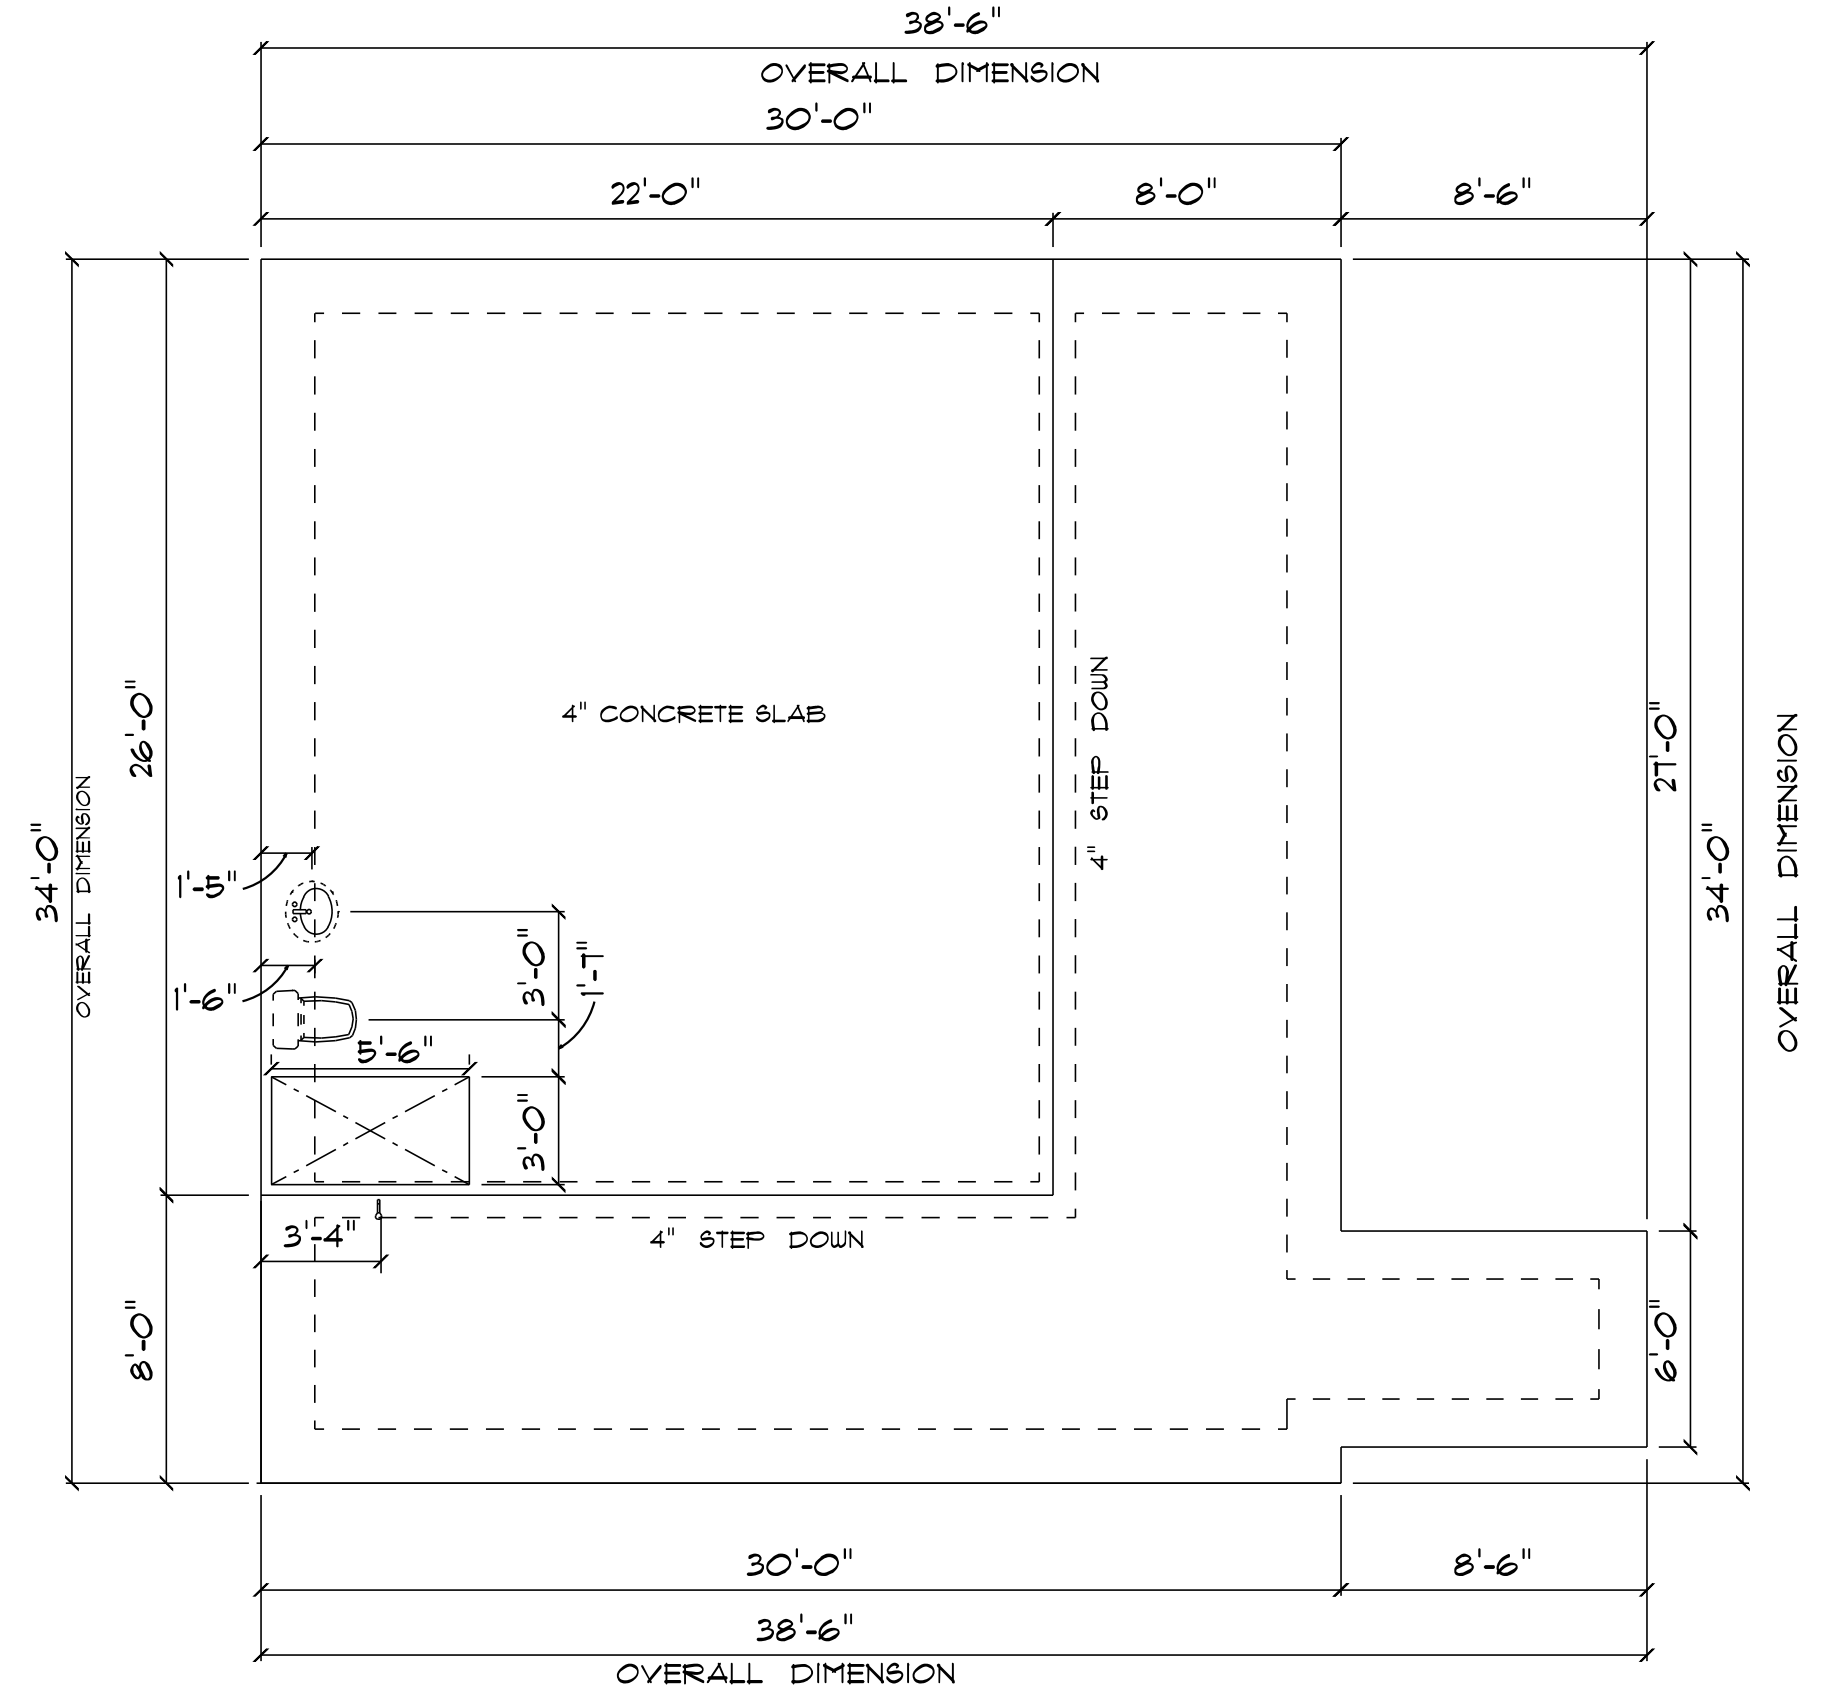

* POOL HOUSE *

* PLUMBING/FOUNDATION PLAN *

SCALE : 1/4" = 1'-0"

- IMPORTANT NOTES:
1. IT IS THE BUILDER'S RESPONSIBILITY TO VERIFY ALL GEOMETRY AND DIMENSIONS BEFORE ORDERING ANY MATERIALS OR BEGINNING CONSTRUCTION.
 2. THESE PLANS ARE FOR LAYOUT AND DESIGN PURPOSES ONLY. ALL STRUCTURAL NOTES AND DETAILS TO BE PROVIDED BY AN ENGINEER.
 3. ALL EXTERIOR DOORS TO BE 8'-0"

**PATTY & CHRIS
HETRICK**

3891 SW PINEMOUNT RD
LAKE CITY, FLORIDA

Teena M. Ruffo
2925 SW SR 47
Lake City Florida, 32025
Cell: (386) 861 - 1191
Email: teenaruffo@gmail.com

PRINTED DATE:
Wednesday, July 7, 2021

DRAWN BY: Teena M. Ruffo

CHECKED BY:

BUILDING CONTRACTOR


FINAL DATE:

JOB NUMBER:

DRAWING NUMBER

A-2

OF 8 SHEETS

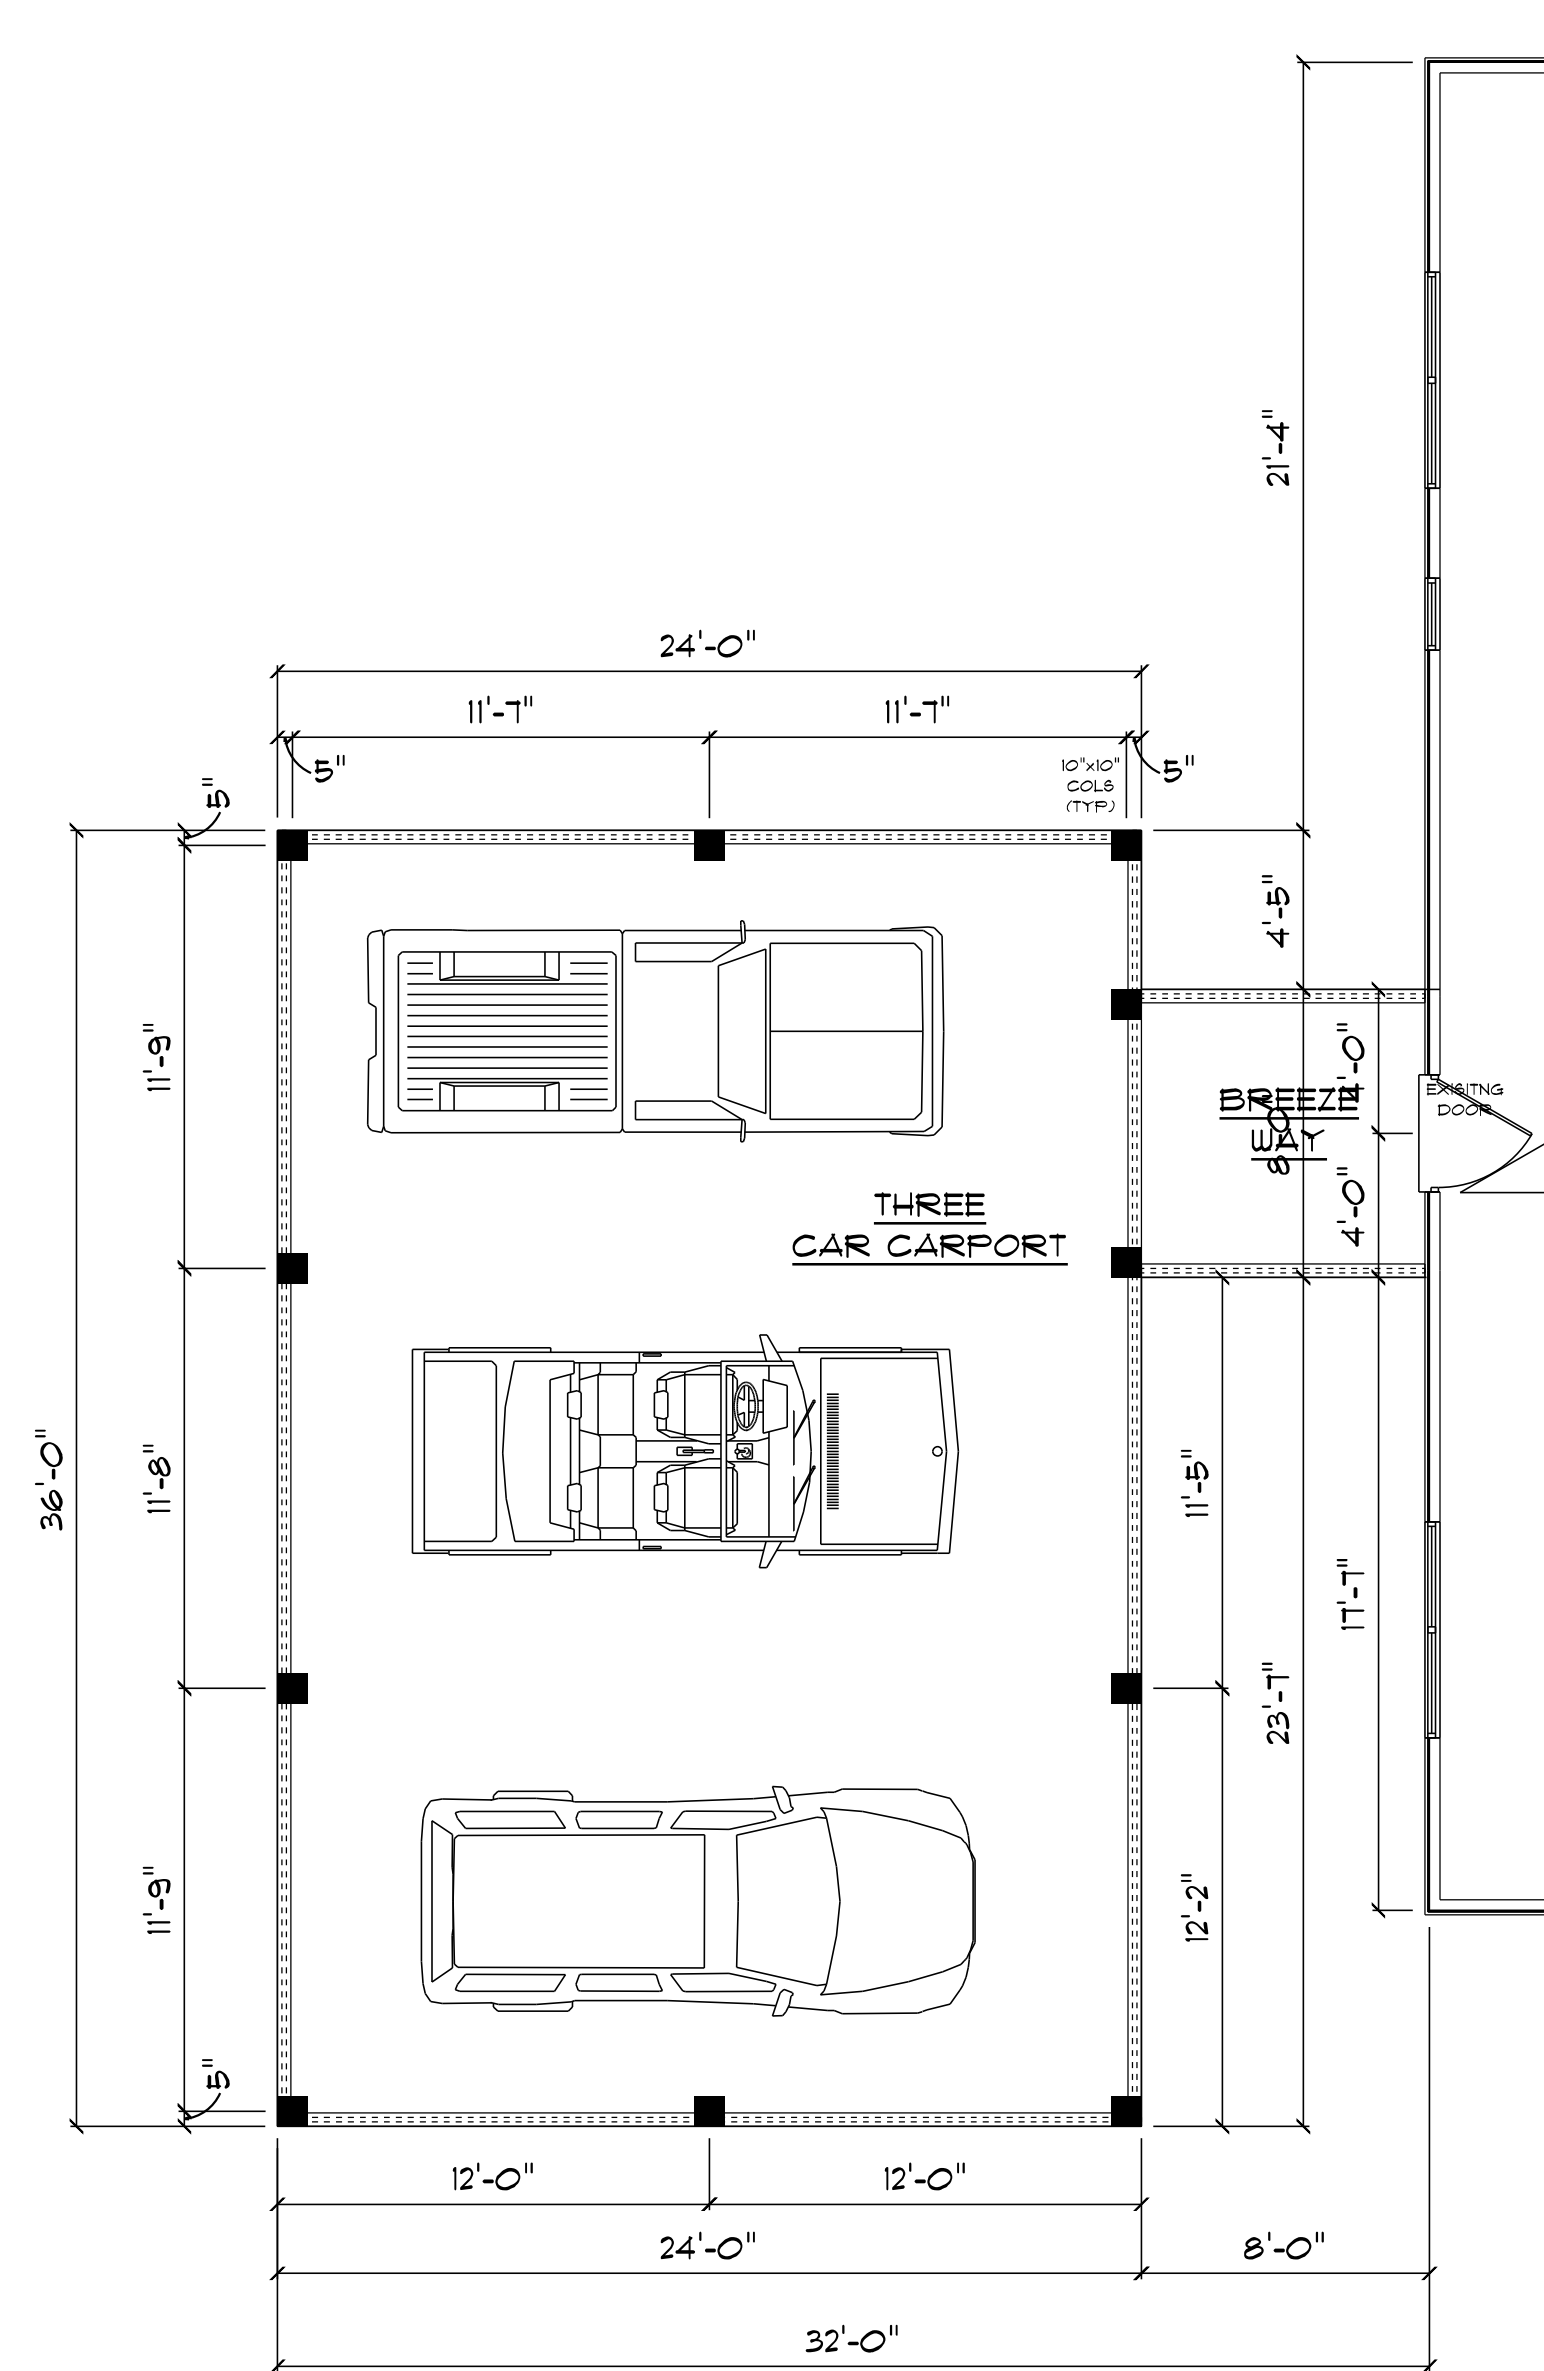

* CARPORT *
* FLOOR PLAN *
SCALE : 3/16" = 1'-0"


IMPORTANT NOTES:
1. IT IS THE BUILDER'S RESPONSIBILITY TO VERIFY ALL GEOMETRY AND DIMENSIONS BEFORE ORDERING ANY MATERIALS OR BEGINNING CONSTRUCTION.
2. THESE PLANS ARE FOR LAYOUT AND DESIGN PURPOSES ONLY. ALL STRUCTURAL NOTES AND DETAILS TO BE PROVIDED BY AN ENGINEER.

NEW 3 CAR CARPORT AND BREEZEWAY = 931 S.F.

ELECTRICAL LEGEND		
ELECTRICAL	COUNT	SYMBOL
ceiling fan globe	2	
pot light	10	
outlet w/p	2	
switch	2	

ELECTRICAL PLAN NOTES

- E-1 WIRE ALL APPLIANCES, HVAC UNITS AND OTHER EQUIPMENT PER MANUFACTURER'S SPECIFICATIONS.
- E-2 ALL INSTALLATIONS SHALL BE PER NATIONAL ELECTRIC CODE.
- E-3 ALL SMOKE /CARBON MONOXIDE DETECTORS SHALL BE 120V W/BATTERY BACKUP OF THE PHOTOELECTRIC TYPE AND SHALL BE INTERLOCKED TOGETHER. INSTALL INSIDE AND NEAR ALL BEDROOMS AS PER CODE.
- E-4 TELEPHONE, TELEVISION AND OTHER LOW VOLTAGE DEVICES OR OUTLETS SHALL BE AS PER THE OWNER'S DIRECTION AND IN ACCORDANCE WITH APPLICABLE SECTIONS OF NATIONAL ELEC. CODE LATEST EDITION.
- E-5 ELECTRICAL CONTRACTOR SHALL BE RESPONSIBLE FOR THE DESIGN AND SIZING OF ELECTRICAL SERVICE AND CIRCUITS.
- E-6 ENTRY OF SERVICE UNDERGROUND OR OVERHEAD) IS TO BE DETERMINED BY THE POWER COMPANY.
- E-7 ALL BEDROOM RECEPTALS ARE TO BE AFCI (ARC FAULT CIRCUIT INTERRUPT).
- E-8 75% OF ALL PERMANENT LIGHTS TO BE ENERGY EFFICIENT.

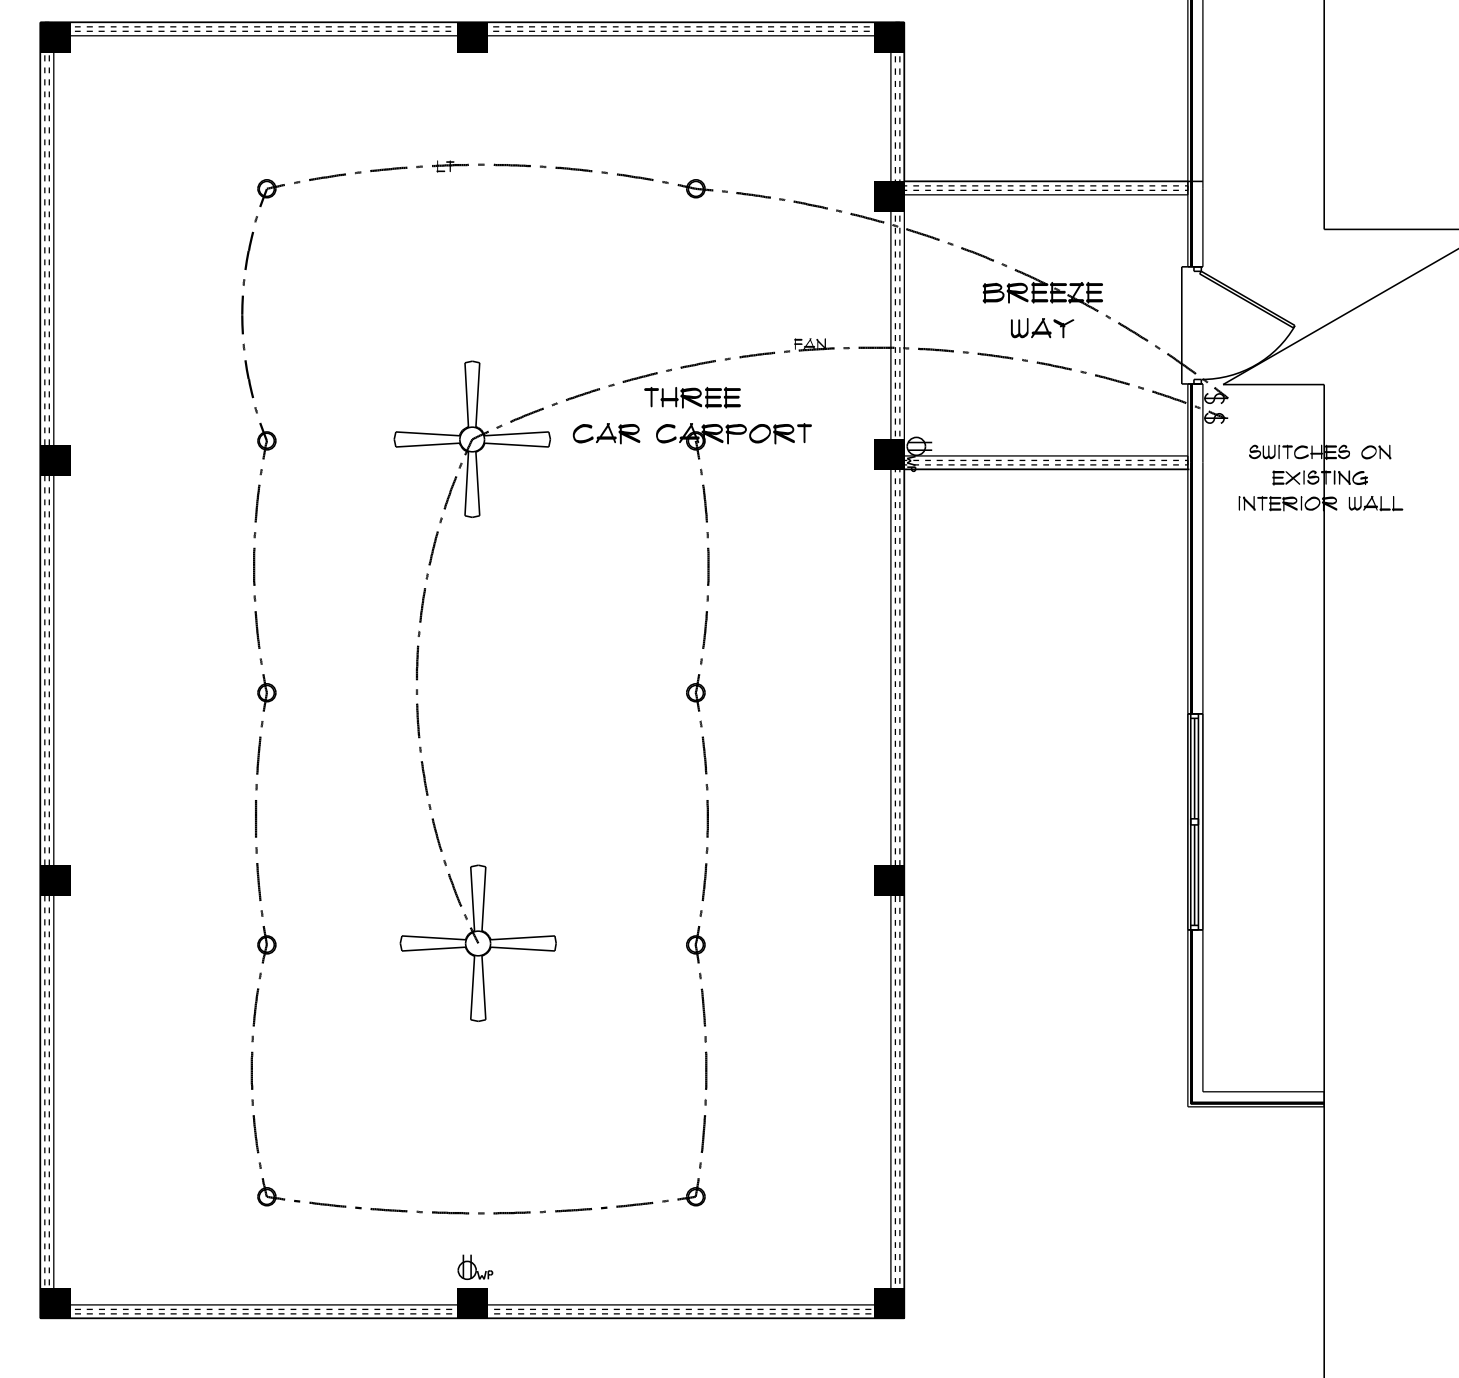

* CARPORT *
* ELECTRIC PLAN *
SCALE : 3/16" = 1'-0"

PATTY & CHRIS
METRICK

3891 SW PINEMOUNT RD
LAKE CITY, FLORIDA

Teena M. Ruffo
2925 SW SR 47
Lake City Florida, 32025
Cell: (386) 861 - 1191
Email: teenaruffo@gmail.com

PRINTED DATE:
Wednesday, July 7, 2021

DRAWN BY: Teena M. Ruffo CHECKED BY:


BUILDING CONTRACTOR

FINAL DATE:


JOB NUMBER:

DRAWING NUMBER


A-3
OF 8 SHEETS

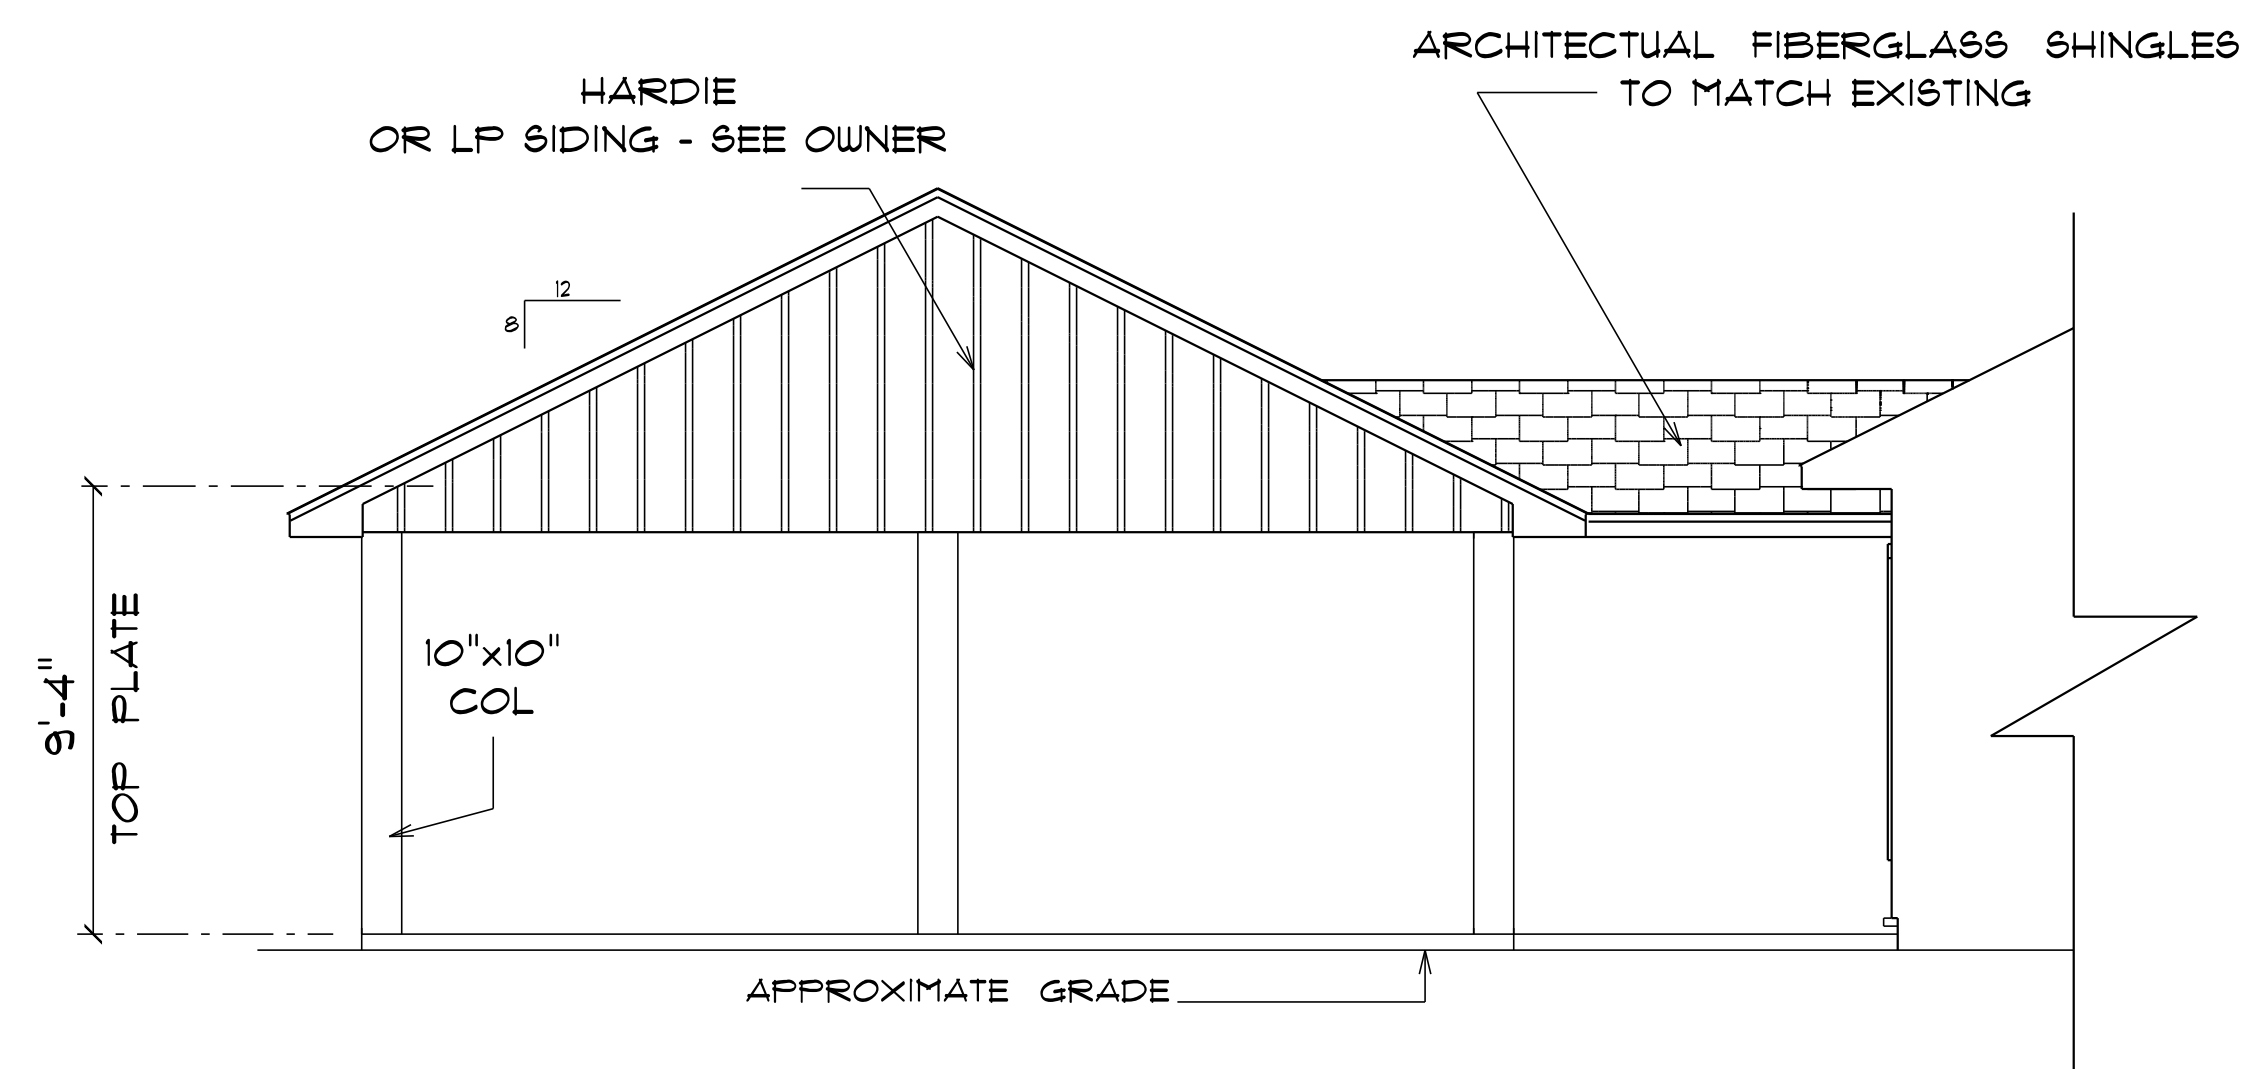


*** CARPORT ***
*** FRONT ELEVATION ***
 SCALE : 1/4" = 1'-0"

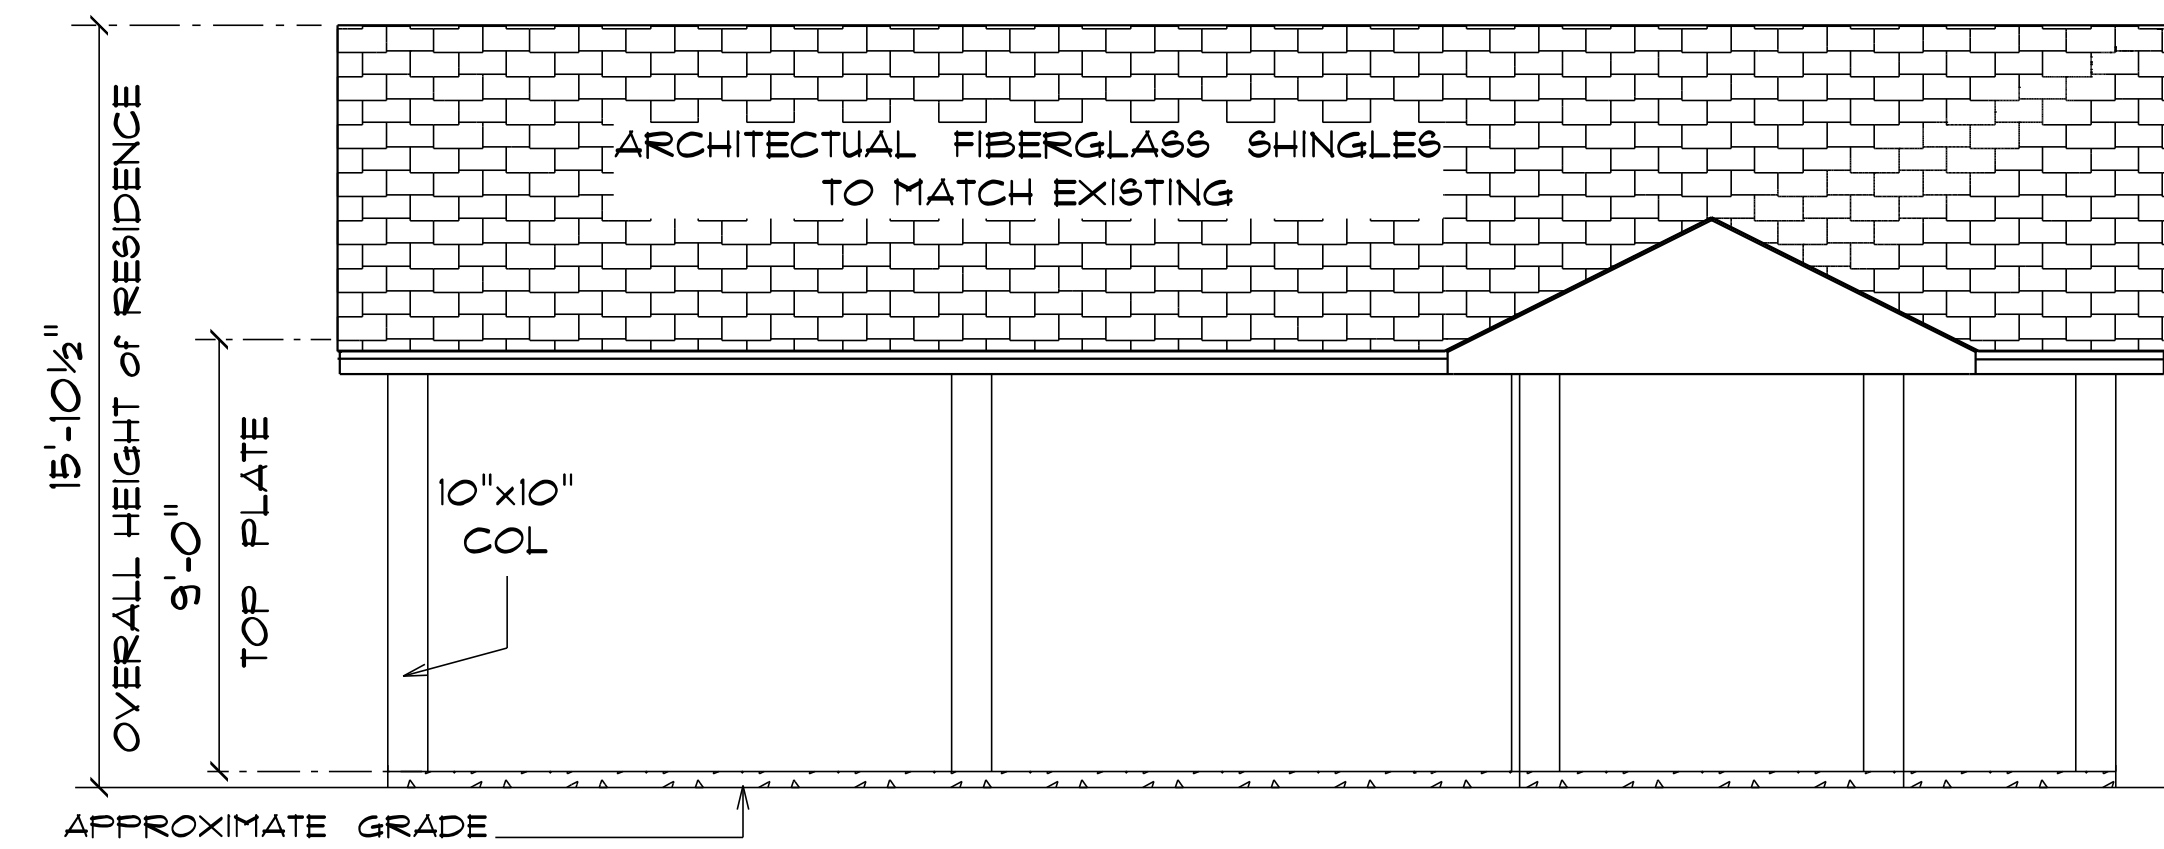

*** CARPORT ***
*** RIGHT SIDE ELEVATION ***
 SCALE : 1/4" = 1'-0"

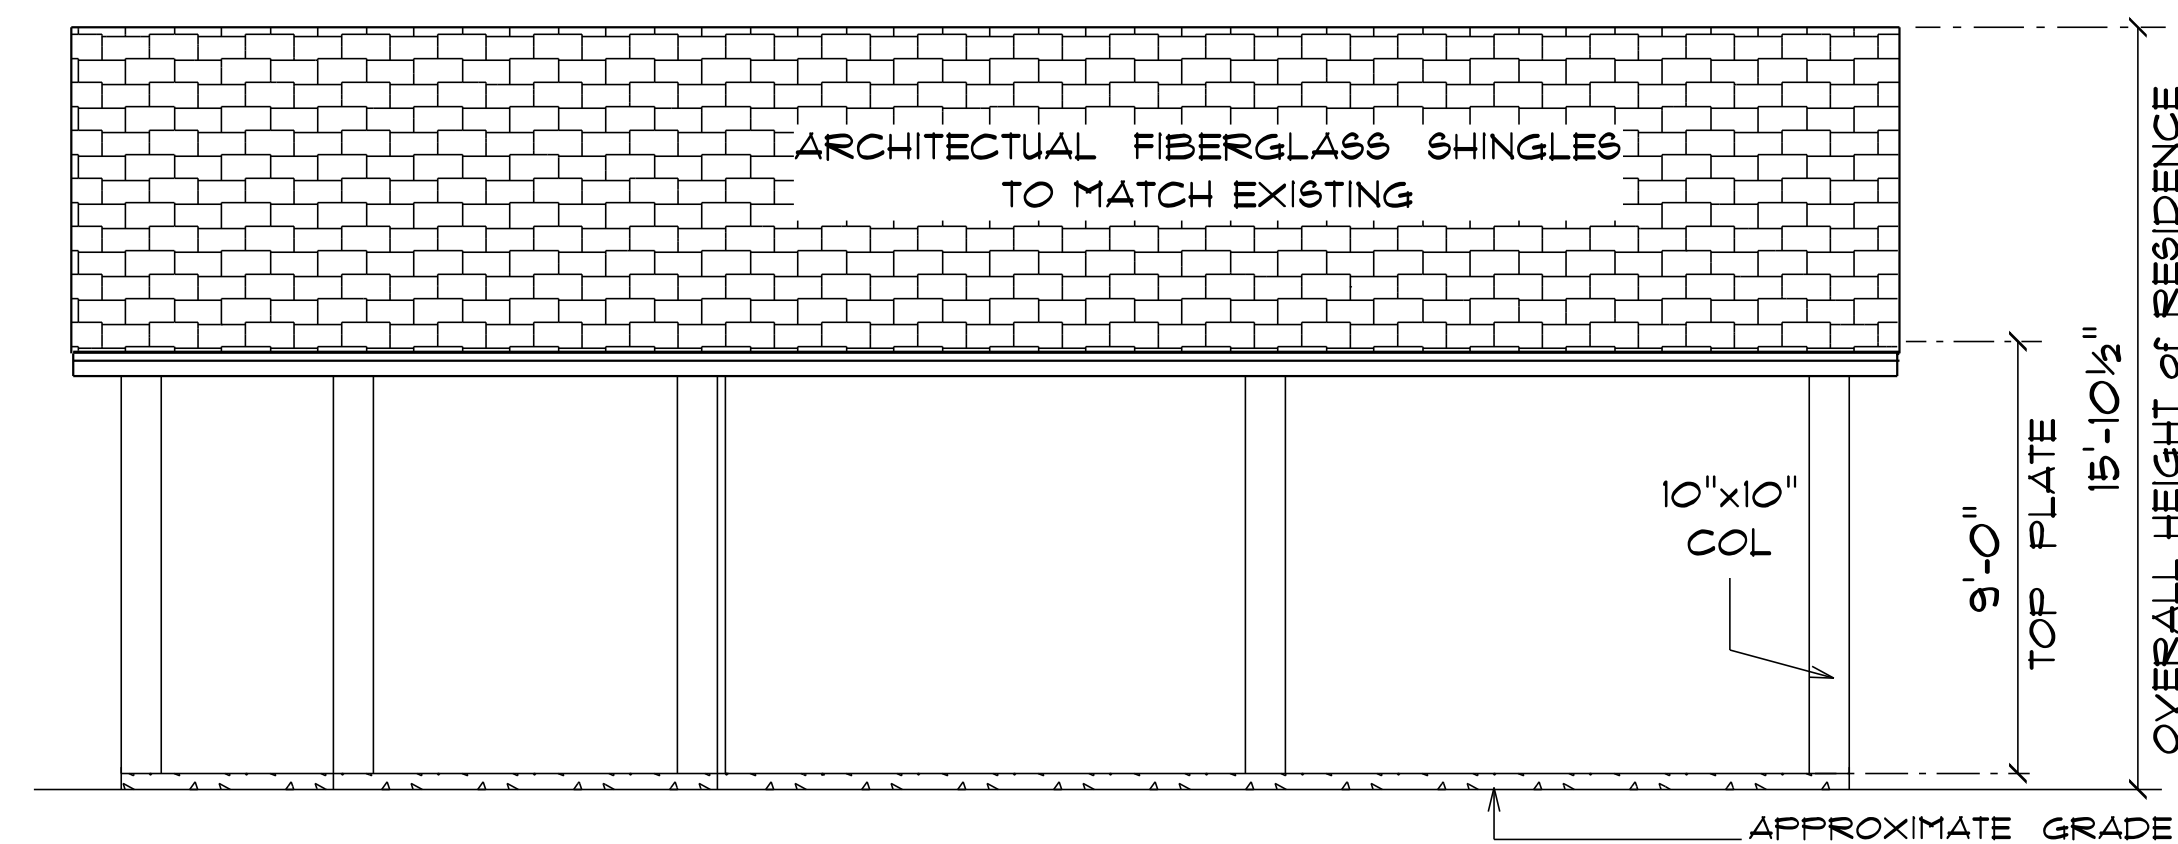

*** CARPORT ***
*** LEFT SIDE ELEVATION ***
 SCALE : 1/4" = 1'-0"

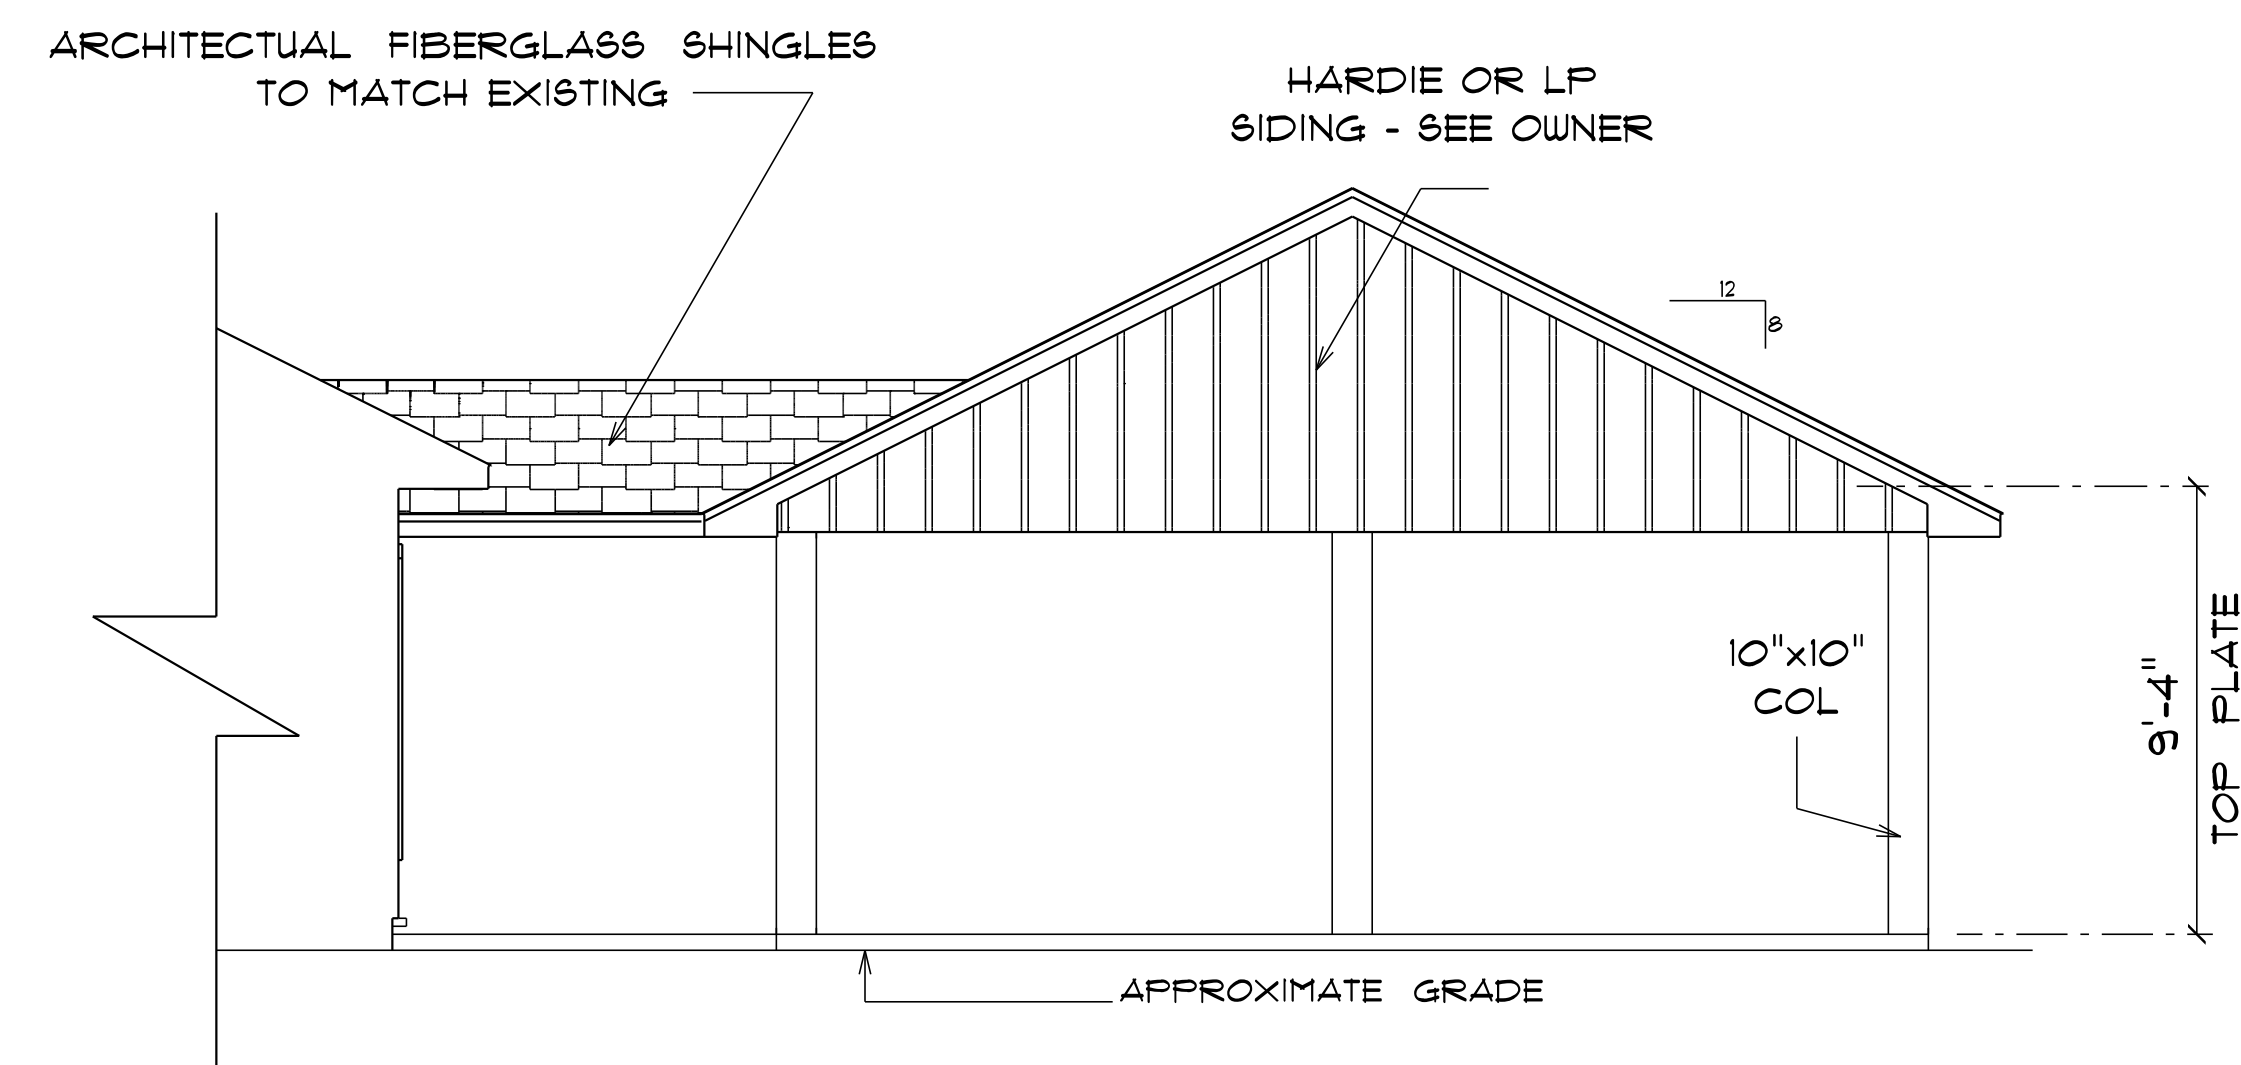

*** CARPORT ***
*** REAR ELEVATION ***
 SCALE : 1/4" = 1'-0"

**PATTY & CHRIS
 HEIRICK**

3891 SW PINEMOUNT RD
 LAKE CITY, FLORIDA

Teena M. Ruffo
 2925 SW SR 41
 Lake City Florida, 32025
 Cell: (386) 861-1191
 Email: teenaruffo@gmail.com

PRINTED DATE:
 Wednesday, July 7, 2021

DRAWN BY: Teena M. Ruffo CHECKED BY:

BUILDING CONTRACTOR


FINAL DATE:

JOB NUMBER:

DRAWING NUMBER

A-4

OF 8 SHEETS

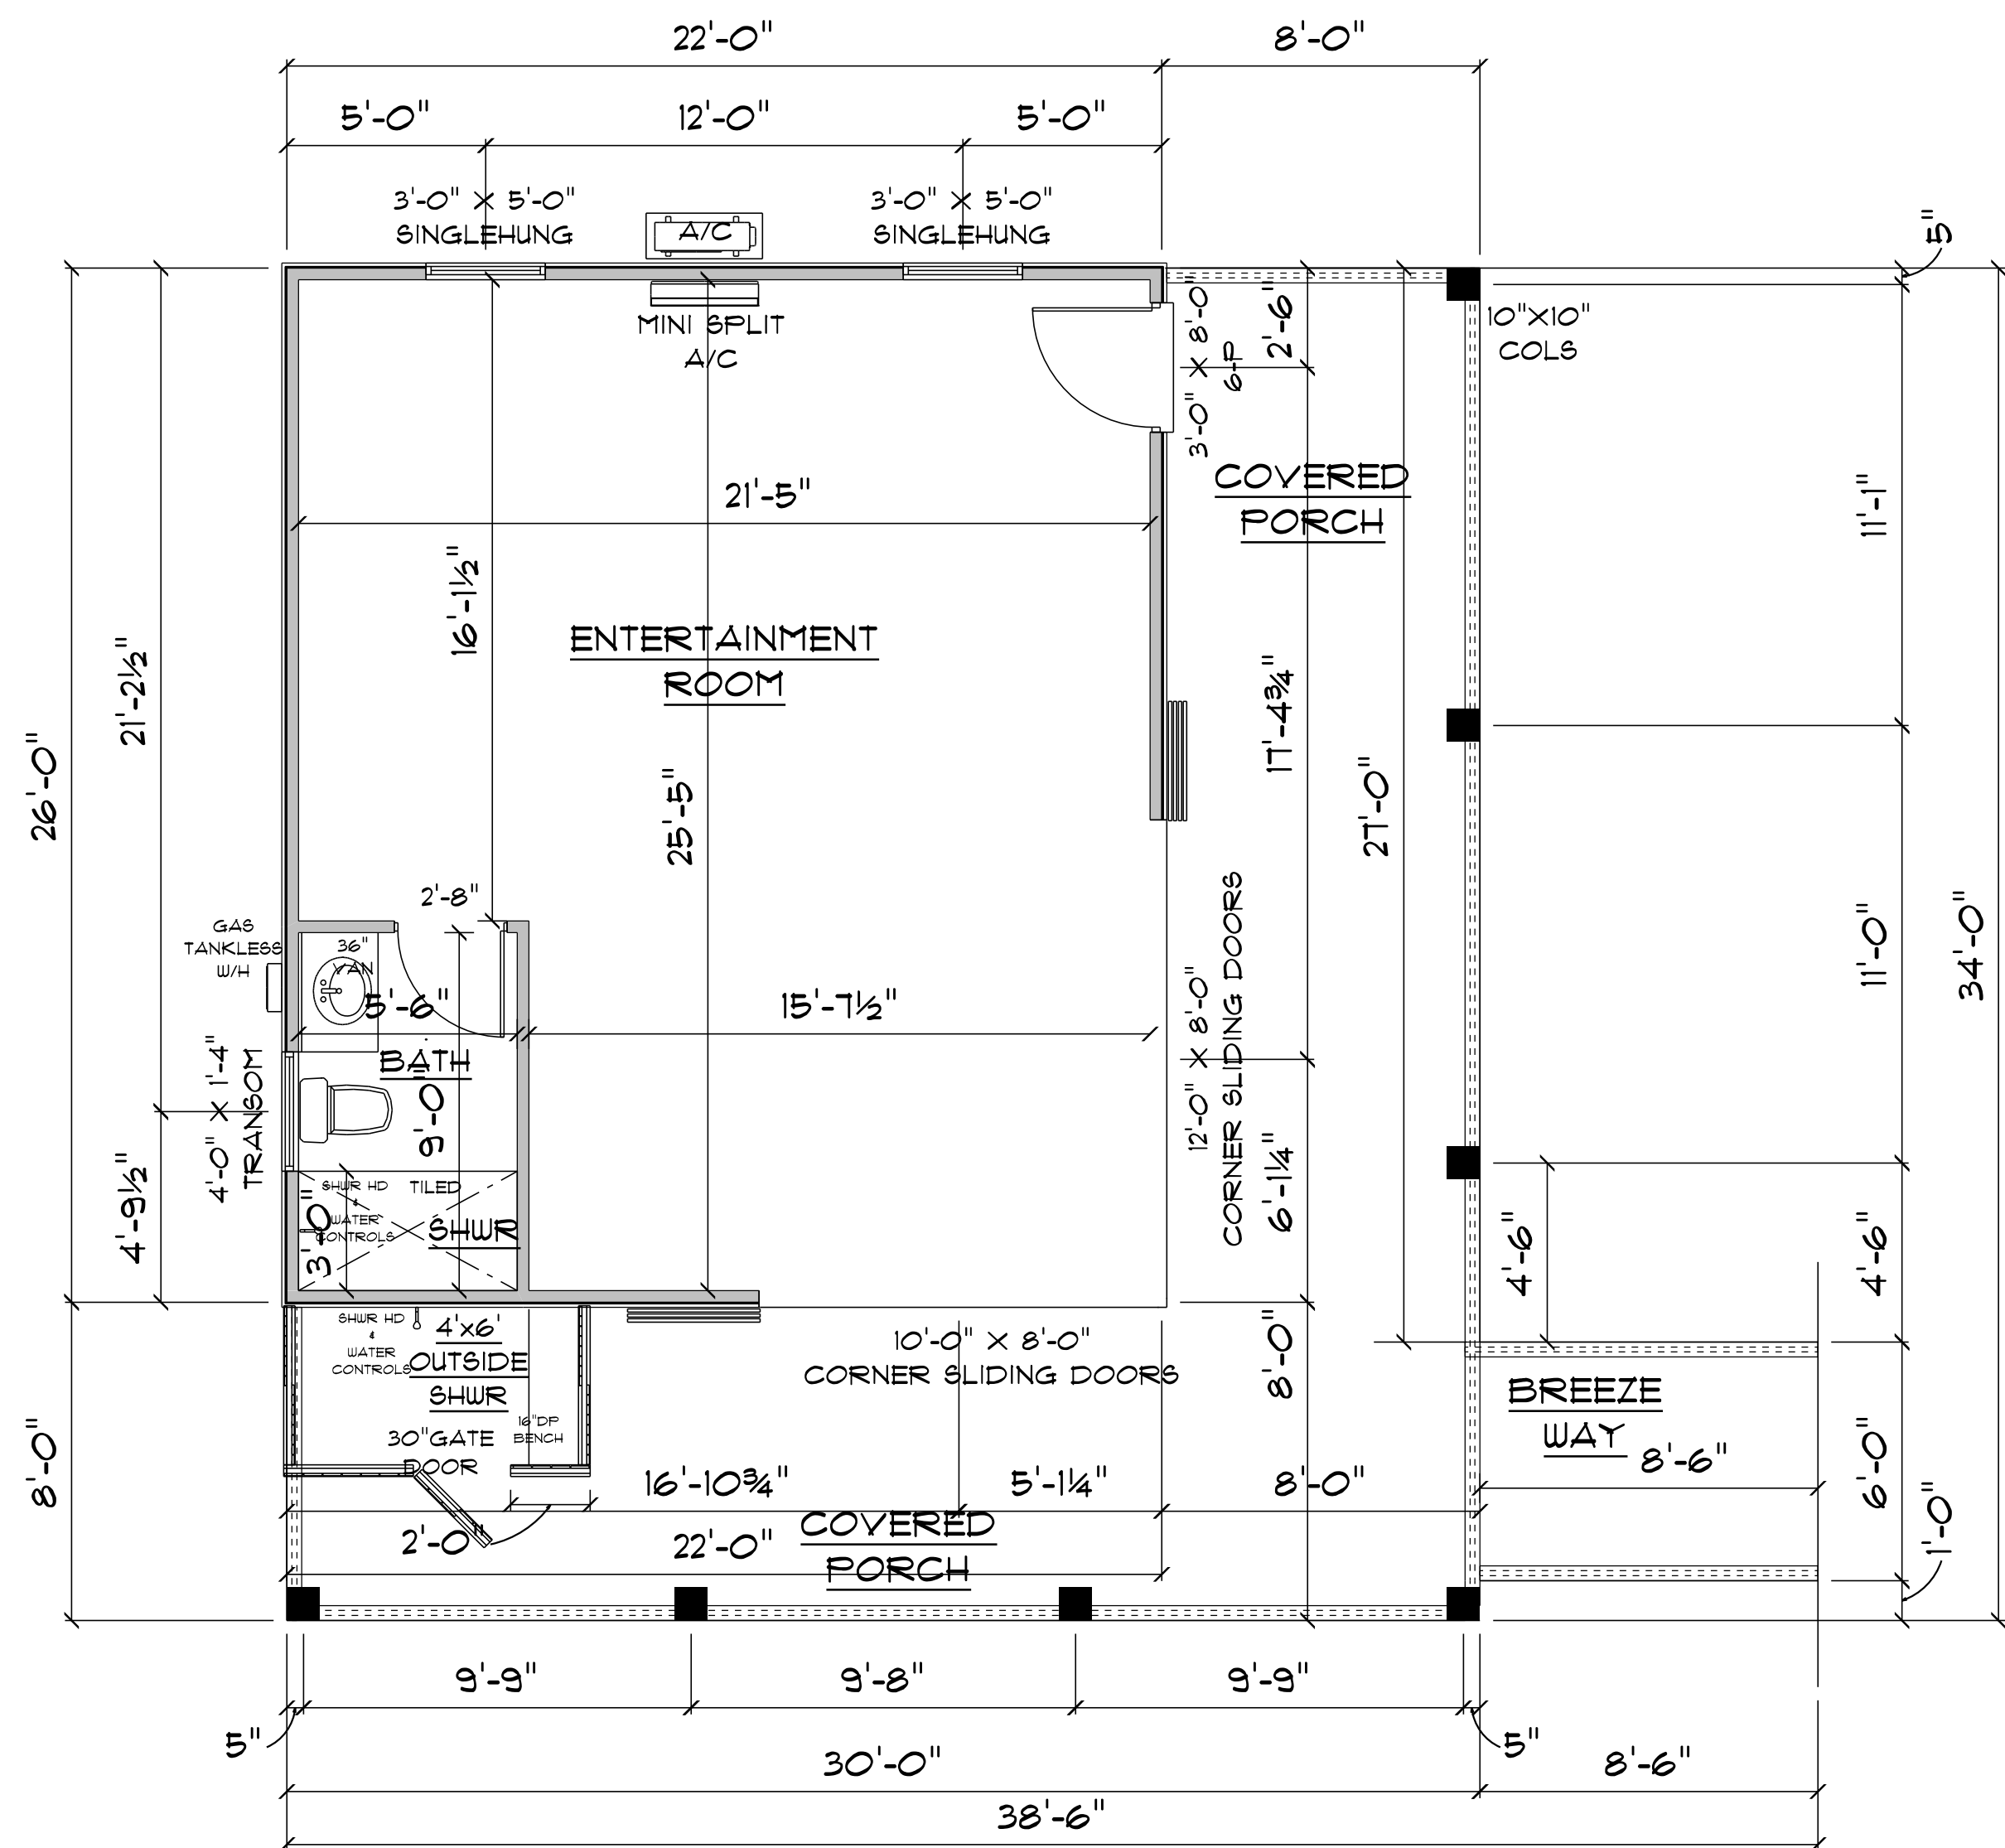


* POOL HOUSE *

* FLOOR PLAN *

SCALE : 1/4" = 1'-0"

A/C POOL HOUSE = 584 S.F.
COVERED PORCH = 464 S.F.

TOTAL AREA UNDER ROOF = 1,048 S.F.

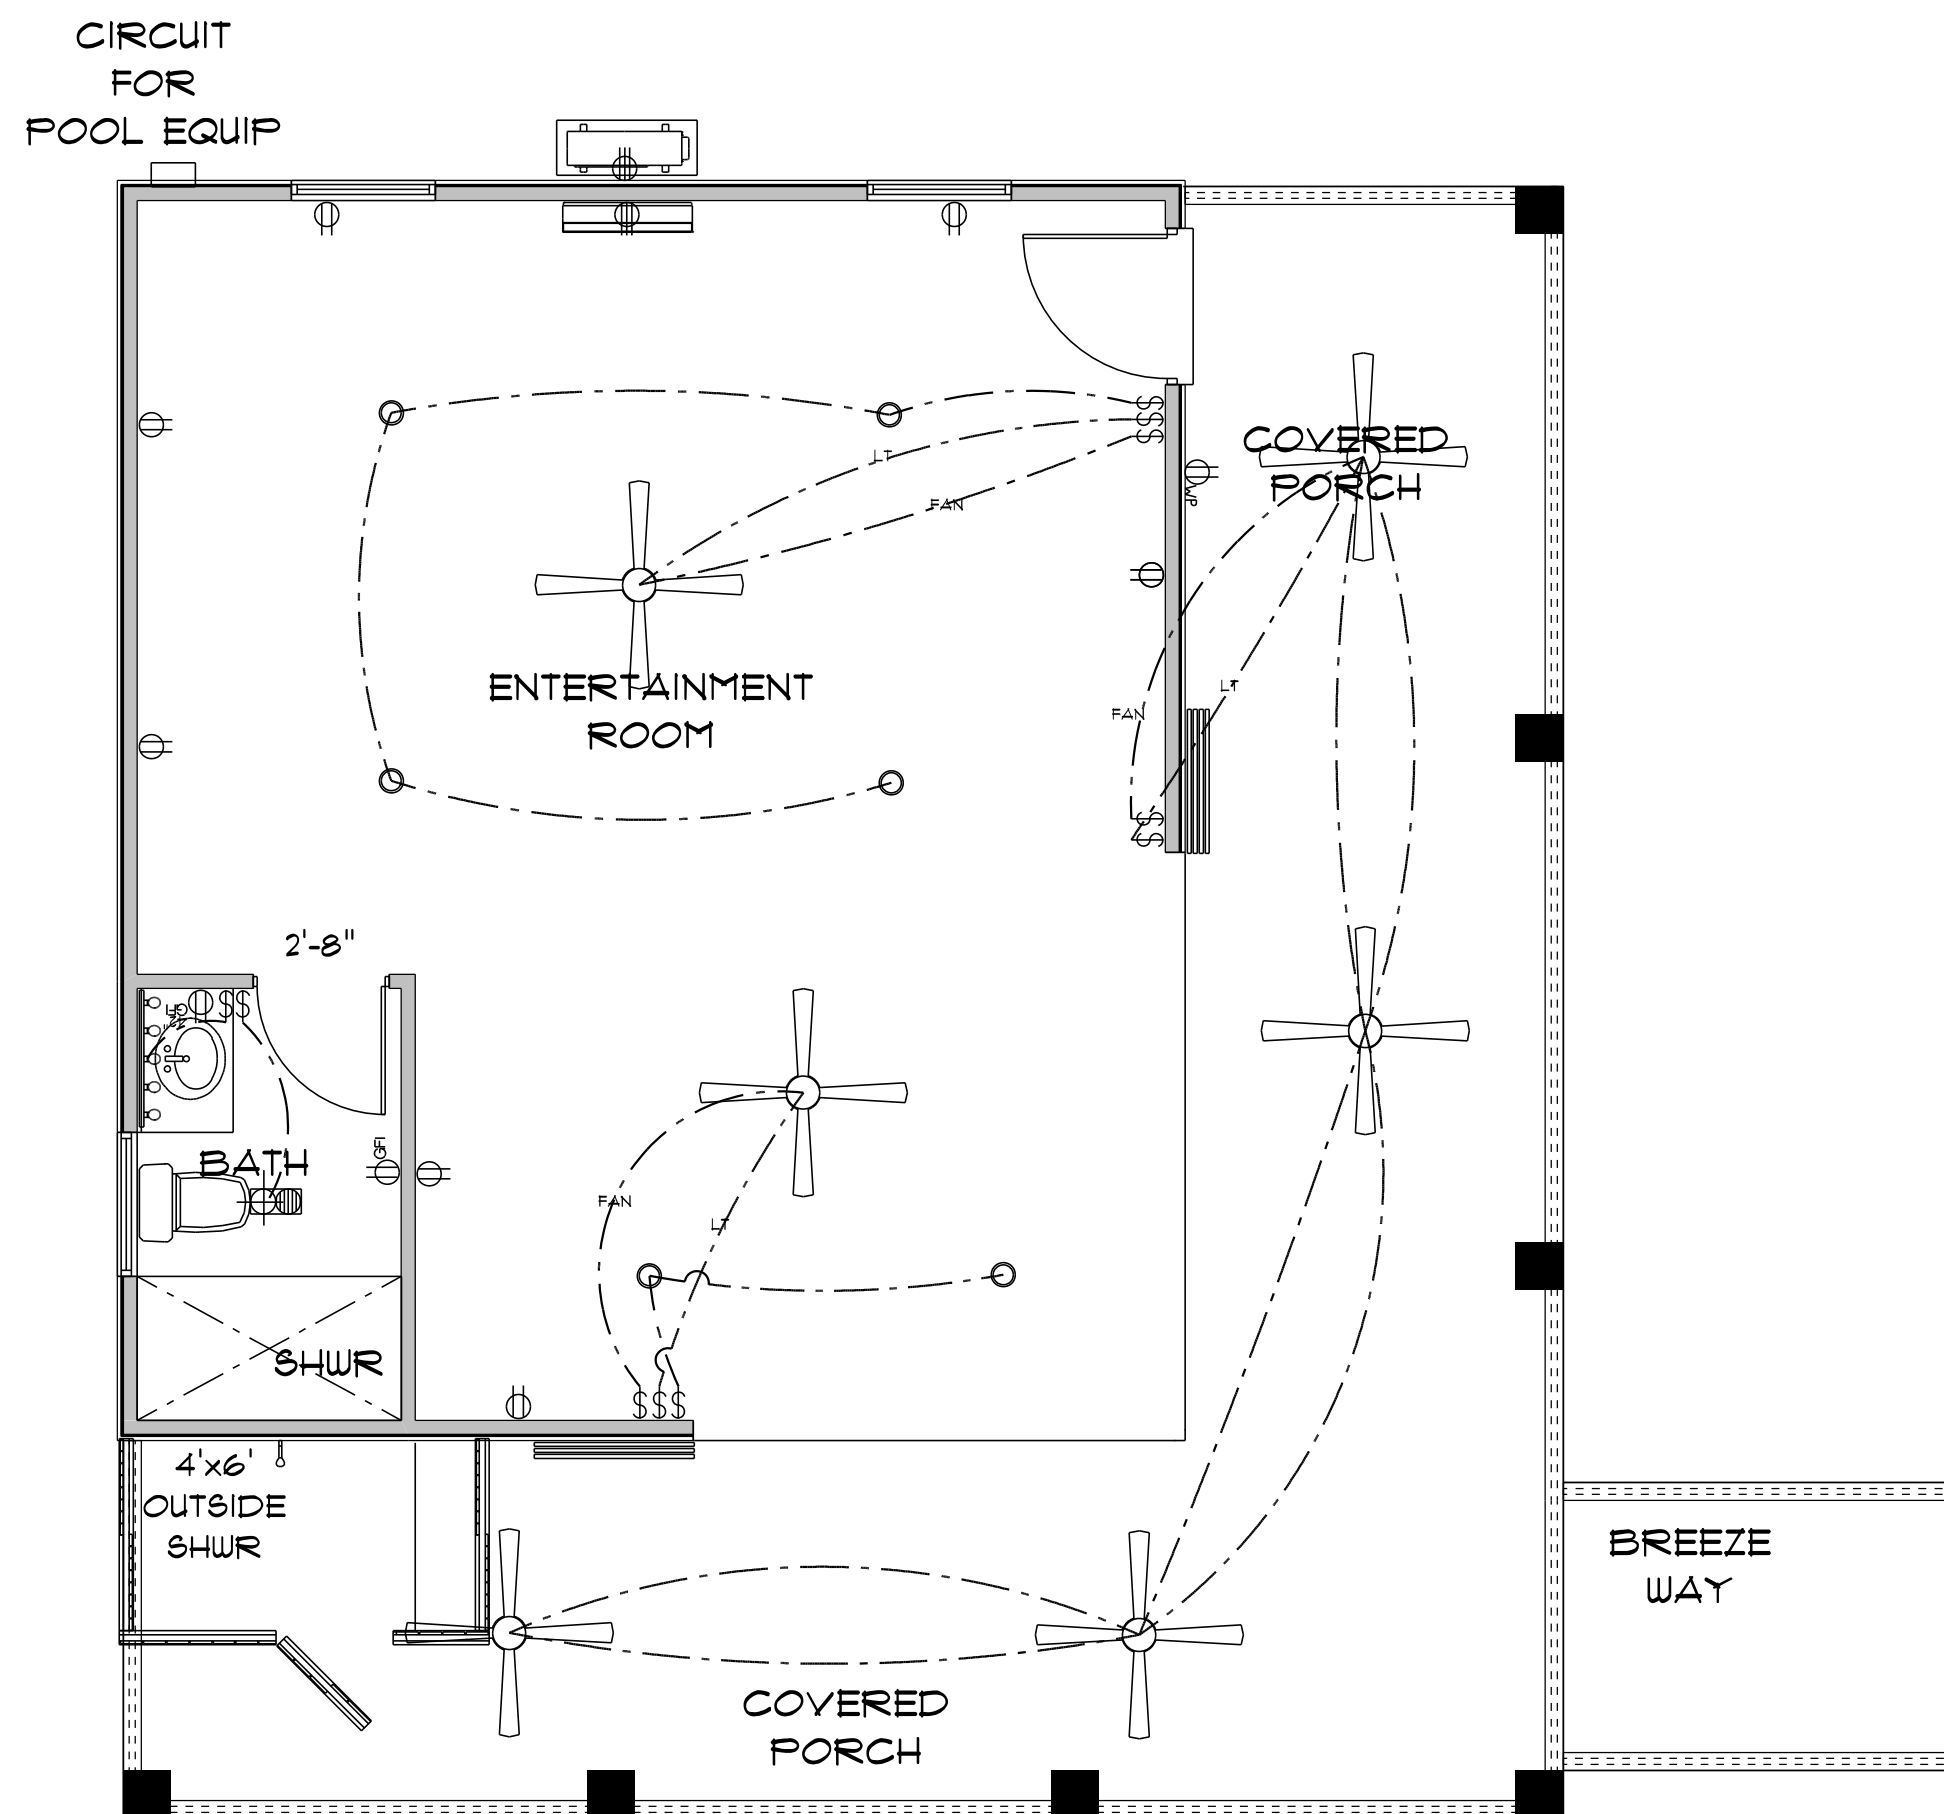

ELECTRICAL LEGEND		
ELECTRICAL	COUNT	SYMBOL
ceiling fan globe Ol	6	
pot light	6	
outlet	8	
outlet 220v	2	
outlet gfi	2	
outlet wp	1	
switch	10	
vent light combo	1	
vanity bar light Ol	1	

ELECTRICAL PLAN NOTES

- E-1 WIRE ALL APPLIANCES, HVAC UNITS AND OTHER EQUIPMENT PER MANUFACTURER'S SPECIFICATIONS.
- E-2 ALL INSTALLATIONS SHALL BE PER NATIONAL ELECTRIC CODE.
- E-3 ALL SMOKE /CARBON MONOXIDE DETECTORS SHALL BE 120V W/BATTERY BACKUP OF THE PHOTOELECTRIC TYPE, AND SHALL BE INTERLOCKED TOGETHER. INSTALL INSIDE AND NEAR ALL BEDROOMS AS PER CODE.
- E-4 TELEPHONE, TELEVISION AND OTHER LOW VOLTAGE DEVICES OR OUTLETS SHALL BE AS PER THE OWNER'S DIRECTION AND IN ACCORDANCE WITH APPLICABLE SECTIONS OF NATIONAL ELCT. CODE LATEST EDITION.
- E-5 ELECTRICAL CONTRACTOR SHALL BE RESPONSIBLE FOR THE DESIGN AND SIZING OF ELECTRICAL SERVICE AND CIRCUITS.
- E-6 ENTRY OF SERVICE UNDERGROUND OR OVERHEAD) IS TO BE DETERMINED BY THE POWER COMPANY.
- E-7 ALL BEDROOM RECEPTALS ARE TO BE AFCI (ARC FAULT CIRCUIT INTERRUPT).
- E-8 75% OF ALL PERMANENT LIGHTS TO BE ENERGY EFFICIENT.

* POOL HOUSE *
* ELECTRIC PLAN *

SCALE : 1/4" = 1'-0"

PATTY & CHRIS
METRICK

3891 SW PINEMOUNT RD
LAKE CITY, FLORIDA

Teresa M. Ruffo
2925 SW SR 47
Lake City Florida, 32025
Cell: (386) 867 - 1191
Email: ternaruffo@gmail.com

PRINTED DATE:
Wednesday, July 7, 2021

DRAWN BY: Teresa M. Ruffo CHECKED BY:

BUILDING CONTRACTOR


FINAL DATE:

JOB NUMBER:

DRAWING NUMBER


A-5

OF 8 SHEETS

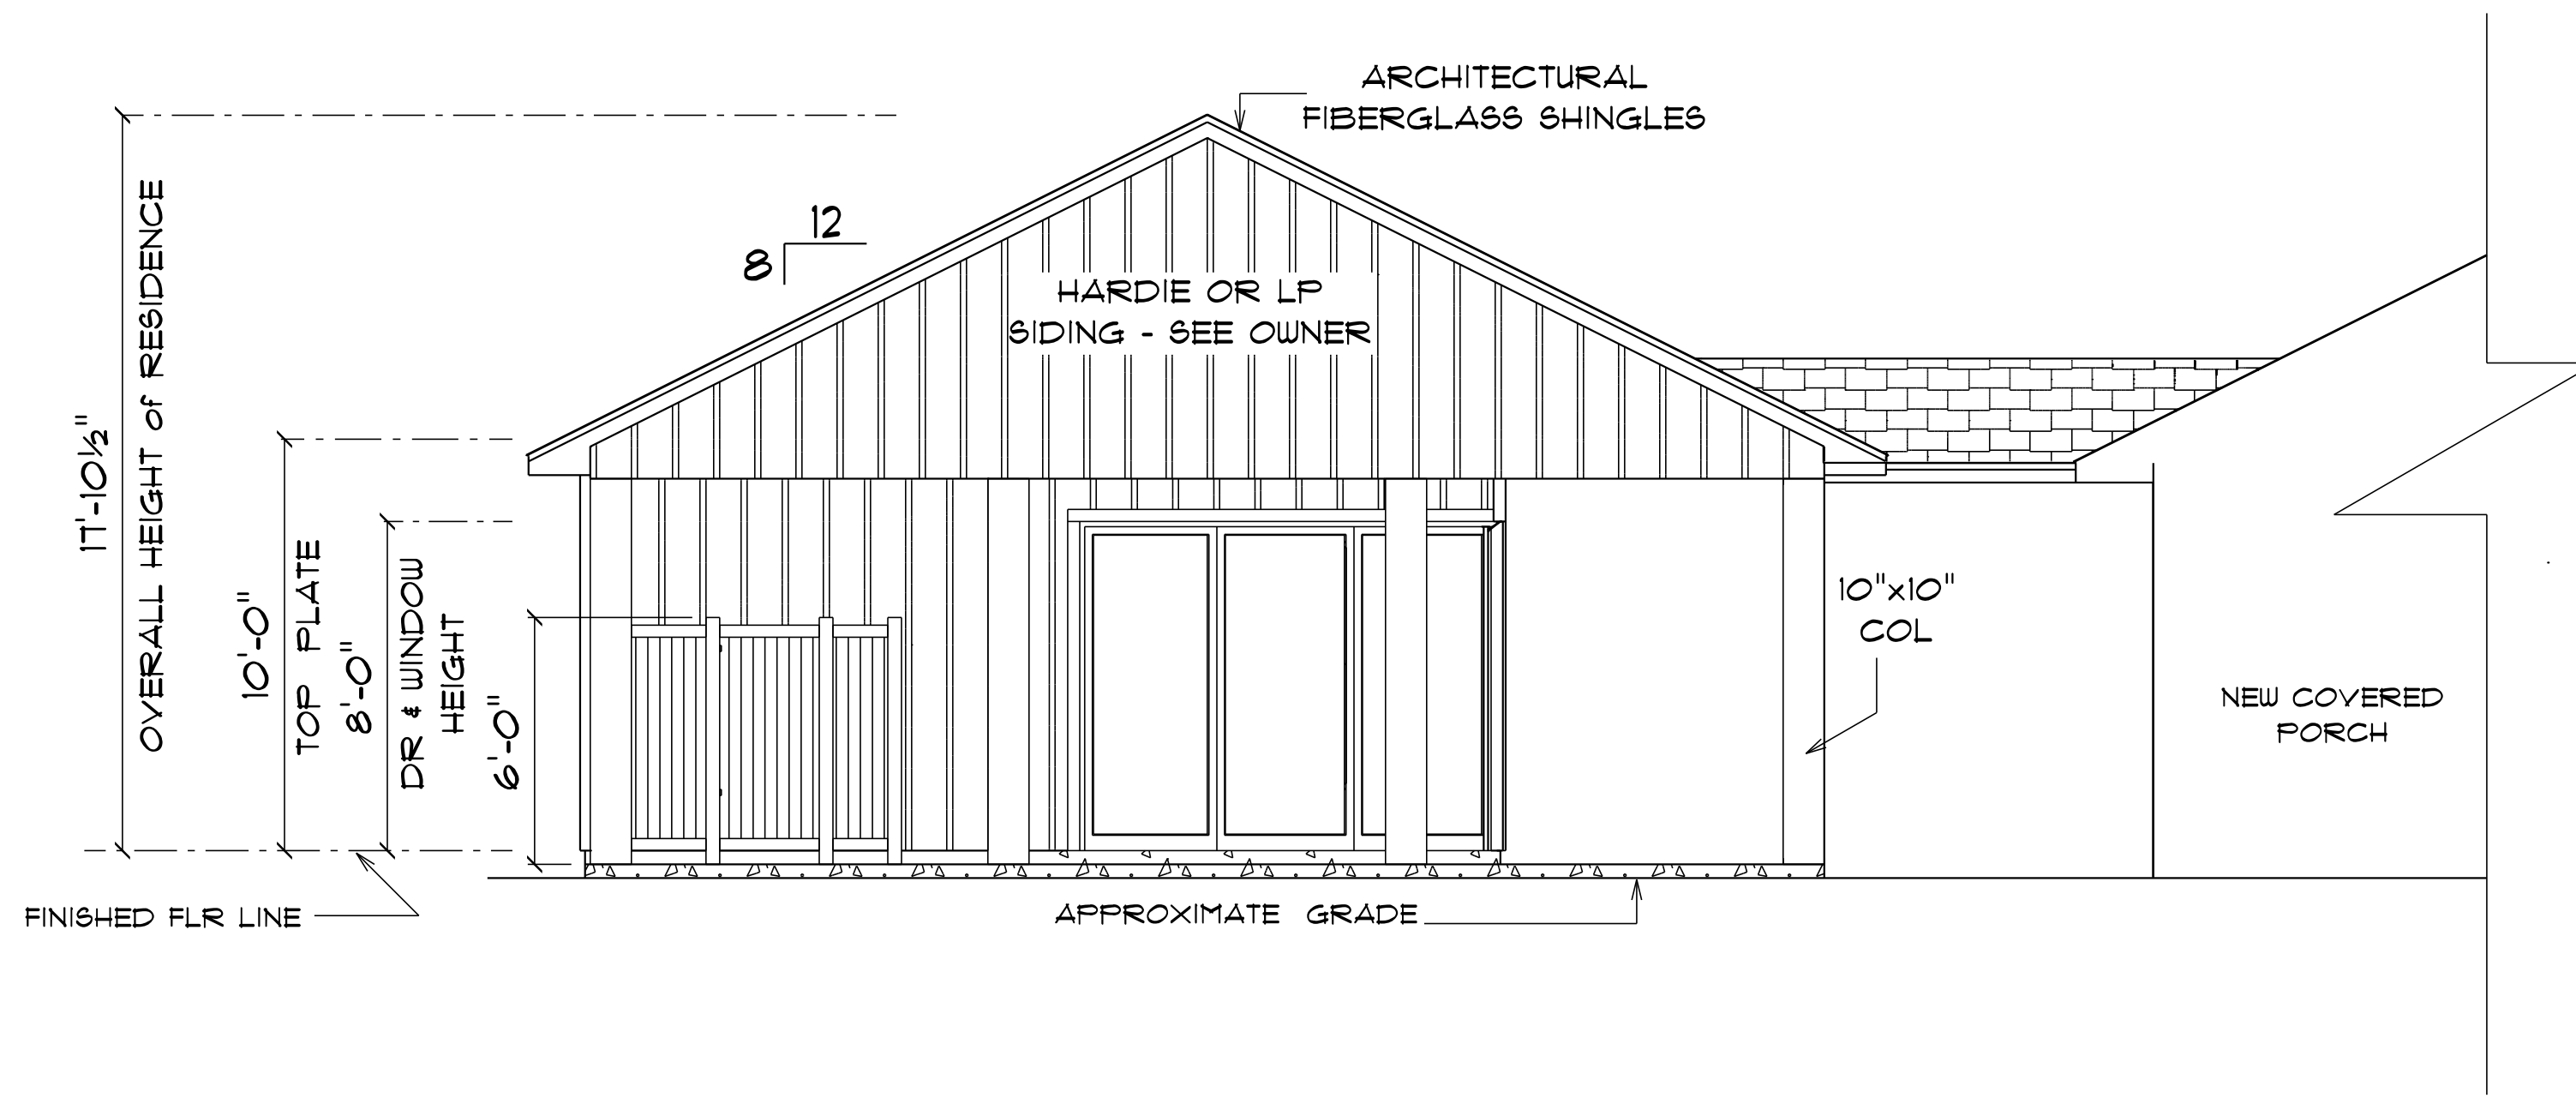


*** POOL HOUSE ***
*** FRONT ELEVATION ***

SCALE : 1/4" = 1'-0"

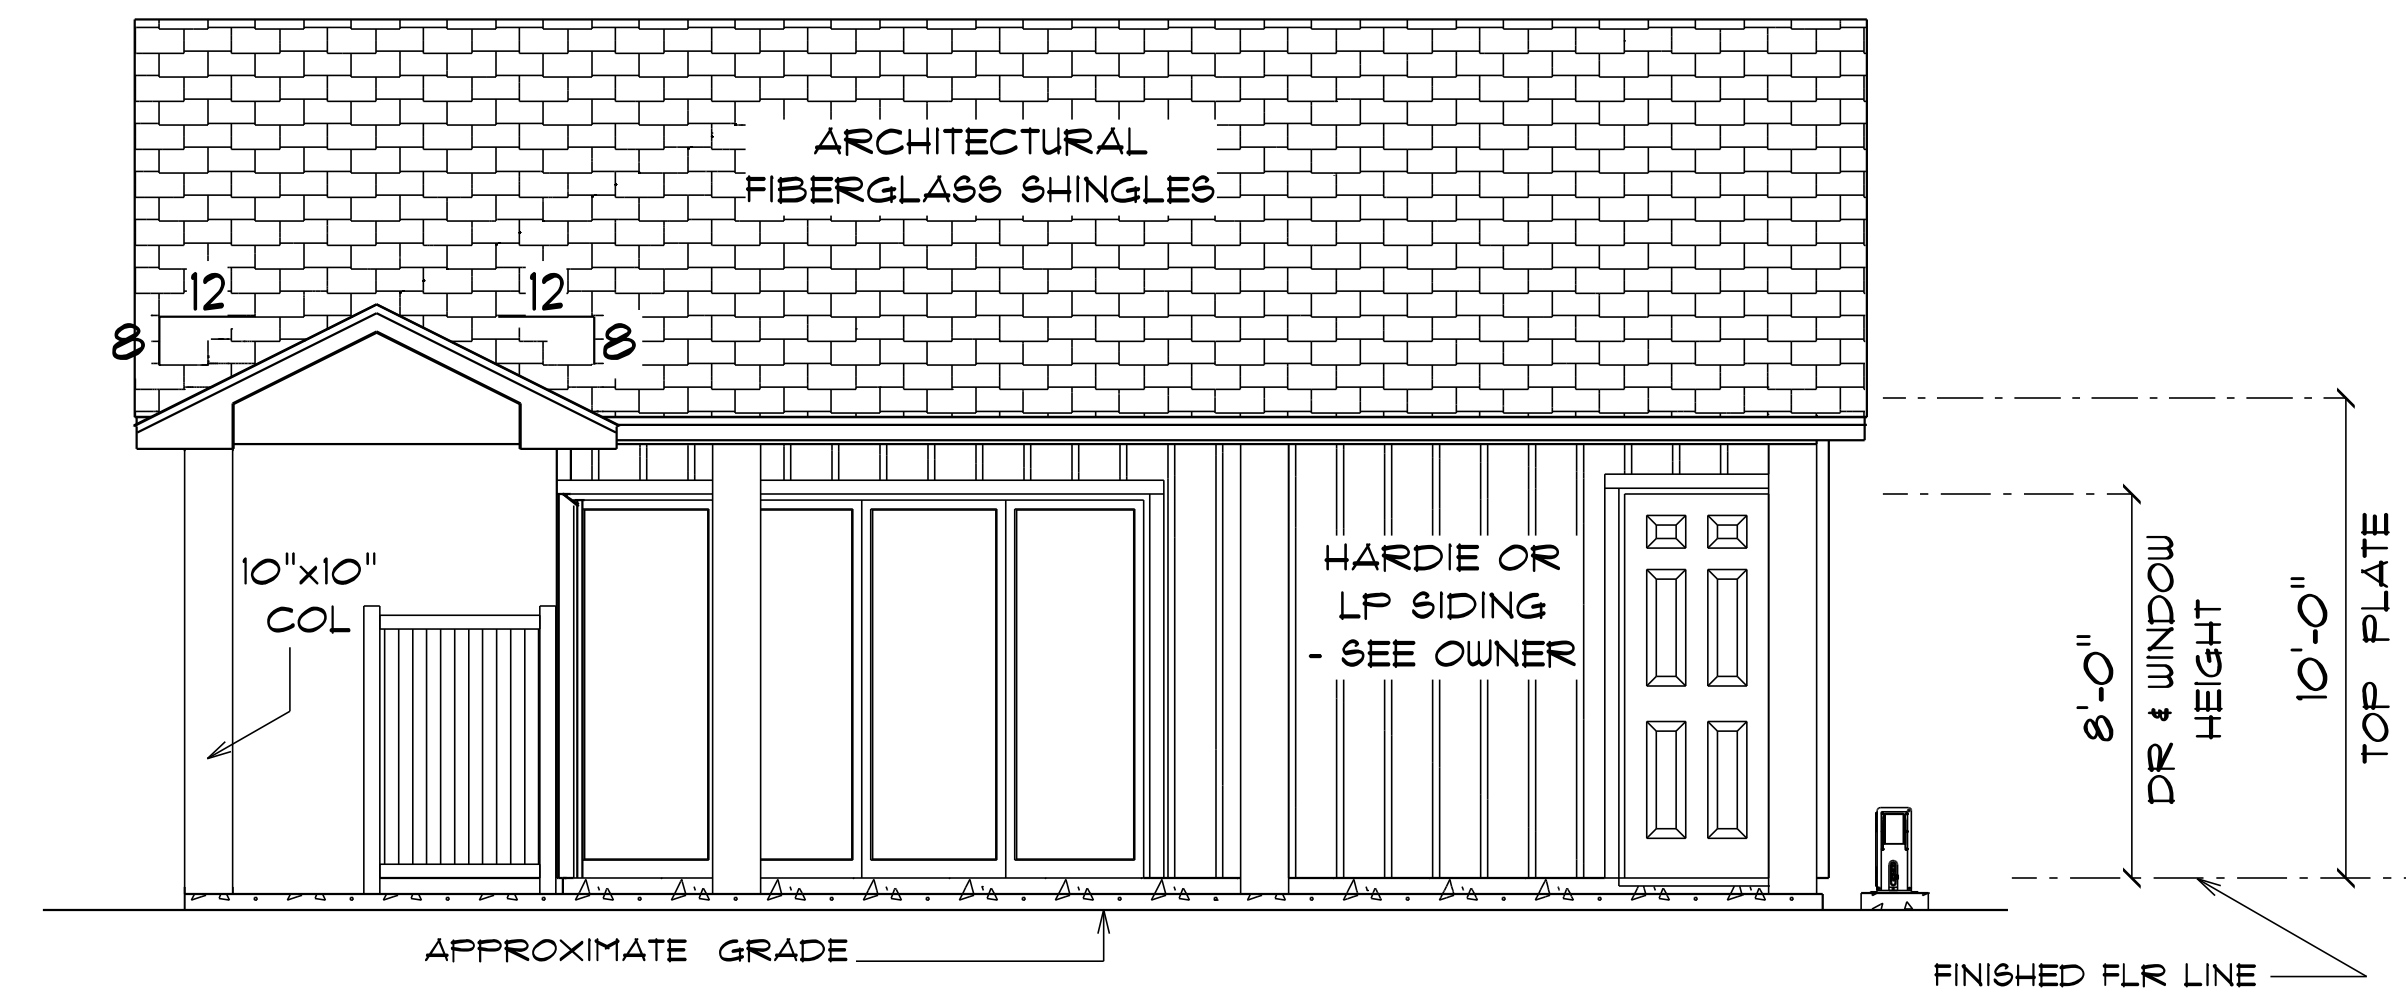


*** POOL HOUSE ***
*** RIGHT ELEVATION ***

SCALE : 1/4" = 1'-0"

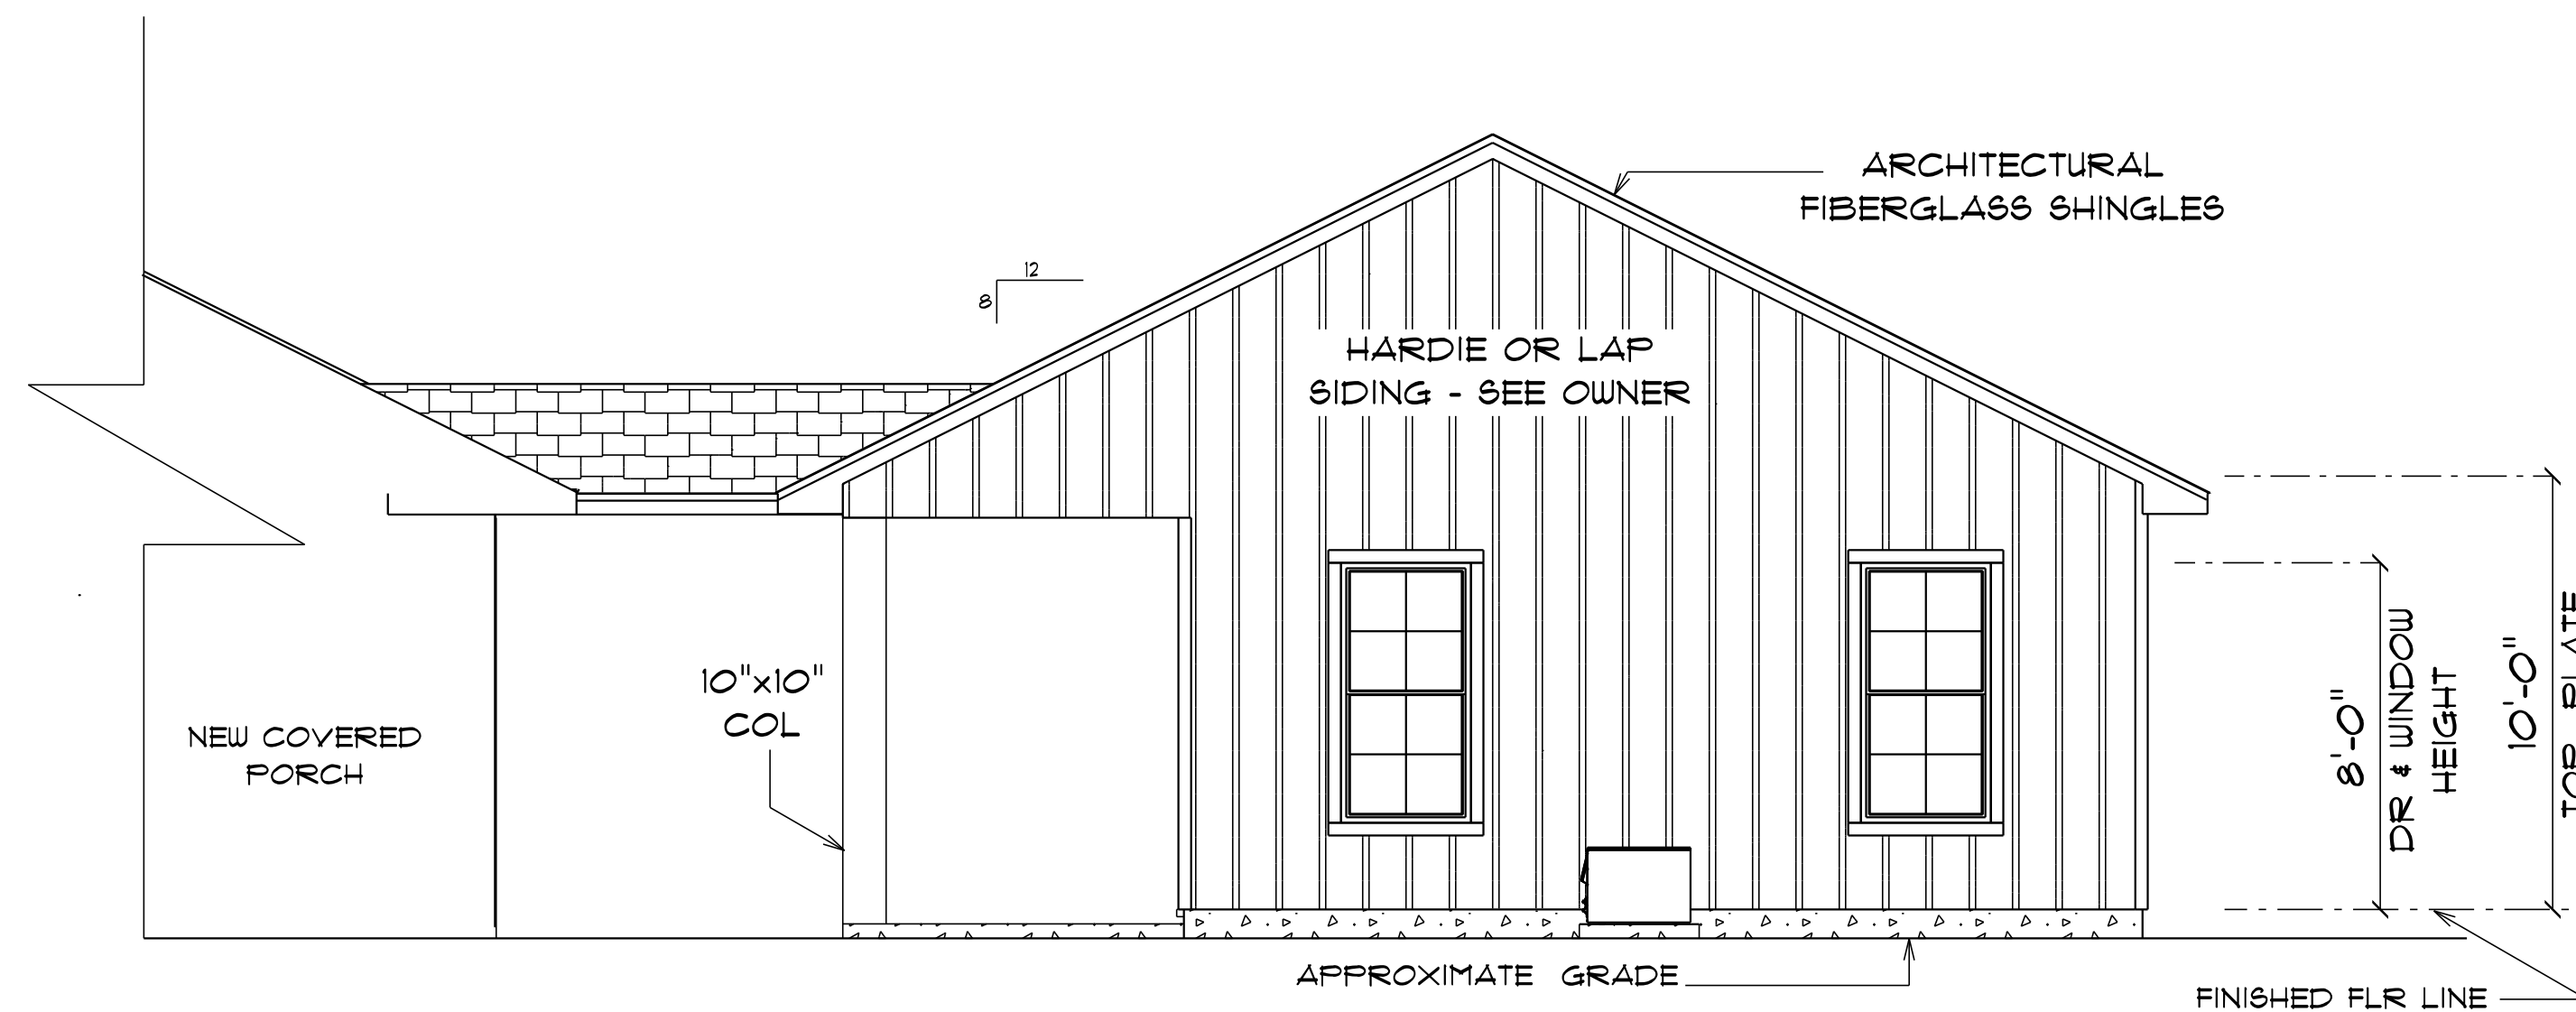

*** POOL HOUSE ***
*** REAR ELEVATION ***

SCALE : 1/4" = 1'-0"

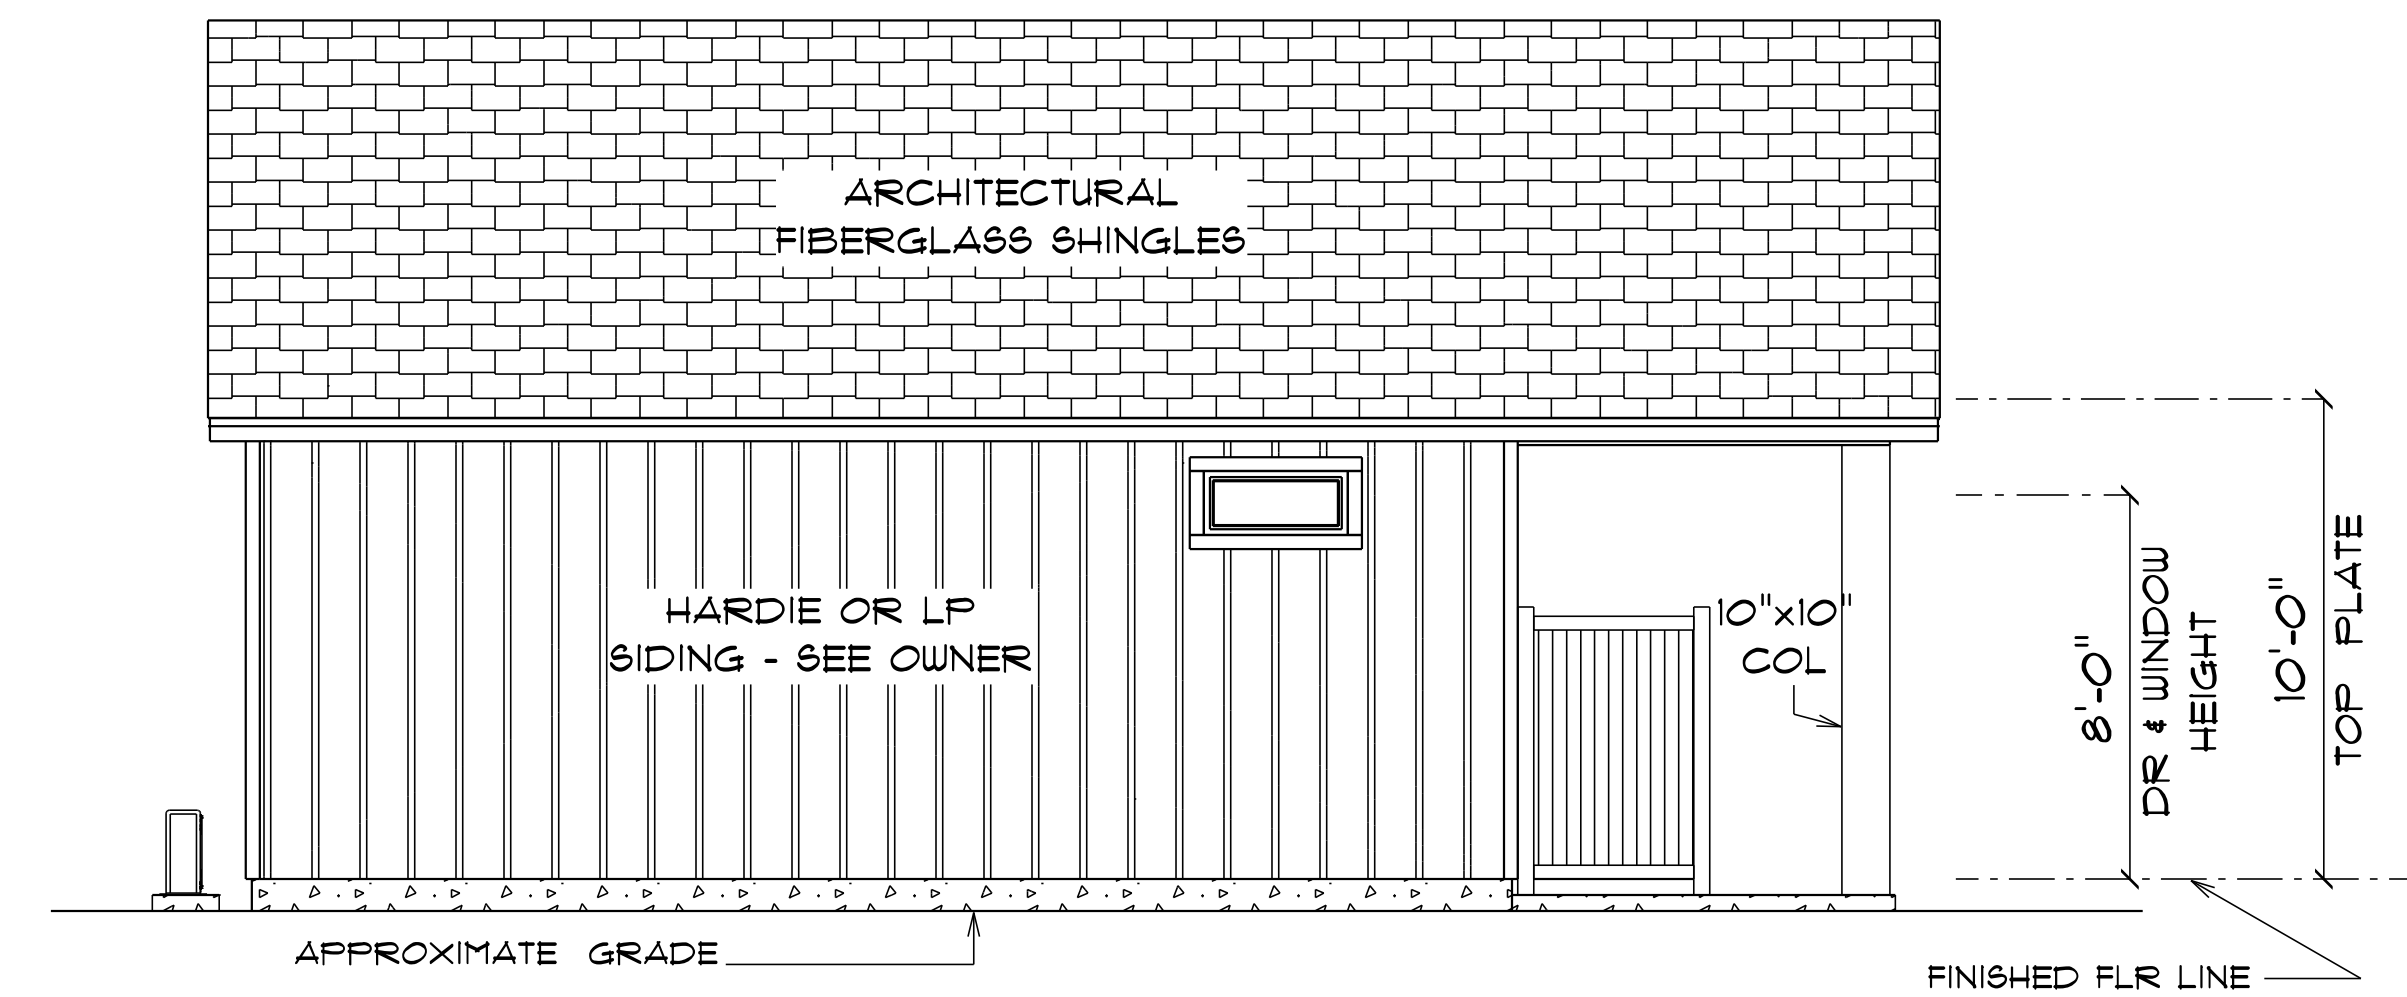

*** POOL HOUSE ***
*** LEFT ELEVATION ***

SCALE : 1/4" = 1'-0"

PATTY & CHRIS
HETRICK

3891 SW PINEMOUNT RD
LAKE CITY, FLORIDA

Teena M. Ruffo
2925 SW SR 47
Lake City Florida, 32025
Cell: (386) 867-1191
Email: teenaruffo@gmail.com

PRINTED DATE:
Wednesday, July 7, 2021

DRAWN BY: Teena M. Ruffo

CHECKED BY:

BUILDING CONTRACTOR


FINAL DATE:

JOB NUMBER:

DRAWING NUMBER

A-6

OF 8 SHEETS

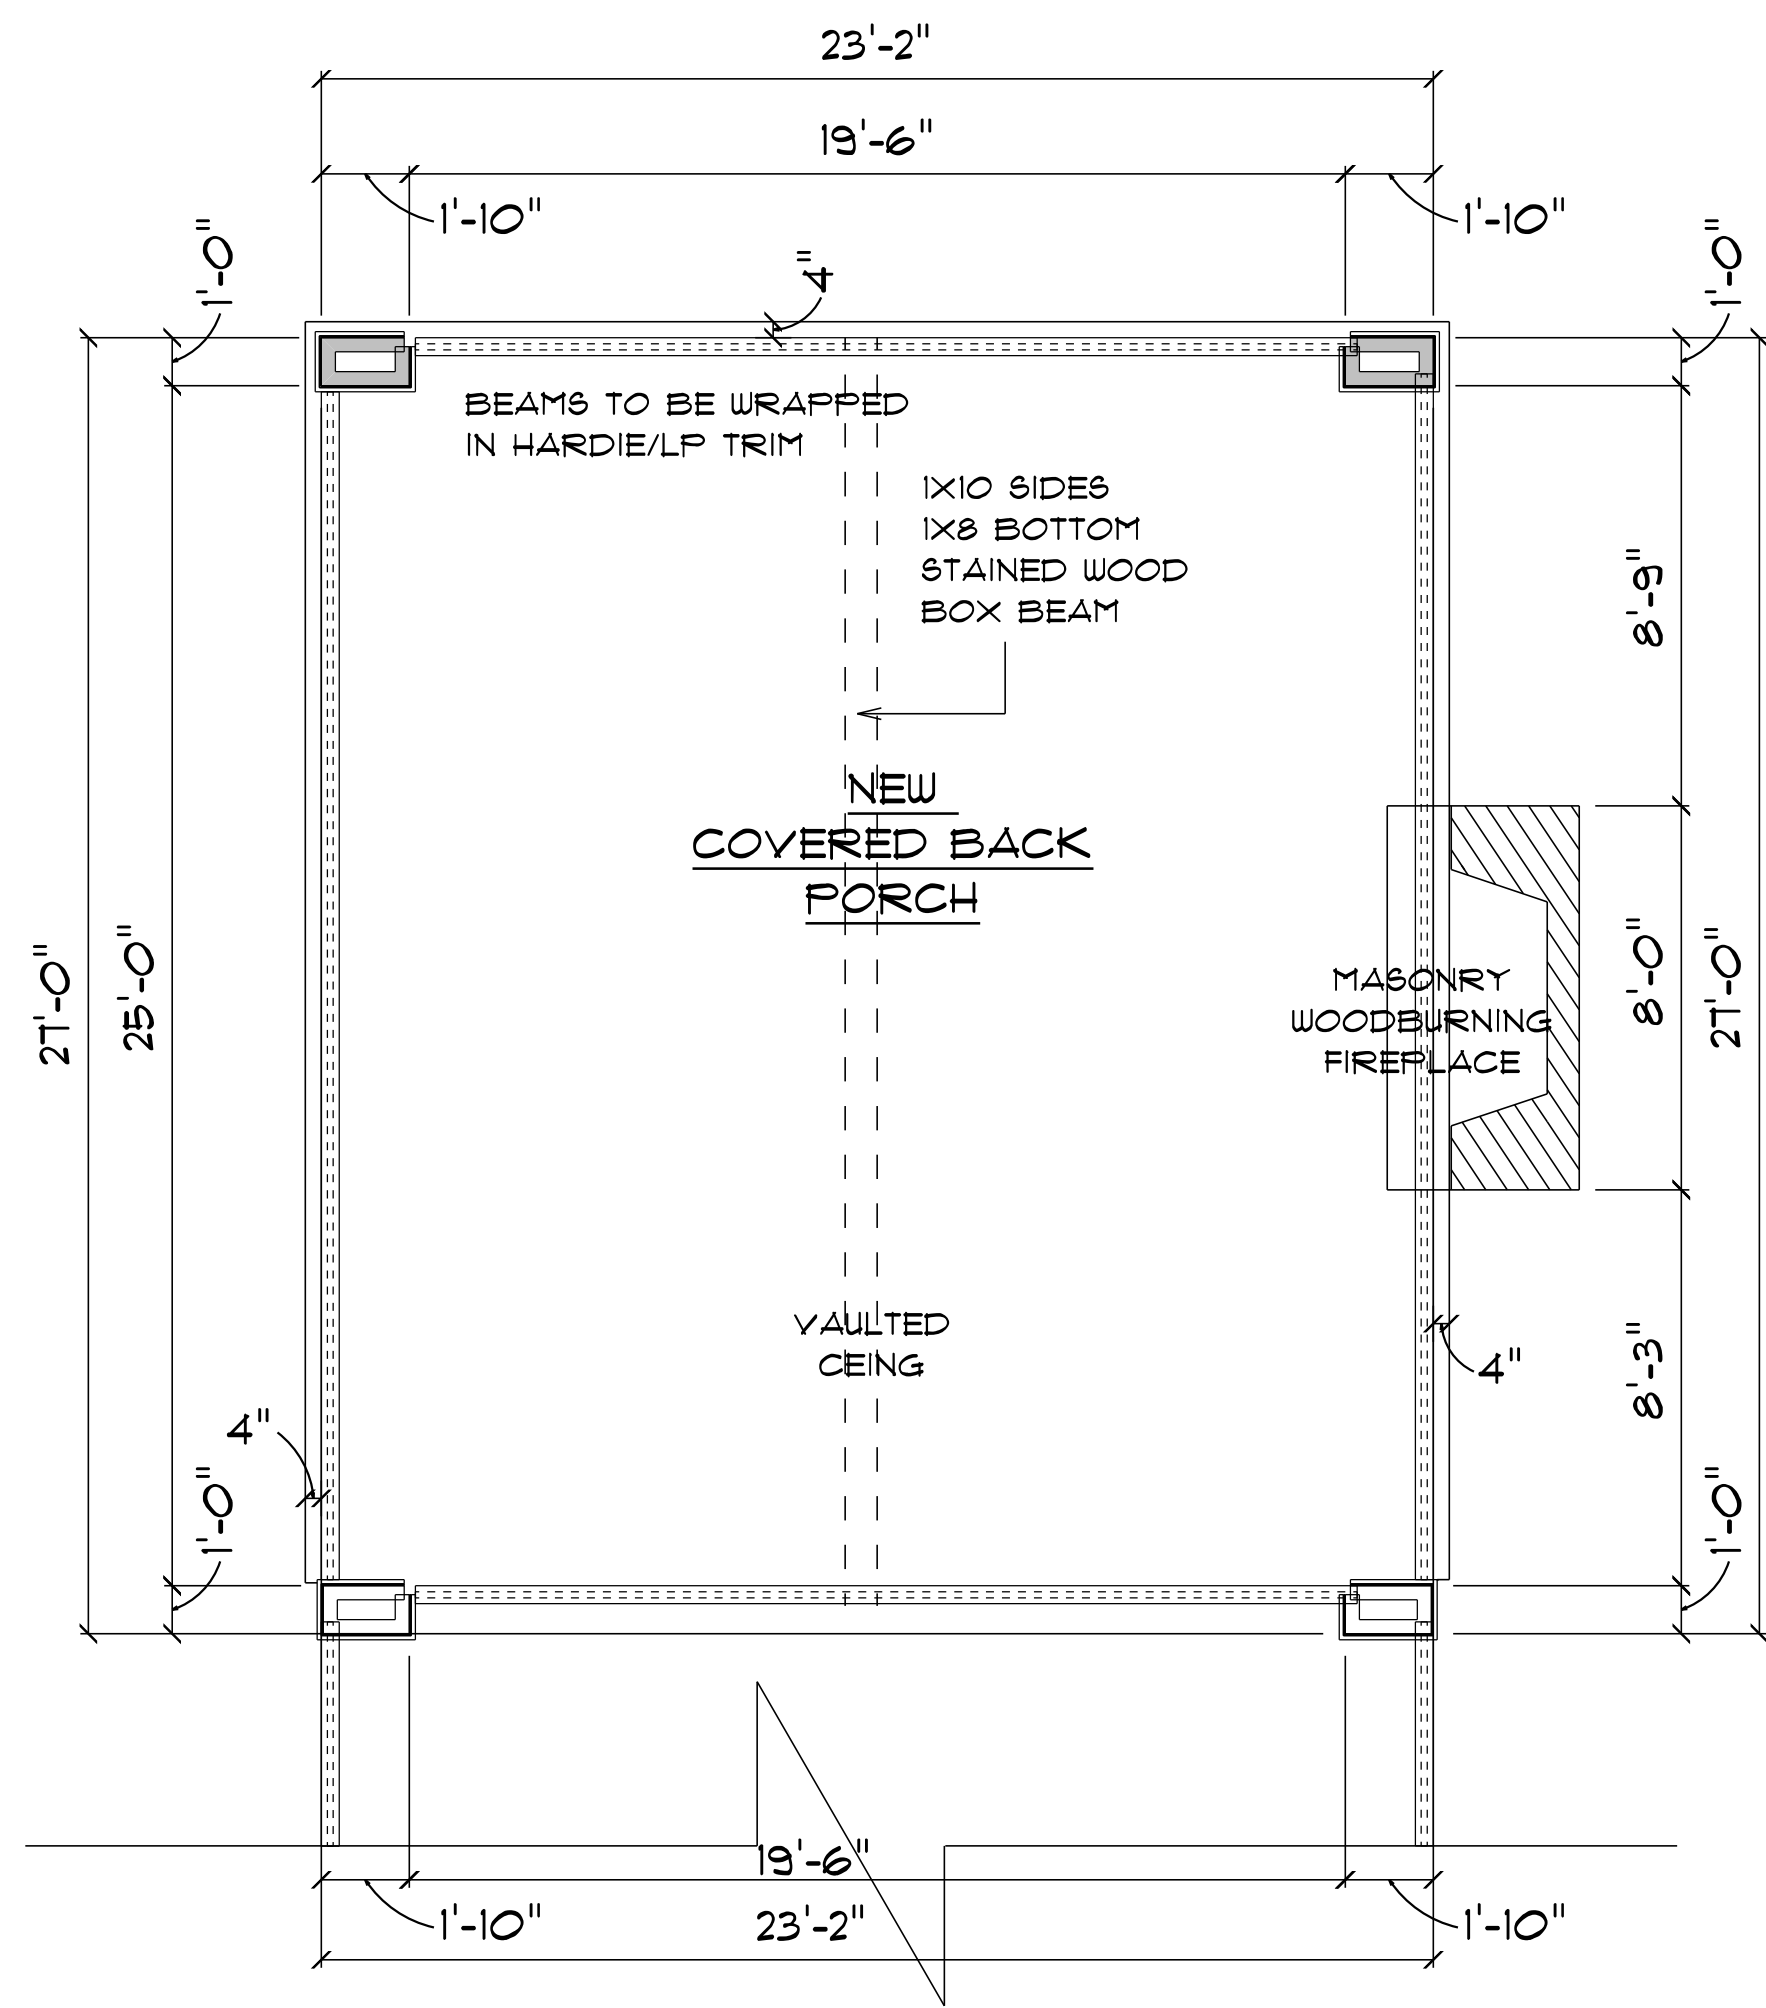

* COVERED PORCH *

* FLOOR PLAN *

SCALE : 1/4" = 1'-0"

NEW COVERED BACK PORCH = 611 S.F.


IMPORTANT NOTES:

1. IT IS THE BUILDER'S RESPONSIBILITY TO VERIFY ALL GEOMETRY AND DIMENSIONS BEFORE ORDERING ANY MATERIALS OR BEGINNING CONSTRUCTION.
2. THESE PLANS ARE FOR LAYOUT AND DESIGN PURPOSES ONLY ALL STRUCTURAL NOTES AND DETAILS TO BE PROVIDED BY AN ENGINEER.

ELECTRICAL LEGEND		
ELECTRICAL	COUNT	SYMBOL
ceiling fan globe 01	2	
pot light	8	
outlet wp	4	
switch	3	

ELECTRICAL PLAN NOTES

- E-1 WIRE ALL APPLIANCES, HVAC UNITS AND OTHER EQUIPMENT PER MANUFACTURER'S SPECIFICATIONS.
- E-2 ALL INSTALLATIONS SHALL BE PER NATIONAL ELECTRIC CODE.
- E-3 ALL SMOKE /CARBON MONOXIDE DETECTORS SHALL BE 120V W/BATTERY BACKUP OF THE PHOTOELECTRIC TYPE, AND SHALL BE INTERLOCKED TOGETHER. INSTALL INSIDE AND NEAR ALL BEDROOMS AS PER CODE.
- E-4 TELEPHONE, TELEVISION AND OTHER LOW VOLTAGE DEVICES OR OUTLETS SHALL BE AS PER THE OWNER'S DIRECTION AND IN ACCORDANCE WITH APPLICABLE SECTIONS OF NATIONAL ELCT. CODE LATEST EDITION.
- E-5 ELECTRICAL CONTRACTOR SHALL BE RESPONSIBLE FOR THE DESIGN AND SIZING OF ELECTRICAL SERVICE AND CIRCUITS.
- E-6 ENTRY OF SERVICE UNDERGROUND OR OVERHEAD) IS TO BE DETERMINED BY THE POWER COMPANY.
- E-7 ALL BEDROOM RECEPTALS ARE TO BE AFCI (ARC FAULT CIRCUIT INTERRUPT)
- E-8 75% OF ALL PERMANENT LIGHTS TO BE ENERGY EFFICIENT.

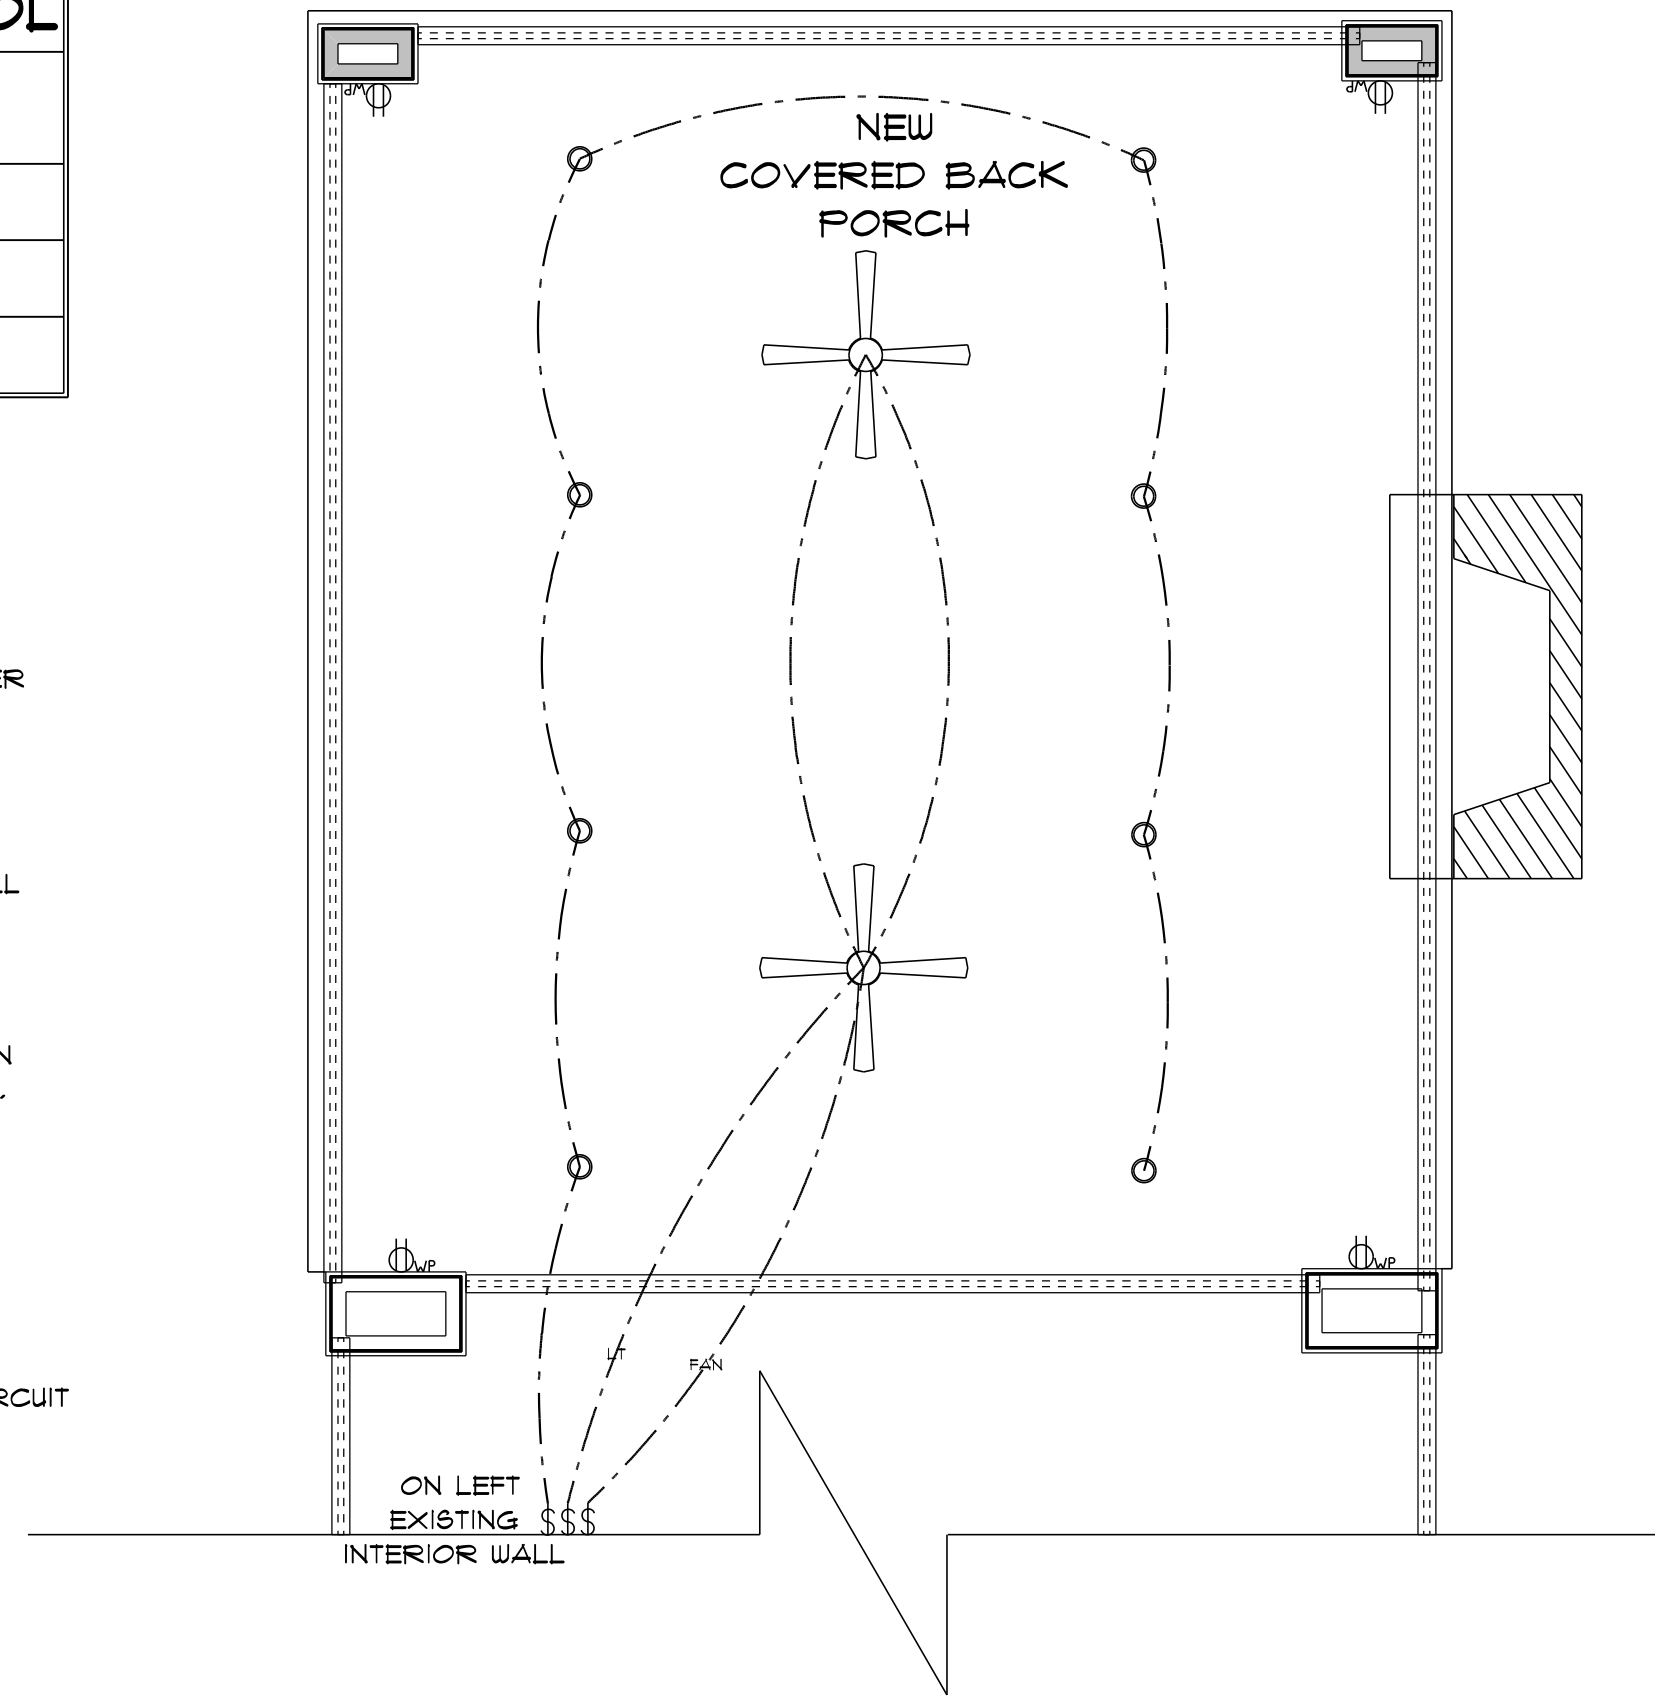

* COVERED PORCH *

* ELECTRIC PLAN *

SCALE : 1/4" = 1'-0"

PATTY & CHRIS
HETRICK

3891 SW PINEMOUNT RD
LAKE CITY, FLORIDA

Teena M. Ruffo
2925 SW SR 47
Lake City Florida, 32025
Cell: (386) 867-1191
Email: teenaruffo@gmail.com

PRINTED DATE:
Wednesday, July 7, 2021

DRAWN BY: Teena M. Ruffo


CHECKED BY:

BUILDING CONTRACTOR


FINAL DATE:

JOB NUMBER:


DRAWING NUMBER

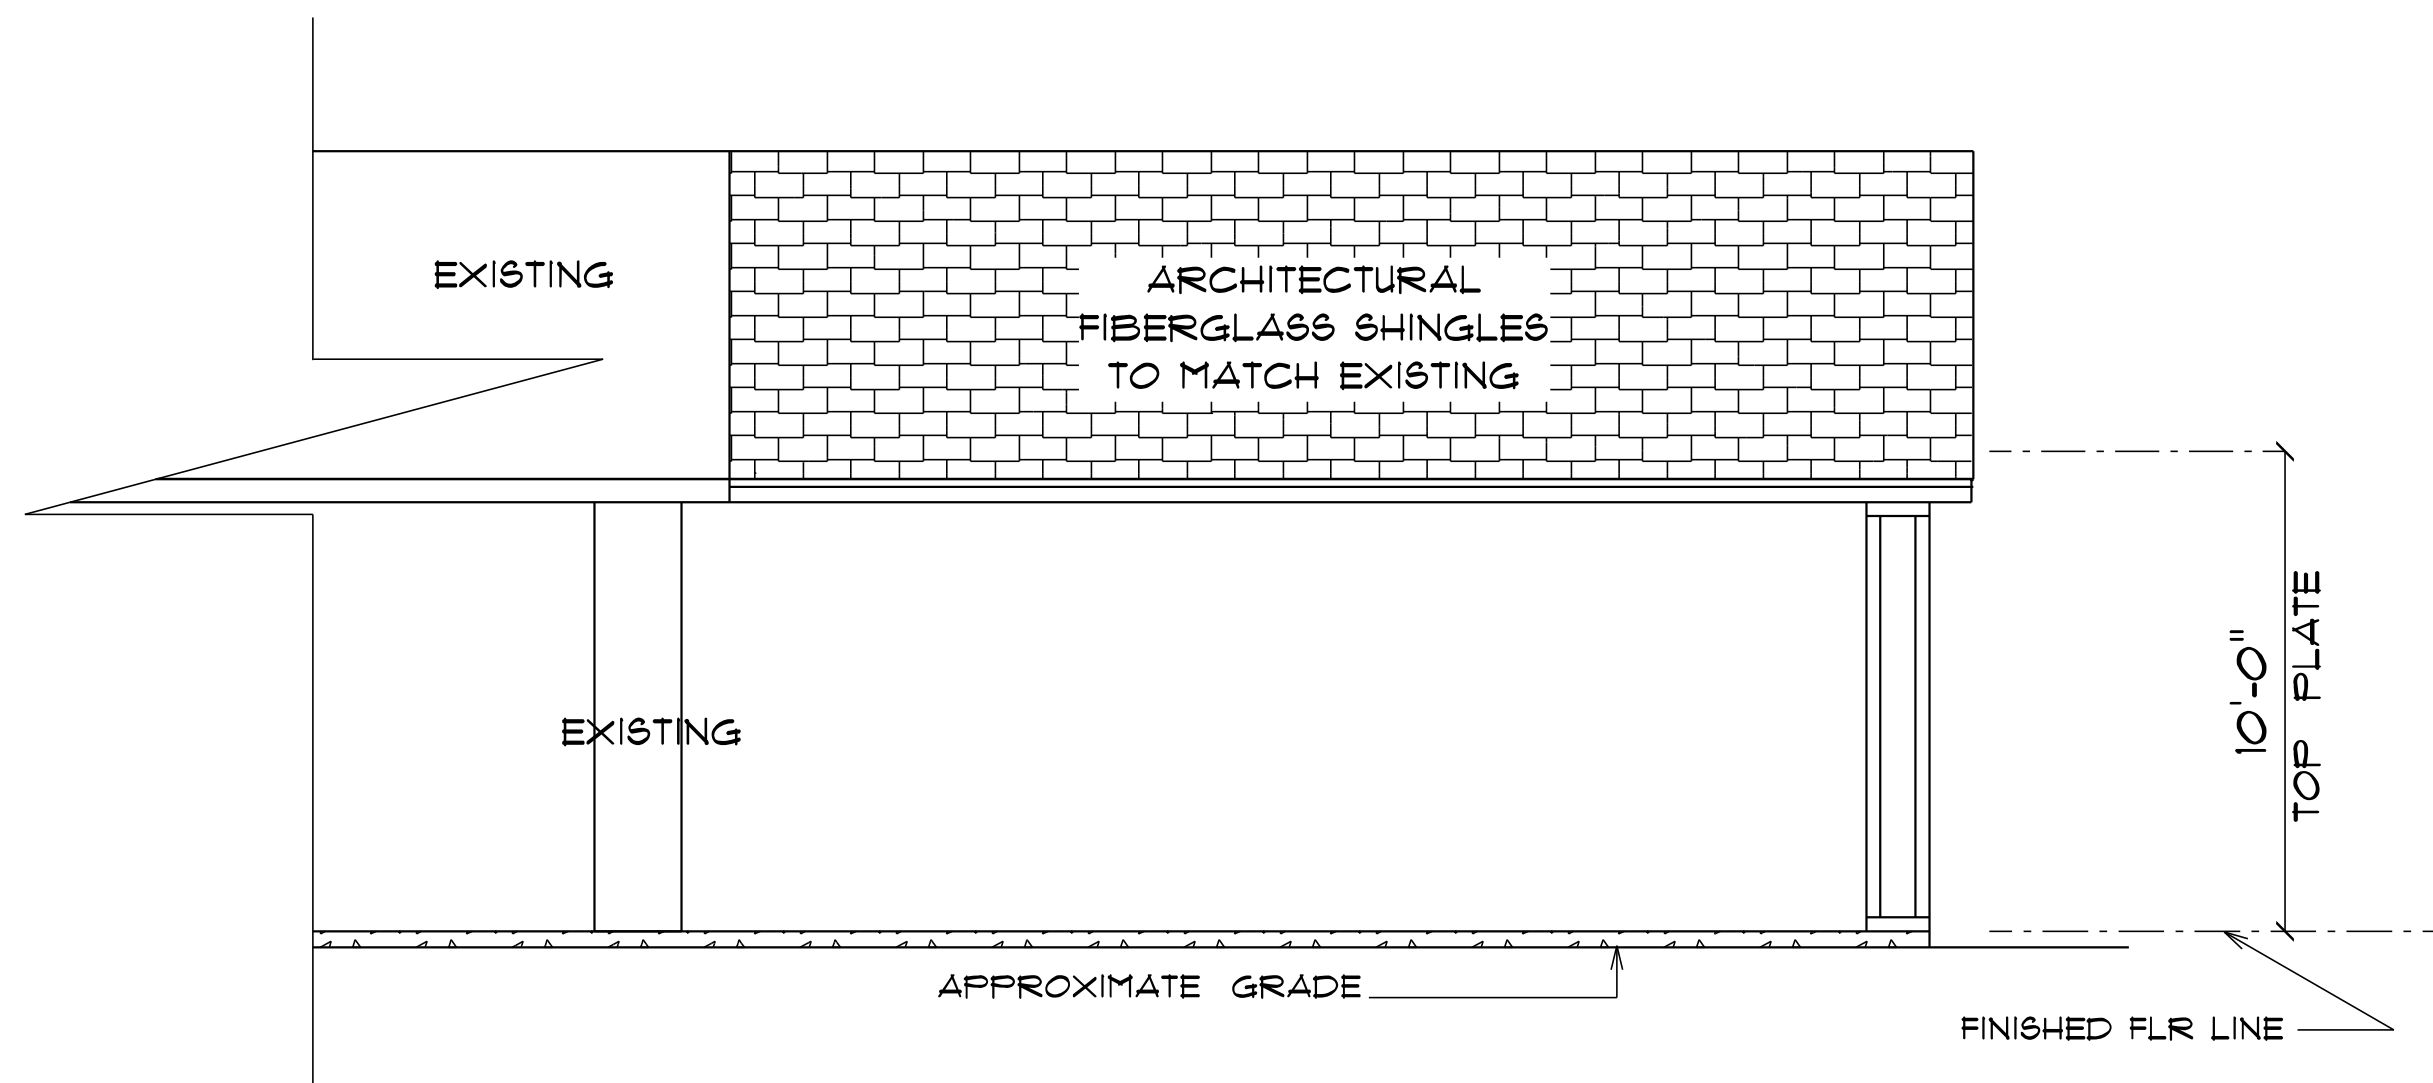

*** COVERED
PORCH ***
*** RIGHT ELEVATION ***
SCALE : 1/4" = 1'-0"

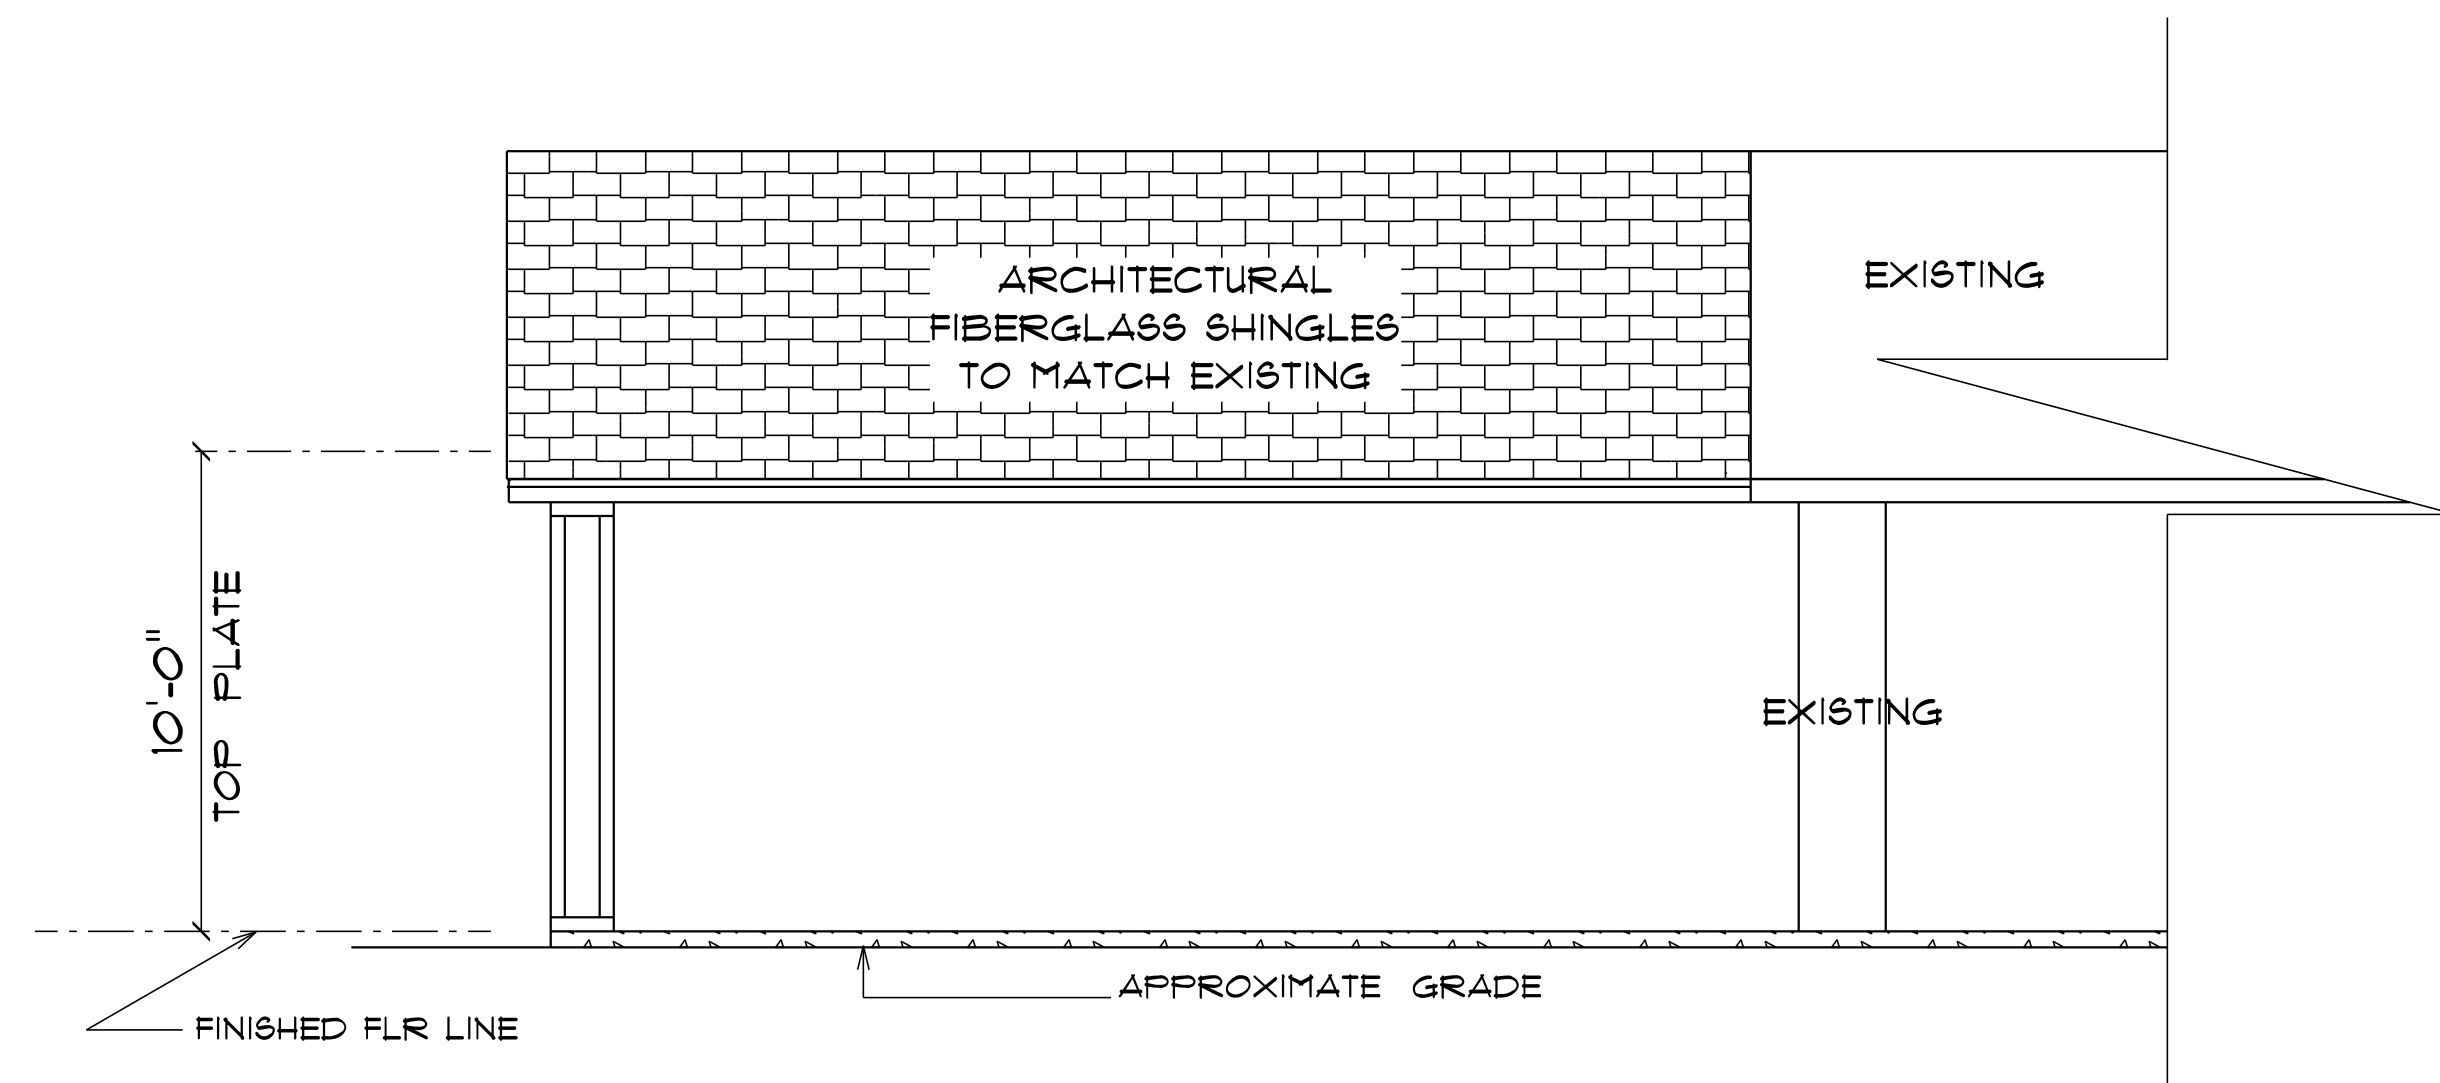

*** COVERED
PORCH ***
*** LEFT ELEVATION ***
SCALE : 1/4" = 1'-0"

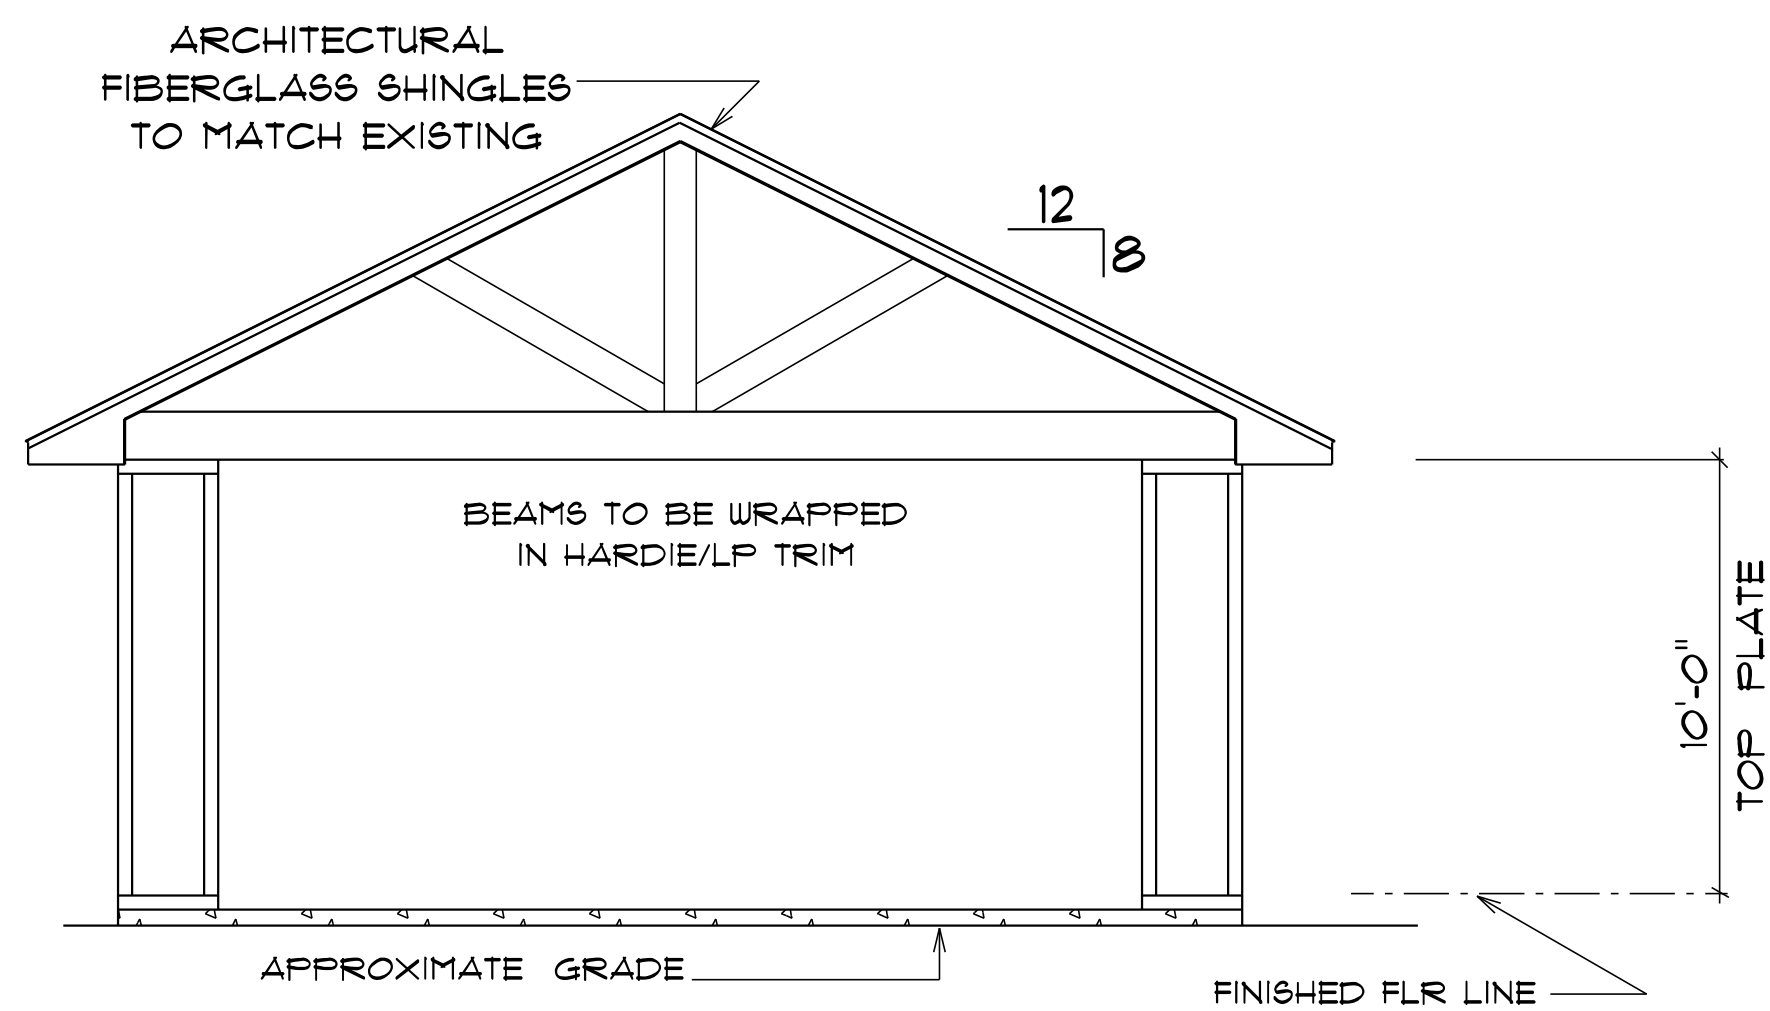

*** COVERED
REAR ***
*** LEFT ELEVATION ***
SCALE : 1/4" = 1'-0"

**PATTY & CHRIS
HETRICK**

3891 SW PINEMOUNT RD
LAKE CITY, FLORIDA

Teena M. Ruffo
2925 SW SR 47
Lake City Florida, 32025
Cell: (386) 861-1191
Email: teenaruffo@gmail.com

PRINTED DATE:
Wednesday, July 7, 2021

DRAWN BY: Teena M. Ruffo CHECKED BY:

BUILDING CONTRACTOR

FINAL \$ DATE:

JOB NUMBER:

DRAWING NUMBER

A-8

OF 8 SHEETS