



ELECTRICAL
FLOOR PLAN -
POWER

DRAWN BNH
CHECKED MTR
DATE 02/07/12
CAD 3702060/CD


REVISIONS

FILE NO. 3702.060
S H E E T


E1.10

Bid Documents

M&A Project No. 11238
Moses & Associates, Inc. Consulting Engineers
2209 NW 40th Terrace, Ste A Gainesville, FL 32605
FL License EB-0003097
352-372-1911
f 352-372-0186
moses-eng.com

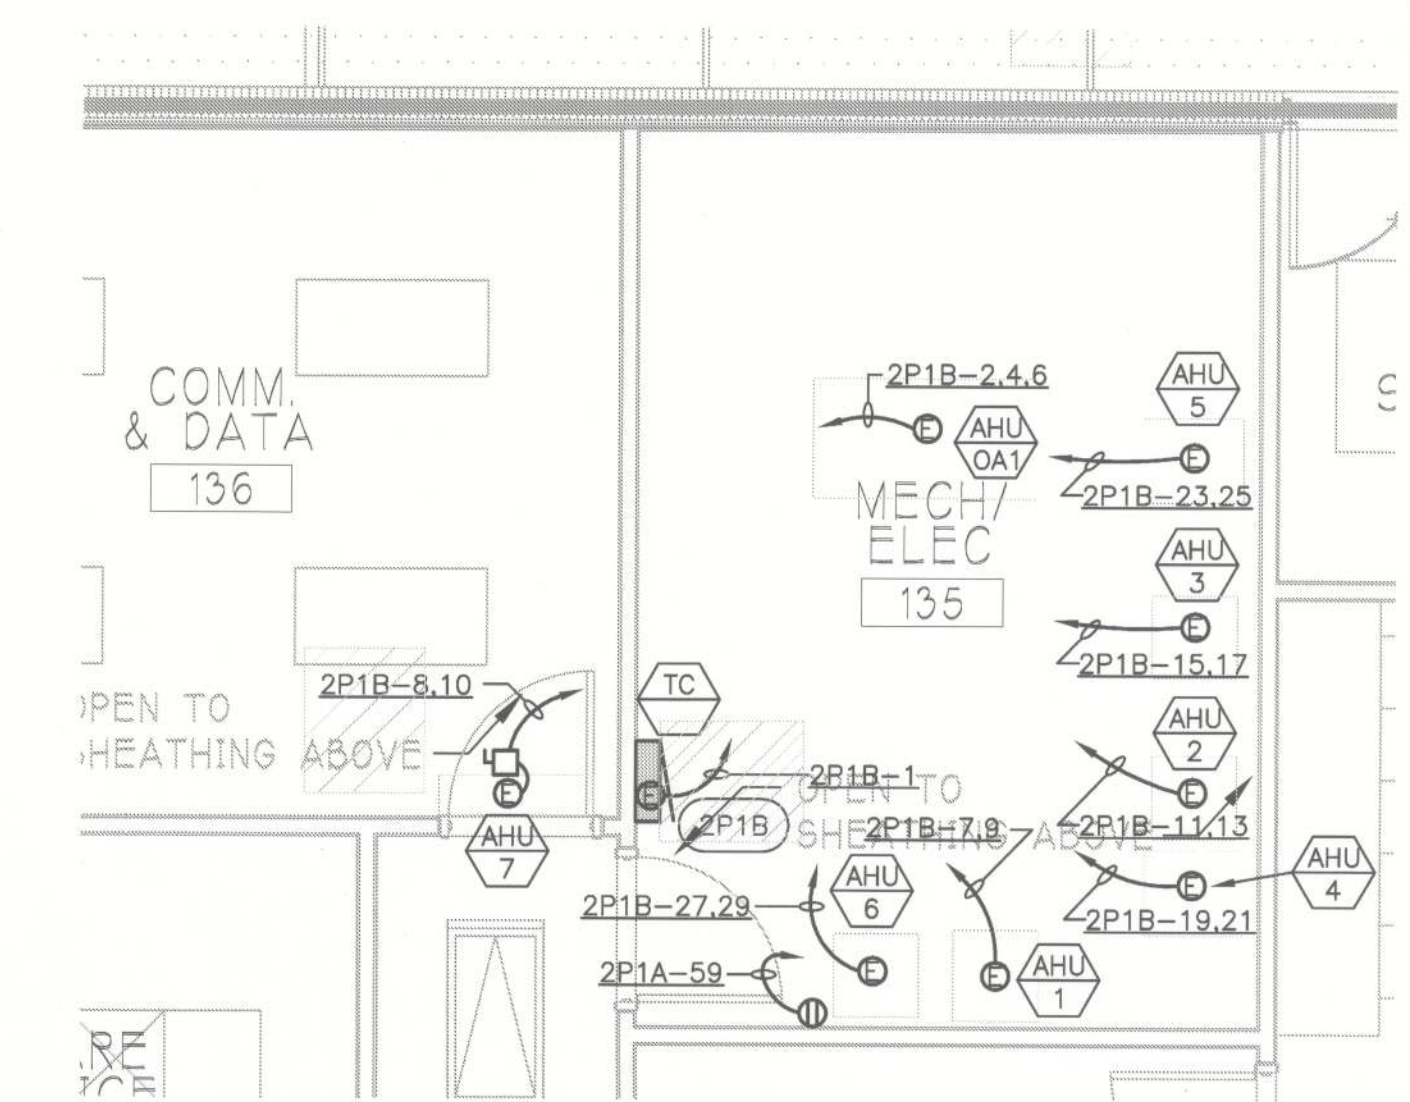

ENLARGED FLOOR PLAN MECH. RM 135
SCALE: 1/4" = 1'-0"

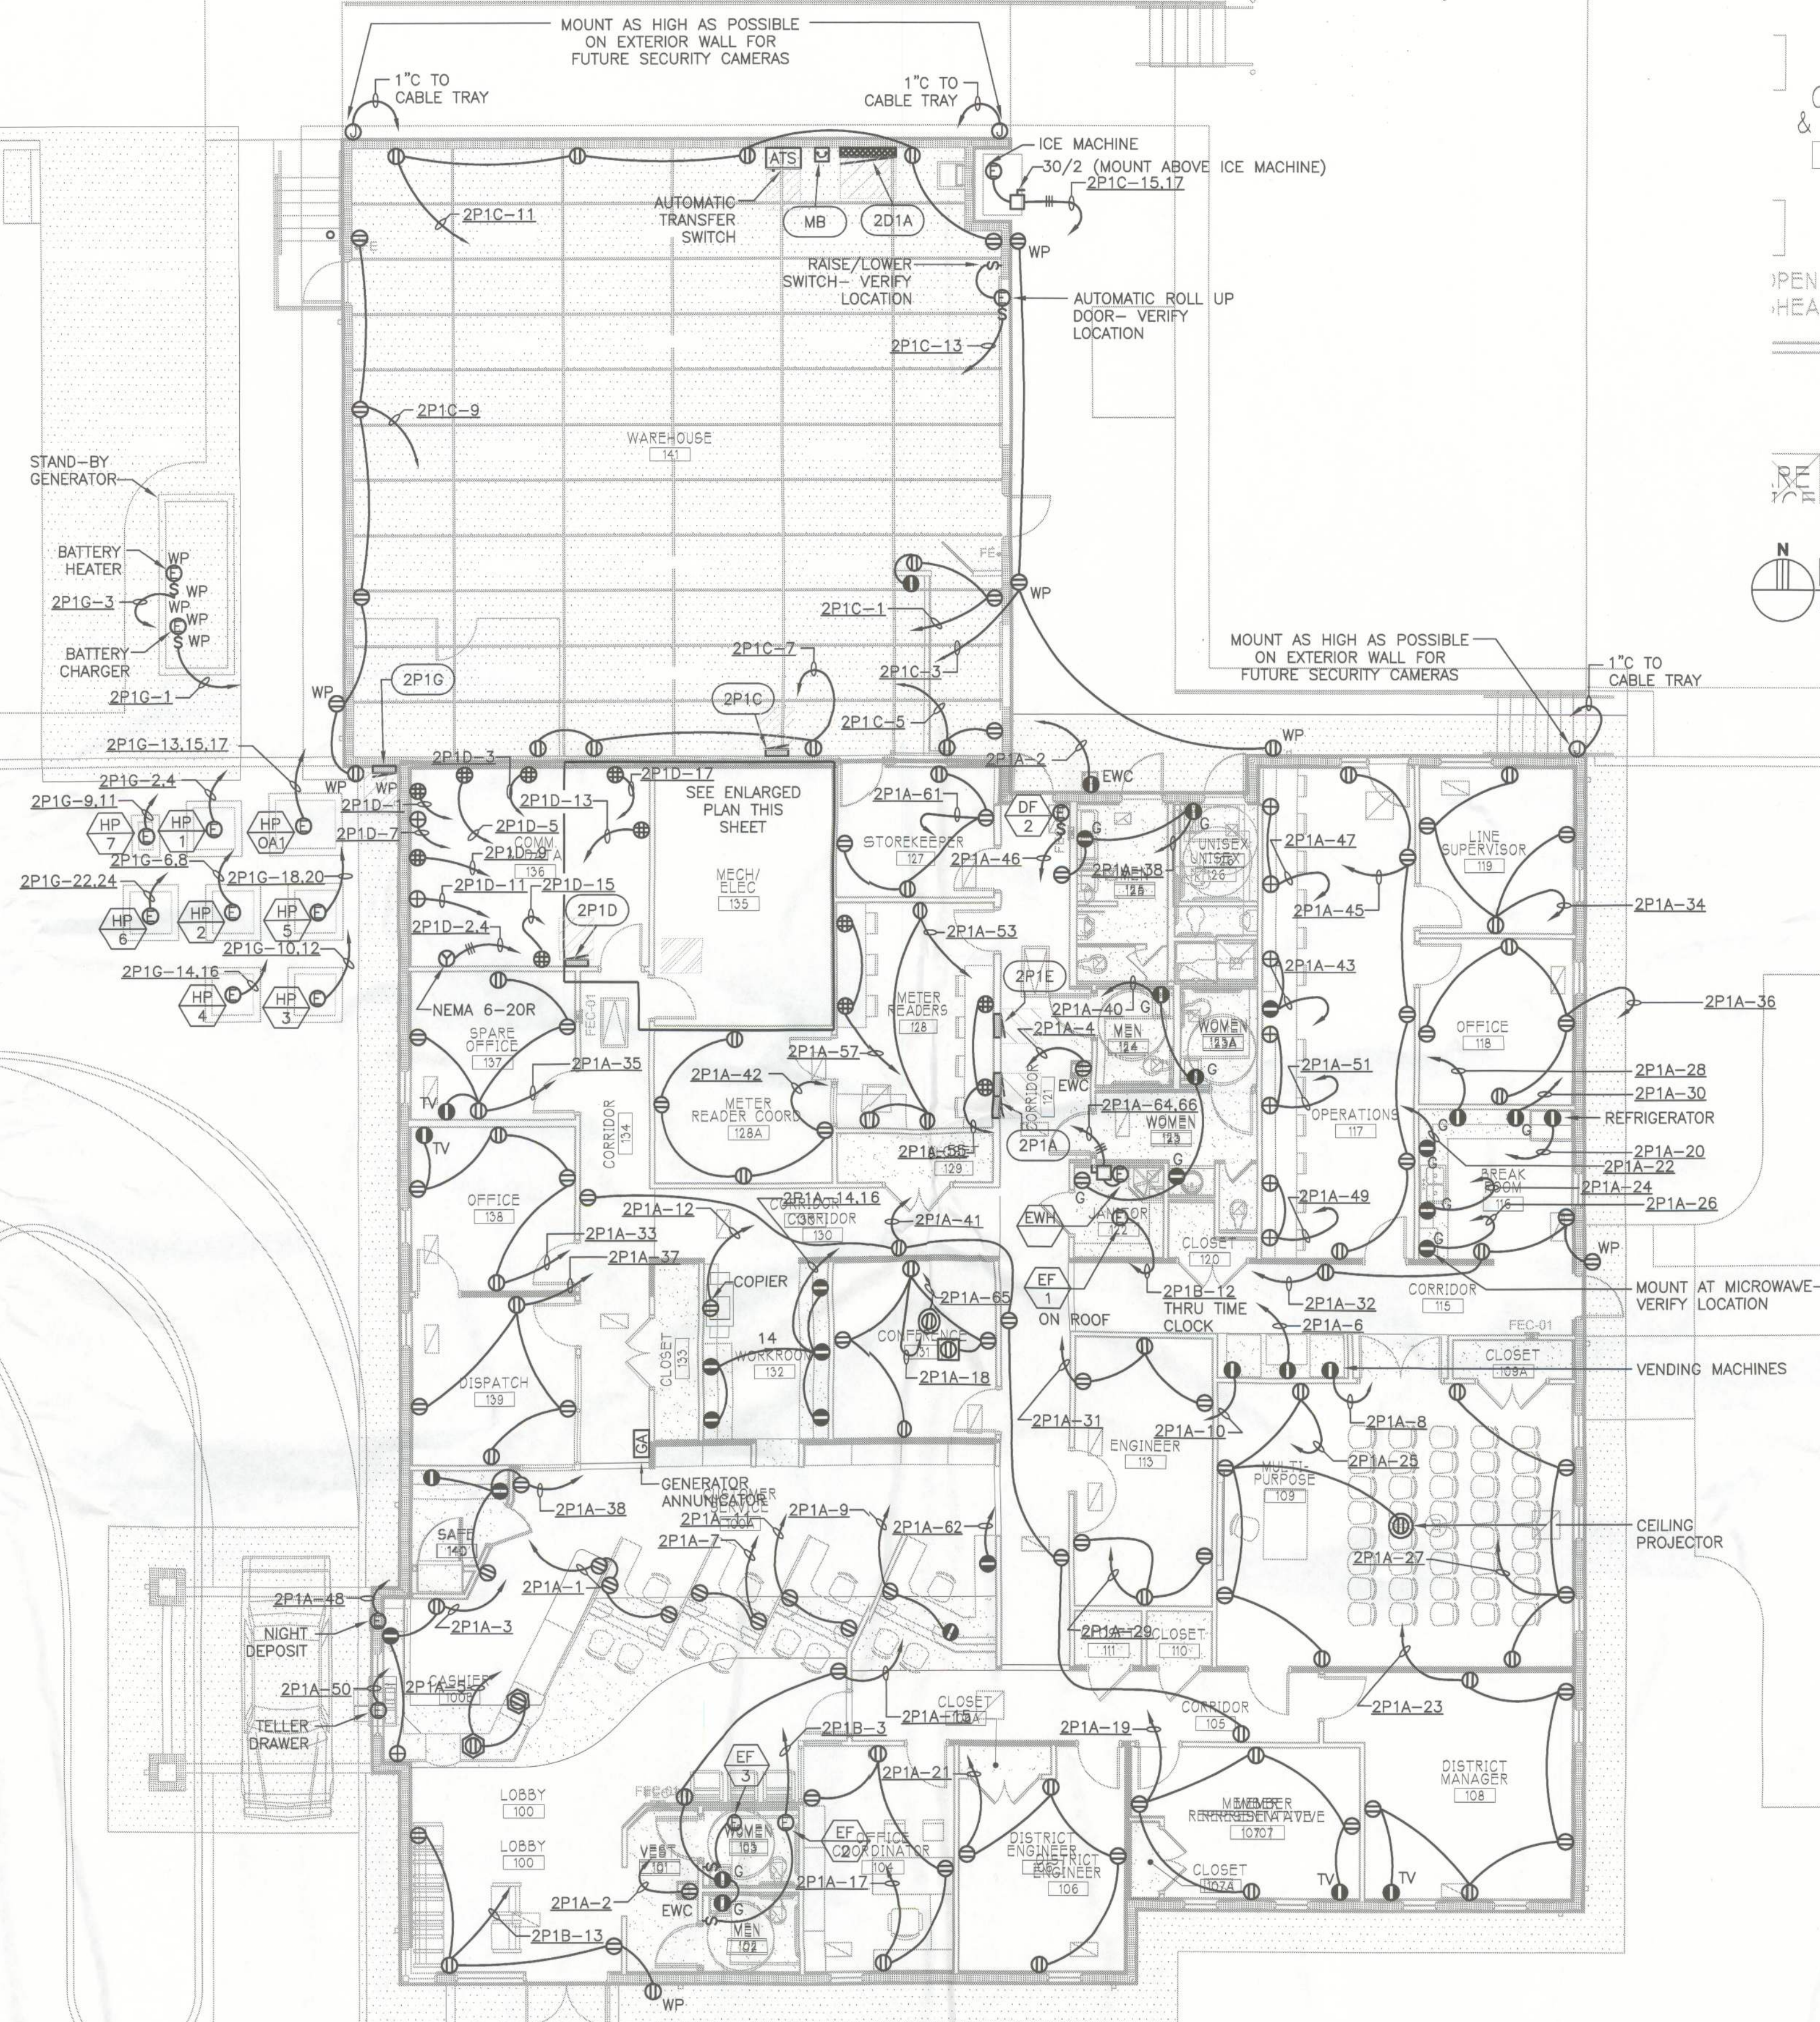

ELECTRICAL FLOOR PLAN - POWER
SCALE: 1/8" = 1'-0"