




Ajax
0365 Hood Road South Suite 203 t +1 904-262-8660
Jacksonville, Fl. 32257 f +1 904-262-8623

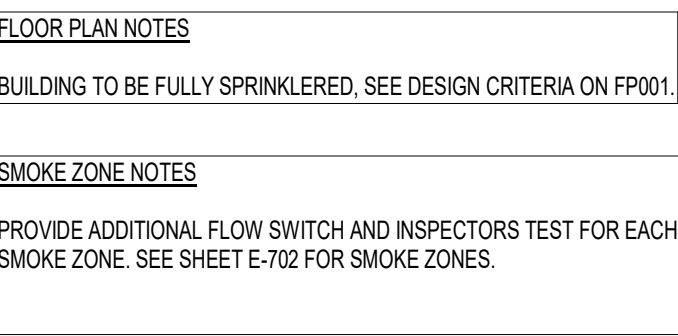


Professional Seals

Christopher J. Floegel, P.E.
State of Florida
Professional Engineer
License No. 84276

This item has been electronically signed and sealed by the individual named above, using a dated Digital Signature in the space below, per F.A.C. Rule 15-23.004. Printed copies of this document are not considered signed and sealed, and the signature must be verified on any electronic copies.

Digitally signed by Christopher Floegel
DN: cn=Christopher Floegel,
ou=H05430000000785A78F28000015C2,
o=DITC ENGINEERING SOLUTIONS, cr=D
Date: 2020.07.22 09:22:18-0500

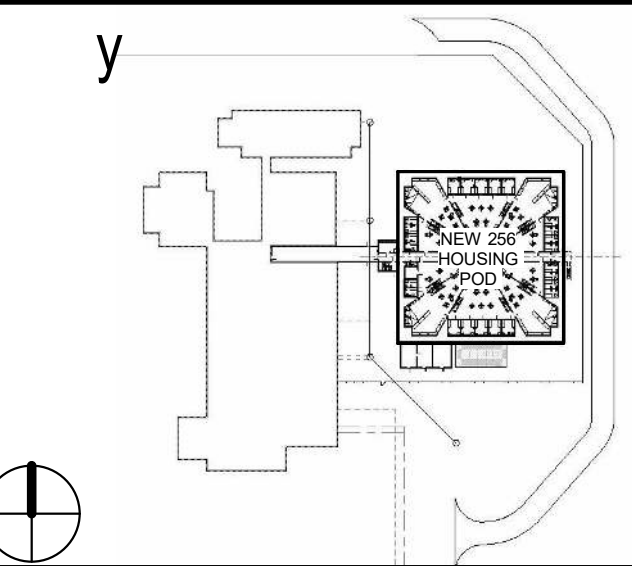

y y y y

SCALE 1/8" = 1'-0"

[illegible]

No.	Description	Date
	ISSUED FOR PERMIT	7-24-20

REVISIONS

DRAWN BY	D PETERSON
APPROVED BY	F ROBERTSON
CHECKED BY	F GARDNER
DATE	JULY 24, 2020

TITLE

UPPER TIER FIRE PROTECTION PLAN - AREA C

PROJECT NO.	50101397
-------------	----------

FP-121C

SHEET NO.

DESTROY AFTER USE

1 UPPER TIER FIRE PROTECTION PLAN - AREA C

Scale: 1/8" = 1'-0"