



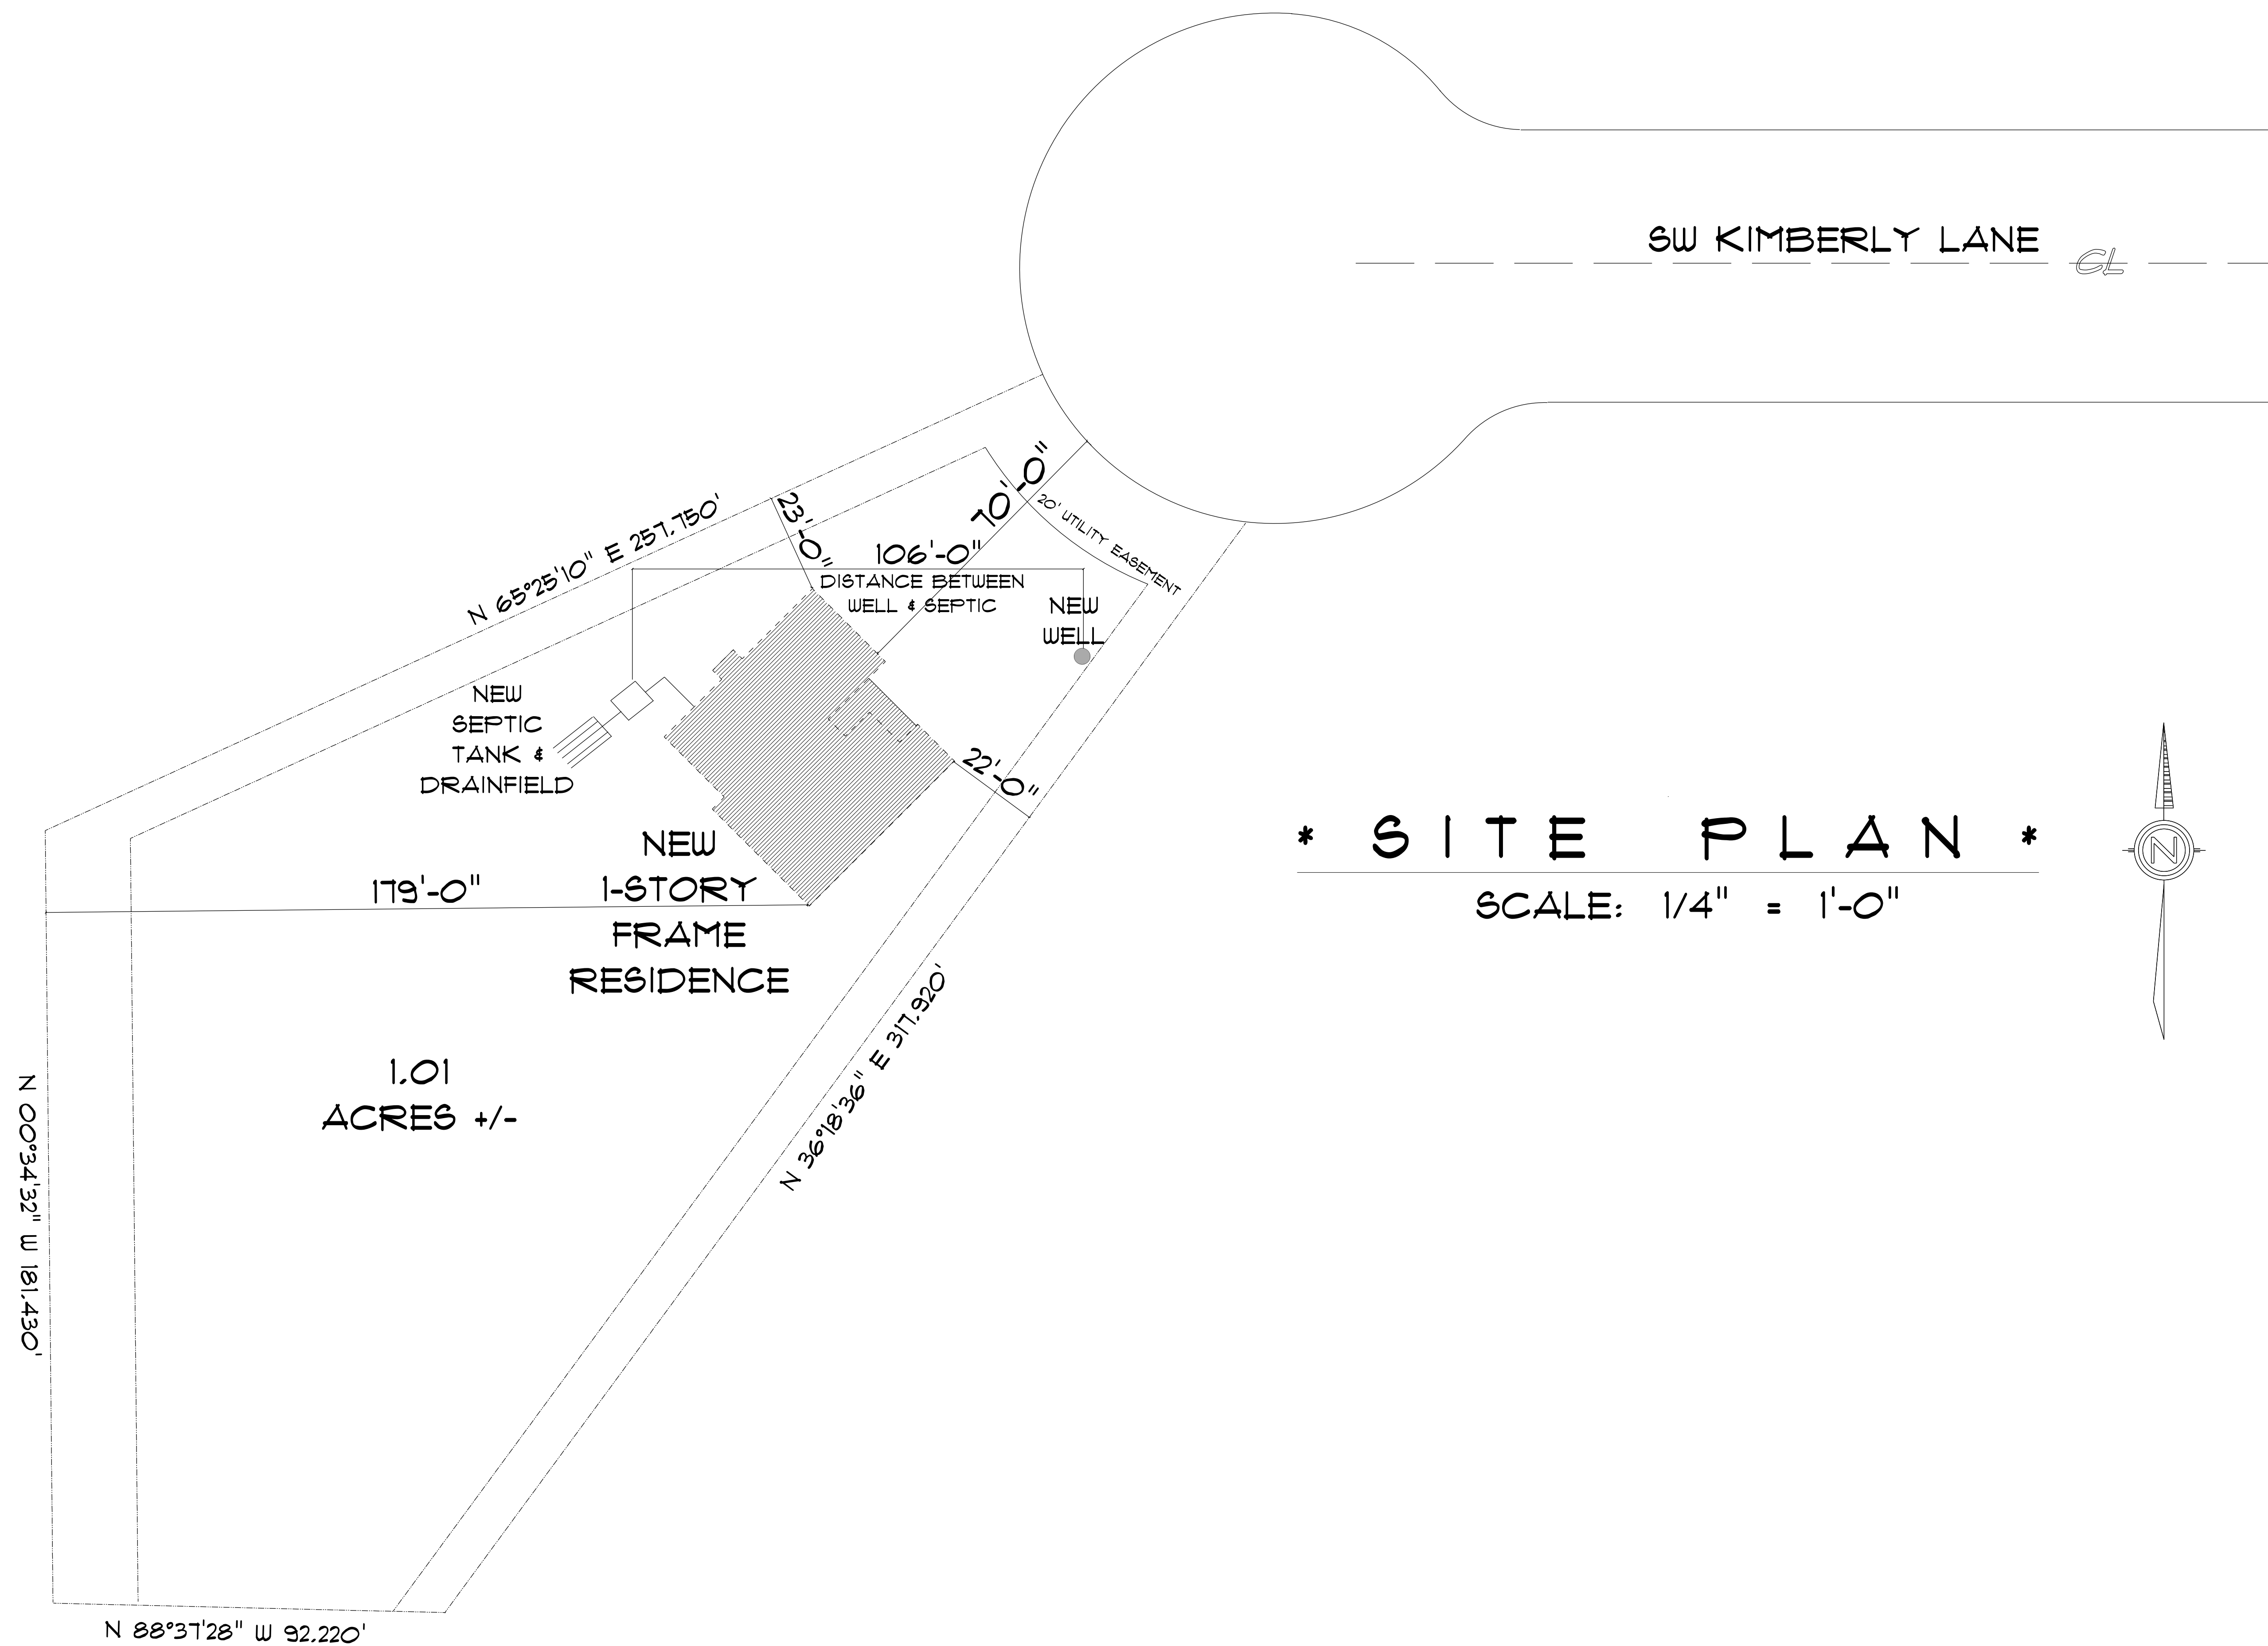

**\* SITE PLAN \***  
SCALE: 1/4" = 1'-0"

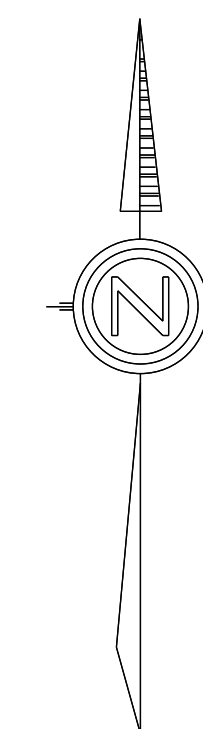

NEW RESIDENCE  
FOR  
TERRY WAYNE

Teena M. Ruffo  
2925 SW 8R 47  
Lake City Florida, 32025  
Cell: (386) 867-1191  
Email: teenaruffo@gmail.com

PRINTED DATE:  
Monday, June 24, 2024

DRAWN BY: Teena and Kara CHECKED BY:


BUILDING CONTRACTOR  
ZECHER CONSTRUCTION

FINAL DATE:

JOB NUMBER:

DRAWING NUMBER  
A-1

OF 6 SHEETS

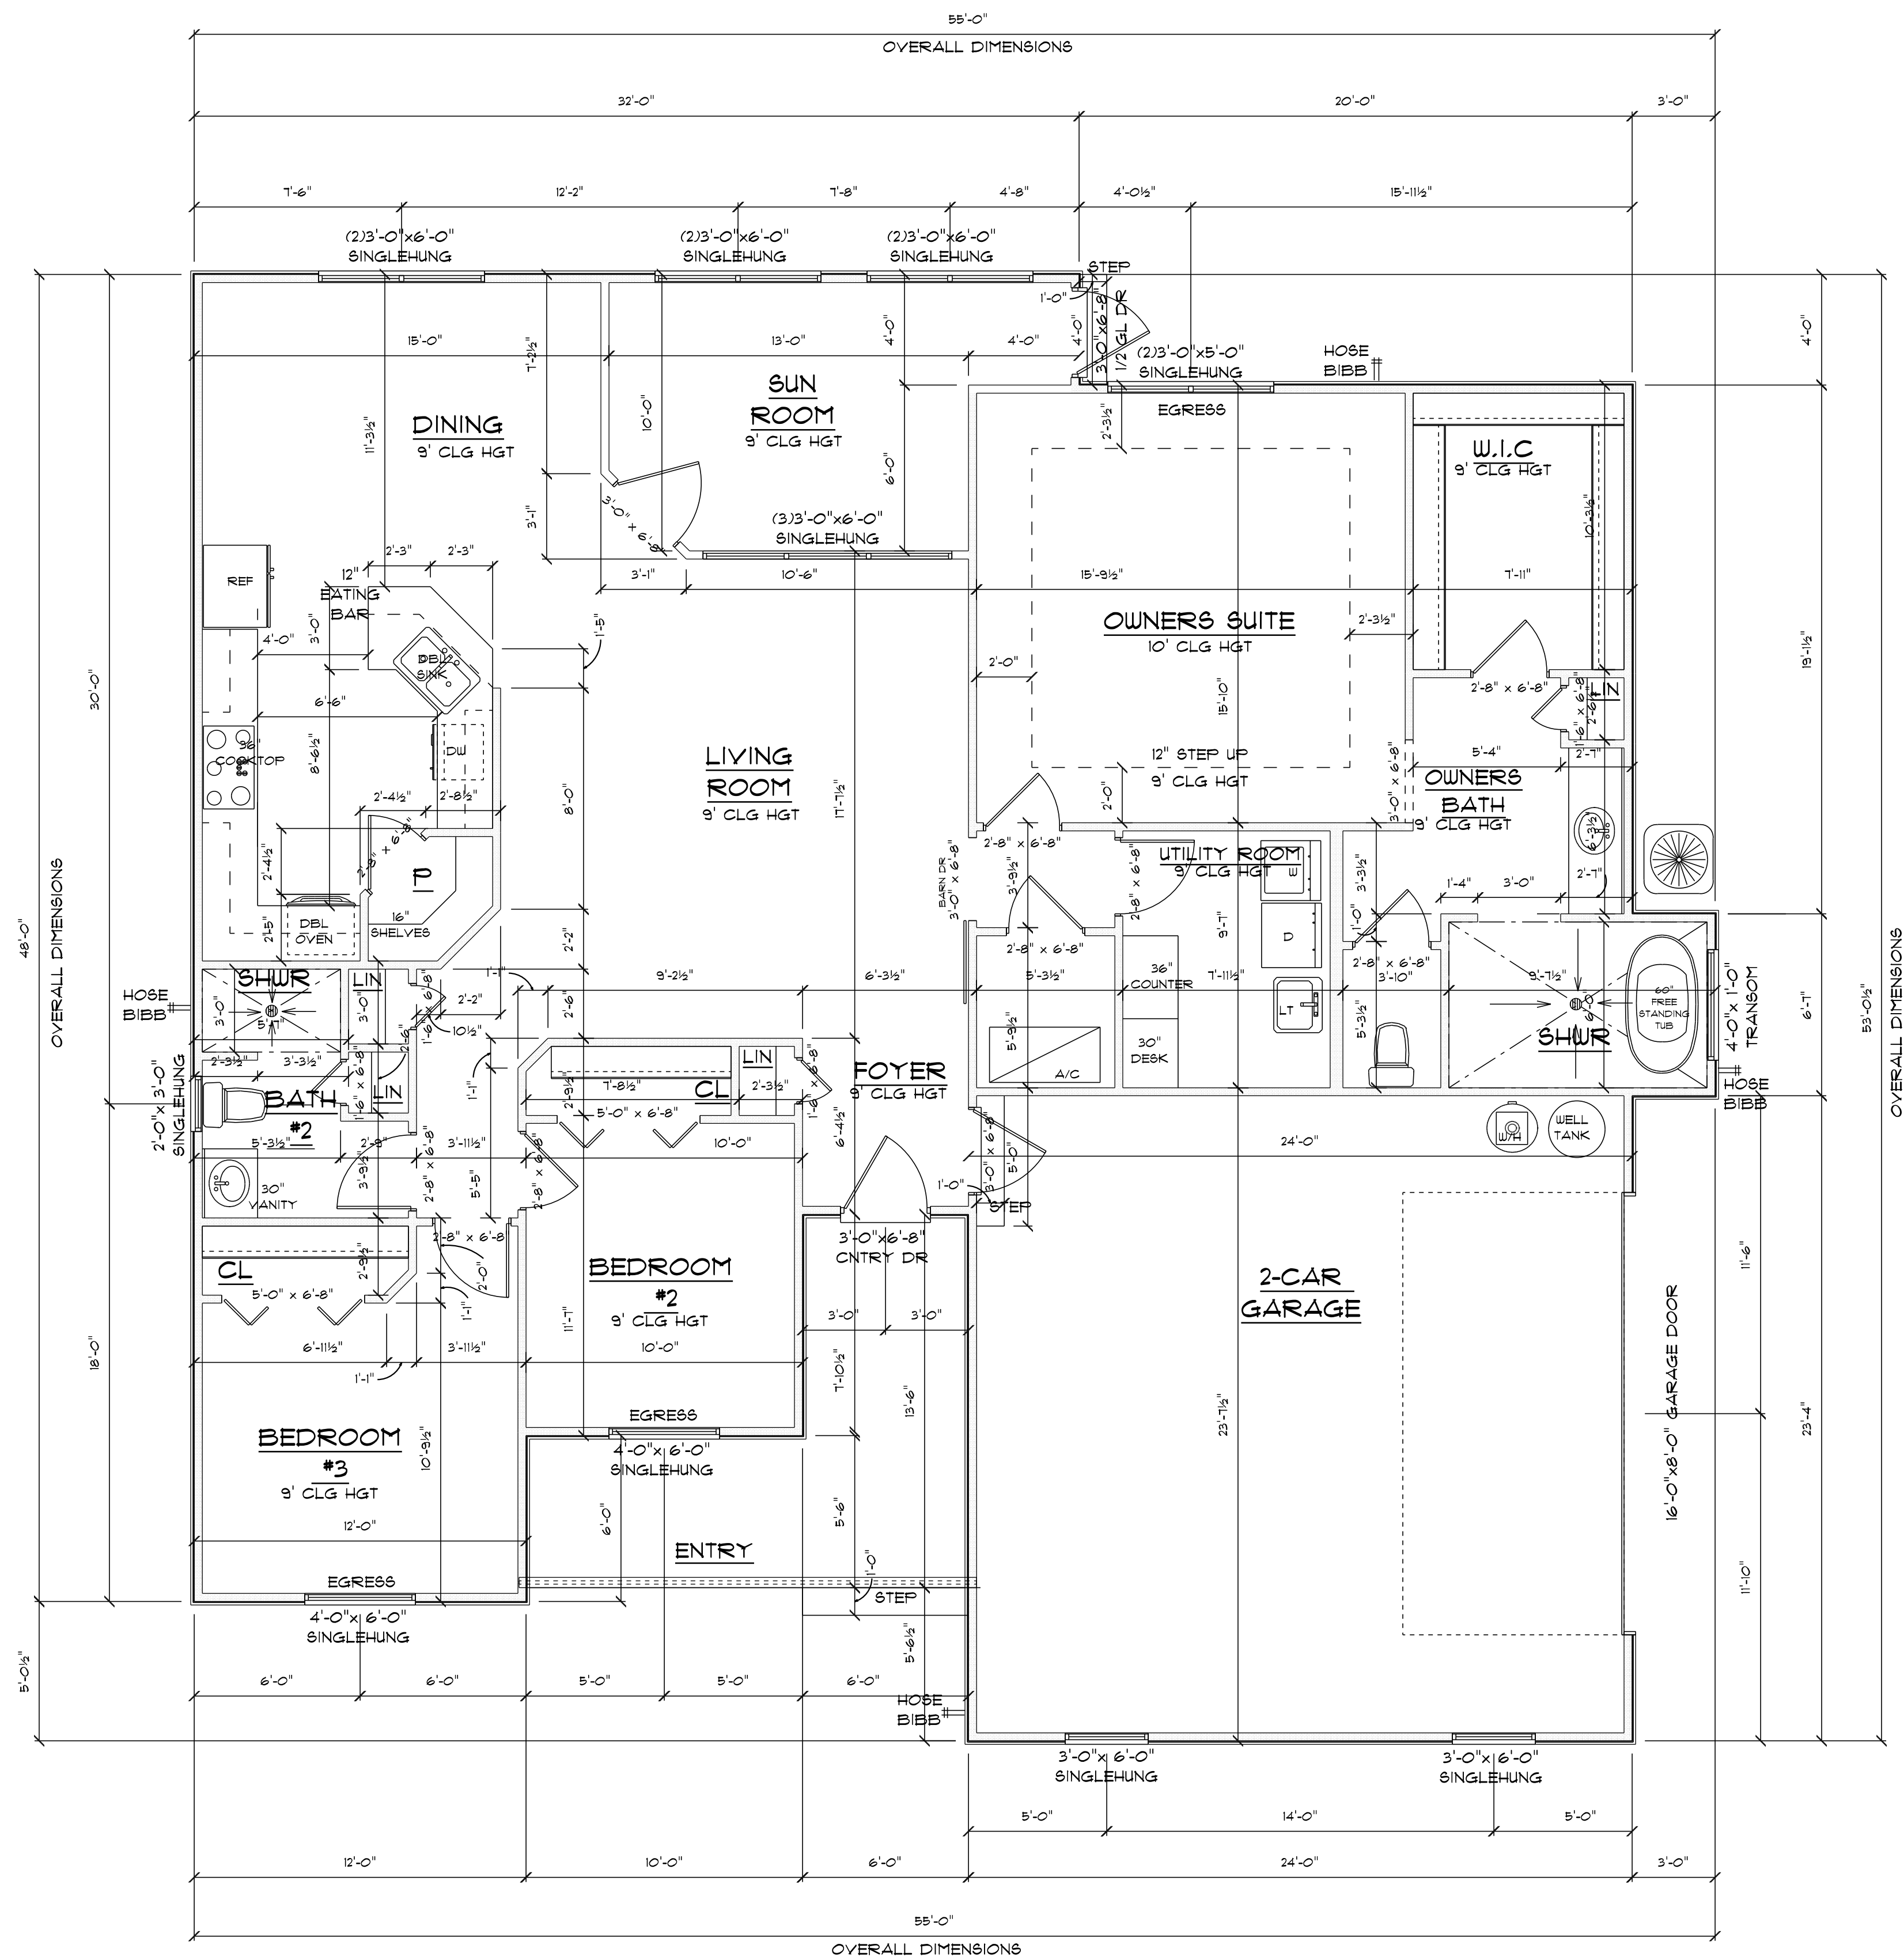

\* FLOOR PLAN \*

SCALE: 1/4" = 1'-0"

|                                    |             |
|------------------------------------|-------------|
| A/C LIVING AREA                    | = 1854 S.F. |
| FRONT ENTRY                        | = 134 S.F.  |
| 2-CAR GARAGE & MECH.CL             | = 542 S.F.  |
| TOTAL AREA UNDER ROOF = 2,530 S.F. |             |

NEW RESIDENCE  
FOR  
TERRY WAYNE

Teena M. Ruffo  
2925 SW SR 47  
Lake City Florida, 32025  
Cell: (386) 867-1191  
Email: teenaruffo@gmail.com

PRINTED DATE:  
Monday, June 24, 2024

DRAWN BY: Teena and Kara

CHECKED BY:

BUILDING CONTRACTOR  
ZECHER CONSTRUCTION

FINAL DATE:

JOB NUMBER:

DRAWING NUMBER

A-2


OF 6 SHEETS



## \* FRONT ELEVATION \*

SCALE : 1/4" = 1'-0"

NOTE: 18" OVERHANG ON EAVES  
12" OVERHANG ON GABLE ENDS

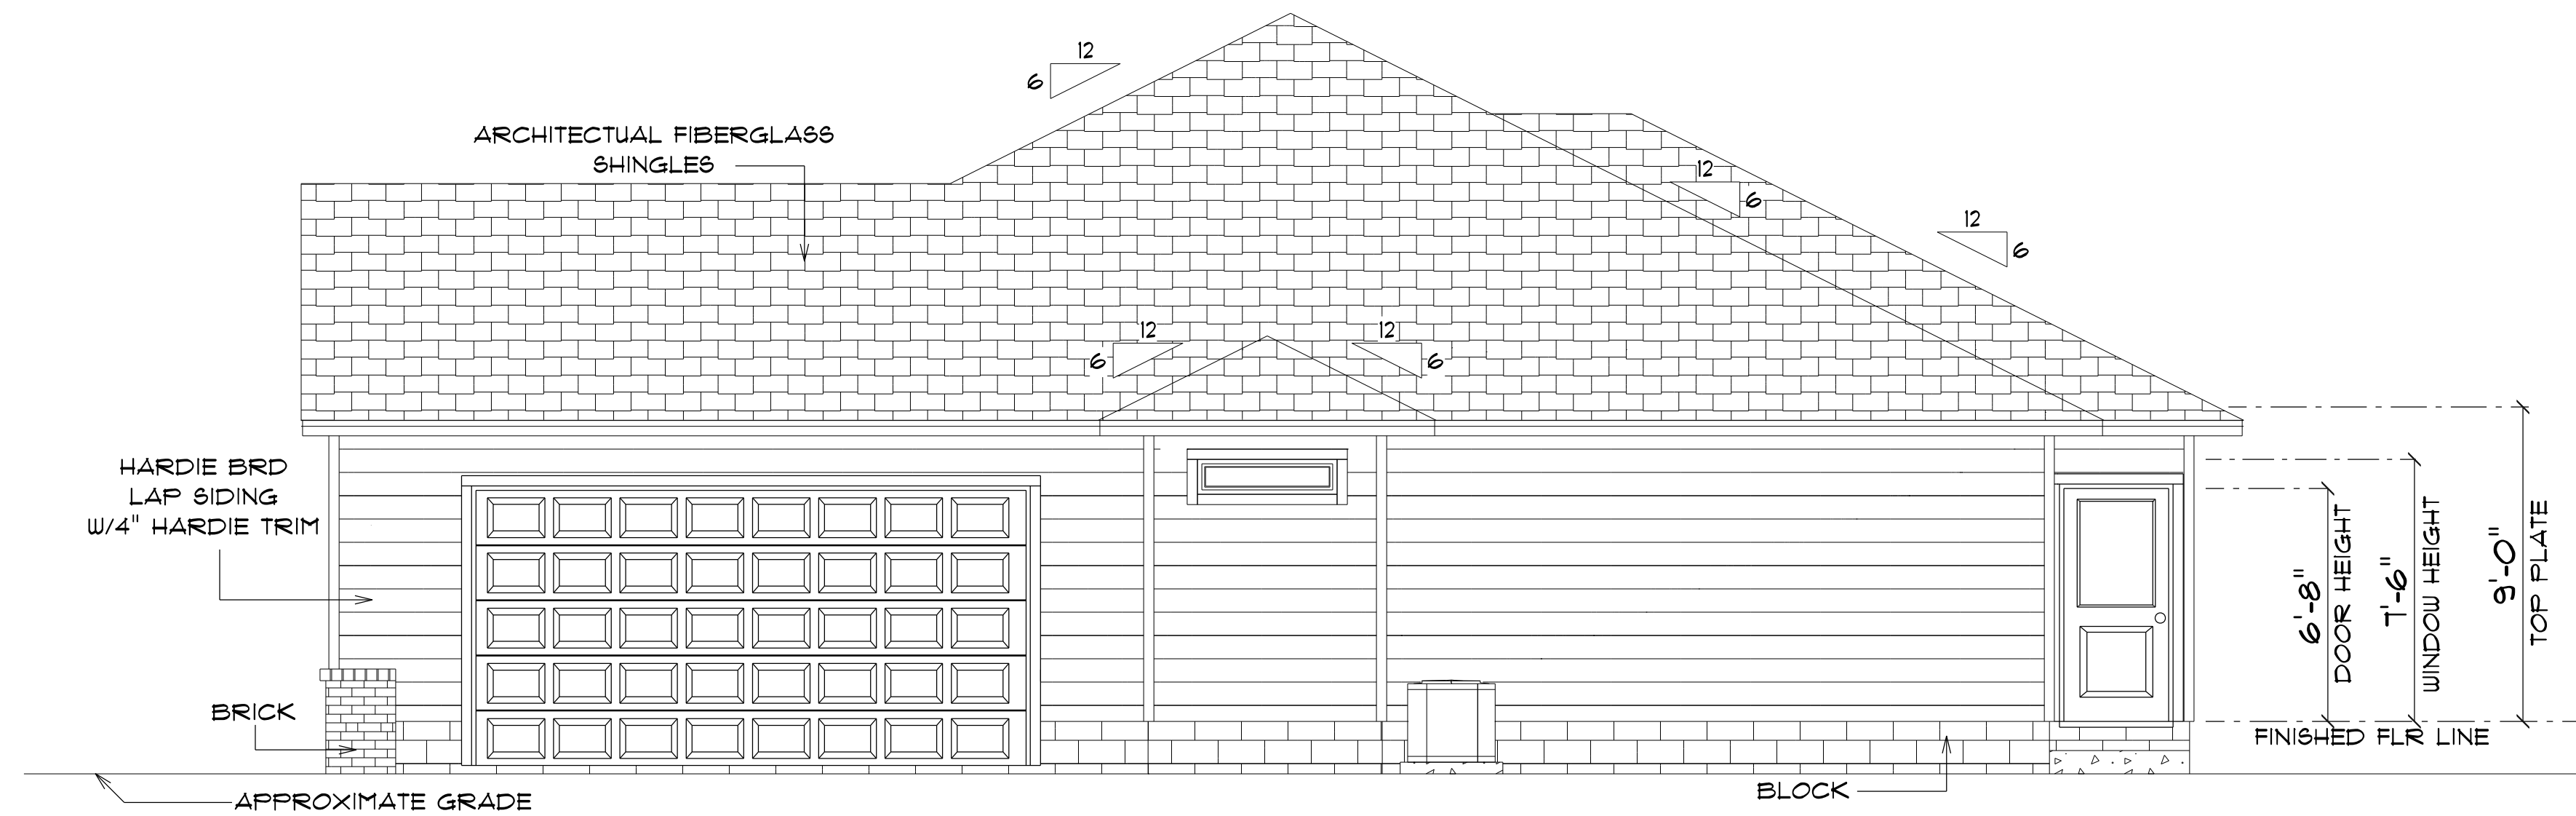

## \* RIGHT ELEVATION \*

SCALE : 1/4" = 1'-0"

NOTE: 18" OVERHANG ON EAVES  
12" OVERHANG ON GABLE ENDS

NEW RESIDENCE  
FOR  
TERRY WAYNE

Teena M. Ruffo  
2925 SW SR 47  
Lake City Florida, 32025  
Cell: (386) 867-1191  
Email: teenaruffo@gmail.com

PRINTED DATE:  
Monday, June 24, 2024

DRAWN BY: Teena and Kara

CHECKED BY:

BUILDING CONTRACTOR  
ZECHER CONSTRUCTION


FINAL DATE:

JOB NUMBER:

DRAWING NUMBER

A-3


OF 6 SHEETS

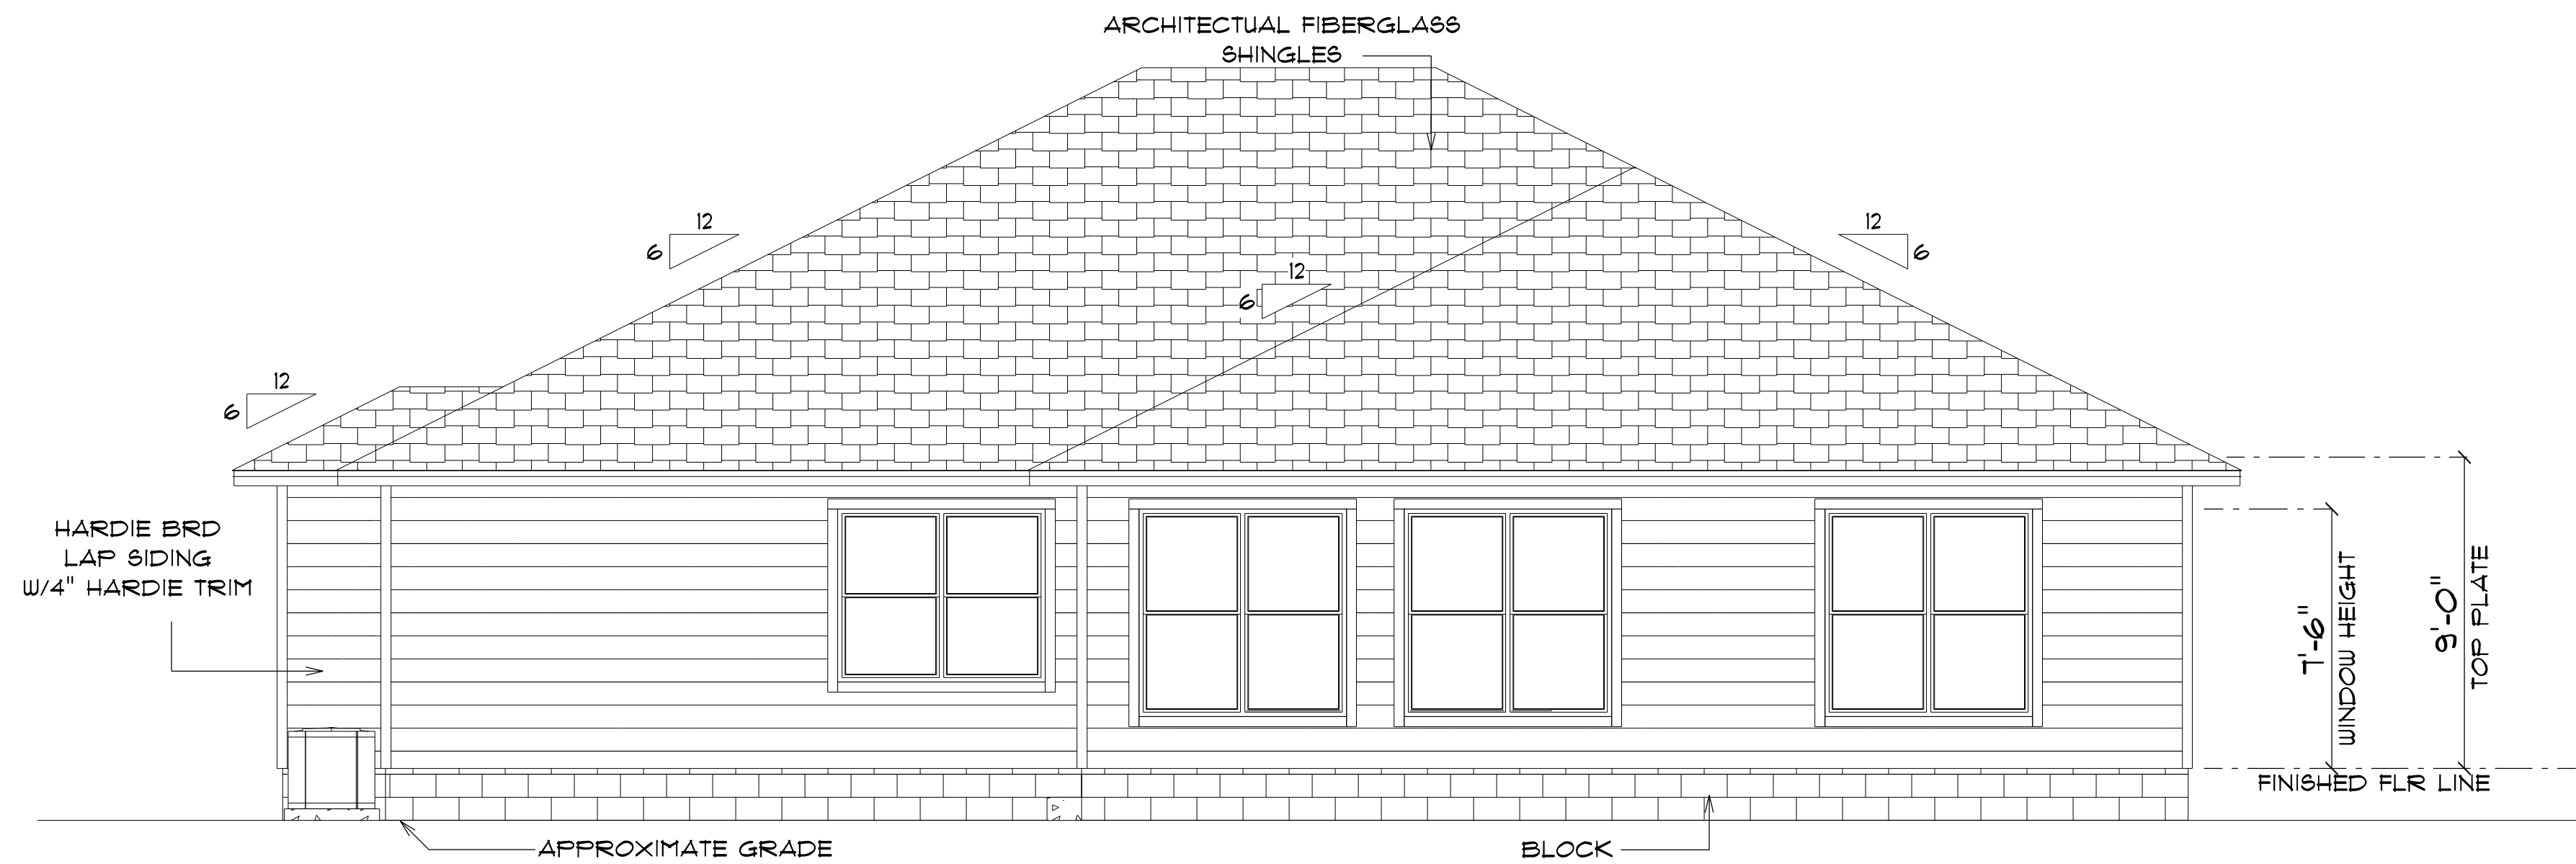

\* REAR ELEVATION \*

SCALE : 1/4" = 1'-0"

NOTE: 18" OVERHANG ON EAVES  
12" OVERHANG ON GABLE ENDS

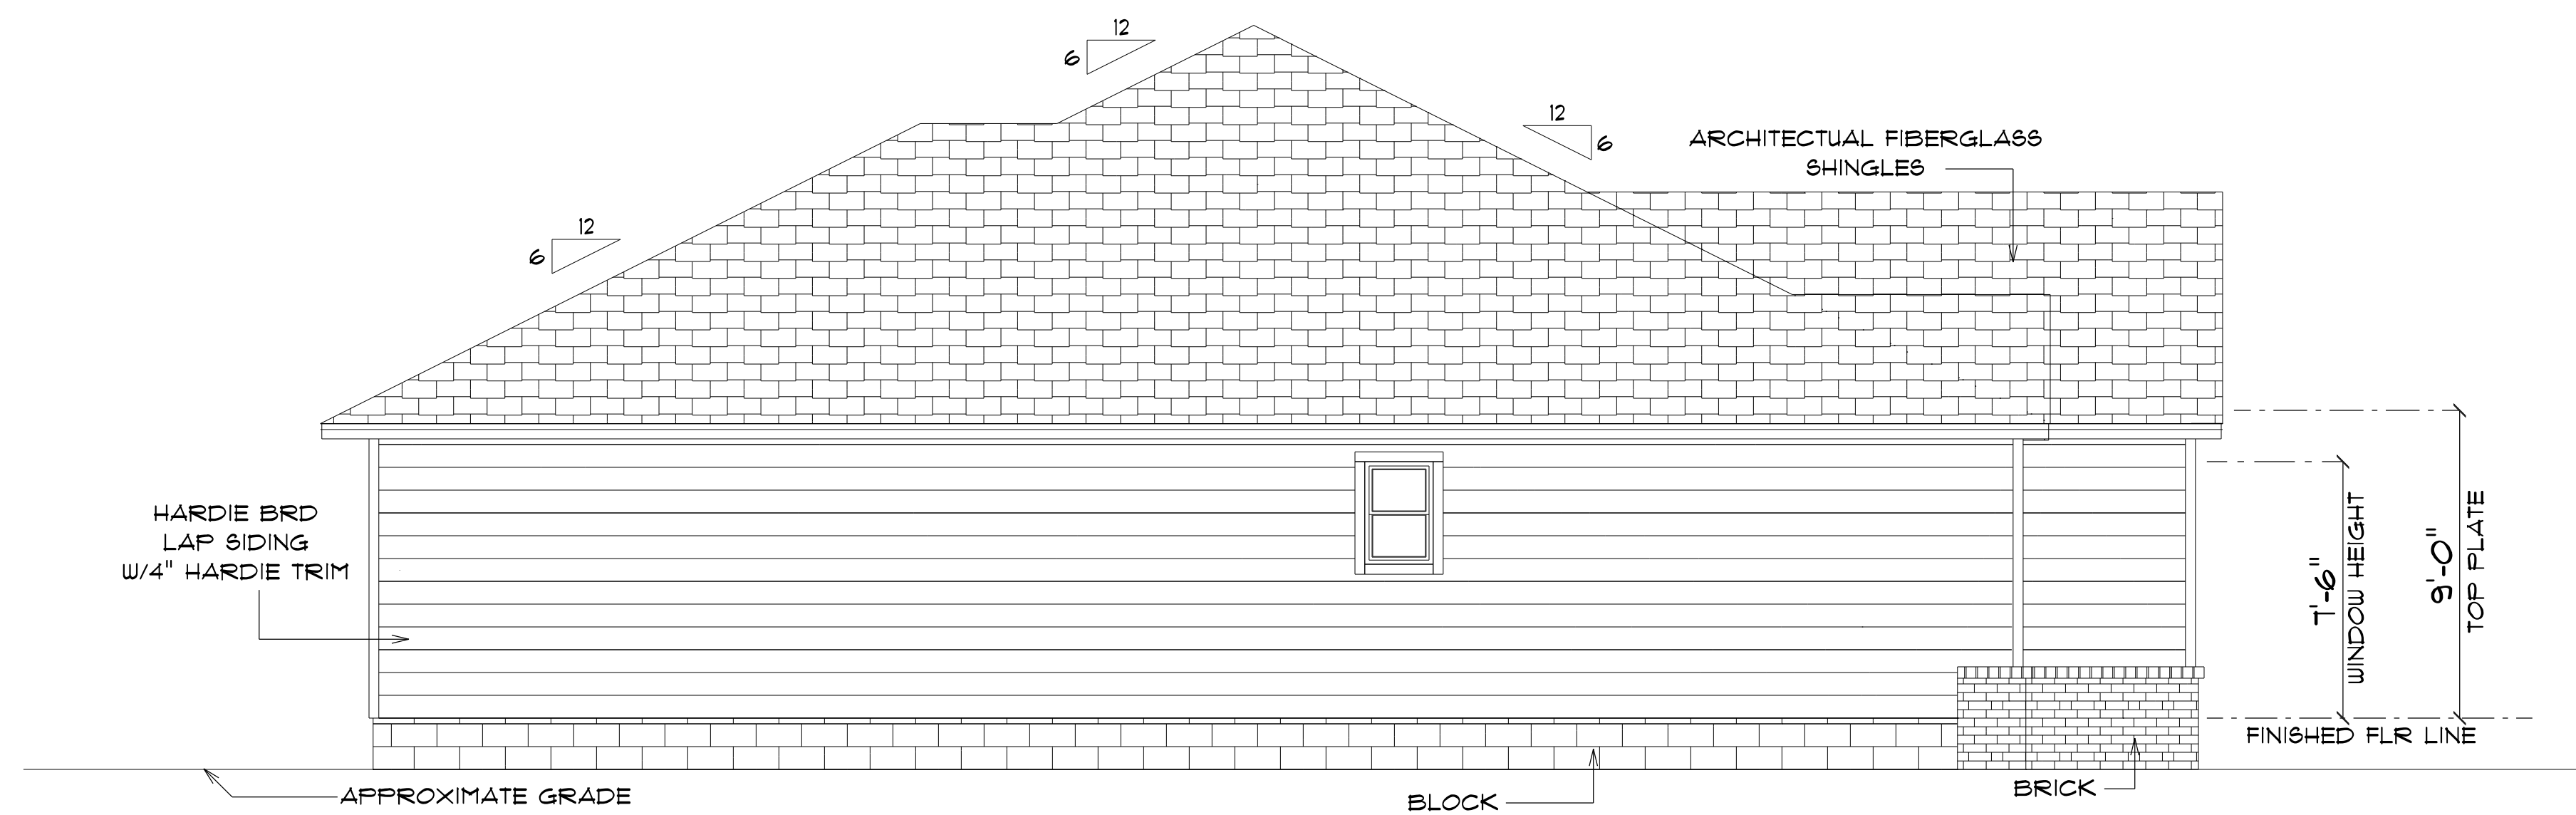

\* LEFT ELEVATION \*

SCALE : 1/4" = 1'-0"

NOTE: 18" OVERHANG ON EAVES  
12" OVERHANG ON GABLE ENDS

NEW RESIDENCE  
FOR  
TERRY WAYNE

Teena M. Ruffo  
2925 SW SR 41  
Lake City Florida, 32025  
Cell: (386) 867 - 1191  
Email: teenaruffo@gmail.com

PRINTED DATE:  
Monday, June 24, 2024

DRAWN BY: Teena and Kara  
CHECKED BY:


BUILDING CONTRACTOR  
ZECHER CONSTRUCTION

FINAL'S DATE:

JOB NUMBER:

DRAWING NUMBER  
A-4

OF 6 SHEETS

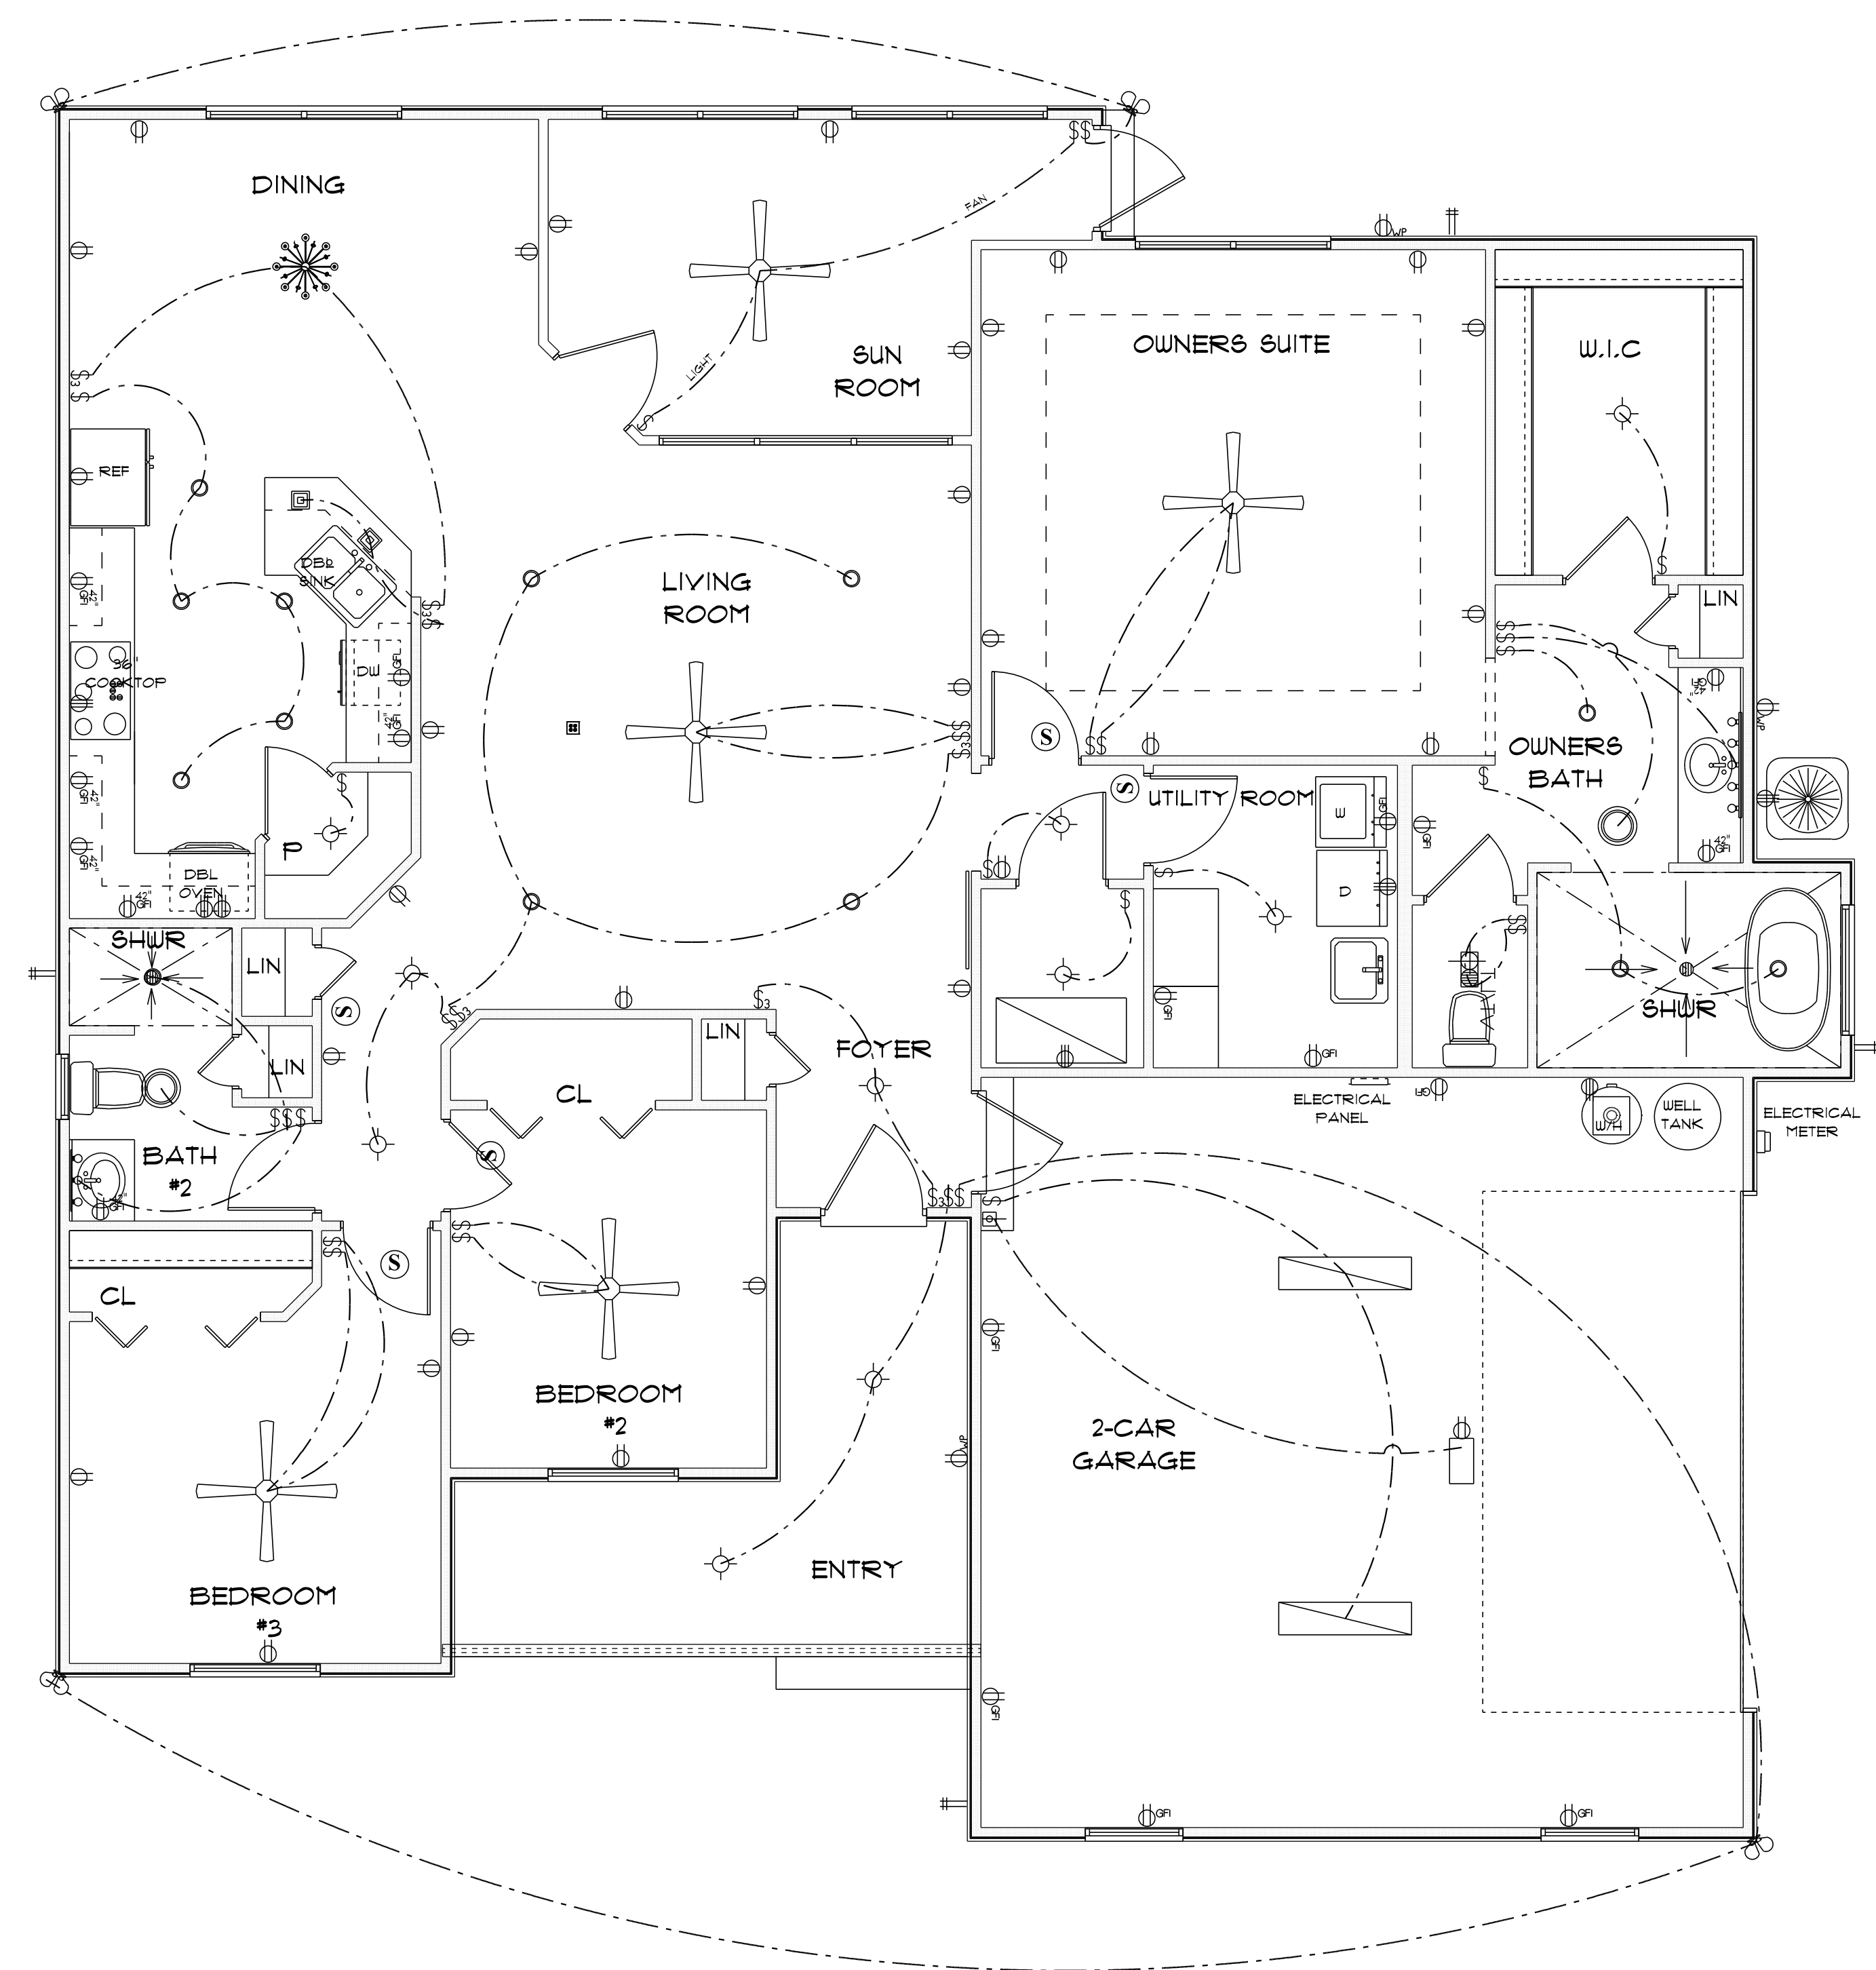

\* ELECTRICAL PLAN \*

SCALE : 1/4" = 1'-0"

|                                    |             |
|------------------------------------|-------------|
| A/C LIVING AREA                    | = 1854 S.F. |
| FRONT ENTRY                        | = 134 S.F.  |
| 2-CAR GARAGE & MECH.CL             | = 542 S.F.  |
| TOTAL AREA UNDER ROOF = 2,530 S.F. |             |

| ELECTRICAL LEGEND          |       |        |
|----------------------------|-------|--------|
| ELECTRICAL                 | COUNT | SYMBOL |
| automatic garage dr opener | 1     |        |
| ceiling classic            | 1     |        |
| ceiling fan                | 5     |        |
| round vent fan             | 2     |        |
| electrical panel           | 1     |        |
| floor outlet double        | 1     |        |
| fluorescent lt fixture     | 2     |        |
| garage dr opener           | 1     |        |
| light                      | 10    |        |
| outlet                     | 29    |        |
| outlet 220v                | 7     |        |
| outlet gfi                 | 18    |        |
| outlet wp                  | 3     |        |
| pendant large              | 2     |        |
| pot light                  | 13    |        |
| Smoke Detector             | 5     |        |
| spotlight double           | 4     |        |
| switch                     | 31    |        |
| switch 3 way               | 6     |        |
| vanity bar light O1        | 1     |        |
| vanity bar light O2        | 1     |        |
| vent light combo           | 1     |        |

ELECTRICAL PLAN NOTES

- E-1 WIRE ALL APPLIANCES, HVAC UNITS AND OTHER EQUIPMENT PER MANUFACTURERS SPECIFICATIONS.
- E-2 CONSULT THE OWNER FOR THE NUMBER OF SEPERATE TELEPHONE LINES TO BE INSTALLED.
- E-3 ALL INSTALLATIONS SHALL BE PER NATIONAL ELECTRIC CODE.
- E-4 ALL SMOKE DETECTORS SHALL BE 120V W/BATTERY BACKUP OF THE PHOTOELECTRIC TYPE, AND SHALL BE INTERLOCKED TOGETHER. INSTALL INSIDE AND NEAR ALL BEDROOMS.
- E-5
- E-6 TELEPHONE, TELEVISION AND OTHER LOW VOLTAGE DEVICES OR OUTLETS SHALL BE AS PER THE OWNERS DIRECTION AND IN ACCORDANCE WITH APPLICABLE SECTIONS OF NATIONAL ELCT. CODE LATEST EDITION.
- E-7 ELECTRICAL CONTRACTOR SHALL BE RESPONSIBLE FOR THE DESIGN AND SIZING OF ELECTRICAL SERVICE AND CIRCUITS.
- E-8 ENTRY OF SERVICE UNDERGROUND OR OVERHEAD IS TO BE DETERMINED BY THE POWER COMPANY.
- ALL BEDROOM RECEPTICALS ARE TO BE AFCI (ARC FAULT CIRCUIT INTERRUPT)

NEW RESIDENCE  
FOR  
TERRY WAYNE

Teena M. Ruffo  
2925 SW 8R 41  
Lake City Florida, 32025  
Cell: (386) 861 - 1191  
Email: teenaruffo@gmail.com

PRINTED DATE:  
Monday, June 24, 2024

DRAWN BY: Teena and Kara CHECKED BY:

BUILDING CONTRACTOR  
ZECHER CONSTRUCTION

FINAL& DATE:

JOB NUMBER:

DRAWING NUMBER  
A-5

OF 6 SHEETS