

CONSTRUCTION PLANS FOR CELEBRATION COMMUNITY CHURCH

PLANS PREPARED FOR:

CELEBRATION COMMUNITY CHURCH
c/o DICK SHORR, PASTOR
660 SW GRASSY LANE
FT. WHITE, FL 32038
PH. (386)-497-3034



BAILEY BISHOP & LANE, INC.

ENGINEERS • SURVEYOR • PLANNERS

**3107 SW BARNETT WAY
P.O. BOX 3717
LAKE CITY, FL 32056
PH. (904) 752-5640**

APPROVED
INSPECTION DEPARTMENT
LAKE CITY FIRE DEPT.
BY: CA 11/14/02
12/2/02


[Signature]
11/14/02

(opp. N.S.)

47-S
1-3-03

Celebration Community Church
Donnie Williams Const.

GENERAL MOUNTING HEIGHTS

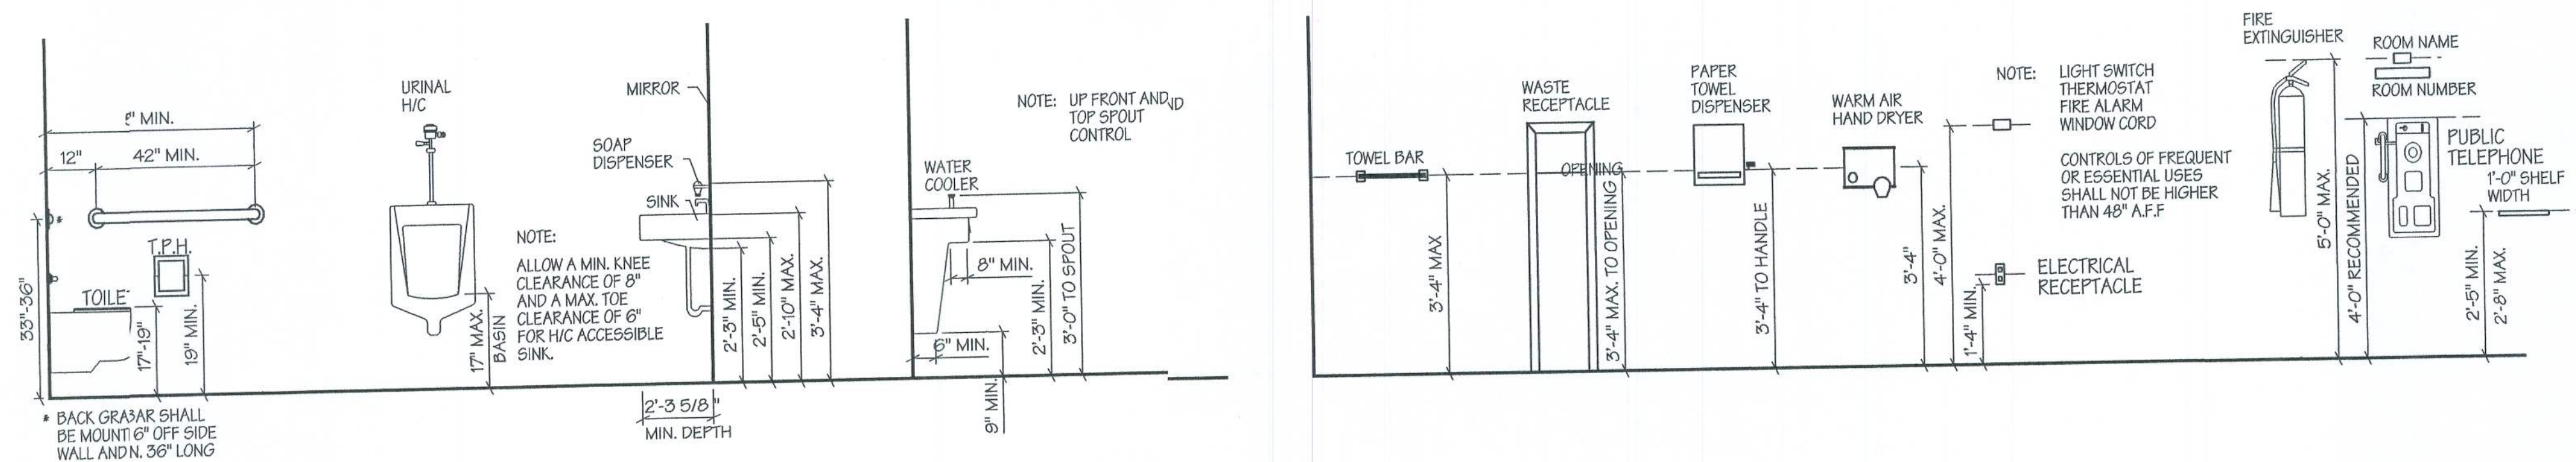

ABBREVIATIONS LEGEND

A.B.	ANCHOR BOLT	GA.	GAG	S.B.C.	SOUTHERN BUILDING CODE
ACOUS.	ACOUSTICAL	GALV.	GALVANIZED	SCHED.	SCHEDULE
ALT.	ALTERNATE	G.B.	GRA BAR	S.D.	SOAP DISPENSER
ALUM.	ALUMINUM	G.I.	GALVANIZED IRON	S.F.	SQUARE FEET
ANL.	ANGLE	GL.	GLAS	SH.	SHelf
A.P.	ACCESS PANEL	G.S.	GRAEL STOP	SHt.	SHEET
ARCH.	ARCHITECT	GYP.	GYPSUM BOARD	S.N.R.	SANITARY NAPKIN RECEPTACLE
A.T.	ACOUSTICAL TILE			S.S.	STAINLESS STEEL
				STD.	STANDARD
				STL.	STEEL
				SUSP.	SUSPENDED
BD.	BOARD	H.	HIGH	TEMP.	TEMPERED
B.J.	BAR JOIST	H.B.	HOS BIBB	THK.	THICK
BLDG.	BUILDING	H.C.	HANICAP (PED)	T.P.D.	TOILET PAPER DISPENSER
BLK(G)	BLOCKING	H.M.	HOLDW METAL	T.S.	TUBULAR STEEL
BM.	BEAM	HORIZ.	HORIZONTAL	TYP.	TYPICAL
B.M.	BENCH MARK	HR.	HOU		
BOT.	BOTTOM	HT.	HEIGHT		
BRG.	BEARING	H.W.	HOTVATER		
BRK.	BRICK				
B.S.	BOTH SIDES	INSUL.	INSULATION	U.N.O.	UNLESS NOTED OTHERWISE
B.U.R.	BUILT-UP ROOFING	INT.	INTERIOR	UR.	URINAL
	BY (2X4)	JT.	JOINT		
		JST.	JOIST	V.C.T.	VINYL COMPOSITE TILE
CAB.	CABINET			VERT.	VERTICAL
C.I.	CAST IRON	K.O.	KNCK OUT	V.P.B	VEENEER PLASTER BASE
C.J.	CONSTRUCTION JOINT	K.S.	KNE SPACE	VTR.	VENT THROUGH ROOF
CL.	CENTERLINE			V.T.	VINYL TILE
C.L.	CHAIN LINK	L.	LONG		
CLG.	CEILING	LAM.	LAMINATE	W.	WIDE
CLR.	CLEAR	LAV.	LAVATORY	W/	WITH
C.M.U	CONCRETE MASONRY UNIT	L.L.H.	LONG LEG HORIZONTAL	W.C.	WATER CLOSET
C.O.	CLEAN OUT	L.L.V.	LONG LEG VERTICAL	WCO	WALL CLEAN OUT
COL.	COLUMN	L.T.	LIQARD TILE	WD.	WOOD
CONC.	CONCRETE	L.W.	LIGT WEIGHT	W/O	WITHOUT
CONN.	CONNECTION			W.P.	WATERPROOFING
CONT.	CONTINUOUS	MAS.	MAONRY	W.W.F.	WIDE WELDED FABRIC
CPT.	CARPET	MAX.	MAMUM	W.W.M.	WELDED WIRE MESH
C.T.	CERAMIC TILE	MBL.	MABLE		
CTR.	COUNTER	MFR.	MAUFACTURE(R)		
		M.H.	MAHOLE		
		M.H.O.	MAINETIC HOLD OPEN		
DBL.	DOUBLE	MIN.	MINIMUM		
DET.	DETAIL	MIRR.	MIROR		
DIA.	DIAMETER	MISC.	MICELLANEOUS		
DIM.	DIMENSION	M.O.	MAONRY OPENING		
DISP.	DISPENSER	MTL.	MEAL		
D.P.M.	DAMPPOOFING MEMB.				
D.S.	DOWNSPOUT	N/A	NO APPLICABLE		
D.W.	DRYWALL	N.I.C.	NO IN CONTRACT		
		N.O.(#)	NUIBER		
		N.T.S.	NO TO SCALE		
EA.	EACH	O.A.	OUSIDE AIR		
E.J.	EXPANSION JOINT	O.C.	ONCENTER		
ELEC.	ELECTRICAL	OPP.	OPOSITE		
ELEV.	ELEVATION				
EQ.	EQUAL				
E.W.C.	ELECTRICAL WATER COOLER	PART.	PATITION		
EXIST.	EXISTING	P.C.	PRCAST		
EXT.	EXTERIOR	PL.	PLTE		
		PLAS.	PLSTER		
F.D.	FLOOR DRAIN	PNL.	PAEL		
F.E.	FIRE EXTINGUISHER	PRE-FAB	PRFABRICATED		
F.E.C.	FIRE EXT. CABINET	P.T.	PRSSURE- TREATED		
F.F.	FINISH FLOOR	P.T.D.	P/ER TOWEL DISPENSER		
FIN.	FINISH				
FIXT.	FIXTURE	Q.T.	QARRY TILE		
FLR.	FLOOR				
FLSHG.	FLASHING	R.D.	ROF DRAIN		
FTG.	FOOTING	REQD.	RQUIRED		
FUR.	FURRING	REINF.	REINFORCE(D) REINFORCING		
F.V.	FIELD VERIFY	RM.	ROM		

SYMBOLS LEGEND

TYPE	DESCRIPTION
	SECTION
	DETAIL MARK
	REFERENCE (TO ANOTHER SECTION OR DETAIL)
	ROOM NUMBER
	DOOR (WITH MARK SYMBOL)
	WINDOW (WITH MARK SYMBOL)
	TARGET ELEVATION (EXISTING ELEVATION MARK NOT SHADED)

MATERIALS LEGEND

TYPE	DESCRIPTION
	BATT INSULATION
	BRICK VENEER
	POURED IN PLACE CONCRETE (IN SECTION)
	RIGID INSULATION
	WOOD FRAMING (IN SECTION)
	8" CONCRETE BLOCK

SHEET INDEX

COVER SHEET	G1
SHEET INDEX, LEGENDS & ABBREVIATIONS	G2
GENERAL NOTES	G3
FLOOR PLAN	B1
ELEVATIONS	B2
FOUNDATION PLAN	B3
WALL SECTIONS AND DETAILS	B4
ELECTRICAL PLAN	E1

BAILEY BISHOP & LANE, INC.
SW BARNETT WAY
P.O. BOX 3717
LAKE CITY, FL 32056-3717
PH. (904) 124-0040 FAX (904) 700-7771
Eng. Lic. 7562 Survey Lic. LB-0006685

SHEET INDEX, LEGENDS
AND ABBREVIATIONS
CELEBRATION COMMUNITY CHURCH

REVISIONS

JOB NO.
020000
DATE
11/11/02
SHEET NO.
G2

GENERAL CONSTRUCTION NOTES

GENERAL NOTES

1. CONTRACTOR SHALL VERIFY ALL DIMENSIONS AND DETAILS SHOWN. NOTIFY THE ENGINEER OF ANY CHANGES OR MODIFICATIONS TO THE PLANS.
2. ALL PRE-FABRICATED BUILDING ELEMENTS SHALL BE DESIGNED, FABRICATED AND ERECTED IN STRICT ACCORDANCE WITH ALL APPLICABLE CODES, SPECIFICATIONS AND REGULATIONS AND TO SUPPORT LOADS INDICATED IN THE STRUCTURAL DESIGN NOTES AND ANY CONCENTRATED LOADS. ALL REQUIRED BRACING (TEMPORARY AND PERMANENT) SHALL BE DESIGNED AND NOTED ON ERECTION DRAWINGS BY THE MANUFACTURER. CONTRACTOR SHALL PROVIDE SHOP DRAWINGS OF ALL PRE-FABRICATED ELEMENTS FOR REVIEW AND APPROVAL BY THE ENGINEER OF RECORD.
3. ALL FRAMING LUMBER SHALL BE SET AND SPACED AS INDICATED, SECURELY ATTACHED, NAILED, BRIDGED AND BLOCKED TO FORM A RIGID STRUCTURE. ALL WORK IS TO BE SECURELY SET, INCLUDING ANCHORING TO MASONRY AND CONCRETE.
4. PROVIDE BLOCKING, NAILERS, PLATES AND OTHER MISCELLANEOUS WHERE SHOWN AND REQUIRED. SECURELY FASTEN BLOCKING IN PLACE. PLACE BOLTS IN CONCRETE, MASONRY AND STEEL FOR THE FASTENING OF BLOCKING AND PLATES WHERE SHOWN AND/OR REQUIRED.
5. ALL WOOD OR METAL STUDS SHALL BE SPACED AT 16" O.C., UNLESS OTHERWISE NOTED ON THE PLANS, WITH A SINGLE GLE PLATE, DOUBLE TOP PLATE AND A CONTINUOUS ROW OF SOLID GIRTS AT THE ENTER OF HEIGHT. ALL OPENINGS SHALL HAVE DOUBLE WOOD STUDS AT EACH JAMB.
6. ALL WALLS AND OTHER STRUCTURAL MEMBERS SHALL BE TEMPORARILY BRACED UNTIL PERMANENT BRACING IS IN PLACE.
7. ALL WINDOW AND DOOR HEADERS WITH A MAXIMUM SPAN OF 6'-0" IN A NON-BEARING STUD WALL SHALL -2X6 FOR 4" WALLS AND 3-2X6 FOR A 6" WALLS.

STRUCTURAL NOTES

STRUCTURAL DESIGN CRITERIA


1. ALL WORK HAS BEEN DESIGNED FOR THE FOLLOWING LOADS AND SPECIFICATIONS APPLIED IN ACCORDANCE WITH THE LATEST EDITIONS OF THE SOUTHERN BUILDING CODE AND ACI 318.
2. DESIGN LOADS:
 - 2.1 DEAD LOAD(ROOF)= 15 PF
 - 2.2 LIVE LOAD(ROOF)= 20 PF
 - 2.3 WIND LOAD = 150 MPH @ 30 FT.

CONCRETE NOTES


1. SOIL BEARING= 2500 PSF (MINIMUM)
2. FILL AND COMPACTION:
ALL FILL MATERIAL SHALL BE CLEAN, WELL DRAINED SAND WITH NOT MORE THAN 10% PASSING THE No. 200 STANDARD SIEVE. ALL FILL MATERIAL SHALL BE COMPACTED TO 95% OF THE MODIFIED MAXIMUM DRY DENSITY AS DETERMINED BY ASTM T-180.
3. CONCRETE COMPRESSIVE STRENGTH AND SLUMP:
THE MINIMUM 28-DAY COMPRESSIVE STRENGTH AND SLUMP OF CONCRETE SHALL BE AS FOLLOWS:
FOUNDATIONS AND FLOOR SLAB: $f_c' = 4000$ PSI SLUMP: 2"-5"
SIDEWALKS AND CONCRETE PAVEMENT: $f_c' = 2500$ PSI SLUMP: 3"-6"
ALL CONCRETE SHALL BE MIXED IN ACCORDANCE WITH THE LATEST EDITIONS OF ACI 315 AND ACI 318.
4. REINFORCING STEEL:
ALL LAP SPLICES SHALL BE A MINIMUM OF 18" OR AS SPECIFIED ON THE PLANS.
REINFORCING STEEL BARS ASTM A-615 GRADE 40
WELDED WIRE FABRIC - ASTM A-185
5. UNLESS OTHERWISE NOTED ON THE PLANS, ALL SLABS ON GRADE SHALL BE REINFORCED WITH ONE LAYER OF 6X6X10/10 WELDED WIRE FABRIC PLACED AT 1/3 THE THICKNESS OF THE SLAB FROM THE BOTTOM OF THE SLAB.

ARCHITECTURAL NOTES


1. ALL DRYWALL SHALL BE 5/8" GYPSUM WALLBOARD UNLESS OTHERWISE NOTED ON THE DRAWINGS.
2. ALL CONSTRUCTION, EQUIPMENT AND FINISHES SHALL MEET OR EXCEED ALL LOCAL CODES, SOUTHERN BUILDING CODE, NFPA 101 LIFE SAFETY CODE AND ALL OTHER GOVERNING CODES AND REVISIONS.
3. ALL INTERIOR STUD WALLS ARE TO BE OF 4" STUDS @ 16" O.C. UNLESS OTHERWISE NOTED ON THE PLANS.
4. ROOF SLOPES SHALL BE AS NOTED ON THE PLANS. METAL ROOFING, UNDERLAYMENT, FLASHING, DIP MOLDING AND VENTILATION SHALL BE AS SPECIFIED BY THE ROOFING MANUFACTURER.
5. DO NOT USE ANY MATERIALS CONTAINING ASBESTOS.
6. THE CONTRACTOR SHALL VERIFY ALL DIMENSIONS AND DETAILS SHOWN AND NOTIFY THE ENGINEER OF ANY CHANGES OR MODIFICATIONS.
7. THE CONTRACTOR SHALL VERIFY ALL EXISTING CONDITIONS AND DIMENSIONS AT THE JOB SITE TO INSURE THAT ALL NEW WORK WILL FIT IN THE MANNER INTENDED AND ON THE PLANS. SHOULD ANY CONDITIONS EXIST THAT ARE CONTRARY TO THOSE SHOWN ON THE PLANS, THE CONTRACTOR SHALL NOTIFY THE ENGINEER OF SUCH DIFFERENCES IMMEDIATELY AND PRIOR TO PROCEEDING WITH THE WORK.
8. ANY WOOD OR TIMBER THAT COMES IN CONTACT WITH CONCRETE OR MASONRY SHALL BE PRESSURE TREATED.
9. SEE STRUCTURAL DRAWINGS FOR ALL SIZES, SHAPES AND CONDITIONS OF ALL STRUCTURAL MEMBERS, CONNECTIONS FOOTINGS, BRACING, AND REINFORCING.
10. ALL INTERIOR FINISHES SHALL MEET THE REQUIREMENTS OF LIFE SAFETY CODE SECTION 6-5.1.5.
11. ALL FLOOR FINISHES SHALL BE LEVEL AND SHALL AVOID ANY CHANGES IN ELEVATION GREATER THAN 1/2" INCLUDING DOOR THRESHOLDS AND STEP DOWNS AT EXTERIOR AND INTERIOR DOORS.
12. ALL FASCIAE AND SOFFIT VENTS ARE TO BE OF ALUMINUM WITH SOFFIT VENTS HAVING 2" CONTINUOUS VENTILATION, SCREENED. COLOR SHALL BE AS SPECIFIED BY OWNER/CONTRACTOR.
13. FOUNDATION WATER-PROOFING AND MOISTURE BARRIER TO CONSIST OF 6-MIL PLASTIC POLYETHYLENE. ALL LAPS SHALL BE A MINIMUM OF 12".
14. FINAL LOCATION, SIZE AND PLACEMENT OF ALL PLUMBING, ELECTRICAL AND MECHANICAL COMPONENTS SHALL BE DETERMINED BY A LICENSED ELECTRICAL OR MECHANICAL CONTRACTOR IN ACCORDANCE WITH CHAPTER 471.003 2(i).
15. THE HEATING, AIR CONDITIONING AND VENTILATING SYSTEM SHALL HAVE MINIMUM SEER, EER AND COP AS SPECIFIED BY THE LATEST EDITION OF THE ENERGY DEPARTMENT OF COMMUNITY AFFAIRS.
16. ALL EXTERIOR DOORS SHALL HAVE PANIC HARDWARE AND DOOR CLOSURE DEVICES.

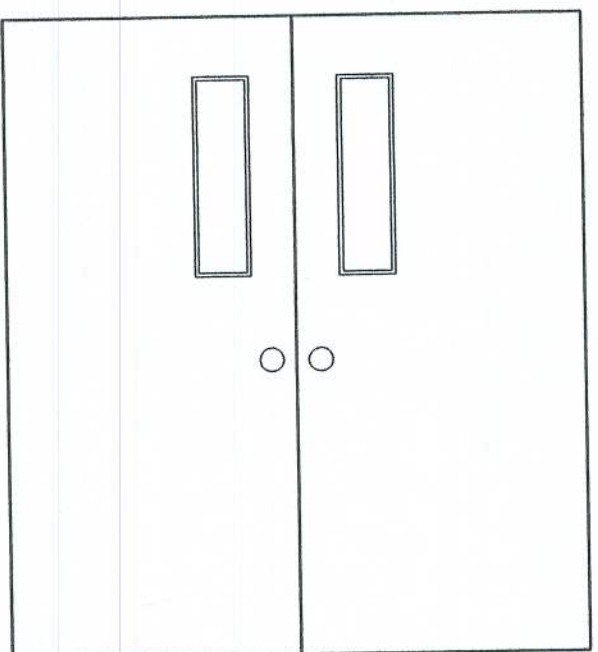


TYPE 'A'
INSULATED STEEL
ENTRY DOOR BORED
FOR DEADBOLT LOCK
STEEL FRAME

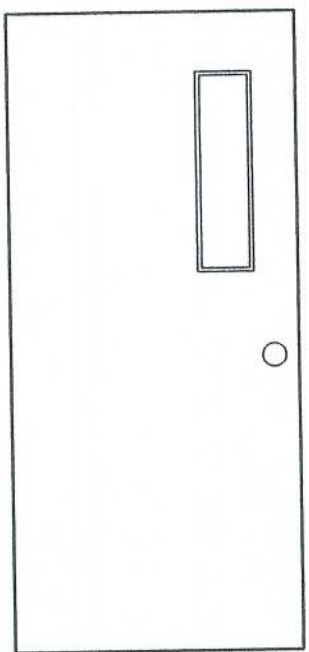

TYPE 'B'
STEEL - COMMERCIAL
GRADE W/ SIDE LITE -
STEEL FRAME

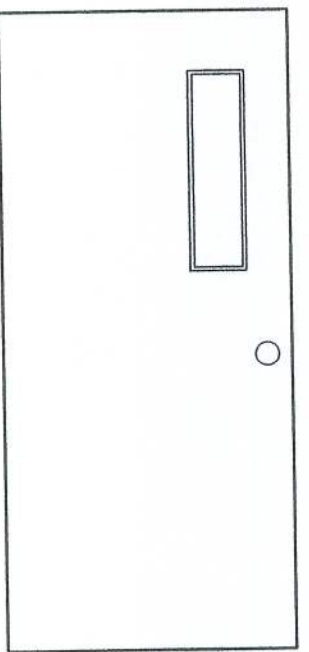

TYPE 'C'
SOLID CORE FLUSH
LUAN DOOR W/ SIDE
LITE - STAIN GRADE
STEEL FRAME
(FIRE-RATED)

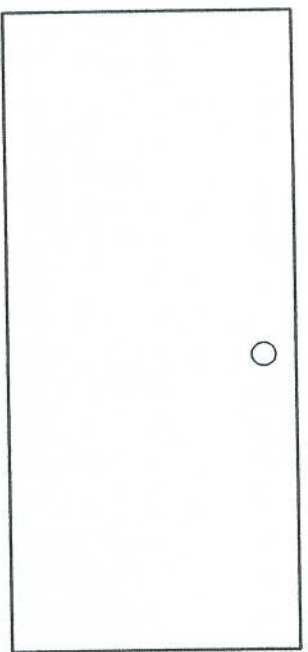

TYPE 'D'
SOLID CORE FLUSH
LUAN DOOR -
STAIN GRADE
STEEL FRAME


REVISIONS

DOB NO.
030000
DATE
1/11/02
SHEET NO.


G3

GENERAL NOTES

BAILEY BISHOP & LANE BUILDING

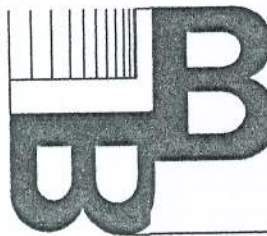

BAILEY BISHOP & LANE, INC.
SW BARNETT WAY
P.O. BOX 3717
LAKE CITY, FL 32056-3717
PH. (904) 752-5640 FAX (904) 755-7771
Eng. Lic. 7562 Survey Lic. LB-0006665

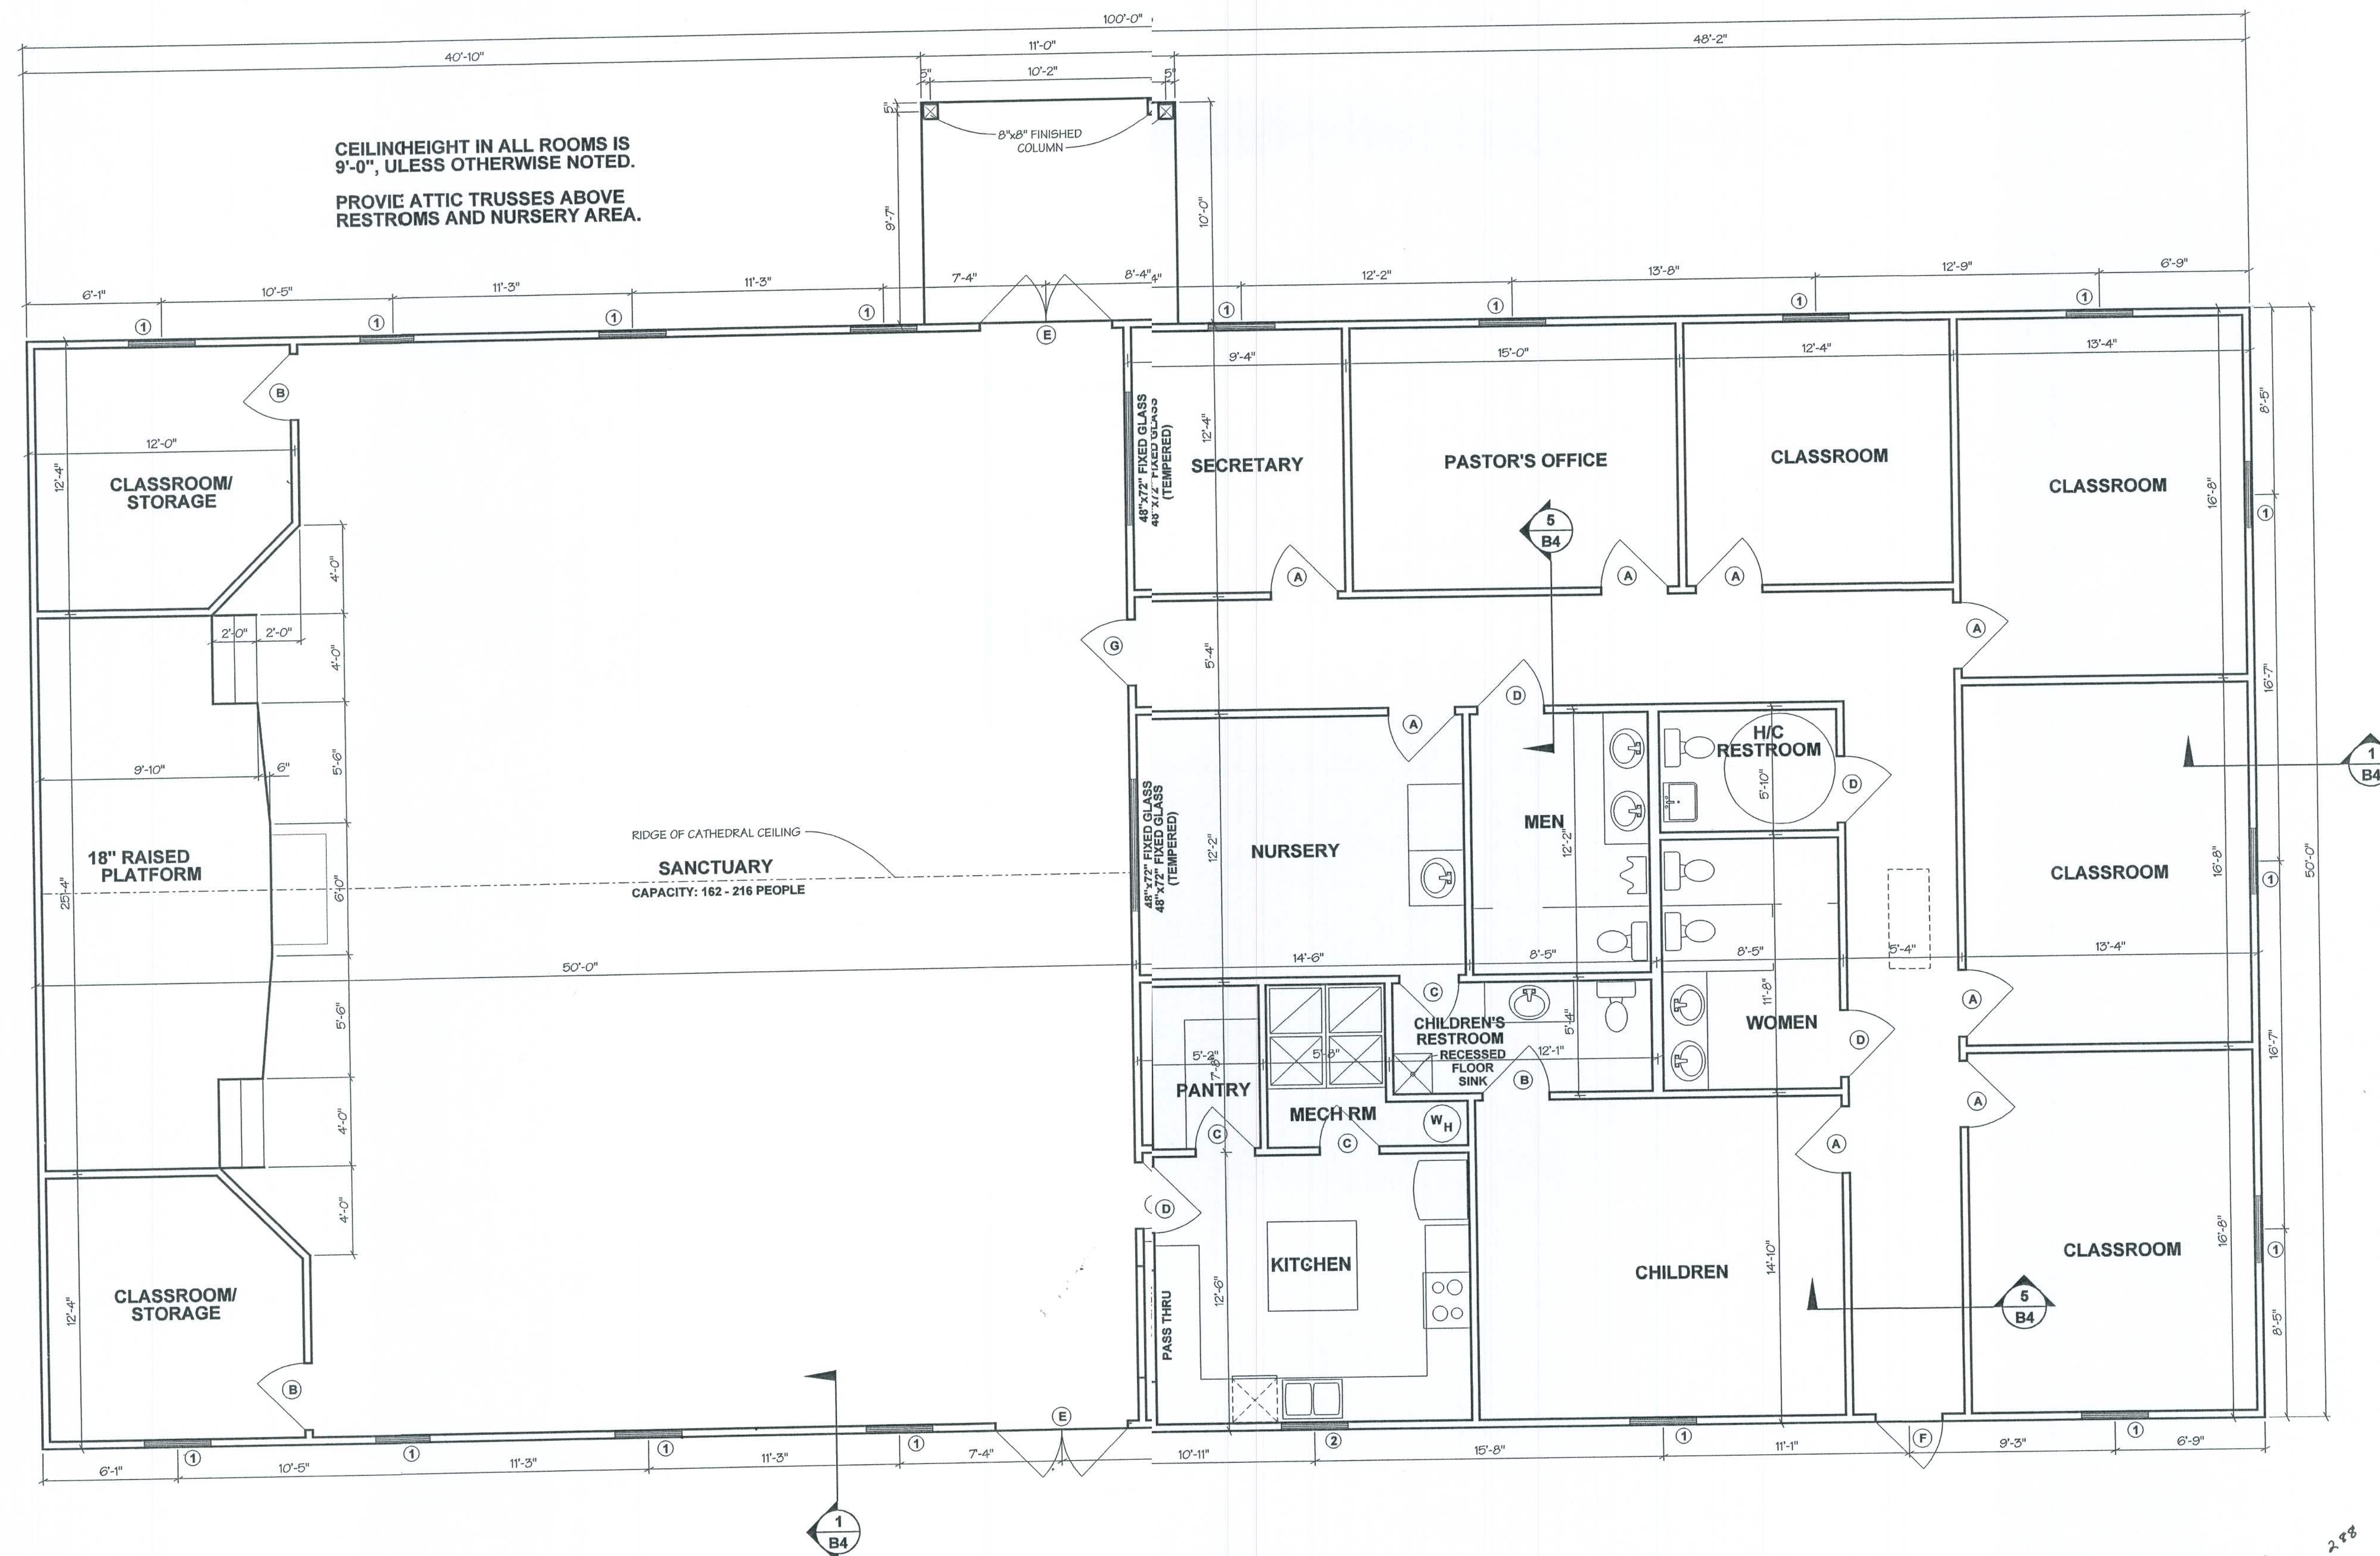

DOOR SCHEDULE				
SYMBOL	QUANT.	DIMENSIONS		REMARKS
		WIDTH	HEIGHT	
A	8	36"	80"	TYP; 1 HR FIRE RATED
B	3	36"	80"	TYP
C	3	32"	80"	TYP
D	4	36"	80"	TYP; DOOR CLOSER
E	2	72"	80"	TYP; PANIC HARDWARE; DOOR CLOSER
F	1	36"	80"	TYP; PANIC HARDWARE; DOOR CLOSER
G	1	36"	80"	TYP; PANIC HARDWARE; DOOR CLOSER

FLOOR PLAN

WIND LOAD ENGINEERING FBC 2001, SECTION 1606

BASIC WIND SPEED = 110 MPH
WIND EXPOSURE = B
WIND IMPORTANCE FACTOR = 1.0
INTERNAL PRESSURE COEFFICIENT = 1.0
COMPONENT & CLADDING DESIGN WIND PRESSURE:
WINDOWS & DOORS < 45 PSF

THESE PLANS COMPLY WITH WIND LOAD
REQUIREMENTS OF SECTION 1606, FBC 2001.
ALL EXTERIOR WALLS HAVE BEEN CONSIDERED
AS SHEARWALLS FOR LATERAL STABILITY.


WINDOW SCHEDULE				
SYMBOL	QUANT.	DIMENSIONS		REMARKS
		WIDTH	HEIGHT	
1	17	36"	72"	
2	1	36"	48"	

REVISIONS


FLOOR PLAN CELEBRATION COMMUNITY CHURCH

BAILEY BISHOP & LANE, INC.
SWBARNETTWAY
P. O. BOX 3717
LAKE CITY, FL 32066 3717
PH. (904) 752-5640 FAX (904) 755-7771
Eng. Lic. 7562 Survey Lic. LB-0006685


JOB NO.
022000
DATE
11/1/02
SHEET NO.
B1

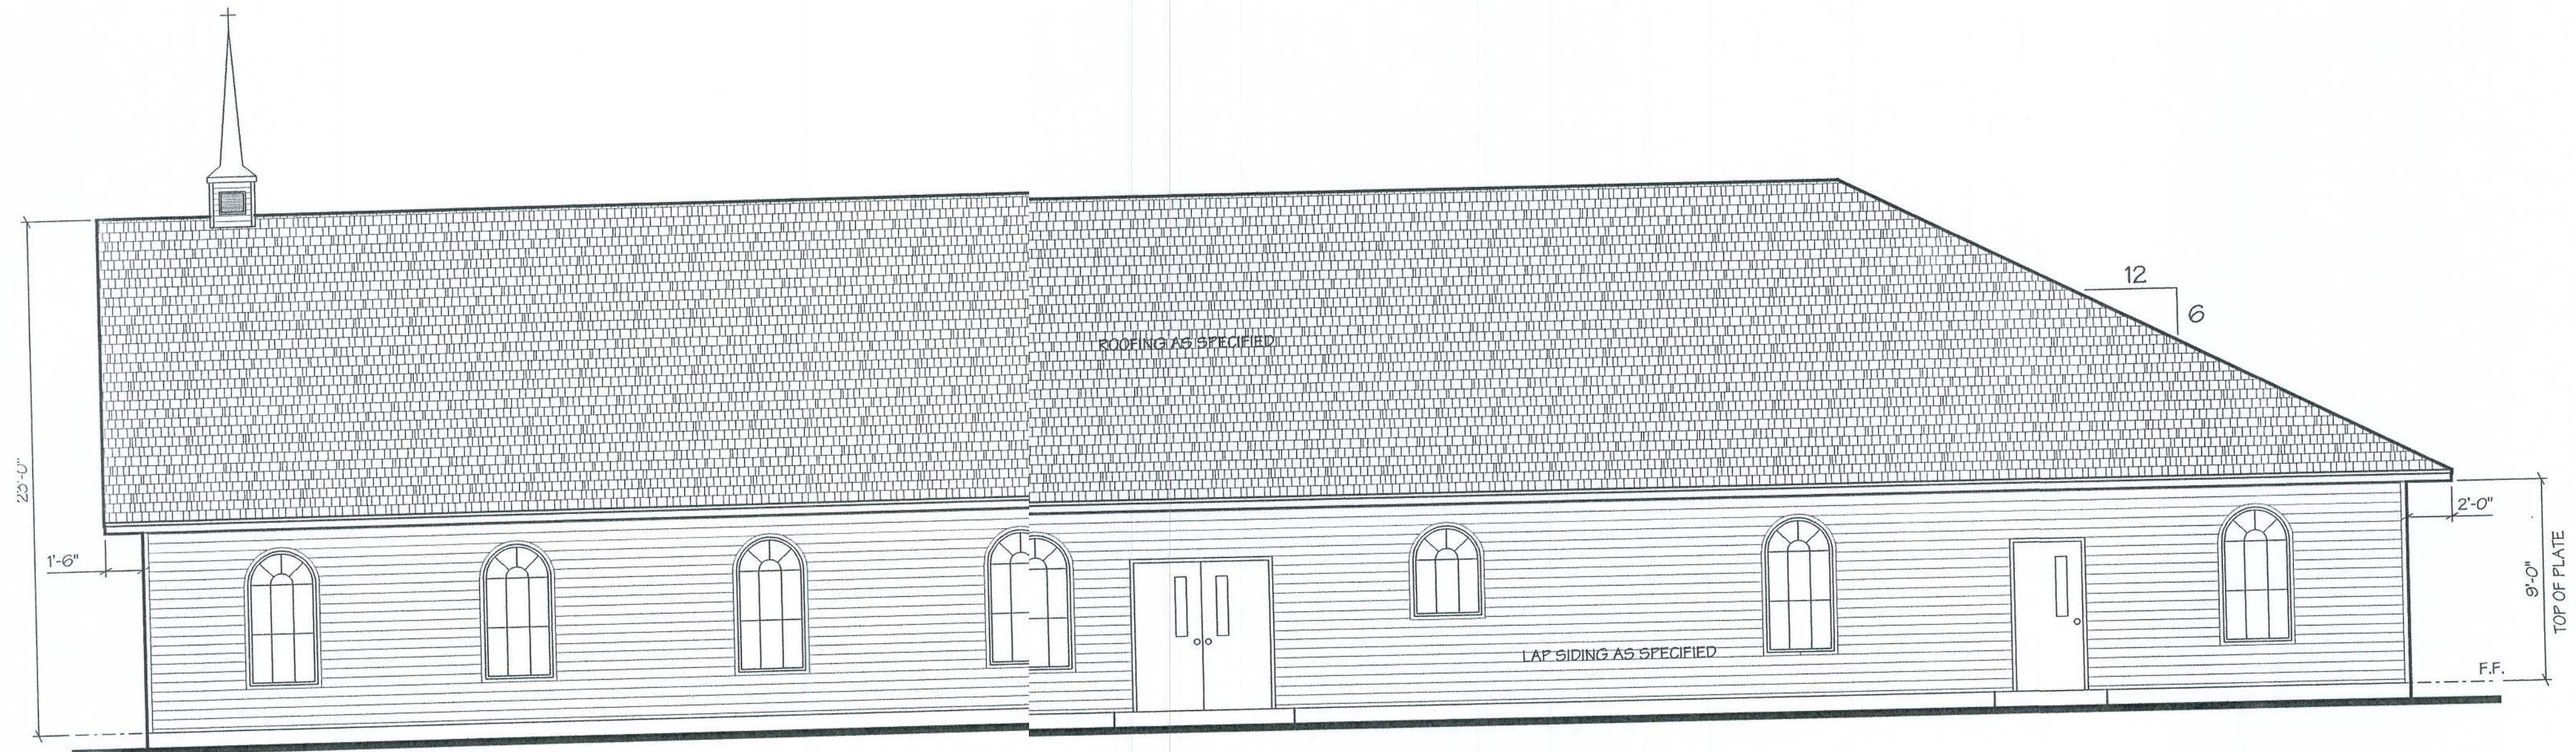


SOUTH ELEVATION

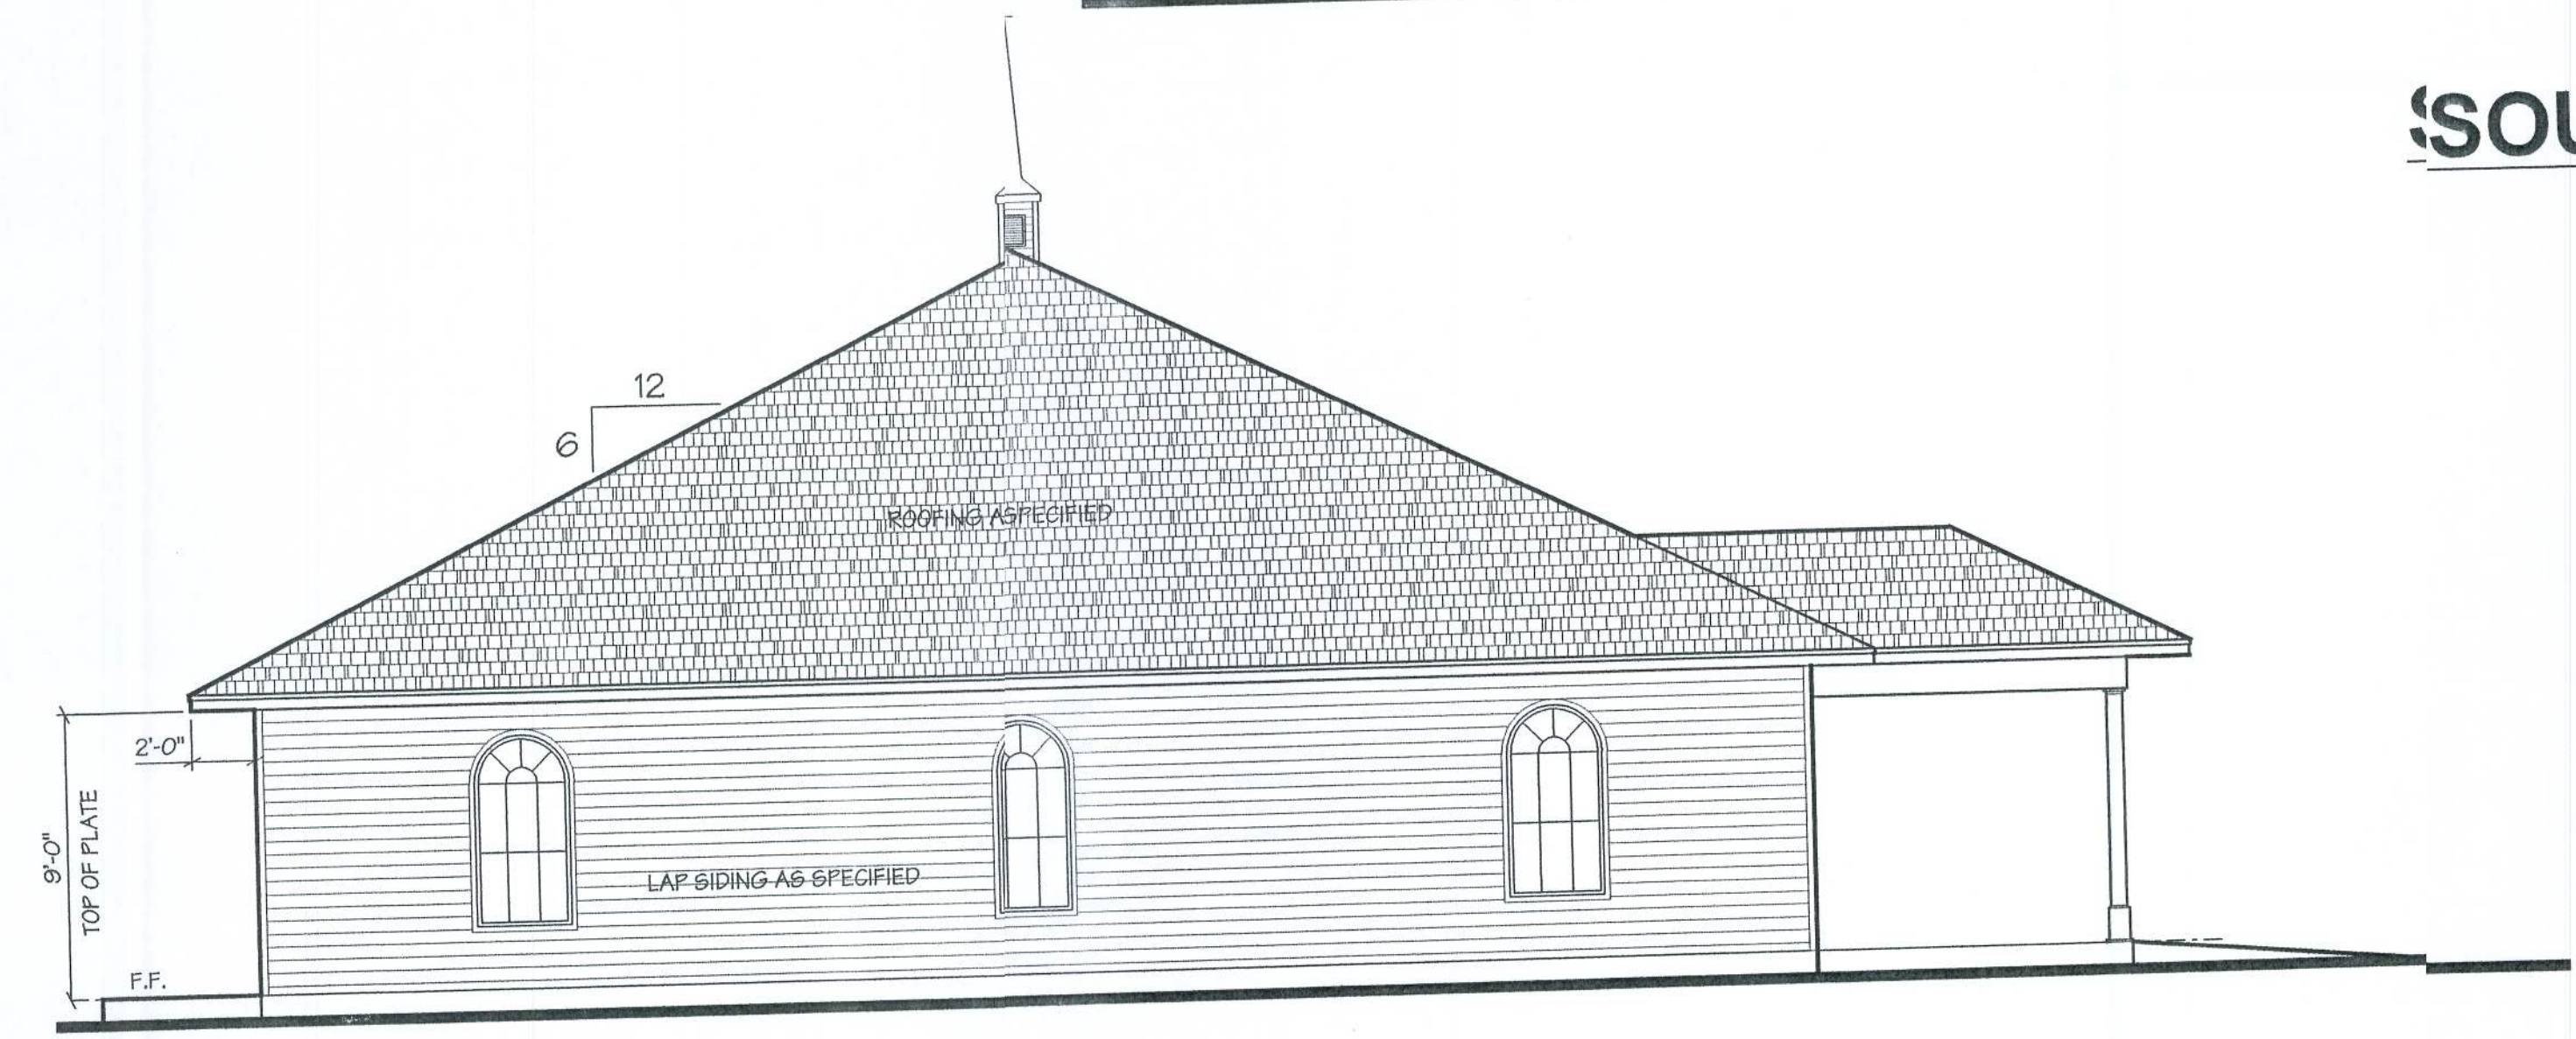

EAST ELEVATION

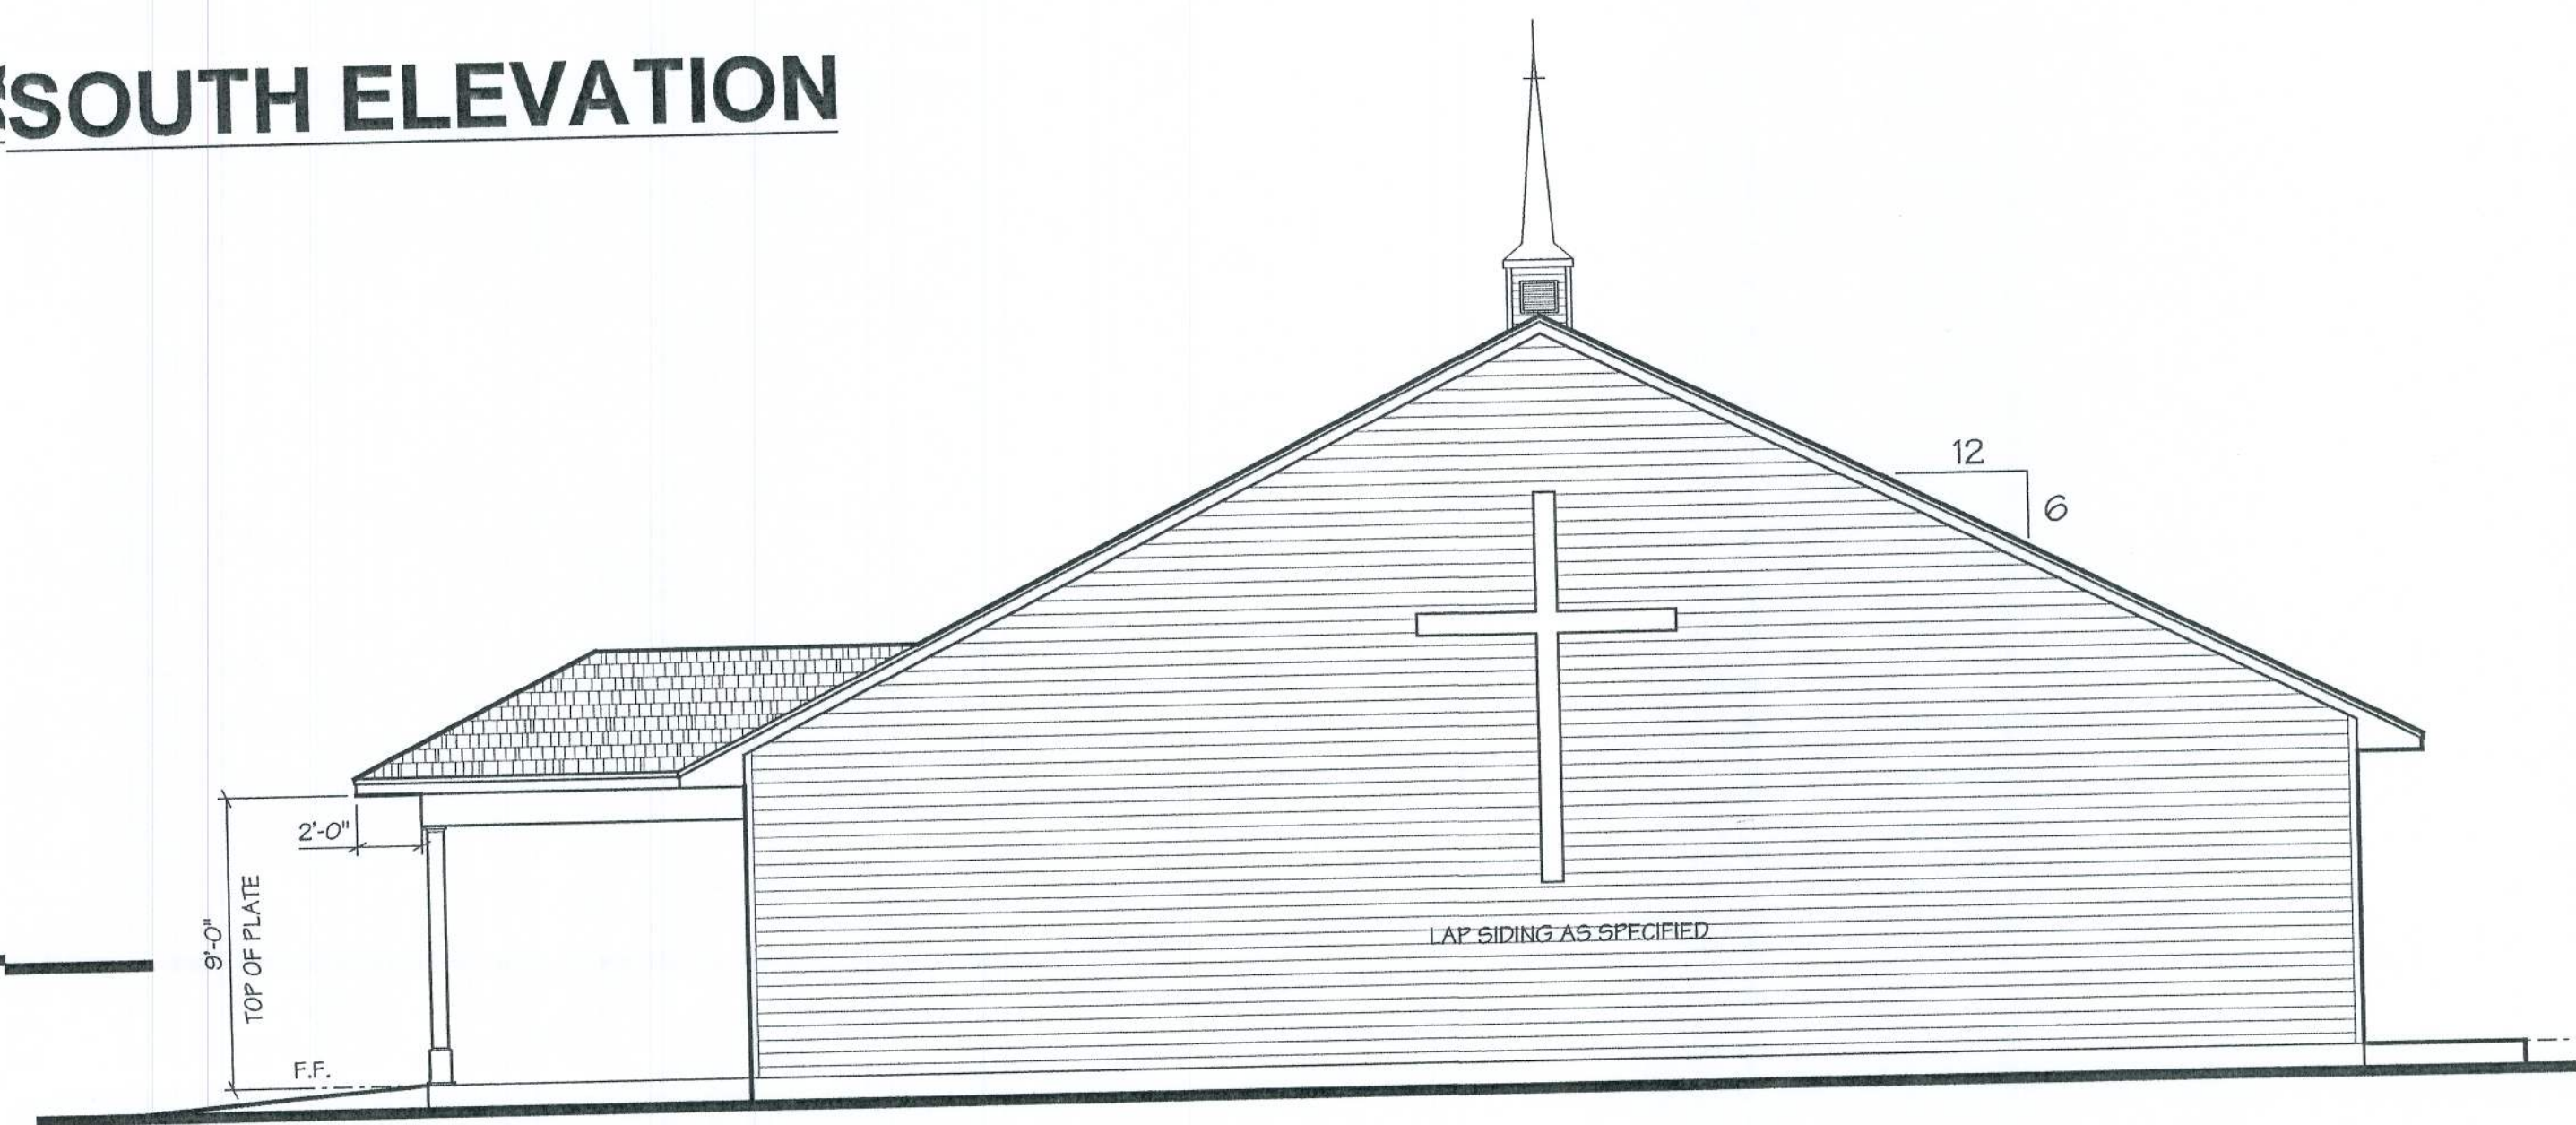

WEST ELEVATION

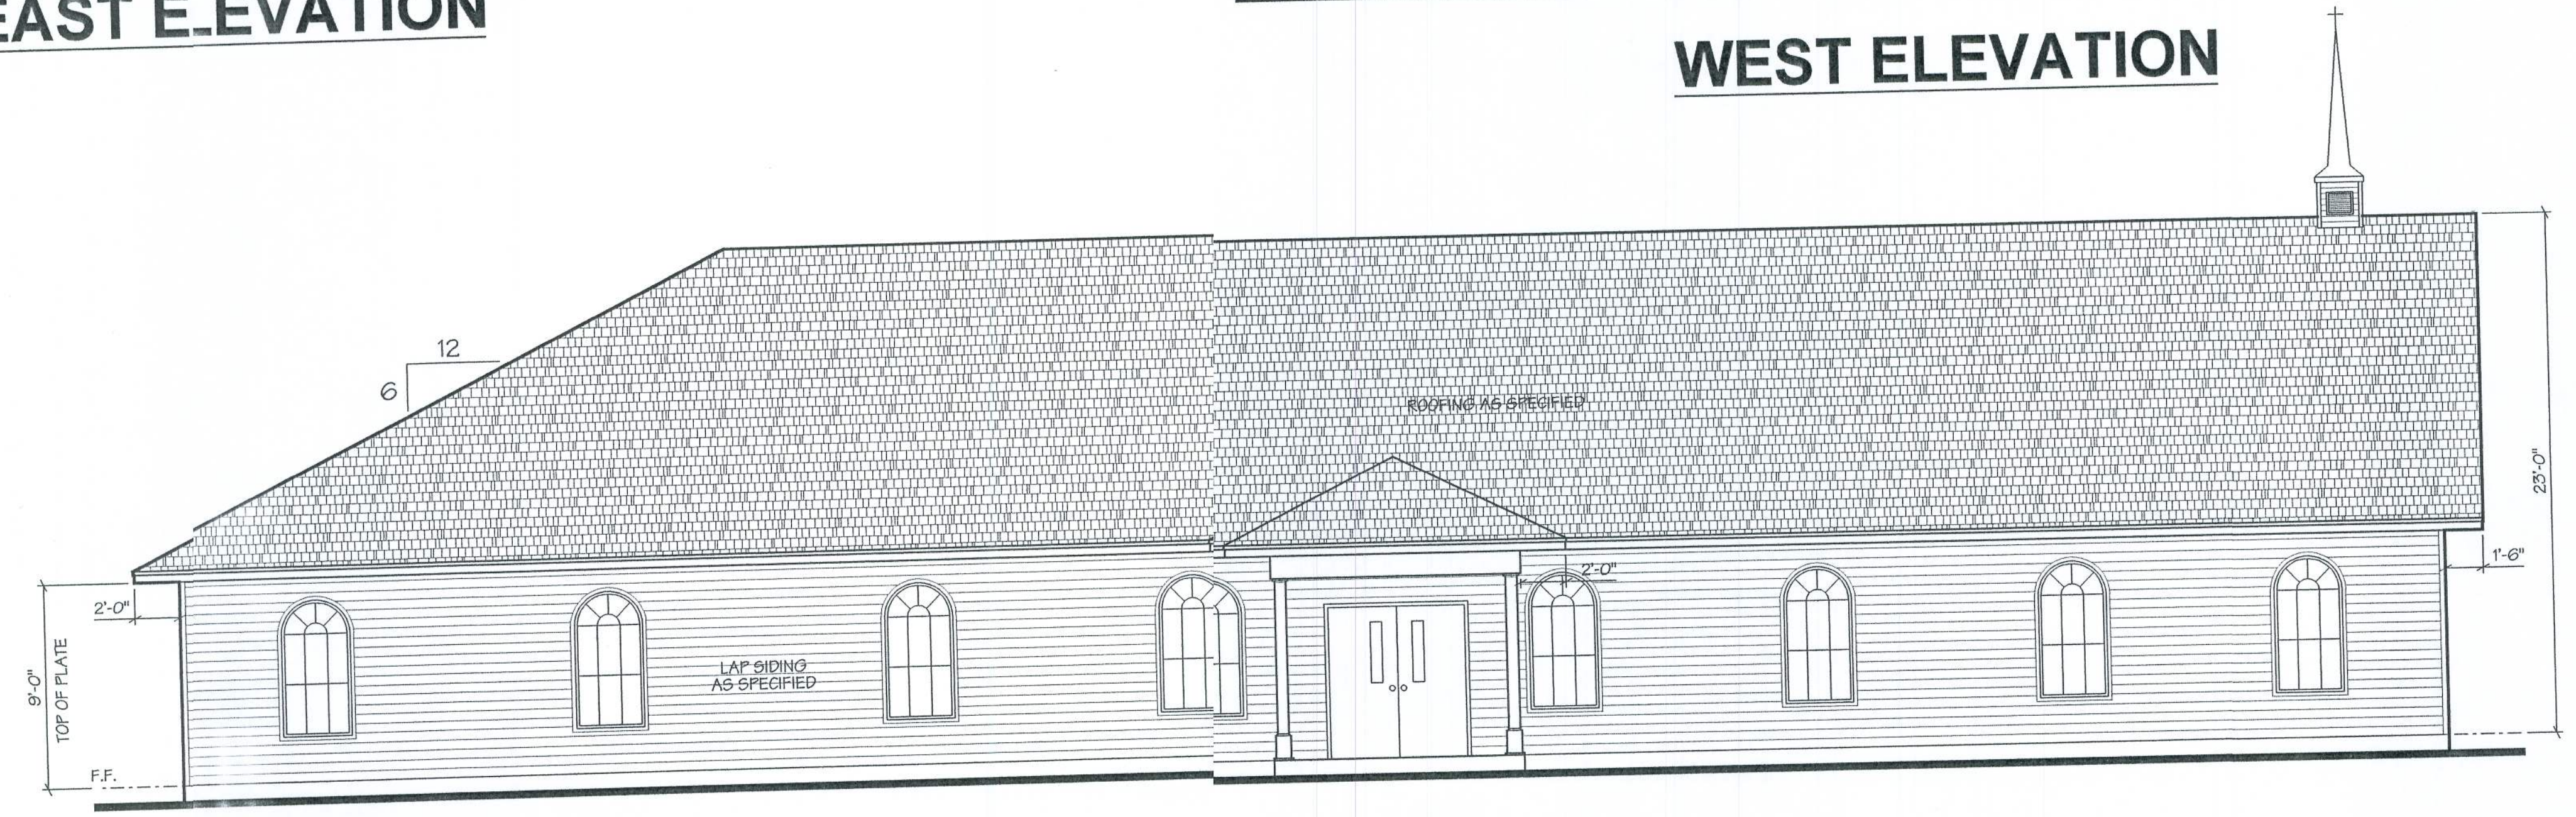

NORTH ELEVATION

RPB
11/14/02

BAILEY BISHOP & LANE, INC.
SW BARNETT WAY
P.O. BOX 3717
LAKE CITY, FL 32006-3717
PH. (904) 752-5640 FAX (904) 755-7771
Eng. Lic. 7362 Survey Lic. LB-0006685




ELEVATIONS
CELEBRATION COMMUNITY CHURCH

REVISIONS

JOB NO.
020000
DATE
11/11/02
SHEET NO.

32

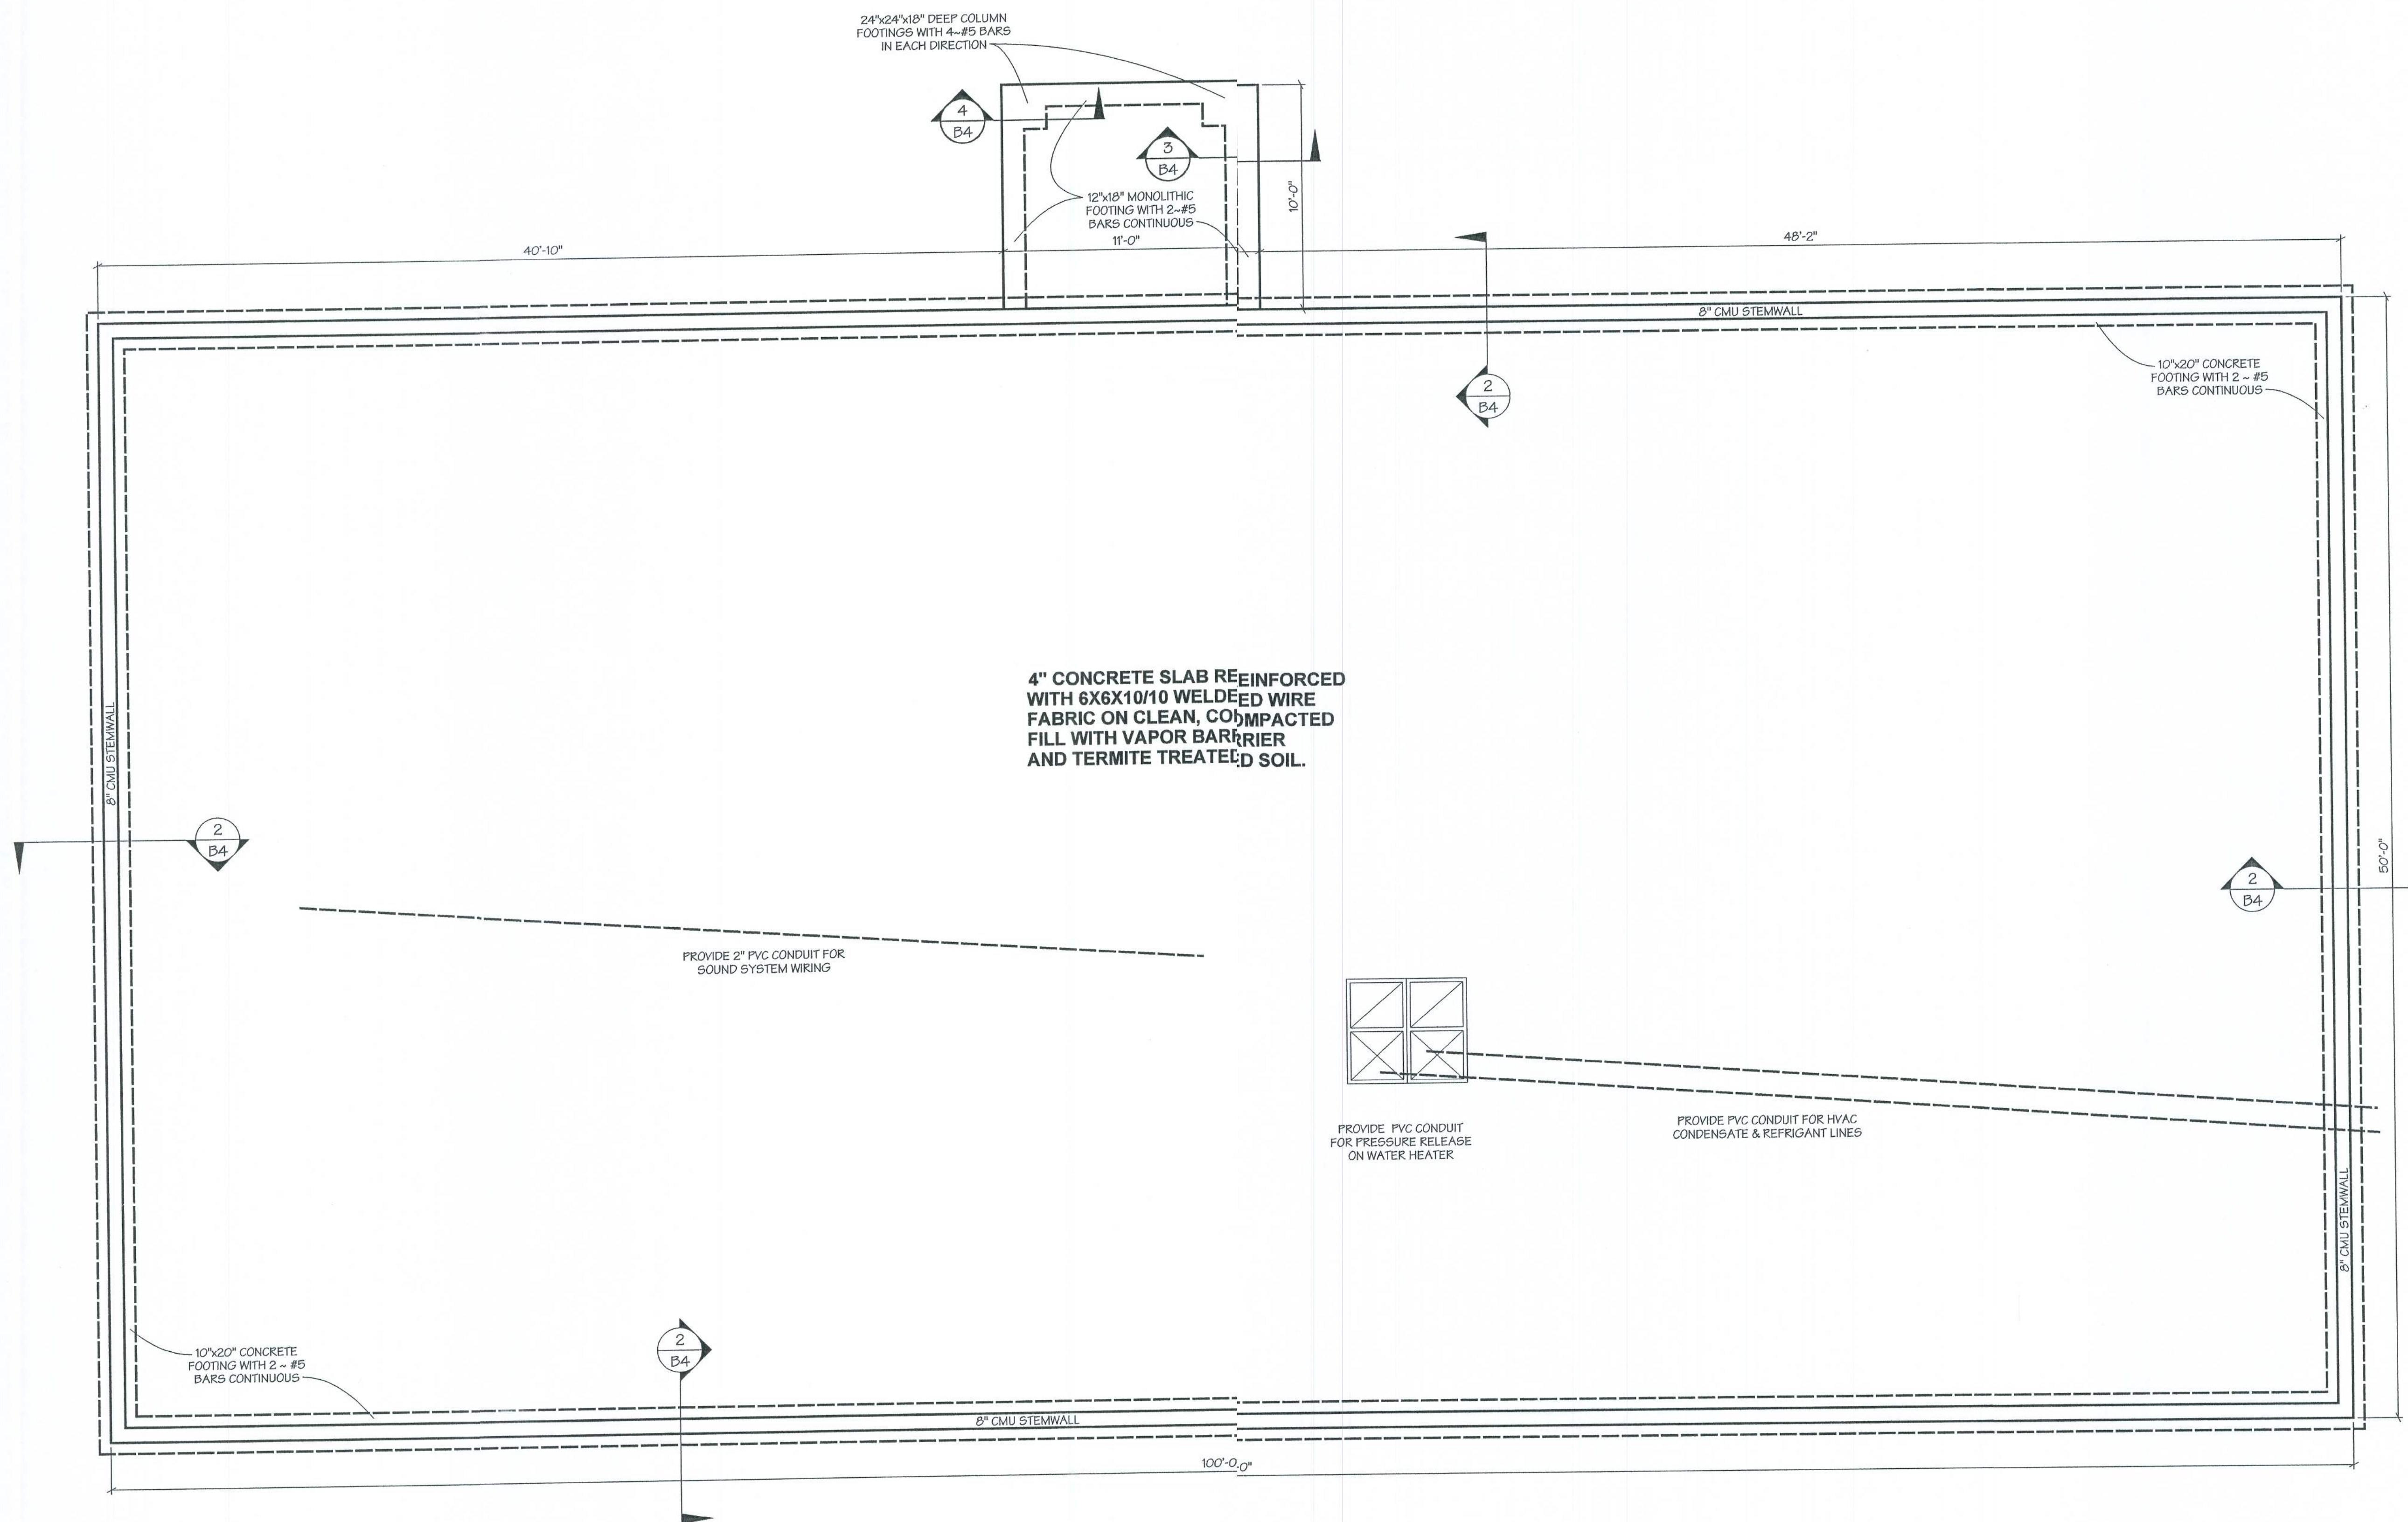

FOUNDATION PLAN

Handwritten signature and date
11/14/02

REVISIONS


JTB NO.
010000
DATE
11/11/02
SHEET NO.

B3




BAILEY BISHOP & LANE, INC.
SW BARNETT WAY
P.O. BOX 3717
LAKE CITY, FL 32056-3717
PH. (904) 752-5640 FAX (904) 755-7771
Eng. Lic. 73662 Survey Lic. LB-0006685

FOUNDATION PLAN
CELEBRATION COMMUNITY CHURCH

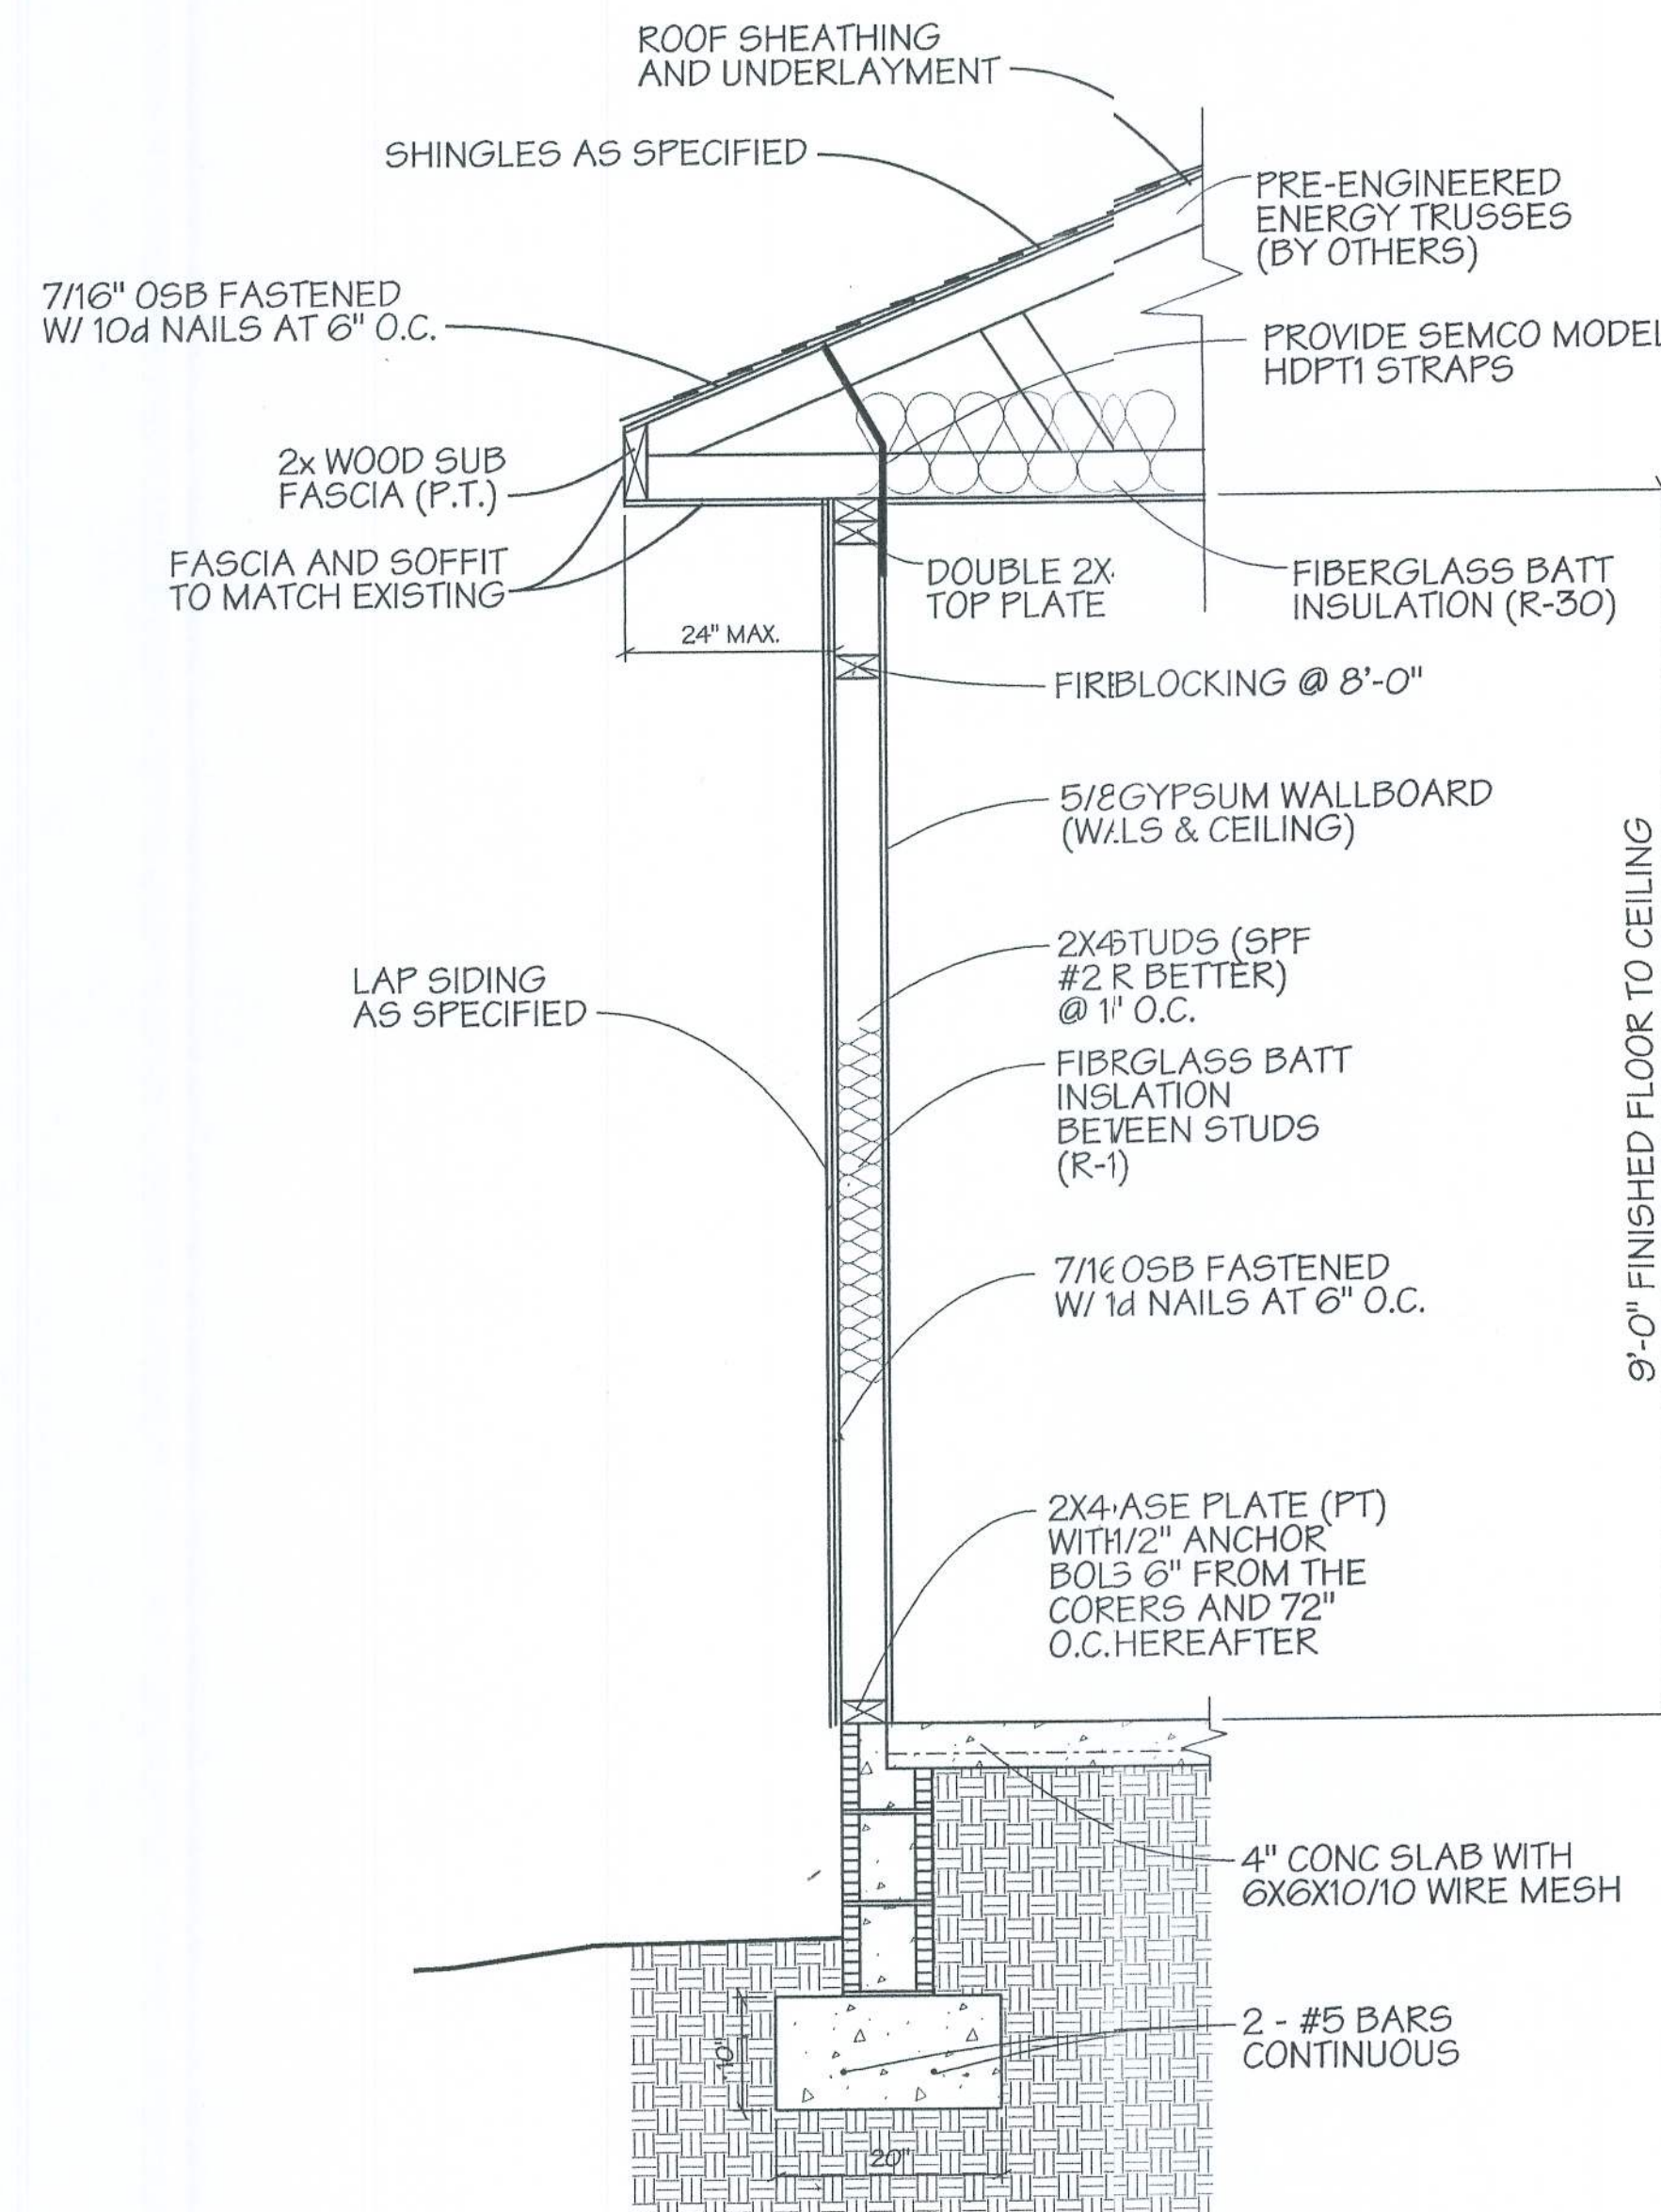


WALL SECTION

1
B4

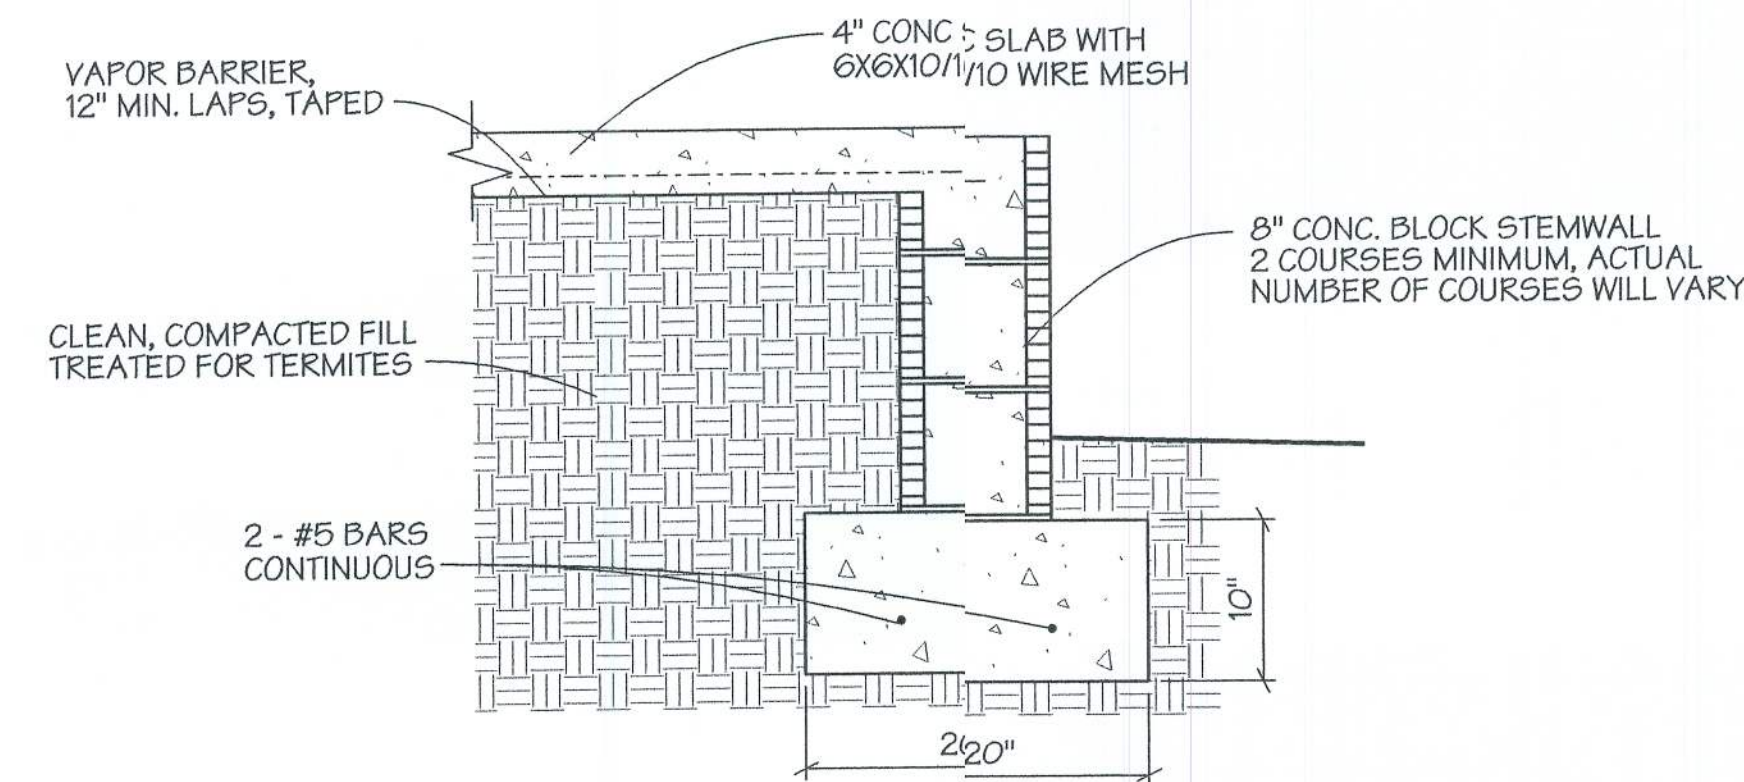


FOOTING DETAIL

2
B4

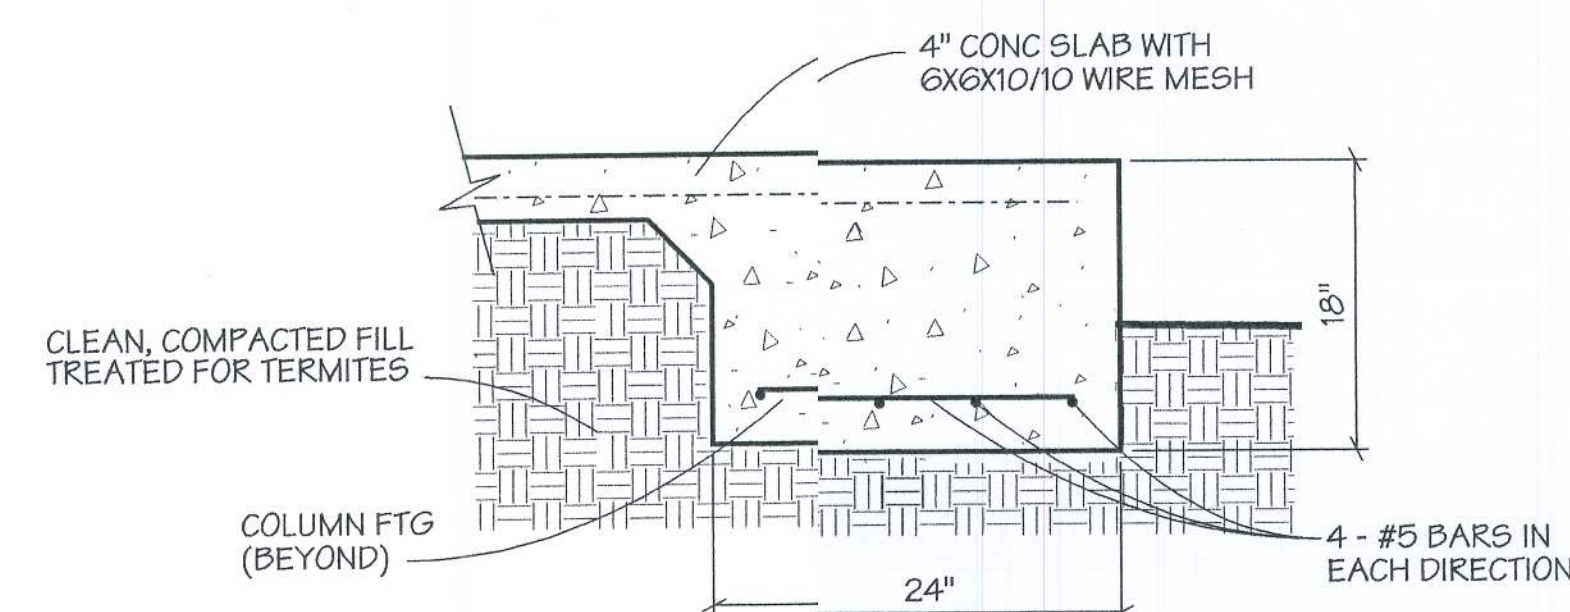


FOOTING DETAIL

4
B4

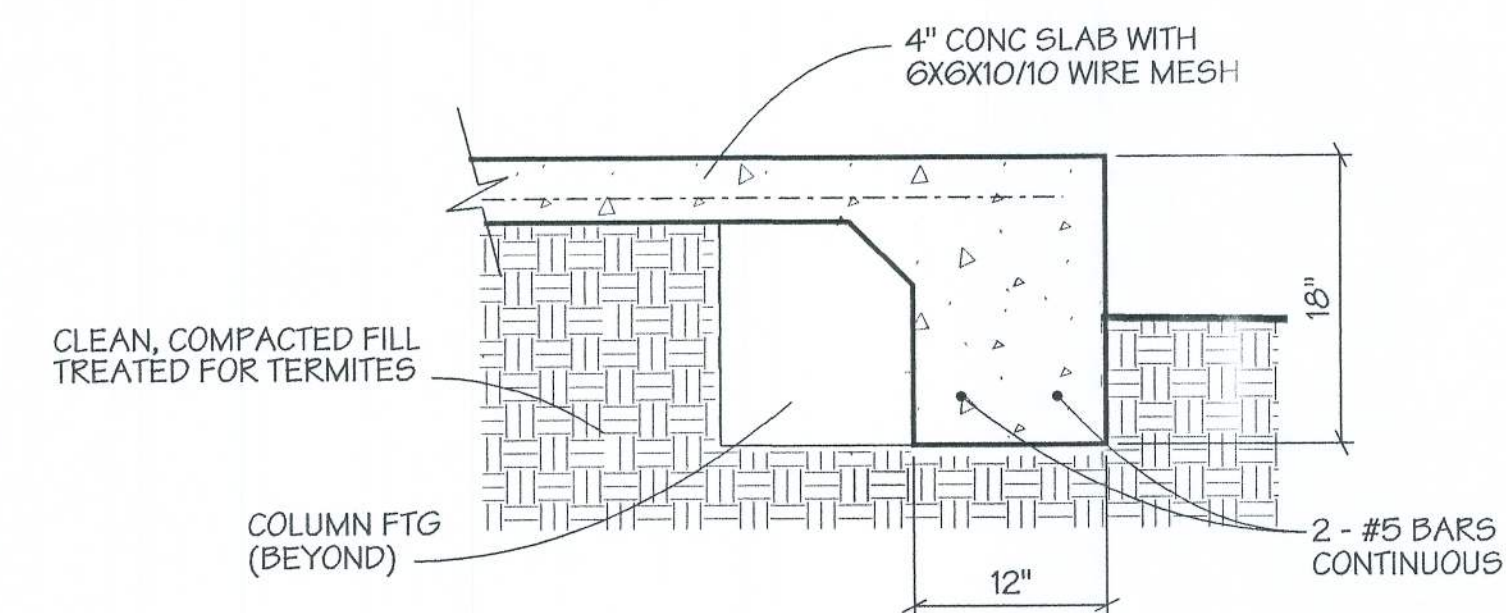

FOOTING DETAIL

3
B4

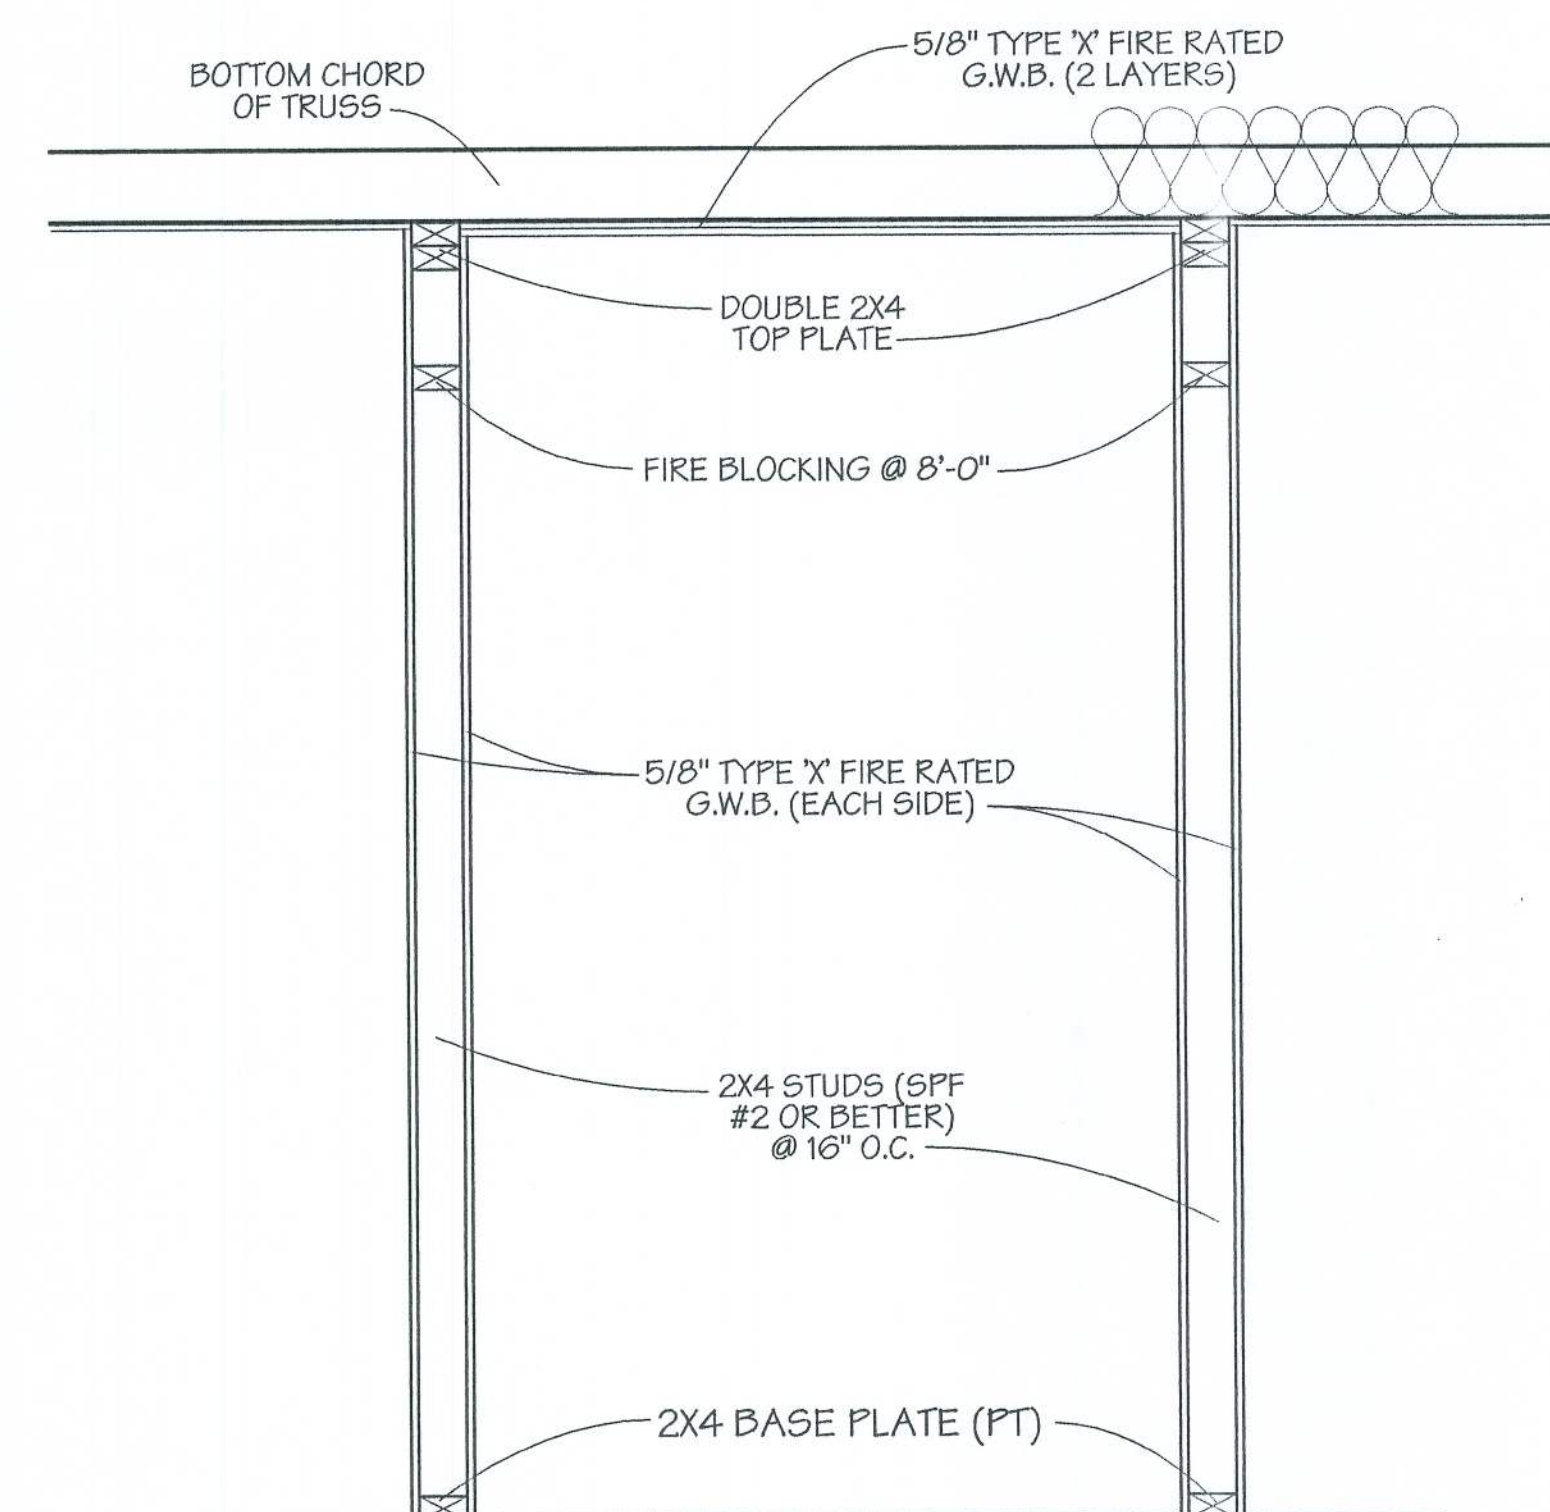

CORRIDOR WALL SECTION

5
B4

JOE NO.
020000
DATE
11/1/02
SHEET NO.

B4


**WALL SECTIONS
AND DETAILS**
CELEBRATION COMMUNITY CHURCH

REVISIONS

BAILEY BISHOP & LANE, INC.
SW BARNETT WAY
P.O. BOX 3717
LAKE CITY, FL 32056-3717
PH. (904) 752-5640 FAX (904) 755-7771
Eng. Lic. 7362 Survey Lic. LB-0006685



NOTE: THIS ELECTRICAL PLAN IS INTENDED TO SHOW SCHEMATICALLY THE LAYOUT OF THE ELECTRICAL SYSTEM. FINAL LOCATIONS AND SIZING OF THE COMPONENTS SHALL BE THE RESPONSIBILITY OF THE LICENSED ELECTRICAL CONTRACTOR. ALL WORK SHALL BE PERFORMED IN ACCORDANCE WITH APPLICABLE CODES AND REGULATIONS.

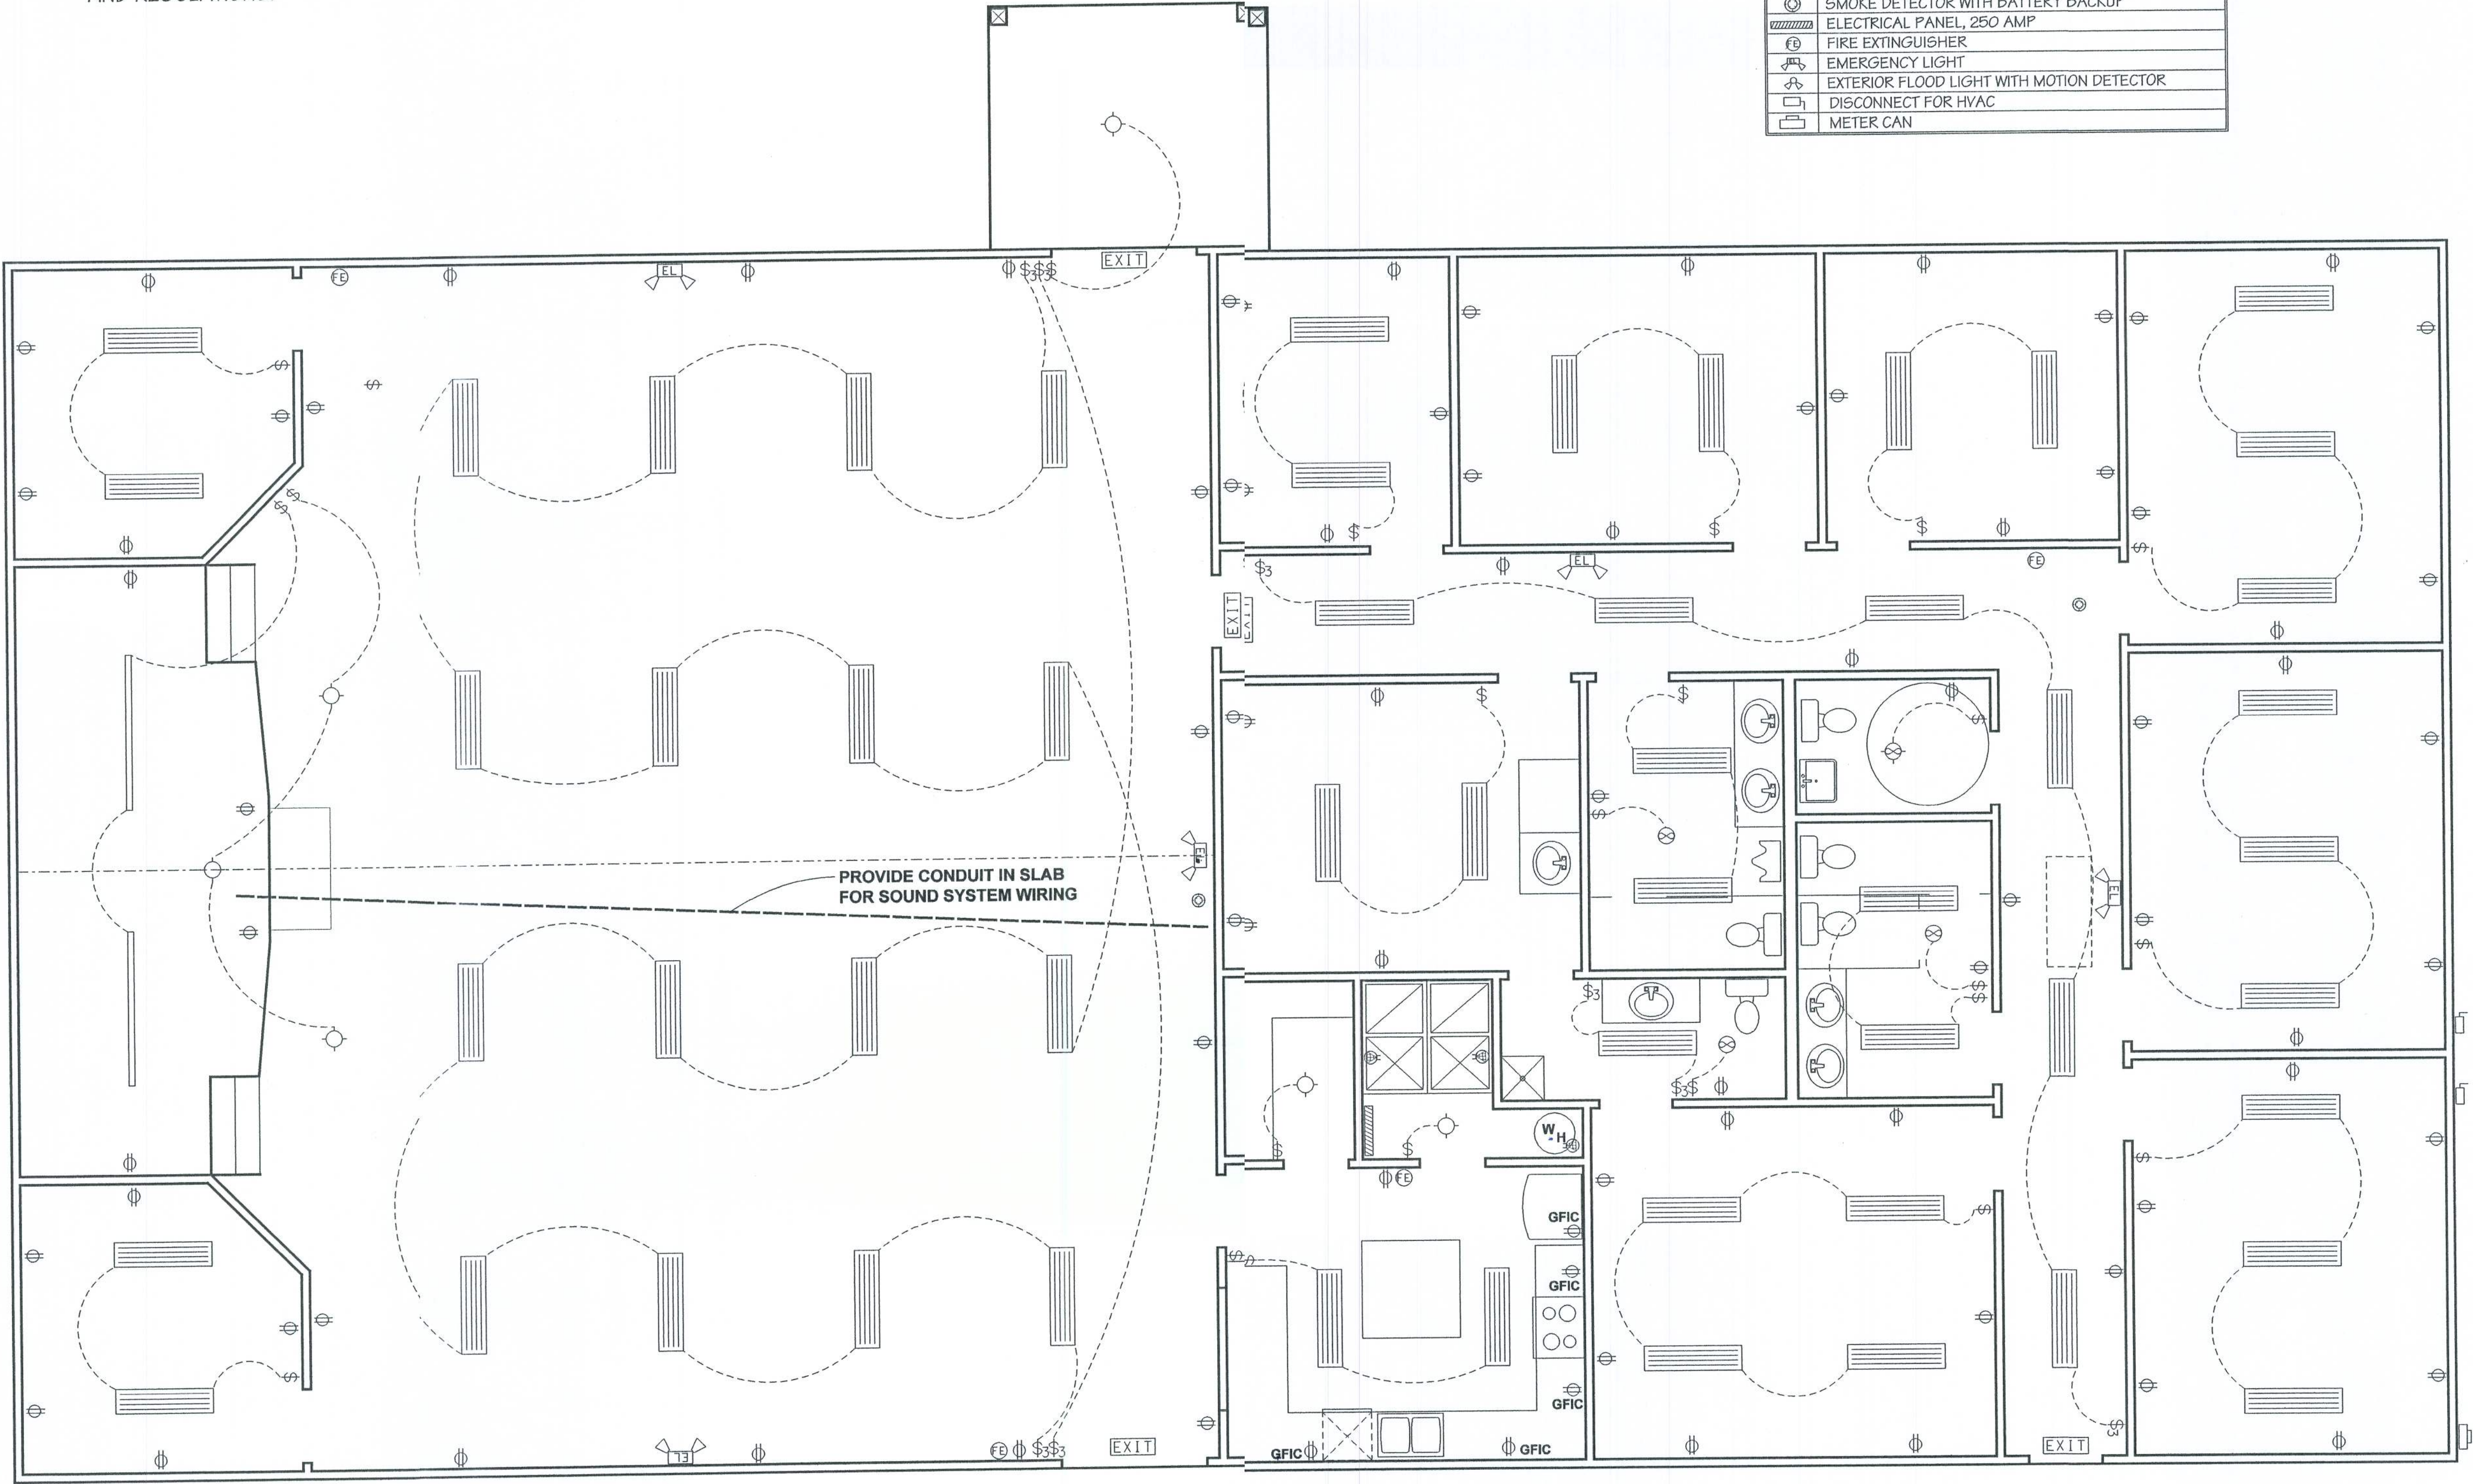

ELECTRICAL PLAN

ELECTRICAL SYMBOLS	
TYPE	DESCRIPTION
⊕	STANDARD DUPLEX RECEPTACLE, 110 VOLT
⊕1	GROUND FAULT INTERRUPTER RECEPTACLE, 110 VOLT
⊕	SPECIAL PURPOSE OUTLET, 220 VOLT
\$	SINGLE POLE SWITCH
\$3	THREE WAY SWITCH
\$4	FOUR WAY SWITCH
⬢	48", 4 BULB FLORESCENT LIGHT (SURFACE MOUNTED)
⬢	TRACK LIGHT (SURFACE MOUNTED)
⬢	INCANDESCENT LIGHT
⬢	RECESSED INCANDESCENT LIGHT
⬢	EXHAUST FAN/LIGHT COMBINATION
EXIT	ILLUMINATED EXIT SIGN WITH BATTERY BACKUP
⊕	SMOKE DETECTOR WITH BATTERY BACKUP
⬢	ELECTRICAL PANEL, 250 AMP
⬢	FIRE EXTINGUISHER
⬢	EMERGENCY LIGHT
⬢	EXTERIOR FLOOD LIGHT WITH MOTION DETECTOR
⬢	DISCONNECT FOR HVAC
⬢	METER CAN

ELECTRICAL PLAN
CELEBRATION COMMUNITY CHURCH

REVISIONS

JOB NO.
020000
DATE
11/1/02
SHEET NO.

E1

BAILEY BISHOP & LANE, INC.
SW BARNETT WAY
P.O. BOX 3717
LAKE CITY, FL 32006-3717
PH. (904) 752-5640 FAX (904) 755-7771
Eng. Lic. 7362 Survey Lic. LB-0006685