


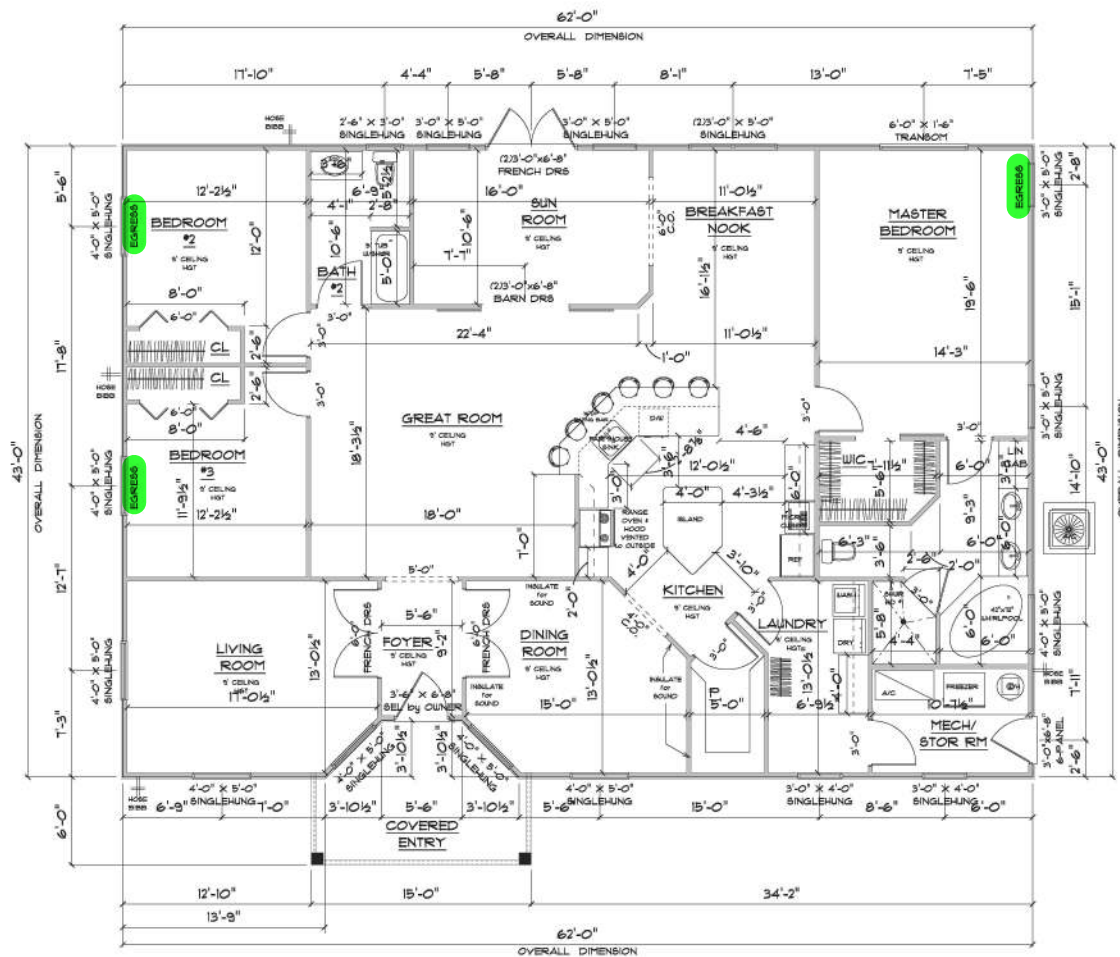

A/C LIVING AREA	*	3638 S.F.
COVERED ENTRY	*	128 S.F.
TOTAL AREA UNDER ROOF	*	3766 S.F.

* FLOOR PLAN *

SCALE : 1/4" = 1'-0"

IMPORTANT NOTES:
 1. IT IS THE BUILDERS RESPONSIBILITY TO VERIFY ALL GEOMETRY AND DIMENSIONS BEFORE ORDERING ANY MATERIALS OR BEGINNING CONSTRUCTION.
 2. THESE PLANS ARE FOR LAYOUT AND DESIGN PURPOSES ONLY. ALL STRUCTURAL NOTES AND DETAILS TO BE PROVIDED BY AN ENGINEER.

HERVYN &
KATHLEEN
DALE

FLORIDA

Terrill H. Ruffo
2020 341 551-471
Lake City, Florida, 33509
Cell: (386) 881-1151
Email: terrillruffo@gmail.com

PRINTED DATE:
Tuesday, June 15, 2021

DRAWN BY:
Terrill H. Ruffo

CHECKED BY:
ROGER WAGGONER


FINAL DATE:

JOB NUMBER:

DRAWING NUMBER:

A-3


OF 6 SHEETS

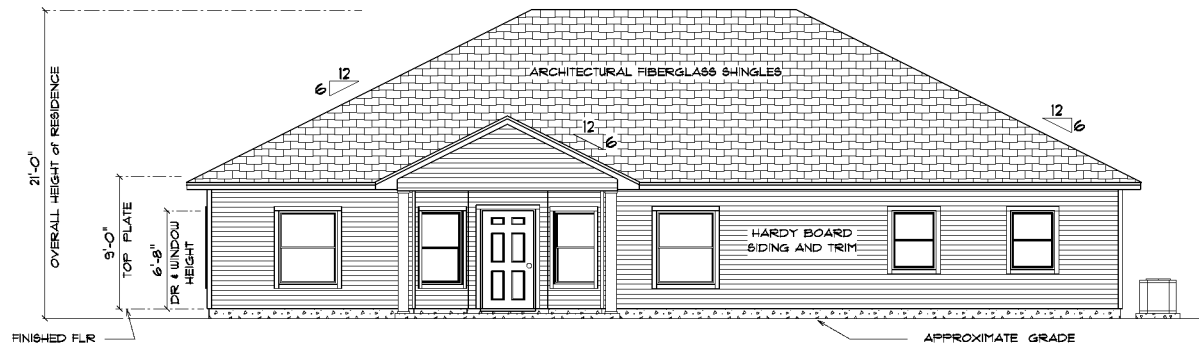

• FRONT ELEVATION •

NOTE:
12" OVERHANG ON GABLE ENDS
18" ON ALL OTHER EAVES

SCALE : 1/4" = 1'-0"

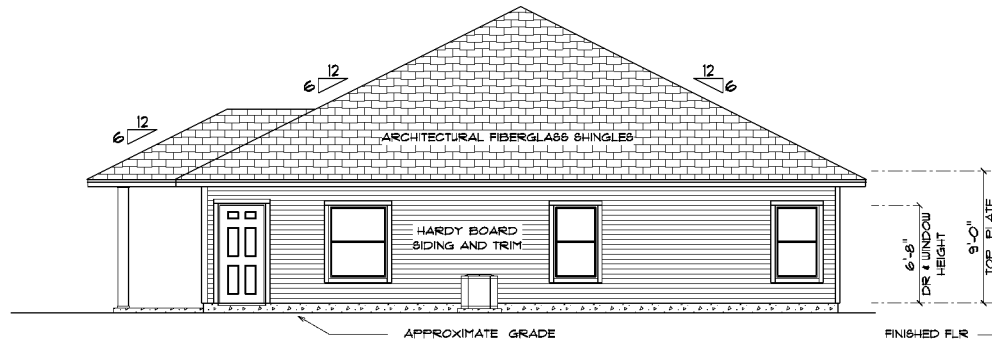

• RIGHT ELEVATION •

NOTE:
12" OVERHANG ON GABLE ENDS
18" ON ALL OTHER EAVES

SCALE : 1/4" = 1'-0"

MERVIN &
KATHLEEN
DALE

FLORIDA

Teresa H. Ruffo
2025 SU 046 41
Lakeland, Florida 33025
Cell: (888) 881-1181
Email: t.h.ruffo@gmail.com

PRINTED DATE:
Tuesday, June 15, 2021

DRAWN BY: CHECKED BY:

Teresa H. Ruffo

RAJINDRA CORPORATION

ROGER WILCOX


FINAL DATE:

JOB NUMBER:

DRAWING NUMBER:

A-4


OF 6 SHEETS

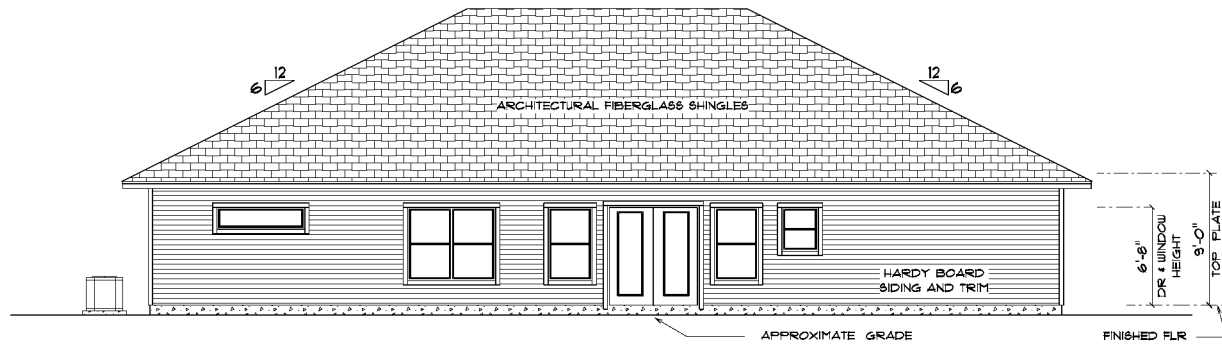

• REAR ELEVATION •

NOTE:
12" OVERHANG ON GABLE ENDS
18" ON ALL OTHER EAVES

SCALE : 1/4" = 1'-0"

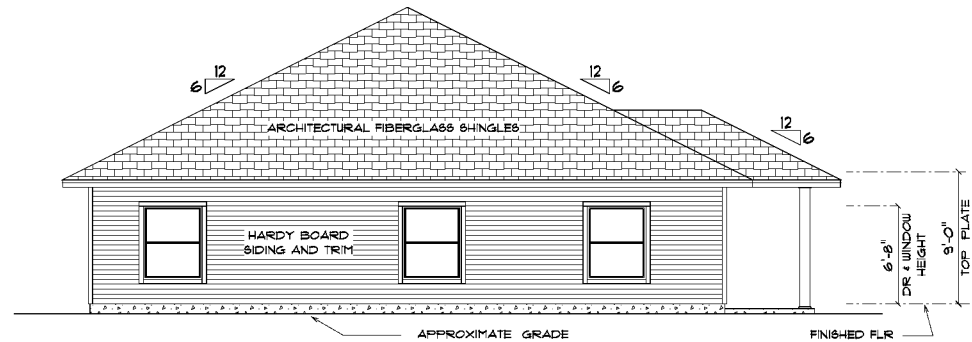

• LEFT ELEVATION •

NOTE:
12" OVERHANG ON GABLE ENDS
18" ON ALL OTHER EAVES

SCALE : 1/4" = 1'-0"

MERVIN &
KATHLEEN
DALE

FLORIDA

Terene H. Ruffo
2025 SU 04 41
Lakeland, Florida 33025
Cell: (888) 881-1181
Email: tereneh@tereneh.com

PRINTED DATE:
TUESDAY, JUNE 15, 2021

DRAWN BY: MERVIN & KATHLEEN DALE
CHECKED BY: ROGER UNWIDON

FINAL DATE:

JOB NUMBER:


DRAWING NUMBER:

A-5
OF 6 SHEETS

ELECTRICAL LEGEND		
ELECTRICAL	COUNT	SYMBOL
ceiling fan globe 01	6	
ceiling classic	2	
pendant large	5	
pot light	18	
spotlight double	4	
wall mount sconce	5	
Smoke Detector	3	
electrical panel	1	
floor outlet single	2	
door bell	1	
light	10	
outlet	62	
outlet 220v	3	
outlet gfi	20	
outlet wp	9	
switch	34	
switch 3 way	18	
vent light combo	2	
vanity bar light 01	2	

ELECTRICAL PLAN NOTES

- E-1 WIRE ALL APPLIANCES, HVAC UNITS AND OTHER EQUIPMENT PER MANUFACTURER'S SPECIFICATIONS.
- E-2 ALL INSTALLATIONS SHALL BE PER NATIONAL ELECTRIC CODE.
- E-3 ALL SMOKE (CARBON MONOXIDE DETECTORS SHALL BE DCV (BATTERY BACKUP OR THE PHOTOELECTRIC TYPE AND SHALL BE INTERLOCKED TOGETHER, INSTALL INSIDE AND NEAR ALL BEDROOMS AS PER CODE.
- E-4 TELEPHONE, TELEVISION AND OTHER LOW VOLTAGE DEVICES OR OUTLETS SHALL BE AS PER THE OWNER'S DIRECTION AND IN ACCORDANCE WITH APPLICABLE SECTIONS OF NATIONAL ELEC. CODE LATEST EDITION.
- E-5 ELECTRICAL CONTRACTOR SHALL BE RESPONSIBLE FOR THE DESIGN AND SIZING OF ELECTRICAL SERVICE AND CIRCUITS.
- E-6 ENTRY OF SERVICE UNDERGROUND OR OVERHEAD) IS TO BE DETERMINED BY THE POWER COMPANY.
- E-7 ALL BEDROOM RECEPTALS ARE TO BE AFCI (ARC FAULT CIRCUIT INTERRUPT)
- E-8 75% OF ALL PERMANENT LIGHTS TO BE ENERGY EFFICIENT.

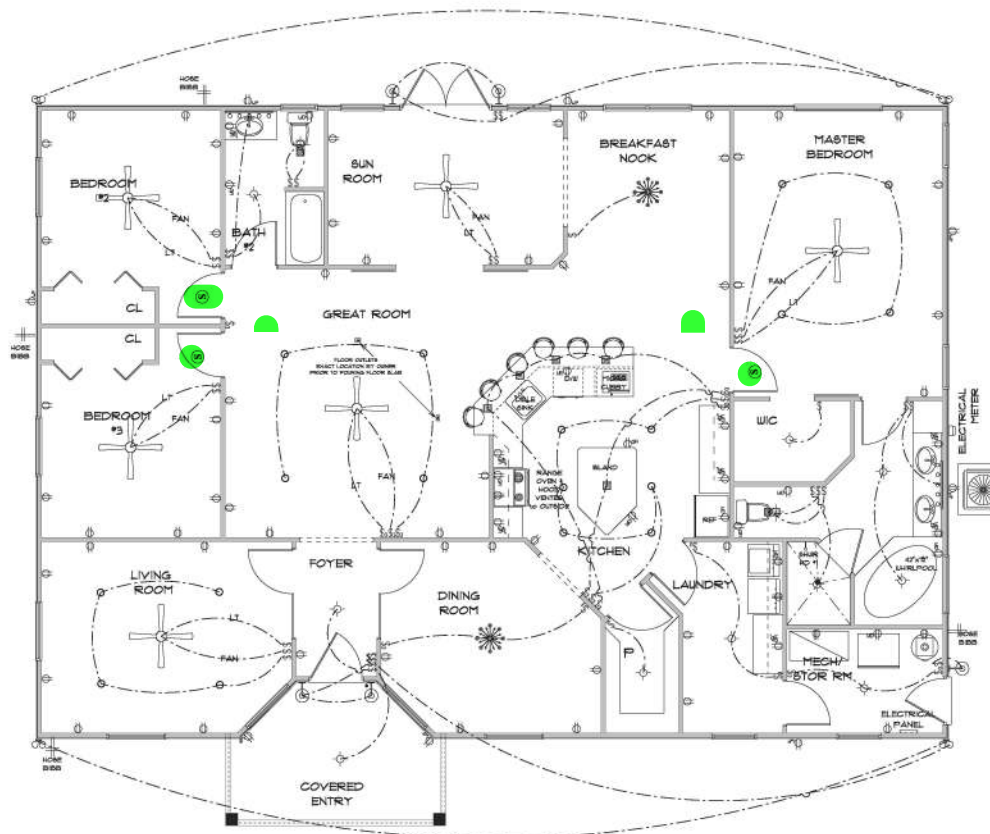

ELECTRICAL PLAN

SCALE : 1/4" = 1'-0"

HERVIN &
KATHLEEN
DALE
FLORIDA

Terrill H. Ruffo
2020 361 585-471
Lake City, Florida, 33029
Cell: (386) 881-1151
Email: terrillruffo@gmail.com

PRINTED DATE:
Tuesday, June 15, 2021
DRAWN BY: TERRILL H. RUFFO
CHECKED BY: ROGER W. WOODSON
FINAL DATE:
JOB NUMBER:
DRAWING NUMBER:
A-6
OF 6 SHEETS